

1 SITE PLAN - EXISTING
1/8" = 1'-0"

SITE PLAN -
EXISTING

A1.0A


SCALE: 1/8" = 1'-0"

DRAWN BY: Author

PROJECT NO.: 123-456

BUILDING ACCESSIBILITY UPGRADES

- ACCESSIBLE PATH OF TRAVEL TO EACH FLOOR
- EXISTING STAIR MARKINGS
- EXISTING STAIR RAILINGS
- DOOR ACCESSIBILITY (LEVERS, OPERATING FORCE, CLOSING SIGNAGE)
- RESTROOM CLEANSING & PAPER PRODUCT DISPENSING & DISPOSAL
- RESTROOM GRAB BARS
- ACCESSIBLE SEATING
- AUDIBLE FEATURES (ASSISTIVE LISTENING SYSTEM)
- KITCHEN AREA ACCESSIBILITY (ACC. DIMENSIONS, MANEUVERABILITY, CLEARANCES, REACH)
- ACCESSIBLE DRINKING FOUNTAIN
- ACCESSIBLE CONTROLS (THERMOSTATS & SWITCHES)
- HAZARDOUS HEADROOM CLEARANCE
- ACCESSIBLE OPERATIONAL WINDOW

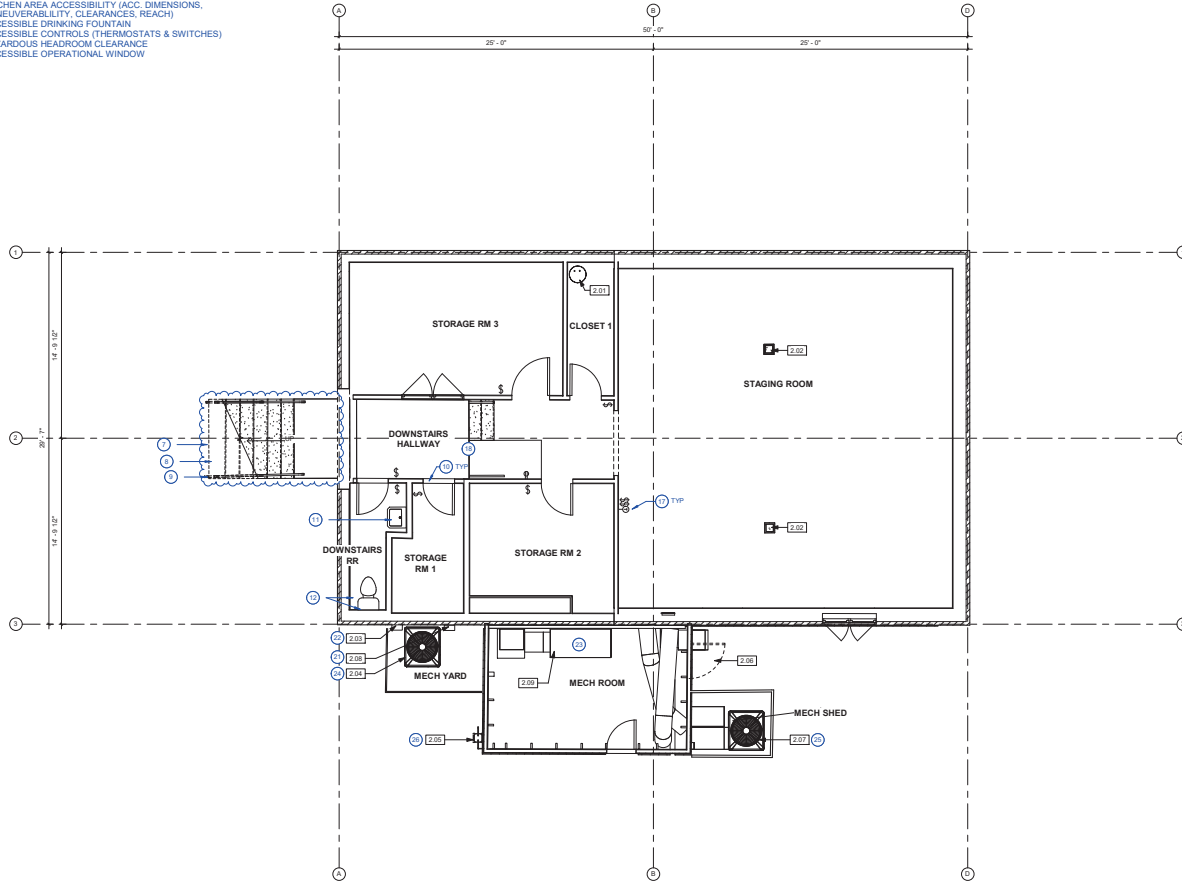

EQUIPMENT SCHED							
NO.	CATEGORY	ITEM	COMPANY	MODEL	SN	INFO	YEAR
20	ELECTRICAL	ELECTRICAL PANEL - UPPER LEVEL	GE	NOT DE-306668	7000 AMP - 120/240 V - 1 PHASE	1975, 1985, 1997, 2009	50.40, 25.15
21	ELECTRICAL	ELECTRICAL PANEL - 2ND	Cutler-Hammer	7	7000 AMP - 120/240 V - 1 PHASE	1998	25
22	ELECTRICAL	ELECTRICAL PANEL - LOWER LEVEL	Cutler-Hammer	7	7		
23	MECHANICAL	FURNACE	LENNIX	C-25-250-1	150000000000	ALSO 1998	18
24	MECHANICAL	AIR COMPRESSOR	LENNIX	H250-460-3P	200000000000	2016	9
25	MECHANICAL	AIR COMPRESSOR	LENNIX	H250-460-3P	200000000000	2016	9
26	PLUMBING	GAS METER	HONEYWELL	AL-300	AMERICAN METERS 20150	2009-2015	15, 9

KEYNOTES

NO.	DESCRIPTION	DETAIL
DIVISION 02 - EXISTING CONDITIONS/DEMO		
2.01	WATER HEATER TANK	
2.02	COLUMN	
2.03	ELECTRIC PANEL 2 - LOWER FLOOR	
2.04	AIR COMPRESSOR 1	
2.05	GAS METER	
2.06	DOOR TO MECHANICAL ROOM BELOW RAMP	
2.07	AIR COMPRESSOR 2	
2.08	ELECTRIC PANEL 3 - AIR CONDITIONING	
2.09	FURNACE	

PLAN LEGEND

- EXISTING WALL
- DEMOLISHED WALL
- NEW WALL
- WORK POINT / CONTROL POINT / DATUM MARK
- KEYNOTE TAG
- DOOR TAG
- WINDOW TAG
- WALL TAG
- STOREFRONT TAG
- REVISION
- MATERIAL/FINISH TAG
- EXIT LIGHTING
- DOWNPOUT

SHEPPHARD ASSOCIATES
ARCHITECTS + ENGINEERS
2650 AGOURA ROAD, SUITE 108
CALABASAS, CA 91302
310.267.8030 | info@shep-ae.com
We are an equal opportunity employer. All qualified applicants will be considered for employment without regard to race, color, sex, gender, religion, age, national origin, ancestry, marital status, sexual orientation, or disability. We are an equal opportunity employer. All qualified applicants will be considered for employment without regard to race, color, sex, gender, religion, age, national origin, ancestry, marital status, sexual orientation, or disability.

CARNegie CENTER
912 3RD STREET
ORLAND, CA 95963


ISSUE NO. DATE DESCRIPTION
04/22/24

REVISION NO. DATE DESCRIPTION

EXISTING PLAN - LOWER LEVEL

A0.2
SCALE: 1/4" = 1'-0"
DRAWN BY: Author
PROJECT NO.: 02-486

1 EXISTING PLAN - LOWER LEVEL
1/4" = 1'-0"

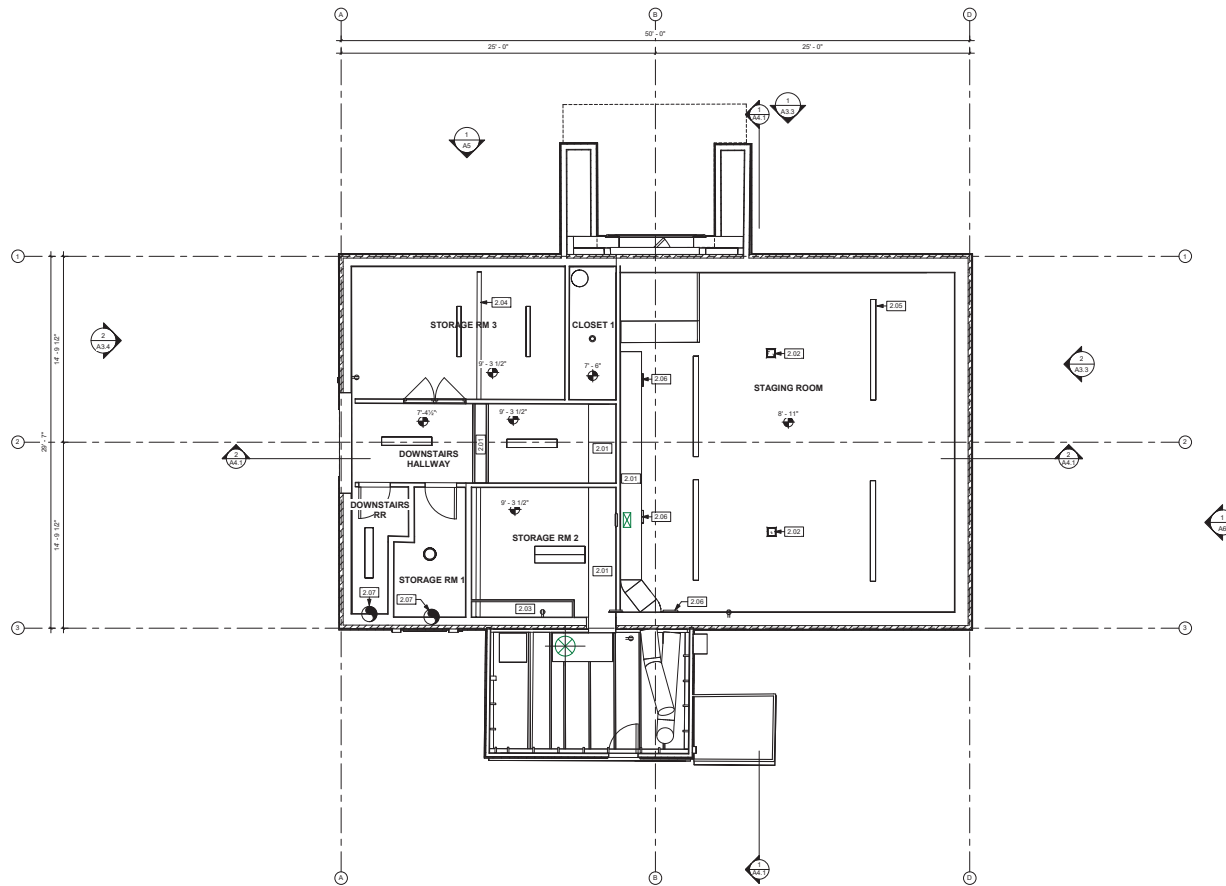

1 EXISTING PLAN - RCP LOWER LEVEL
1/4" = 1'-0"

KEYNOTES

NO.	DESCRIPTION	DETAIL
2.01	EXISTING CONDITIONS	DEMO
2.02	COLUMN	
2.03	CHASE	
2.04	PIPE	
2.05	LIGHT FIXTURE, TYP	
2.06	SUPPLY AIR REGISTER	
2.07	WALL EXHAUST FAN	

SHEPPHARD ASSOCIATES
ARCHITECTS + ENGINEERS
2680 AGOURA ROAD, SUITE 108
CALABASAS, CA 91302
310.367.8030 | info@shep-ae.com

THESE DOCUMENTS ARE THE PROPERTY OF SHEPPHARD ASSOCIATES. NO PART OF THESE DOCUMENTS MAY BE REPRODUCED OR TRANSMITTED IN ANY FORM OR BY ANY MEANS, ELECTRONIC OR MECHANICAL, WITHOUT THE WRITTEN PERMISSION OF SHEPPHARD ASSOCIATES.

CARNEGIE CENTER
912 3RD STREET
ORLAND, CA 95953


ISSUE	NO.	DATE	DESCRIPTION
	03/10/25		

REVISION	NO.	DATE	DESCRIPTION
----------	-----	------	-------------

EXISTING PLAN - RCP LOWER LEVEL
A0.3
SCALE: 1/4" = 1'-0"
DRAWN BY: Author
PROJECT NO: 123-456

BUILDING ACCESSIBILITY UPGRADES

- ACCESSIBLE PATH OF TRAVEL TO EACH FLOOR
- EXISTING STAIR MARKINGS
- EXISTING STAIR RAILINGS
- DOOR ACCESSIBILITY (LEVERS, OPERATING FORCE, CLOSING SIGNAGE)
- RESTROOM CLEANSING & PAPER PRODUCT DISPENSING & DISPOSAL
- RESTROOM GRAB BARS
- ACCESSIBLE SEATING
- AUDIBLE FEATURES (ASSISTIVE LISTENING SYSTEM)
- KITCHEN AREA ACCESSIBILITY (ACC. DIMENSIONS, MANEUVERABILITY, CLEARANCES, REACH)
- ACCESSIBLE DRINKING FOUNTAIN
- ACCESSIBLE CONTROLS (THERMOSTATS & SWITCHES)
- HAZARDOUS HEADROOM CLEARANCE
- ACCESSIBLE OPERATIONAL WINDOW

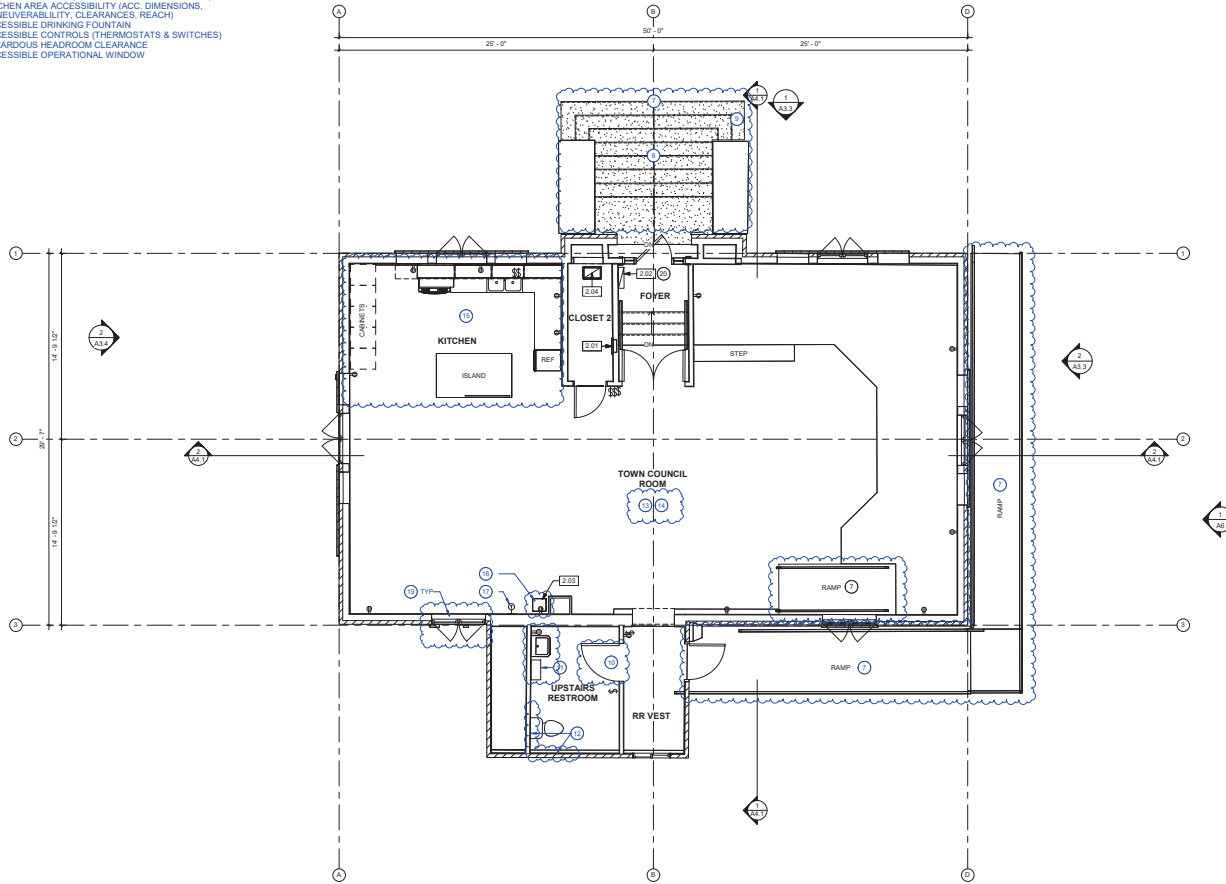

EQUIPMENT SCHED							
NO.	CATEGORY	ITEM	COMPANY	MODEL	SN	INFO	YEAR
20	ELECTRICAL	ELECTRICAL PANEL - UPPER LEVEL	GE	NOT DE-306668	70100 AMP - 120/240 V - 1 PHASE	1975, 1985, 1997, 2009	50.40, 25.15
21	ELECTRICAL	ELECTRICAL PANEL - 2ND	Cutler-Hammer	7	70100 AMP - 120/240 V - 1 PHASE	1998	25
22	ELECTRICAL	ELECTRICAL PANEL - LOWER LEVEL	Cutler-Hammer	7	70100 AMP - 120/240 V - 1 PHASE	1998	25
23	MECHANICAL	FURNACE	LENEXX	C-25-250-1	5192000100200	ALSO 1998	25
24	MECHANICAL	AIR COMPRESSOR	LENEXX	H250-400-3P	5192000100200	2016	9
25	MECHANICAL	AIR COMPRESSOR	LENEXX	H250-400-3P	5192000100200	2016	9
26	PLUMBING	GAS METER	HONEYWELL	HL-300	2000-2015	15, 9	9

KEYNOTES

NO.	DESCRIPTION	DETAIL
DIVISION 02 - EXISTING CONDITIONS/DEMO		
2.01	ELECTRIC PANEL, 1 - UPPER FLOOR	
2.02	WALL RETURN AIR REGISTER	
2.03	FLOOR MOUNTED STANDING WATER FOUNTAIN COLUMN	
2.04	FLOOR RETURN AIR REGISTER	

SHEPPHARD
ASSOCIATES
ARCHITECTS + ENGINEERS
2650 AGOURA ROAD, SUITE 108
CALABASAS, CA 91302

310.367.8030
310.367.8031
www.sheppard-associates.com

CARNEGIE
CENTER
912 3RD STREET
ORLAND, CA 95963


ISSUE
NO. DATE DESCRIPTION

REVISION
NO. DATE DESCRIPTION

EXISTING PLAN -
UPPER FLOOR

A0.4
SCALE: 1/4" = 1'-0"
DRAWN BY: Author
PROJECT NO.: 02-486

1 EXISTING PLAN - UPPER FLOOR
1/4" = 1'-0"

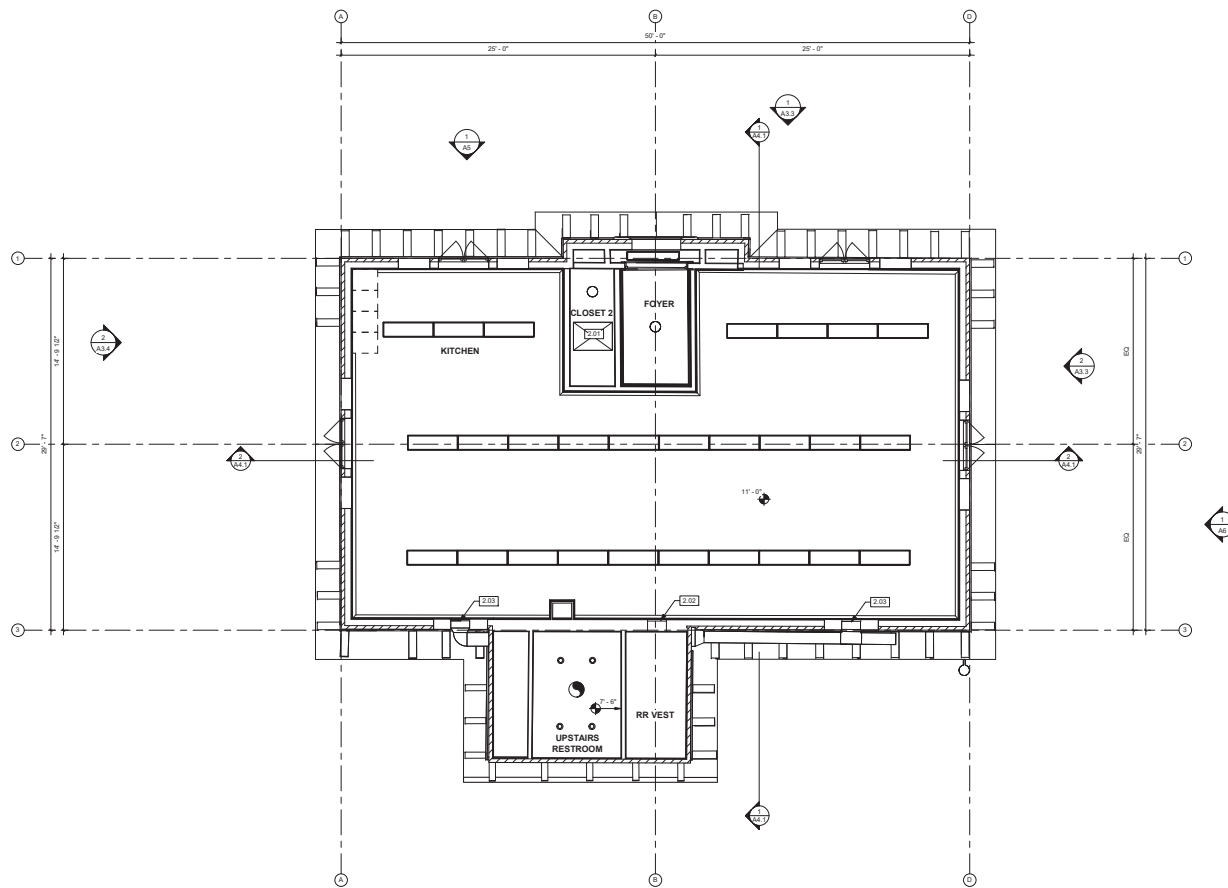

1 EXISTING PLAN - RCP UPPER LEVEL
1/4" = 1'-0"

KEYNOTES

NO.	DESCRIPTION	DETAIL
DIVISION 02 - EXISTING CONDITIONS/DEMO		
2.01	EXISTING ACCESS	
2.02	SUPPLY AIR REGISTER REMAINS	
2.03	SUPPLY AIR REGISTER DEMO	

SHEPPHARD ASSOCIATES
ARCHITECTS + ENGINEERS
26580 AGOURA ROAD, SUITE 108
CALABASAS, CA 91302
310.367.8030 | info@shep-ae.com


THE SHEPPHARD ASSOCIATES ARCHITECTS + ENGINEERS IS AN EQUAL OPPORTUNITY FIRM. WE DO NOT DISCRIMINATE ON THE BASIS OF RACE, GENDER, RELIGION, NATIONAL ORIGIN, ANCESTRY, AGE, SEX, OR SEXUAL ORIENTATION. WE ARE AN AFFIRMATIVE ACTION EMPLOYER. WE DO NOT DISCRIMINATE ON THE BASIS OF RACE, GENDER, RELIGION, NATIONAL ORIGIN, ANCESTRY, AGE, SEX, OR SEXUAL ORIENTATION. WE ARE AN AFFIRMATIVE ACTION EMPLOYER.

CARNEGIE CENTER
912 3RD STREET
ORLAND, CA 95963


ISSUE	NO.	DATE	DESCRIPTION
	03/10/25		

REVISION	NO.	DATE	DESCRIPTION

EXISTING PLAN -
RCP UPPER
LEVEL
A0.5
SCALE: 1/4" = 1'-0"
DRAWN BY: Author
PROJECT NO.: 023-086

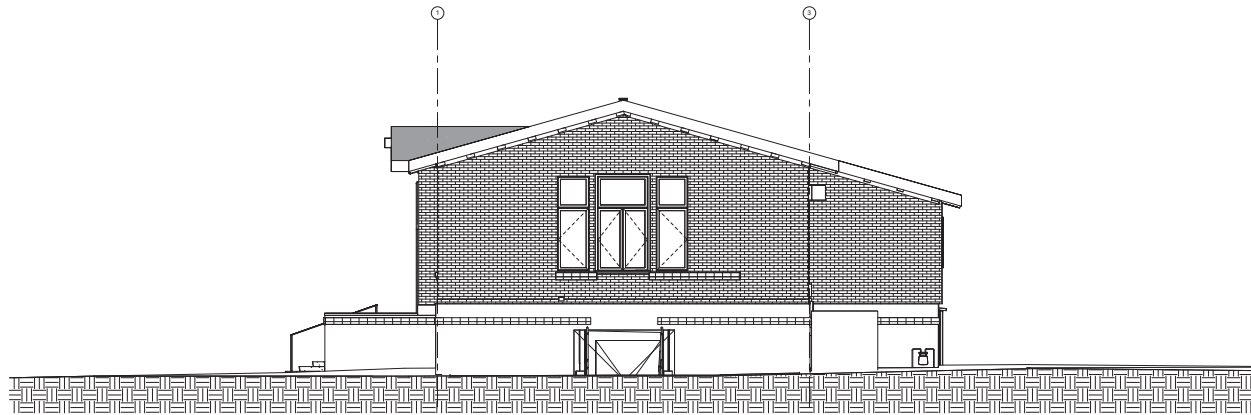

1 NORTH ELEVATION
1/4" = 1'-0"

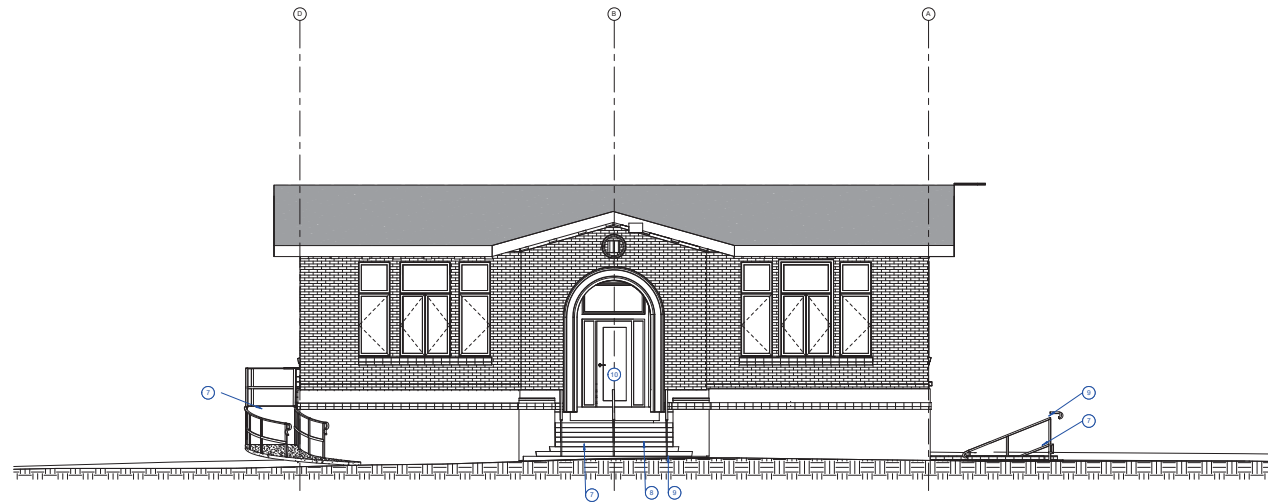

2 EAST ELEVATION
1/4" = 1'-0"

BUILDING ACCESSIBILITY UPGRADES

7. ACCESSIBLE PATH OF TRAVEL TO EACH FLOOR
8. EXISTING STAIR MARKINGS
9. EXISTING STAIR RAILINGS
10. DOOR ACCESSIBILITY (LEVERS, OPERATING FORCE, CLOSING SIGNAGE)
11. RESTROOM CLEANSING & PAPER PRODUCT DISPENSING & DISPOSAL
12. RESTROOM GRAB BARS
13. ACCESSIBLE SEATING
14. AUDIBLE FEATURES (ASSISTIVE LISTENING SYSTEM)
15. KITCHEN AREA ACCESSIBILITY (ACC. DIMENSIONS, MANEUVERABILITY, CLEARANCES, REACH)
16. ACCESSIBLE DRINKING FOUNTAIN
17. ACCESSIBLE CONTROLS (THERMOSTATS & SWITCHES)
18. HAZARDOUS HEADROOM CLEARANCE
19. ACCESSIBLE OPERATIONAL WINDOW

EQUIPMENT SCHED									
NO	CATEGORY	ITEM	COMPANY	MODEL	SN	INFO	YEAR	AGE	
20	ELECTRICAL	ELECTRICAL PANEL - UPPER LEVEL	ISE		NO. DE-308868	7055 AMP - 120/240 V-1 PHASE	1976, 1985, 1997, 2000	32, 40, 26, 16	
21	ELECTRICAL	ELECTRICAL PANEL - A/C	Cutler Hammer			7055 AMP - 120/240 V-1 PHASE	1998	26	
22	ELECTRICAL	ELECTRICAL PANEL - LOWER LEVEL	Cutler Hammer						
23	MECHANICAL	FURNACE	LENNOX	C26-4TFC-1	0N6006H20302		AUG 1998	26	
24	MECHANICAL	AIR COMPRESSOR	LENNOX	H24K-260-2P	EN68076 44185	500/250 HZ 1 PHASE 60 V - GAS SUPPLY	2016	9	
25	MECHANICAL	AIR COMPRESSOR	LENNOX	CONTRAD505050A	SN: 10058611796	500/250 HZ 1 PHASE 60 V - GAS SUPPLY	2004	21	
26	PLUMBING	GAS METER	HONEYWELL	AL-600		AMERICAN METER, 20 PSIG	2006/2016	19, 9	

KEYNOTES

CW	DESCRIPTION	DETAIL
----	-------------	--------

SHEPPHARD ASSOCIATES
ARCHITECTS + ENGINEERS
26560 AGOURA ROAD, SUITE 108
CALABASAS, CA 91302


310.367.8030 | info@shep-ae.com
We are an Equal Opportunity Employer. All qualified applicants will be considered for employment without regard to race, color, sex, gender, religion, age, national origin, ancestry, or disability. We are an Equal Opportunity Employer. All qualified applicants will be considered for employment without regard to race, color, sex, gender, religion, age, national origin, ancestry, or disability.

CARNEGIE CENTER
912 3RD STREET
ORLAND, CA 95963


ISSUE
NO. DATE DESCRIPTION
04/22/24

REVISION
NO. DATE DESCRIPTION

BUILDING ELEVATIONS -
EXISTING
A3.1
SCALE: 1/4" = 1'-0"
DRAWN BY: Author
PROJECT NO.: 23-066

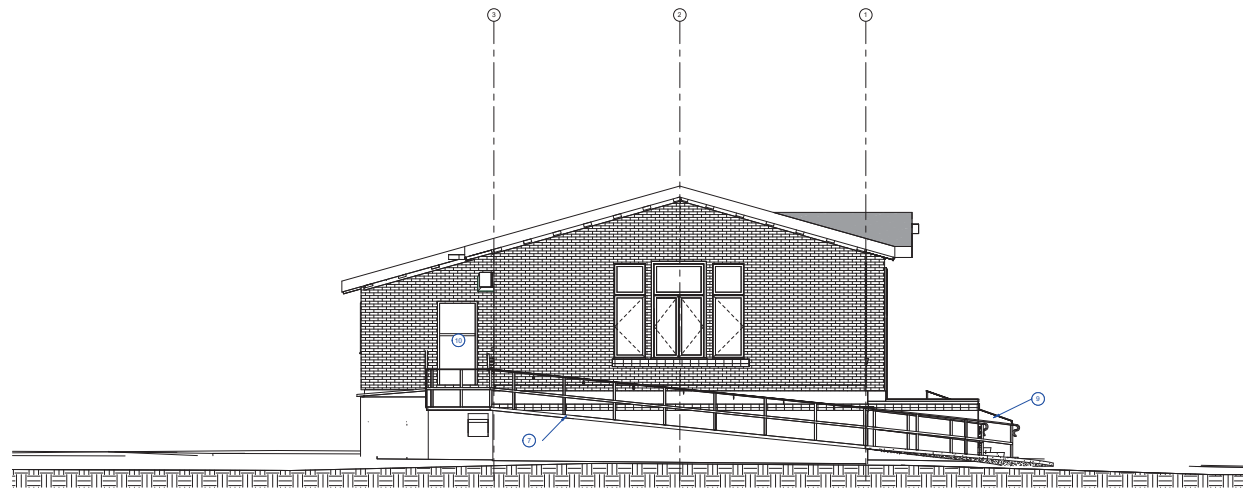

1 SOUTH ELEVATION
1/4" = 1'-0"

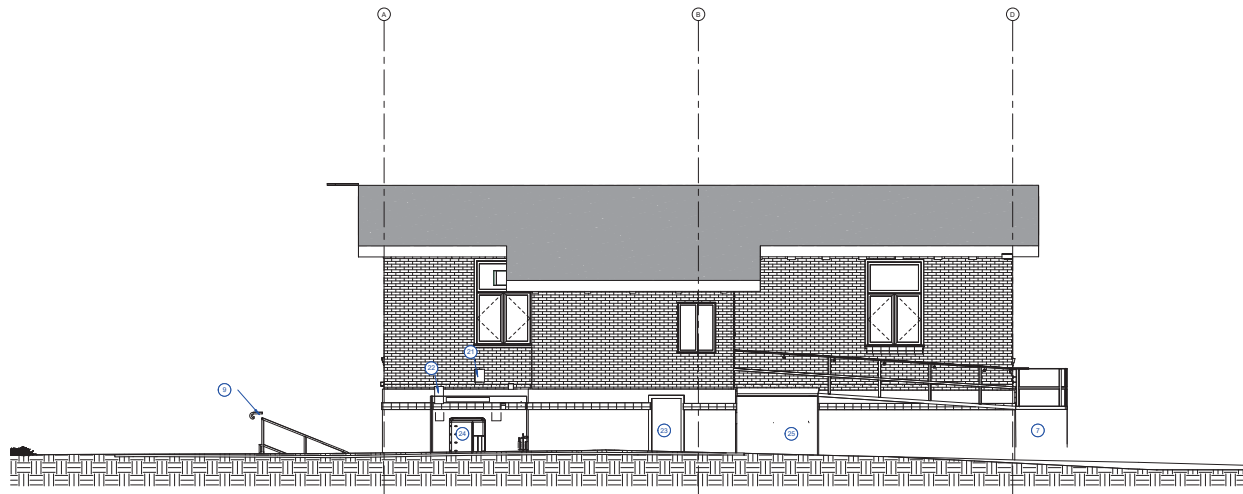

2 WEST ELEVATION
1/4" = 1'-0"

BUILDING ACCESSIBILITY UPGRADES

7. ACCESSIBLE PATH OF TRAVEL TO EACH FLOOR
8. EXISTING STAIR MARKINGS
9. EXISTING STAIR RAILINGS
10. DOOR ACCESSIBILITY (LEVERS, OPERATING FORCE, CLOSING
MOMENT)
11. RESTROOM CLEANSING & PAPER PRODUCT DISPENSING &
DISPOSAL
12. RESTROOM GRAB BARS
13. ACCESSIBLE SEATING
14. AUDIBLE FEATURES (ASSISTIVE LISTENING SYSTEM)
15. KITCHEN AREA ACCESSIBILITY (ACC. DIMENSIONS,
MANEUVERABILITY, CLEARANCES, REACH)
16. ACCESSIBLE DRINKING FOUNTAIN
17. ACCESSIBLE CONTROLS (THERMOSTATS & SWITCHES)
18. HAZARDOUS MATERIALS STORAGE
19. ACCESSIBLE OPERATIONAL WINDOW

EQUIPMENT SCHED								
NO	CATEGORY	ITEM	COMPANY	MODEL	SN	INFO	YEAR	AGE
20	ELECTRICAL	ELECTRICAL PANEL - UPPER LEVEL	GE		NO DE-306968	7055 AMP - 120/240 V 1 PHASE	1979, 1985, 1997, 2009	52, 40, 28, 16
21	ELECTRICAL	ELECTRICAL PANEL - A/C	Gulf-Hammer			7055 AMP - 120/240 V 1 PHASE	1998	26
22	ELECTRICAL	ELECTRICAL PANEL - LOWER LEVEL	Gulf-Hammer				1998	26
23	Mechanical	PURANCE	LENNOX	COB-5F1-C	960609-DE303		AUG 1998	26
24	MECHANICAL	AIR COMPRESSOR	LENNOX	H126-260-1	9565879 44185	2002/26 H1 PHASE V - GAS SUPPLY	2004	21
25	Mechanical	AIR COMPRESSOR	LENNOX	COB-5F1-C	960609-DE303	2002/26 H1 PHASE V - GAS SUPPLY	2004	21
26	Mechanical	AIR COMPRESSOR	LENNOX	COB-5F1-C	960609-DE303	2002/26 H1 PHASE V - GAS SUPPLY	2004	21
27	Mechanical	AIR COMPRESSOR	LENNOX	COB-5F1-C	960609-DE303	2002/26 H1 PHASE V - GAS SUPPLY	2004	21
28	Mechanical	AIR COMPRESSOR	LENNOX	COB-5F1-C	960609-DE303	2002/26 H1 PHASE V - GAS SUPPLY	2004	21
29	Mechanical	AIR COMPRESSOR	LENNOX	COB-5F1-C	960609-DE303	2002/26 H1 PHASE V - GAS SUPPLY	2004	21
30	Mechanical	AIR COMPRESSOR	LENNOX	COB-5F1-C	960609-DE303	2002/26 H1 PHASE V - GAS SUPPLY	2004	21
31	Mechanical	AIR COMPRESSOR	LENNOX	COB-5F1-C	960609-DE303	2002/26 H1 PHASE V - GAS SUPPLY	2004	21
32	Mechanical	AIR COMPRESSOR	LENNOX	COB-5F1-C	960609-DE303	2002/26 H1 PHASE V - GAS SUPPLY	2004	21
33	Mechanical	AIR COMPRESSOR	LENNOX	COB-5F1-C	960609-DE303	2002/26 H1 PHASE V - GAS SUPPLY	2004	21
34	Mechanical	AIR COMPRESSOR	LENNOX	COB-5F1-C	960609-DE303	2002/26 H1 PHASE V - GAS SUPPLY	2004	21
35	Mechanical	AIR COMPRESSOR	LENNOX	COB-5F1-C	960609-DE303	2002/26 H1 PHASE V - GAS SUPPLY	2004	21
36	Mechanical	AIR COMPRESSOR	LENNOX	COB-5F1-C	960609-DE303	2002/26 H1 PHASE V - GAS SUPPLY	2004	21
37	Mechanical	AIR COMPRESSOR	LENNOX	COB-5F1-C	960609-DE303	2002/26 H1 PHASE V - GAS SUPPLY	2004	21
38	Mechanical	AIR COMPRESSOR	LENNOX	COB-5F1-C	960609-DE303	2002/26 H1 PHASE V - GAS SUPPLY	2004	21
39	Mechanical	AIR COMPRESSOR	LENNOX	COB-5F1-C	960609-DE303	2002/26 H1 PHASE V - GAS SUPPLY	2004	21
40	Mechanical	AIR COMPRESSOR	LENNOX	COB-5F1-C	960609-DE303	2002/26 H1 PHASE V - GAS SUPPLY	2004	21
41	Mechanical	AIR COMPRESSOR	LENNOX	COB-5F1-C	960609-DE303	2002/26 H1 PHASE V - GAS SUPPLY	2004	21
42	Mechanical	AIR COMPRESSOR	LENNOX	COB-5F1-C	960609-DE303	2002/26 H1 PHASE V - GAS SUPPLY	2004	21
43	Mechanical	AIR COMPRESSOR	LENNOX	COB-5F1-C	960609-DE303	2002/26 H1 PHASE V - GAS SUPPLY	2004	21
44	Mechanical	AIR COMPRESSOR	LENNOX	COB-5F1-C	960609-DE303	2002/26 H1 PHASE V - GAS SUPPLY	2004	21
45	Mechanical	AIR COMPRESSOR	LENNOX	COB-5F1-C	960609-DE303	2002/26 H1 PHASE V - GAS SUPPLY	2004	21
46	Mechanical	AIR COMPRESSOR	LENNOX	COB-5F1-C	960609-DE303	2002/26 H1 PHASE V - GAS SUPPLY	2004	21
47	Mechanical	AIR COMPRESSOR	LENNOX	COB-5F1-C	960609-DE303	2002/26 H1 PHASE V - GAS SUPPLY	2004	21
48	Mechanical	AIR COMPRESSOR	LENNOX	COB-5F1-C	960609-DE303	2002/26 H1 PHASE V - GAS SUPPLY	2004	21
49	Mechanical	AIR COMPRESSOR	LENNOX	COB-5F1-C	960609-DE303	2002/26 H1 PHASE V - GAS SUPPLY	2004	21
50	Mechanical	AIR COMPRESSOR	LENNOX	COB-5F1-C	960609-DE303	2002/26 H1 PHASE V - GAS SUPPLY	2004	21
51	Mechanical	AIR COMPRESSOR	LENNOX	COB-5F1-C	960609-DE303	2002/26 H1 PHASE V - GAS SUPPLY	2004	21
52	Mechanical	AIR COMPRESSOR	LENNOX	COB-5F1-C	960609-DE303	2002/26 H1 PHASE V - GAS SUPPLY	2004	21
53	Mechanical	AIR COMPRESSOR	LENNOX	COB-5F1-C	960609-DE303	2002/26 H1 PHASE V - GAS SUPPLY	2004	21
54	Mechanical	AIR COMPRESSOR	LENNOX	COB-5F1-C	960609-DE303	2002/26 H1 PHASE V - GAS SUPPLY	2004	21
55	Mechanical	AIR COMPRESSOR	LENNOX	COB-5F1-C	960609-DE303	2002/26 H1 PHASE V - GAS SUPPLY	2004	21

KEYNOTES

CW	DESCRIPTION	DETAIL
----	-------------	--------

SHEPPHARD
ASSOCIATES
ARCHITECTS + ENGINEERS
26560 AGOURA ROAD, SUITE 106
CALABASAS, CA 91302

310.367.8030 will.s@shep-se.com

THE INFORMATION SHOWN ON THESE DRAWINGS IS OWNED BY AND IS THE PROPERTY OF SHEPPARD

NO PART THEREOF SHALL BE COPIED, ADAPTED, OR
DISTRIBUTED TO OTHERS WITHOUT THE PRIOR
WRITTEN CONSENT OF
SHEPPARD ASSOCIATES, ARCHITECTS-ENGINEERS
COPYRIGHT © 2008

CARNEGIE
CENTER

912 3RD STREET.
ORLAND, CA 95963

ISSUE		
NO.	DATE	DESCRIPTION
04/22/24		

REVISION		
NO.	DATE	DESCRIPTION

BUILDING
ELEVATIONS -
EXISTING

A3.2
SCALE: 1/4" = 1'-0"
DRAWN BY: Author
PROJECT NO.: 123-456