


DELONG ROSCOE CAR WASH ESS



DEVELOPED BY



LOCATION INFORMATION	
LAT/LONG:	(42.429615, -89.014115)
GOVERNING CODES:	
BUILDING	(2015) IBC (INTL. BUILDING CODE)
FIRE	(2015) IFC (INTL. FIRE CODE)
ELECTRICAL	(2014) NEC ELECTRICAL CODE
AHU	Village of Roscoe
SITE SPECIFICATIONS	
RISK CATEGORY	II
DESIGN WIND SPEED	115
EXPOSURE CATEGORY	C
GROUND SNOW LOAD	25
SEISMIC IMPORTANCE FACTOR	1
SEISMIC RESPONSE COEFFICIENT	TBD
SEISMIC DESIGN CATEGORY	B
CLOSEST ASHRAE STATION:	ROCK COUNTY AP, WI, USA (WMO: 726415)
ASHRAE - EXTREME ANNUAL MEAN MINIMUM DESIGN DRY BULB TEMPERATURE	-24.4°C
ASHRAE - EXTREME ANNUAL MEAN MAXIMUM DESIGN DRY BULB TEMPERATURE	35.2°C
SYSTEM SIZE INFORMATION	
AC RATING (kW)	530.4kW
ESS INFORMATION	
MANUFACTURER	TESLA
MODEL	MEGAPACK 2XL
SYSTEM SPECIFICATIONS	530.4kW/2121.6kWh/650KVA

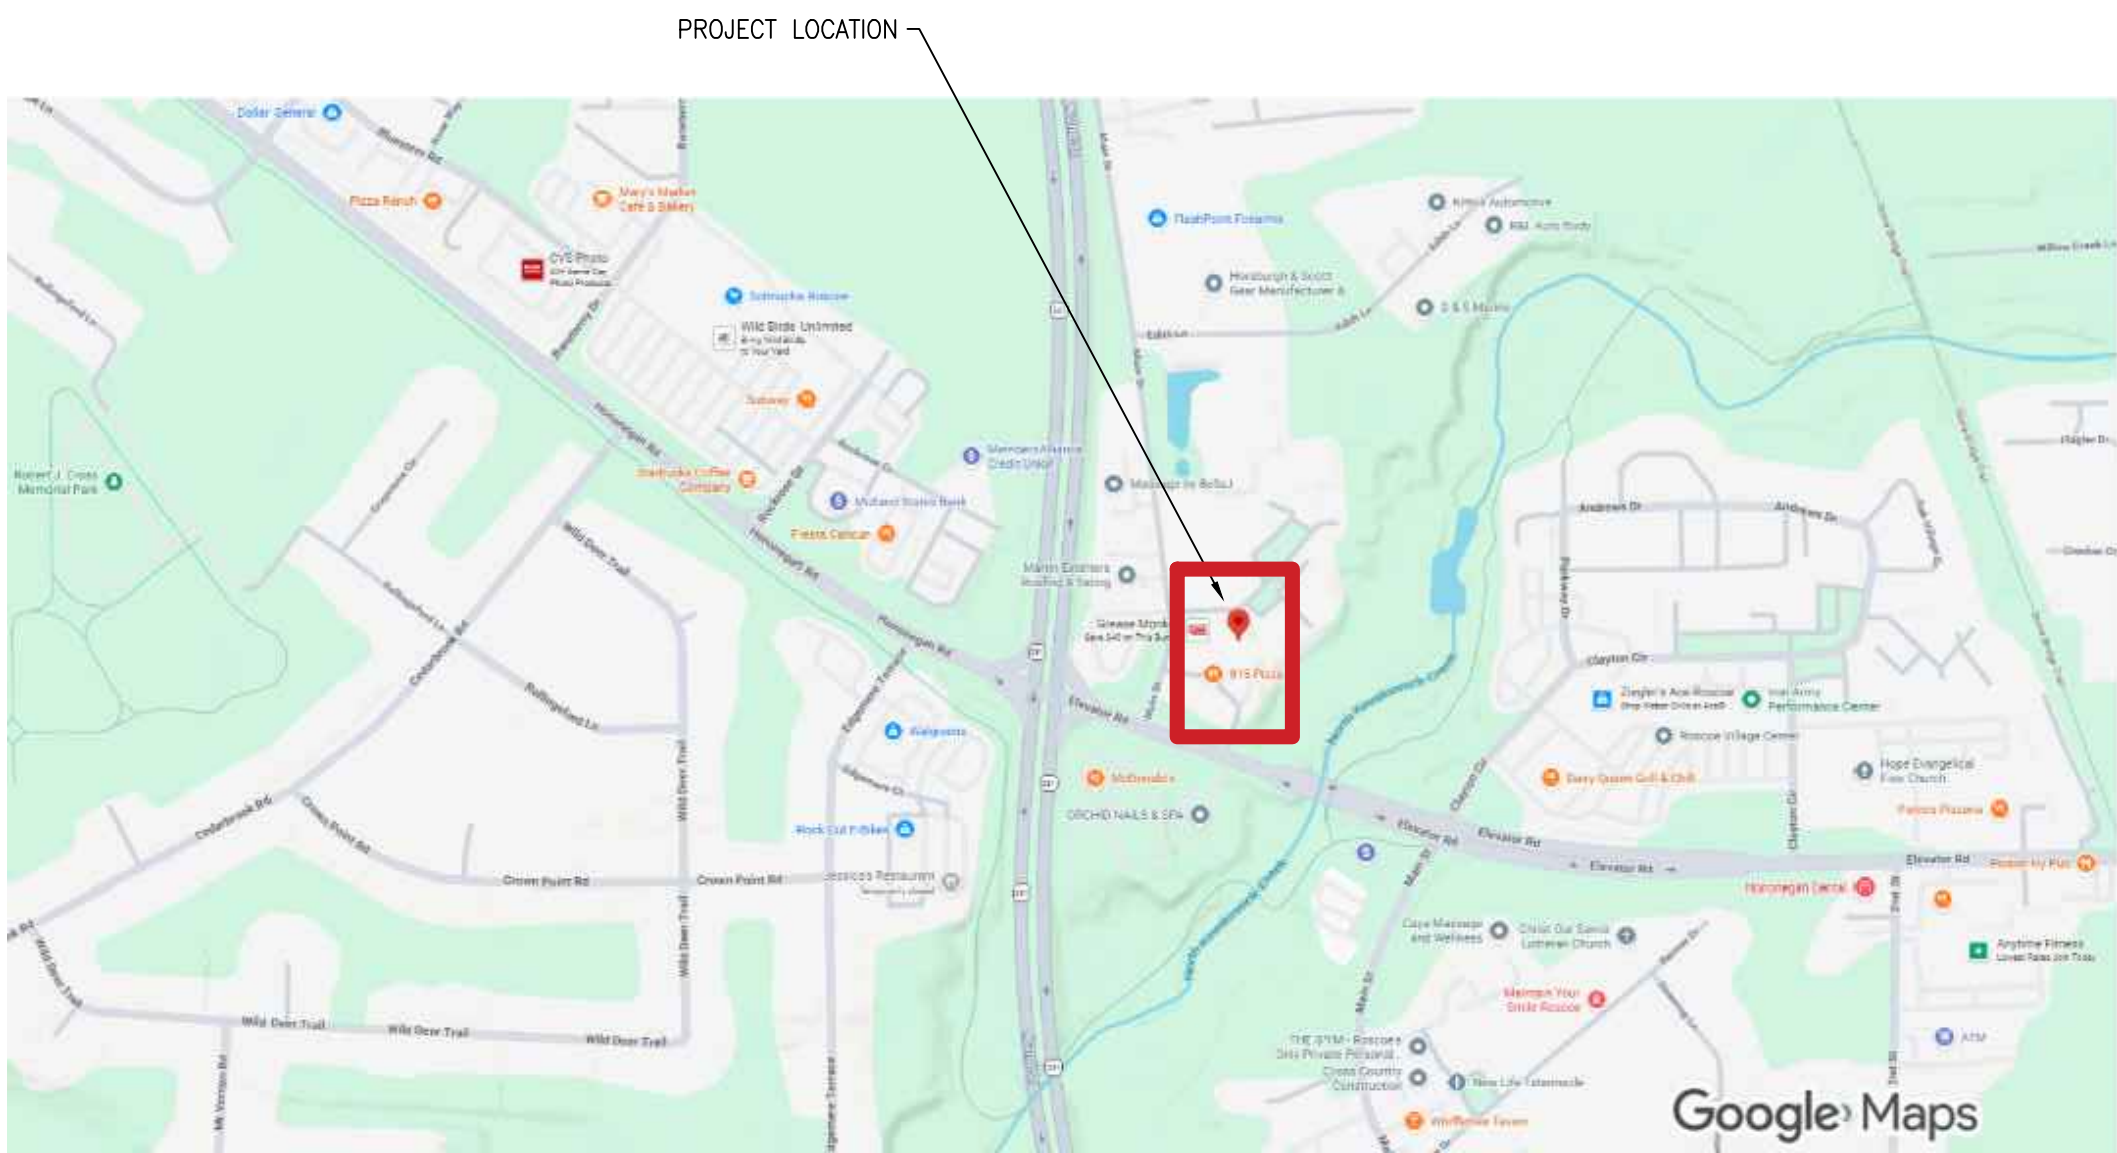

1 VICINITY MAP
NTS



2 OVERALL AERIAL MAP
NTS

SHEET INDEX		● E0.0 - COVER PAGE ● E0.1 - ELECTRICAL NOTES ● E1.0 - SITE PLAN - OVERALL ● E1.0B - ENLARGED ESS & EQUIPMENT LAYOUT ● E1.0C - ESS FEEDER PLAN ● E1.0D - ESS DETAILS ● E2.1 - SINGLE LINE DIAGRAM ● E3.1 - SAFETY PLACARDS ● E4.1 - EQUIPMENT SPECIFICATIONS
●	NEW DRAWING	
Δ	REVISED DRAWING	
○	NO CHANGES	
-	DRAWING REMOVED	
+	REMOVED DRAWING RETURNED TO SET	
DATE	ISSUANCE	
8/19/2026	ISSUED FOR PERMIT	

3 SHEET INDEX



4	08-19-26	ISSUED FOR PERMIT	ODR
3	07-24-26	RE-ISSUED FOR INTERCONNECTION	ODR
2	02-20-24	RE-ISSUED FOR INTERCONNECTION	MFV
1	09-07-23	ISSUED FOR INTERCONNECTION	ODR
NO.	DATE	REVISION	BY

WIZ O' WASH
11629 MAIN ST
ROSCOE IL 61073

SHEET NAME:
COVER
PAGE


REVIEWED AND APPROVED BY:	CL	PROJECT NUMBER	4260003
DESIGN BY:	CL	SHEET NUMBER	E0.0

CONTRACT DRAWING REFERENCE



CONTINENTAL
ENERGY SOLUTIONS

815 COMMERCE DRIVE
SUITE 280
OAK BROOK, ILLINOIS 60523
WWW.CESNRG.COM

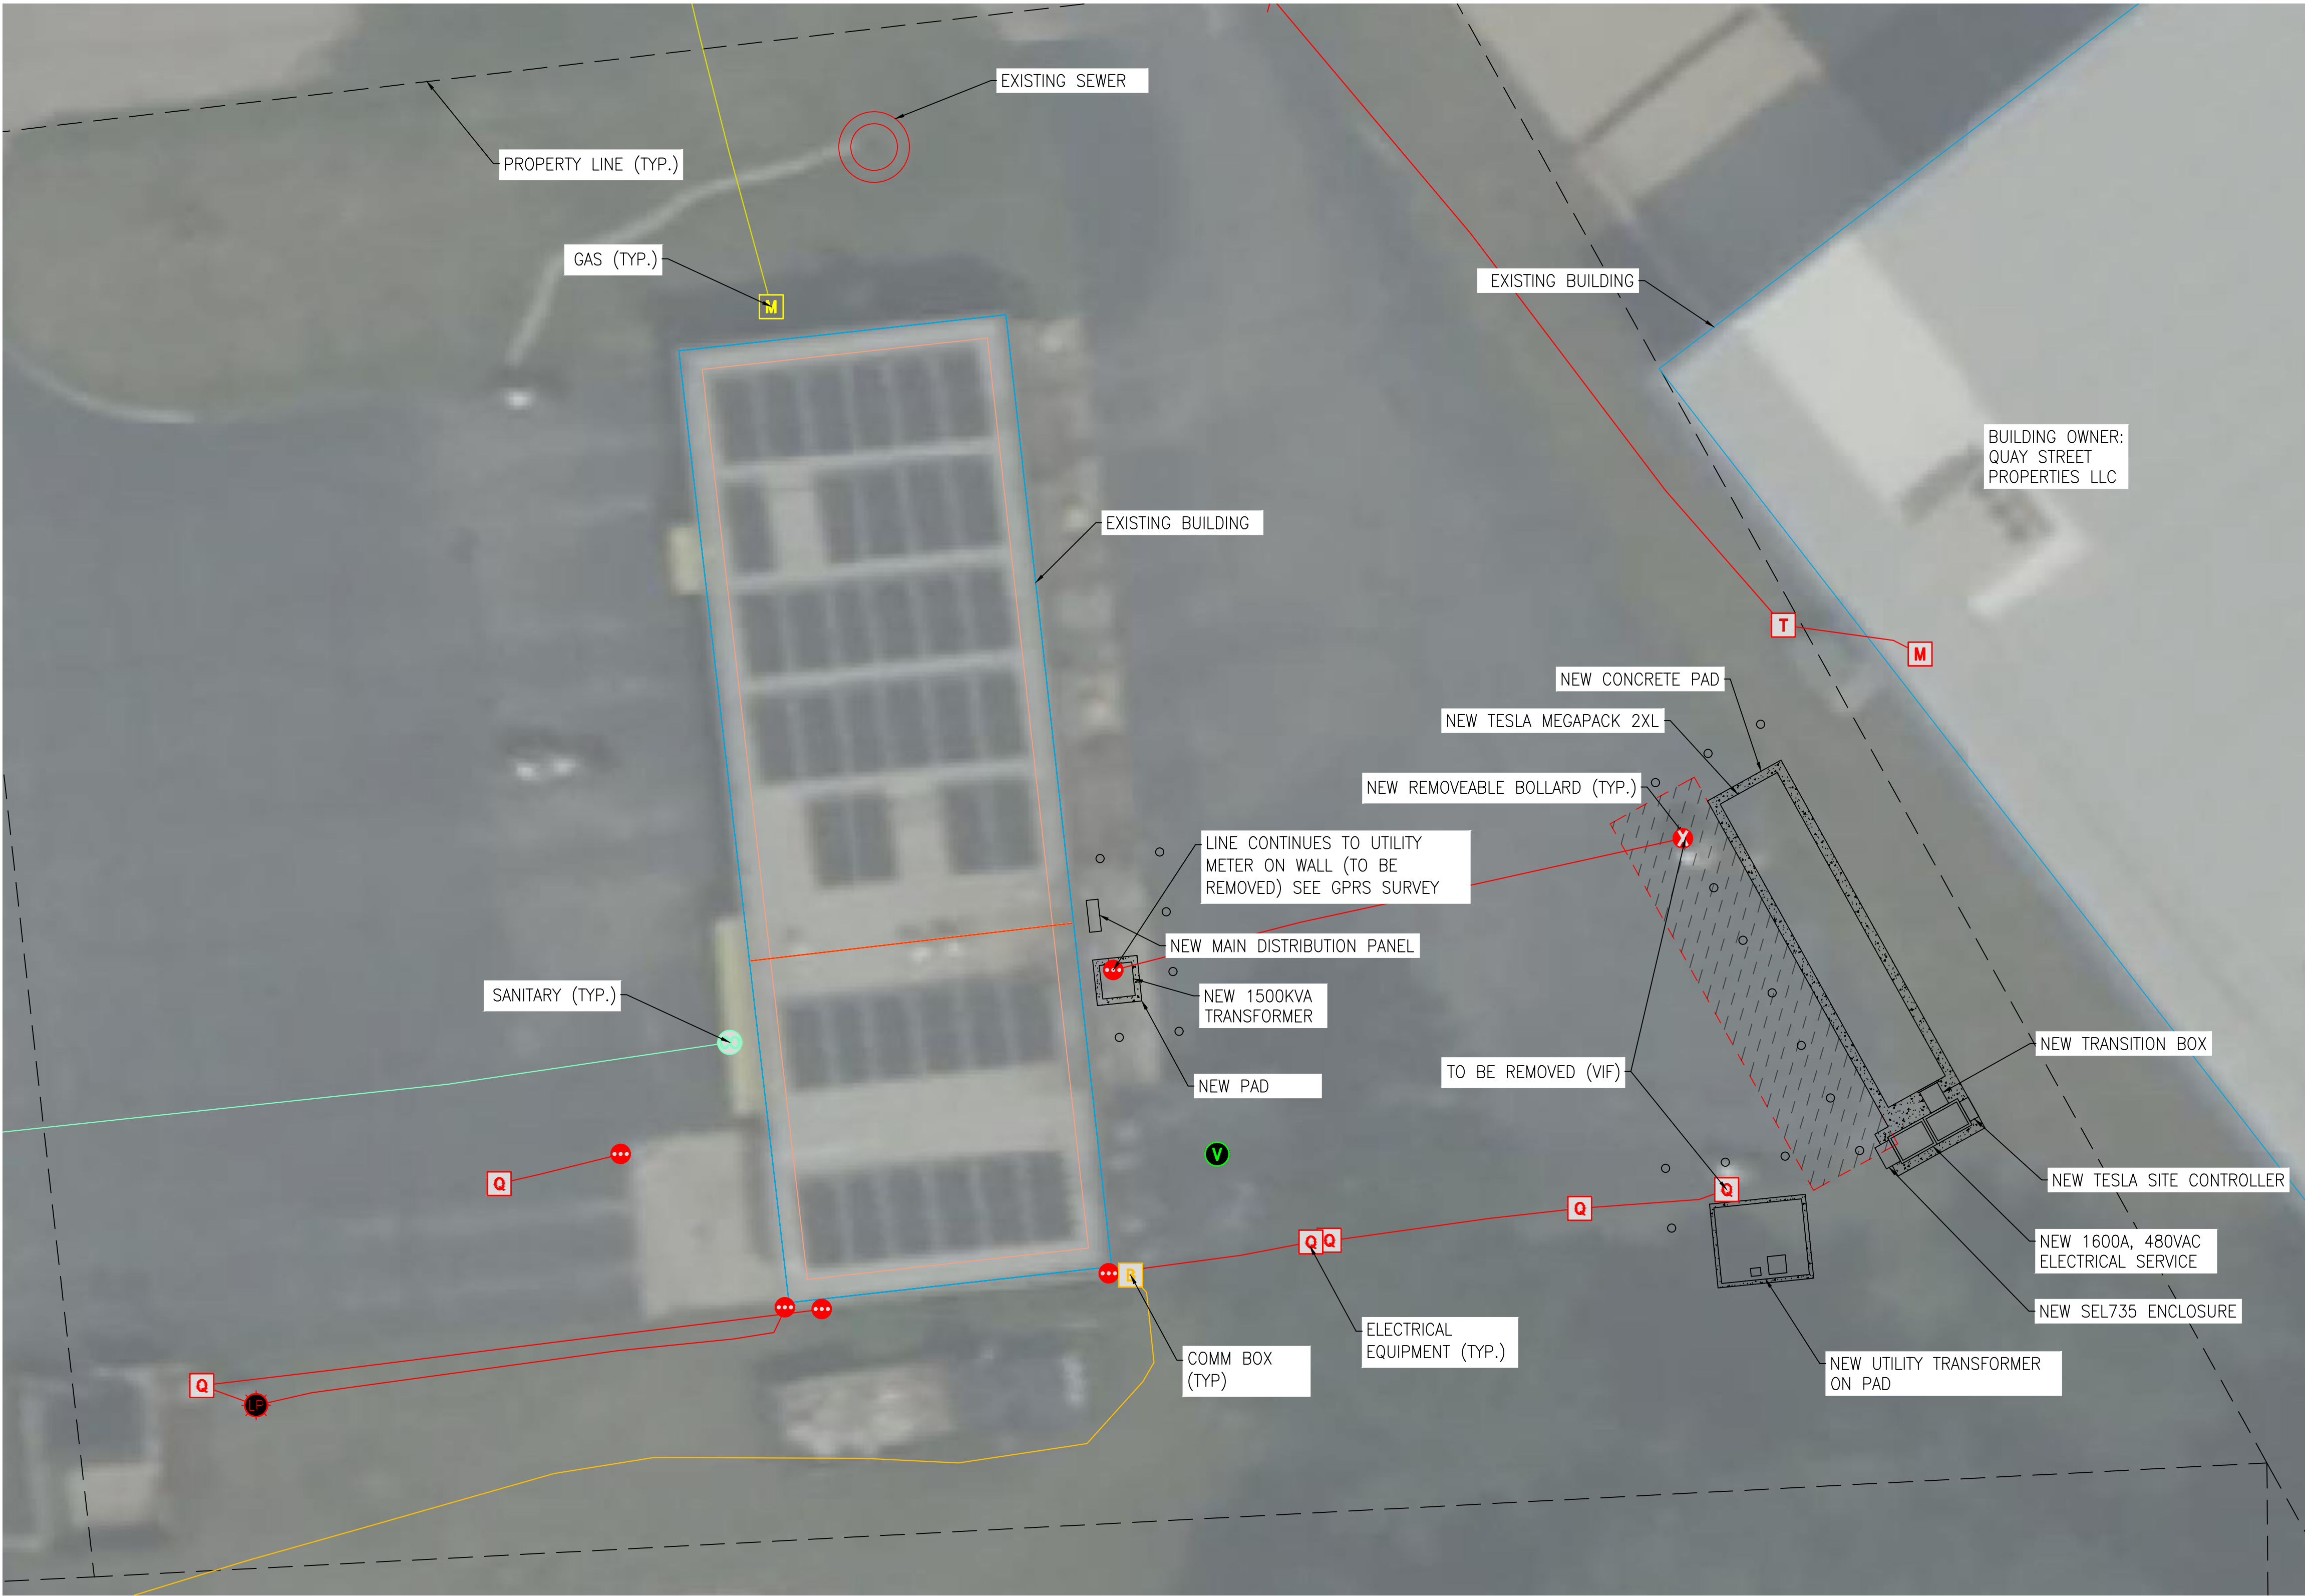

1 OVERALL SITE PLAN
SCALE: 1/8" = 1'-0"

GENERAL NOTES

1. NO NEW INTERIOR OR EXTERIOR LIGHTING PROPOSED AS PART OF THIS PROJECT.
2. NO GRADING OF EXISTING SOIL PROPOSED AS PART OF THIS PROJECT.
3. ALL WORK SHALL COMPLY WITH APPLICABLE RULES, REGULATIONS, AND STANDARDS OF THE AUTHORITY HOLDING JURISDICTION (AHJ).
4. EXISTING FEATURES, INCLUDING TREES AND UTILITIES, ARE TO REMAIN PROTECTED DURING CONSTRUCTION.
5. DISPOSE OF ALL CONSTRUCTION DEBRIS AND SPOILS OFF SITE, IN ACCORDANCE WITH APPLICABLE LAWS, RULES, AND REGULATIONS.
6. UTILITIES SHALL BE PRE-LOCATED AND MARKED ABOVE GROUND PRIOR TO CONSTRUCTION. RACKING POSTS SHALL BRIDGE PRE-LOCATED UTILITIES.
7. FOR DETAILS RELATED TO EROSION PREVENTION, PLEASE REFER TO THE PROVIDED, SITE-SPECIFIC SWPPP & LANDSCAPING PLAN.
8. FOR DETAILS RELATED TO SITE STABILIZATION & MAINTENANCE, PLEASE REFER TO PROVIDED, SITE-SPECIFIC LANDSCAPING PLAN.
9. ARC-FLASH HAZARD WARNING MARKINGS WILL BE PROVIDED ON ELECTRICAL EQUIPMENT THAT IS LIKELY TO REQUIRE EXAMINATION,ADJUSTMENT,SERVICING, OR MAINTENANCE WHILE ENERGIZED TO WARN QUALIFIED PERSONS.
10. WHEREVER CIRCUIT CONDUCTORS ARE SPLICED IN A BOX, ALL EQUIPMENT GROUNDING CONDUCTORS ASSOCIATED WITH THESE CIRCUITS SHALL BE BONDED ("PIGTAILED") TO THE BOX.
11. 3' MINIMUM CLEARANCE WILL BE PROVIDED AROUND ALL FUNCTIONING ELECTRICAL EQUIPMENT.
12. INSTALLATION TO BE IN COMPLIANCE WITH NFPA 855. A PROEJCT SPECIFIC HAZARD MITIGATION ANALYSIS (HMA) MUST BE PREPARED, AND INSTALLATION SHOULD BE IN COMPLIANCE WITH THE PROJECT SPECIFIC HMA.

LEGEND:



4	08-19-26	ISSUED FOR PERMIT	ODR
3	07-24-26	RE-ISSUED FOR INTERCONNECTION	ODR
2	02-20-24	RE-ISSUED FOR INTERCONNECTION	MFV
1	09-07-23	ISSUED FOR INTERCONNECTION	ODR
NO.	DATE	REVISION	BY


WIZ O' WASH
11629 MAIN ST
ROSCOE IL 61073

SHEET NAME:
OVERALL SITE PLAN

REVIEWED AND APPROVED BY:	CL	PROJECT NUMBER	4260003
DESIGN BY:	CL	SHEET NUMBER	E 1 . 0


CONTRACT DRAWING REFERENCE



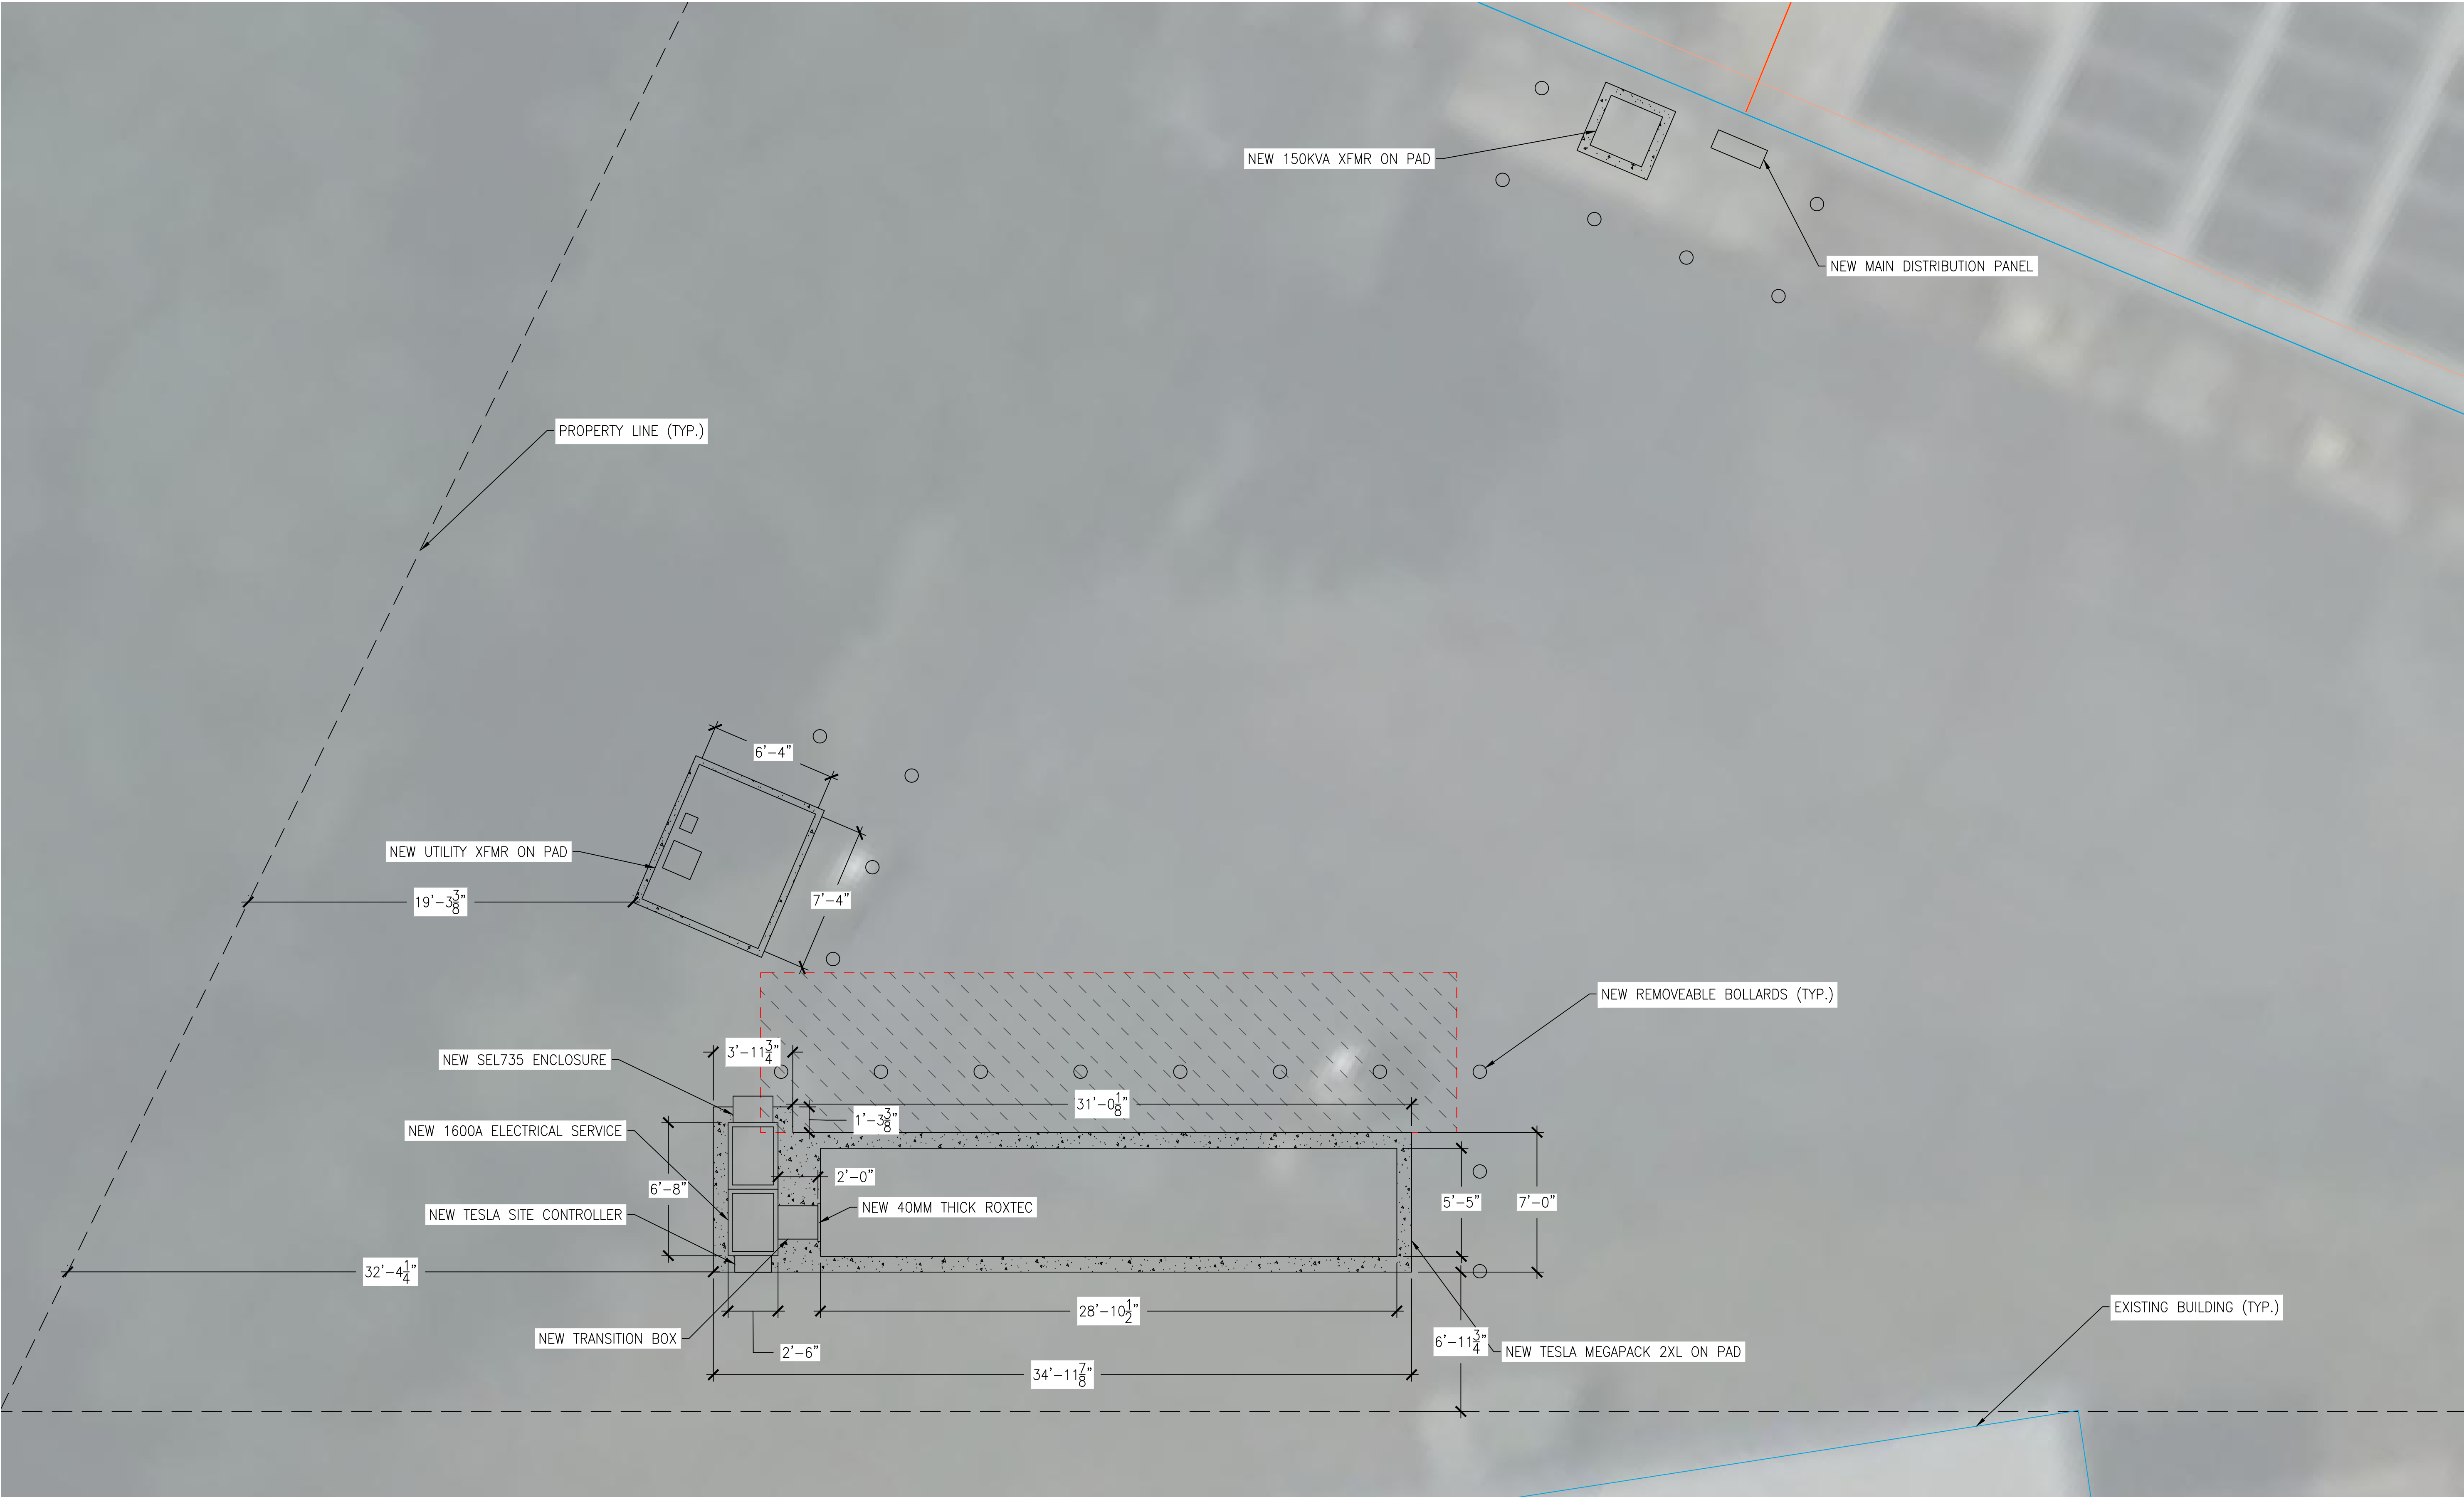

LEGEND:

TESLA 2XL MEGAPACK

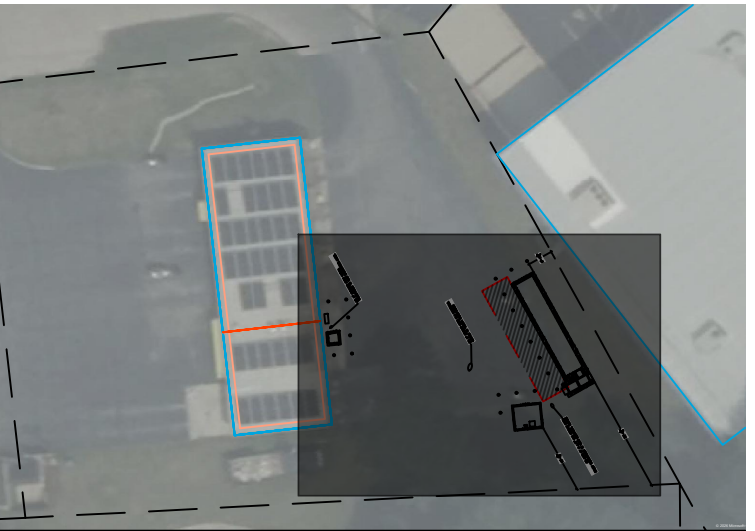

4	08-19-26	ISSUED FOR PERMIT	ODR
3	07-24-26	RE-ISSUED FOR INTERCONNECTION	ODR
2	02-20-24	RE-ISSUED FOR INTERCONNECTION	MFV
1	09-07-23	ISSUED FOR INTERCONNECTION	ODR
NO.	DATE	REVISION	BY

WIZ O' WASH
11629 MAIN ST
ROSCOE IL 61073

SHEET NAME:
ENLARGED ESS &
EQUIPMENT LAYOUT

REVIEWED AND APPROVED BY:	CL	PROJECT NUMBER	4260003
DESIGN BY:	CL	SHEET NUMBER	E1.0B
CONTRACT DRAWING REFERENCE			

CONTINENTAL
ENERGY SOLUTIONS

815 COMMERCE DRIVE
SUITE 280
OAK BROOK, ILLINOIS 60523
WWW.CESNRG.COM


1

ENLARGED ESS & EQUIPMENT LAYOUT

SCALE: 1/4" = 1'-0"

NOTES:

- ALL ELECTRICAL WORK SHALL BE IN ACCORDANCE WITH THE NATIONAL ELECTRICAL CODE AND THE REQUIREMENTS OF THE LOCAL AUTHORITY HOLDING JURISDICTION (AHJ).
- ALL EQUIPMENT IS LISTED AND LABELED PER RECOGNIZED ELECTRICAL TESTING LABORATORY AND INSTALLED PER THE LISTING.
- ALL OUTDOOR EQUIPMENT SHALL BE MINIMUM NEMA 3R.
- VERIFY ALL EQUIPMENT AND DIMENSIONS WITH APPROVED EQUIPMENT RECORD DRAWINGS PRIOR TO BEGINNING WORK.
- EQUIPMENT AND INSTALLATION DETAILS SHALL BE COORDINATED WITH FINAL EQUIPMENT CUT SHEETS.
- CONDUIT SHOWN IS DIAGRAMMATIC AND DOES NOT REFLECT ANY/ALL OBSTRUCTIONS.
- CONTRACTOR TO DETERMINE EXACT ROUTE OF CONDUIT BASED ON EXISTING CONDITIONS.
- CONTRACTOR TO COORDINATE PLANNED CONDUITS ROUTES WITH CONTINENTAL ENERGY SOLUTIONS.
- CONDUIT MUST BE IDENTIFIED AT BOTH ENDS.
- PROVIDE A PULL STRING AND SEAL WITH AN APPROVED SEALANT AT BOTH ENDS.
- ALL WIRE SHALL BE COPPER UNLESS NOTED OTHERWISE (U.N.O.).

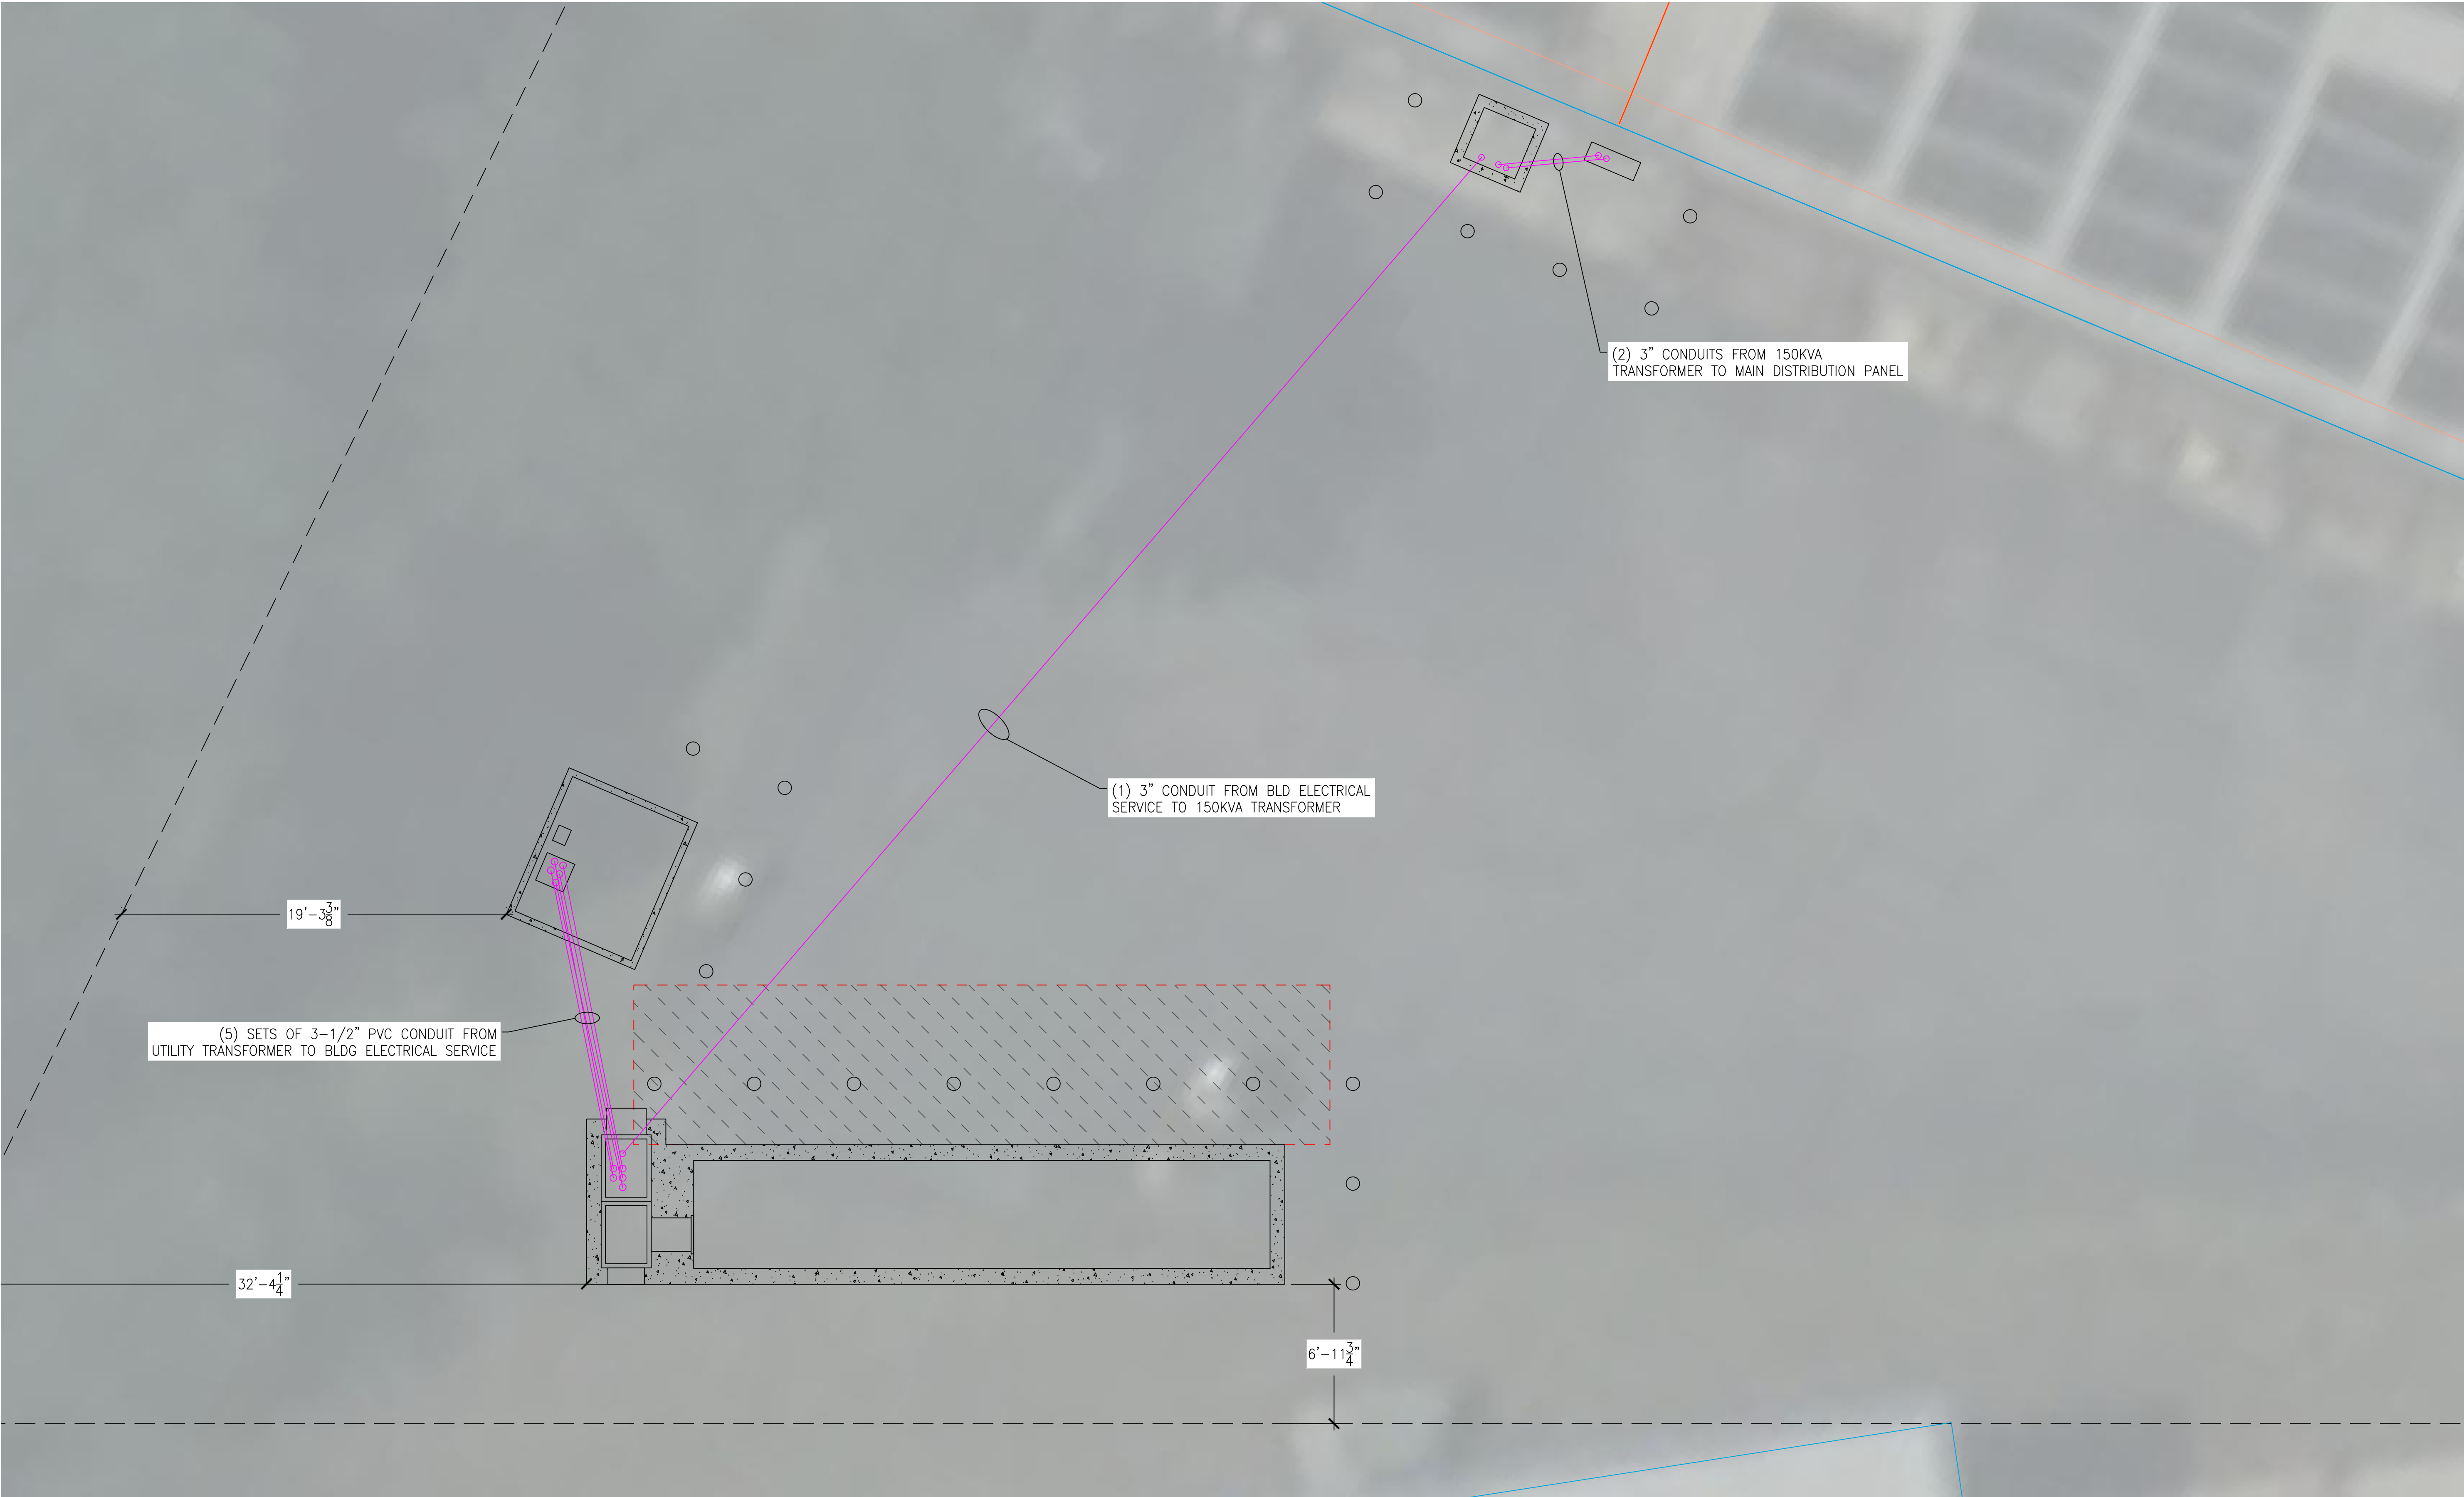


1 ESS FEEDER PLAN
SCALE: 1/4" = 1'-0"

NOTES:

- ALL ELECTRICAL WORK SHALL BE IN ACCORDANCE WITH THE NATIONAL ELECTRICAL CODE AND THE REQUIREMENTS OF THE LOCAL AUTHORITY HOLDING JURISDICTION (AHJ).
- ALL EQUIPMENT IS LISTED AND LABELED PER RECOGNIZED ELECTRICAL TESTING LABORATORY AND INSTALLED PER THE LISTING.
- ALL OUTDOOR EQUIPMENT SHALL BE MINIMUM NEMA 3R.
- VERIFY ALL EQUIPMENT AND DIMENSIONS WITH APPROVED EQUIPMENT RECORD DRAWINGS PRIOR TO BEGINNING WORK.
- EQUIPMENT AND INSTALLATION DETAILS SHALL BE COORDINATED WITH FINAL EQUIPMENT CUT SHEETS.
- CONDUIT SHOWN IS DIAGRAMMATIC AND DOES NOT REFLECT ANY/ALL OBSTRUCTIONS.
- CONTRACTOR TO DETERMINE EXACT ROUTE OF CONDUIT BASED ON EXISTING CONDITIONS.
- CONTRACTOR TO COORDINATE PLANNED CONDUITS ROUTES WITH CONTINENTAL ENERGY SOLUTIONS.
- CONDUIT MUST BE IDENTIFIED AT BOTH ENDS.
- PROVIDE A PULL STRING AND SEAL WITH AN APPROVED SEALANT AT BOTH ENDS.
- ALL WIRE SHALL BE COPPER UNLESS NOTED OTHERWISE (U.N.O.).

LEGEND:

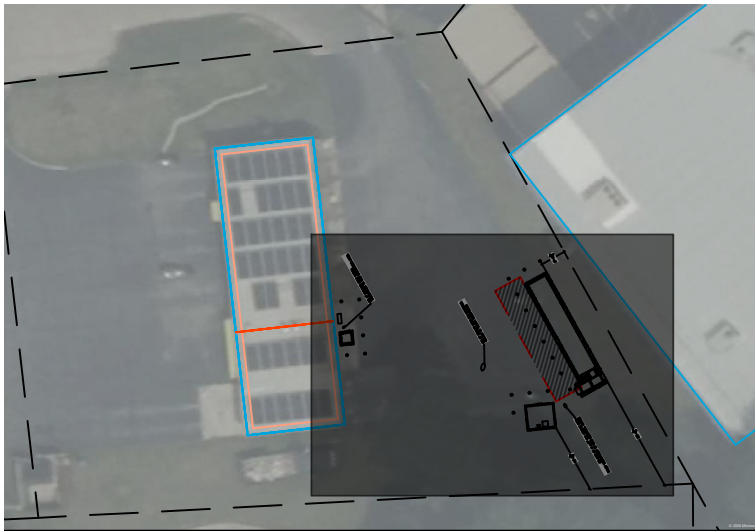

4	08-19-26	ISSUED FOR PERMIT	ODR
3	07-24-26	RE-ISSUED FOR INTERCONNECTION	ODR
2	02-20-24	RE-ISSUED FOR INTERCONNECTION	MFV
1	09-07-23	ISSUED FOR INTERCONNECTION	ODR
NO.	DATE	REVISION	BY

WIZ O' WASH
11629 MAIN ST
ROSCOE IL 61073

SHEET NAME:
**ESS FEEDER
PLAN**


REVIEWED AND APPROVED BY:	CL	PROJECT NUMBER 4260003
DESIGN BY:	CL	SHEET NUMBER E1.00

CONTRACT DRAWING REFERENCE




GENERAL NOTES

1. CONCRETE PAD SIZE SHOWN IS FOR REFERENCE ONLY, FINAL PAD DESIGN TO BE DETERMINED AND STAMPED BY THE SEOR.
2. WHEN POSSIBLE EQUIPMENT TO BE PAINTED RAL9016 TRAFFIC WHITE

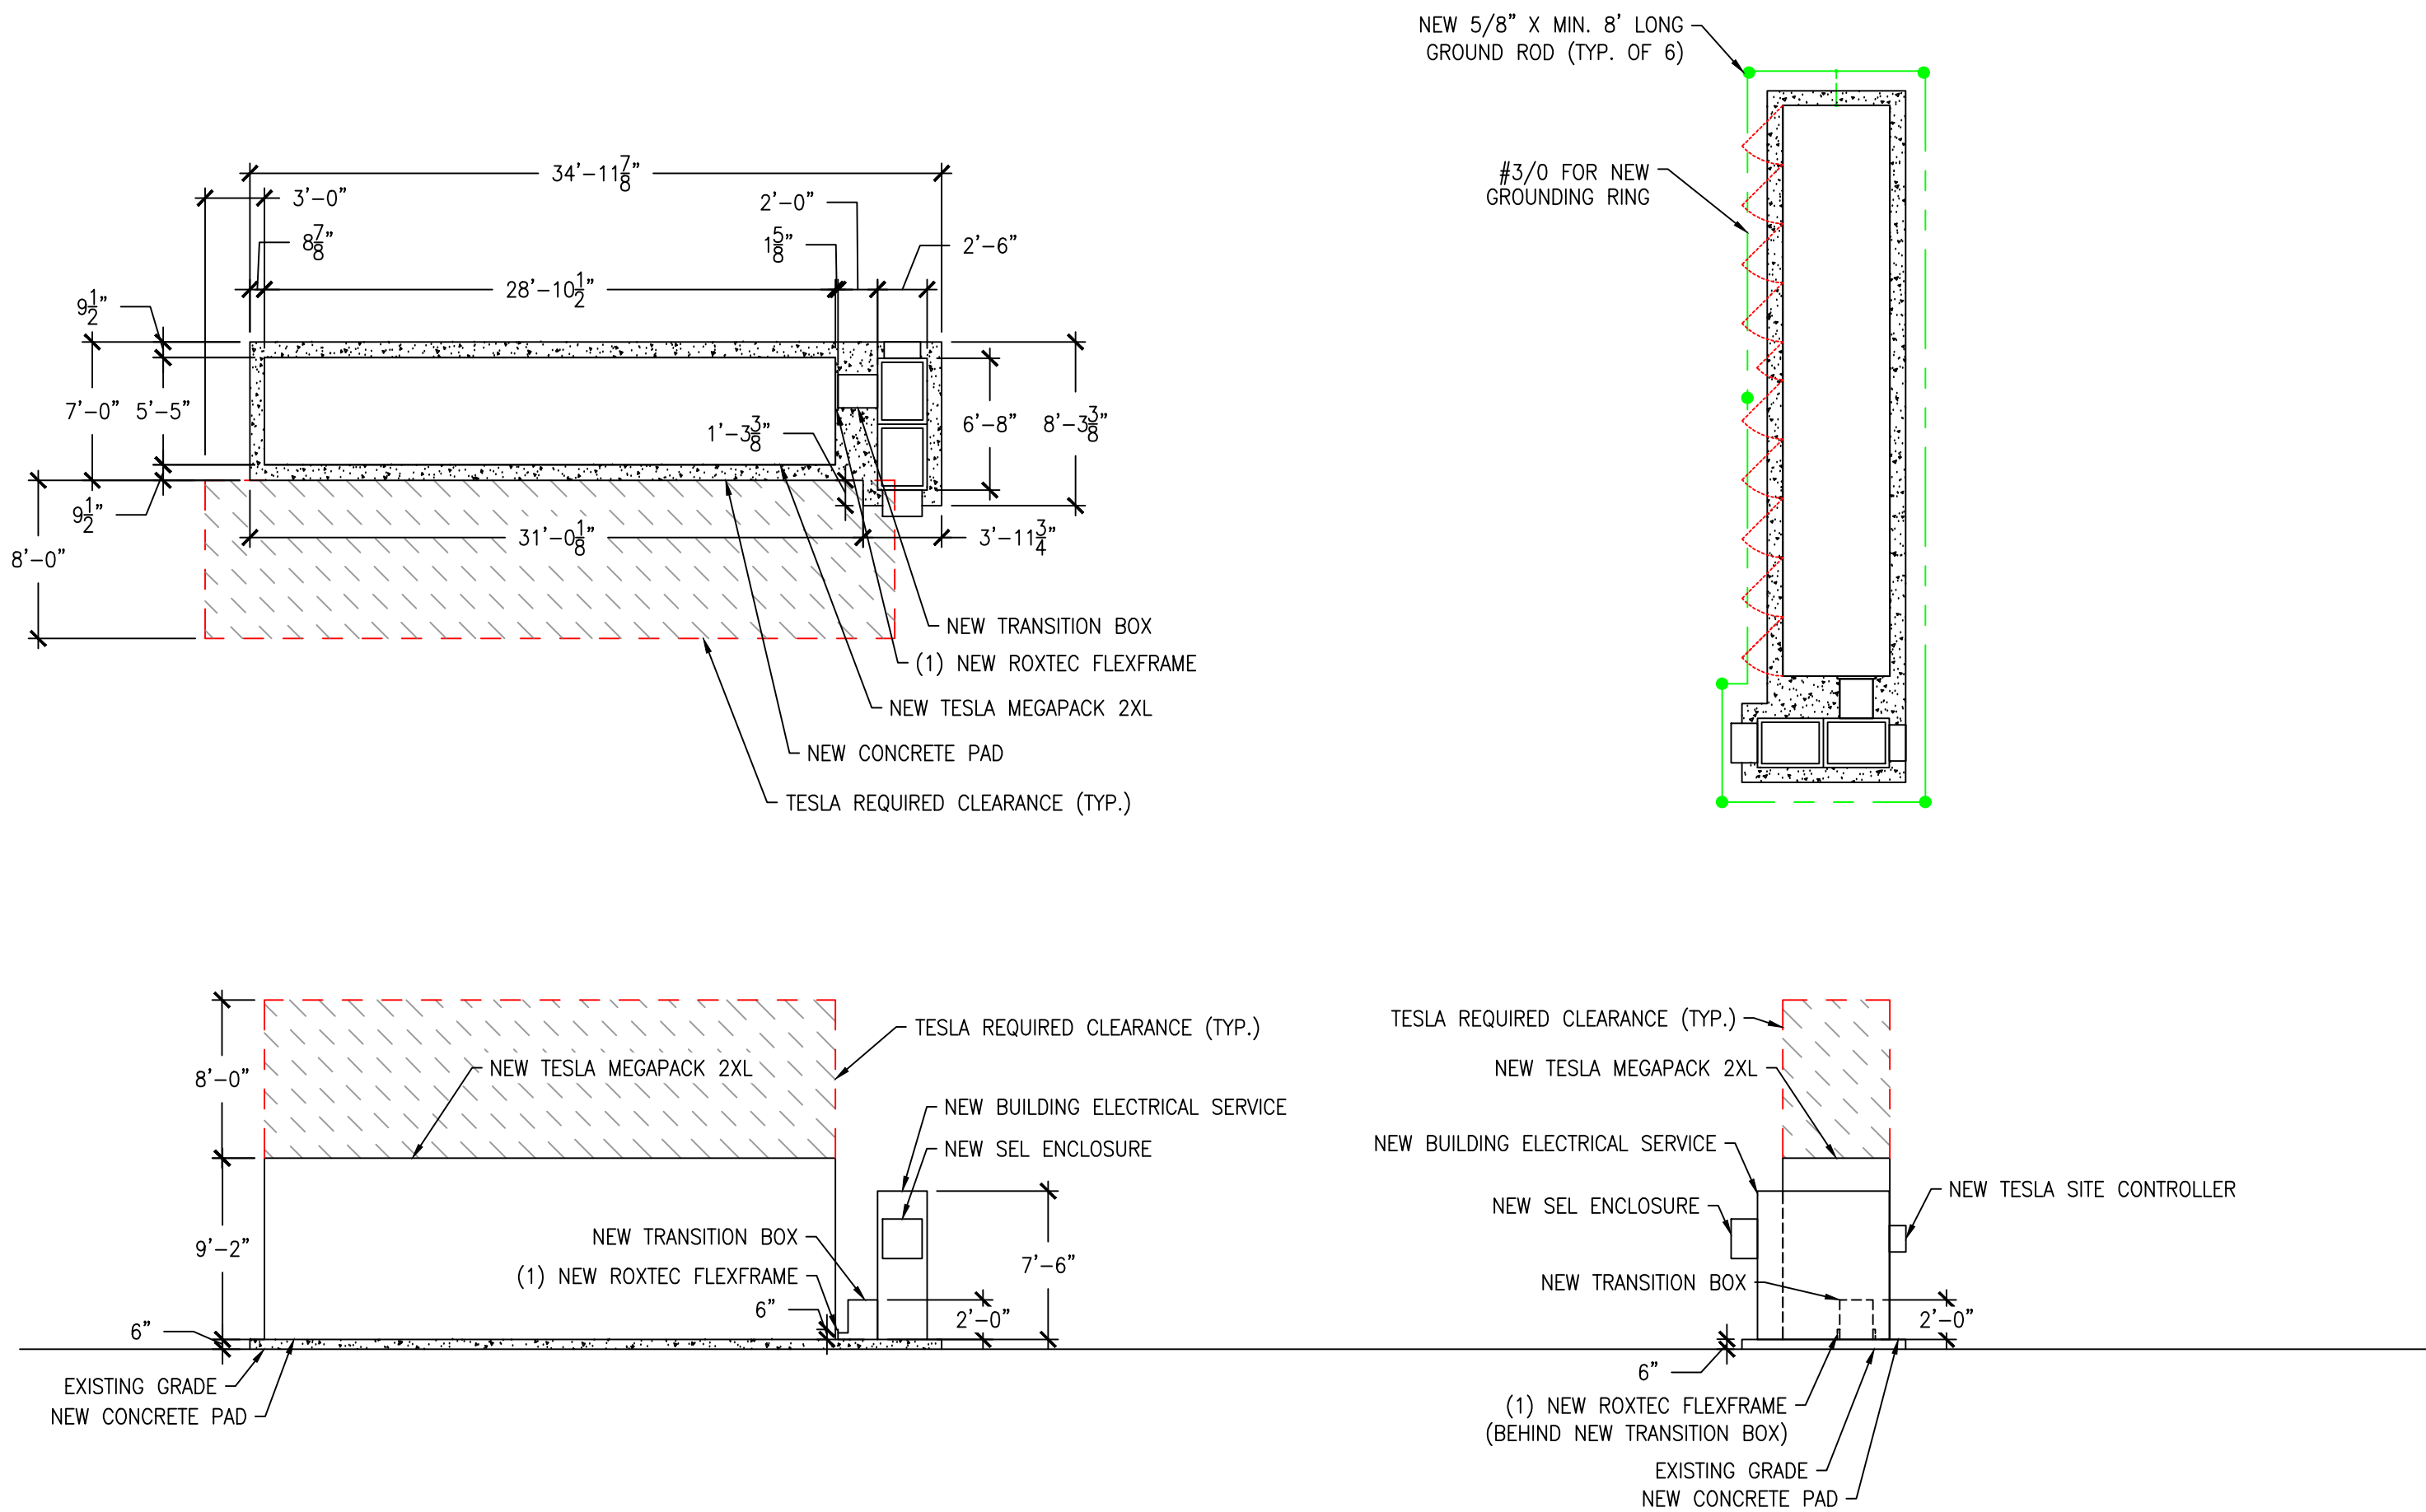

1 OVERALL CONCRETE PAD PLAN
SCALE: 1/8" = 1'-0"

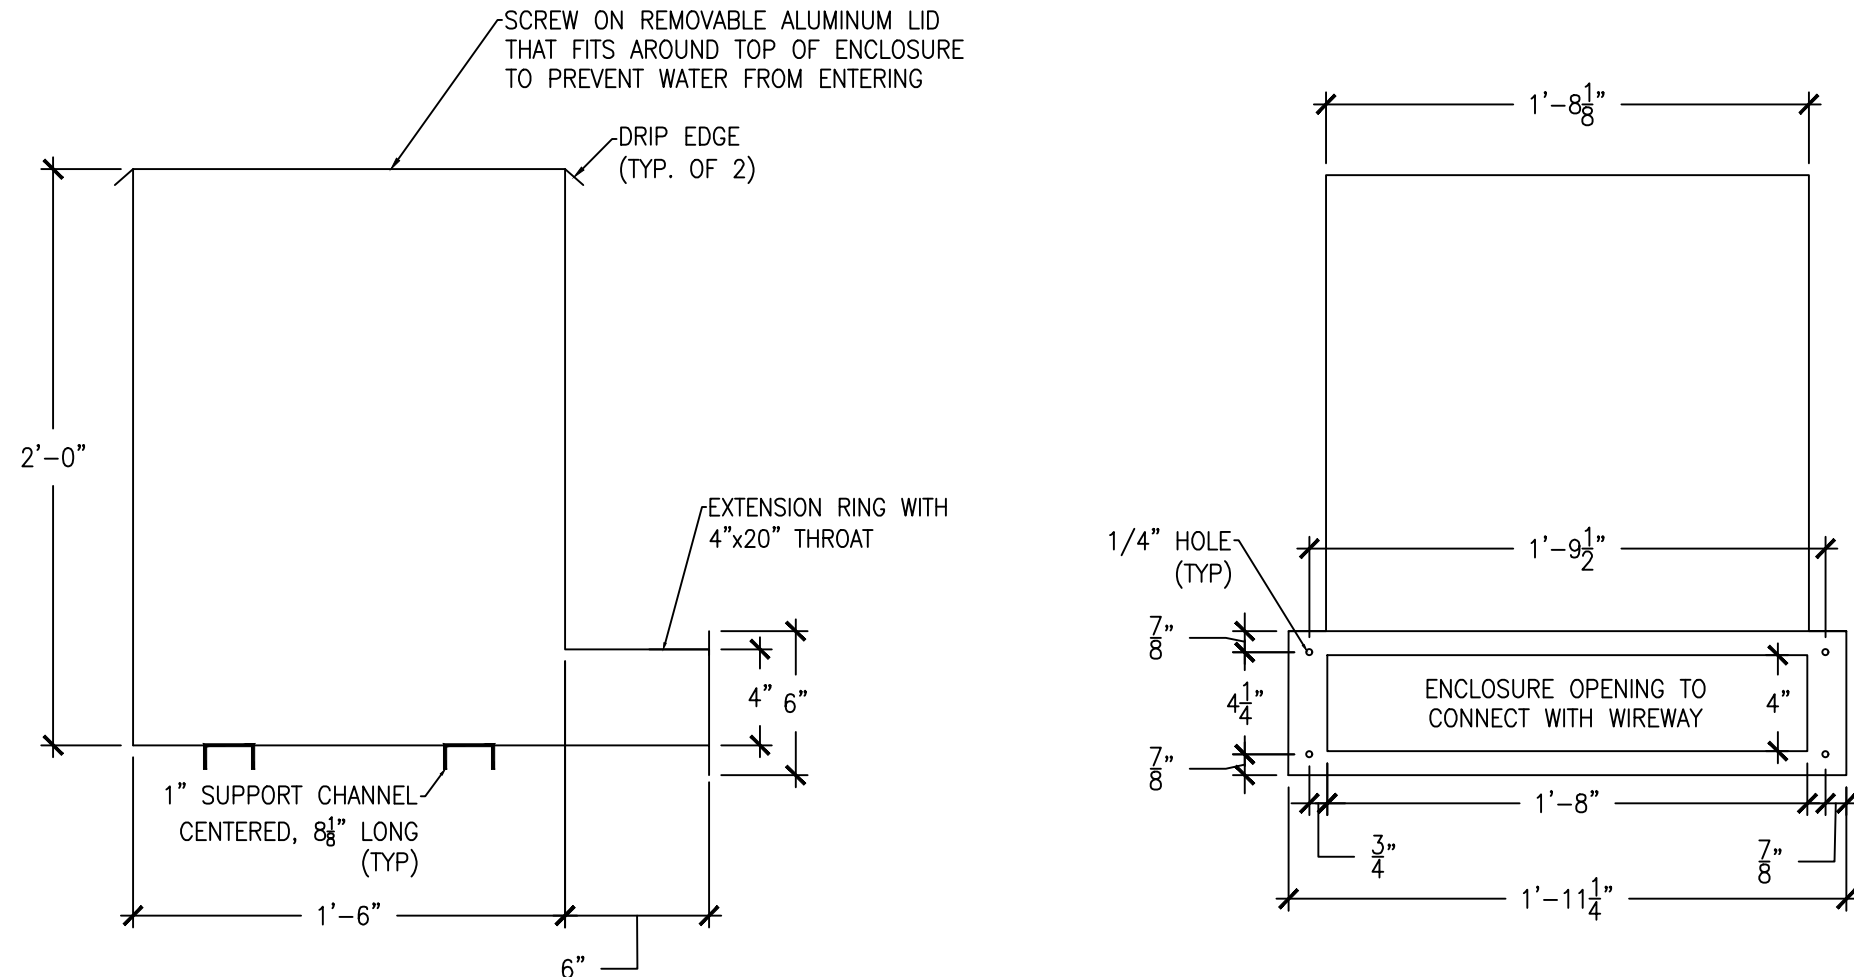

2 TRANSITION BOX SPECIFICATIONS
SCALE: NTS

4	08-19-26	ISSUED FOR PERMIT	ODR
3	07-24-26	RE-ISSUED FOR INTERCONNECTION	ODR
2	02-20-24	RE-ISSUED FOR INTERCONNECTION	MFV
1	09-07-23	ISSUED FOR INTERCONNECTION	ODR
NO.	DATE	REVISION	BY


WIZ O' WASH
11629 MAIN ST
ROSCOE IL 61073

SHEET NAME:
ESS DETAILS

REVIEWED AND APPROVED BY:	CL	PROJECT NUMBER	4260003
DESIGN BY:	CL	SHEET NUMBER	E1.00
CONTRACT DRAWING REFERENCE			

CONTINENTAL
ENERGY SOLUTIONS

815 COMMERCE DRIVE
SUITE 280
OAK BROOK, ILLINOIS 60523
WWW.CESNRG.COM

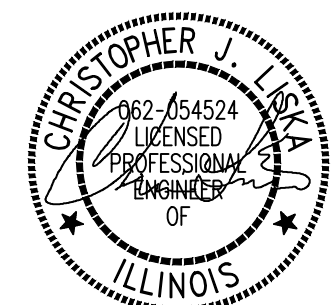


WIZ O' WASH
11629 MAIN ST
ROSCOE IL 61073

SHEET NAME: ONE-LINE
DIAGRAM




CONTINENTAL
ENERGY SOLUTIONS


815 COMMERCE DRIVE
SUITE 280
OAK BROOK, ILLINOIS 60523
WWW.CESNRG.COM

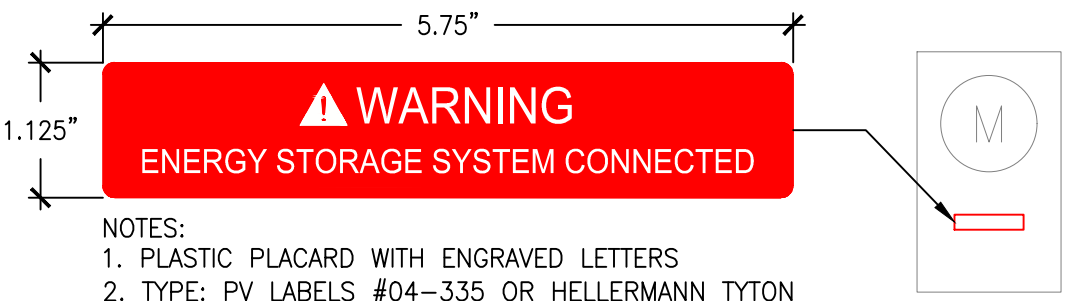


1 UTILITY/ METER LABELING DETAIL
NTS

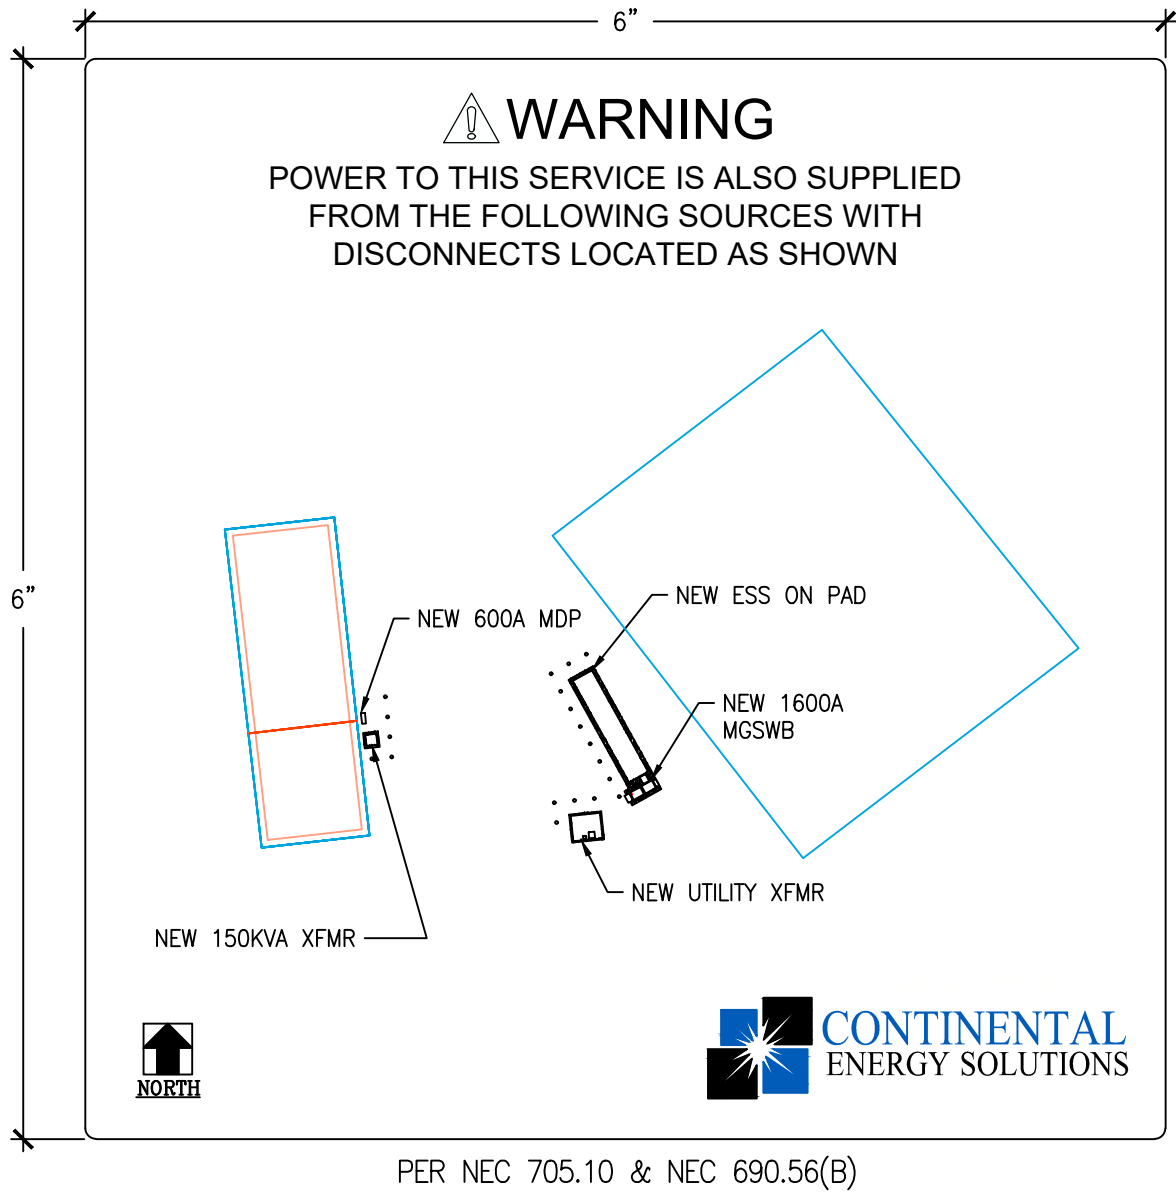

2 BUILDING/STRUCTURE LABELING DETAIL
NTS

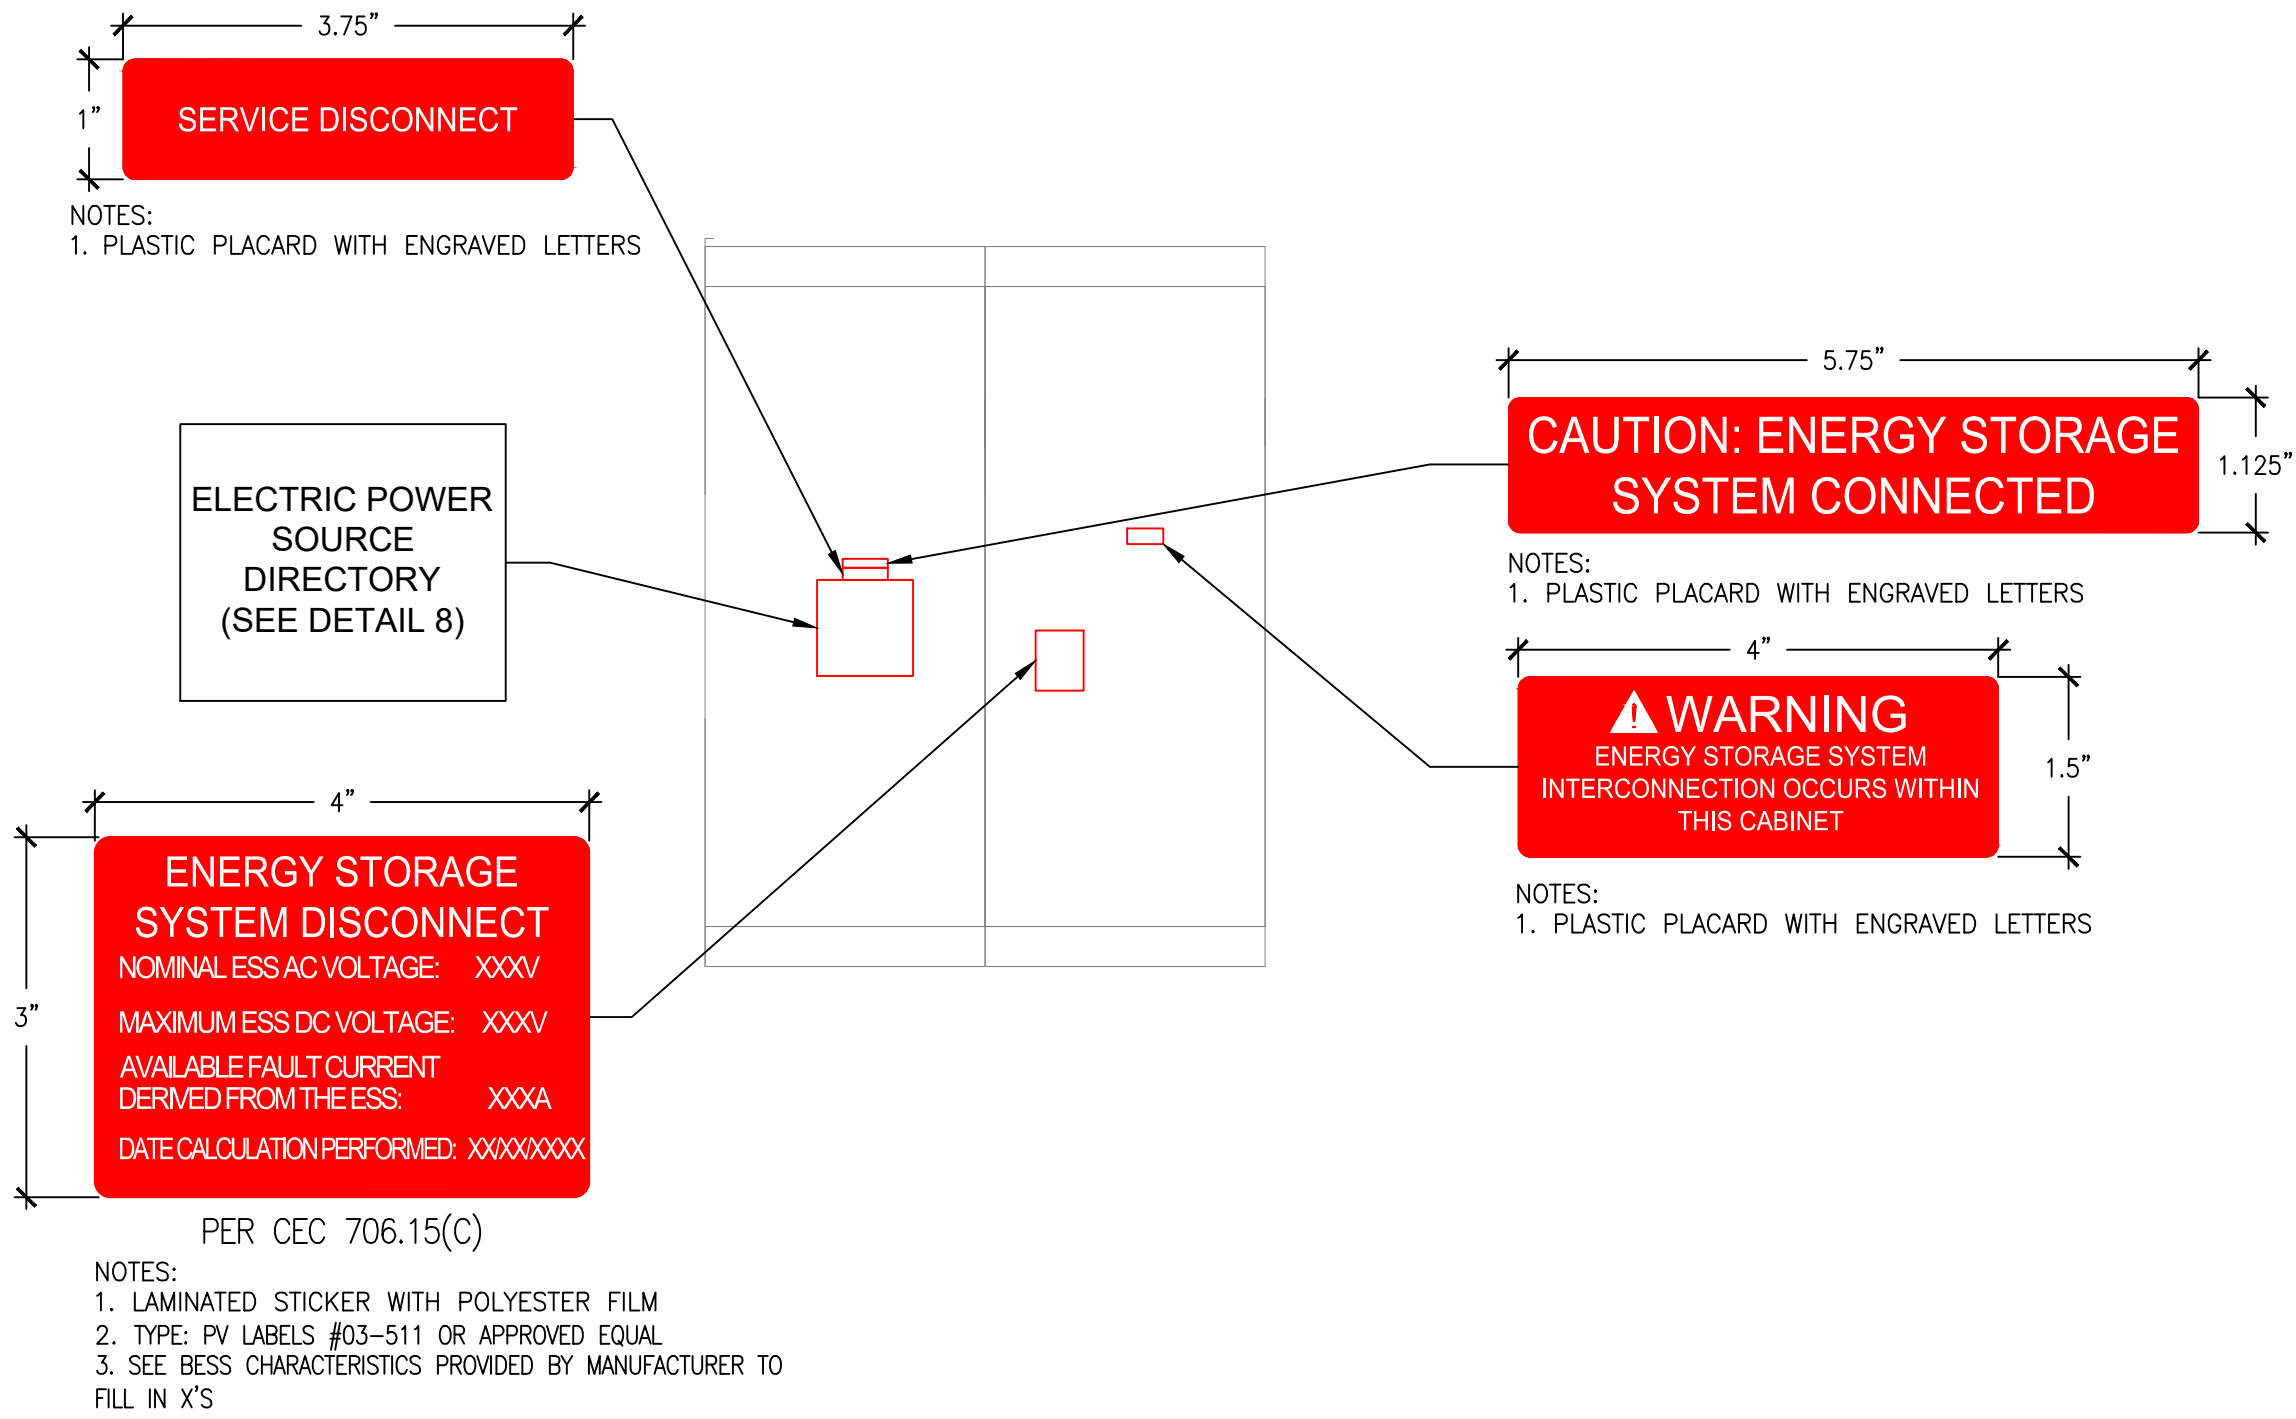

4 MICROGRID SWITCHBOARD LABELING DETAIL
NTS

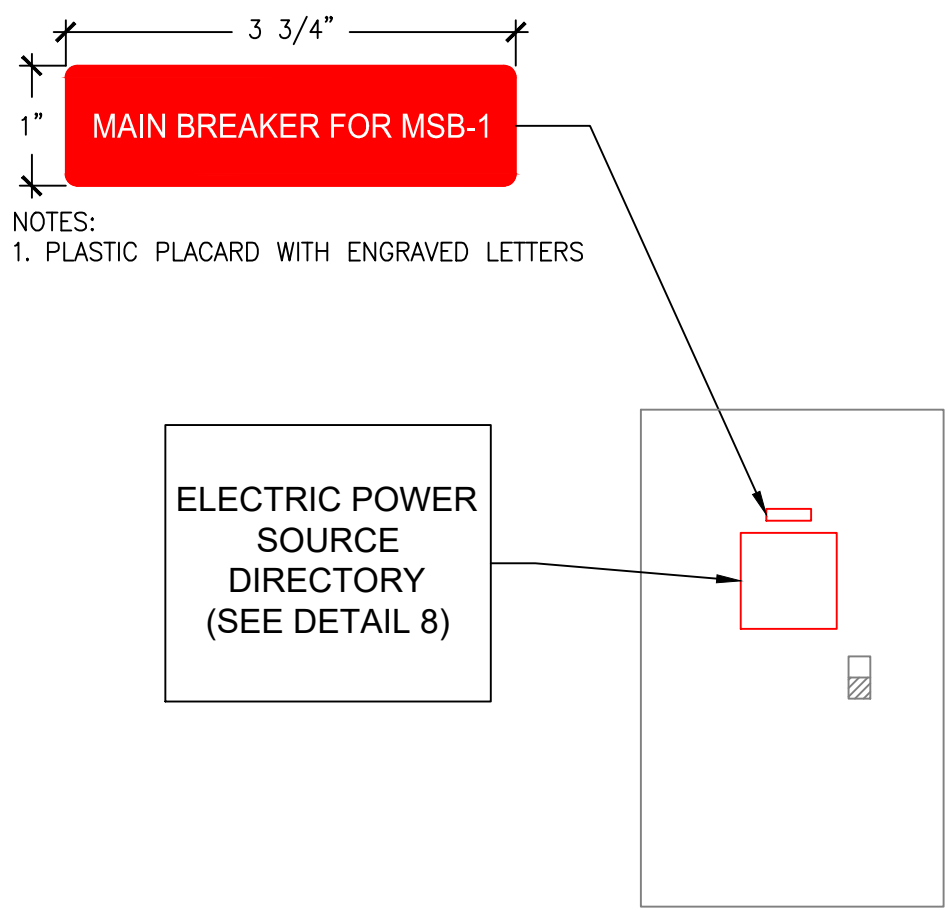

4 AC ENCLOSED C/B LABELING DETAIL
NTS

LABELING NOTES:

- ALL NECESSARY SIGNAGE MUST MEET REQUIREMENTS OF ART. 110, 690 AND 705 AS OUTLINED IN THIS SIGNAGE SCHEDULE.
- ALL SIGNAGE SHALL MEET THE REQUIREMENTS BELOW:
 - BE LABEL TYPE (LAMINATED STICKER WITH POLYESTER FILM) OR PLACARD TYPE (MIN. 1/16" PLASTIC PLACARD WITH ENGRAVED LETTERS)
 - APPLICATION BY ADHESIVE BACK, WITH ADHESIVE SUITABLE FOR LIFE OF PV SYSTEM
 - LISTED TO UL 969
 - REFLECTIVE AND SUITABLE FOR THEIR ENVIRONMENT. SIGNAGE LOCATED OUTSIDE SHALL BE SUITABLE FOR DIRECT SUNLIGHT, RAIN, SNOW, ICE, FOG, AND SALT AIR WITH A MINIMUM TEMPERATURE RATING OF -40 TO 176 DEG FAHRENHEIT.
 - RED BACKGROUND, WHITE LETTERING
 - LETTERING SHALL BE ALL CAPITAL LETTERS WITH ARIAL OR SIMILAR FONT, NON-BOLD
- ALL DIMENSIONS ARE APPROXIMATE. CONTRACTOR TO VERIFY DIMENSIONS ON SITE PRIOR TO PROCUREMENT TO ENSURE ADEQUATE SPACE FOR APPLICATION OF SIGNAGE
- NO FIELD MODIFICATION OF SIGNAGE INCLUDING HAND-WRITING LABELS SHALL BE PERMITTED
- SIGNAGE IN THIS SCHEDULE REPRESENT THE MINIMUM REQUIREMENTS FOR SIGNAGE, CONTRACTOR TO PROVIDE ANY ADDITIONAL SIGNAGE REQUIRED TO FACILITATE A SUFFICIENTLY LABELED SYSTEM



4	08-19-26	ISSUED FOR PERMIT	ODR
3	07-24-26	RE-ISSUED FOR INTERCONNECTION	ODR
2	02-20-24	RE-ISSUED FOR INTERCONNECTION	MFV
1	09-07-23	ISSUED FOR INTERCONNECTION	ODR
NO.	DATE	REVISION	BY

WIZ O' WASH
11629 MAIN ST
ROSCOE IL 61073

SHEET NAME:
SAFETY
PLACARDS

REVIEWED AND APPROVED BY:	CL	PROJECT NUMBER	4260003
DESIGN BY:	CL	SHEET NUMBER	E 3. 1

CONTRACT DRAWING REFERENCE



MEGAPACK 2 XL DATASHEET

TESLA.COM/MEGAPACK

Grid transformation for the world's largest energy projects

- Best-in-class energy density and round-trip efficiency
- Industry-leading power electronics and thermal system performance
- Rapid and cost-effective deployment with factory-assembled and pre-tested solution

Scaled and rigorously tested product safety and reliability

- Comprehensive in-house reliability testing by the leading experts in the industry
- Engineered for safety and performance at every level
- Continuous improvement based on large-scale operational experience

Designed with flexibility and configurability in mind

- Modular architecture that allows for a range of configurations across multiple applications
- Industry experts available to identify site-specific needs
- Integrated solution that allows for battery augmentation over time



POWER AND ENERGY

Megapack duration is configurable. Standard configurations are 2-Hour and 4-Hour durations. Nominal energy is specified at 25°C (77°F).

	AC Power per Megapack	Energy per Megapack
2-Hour	1927 kW	3854 kWh
4-Hour	979 kW	3916 kWh

ELECTRICAL

Nominal AC Voltage	480 V AC 3-phase
Nominal Frequency	50 or 60 Hz
Inverter Power per Megapack ¹	2-Hour Max: 2400 kVA 4-Hour Max: 1320 kVA
Round-Trip Efficiency ²	2-Hour: 91.7% 4-Hour: 93.7%

¹ Scalable from 400 kVA minimum in increments of 50 kVA

² Full-depth cycle including all power conversion and thermal system losses, at 25°C (77°F)

WARRANTY

Coverage	All-inclusive, equipment and energy retention
Term	15 years standard, extendable to 20 years

PART NUMBER

1848844-XX-Y Where X is a number between 0-9 and Y is a letter

MECHANICAL AND MOUNTING

Ingress Ratings	IP66/NEMA 3R (Main Enclosure) IP20 (Thermal System)	
Enclosure Dimensions +/- 13 mm (½ in)	Width: 8800 mm (346 ½ in) Depth: 1650 mm (65 in) Height: 2785 mm (110 in)	
Maximum Weight	38,100 kg (84,000 lb)	
Operating Ambient Temperature	-30°C to 50°C (-22°F to 122°F)	

REGULATORY

System is compliant to grid codes and safety standards of all major markets.

System	NRTL listed to UL 1973, UL 9540, UL 9540A, UL 1741 SB, IEC 62619, IEEE 1547	
Cells	NRTL listed to UL 1642	

CONTROLS AND COMMUNICATIONS

Protocols	Modbus TCP / DNP3 / REST API	
Core Control Modes	Direct Real Power Direct Reactive Power Frequency Support Virtual Inertia	Ramp Rate Control Site Control Power Factor Control Voltage Control

MONITORING

Powerhub	Free-to-use cloud monitoring portal
----------	-------------------------------------

TESLA

MEGAPACK 2 XL DATASHEET - REV. 1.6 - April 21, 2023

1

ESS SPECIFICATIONS

4	08-19-26	ISSUED FOR PERMIT	ODR
3	07-24-26	RE-ISSUED FOR INTERCONNECTION	ODR
2	02-20-24	RE-ISSUED FOR INTERCONNECTION	MFV
1	09-07-23	ISSUED FOR INTERCONNECTION	ODR
NO.	DATE	REVISION	BY

WIZ O' WASH

11629 MAIN ST
ROSCOE IL 61073

SHEET NAME:

EQUIPMENT SPECIFICATIONS

REVIEWED AND APPROVED BY: CL

PROJECT NUMBER
4260003

DESIGN BY: CL

SHEET NUMBER
E4.1

CONTRACT DRAWING REFERENCE

CONTINENTAL
ENERGY SOLUTIONS

815 COMMERCE DRIVE
SUITE 280
OAK BROOK, ILLINOIS 60523
WWW.CESNRG.COM

File Location: C:\Users\ORamirez\OneDrive\Documents\CES\Roscoe - Delong Roscoe - Project Files\00 - Project Delivery\ESS Adder\E2.1 ONE LINE DIAGRAM.dwg Designer: ORamirez