


THIS PRINT AND ALL INFORMATION HEREON IS THE PROPERTY OF KMA ARCHITECTS AND SHALL NOT BE USED ON ANY OTHER JOB WITHOUT WRITTEN PERMISSION OF THE ARCHITECT.

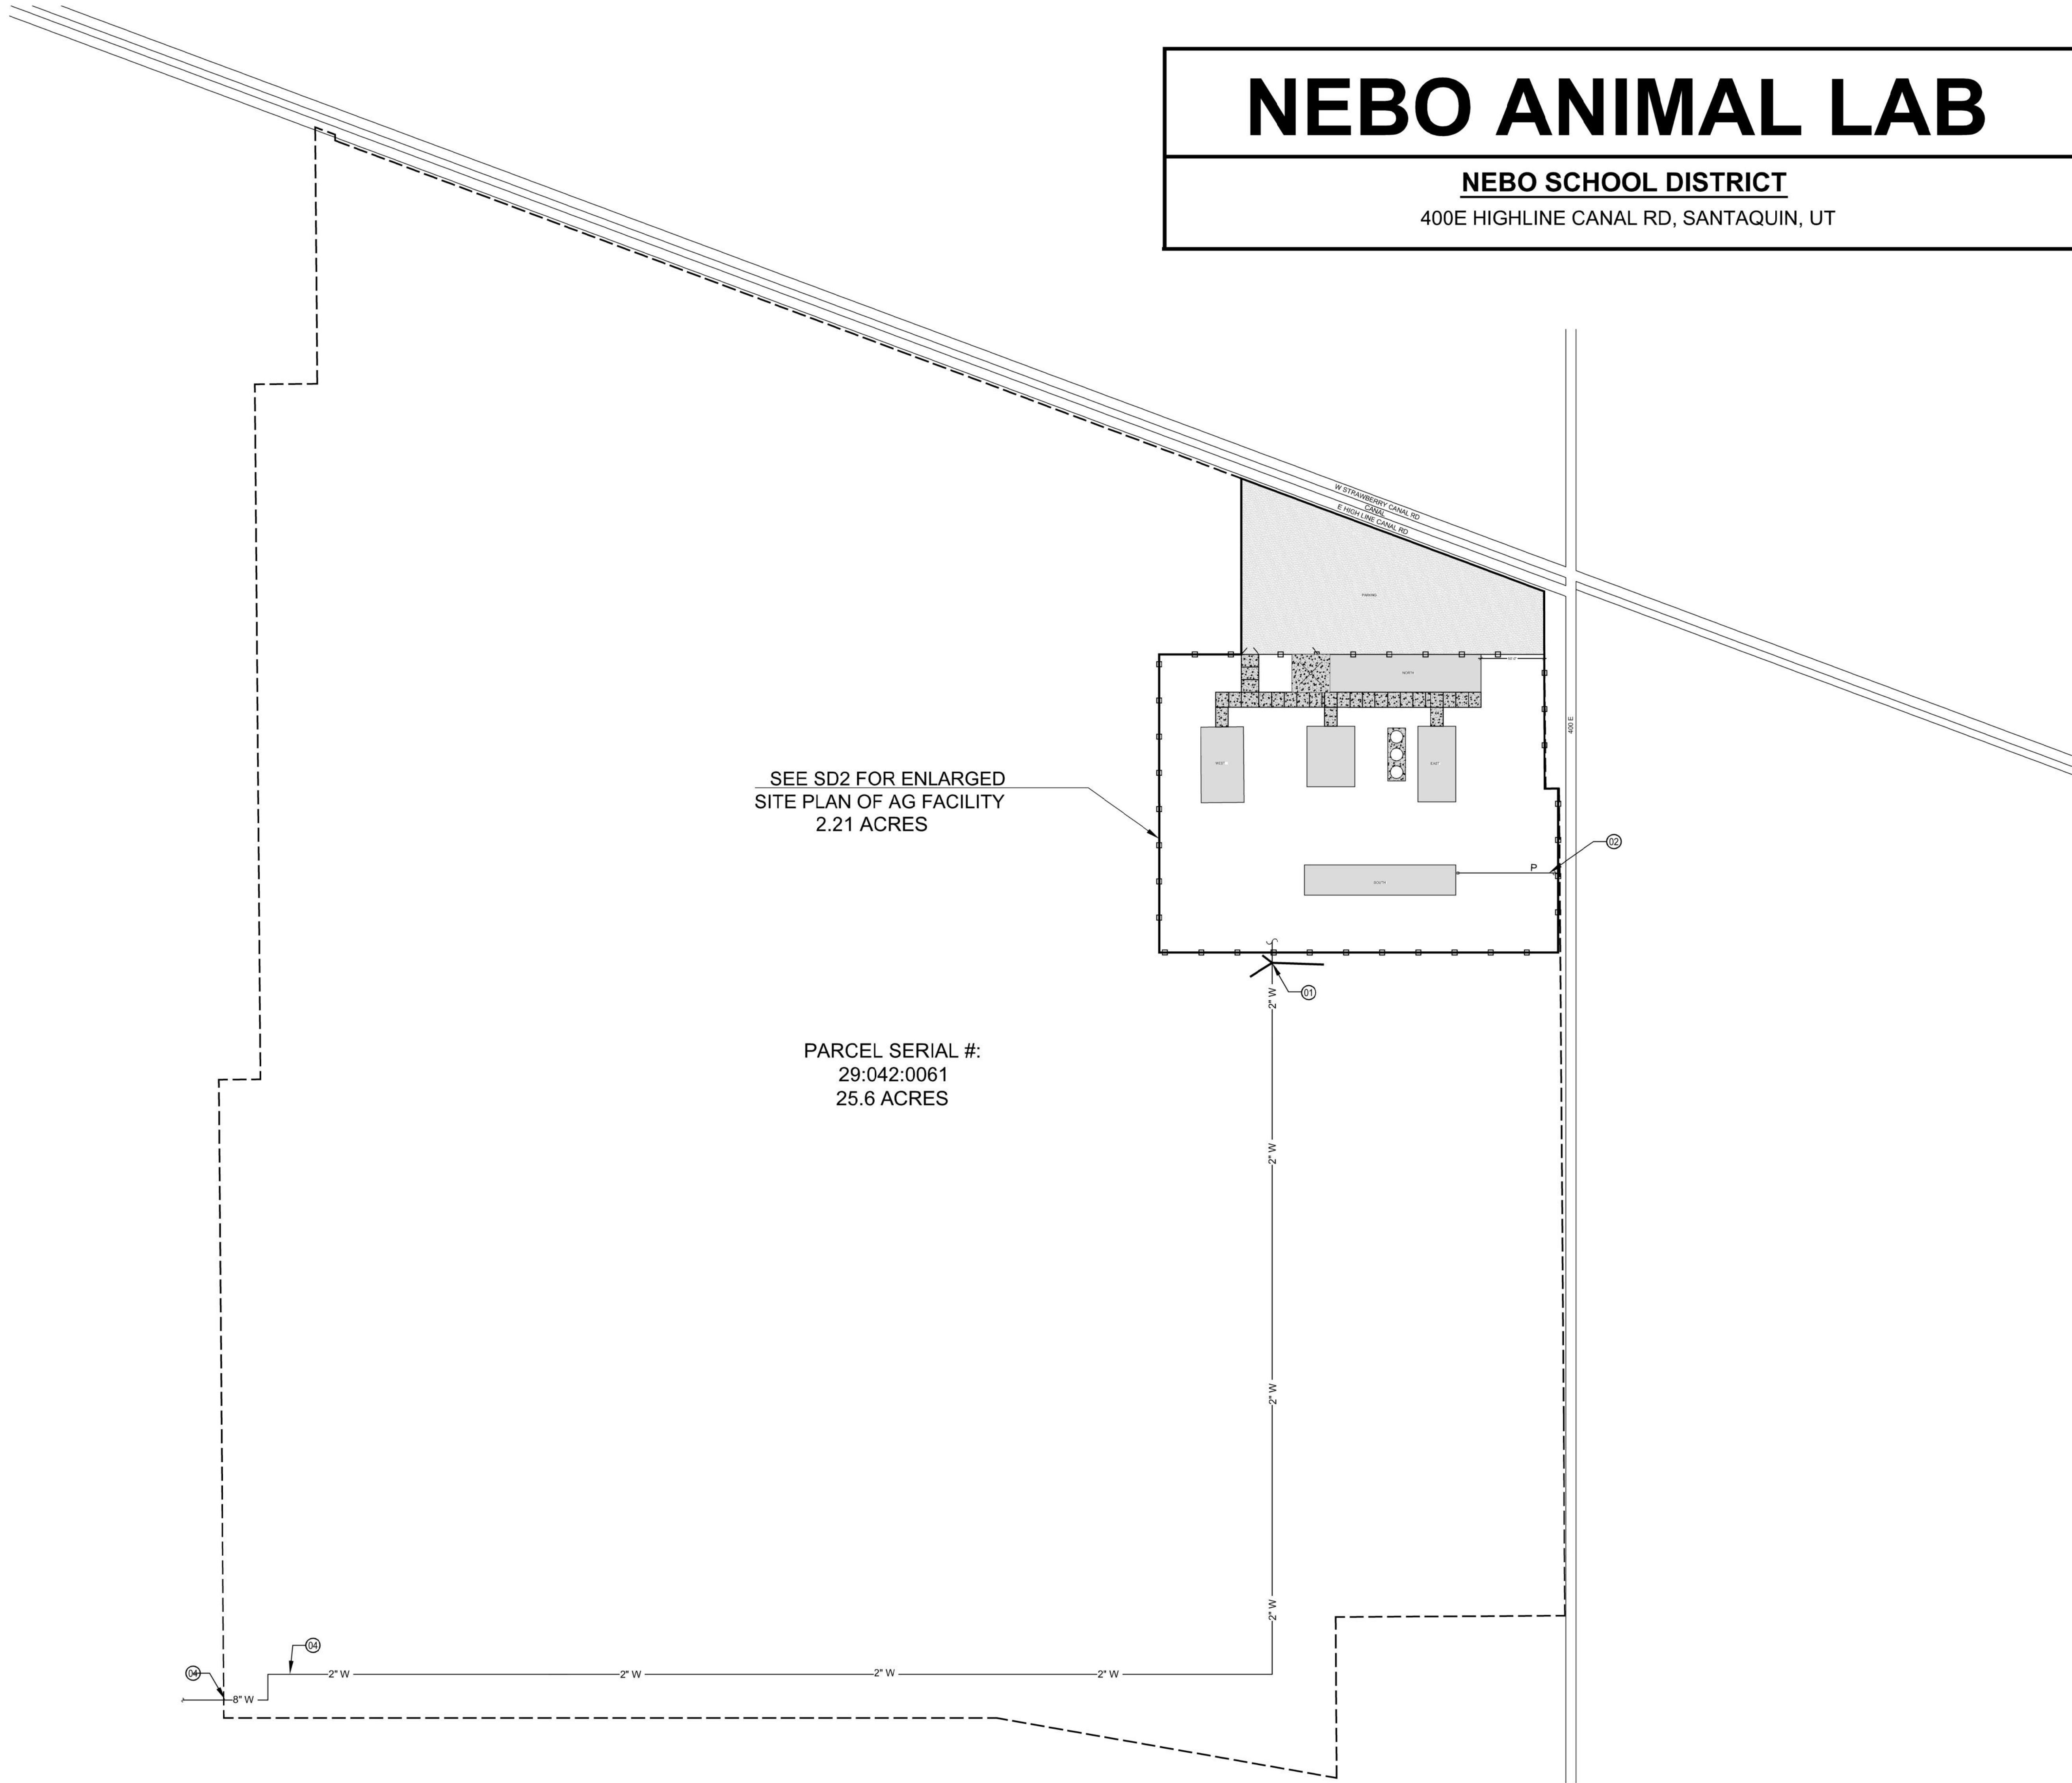

NEBO ANIMAL LAB

NEBO SCHOOL DISTRICT
400E HIGHLINE CANAL RD, SANTAQUIN, UT


INDEX TO DRAWINGS

SD1	- TITLE SHEET & OVERALL SITE PLAN
SD2	- ENLARGED SITE PLAN
A1.1A	- BUILDING A
A1.1B	- BUILDING B
A1.1C	- BUILDING C
A1.1D1	- BUILDING D FOUNDATION + DETAIL
A1.1D	- BUILDING D
A1.1E	- BUILDING E
A3.1A	- BUILDING A ELEVATIONS
A3.1B	- BUILDING B ELEVATIONS
A3.1C	- BUILDING C ELEVATIONS
A3.1D	- BUILDING D ELEVATIONS
A3.1E	- BUILDING E ELEVATIONS
E1	- ENCLOSED BUILDING ELECTRICAL LAYOUT PLAN
E1.1	- OPEN BUILDING ELECTRICAL LAYOUT PLAN

SHEET NOTES:

- 01 - NEW 2" WATER LINE
- 02 - EXISTING 3" MAIN POWER CONDUIT (UNDERGROUND)
- 03 - EXISTING 8" WATER LINE TO PROPERTY
- 04 - CONNECT A NEW 2" WATER LINE. TRENCH AND PIPE TO NEW FACILITY

OVERALL SITE PLAN

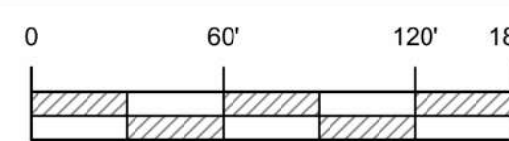

170 NORTH MAIN STREET
SPANISH FORK, UTAH 84660
WWW.KMAARCHITECTS.COM



REVISIONS:

SANTAQUIN, UTAH


NEBO SCHOOL DISTRICT
NEBO ANIMAL LABS

400 E HIGHLINE CANAL RD

DRAWN BY: CH
CHECKED BY: WC
DATE: FEB. 2023
PROJECT #: 171022

SD1


THIS PRINT AND ALL INFORMATION HEREON IS THE PROPERTY OF KMA ARCHITECTS AND SHALL NOT BE USED ON ANY OTHER JOB WITHOUT WRITTEN PERMISSION OF THE ARCHITECT.

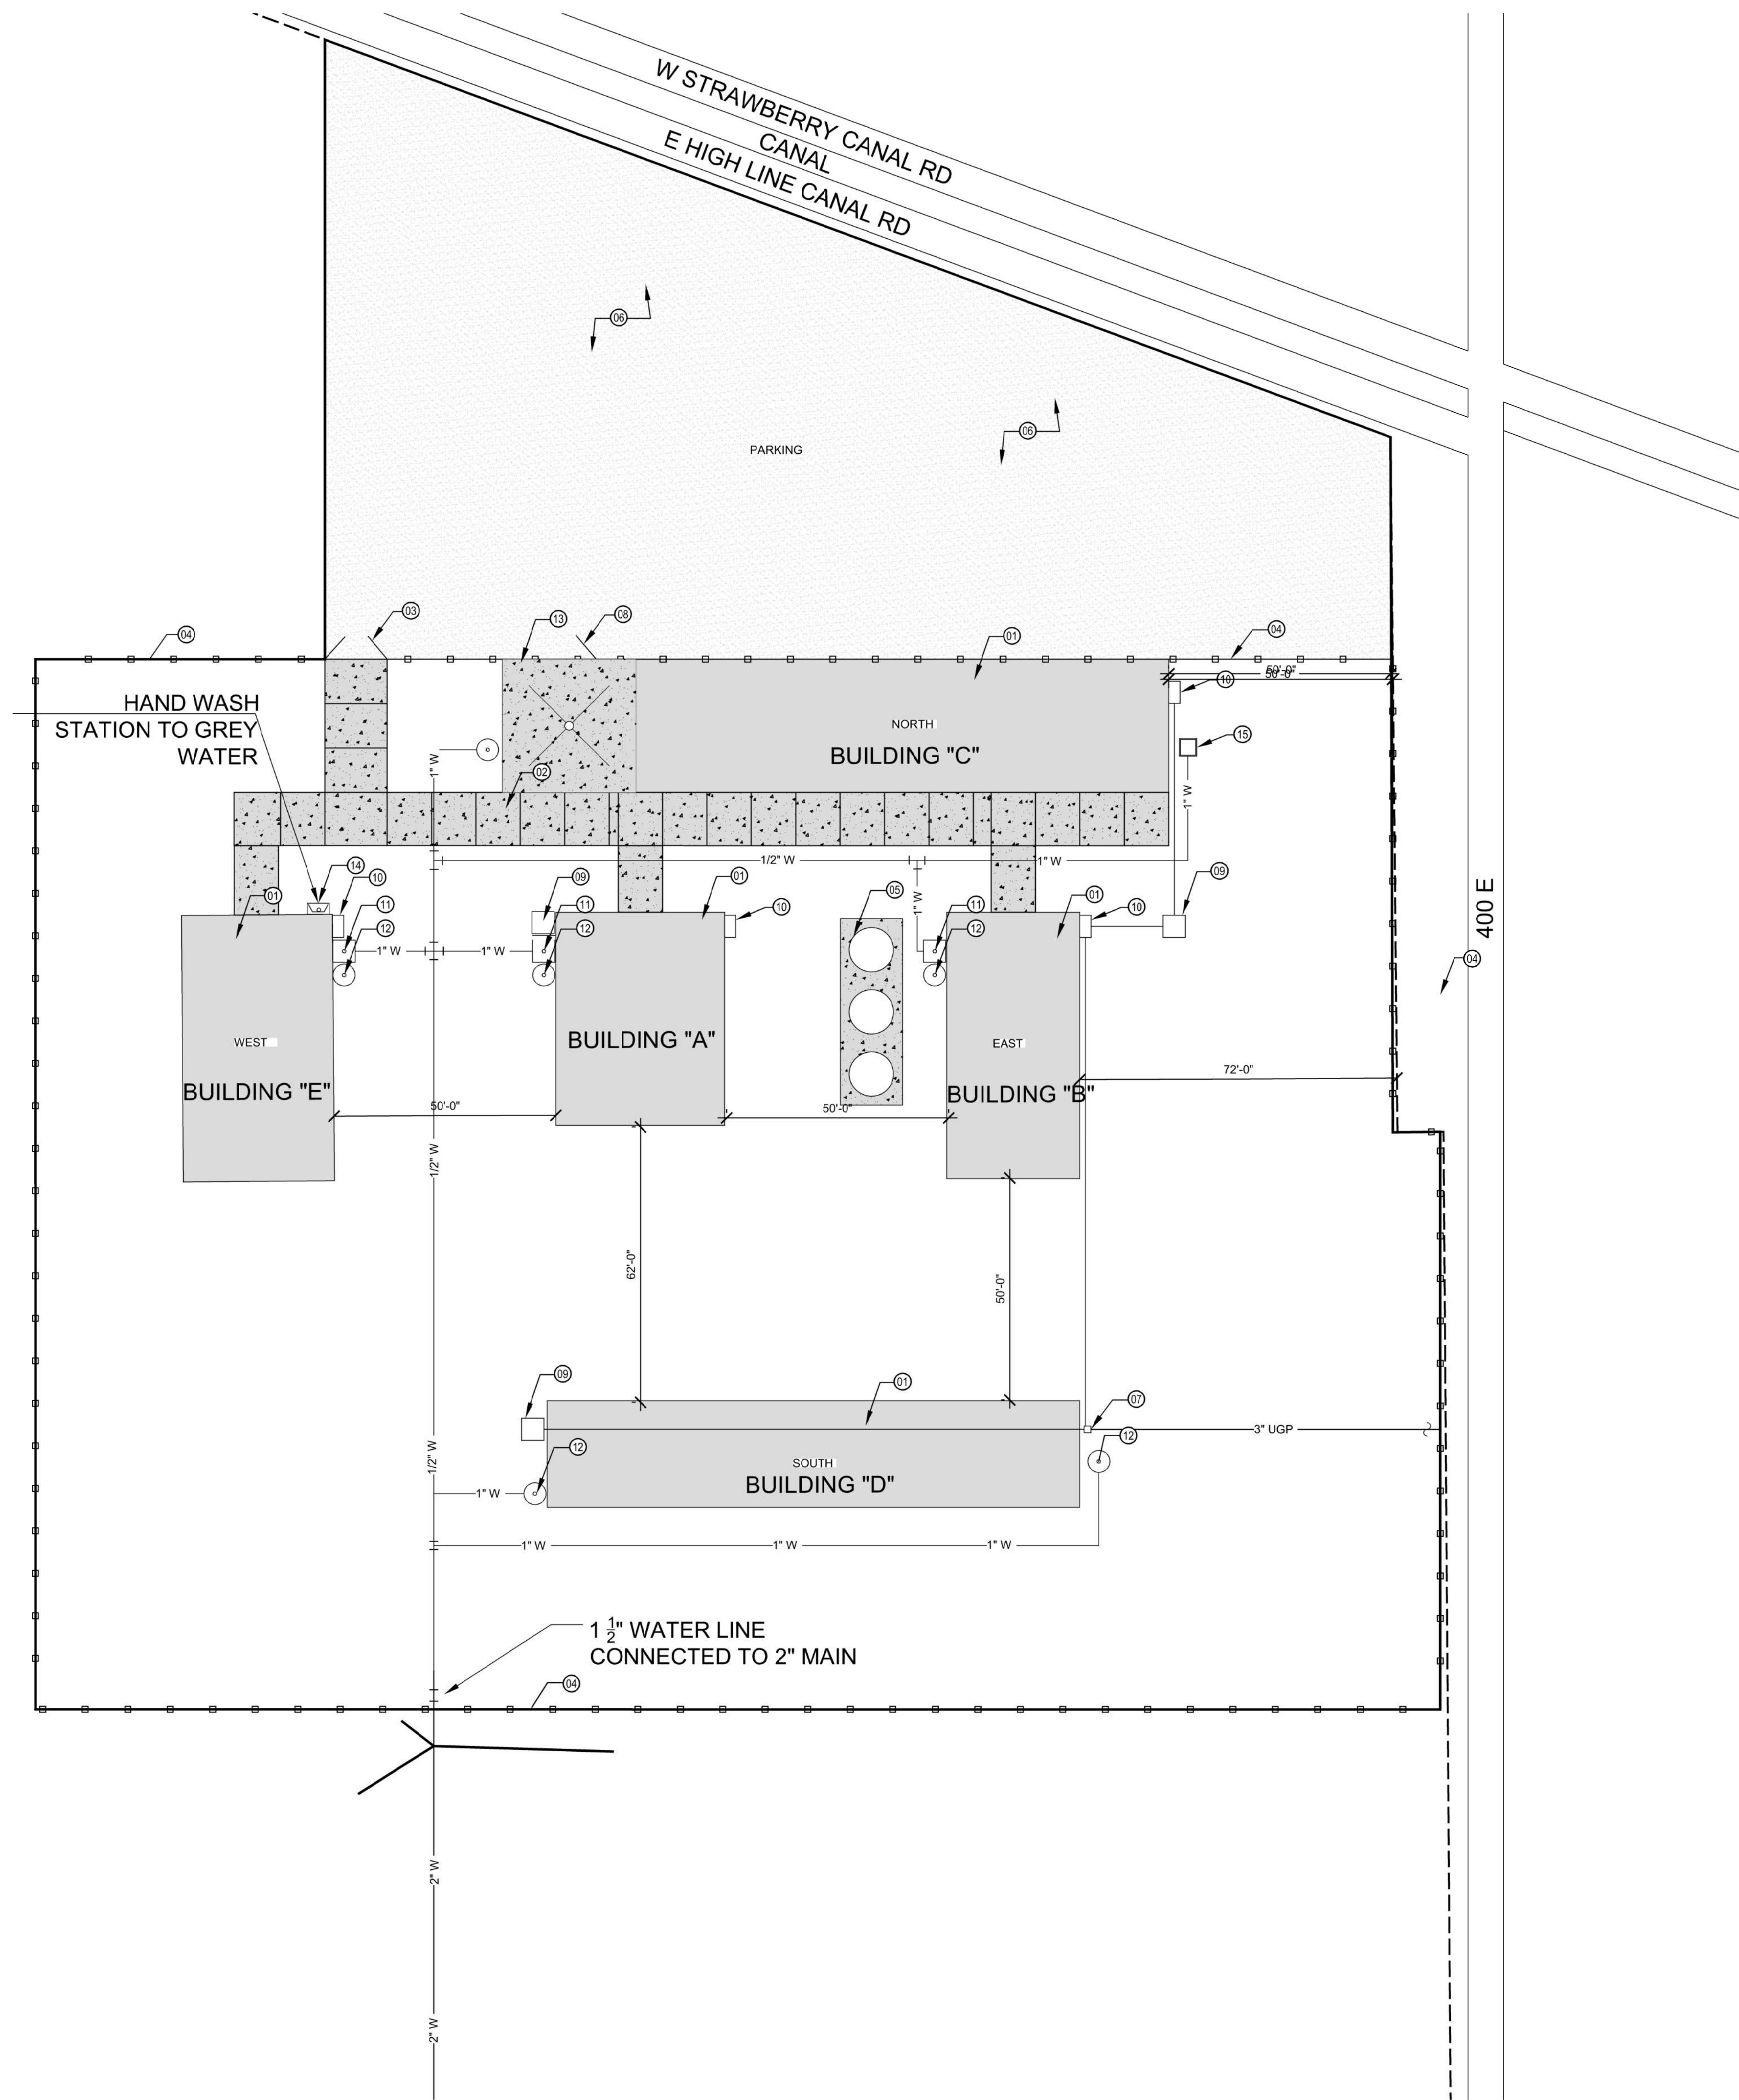

SHEET NOTES:

- 01 - PROPOSED NEW BUILDING TO BE CONSTRUCTED ON SITE
- 02 - CONCRETE DRIVEWAY OVER COMPACTED ROAD BASE
- 03 - CHAINLINK ROLLING OR SWINGING FENCE GATES
- 04 - 5' HIGH CHAINLINK SECURITY FENCE
- 05 - NEW VERTICAL FEED TANKS INSTALLED ON NEW 4" CONC. SLAB
- 06 - GRAVEL PARKING LOT OVER COMPACTED ROAD BASE
- 07 - POWER METER AS PER CITY STANDARDS
- 08 - 6" MAN GATE
- 09 - ELECTRICAL GROUND BOX
- 10 - ELECTRICAL PANEL
- 11 - 1" STEP-UP WASTE
- 12 - 3/4" FROSTLESS HYDRANT
- 13 - CONC. SLAB W/ DRAIN
- 14 - HANDWASH STATION TO GREY WATER
- 15 - 4' X 4' CONCRETE WATER VAULT

FENCED AREA AND
PARKING = 2.21 ACRES
OF THE 25.6 ACRE SITE.

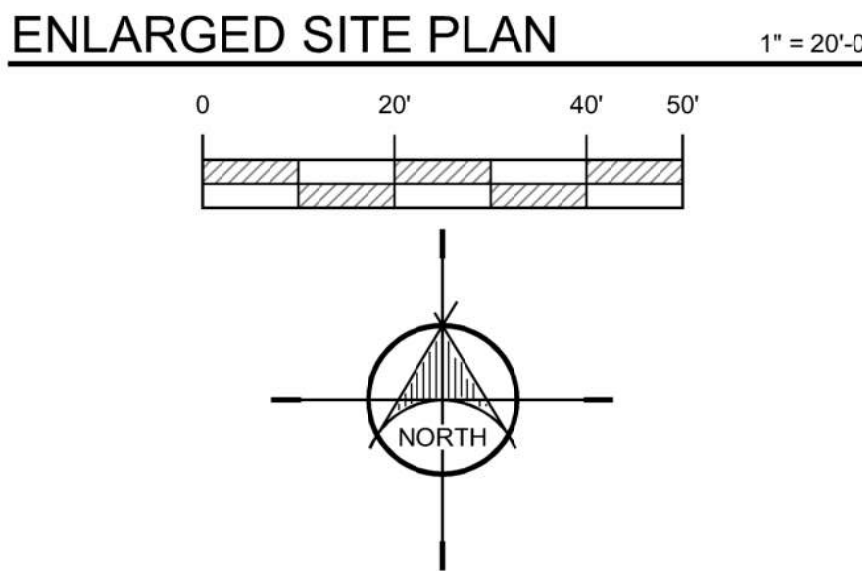


DRAWN BY: CH
CHECKED BY: WC
DATE: FEB. 2023
PROJECT #: 171022

SD2

NEBO SCHOOL DISTRICT
NEBO ANIMAL LABS
400 E HIGHLINE CANAL RD

SANTAQUIN, UTAH

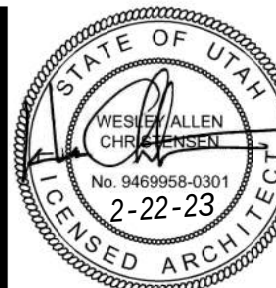


REVISIONS:

KMA
ARCHITECTS


170 NORTH MAIN STREET
SPANISH FORK, UTAH 84660
WWW.KMAARCHITECTS.COM

THIS PRINT AND ALL INFORMATION HEREON IS THE PROPERTY OF KMA ARCHITECTS AND SHALL NOT BE USED ON ANY OTHER JOB WITHOUT WRITTEN PERMISSION OF THE ARCHITECT


2/23/2023 4:27:16 PM
As Noted

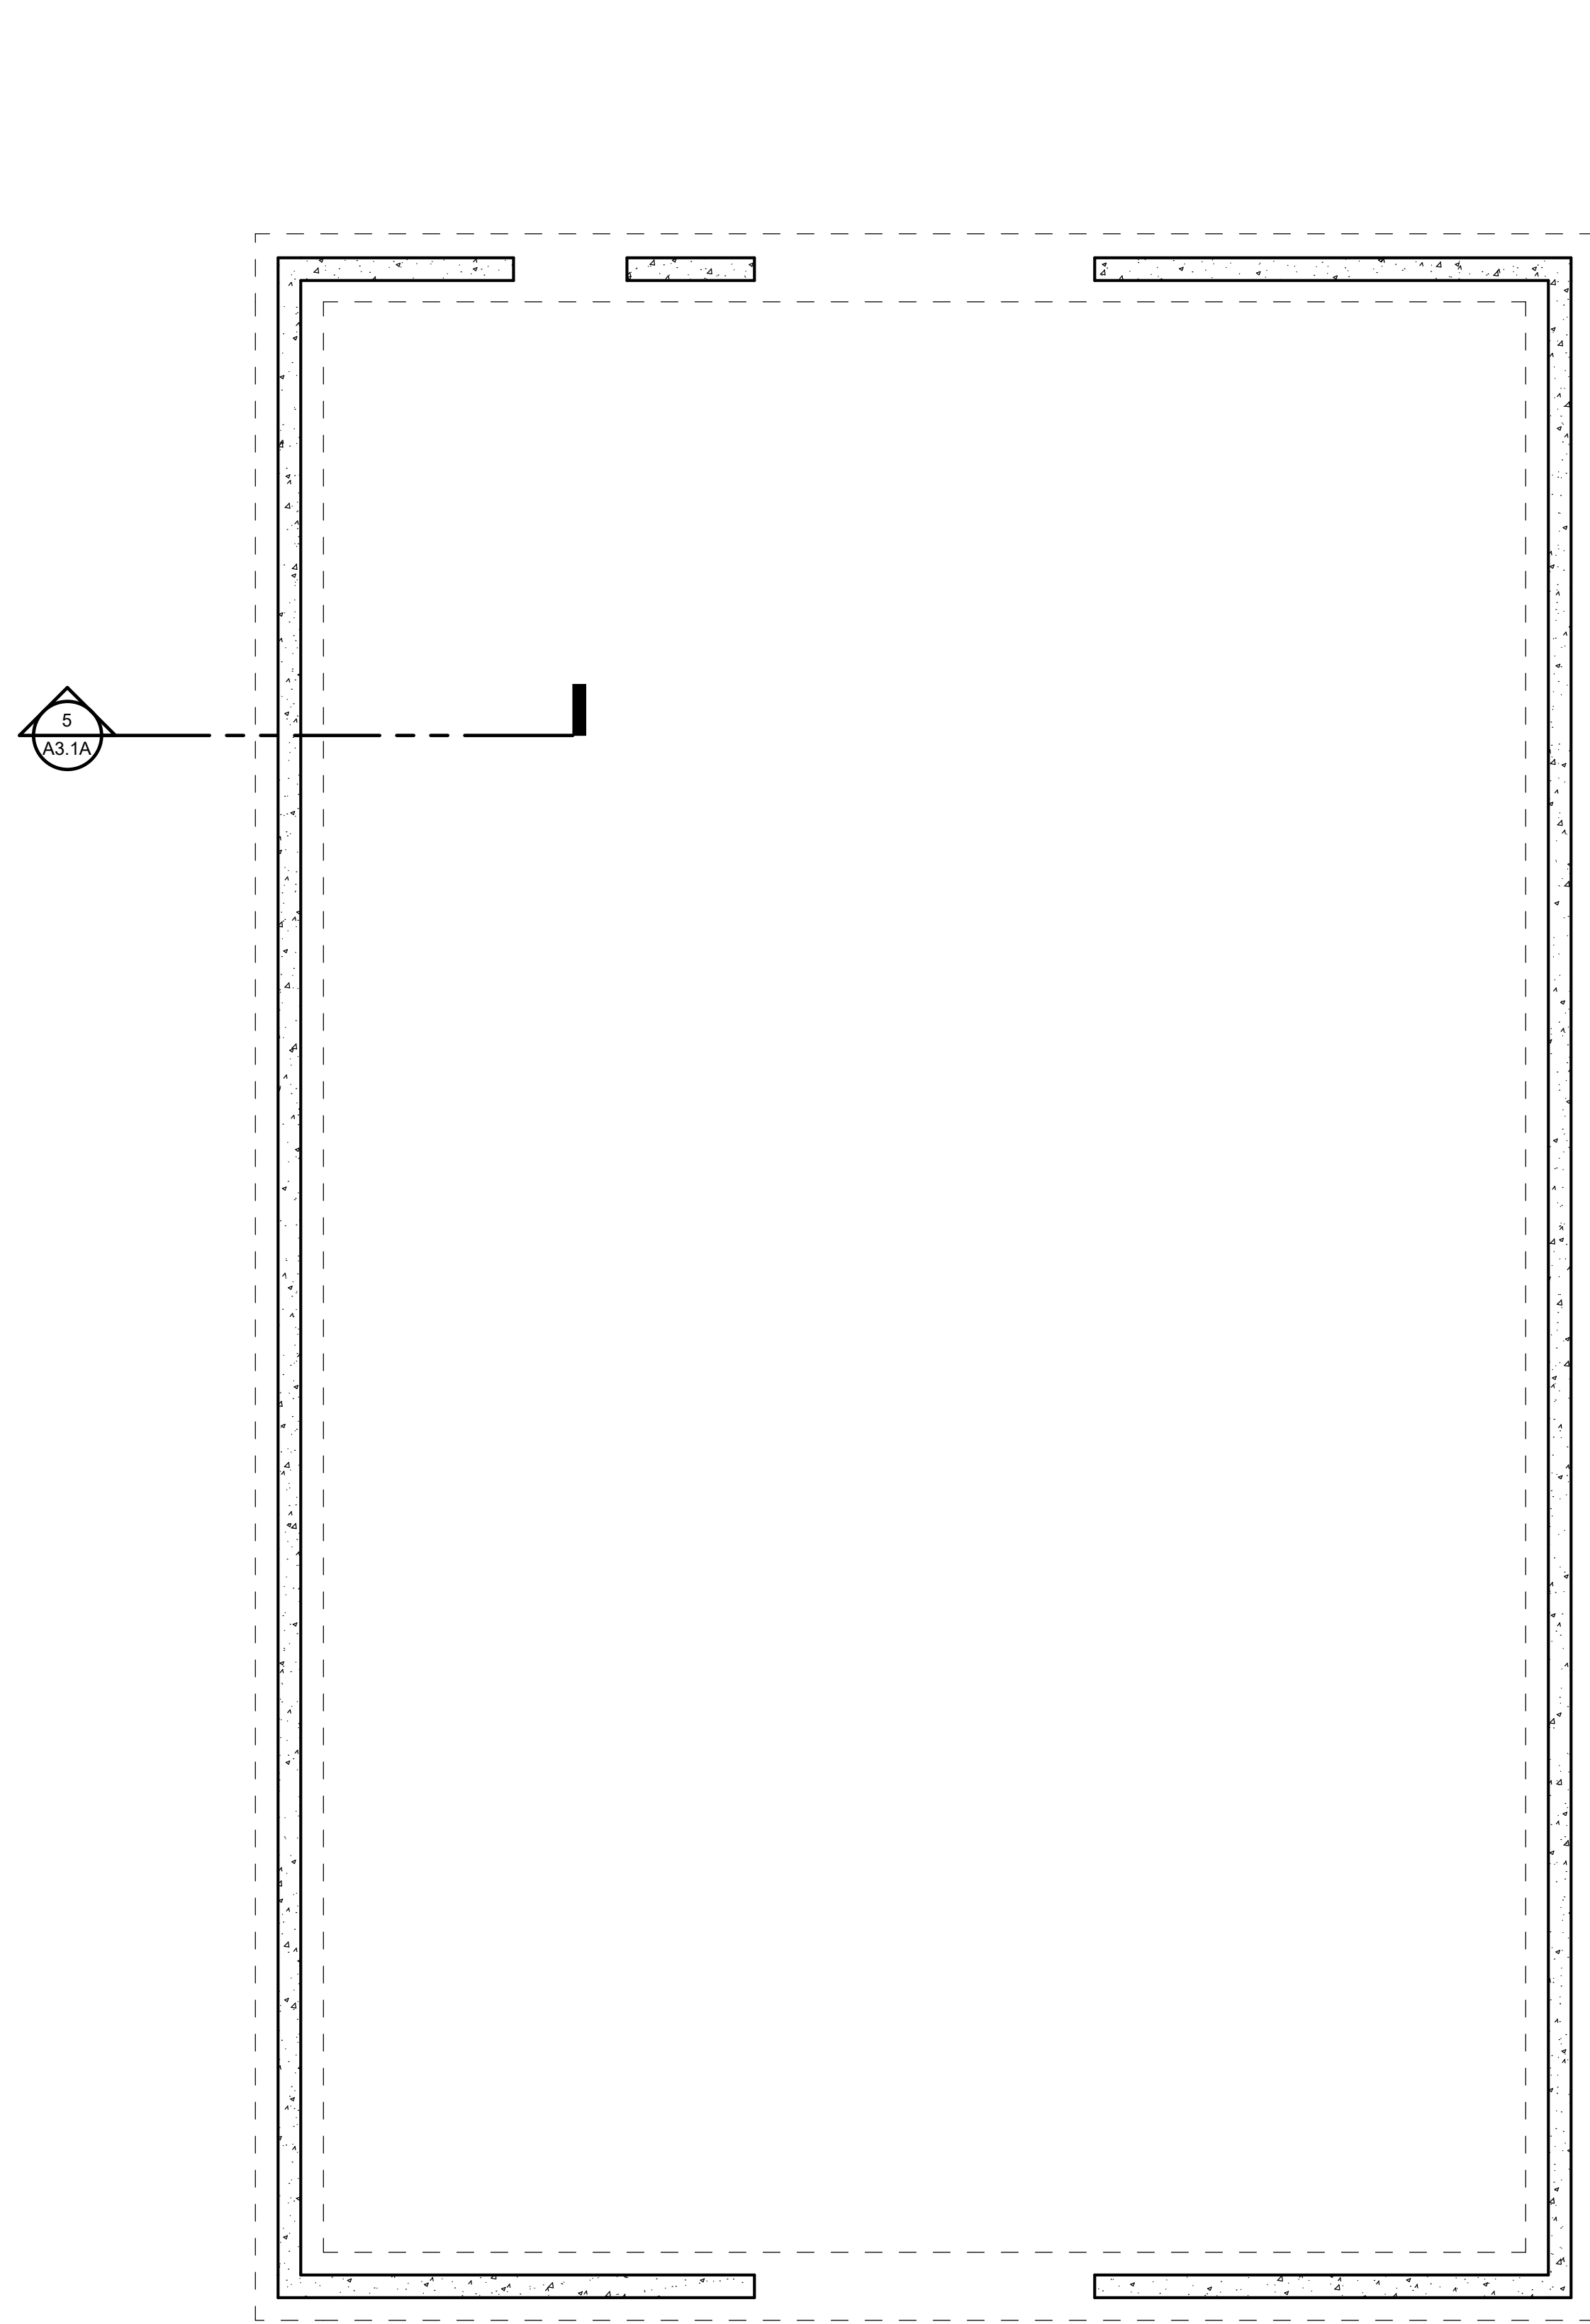




1 FOUNDATION PLAN BUILDING A
1/4" = 1'-0"

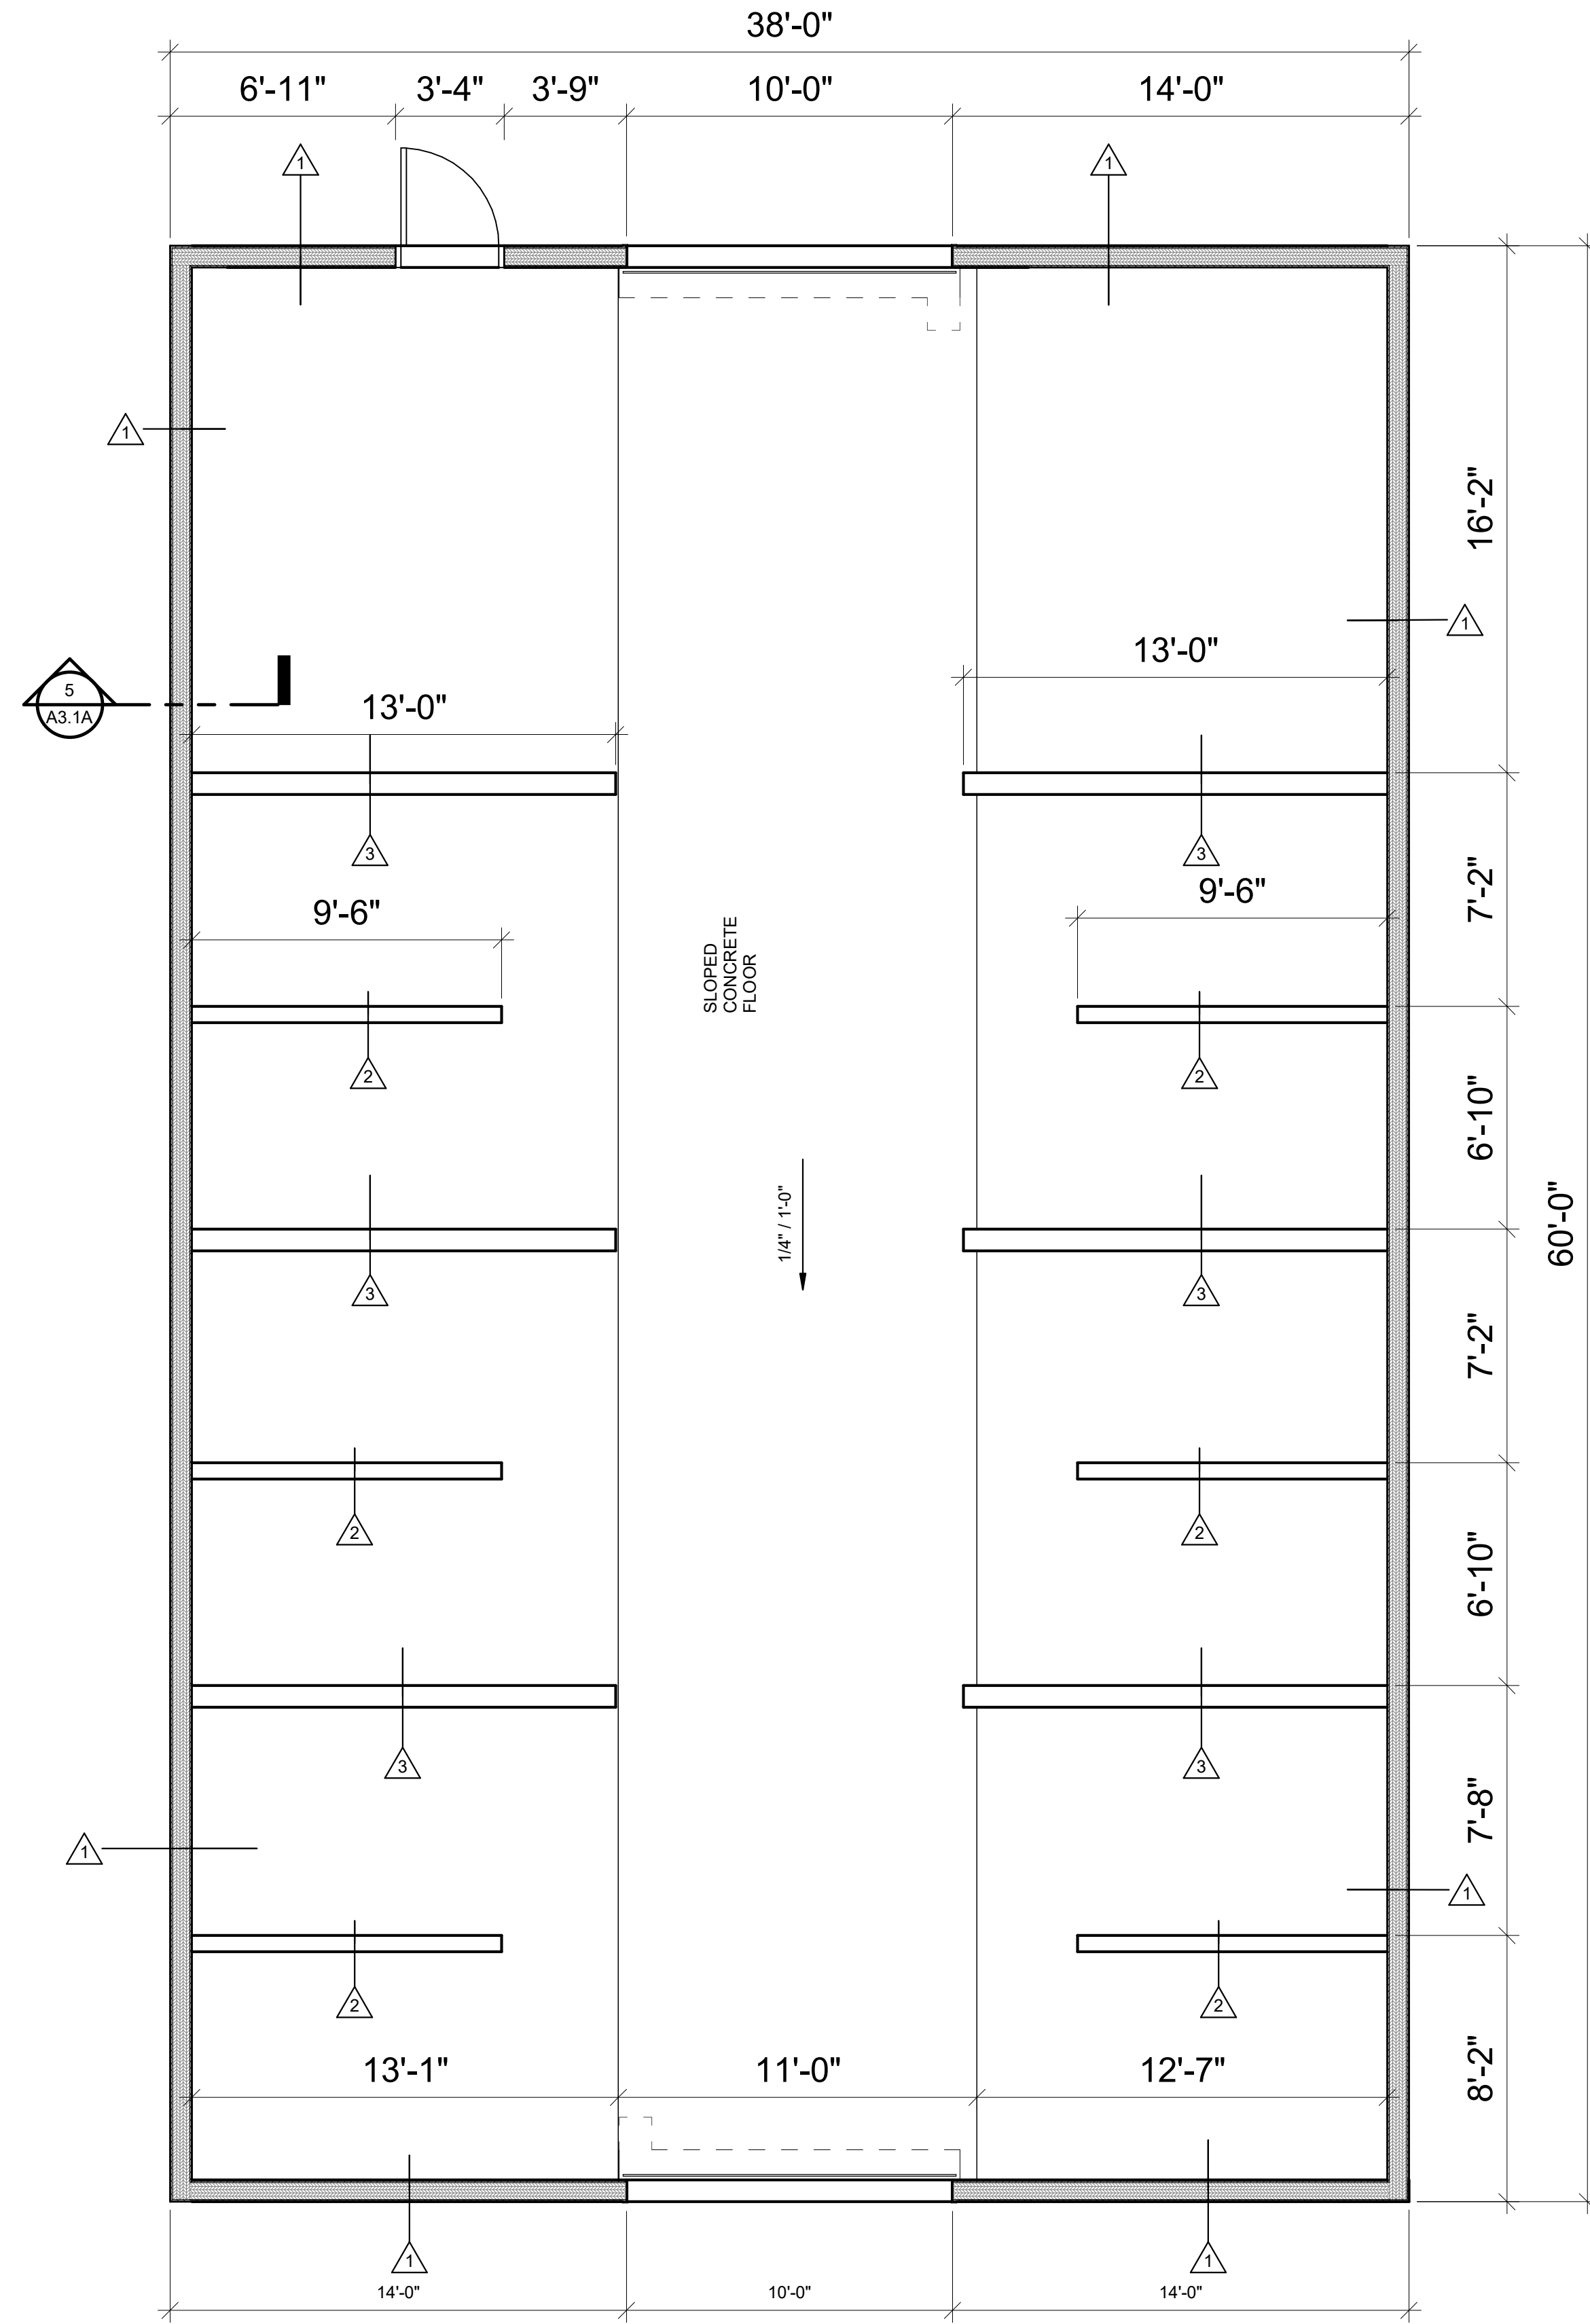

2 MAIN FLOOR PLAN BUILDING A
1/4" = 1'-0"

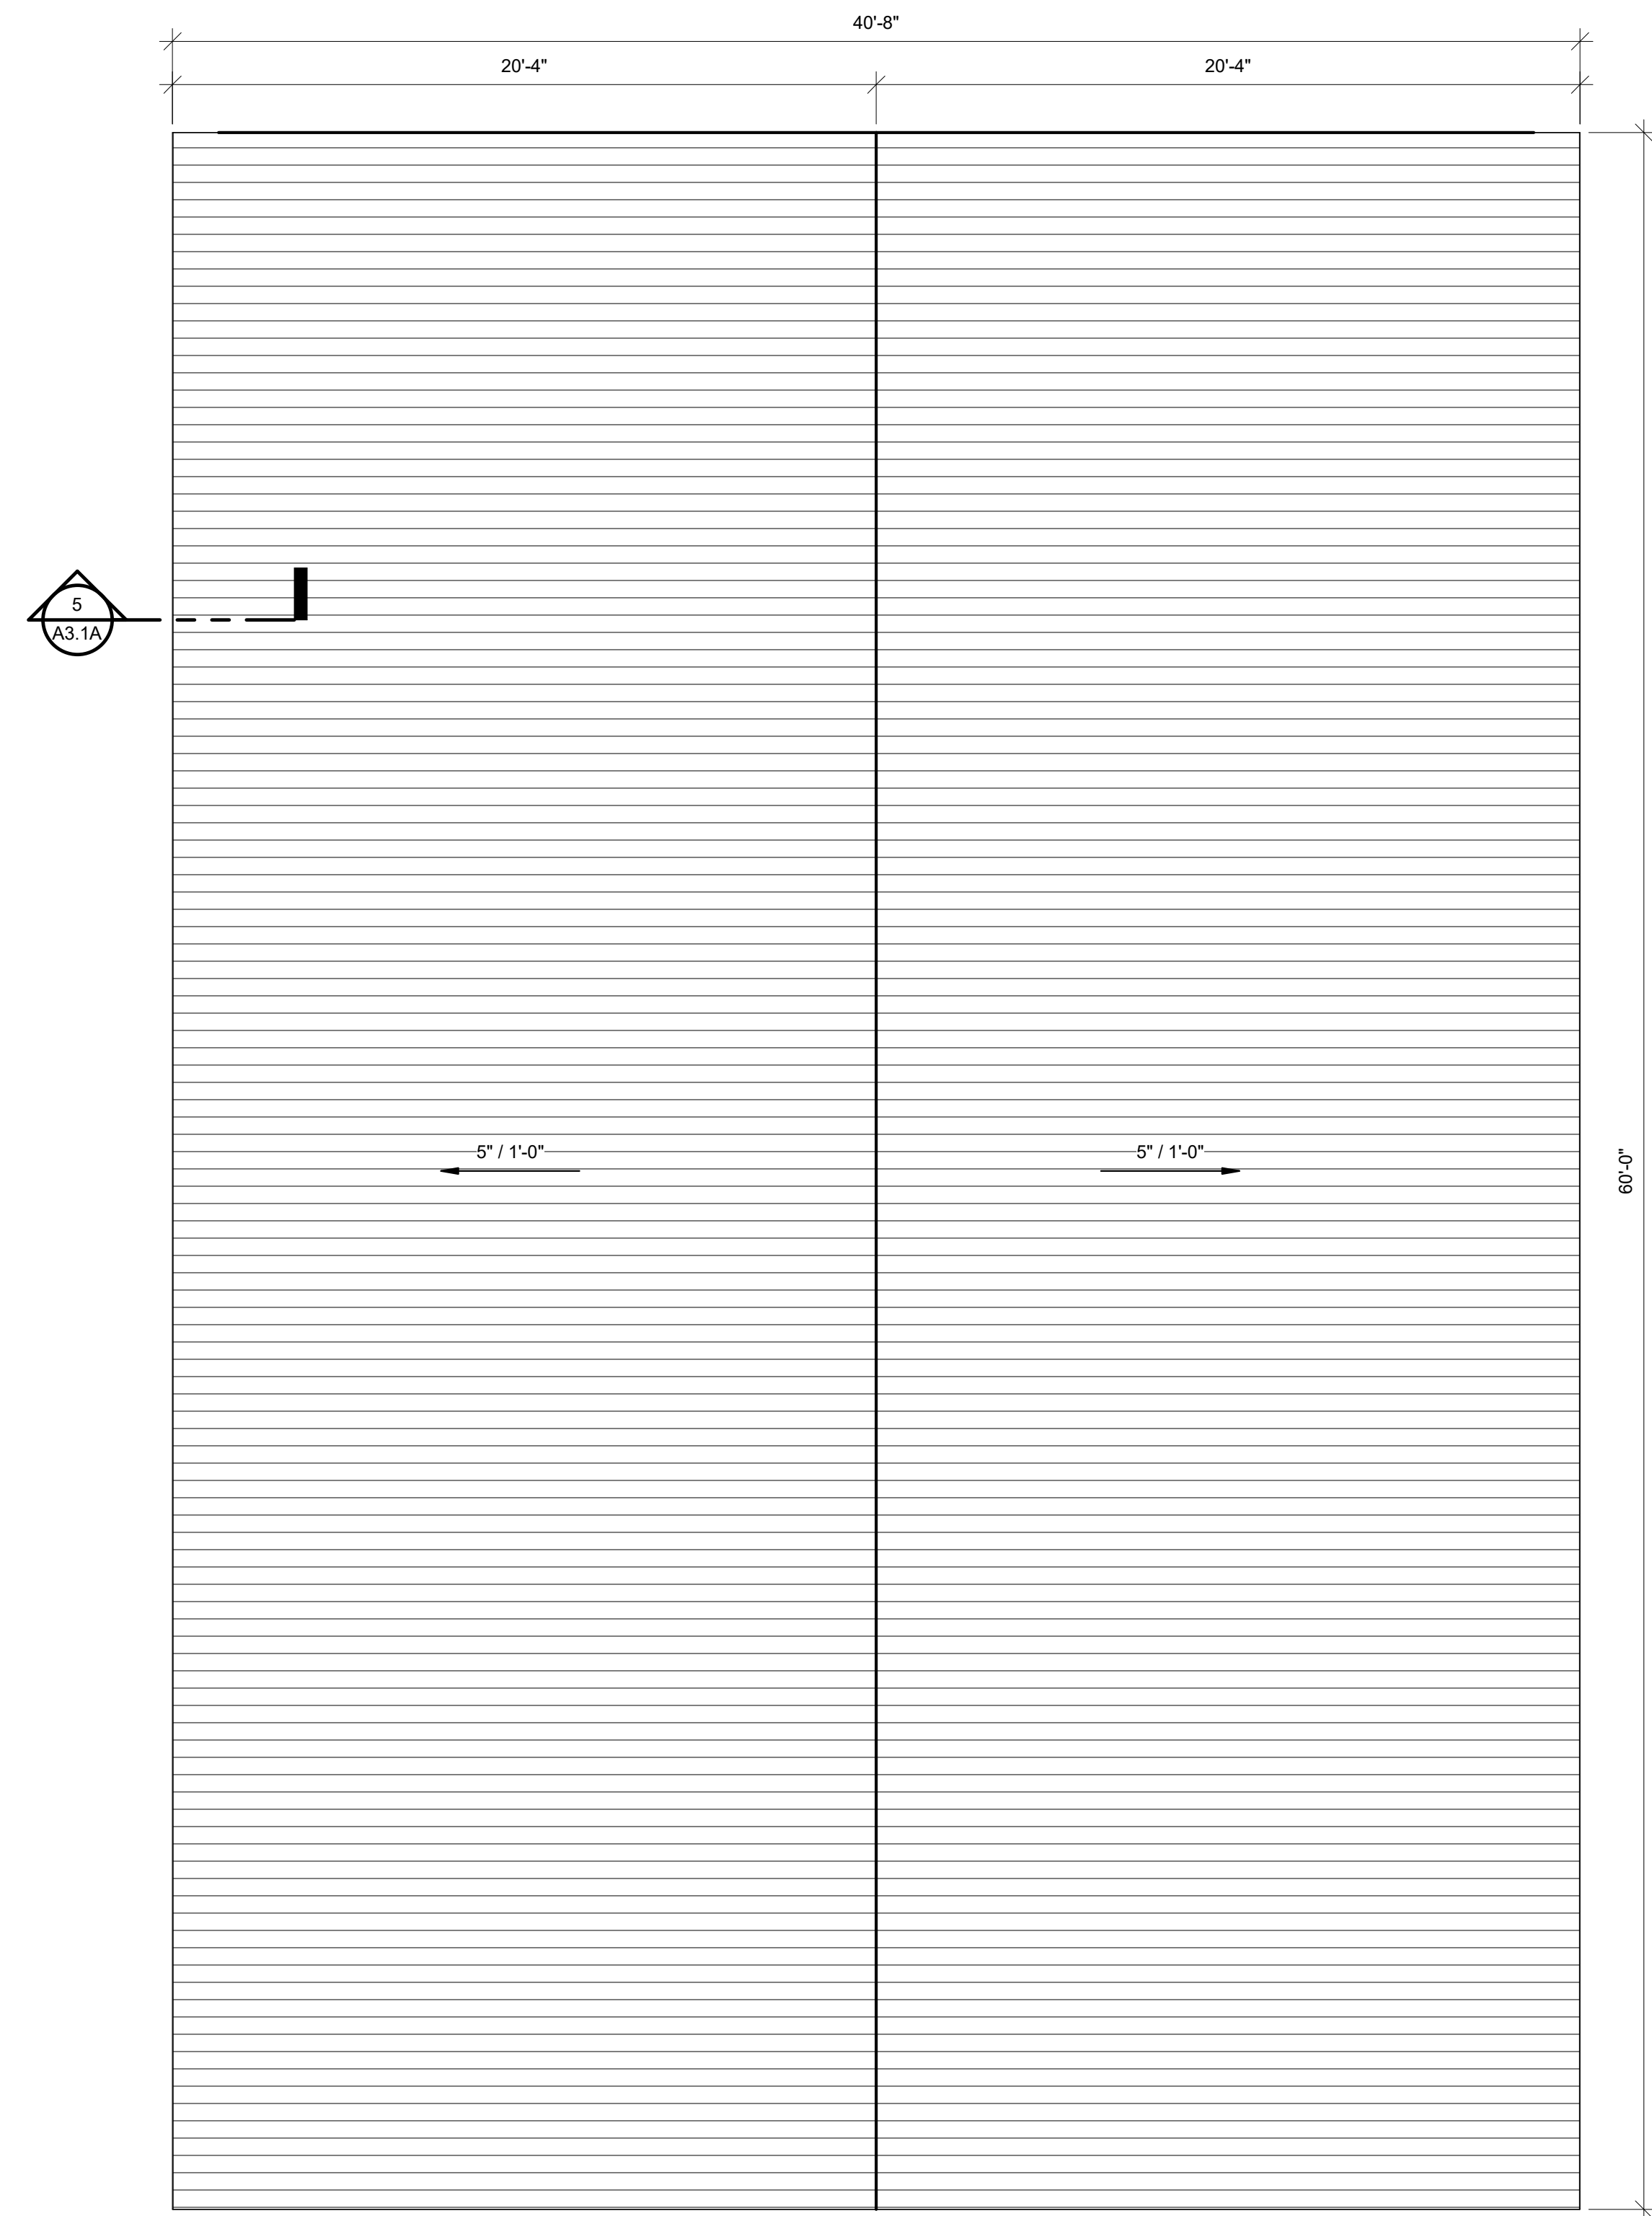

3 ROOF PLAN BUILDING A
1/4" = 1'-0"

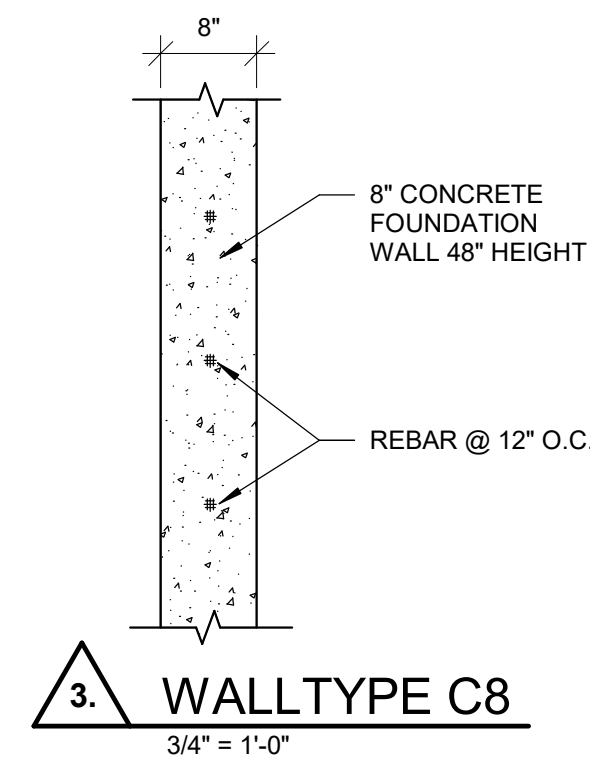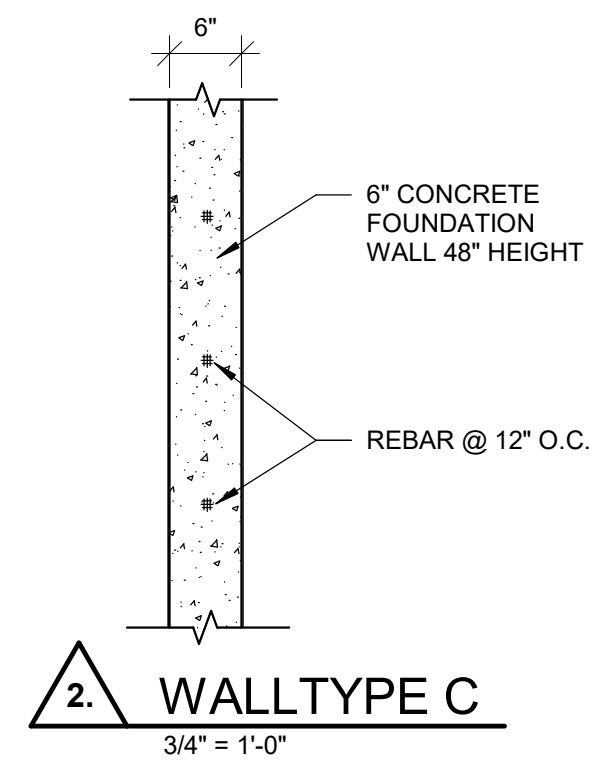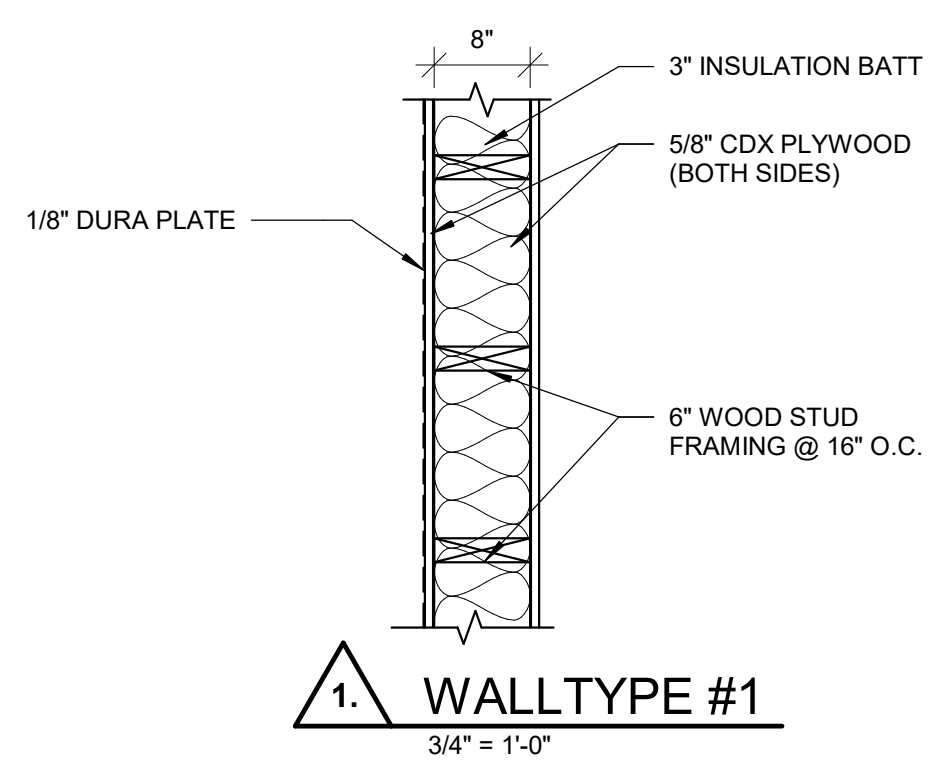

BUILDING A IS THE MIDDLE BUILDING

170 NORTH MAIN STREET
SPANISH FORK, UT 84660
WWW.KMAARCHITECTS.COM



REVISIONS:

SANATQUIN, UTAH


PROJECT TITLE
NEBO SCHOOL DISTRICT
NEBO ANIMAL LABS
1400 E HIGHLINE CANAL RD

DRAWN BY: PC
CHECKED BY: WC
DATE: FEB 2023
PROJECT #: 171022


A1.1A

THIS PRINT AND ALL INFORMATION HEREON IS THE PROPERTY OF KMA ARCHITECTS AND SHALL NOT BE USED ON ANY OTHER JOB WITHOUT WRITTEN PERMISSION OF THE ARCHITECT


2/23/2023 4:27:17 PM
As Noted

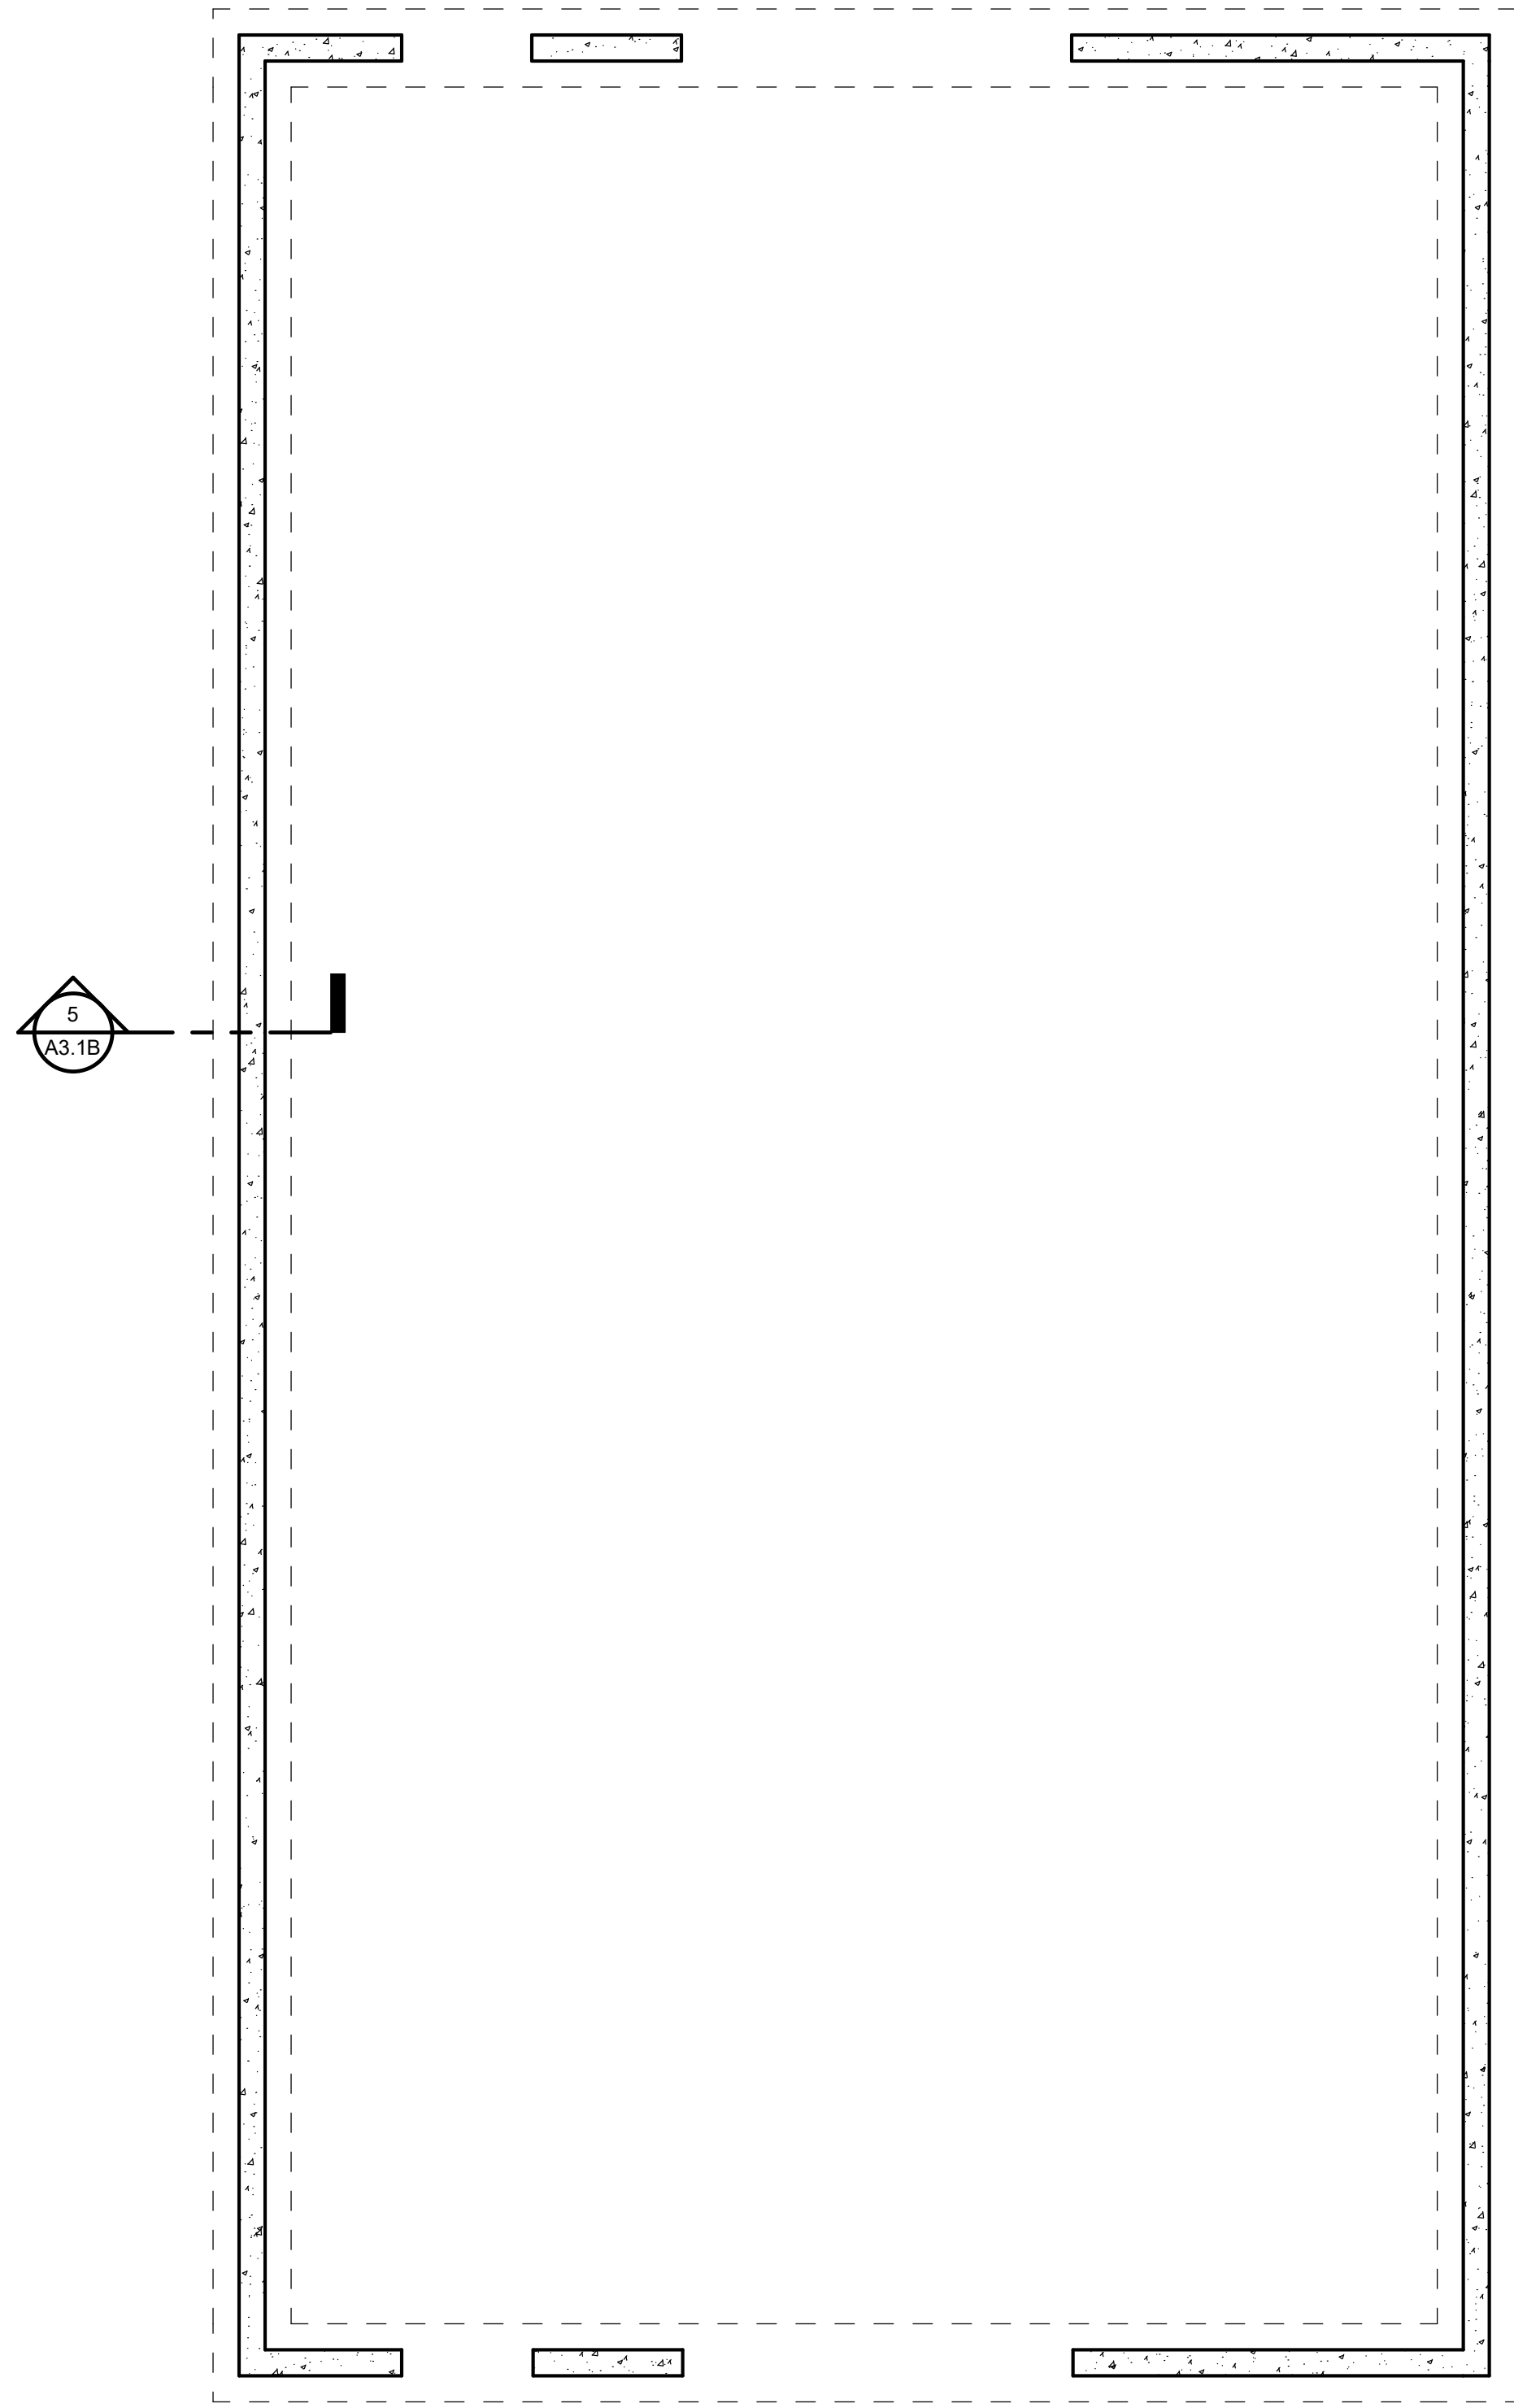


2 FOUNDATION PLAN BUILDING B
1/4" = 1'-0"

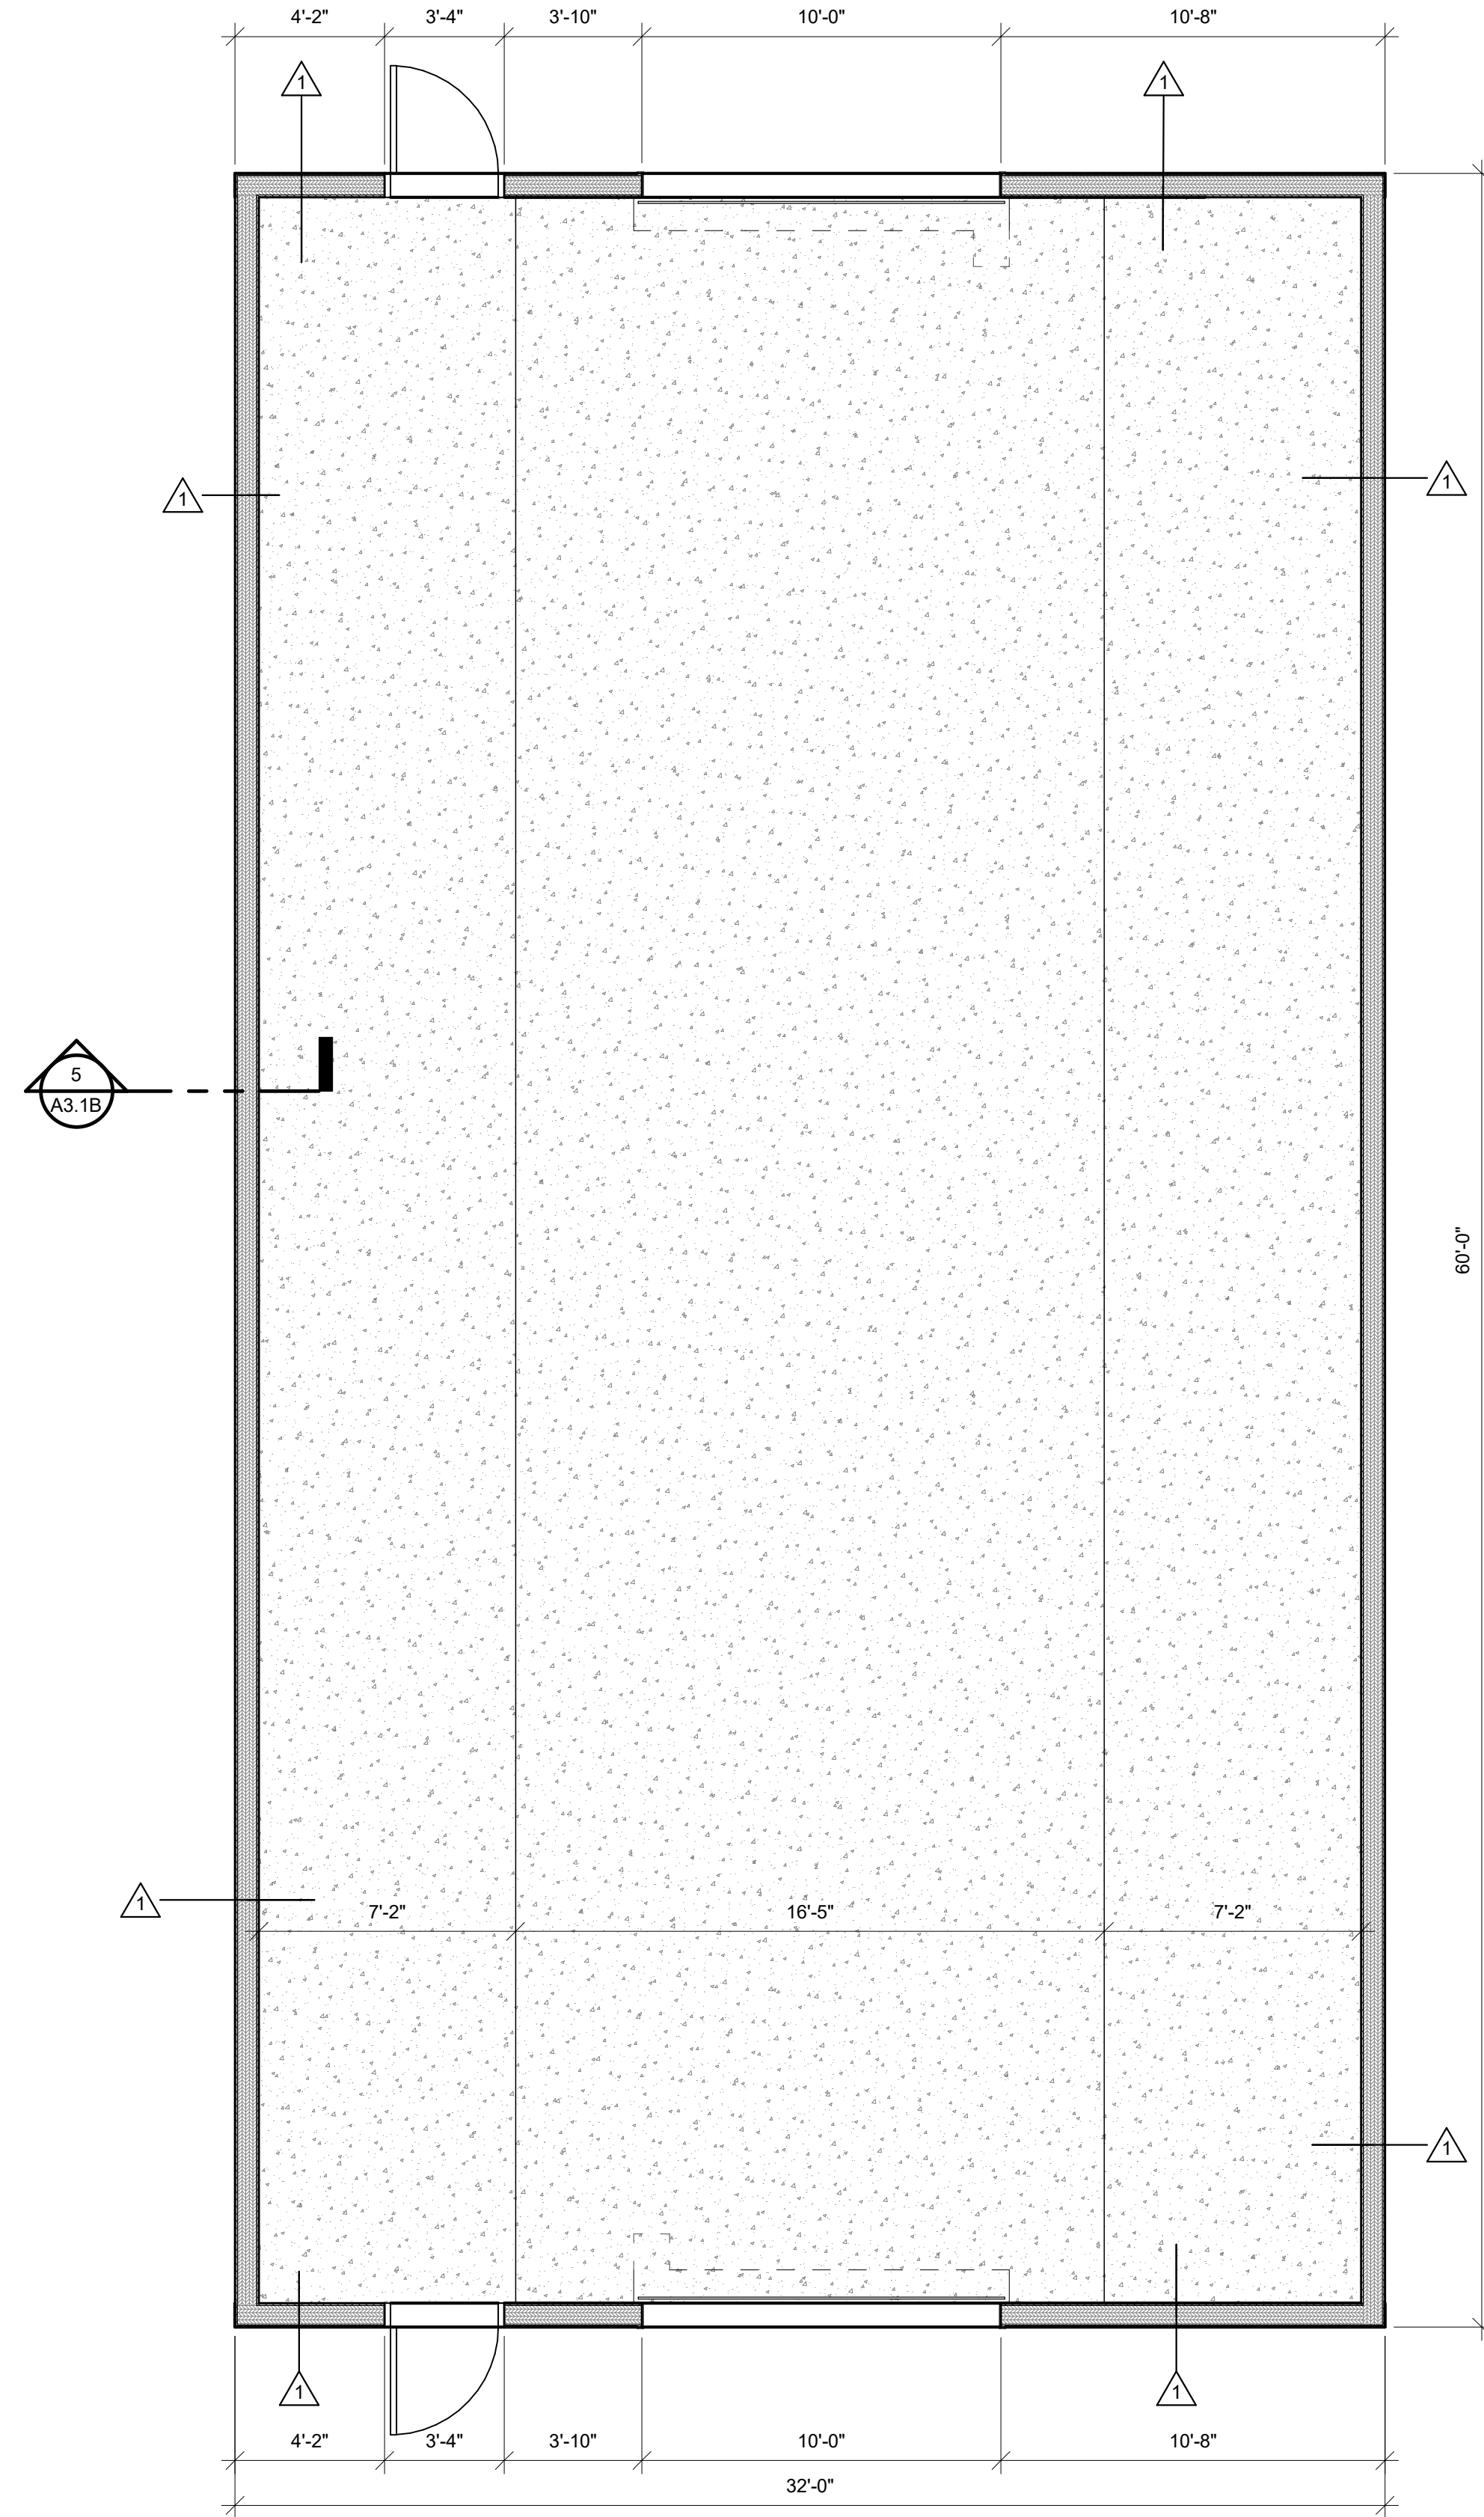

1 MAIN FLOOR PLAN BUILDING B
1/4" = 1'-0"

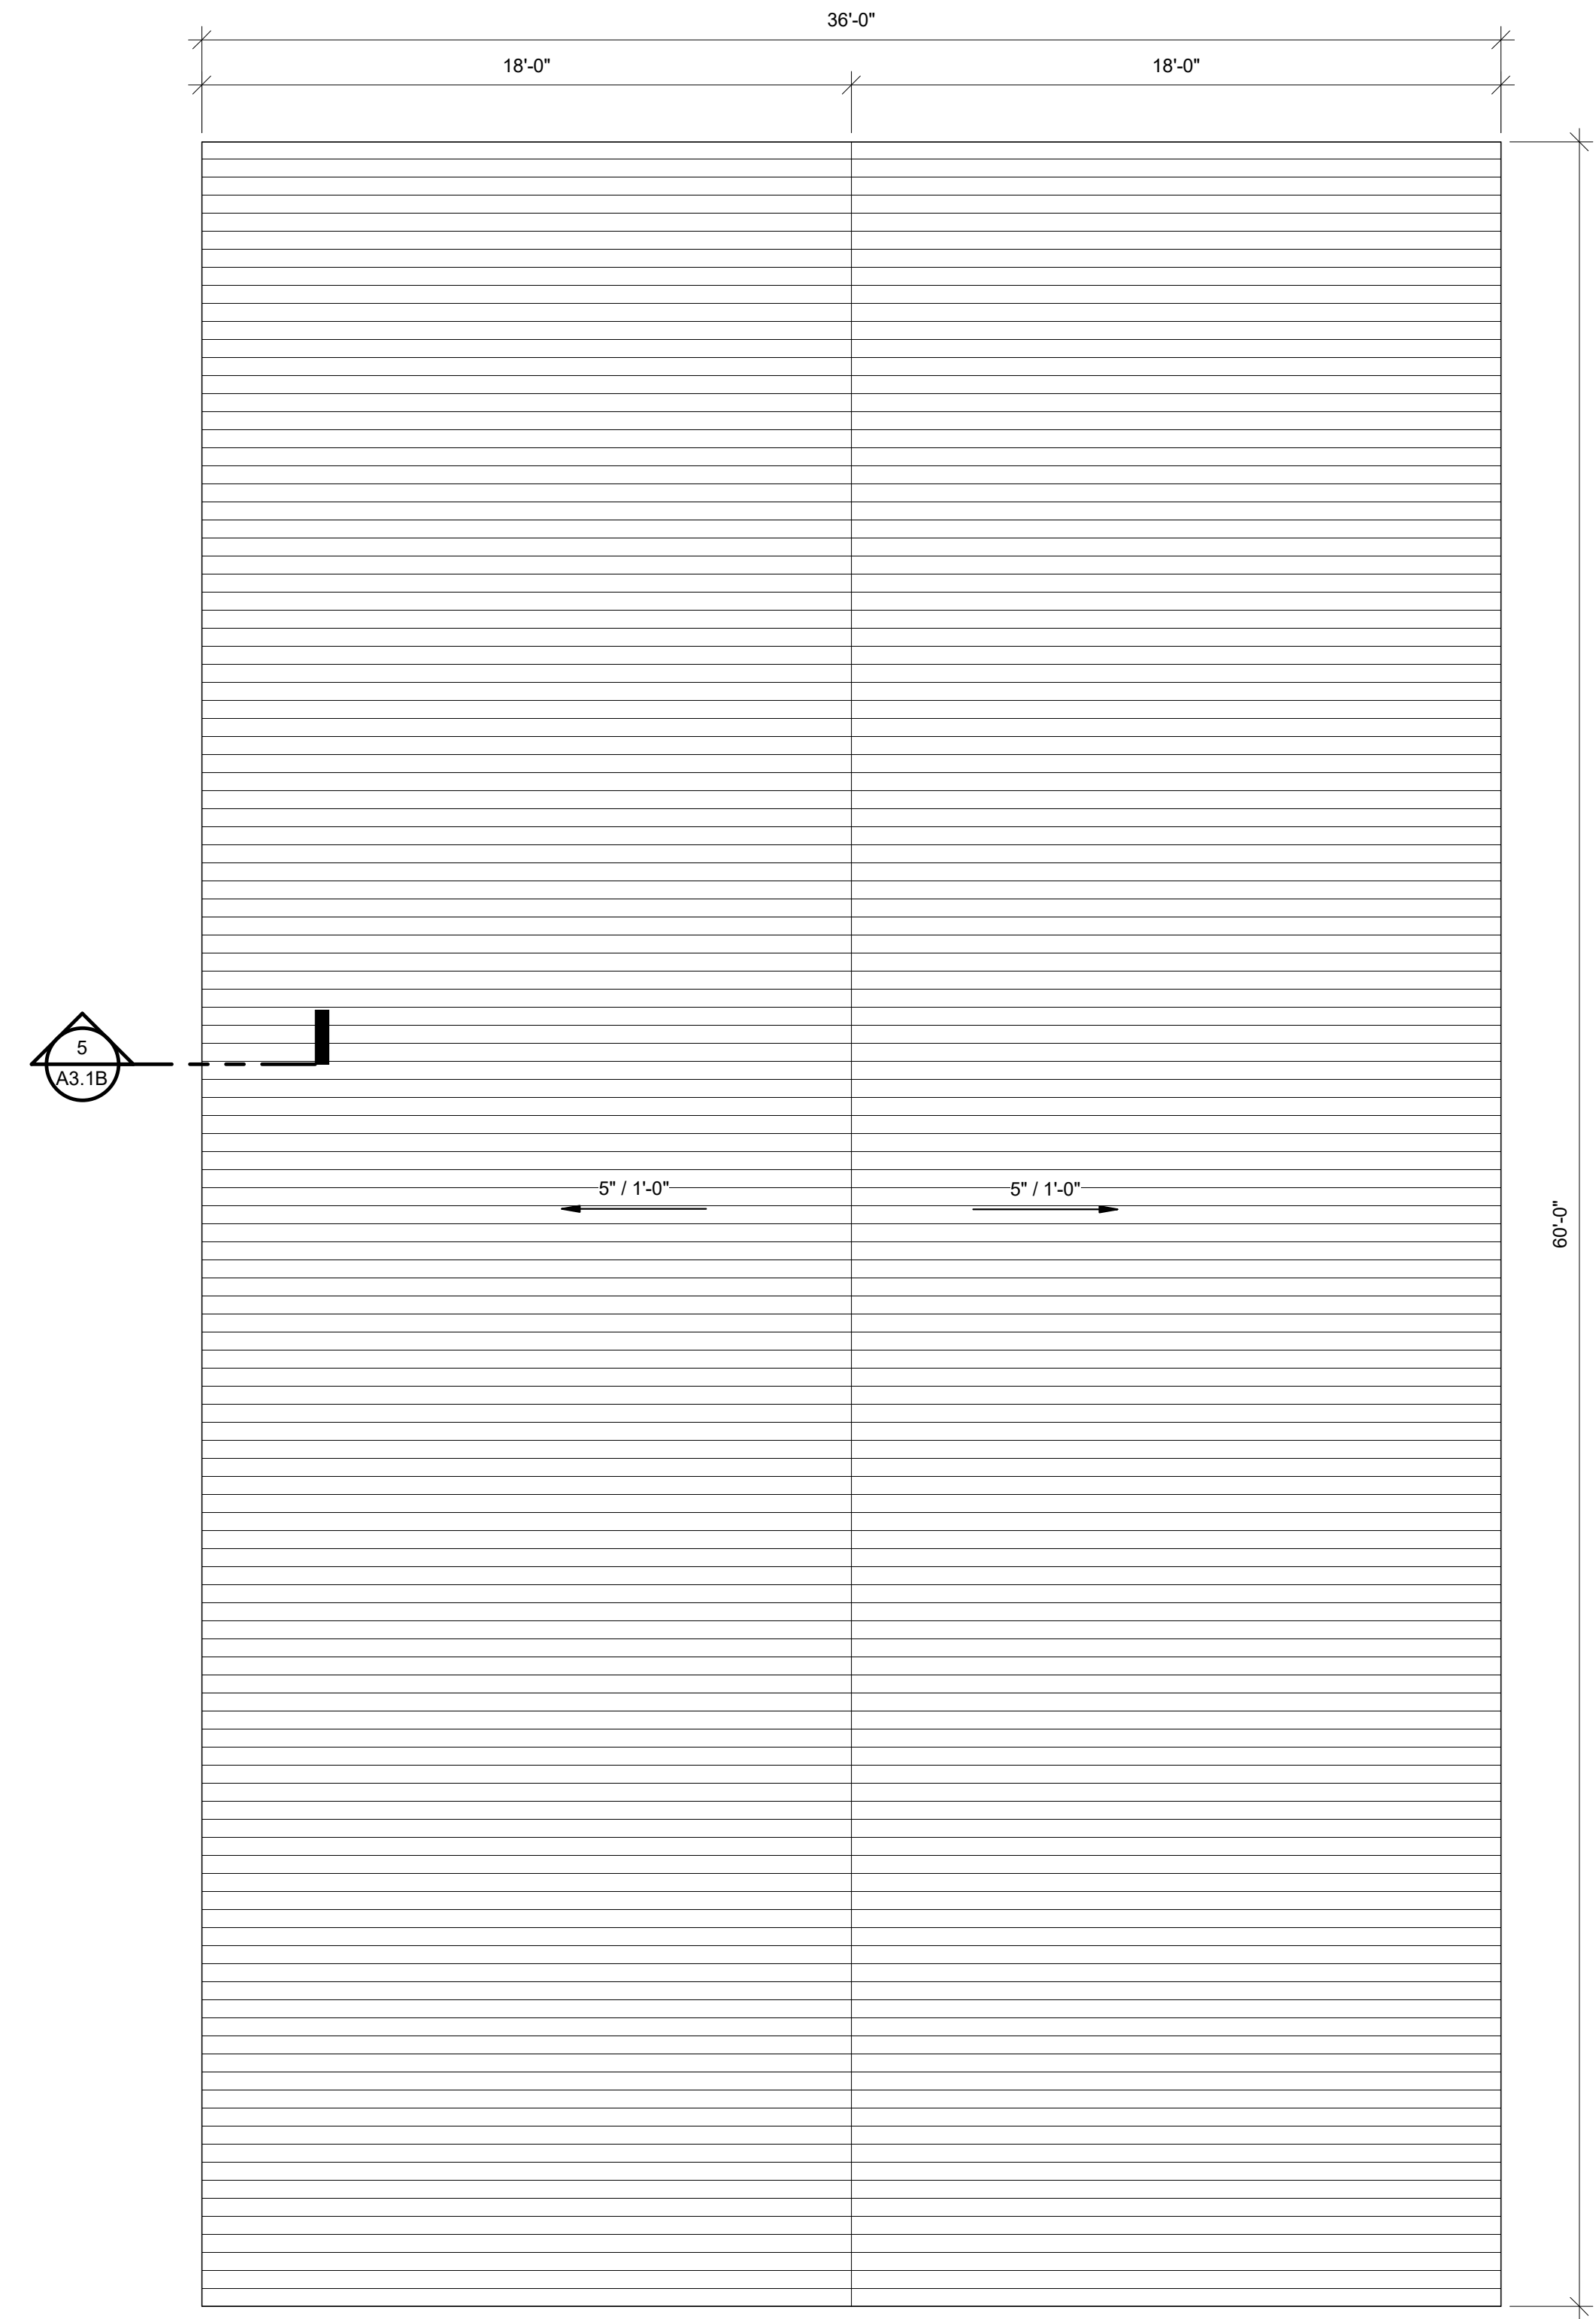


3 ROOF PLAN BUILDING B
1/4" = 1'-0"

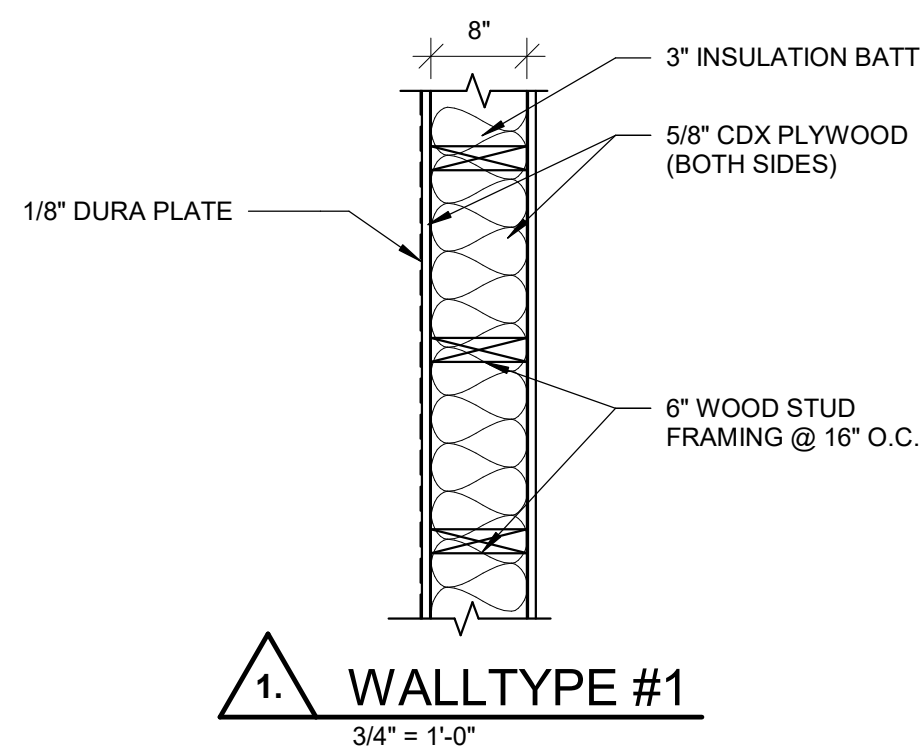

1 WALLTYPE #1
3/4" = 1'-0"

BUILDING B IS THE EAST BUILDING

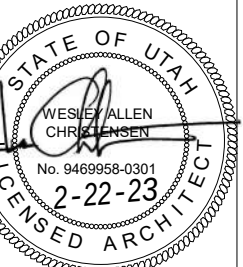

REVISIONS:

PROJECT TITLE
NEBO SCHOOL DISTRICT
NEBO ANIMAL LABS
1400 E HIGHLINE CANAL RD
SANATQUIN, UTAH

PROJECT TITLE
NEBO SCHOOL DISTRICT
NEBO ANIMAL LABS
1400 E HIGHLINE CANAL RD

PROJECT TITLE

DRAWN BY: Author
CHECKED BY: Checker
DATE: FEB 2023
PROJECT #: 171022


A1.1B

170 NORTH MAIN STREET
SPANISH FORK, UTAH 84660
WWW.KMAARCHITECTS.COM




THIS PRINT AND ALL INFORMATION HEREON IS THE PROPERTY OF KMA ARCHITECTS AND SHALL NOT BE USED ON ANY OTHER JOB WITHOUT WRITTEN PERMISSION OF THE ARCHITECT


2/23/2023 4:27:17 PM
As Noted

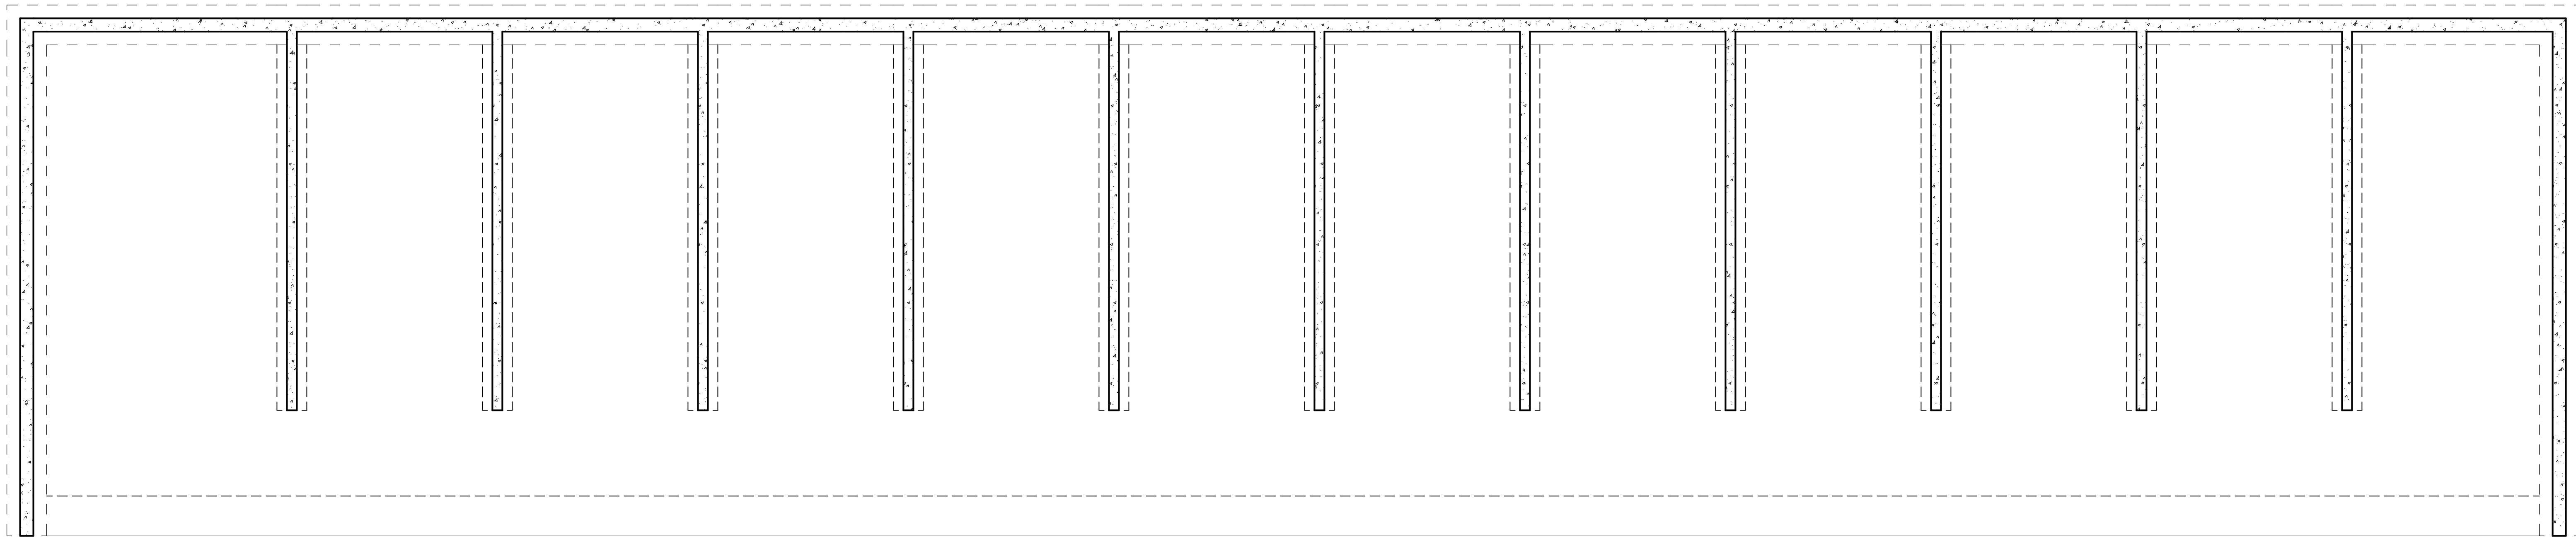



1 FOUNDATION PLAN BUILDING C
1/4" = 1'-0"

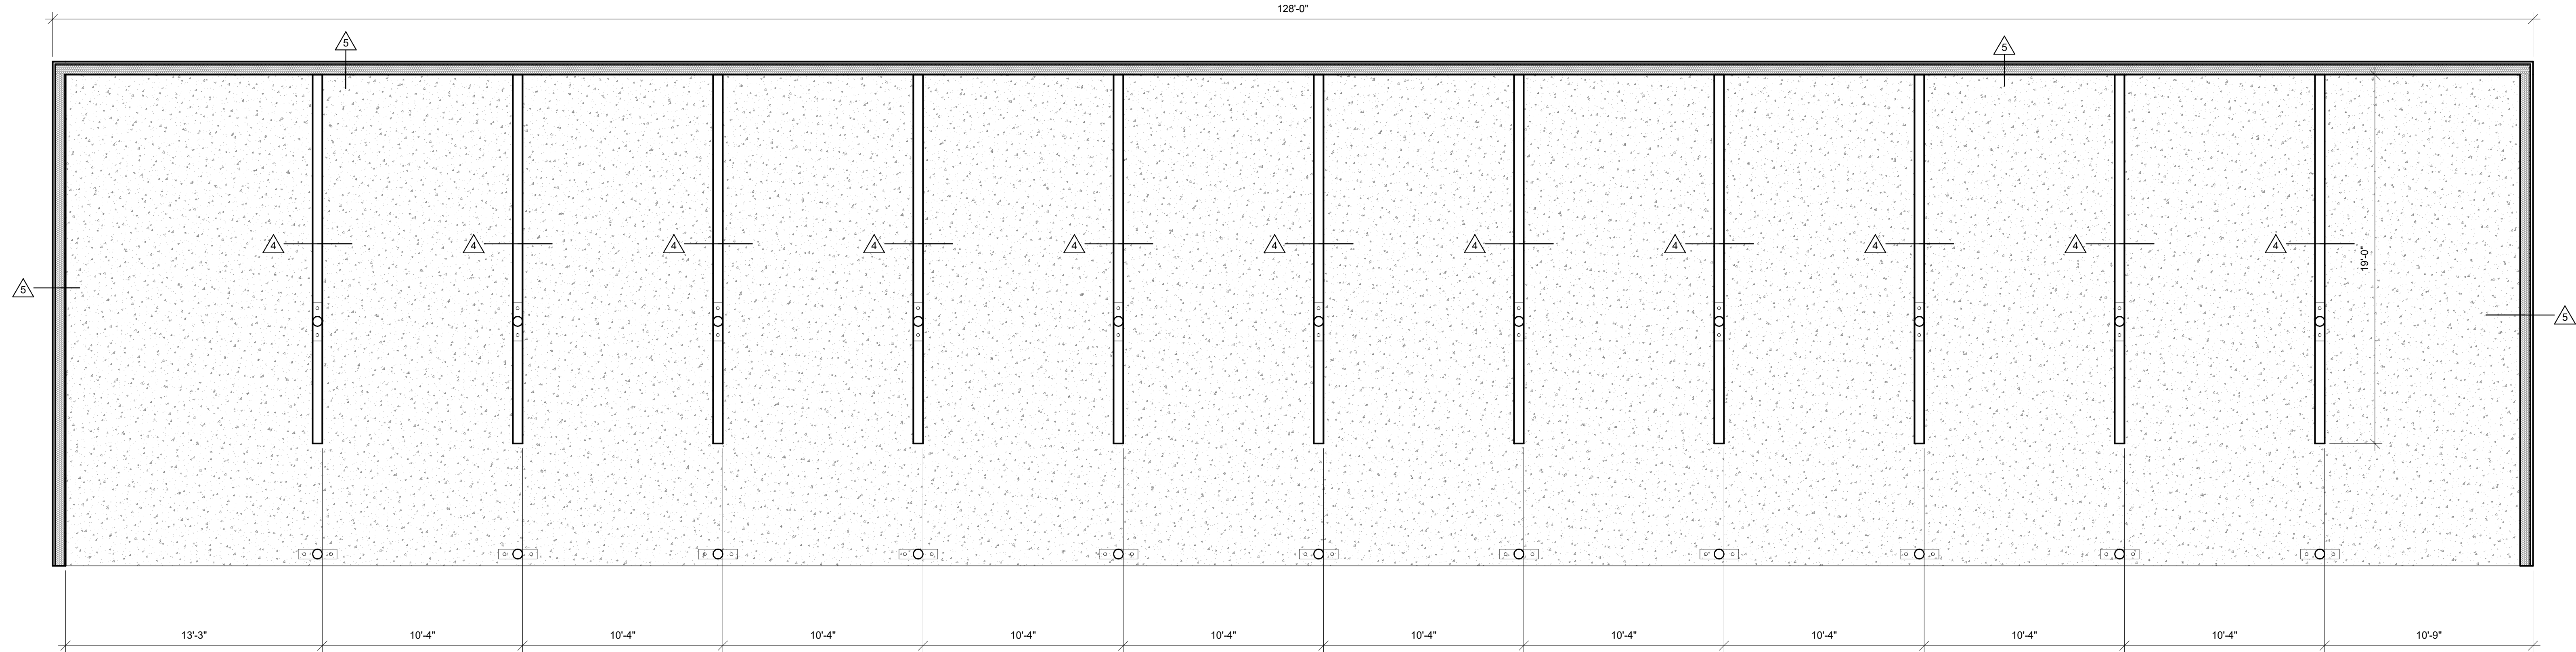

2 MAIN FLOOR PLAN BUILDING C
1/4" = 1'-0"

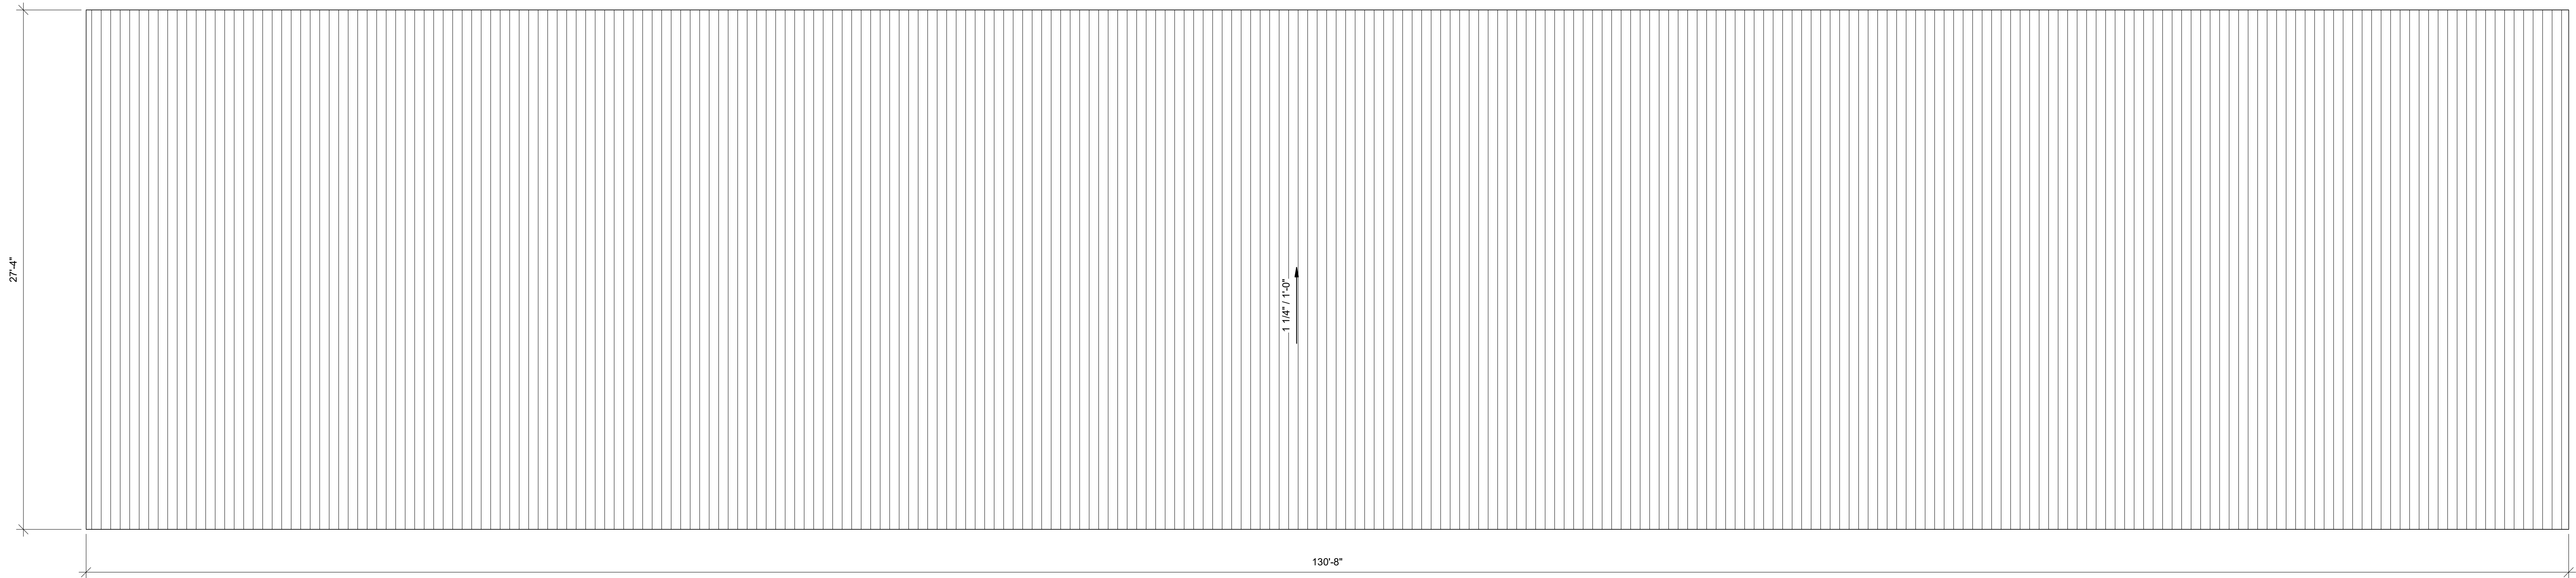

3 ROOF PLAN BUILDING C
1/4" = 1'-0"

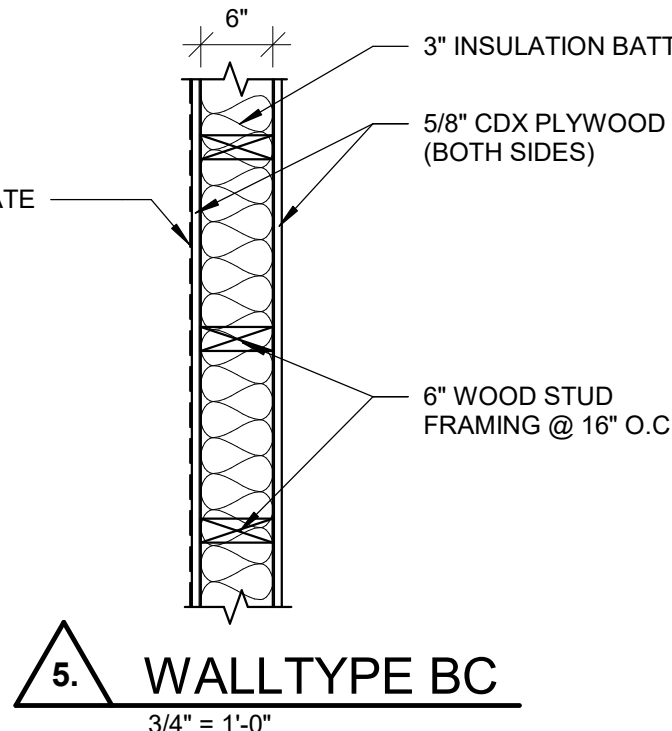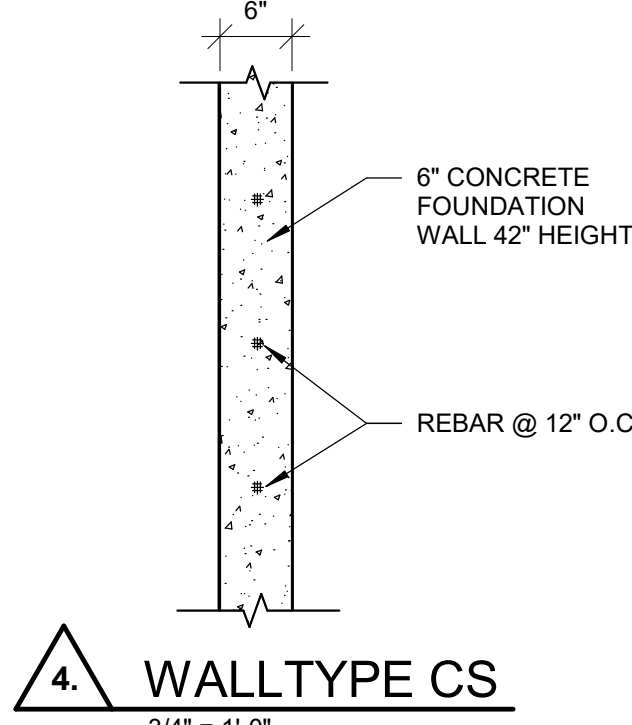

BUILDING C IS THE
NORTH BUILDING



REVISIONS:

PROJECT TITLE
NEBO SCHOOL DISTRICT
NEBO ANIMAL LABS
1400 E HIGHLINE CANAL RD
SANATQUIN, UTAH

DRAWN BY: STAFF
CHECKED BY: WES
DATE: FEB 2023
PROJECT #: 171022


A1.1C

170 NORTH MAIN STREET
SPRINGFIELD, UTAH 84660
WWW.KMAARCHITECTS.COM







1 FOUNDATION PLAN BUILDING D
1/4" = 1'-0"

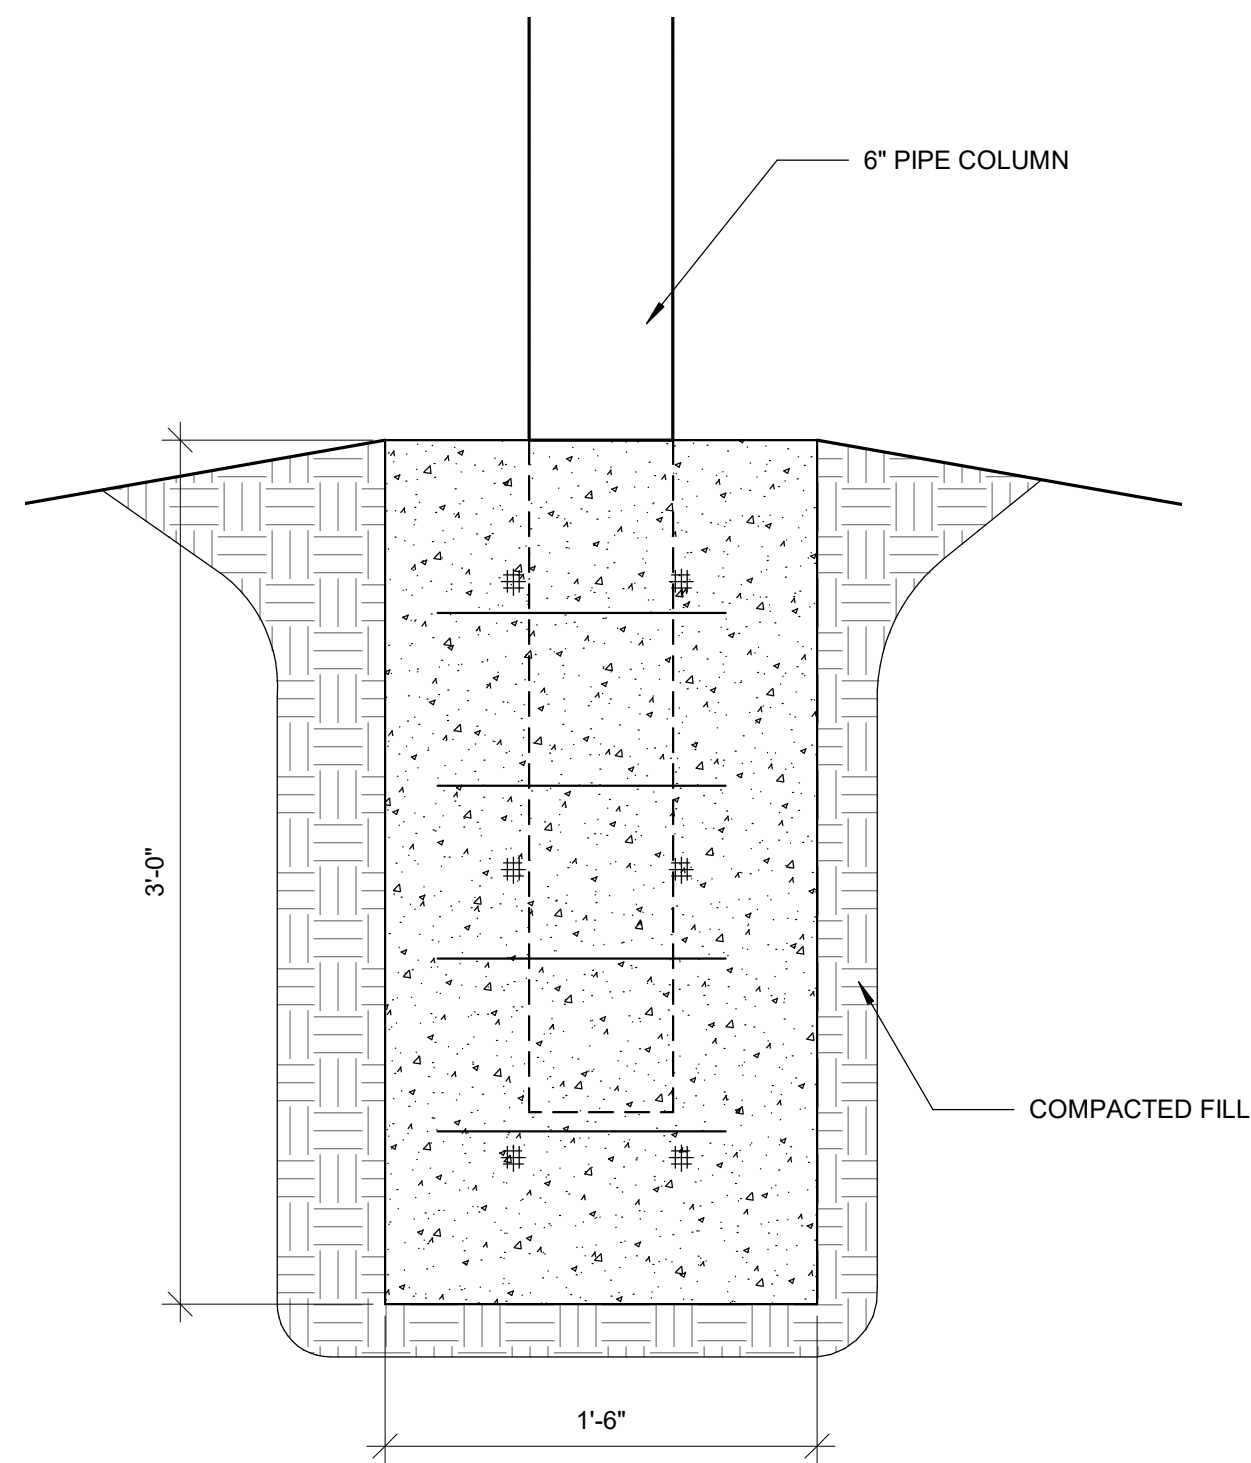



3 COLUMN FOOTING DETAIL
1 1/2" = 1'-0"

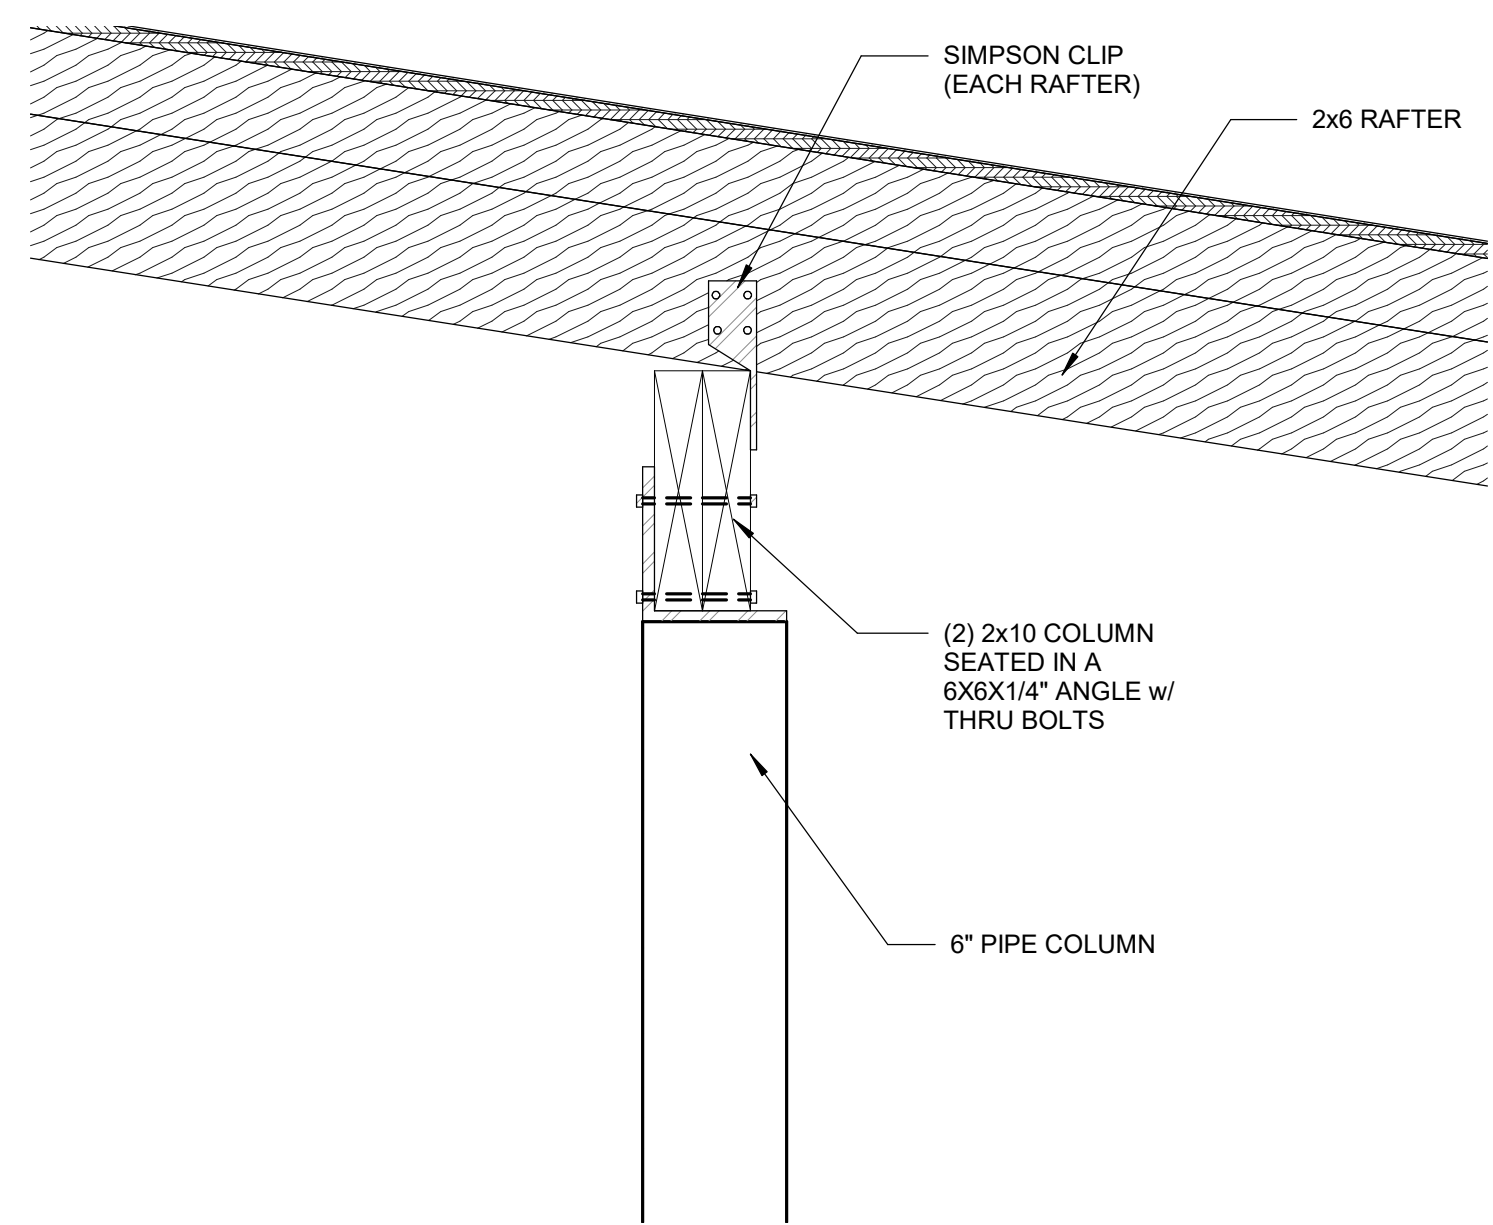

4 COLUMN CONNECTION TO ROOF
1 1/2" = 1'-0"

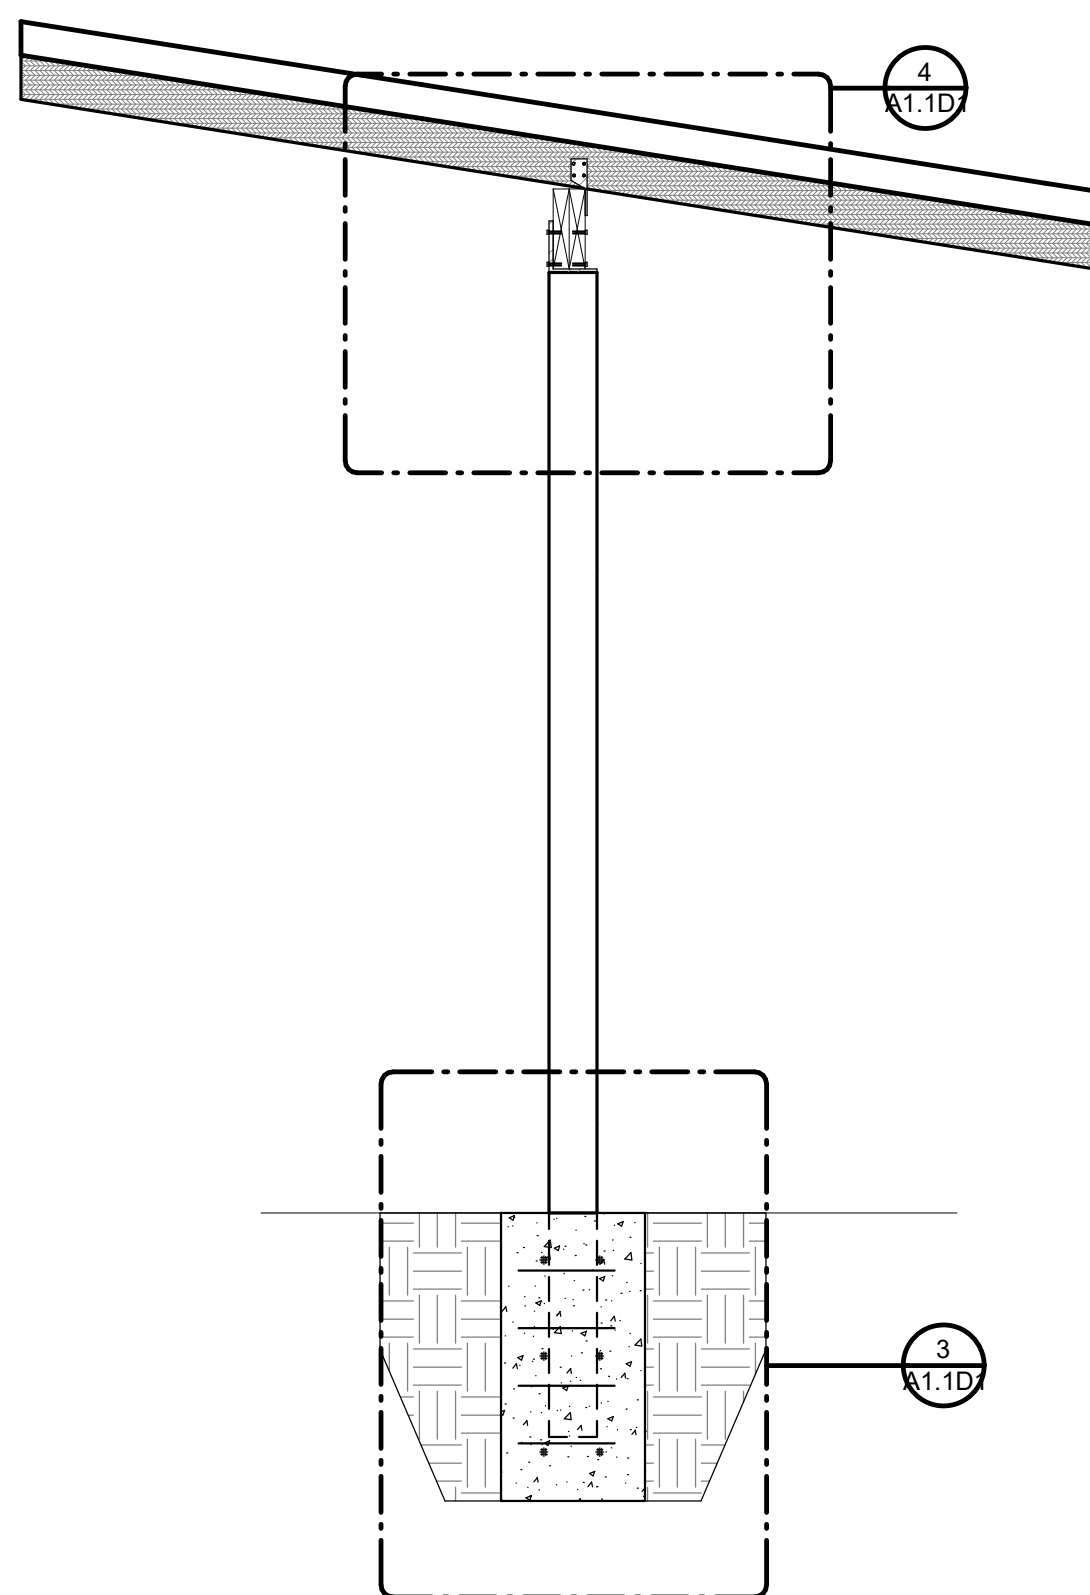

6 BUILDING D
1/2" = 1'-0"

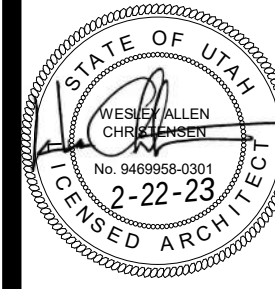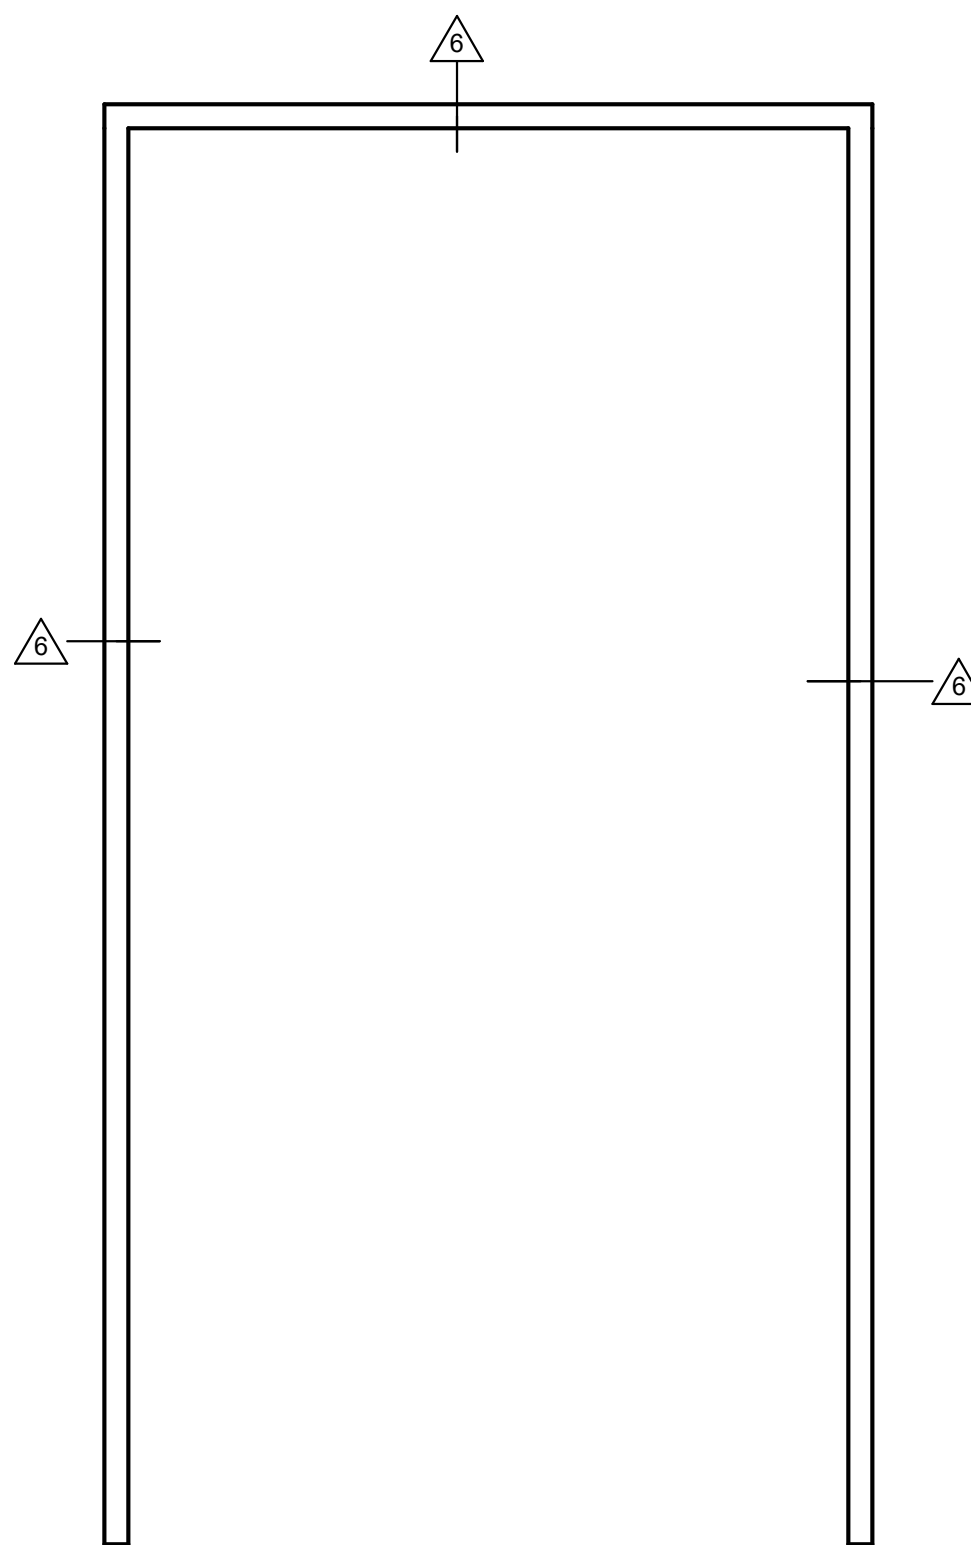

REVISIONS:



PROJECT TITLE
NEBO SCHOOL DISTRICT
NEBO ANIMAL LABS
400 E HIGHLINE CANAL RD
SANATQUIN, UTAH

DRAWN BY: Author
CHECKED BY: Checker
DATE: FEB 2023
PROJECT #: 171022

170 NORTH MAIN STREET
SPRINGFIELD, UT 84660
WWW.KMAARCHITECTS.COM

A1.1D1

BUILDING D IS THE SOUTH BUILDING

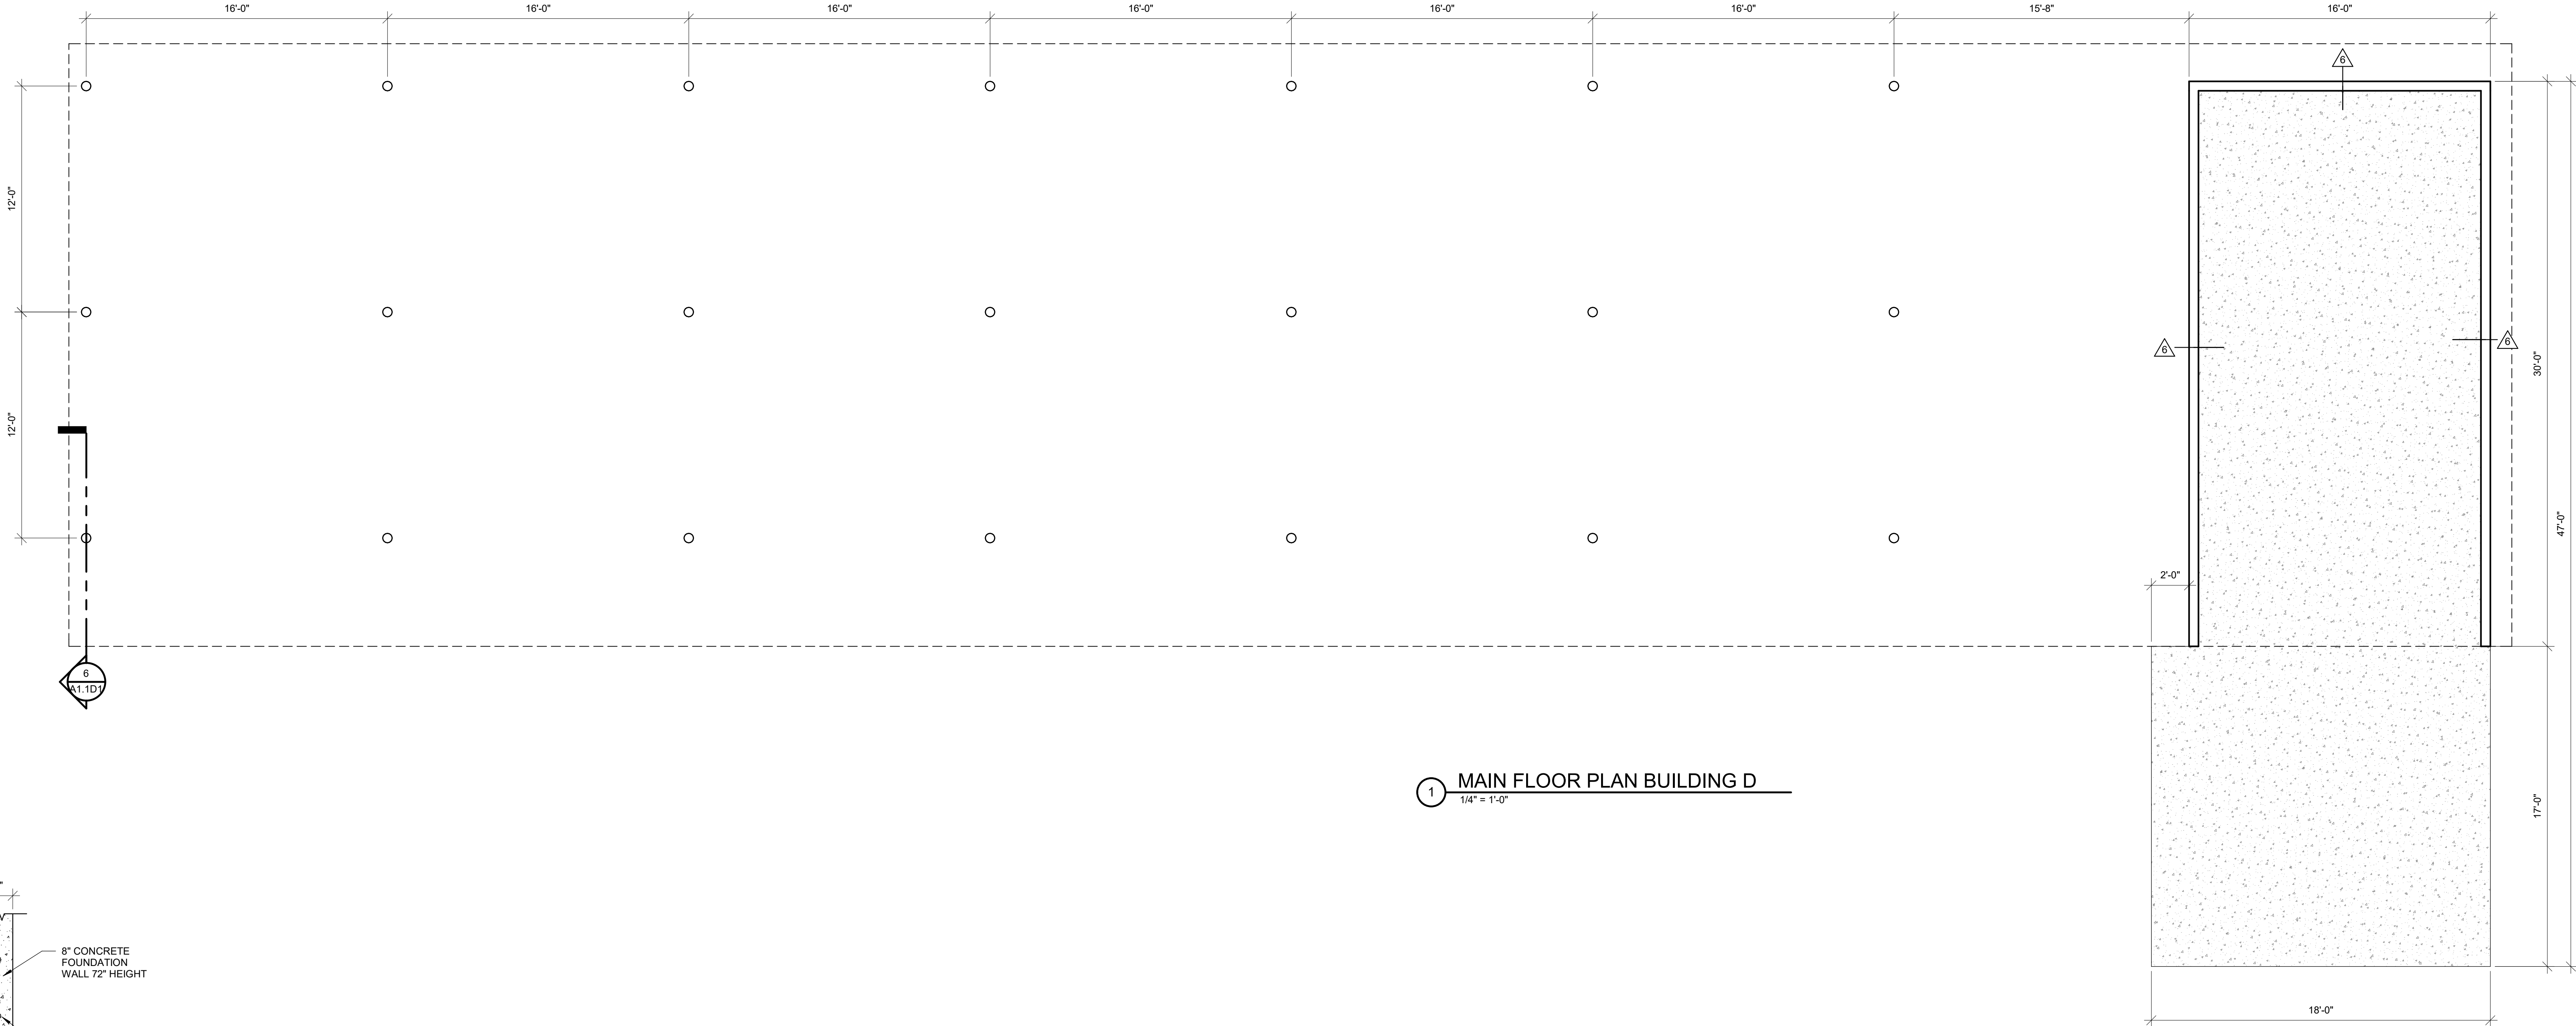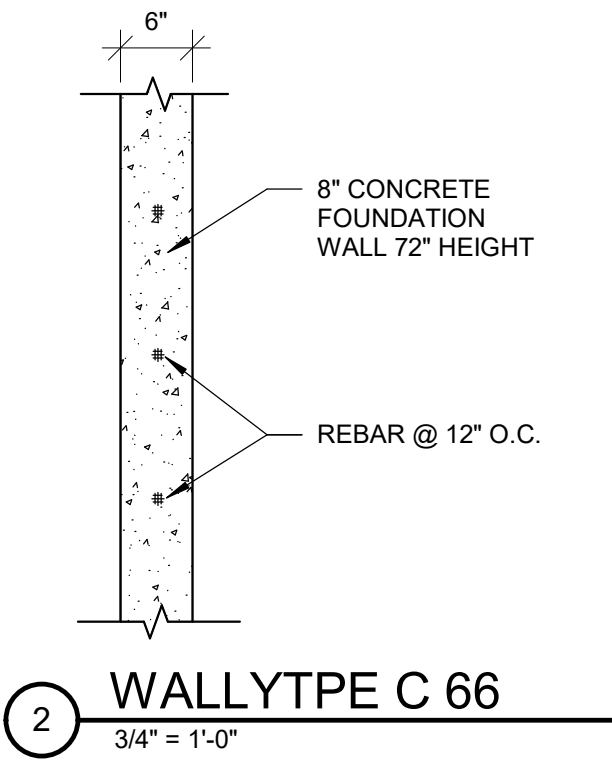


DRAWN BY: Author
CHECKED BY: Checker
DATE: FEB 2023
PROJECT #: 171022

PROJECT TITLE
NEBO SCHOOL DISTRICT
NEBO ANIMAL LABS
1400 E HIGHLINE CANAL RD
SANATQUIN, UTAH




170 NORTH MAIN STREET
SPRINGFIELD, UTAH 84660
WWW.KMAARCHITECTS.COM


A1.1D

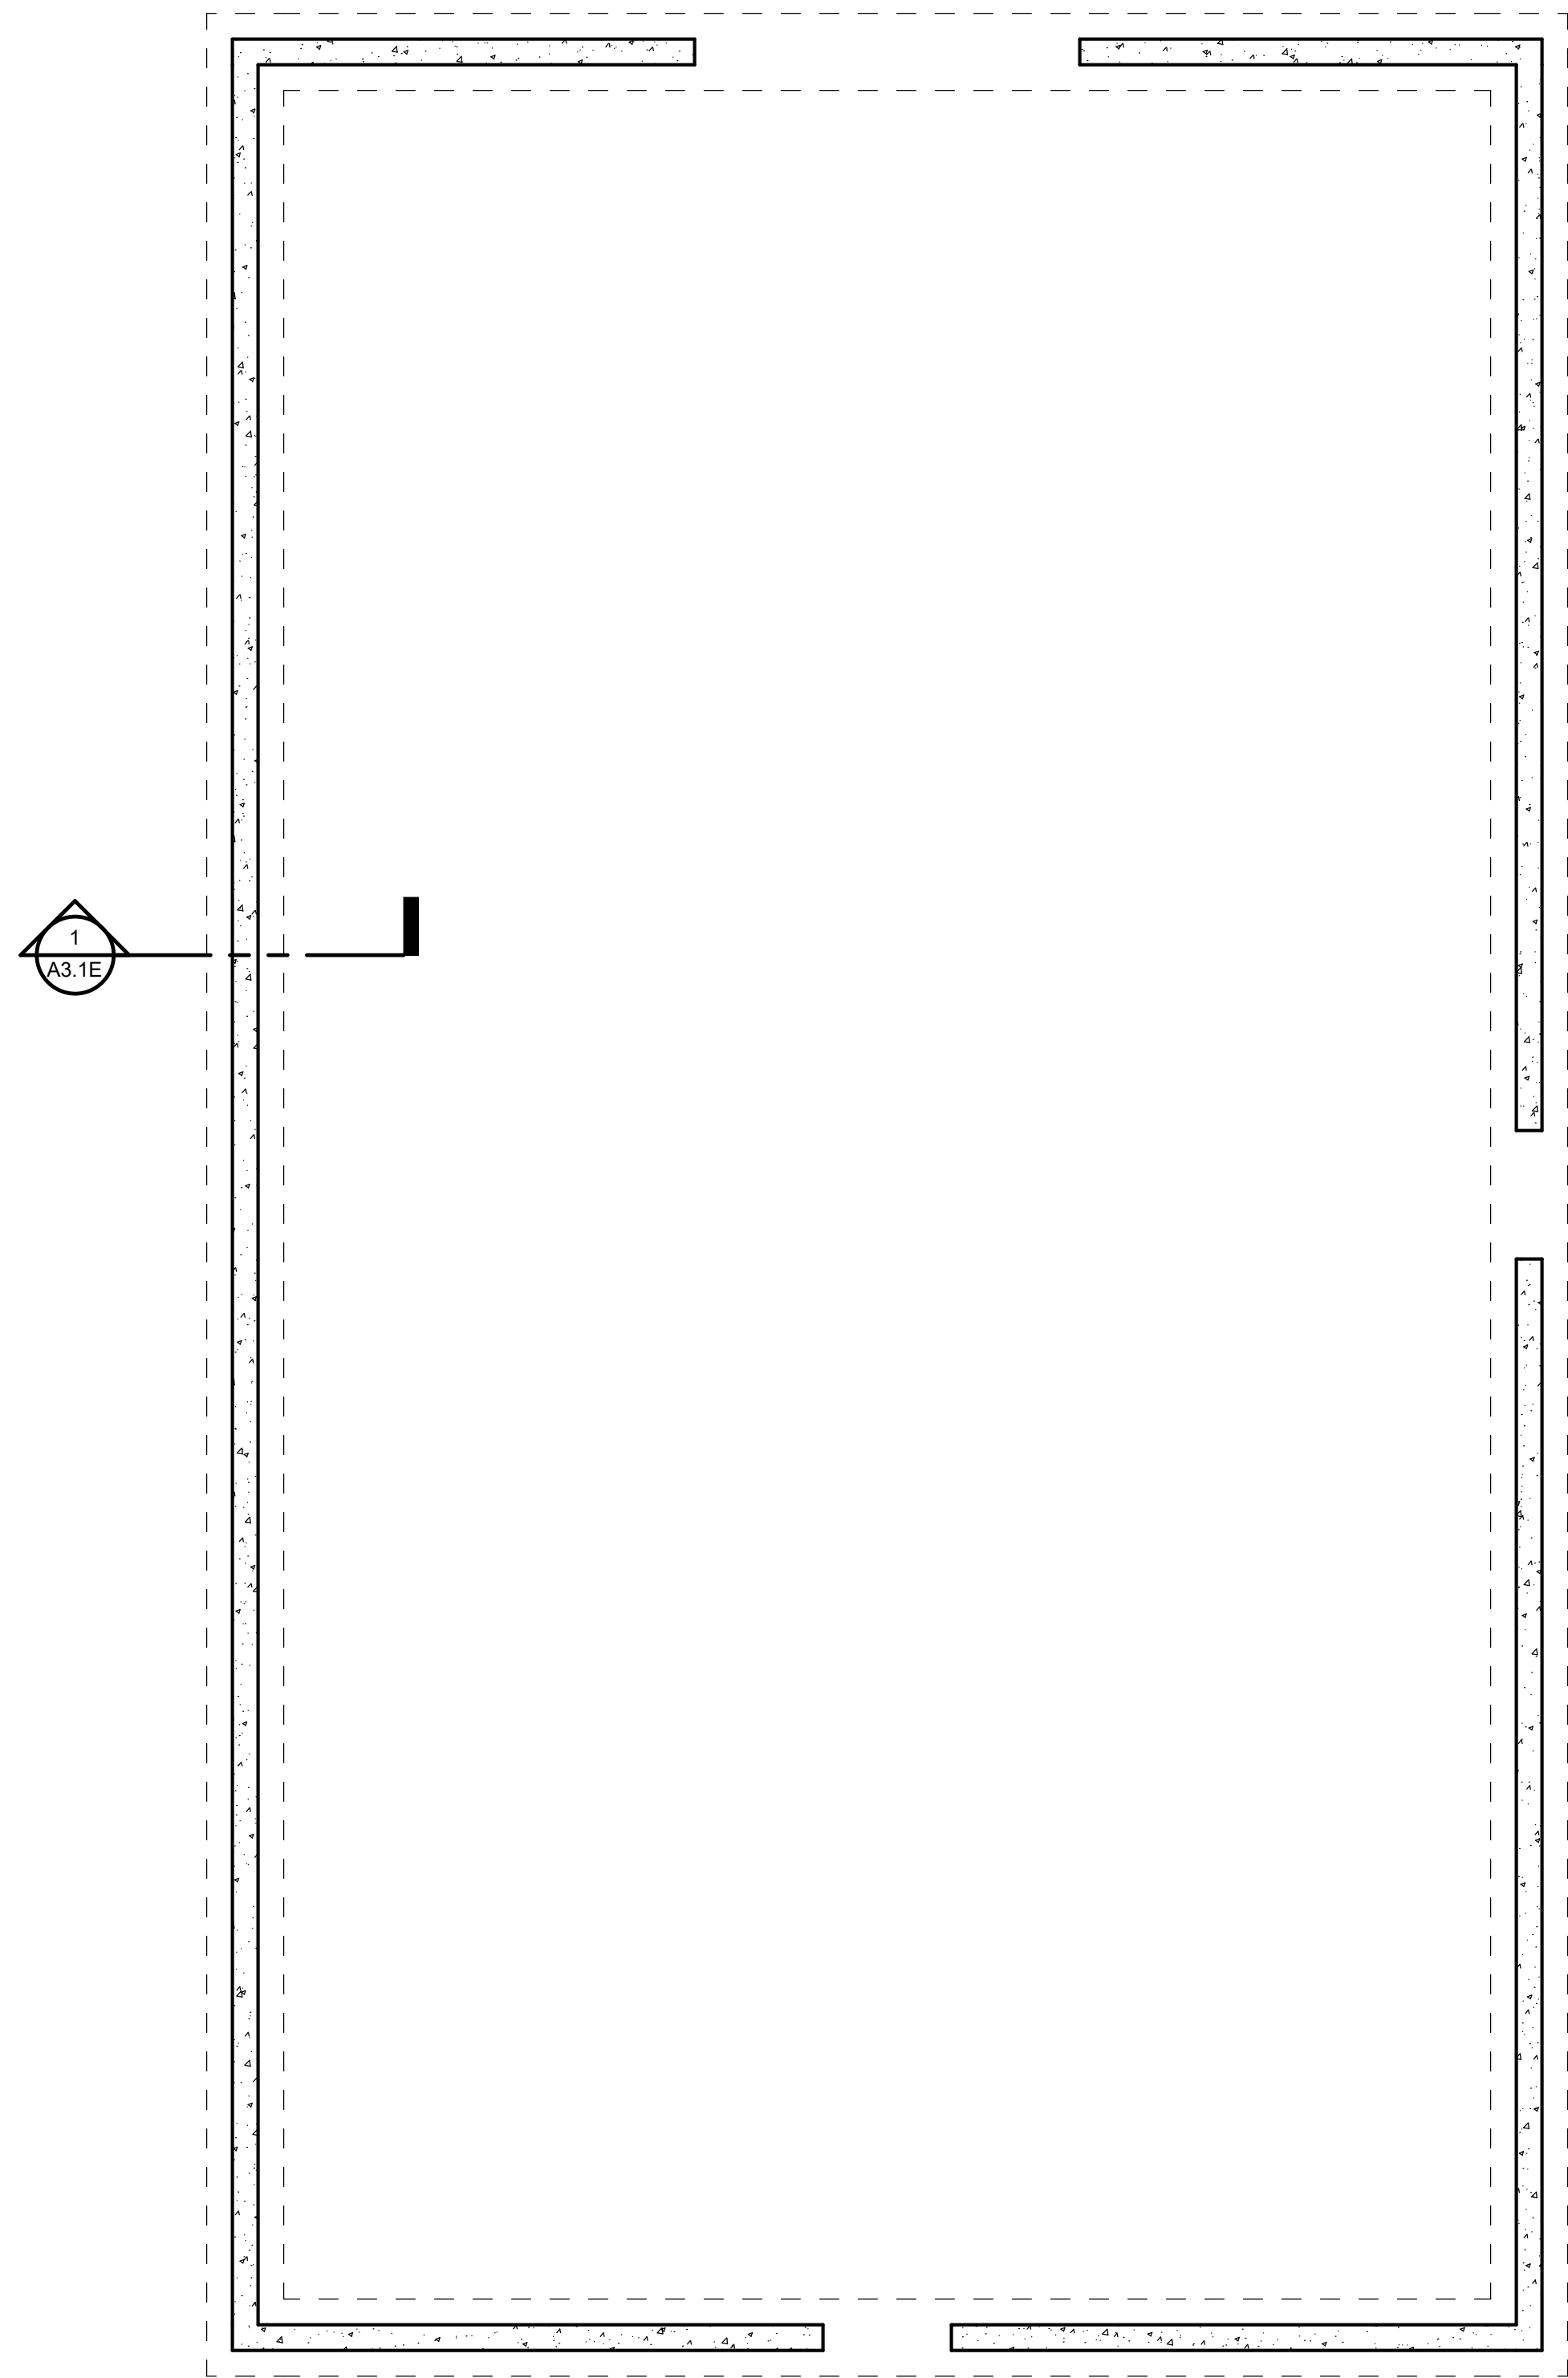


1 FOUNDATION PLAN BUILDING E
1/4" = 1'-0"

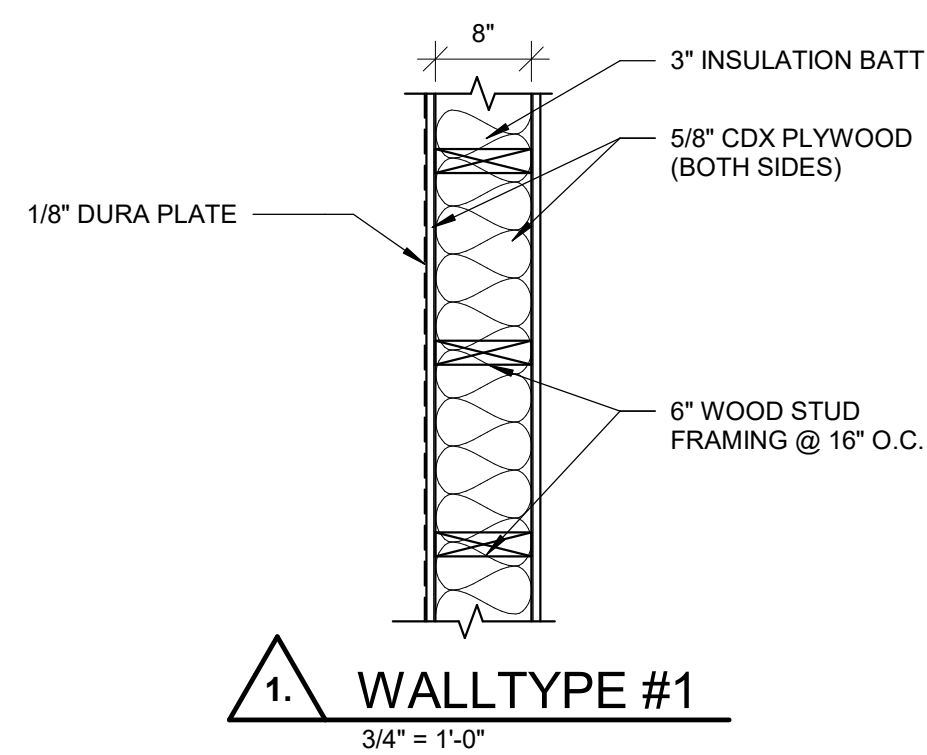

1. WALLTYPE #1
3/4" = 1'-0"

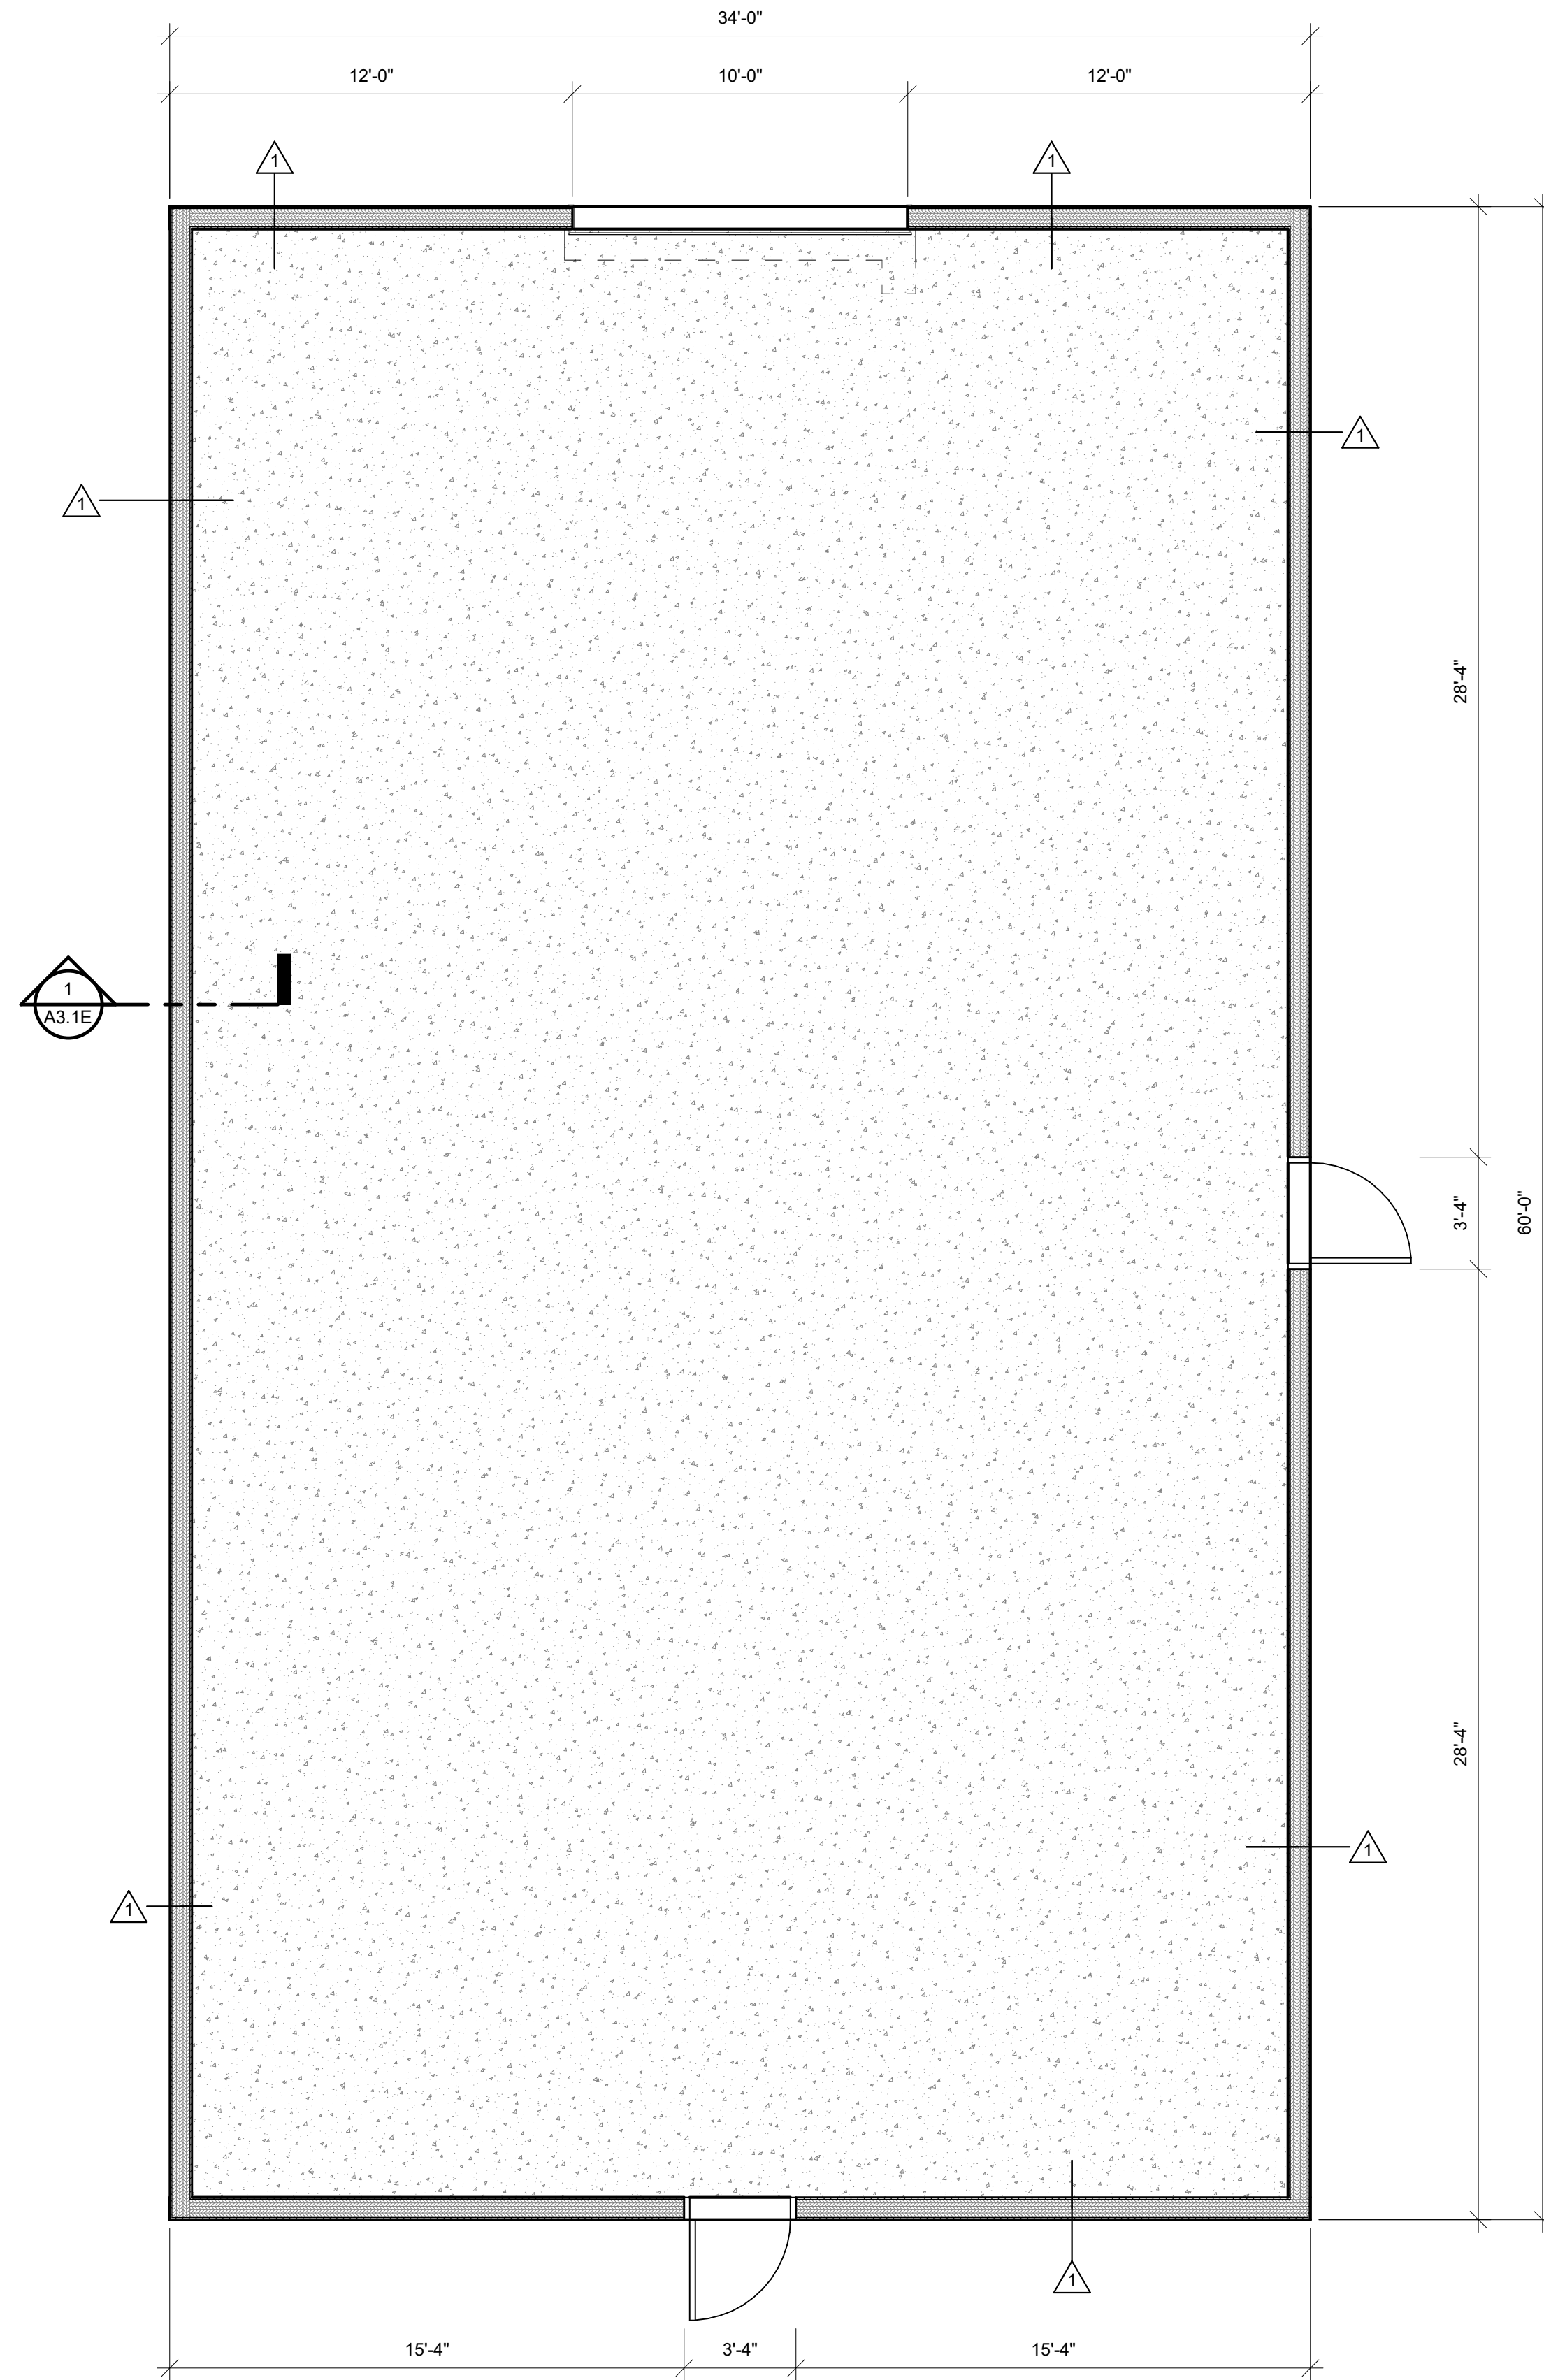

2 MAIN FLOOR PLAN BUILDING E
1/4" = 1'-0"

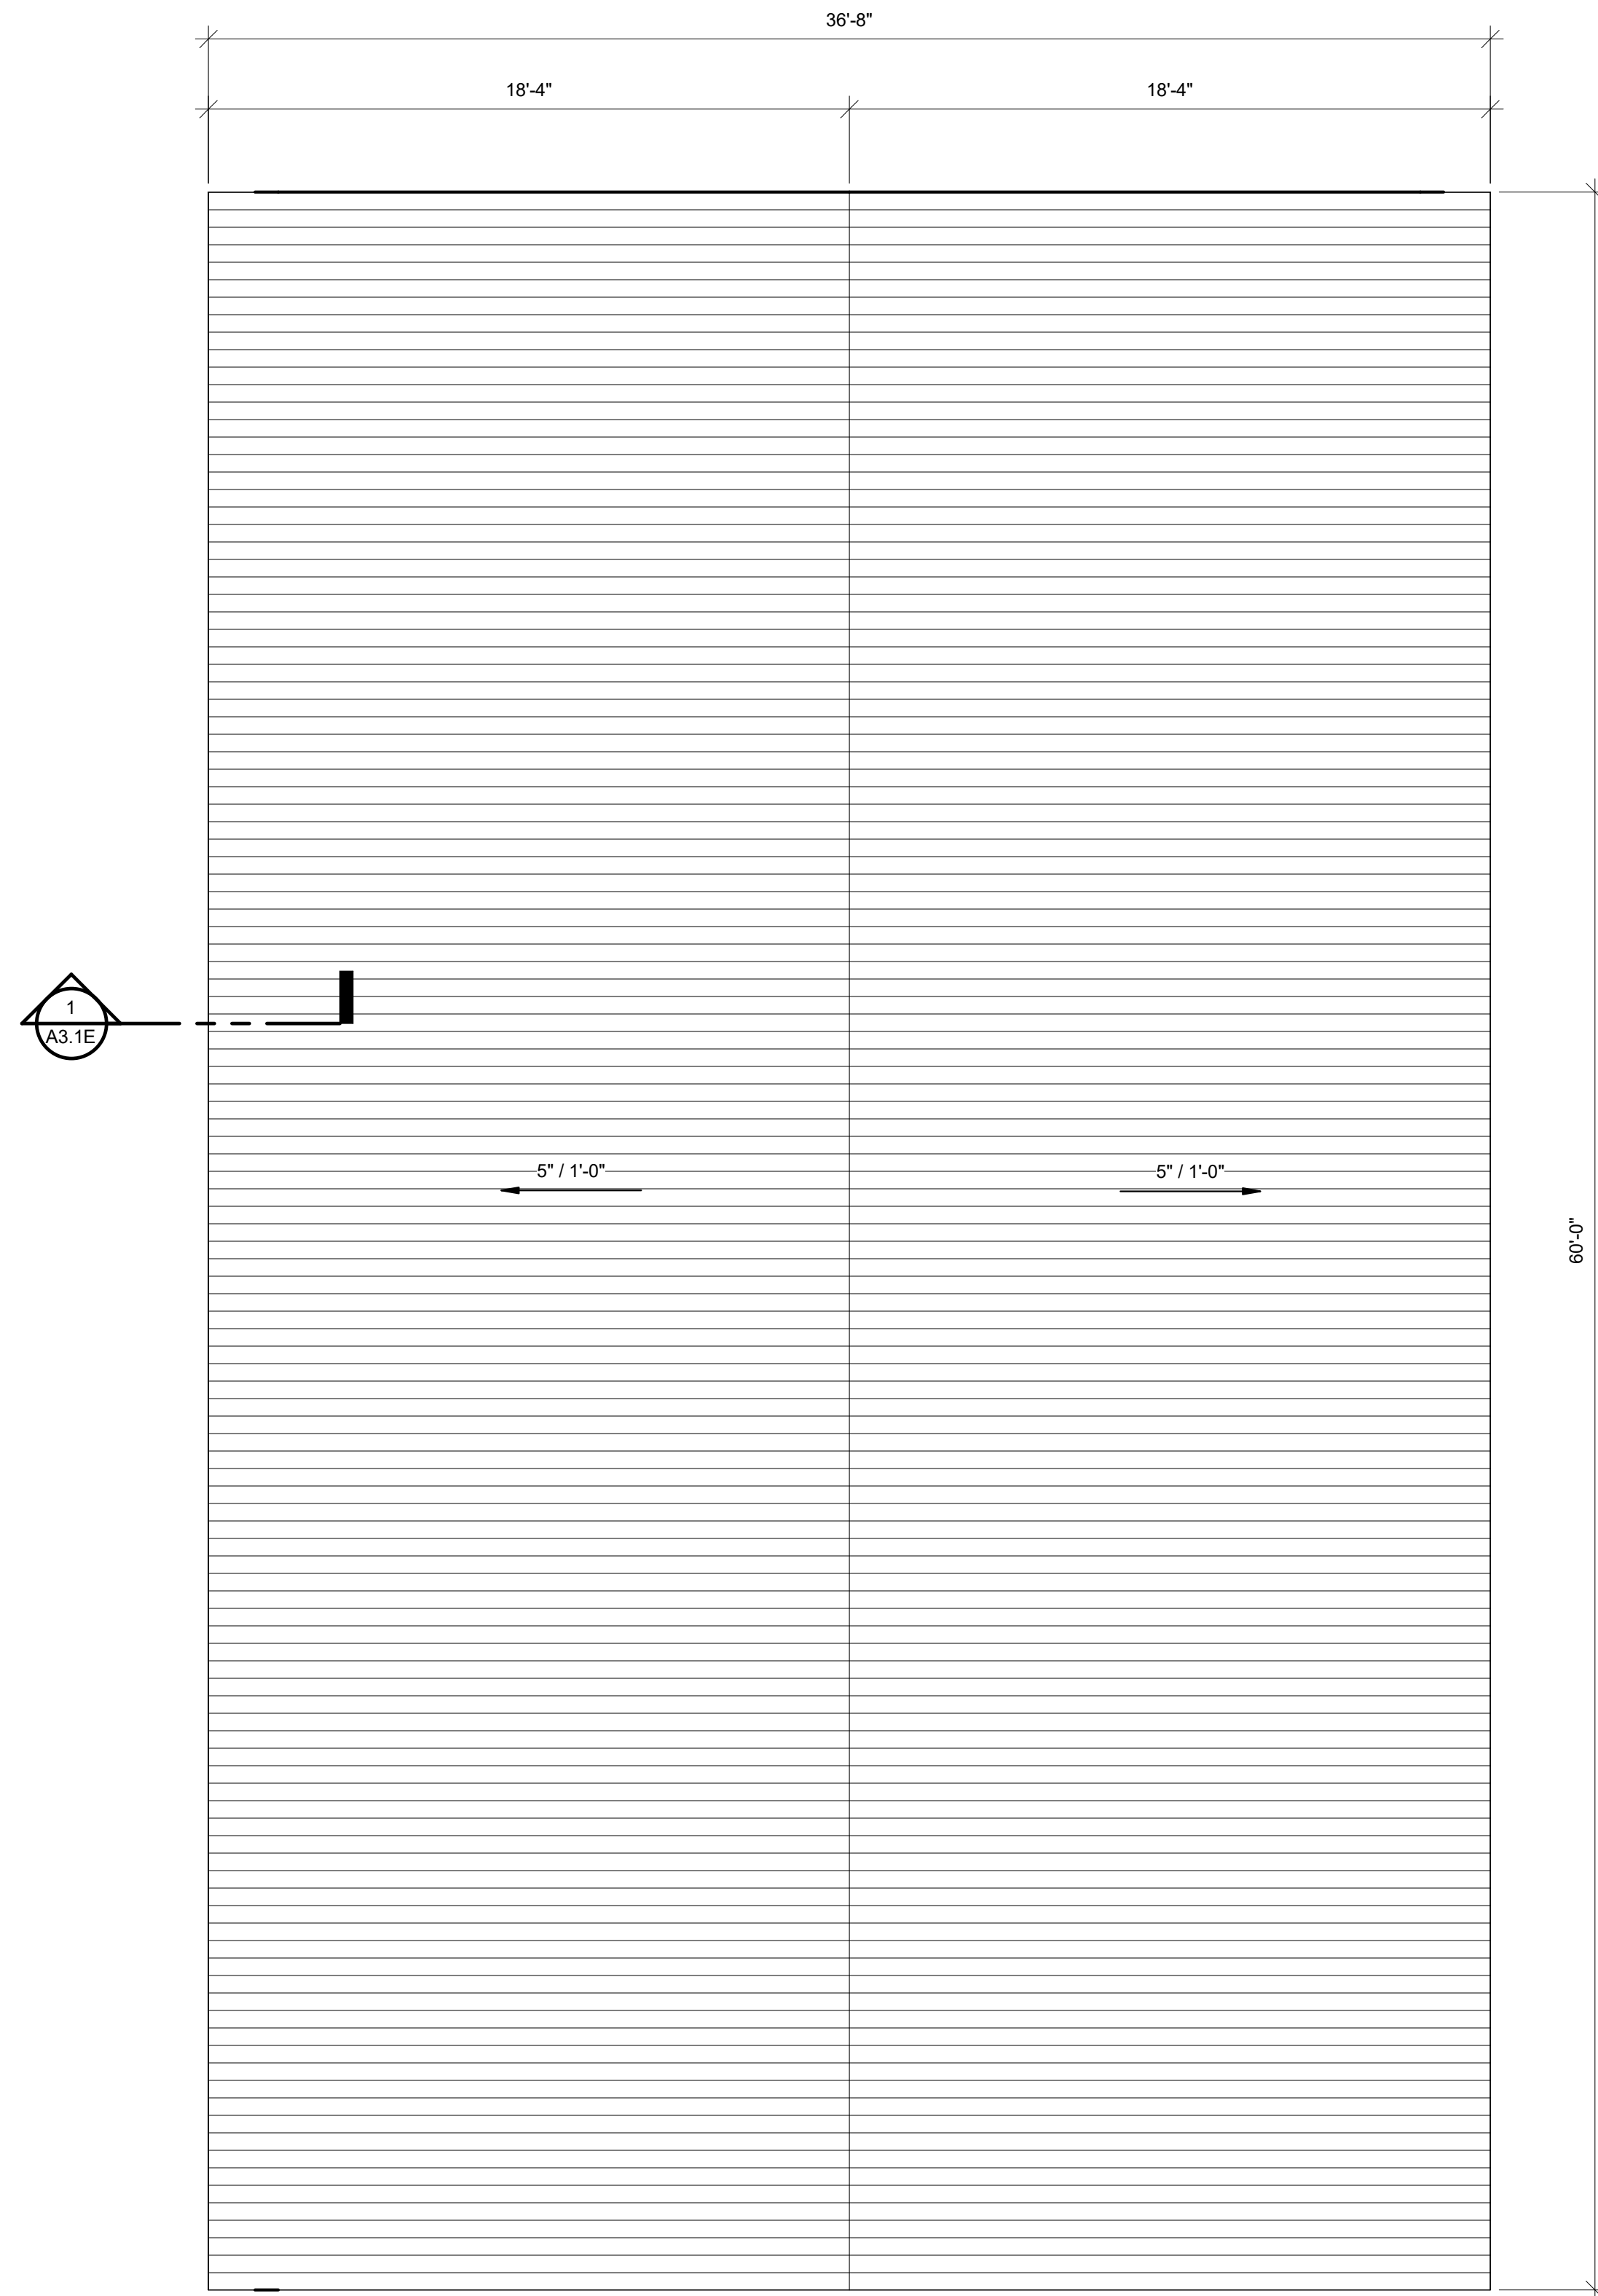

3 ROOF PLAN BUILDING E
1/4" = 1'-0"

BUILDING E IS THE WEST BUILDING



REVISIONS:


PROJECT TITLE
NEBO SCHOOL DISTRICT
NEBO ANIMAL LABS
1400 E HIGHLINE CANAL RD
SANATQUIN, UTAH

DRAWN BY: Author
CHECKED BY: Checker
DATE: FEB 2023
PROJECT #: 171022


A1.1E

170 NORTH MAIN STREET
SPRINGFIELD, UT 84660
WWW.KMAARCHITECTS.COM




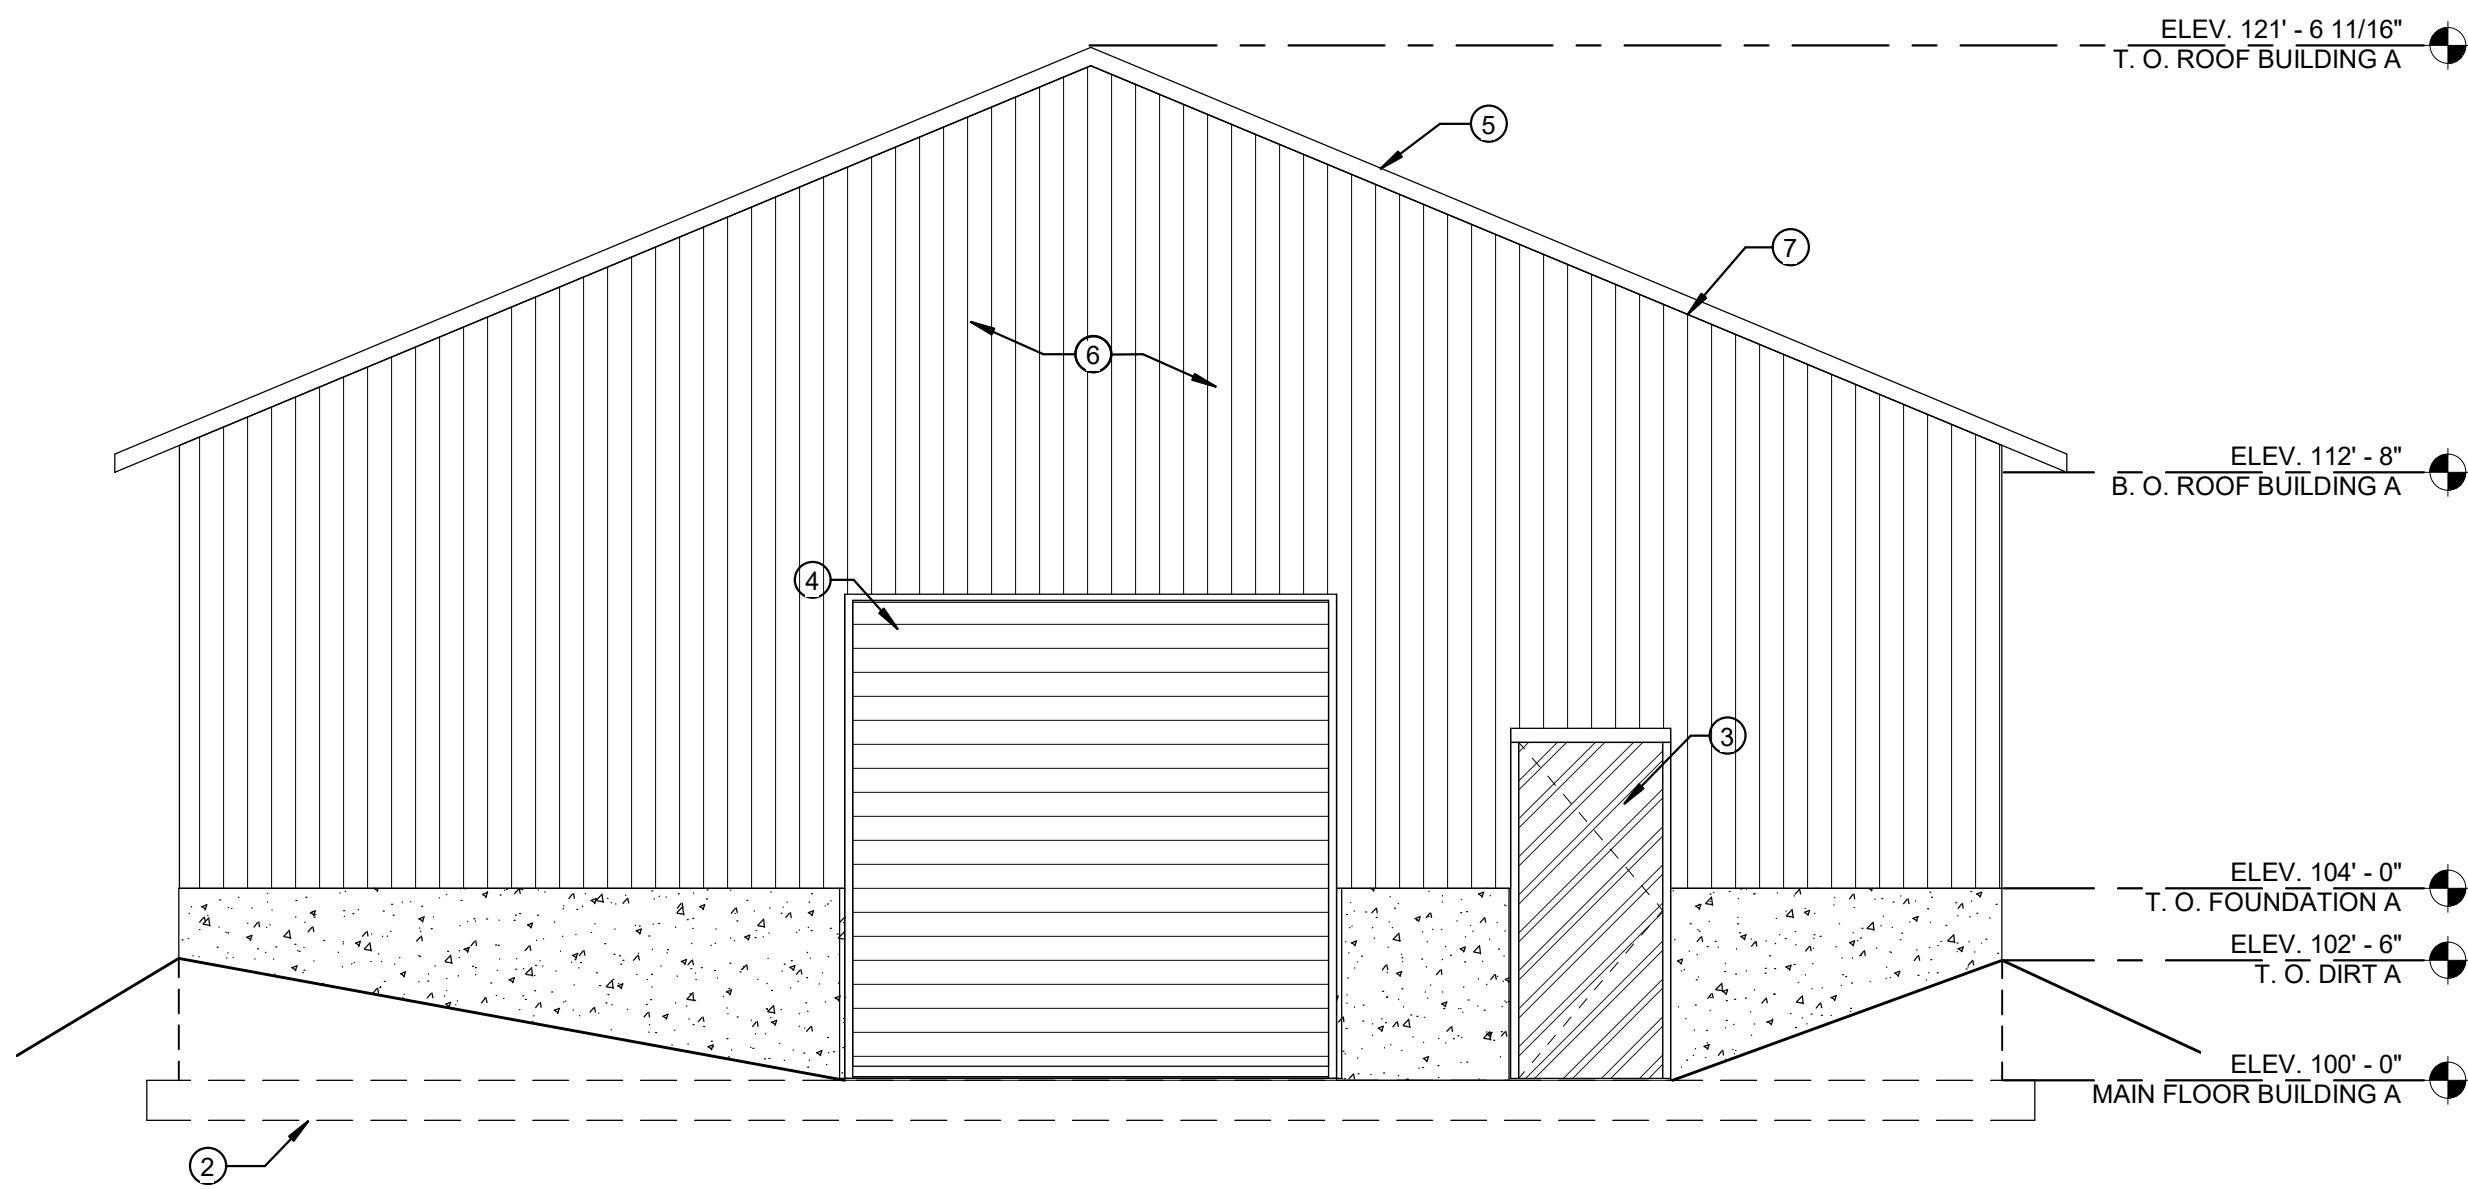


2 BUILDING A NORTH
1/4" = 1'-0"

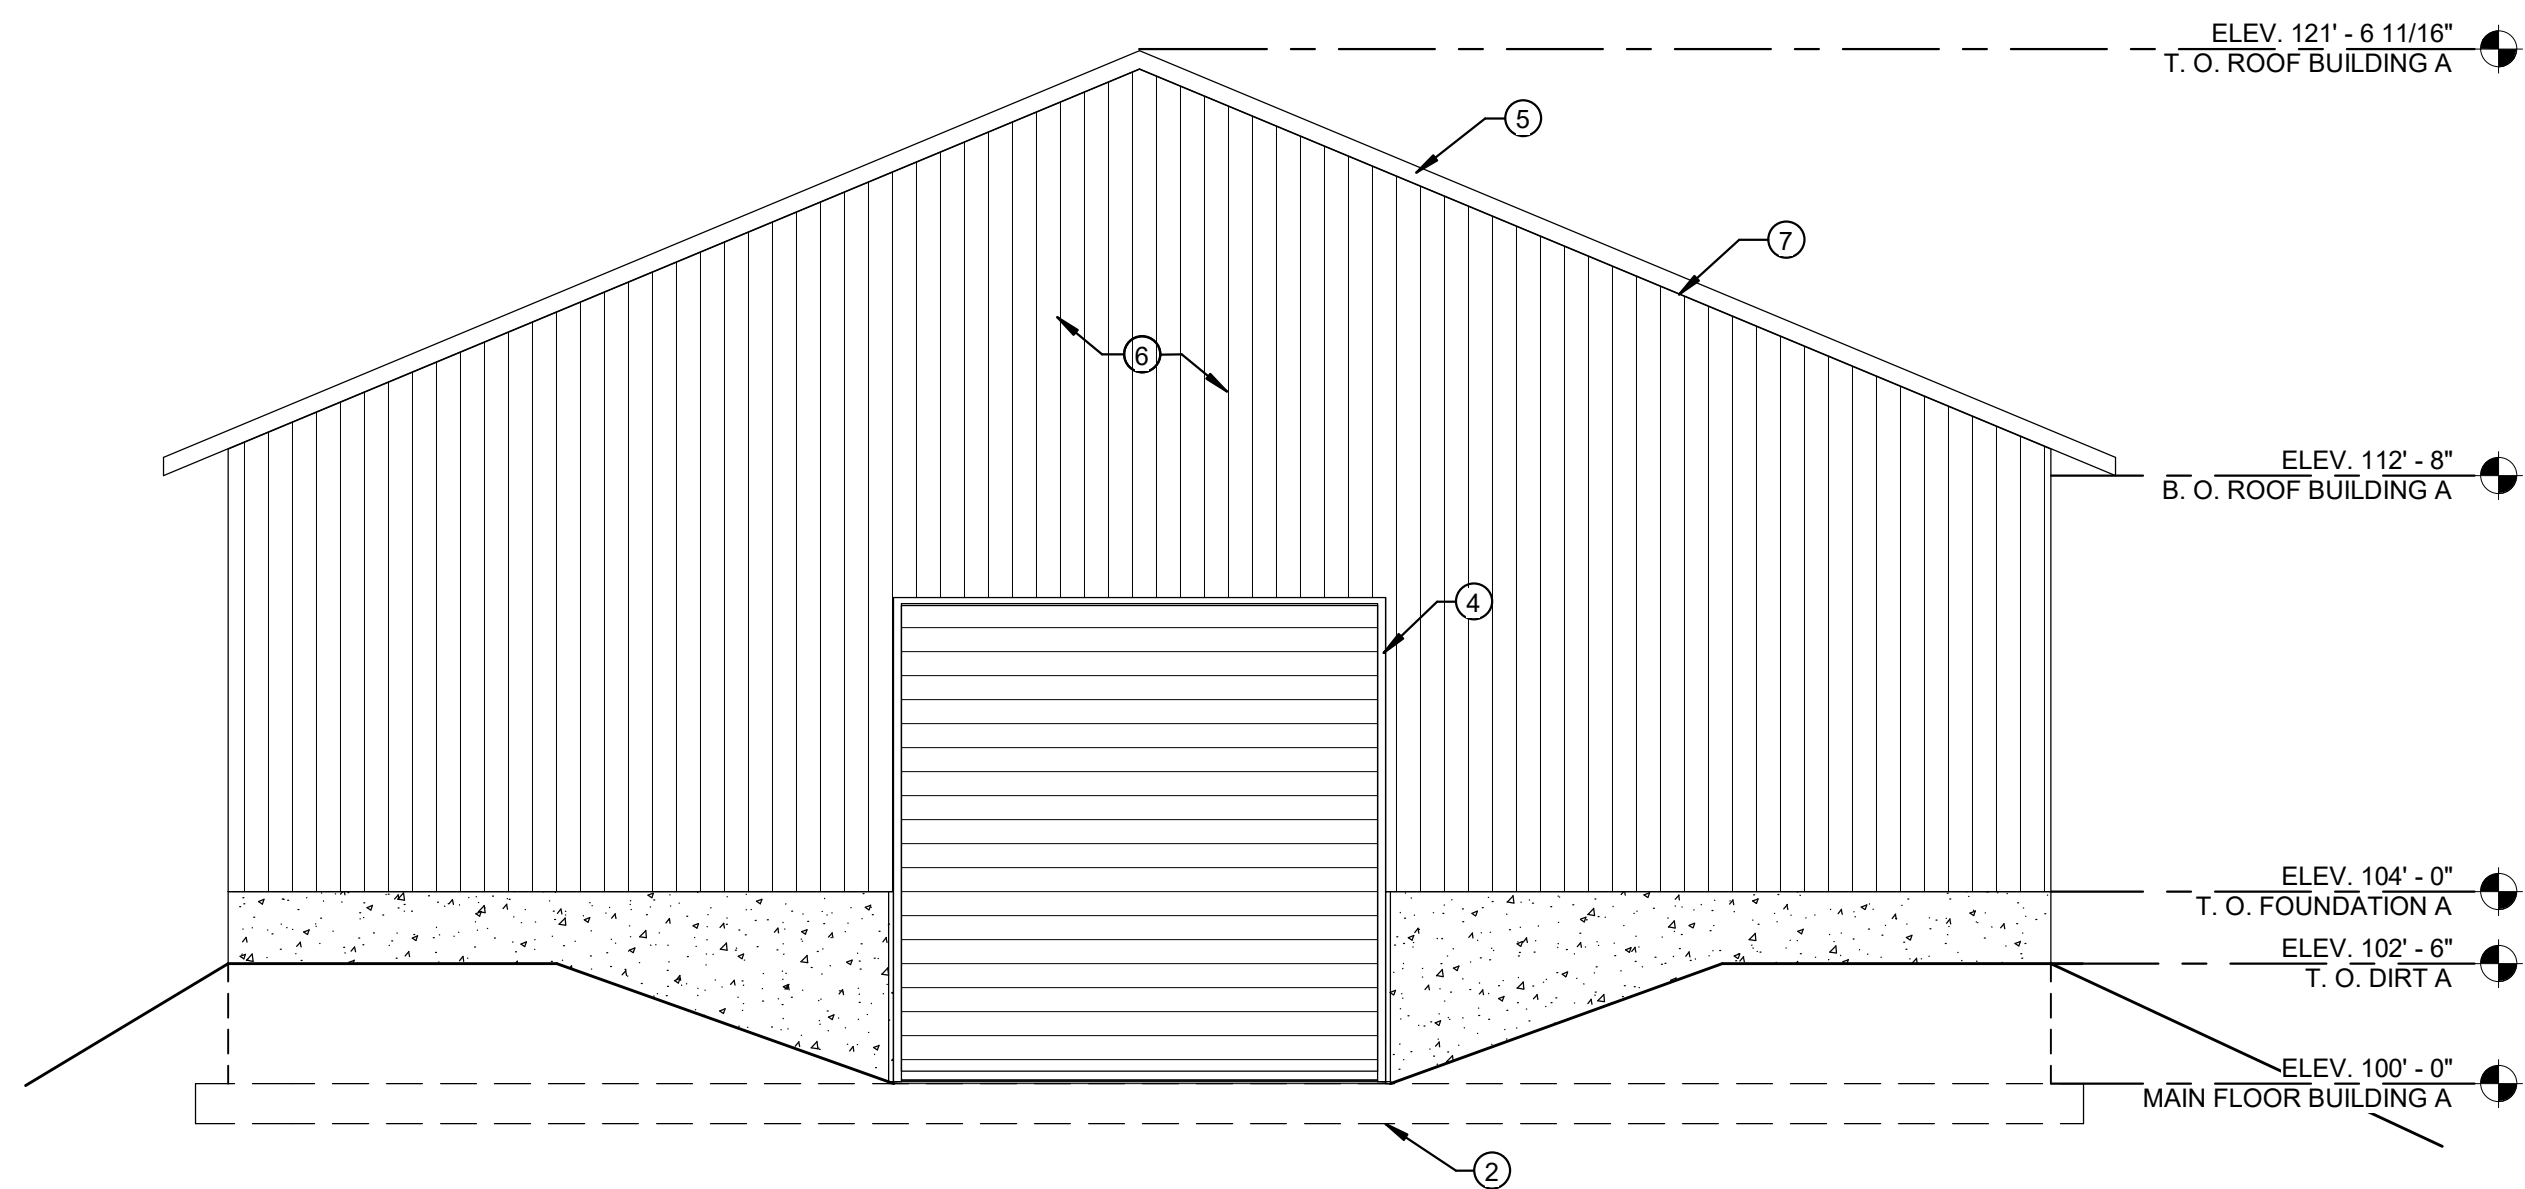


3 BUILDING A SOUTH
1/4" = 1'-0"

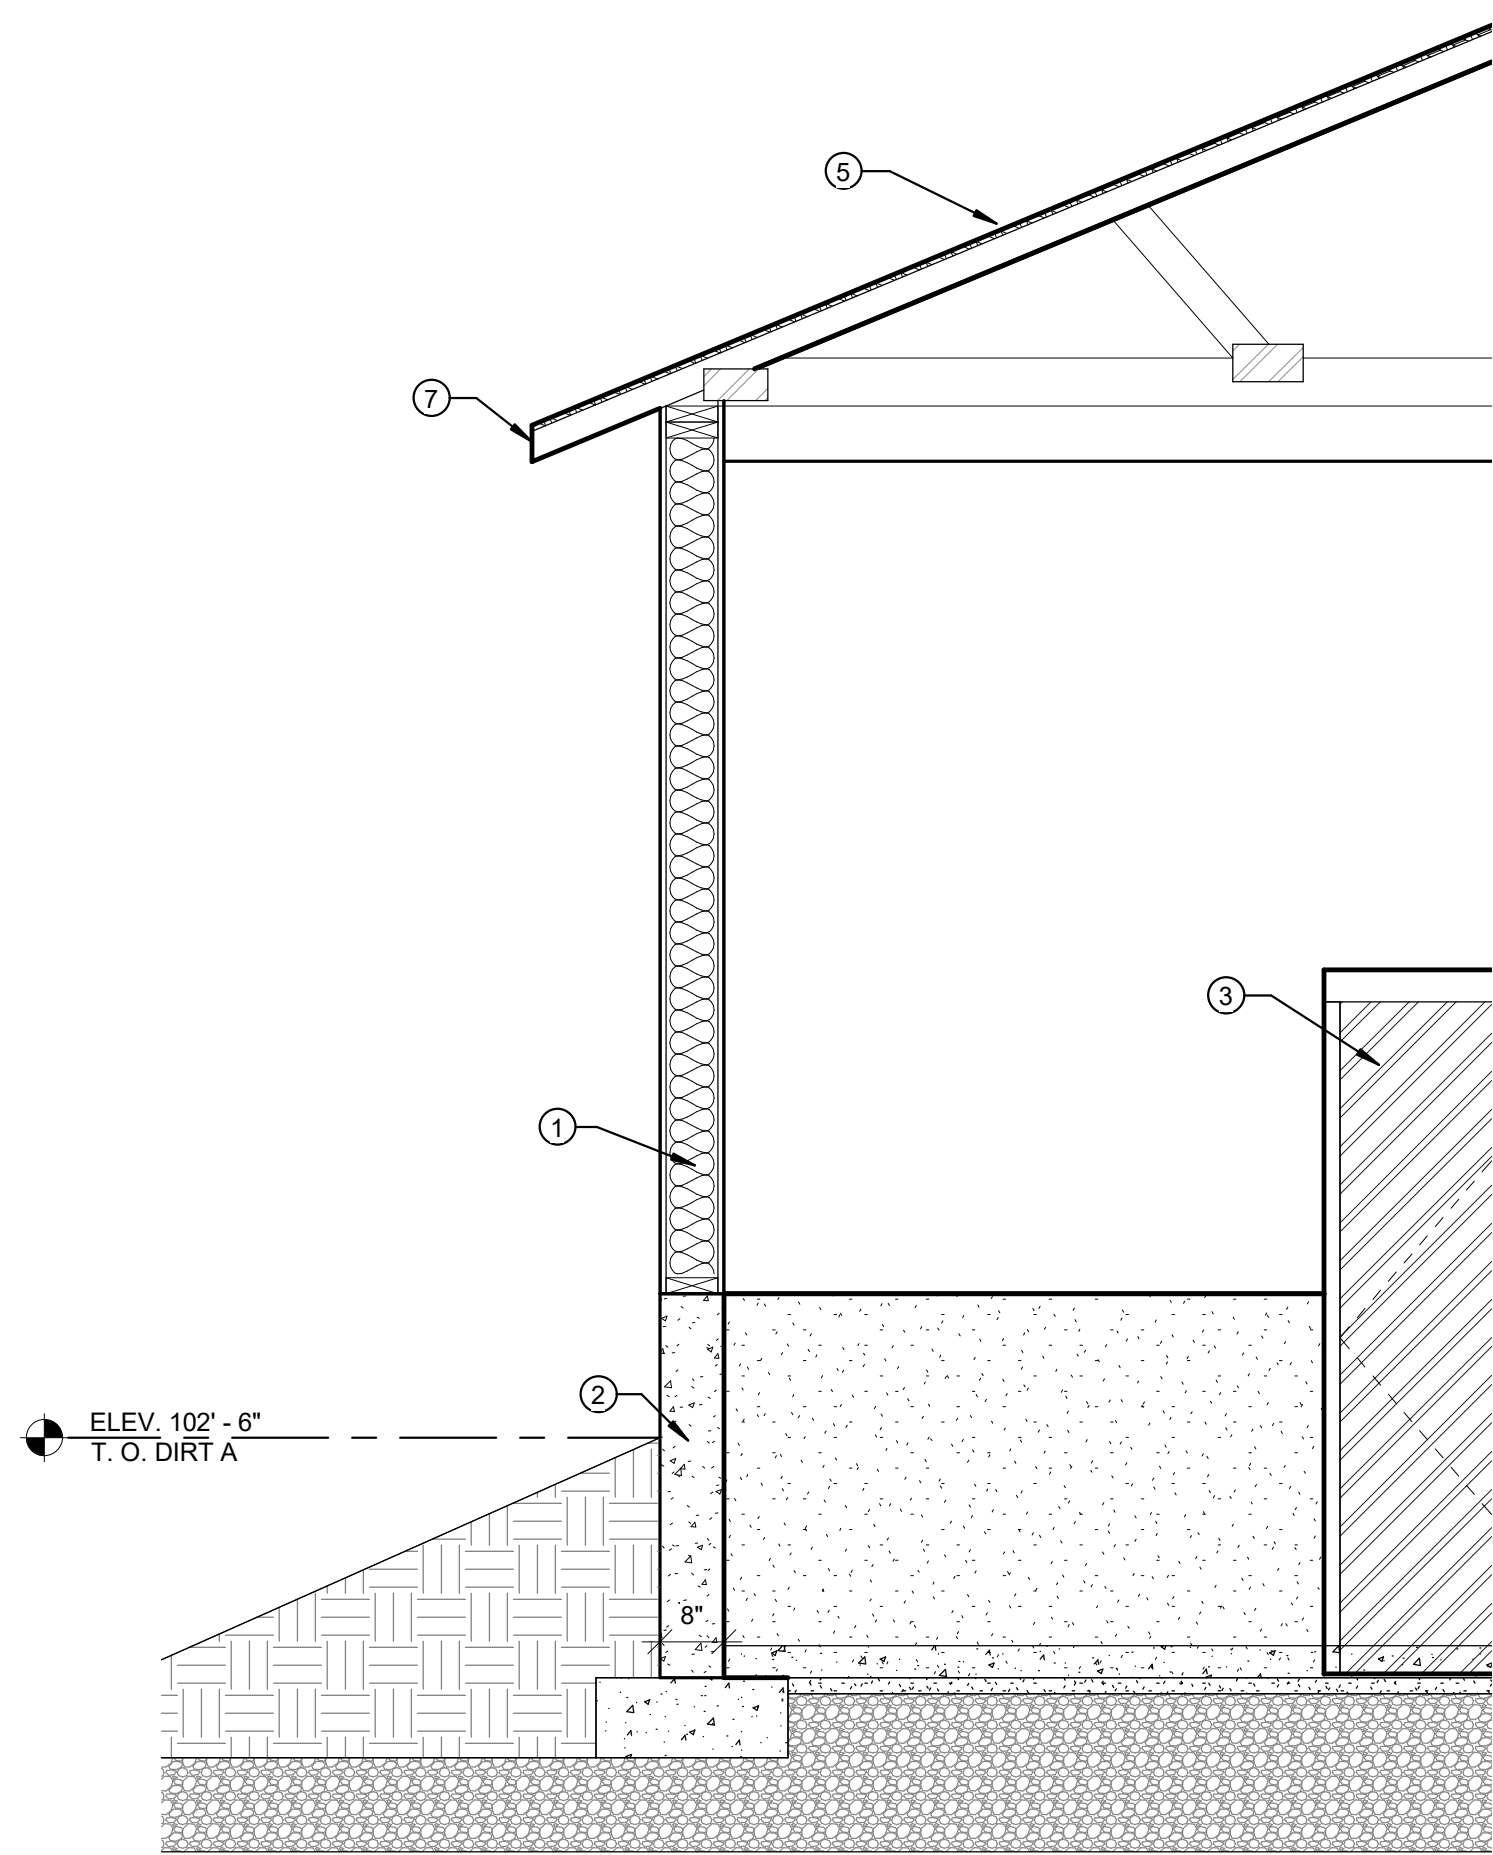

5 BUILDING A
1/2" = 1'-0"

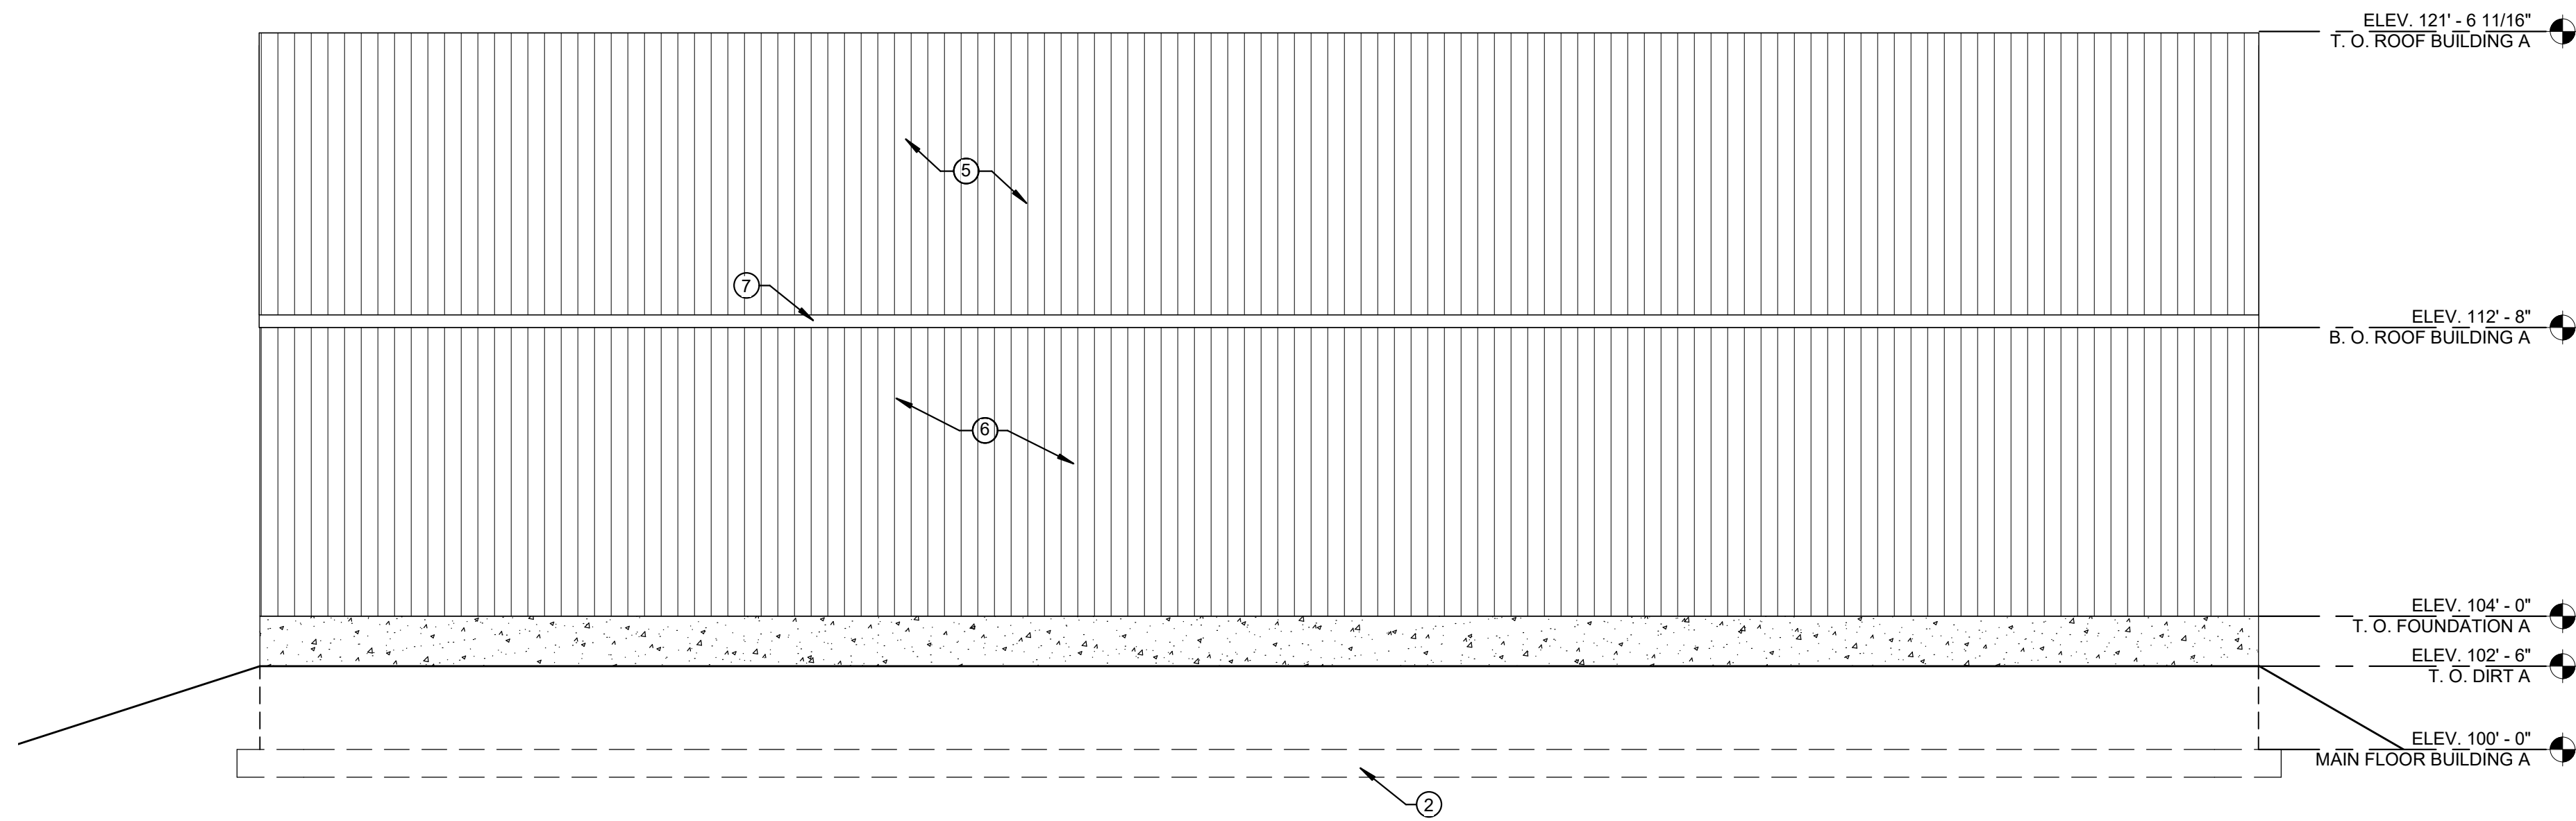

1 BUILDING A EAST
1/4" = 1'-0"

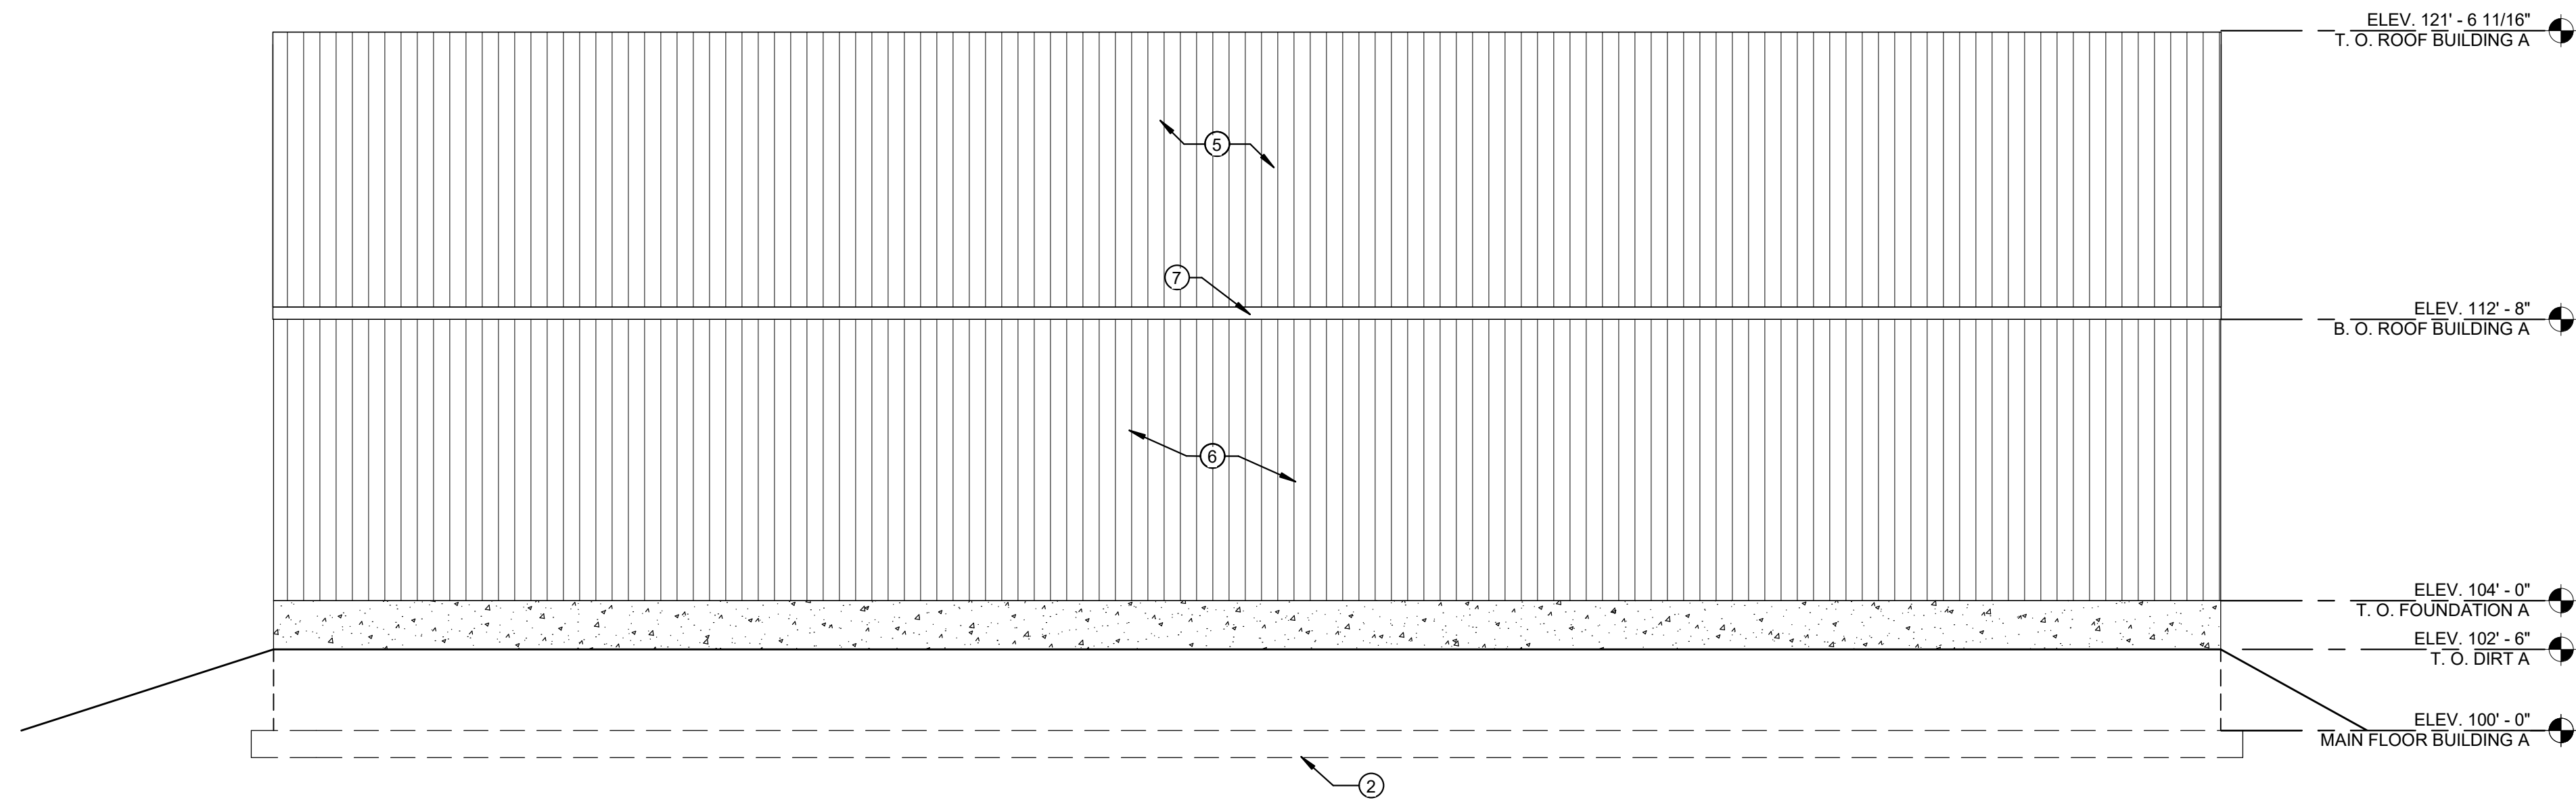

4 BUILDING A WEST
1/4" = 1'-0"

SHEET NOTES

- WOOD FRAME WALLS W/ 5/8" PLYWOOD - SEE STRUCTURAL SHEETS
- CONCRETE FOOTINGS AND FOUNDATION WALLS - SEE STRUCTURAL SHEETS FOR SIZE AND REINFORCING.
- HOLLOW METAL DOOR AND FRAME (PAINTED) - SEE DOOR SCHEDULE. COLOR AS SELECTED BY ARCHITECT.
- 10' ROLL UP DOOR
- METAL ROOF PANELS
- METAL WALL PANELS
- METAL SOFFIT, FASCIA, AND DOWN SPOUT



REVISIONS:

PROJECT TITLE
NEBO SCHOOL DISTRICT
NEBO ANIMAL LABS
1400 E HIGHLINE CANAL RD
SANATQUIN, UTAH


PROJECT TITLE
NEBO SCHOOL DISTRICT
NEBO ANIMAL LABS
1400 E HIGHLINE CANAL RD
SANATQUIN, UTAH

DRAWN BY: Author
CHECKED BY: Checker
DATE: FEB 2023
PROJECT #: 171022


A3.1A

170 NORTH MAIN STREET
SPRINGFIELD, UT 84660
WWW.KMAARCHITECTS.COM


KMA
ARCHITECTS

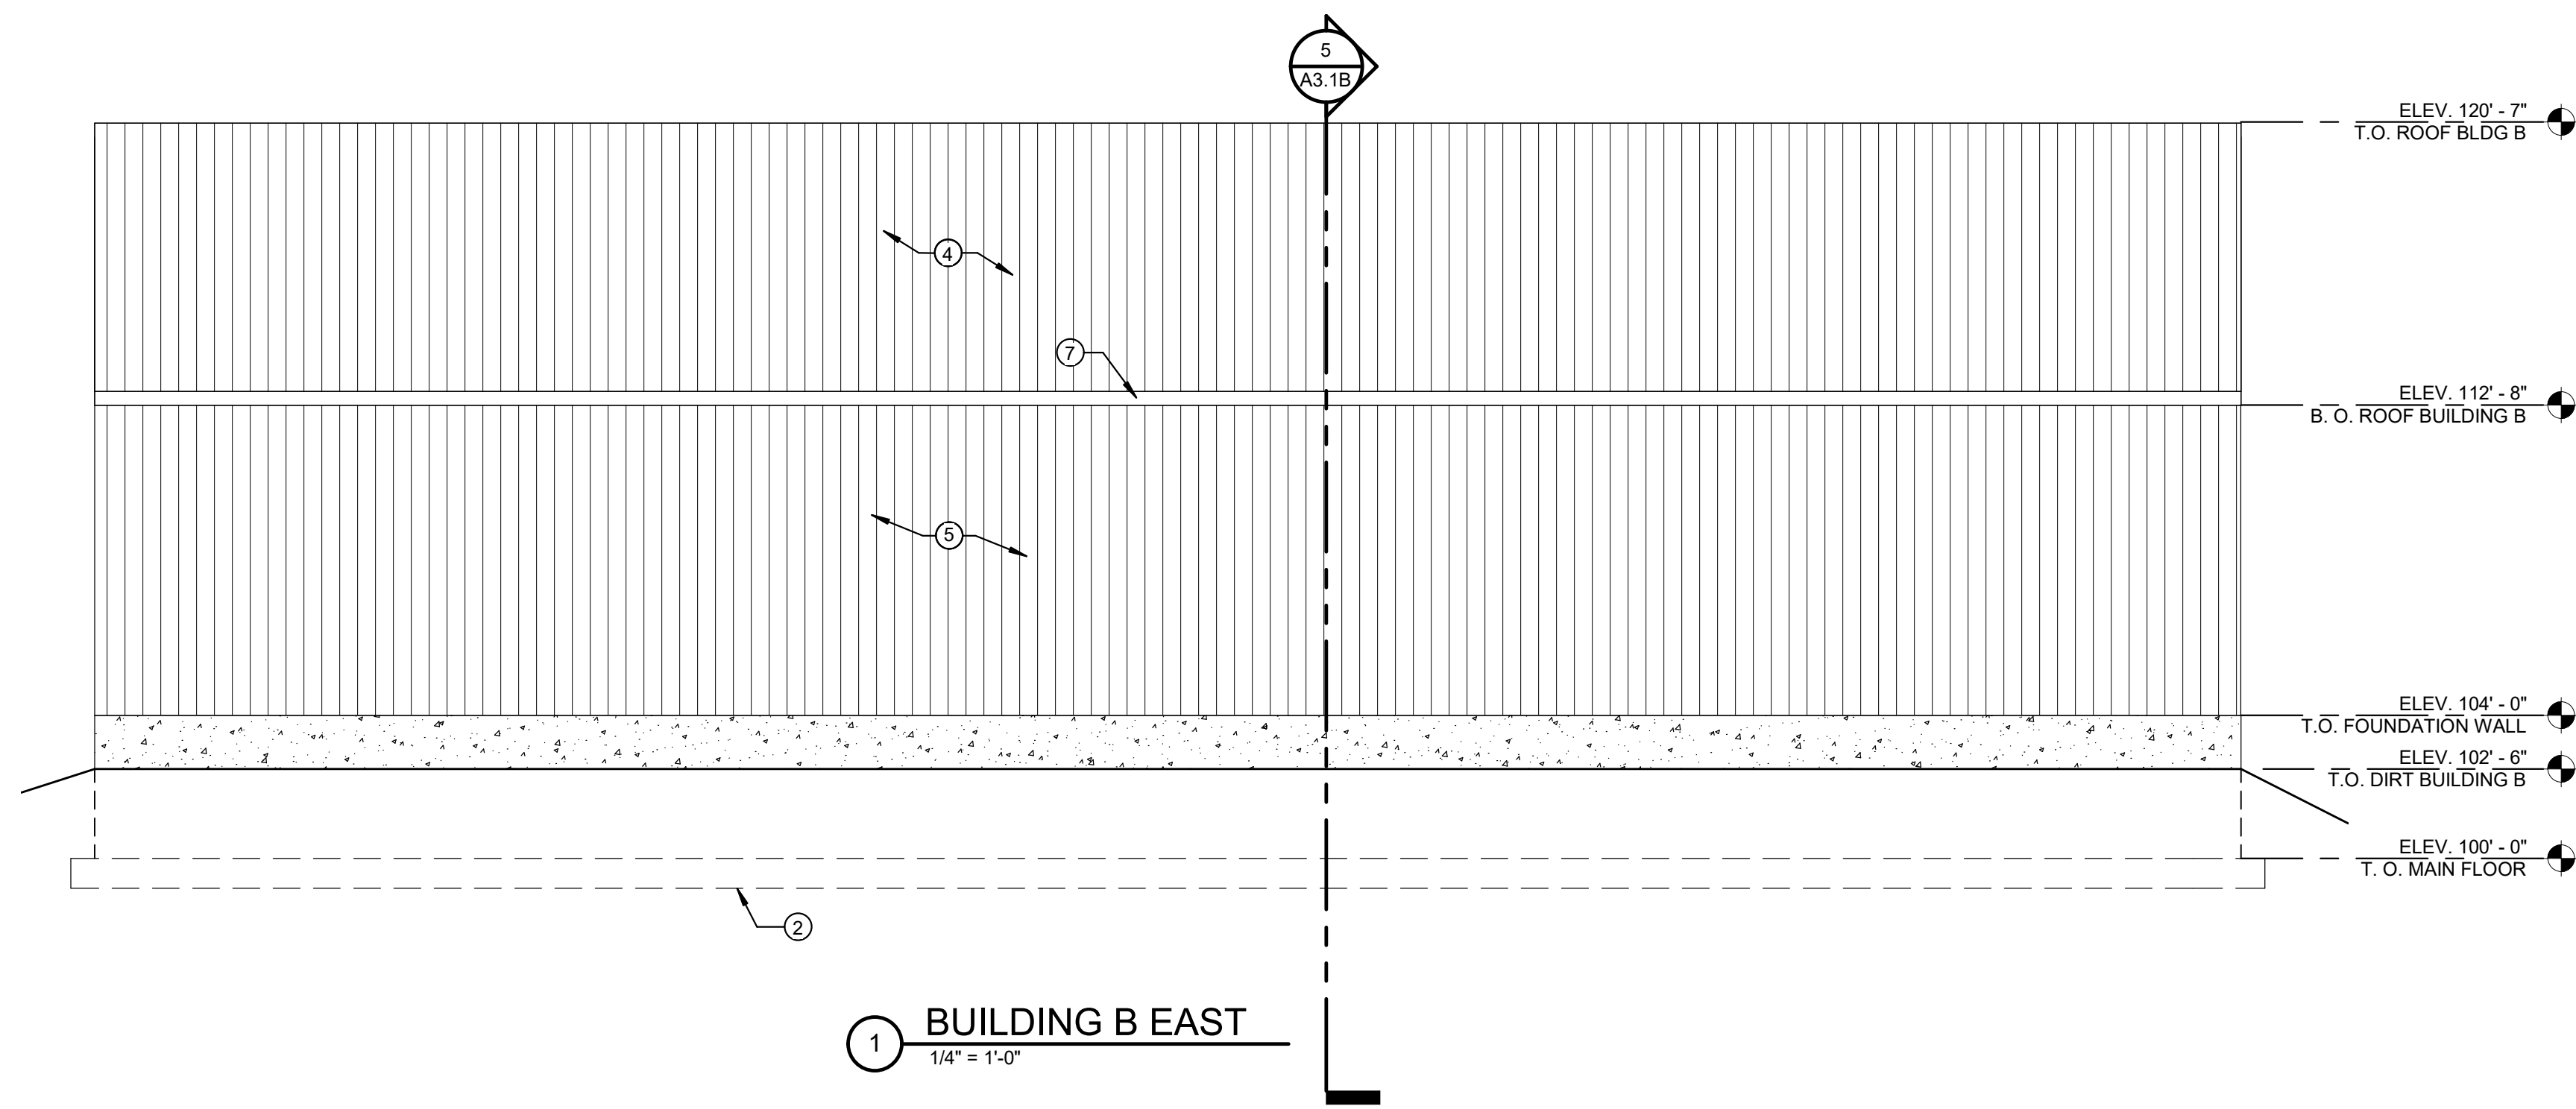


1 BUILDING B EAST
1/4" = 1'-0"

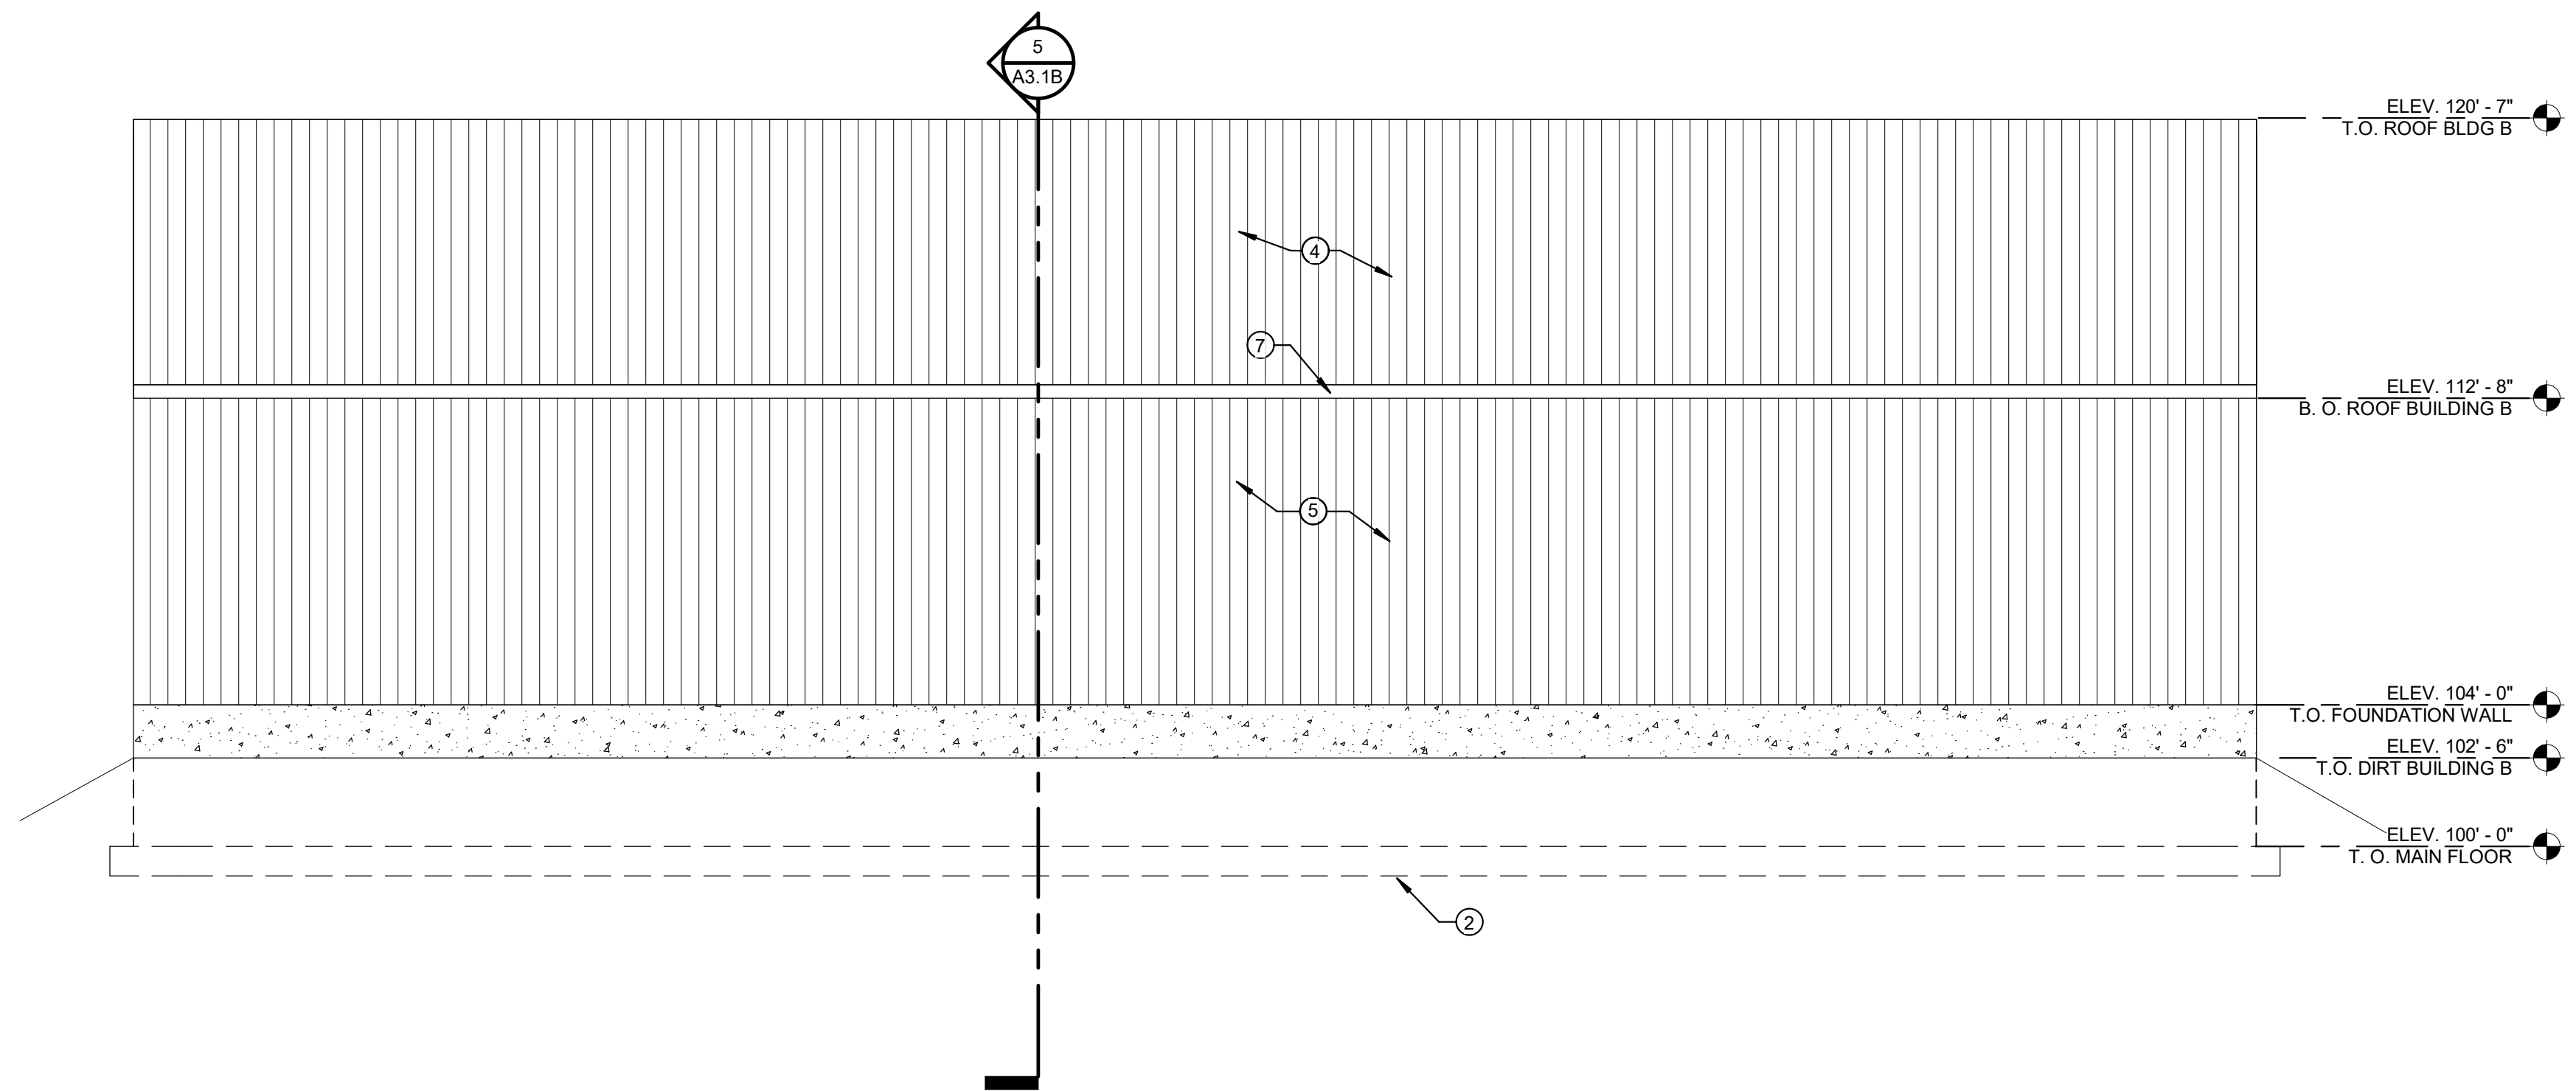


4 BUILDING B WEST
1/4" = 1'-0"

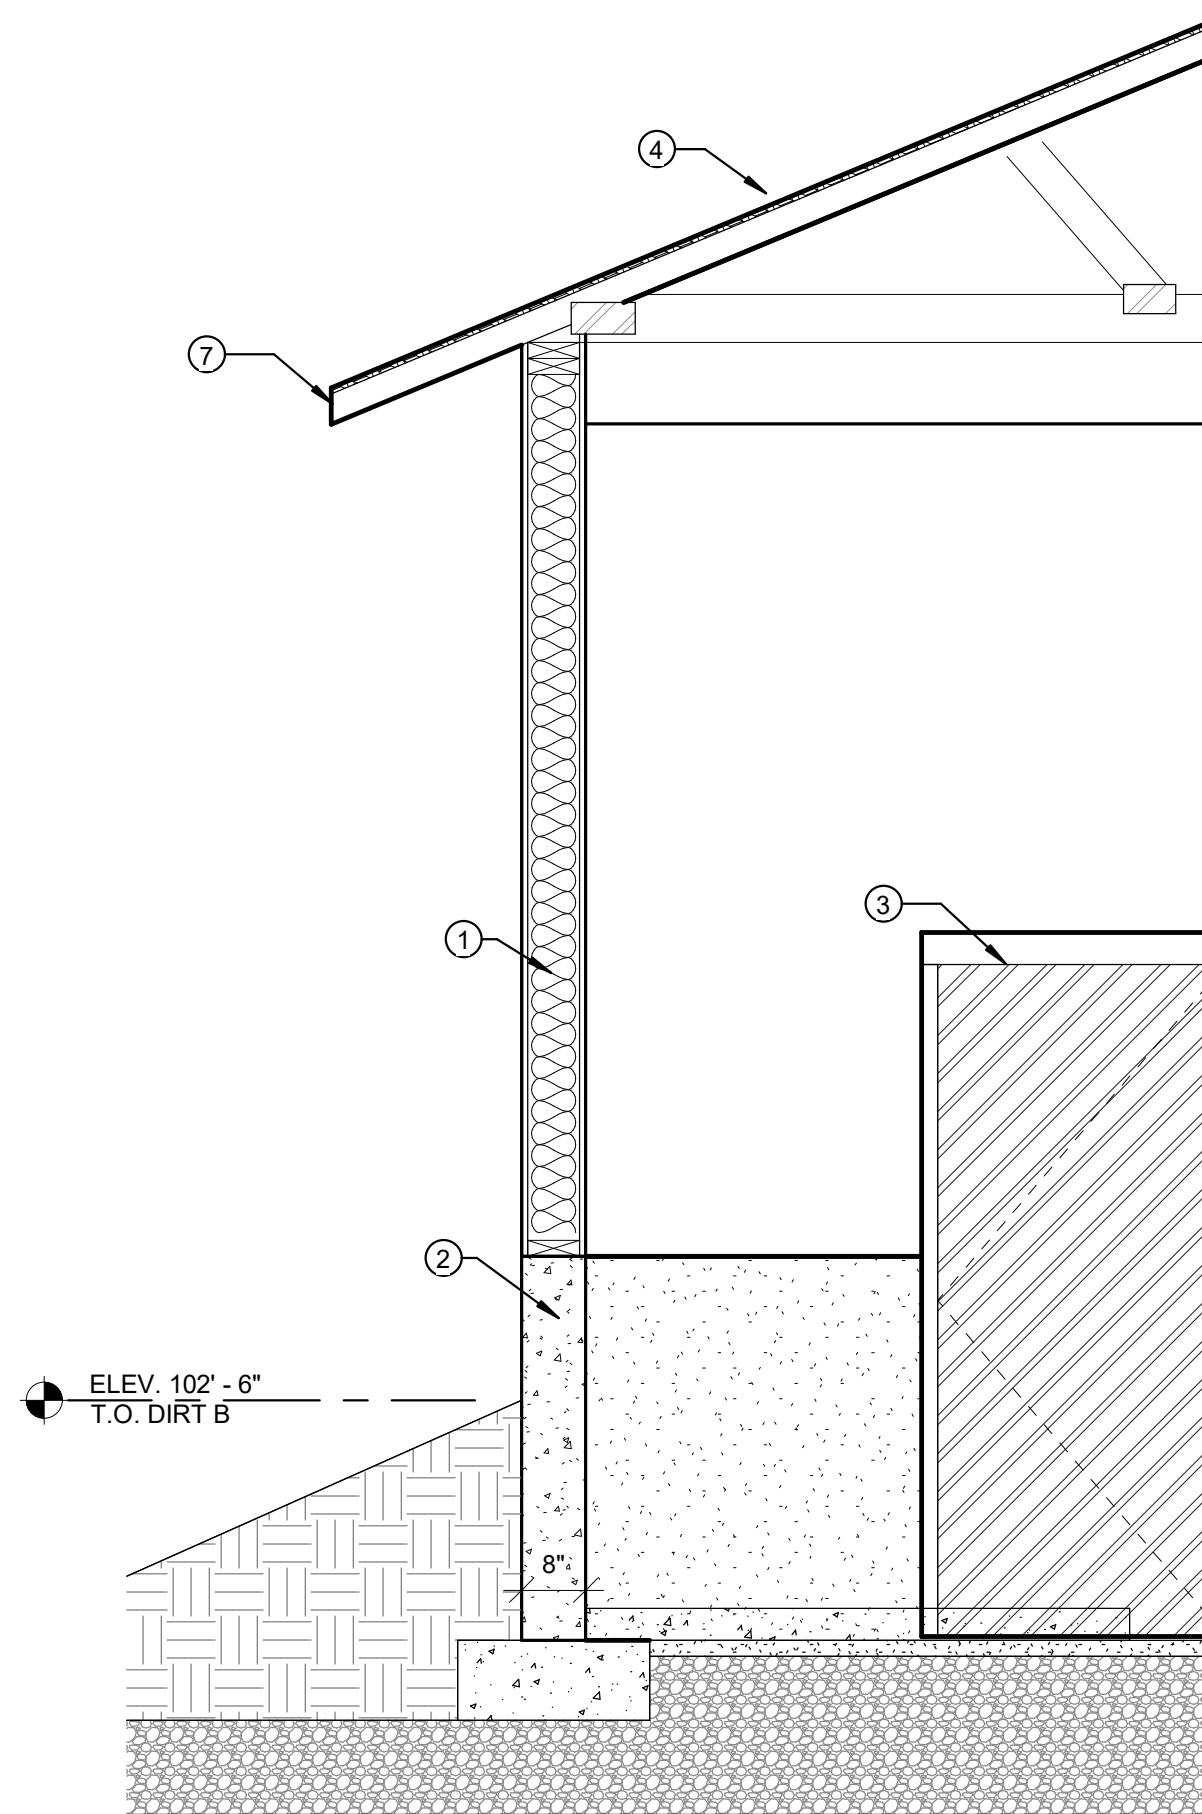

5 BUILDING B
1/2" = 1'-0"

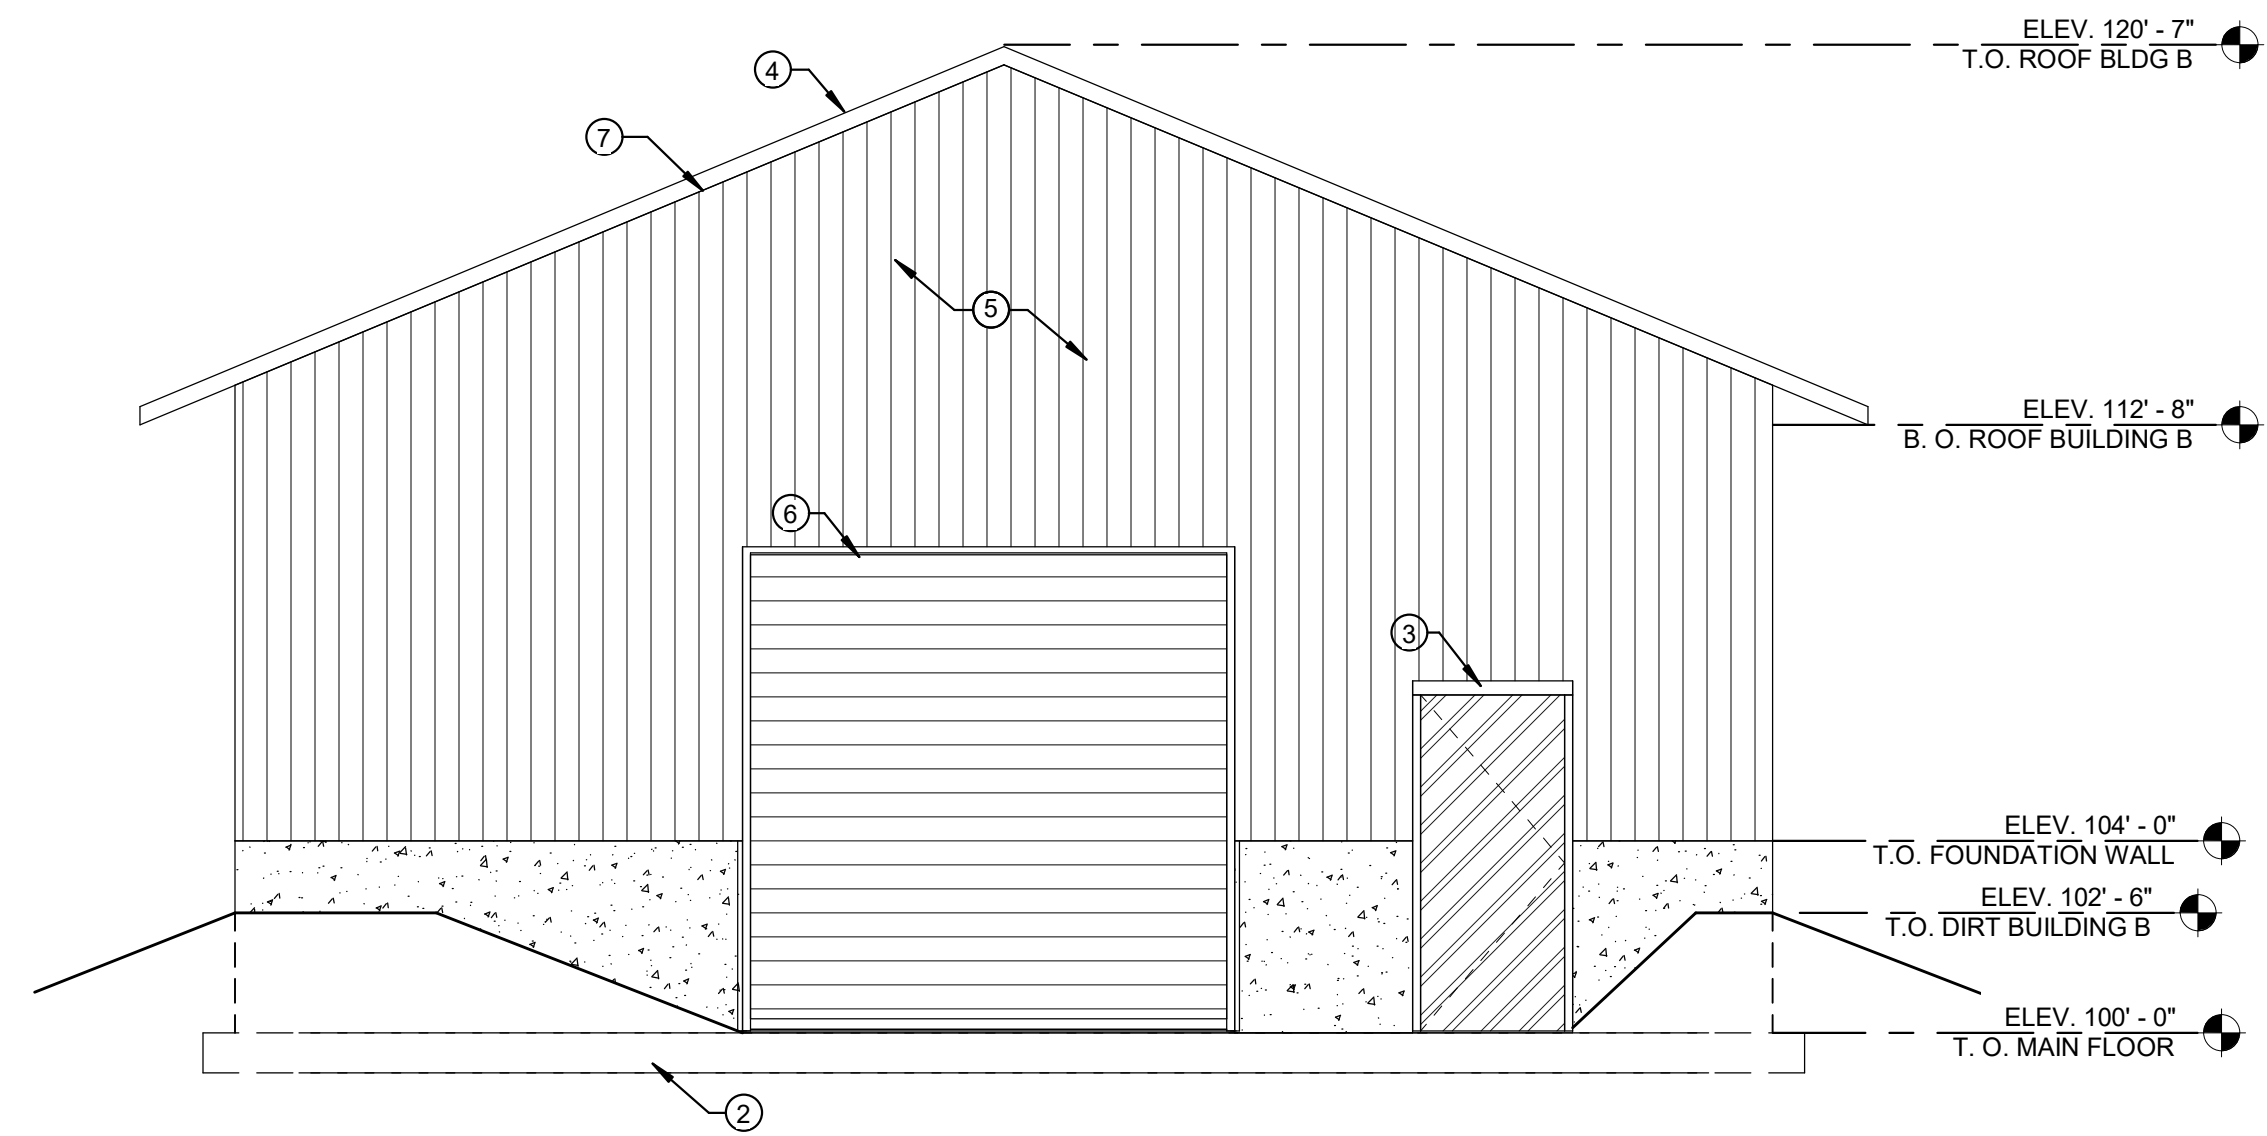

2 BUILDING B NORTH
1/4" = 1'-0"

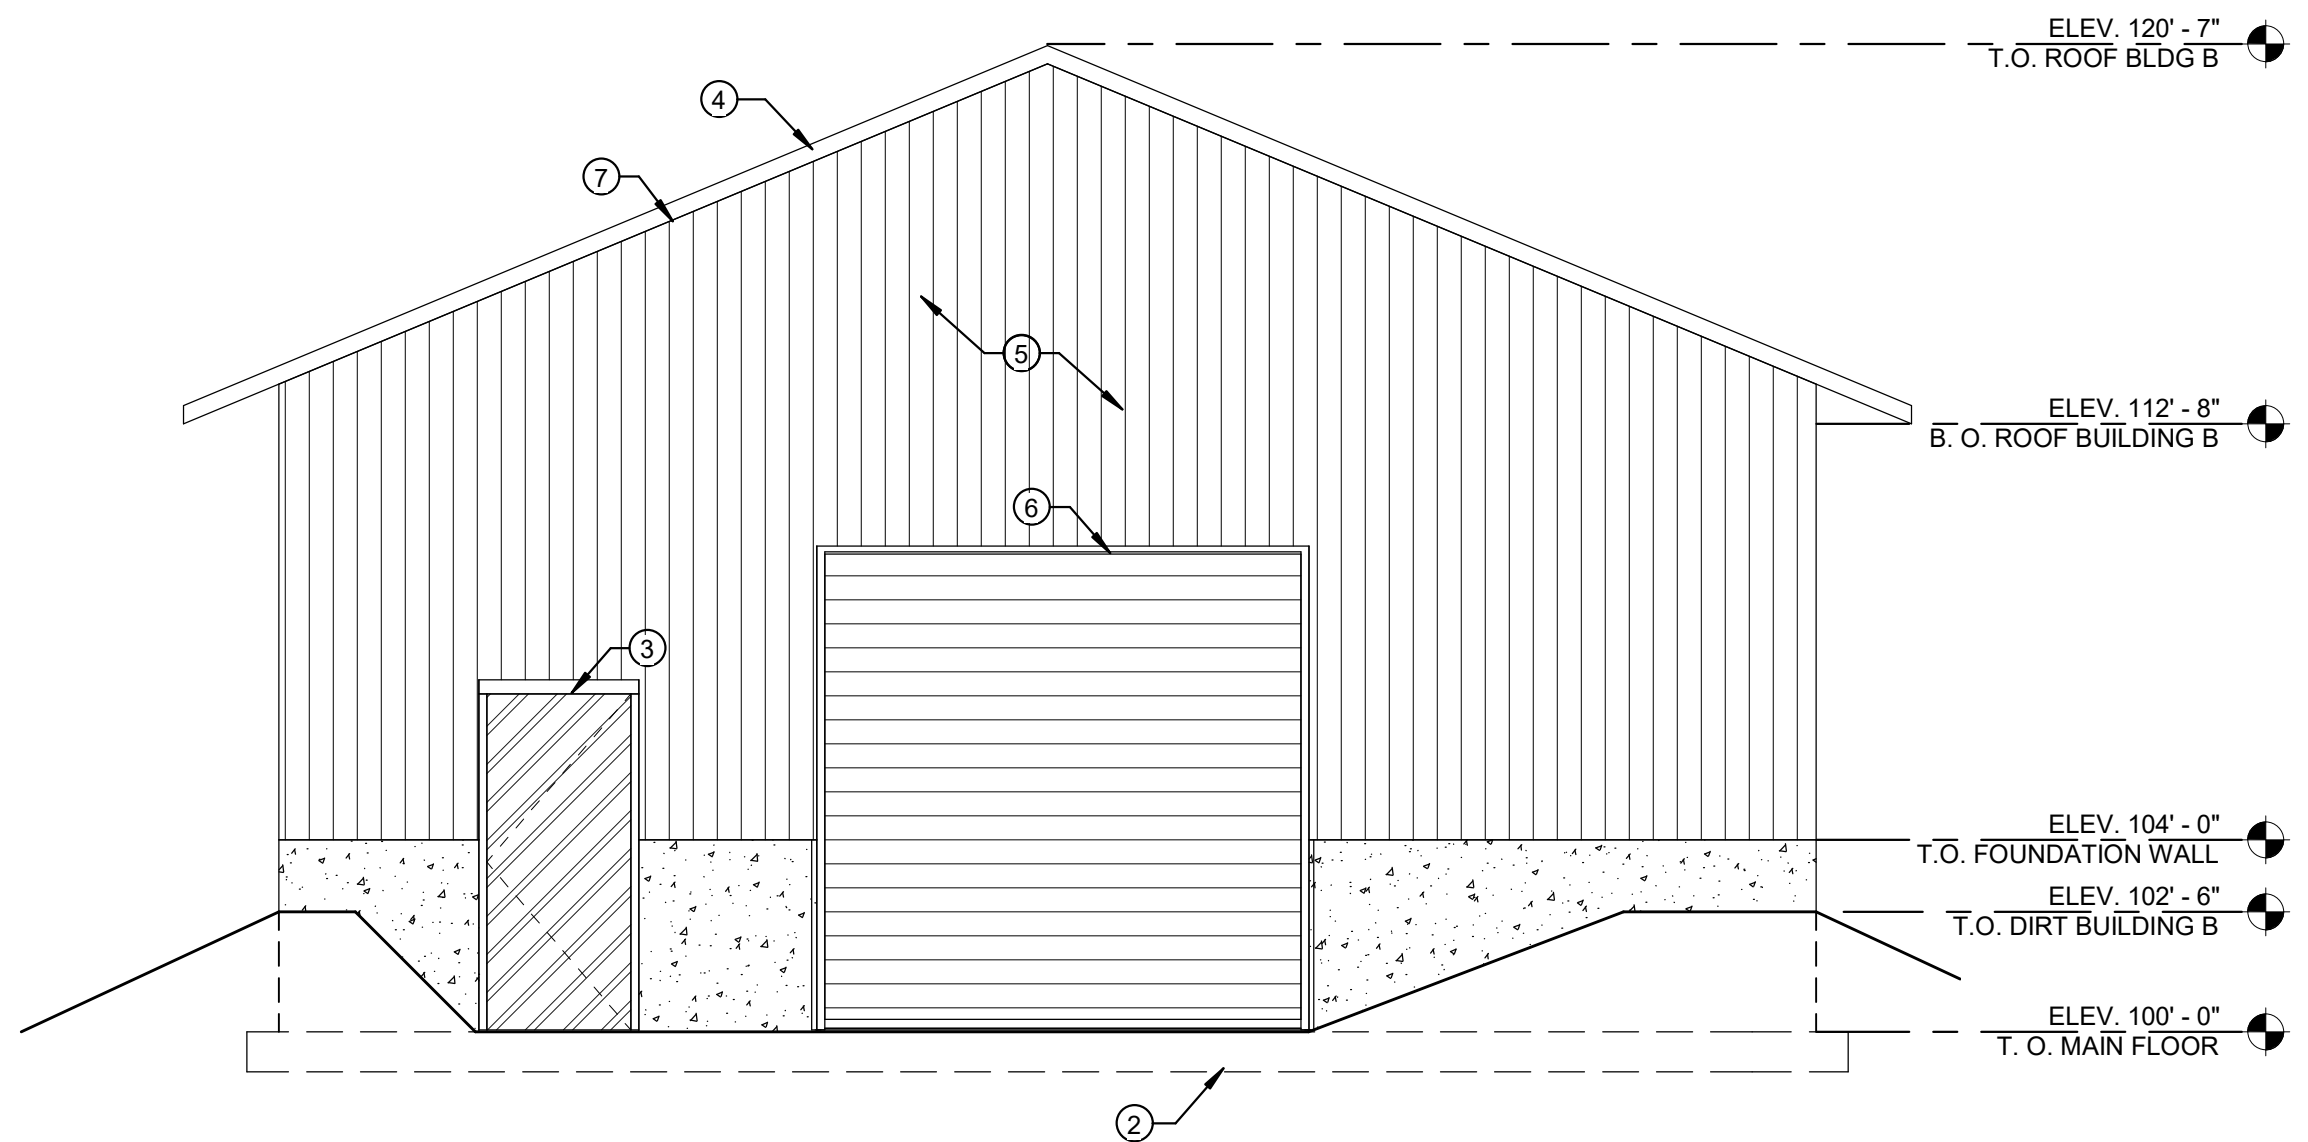

3 BUILDING B SOUTH
1/4" = 1'-0"

SHEET NOTES

- WOOD FRAME WALLS W/ 5/8" PLYWOOD - SEE STRUCTURAL SHEETS
- CONCRETE FOOTINGS AND FOUNDATION WALLS - SEE STRUCTURAL SHEETS FOR SIZE AND REINFORCING.
- HOLLOW METAL DOOR AND FRAME (PAINTED) - SEE DOOR SCHEDULE. COLOR AS SELECTED BY ARCHITECT.
- METAL ROOF PANELS
- METAL WALL PANELS
- 10' ROLL UP DOOR
- METAL SOFFIT, FASCIA, AND DOWN SPOUT



REVISIONS:

PROJECT TITLE
NEBO SCHOOL DISTRICT
NEBO ANIMAL LABS
1400 E HIGHLINE CANAL RD
SANATQUIN, UTAH

PROJECT TITLE
NEBO SCHOOL DISTRICT
NEBO ANIMAL LABS
1400 E HIGHLINE CANAL RD
SANATQUIN, UTAH

DRAWN BY: Author
CHECKED BY: Checker
DATE: FEB 2023
PROJECT #: 171022


A3.1B

170 NORTH MAIN STREET
SPRINGFIELD, UT 84660
WWW.KMAARCHITECTS.COM


KMA
ARCHITECTS

THIS PRINT AND ALL INFORMATION HEREON IS THE PROPERTY OF KMA ARCHITECTS AND SHALL NOT BE USED ON ANY OTHER JOB WITHOUT WRITTEN PERMISSION OF THE ARCHITECT


2/23/2023 4:27:20 PM
As Noted

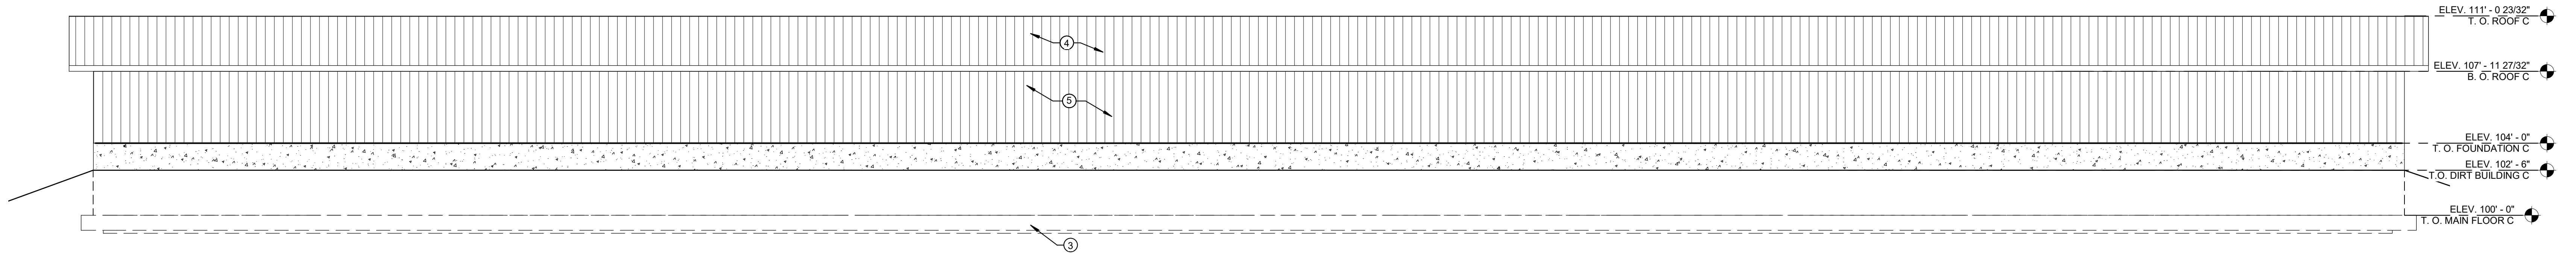


1 BUILDING C NORTH
1/4" = 1'-0"

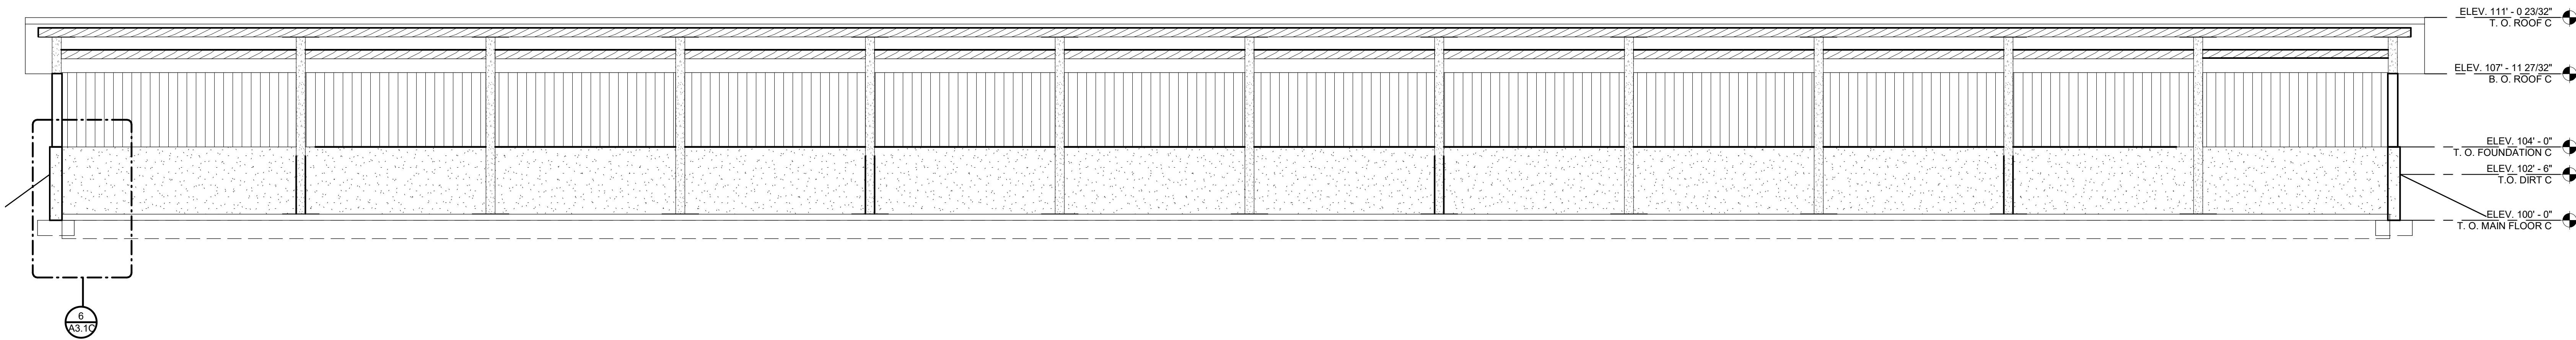


3 BUILDING C SOUTH
1/4" = 1'-0"

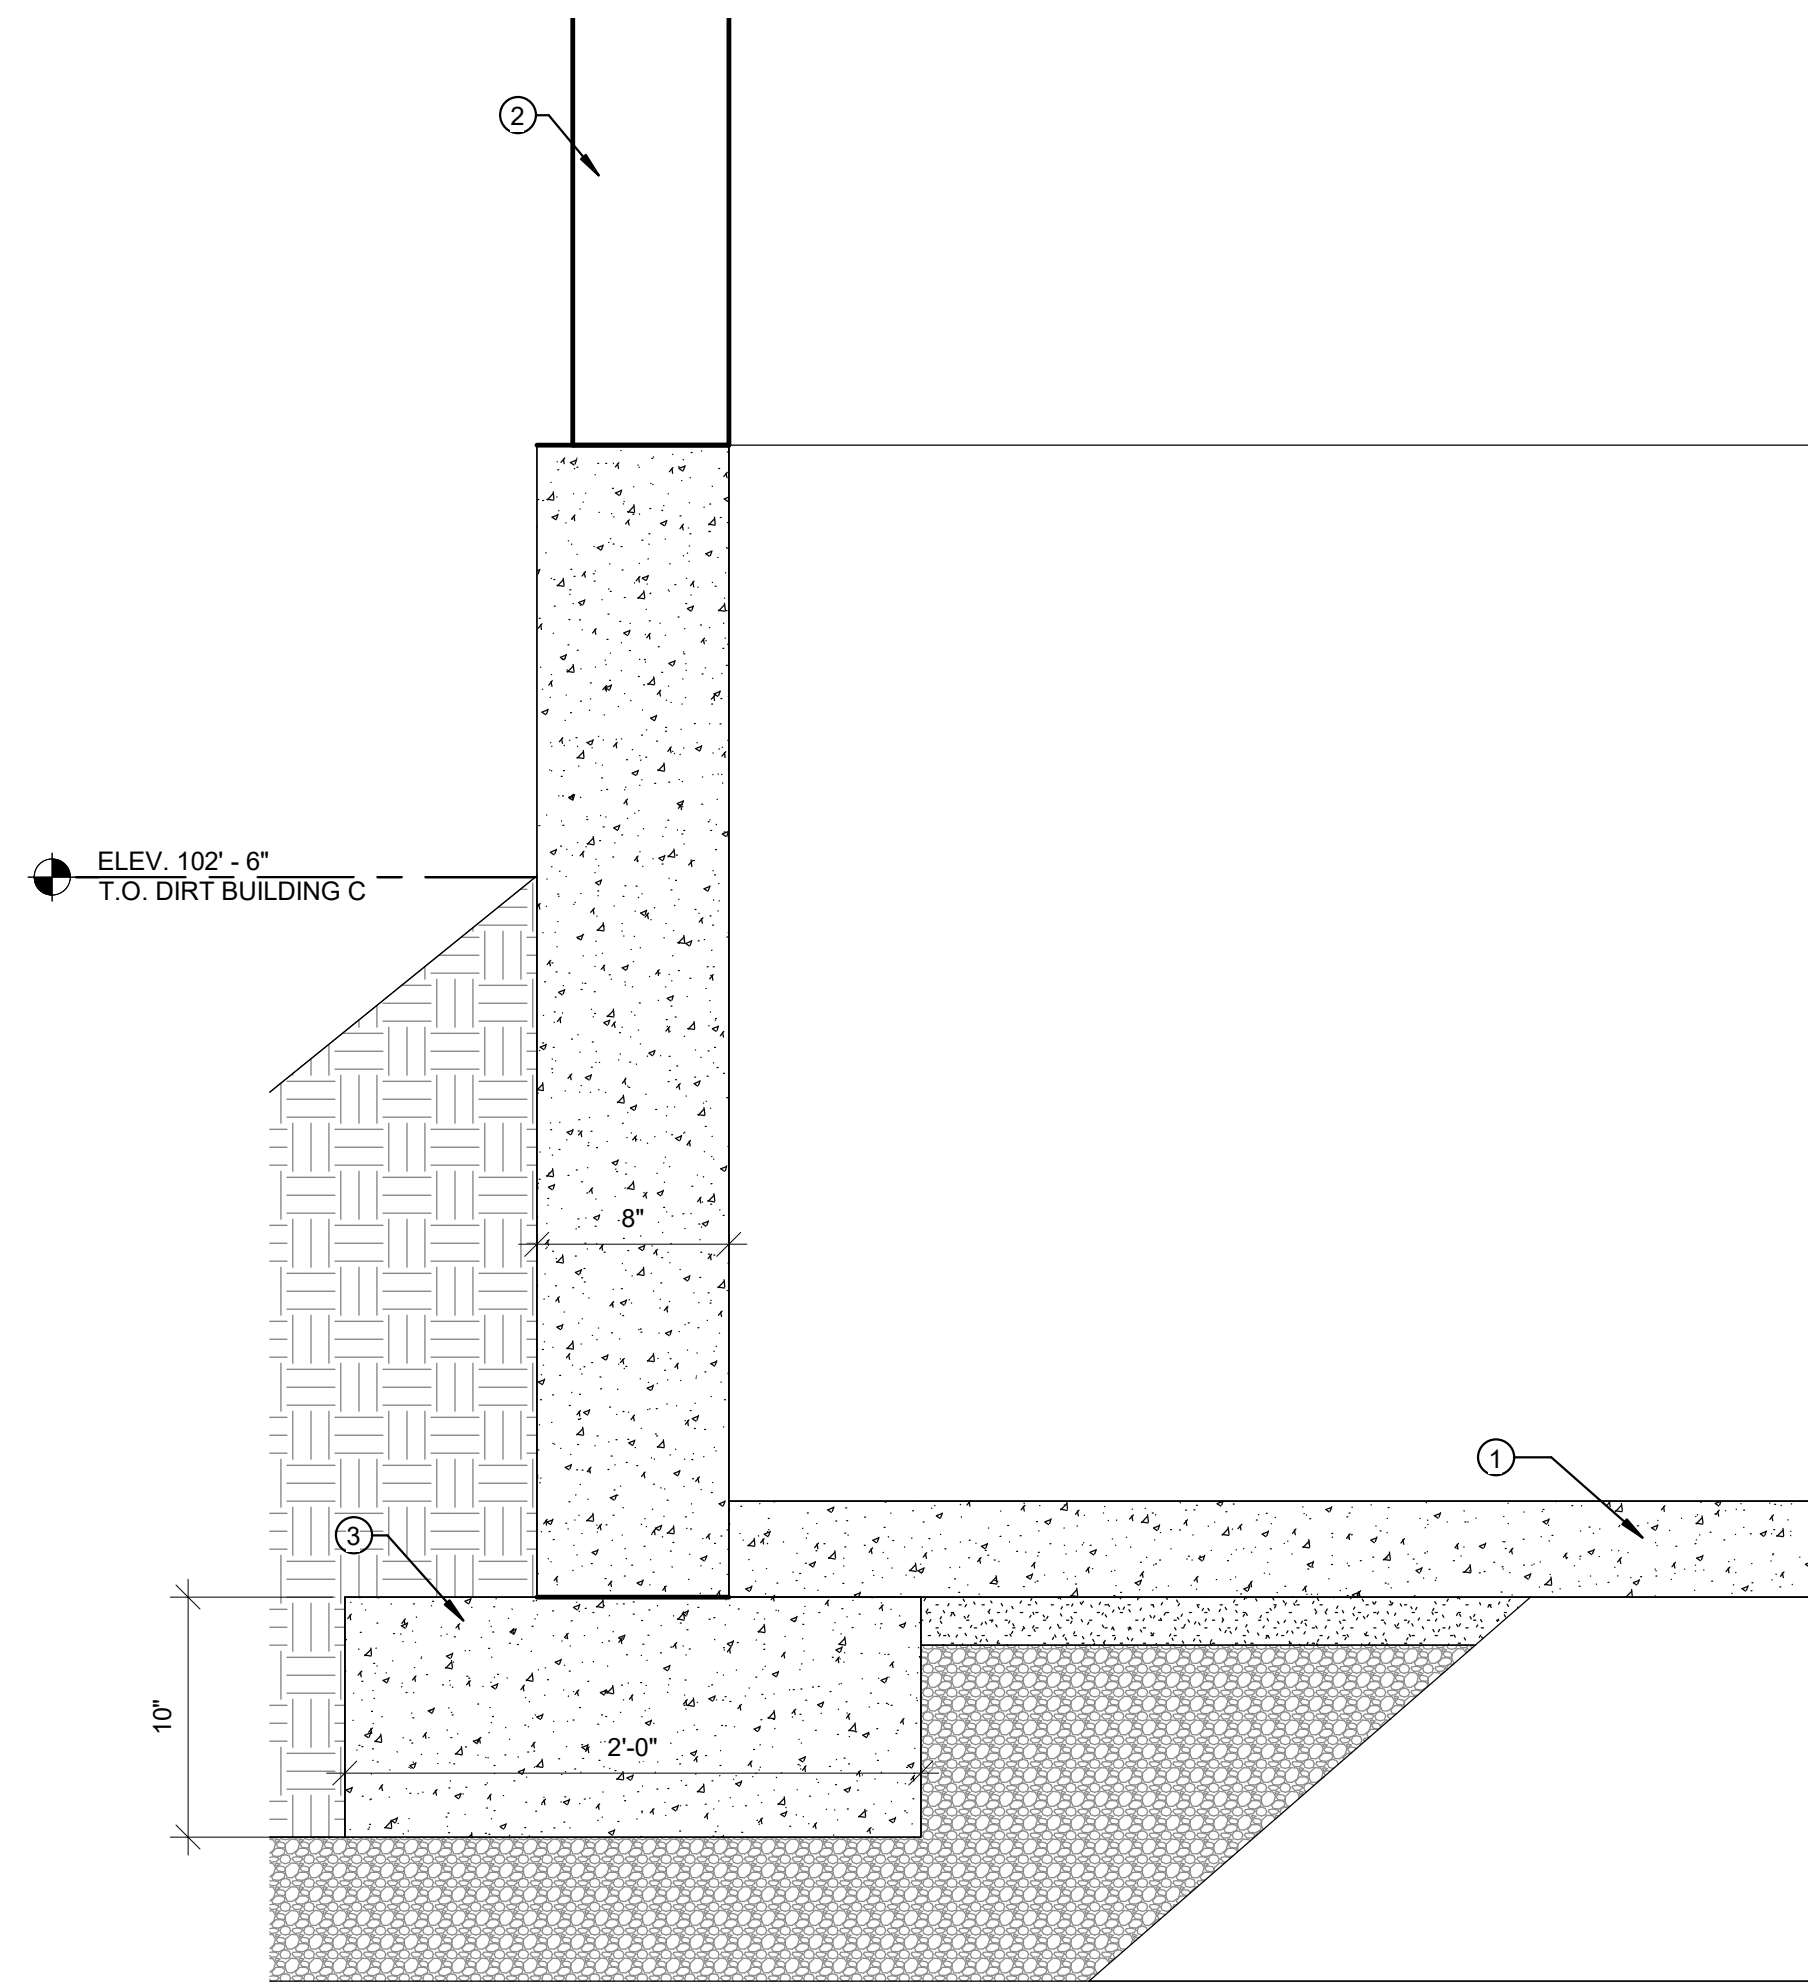

6 FOUNDATION DETAIL
1 1/2" = 1'-0"

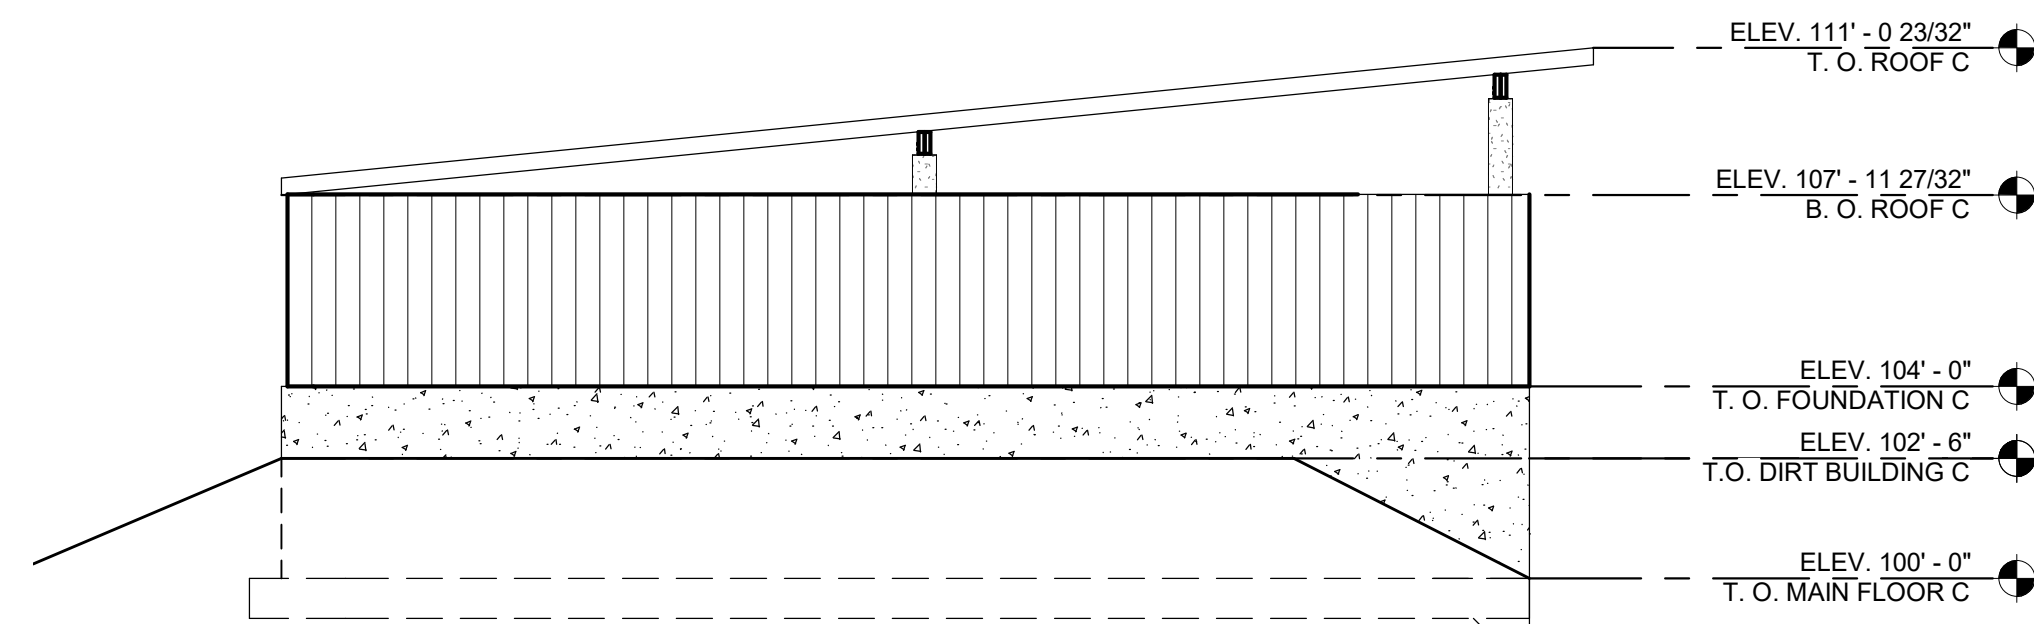


4 BUILDING C WEST
1/4" = 1'-0"

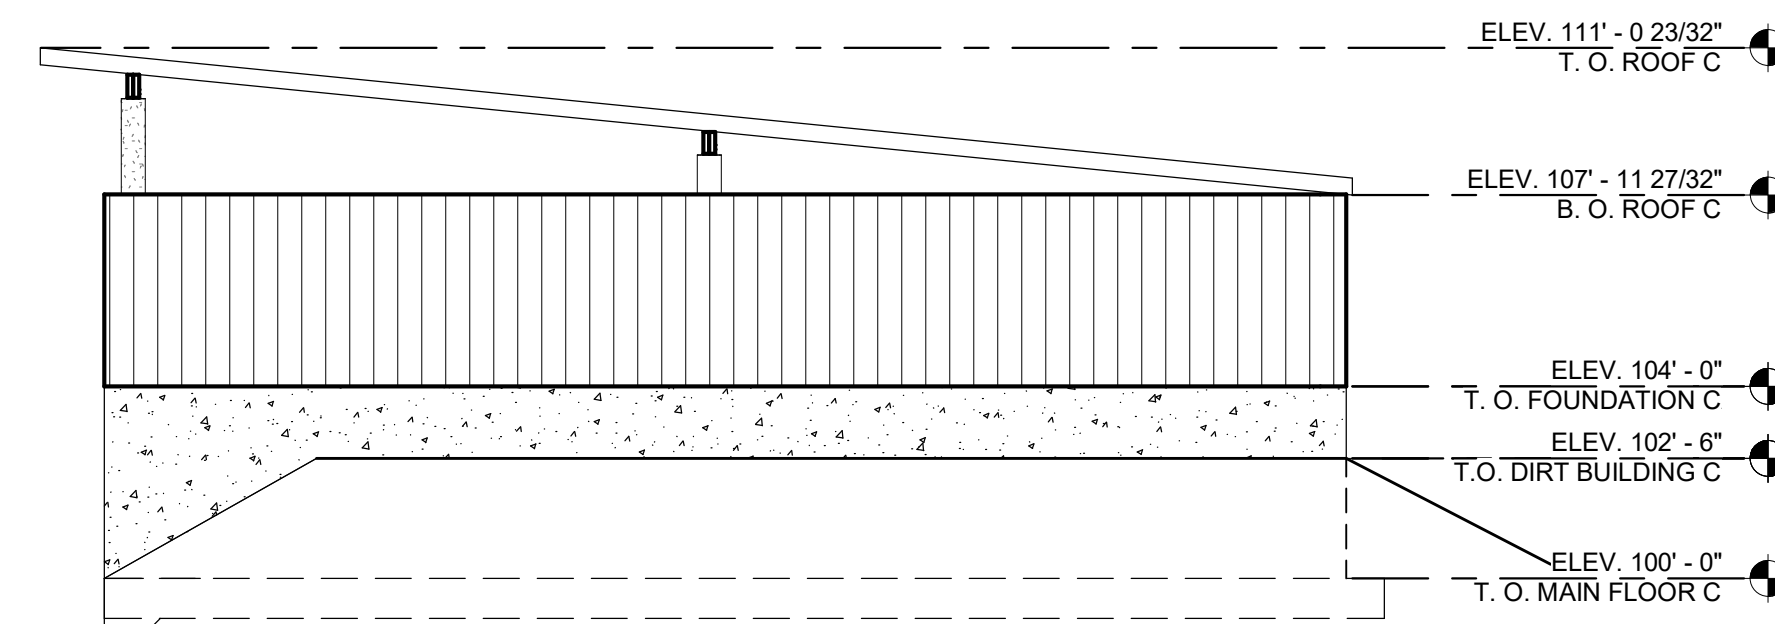

2 BUILDING C EAST
1/4" = 1'-0"

SHEET NOTES

- 1 - 4" CONCRETE SLAB OVER 6" FREE DRAINING GRAVEL - REINFORCED AS PER STRUCTURAL SHEETS. ROUGH PLUMBING TO BE TRENCHED INTO THE SUBSTRATE BELOW GRAVEL.
- 2 - WOOD FRAME WALLS W/ 5/8" PLYWOOD - SEE STRUCTURAL SHEETS
- 3 - CONCRETE FOOTINGS AND FOUNDATION WALLS - SEE STRUCTURAL SHEETS FOR SIZE AND REINFORCING.
- 4 - METAL ROOF PANELS
- 5 - METAL WALL PANELS

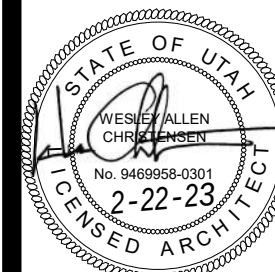

REVISIONS:

PROJECT TITLE
NEBO SCHOOL DISTRICT
NEBO ANIMAL LABS
1400 E HIGHLINE CANAL RD
SANATQUIN, UTAH

DRAWN BY: Author
CHECKED BY: Checker
DATE: FEB 2023
PROJECT #: 171022


A3.1C

170 NORTH MAIN STREET
SPRINGFIELD, UTAH 84660
WWW.KMAARCHITECTS.COM




THIS PRINT AND ALL INFORMATION HEREON IS THE PROPERTY OF KMA ARCHITECTS AND SHALL NOT BE USED ON ANY OTHER JOB WITHOUT WRITTEN PERMISSION OF THE ARCHITECT


2/23/2023 4:27:20 PM
1/4" = 1'-0"

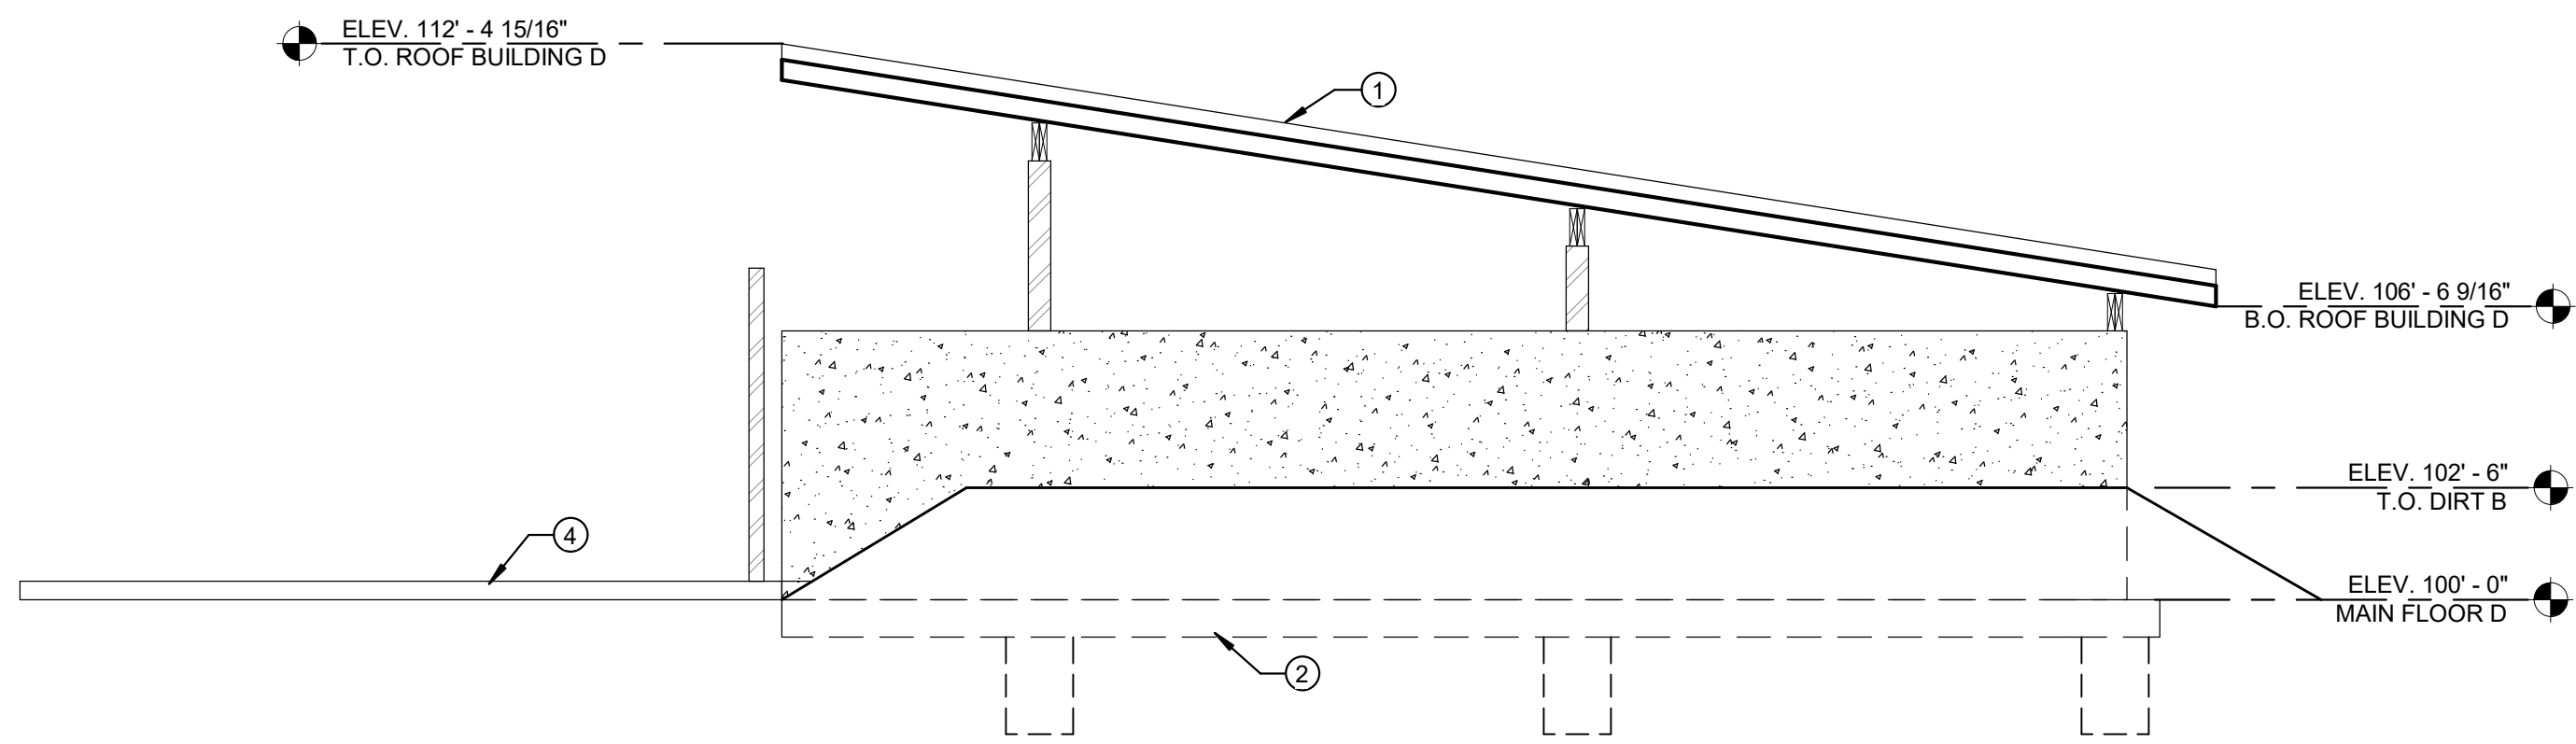


1 BUILDING D EAST
1/4" = 1'-0"

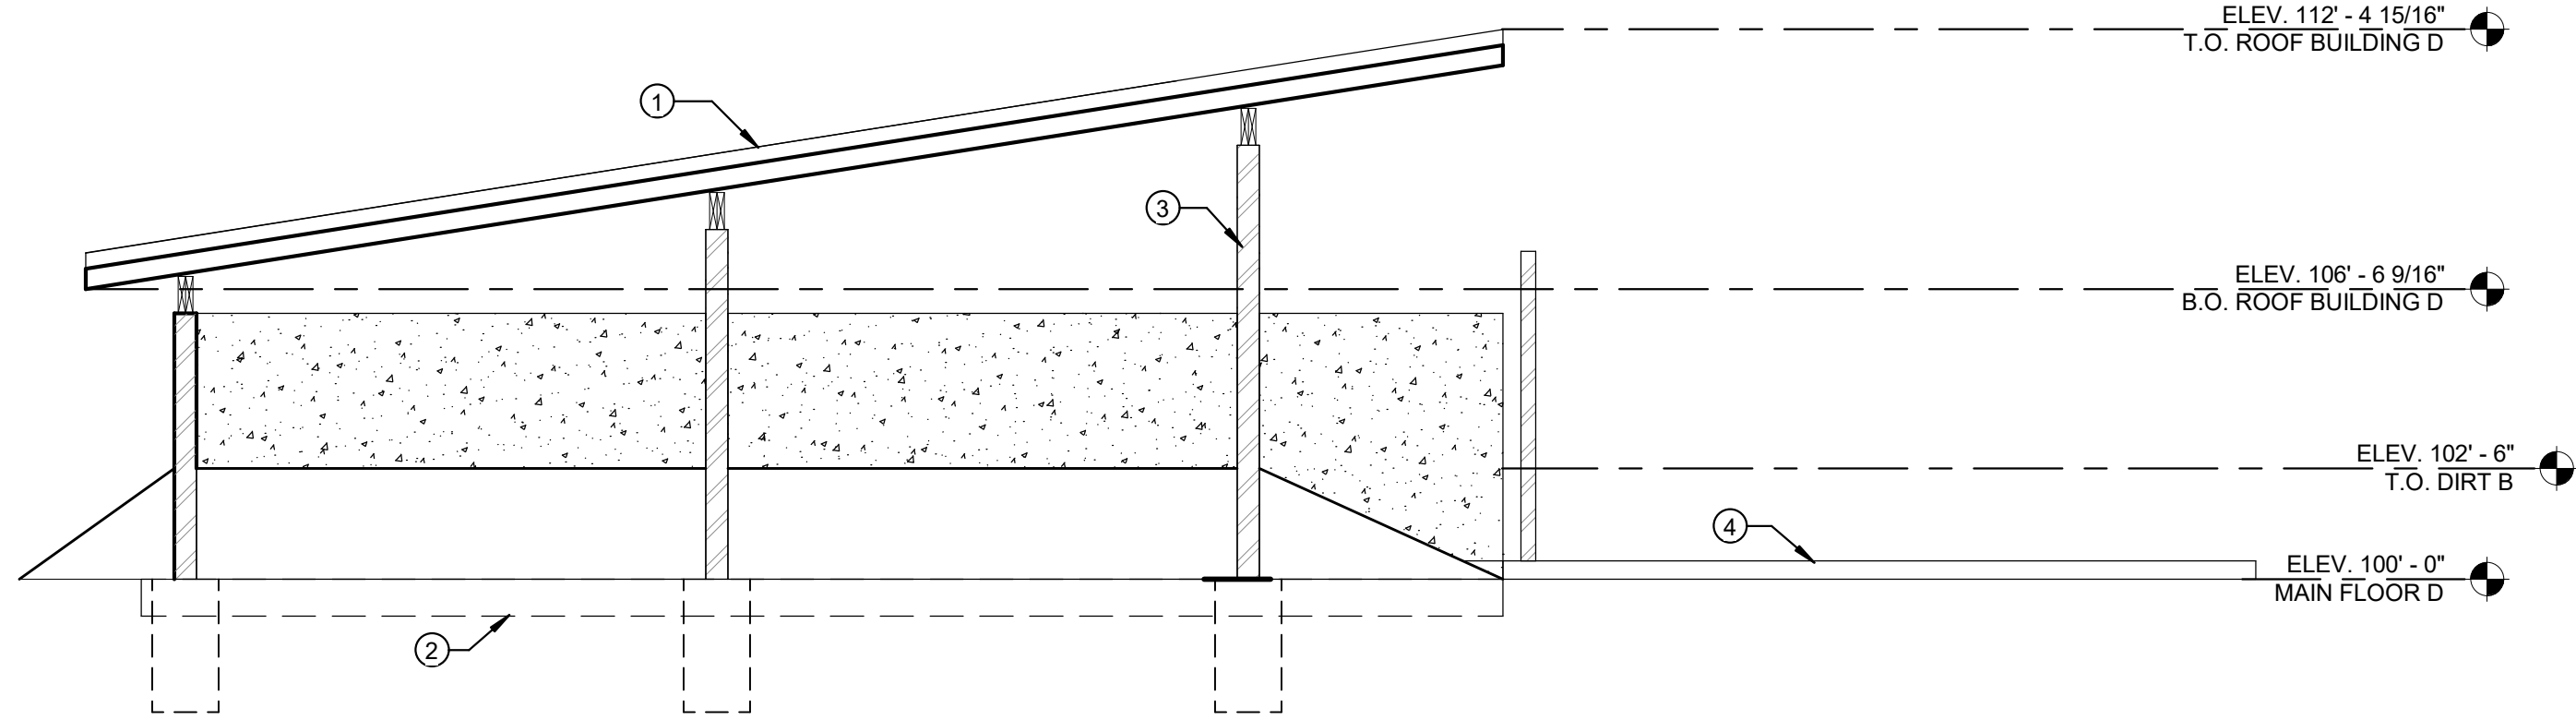

4 BUILDING D WEST
1/4" = 1'-0"

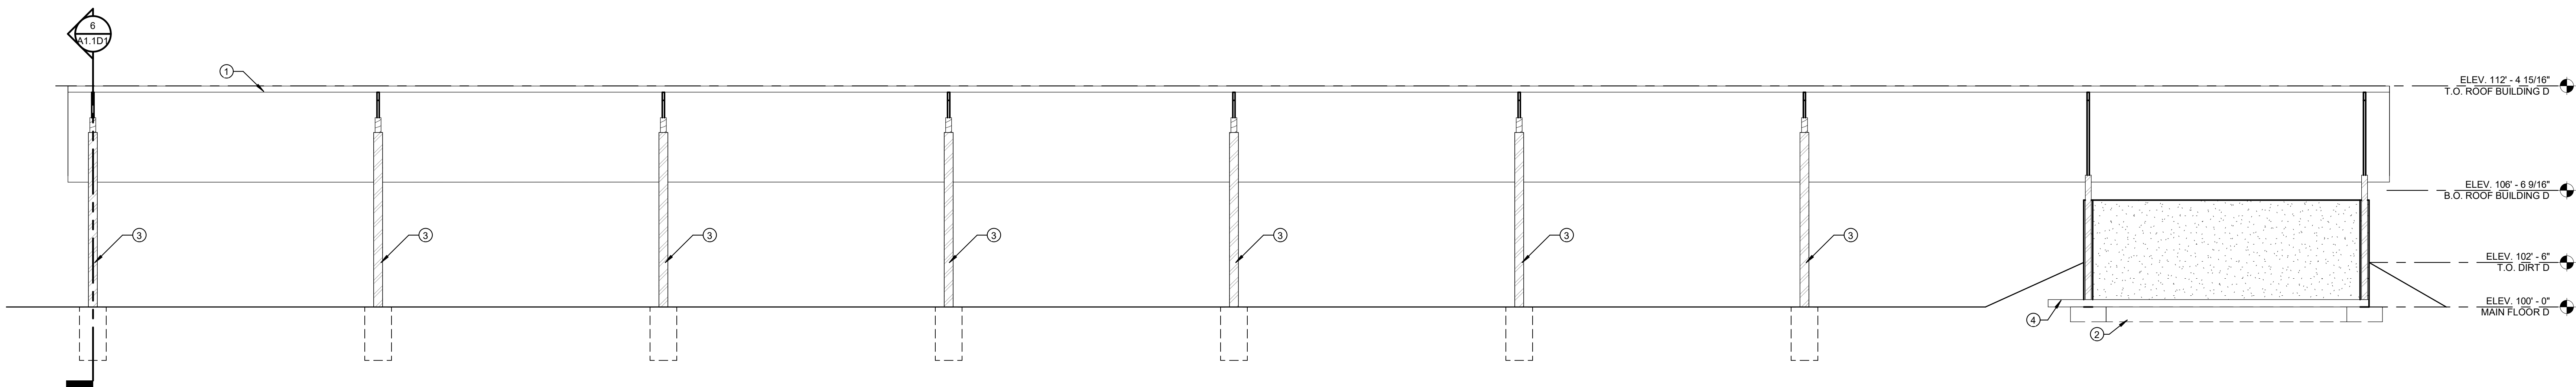

3 BUILDING D SOUTH
1/4" = 1'-0"

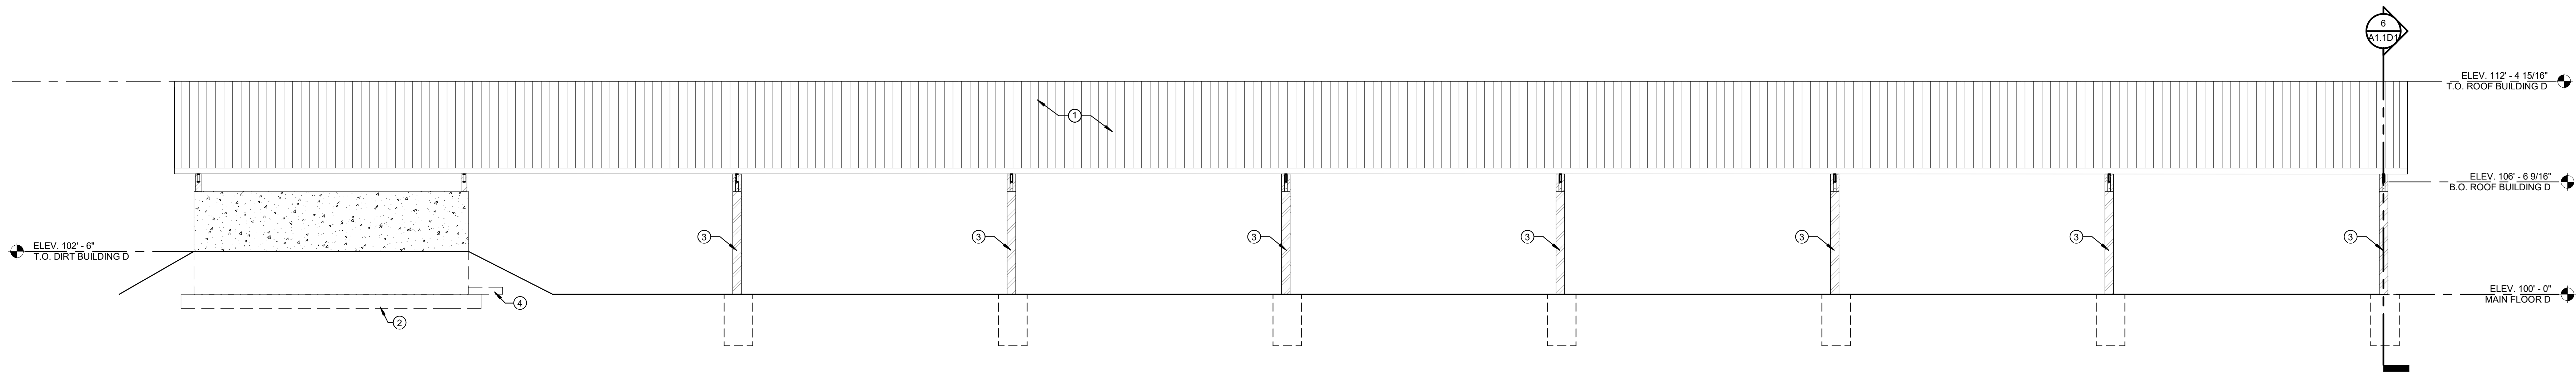


2 BUILDING D NORTH
1/4" = 1'-0"

SHEET NOTES

- METAL ROOF PANELS
- CONCRETE FOOTINGS AND FOUNDATION WALLS - SEE STRUCTURAL SHEETS FOR SIZE AND REINFORCING.
- 6" STEEL PIPE COLUMNS
- 5" CONCRETE SLAB OVER 6" FREE DRAINING GRAVEL - REINFORCED AS PER STRUCTURAL SHEETS. ROUGH PLUMBING TO BE TRENCHED INTO THE SUBSTRATE BELOW GRAVEL.

170 NORTH MAIN STREET
SPRINGFIELD, ILLINOIS 62760
WWW.KMAARCHITECTS.COM

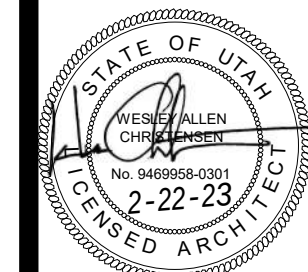


REVISIONS:

SANATQUIN, UTAH


PROJECT TITLE
NEBO SCHOOL DISTRICT
NEBO ANIMAL LABS
1400 E HIGHLINE CANAL RD

DRAWN BY: Author
CHECKED BY: Checker
DATE: FEB 2023
PROJECT #: 171022


A3.1D

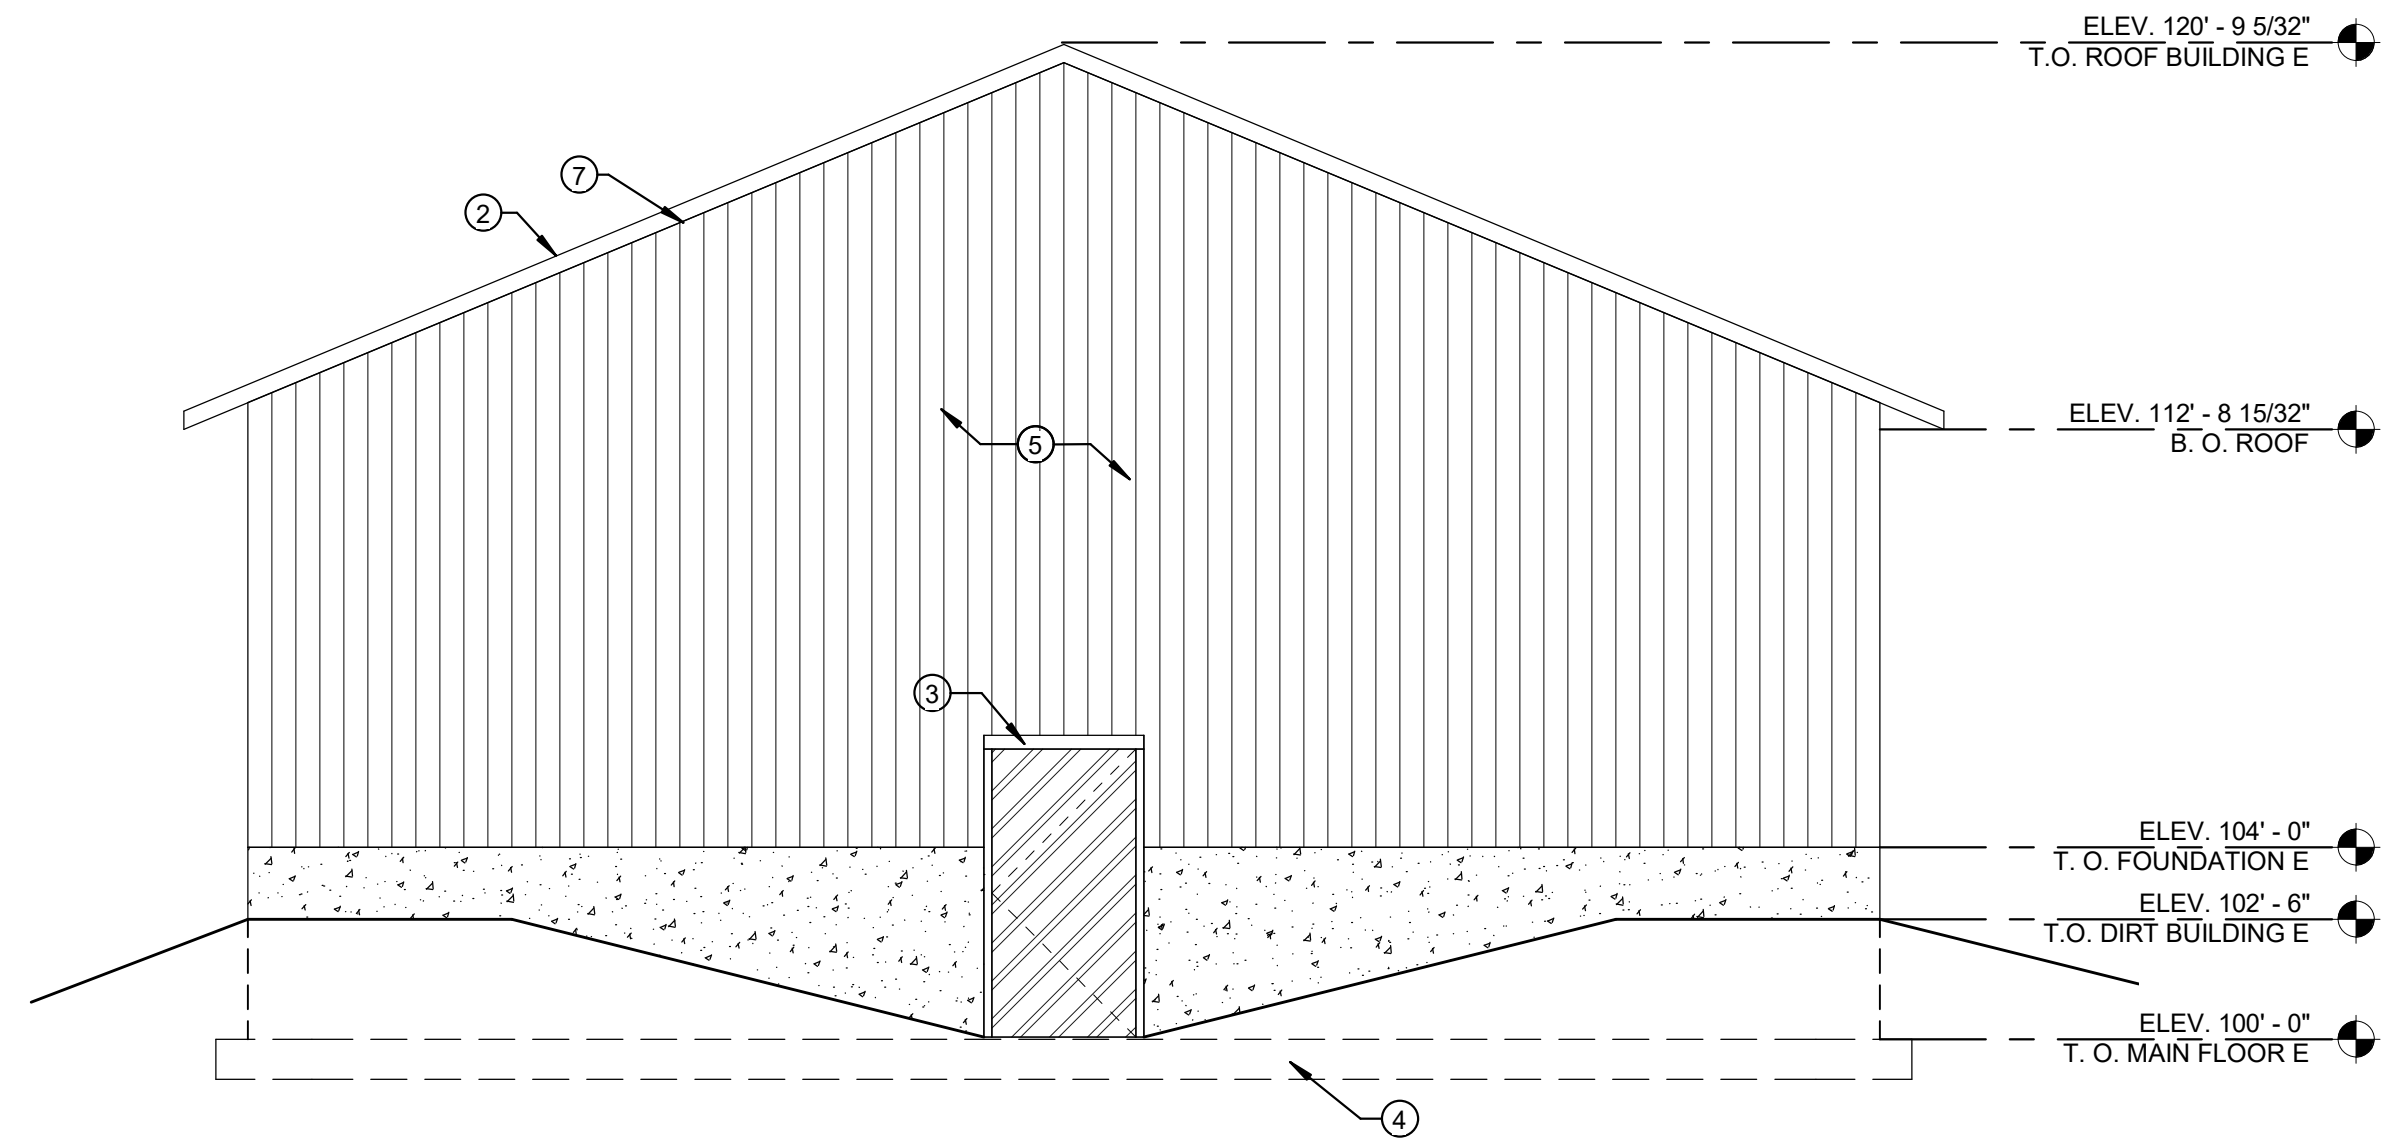


3 BUILDING E SOUTH
1/4" = 1'-0"

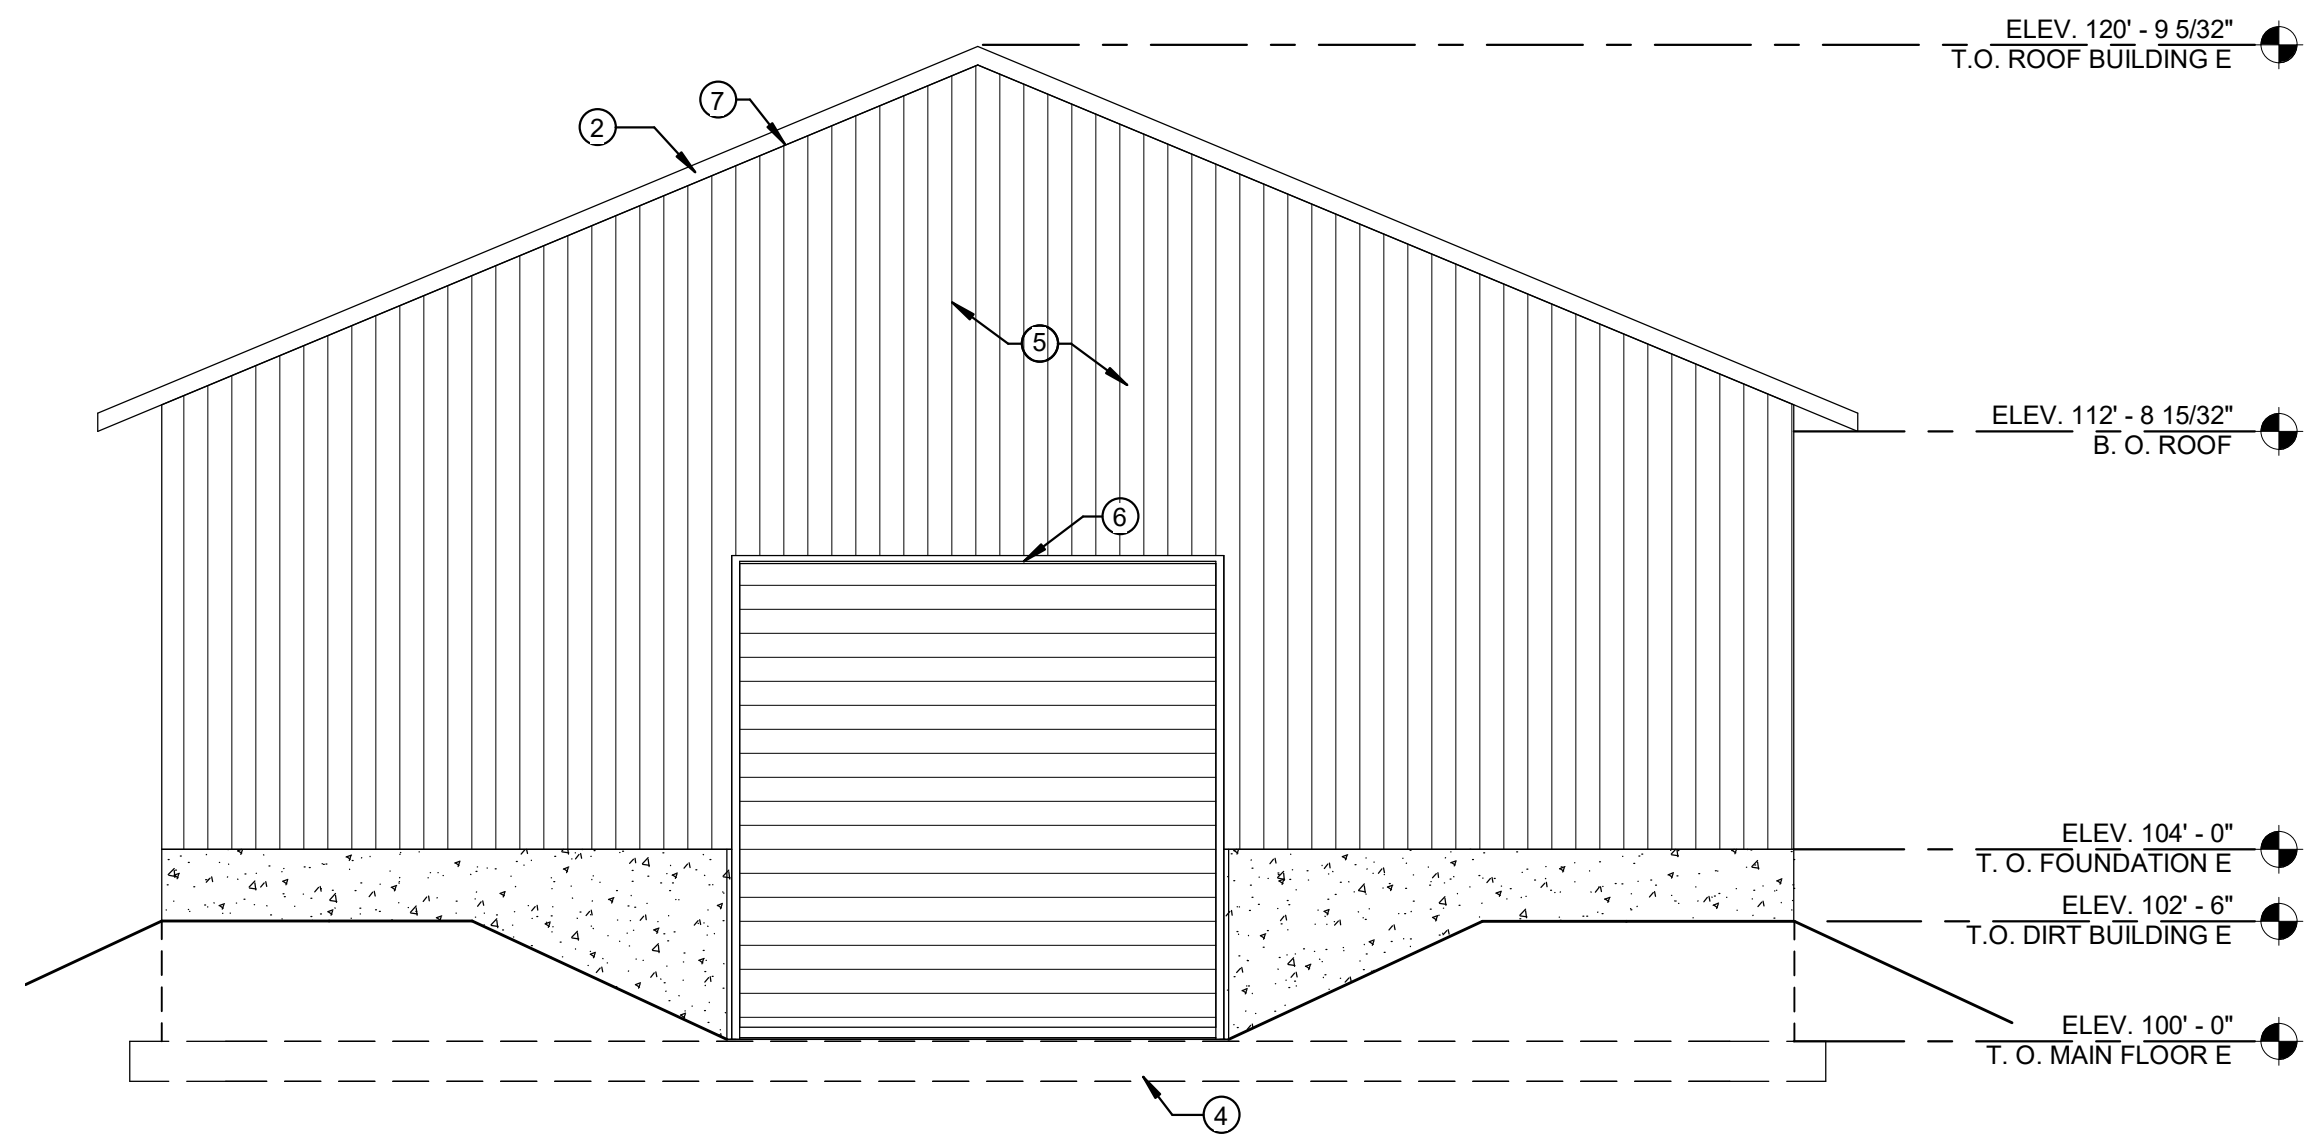


4 BUILDING E NORTH
1/4" = 1'-0"

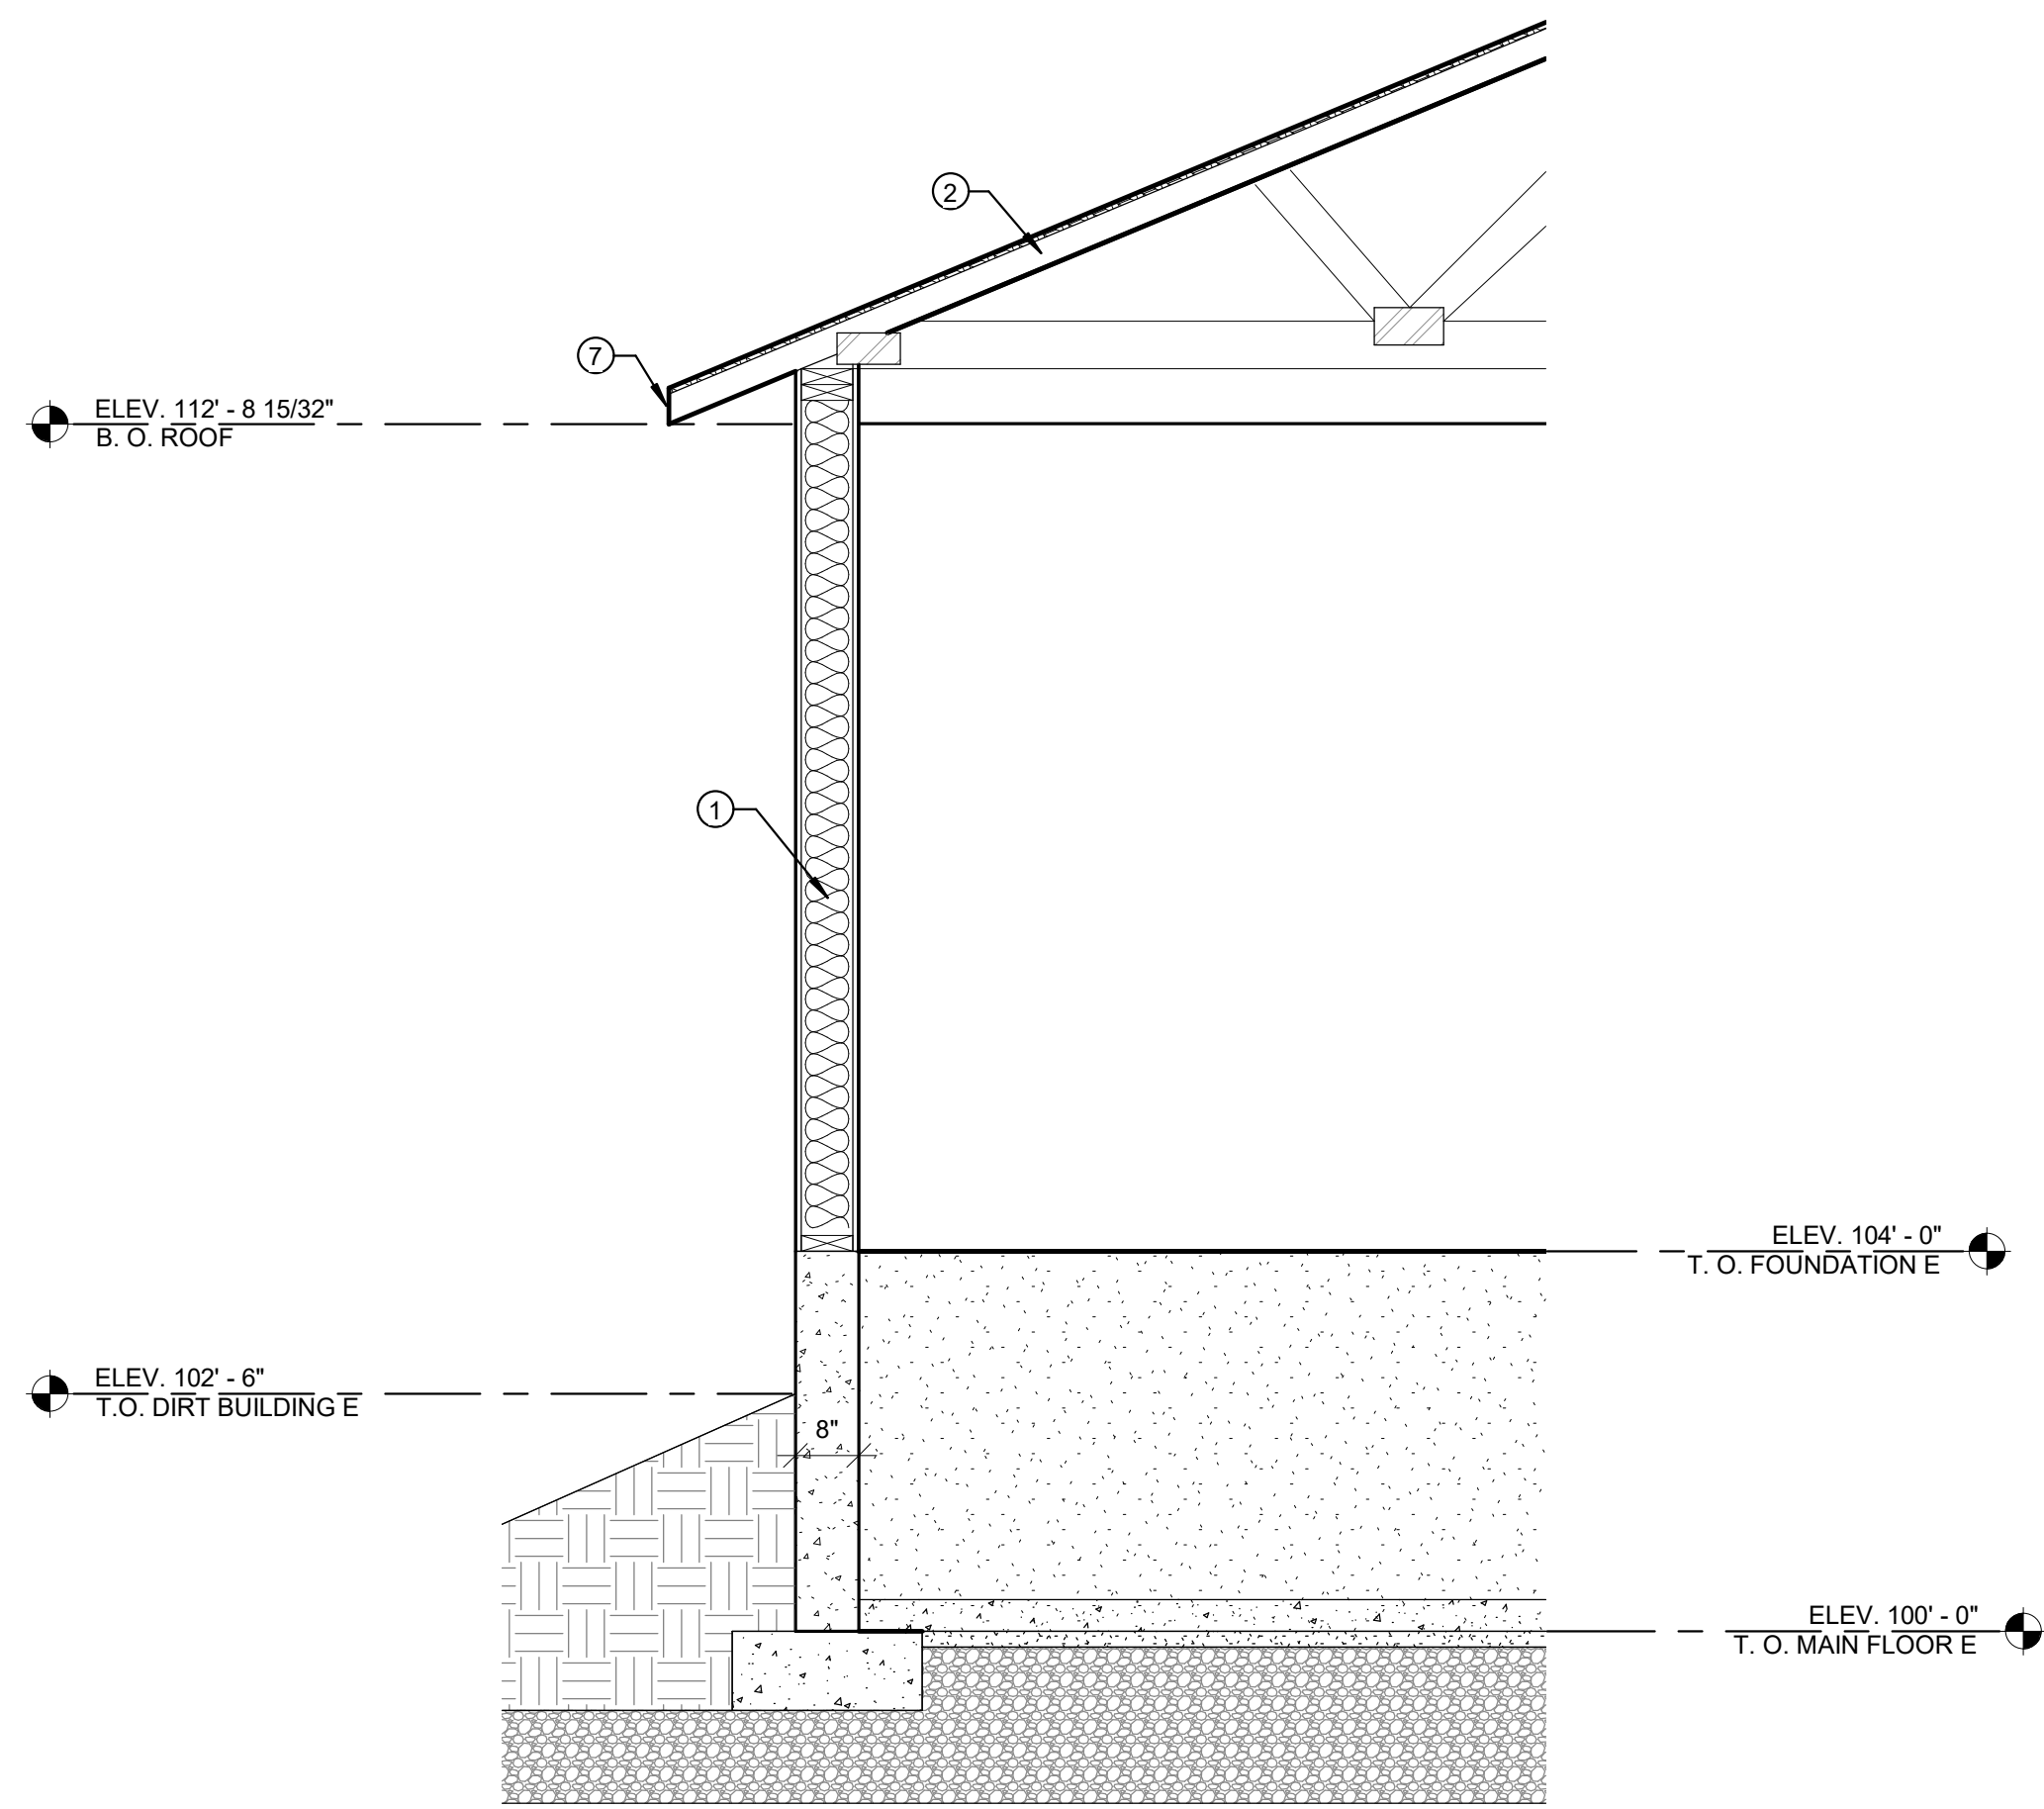

1 BUILDING E
1/2" = 1'-0"

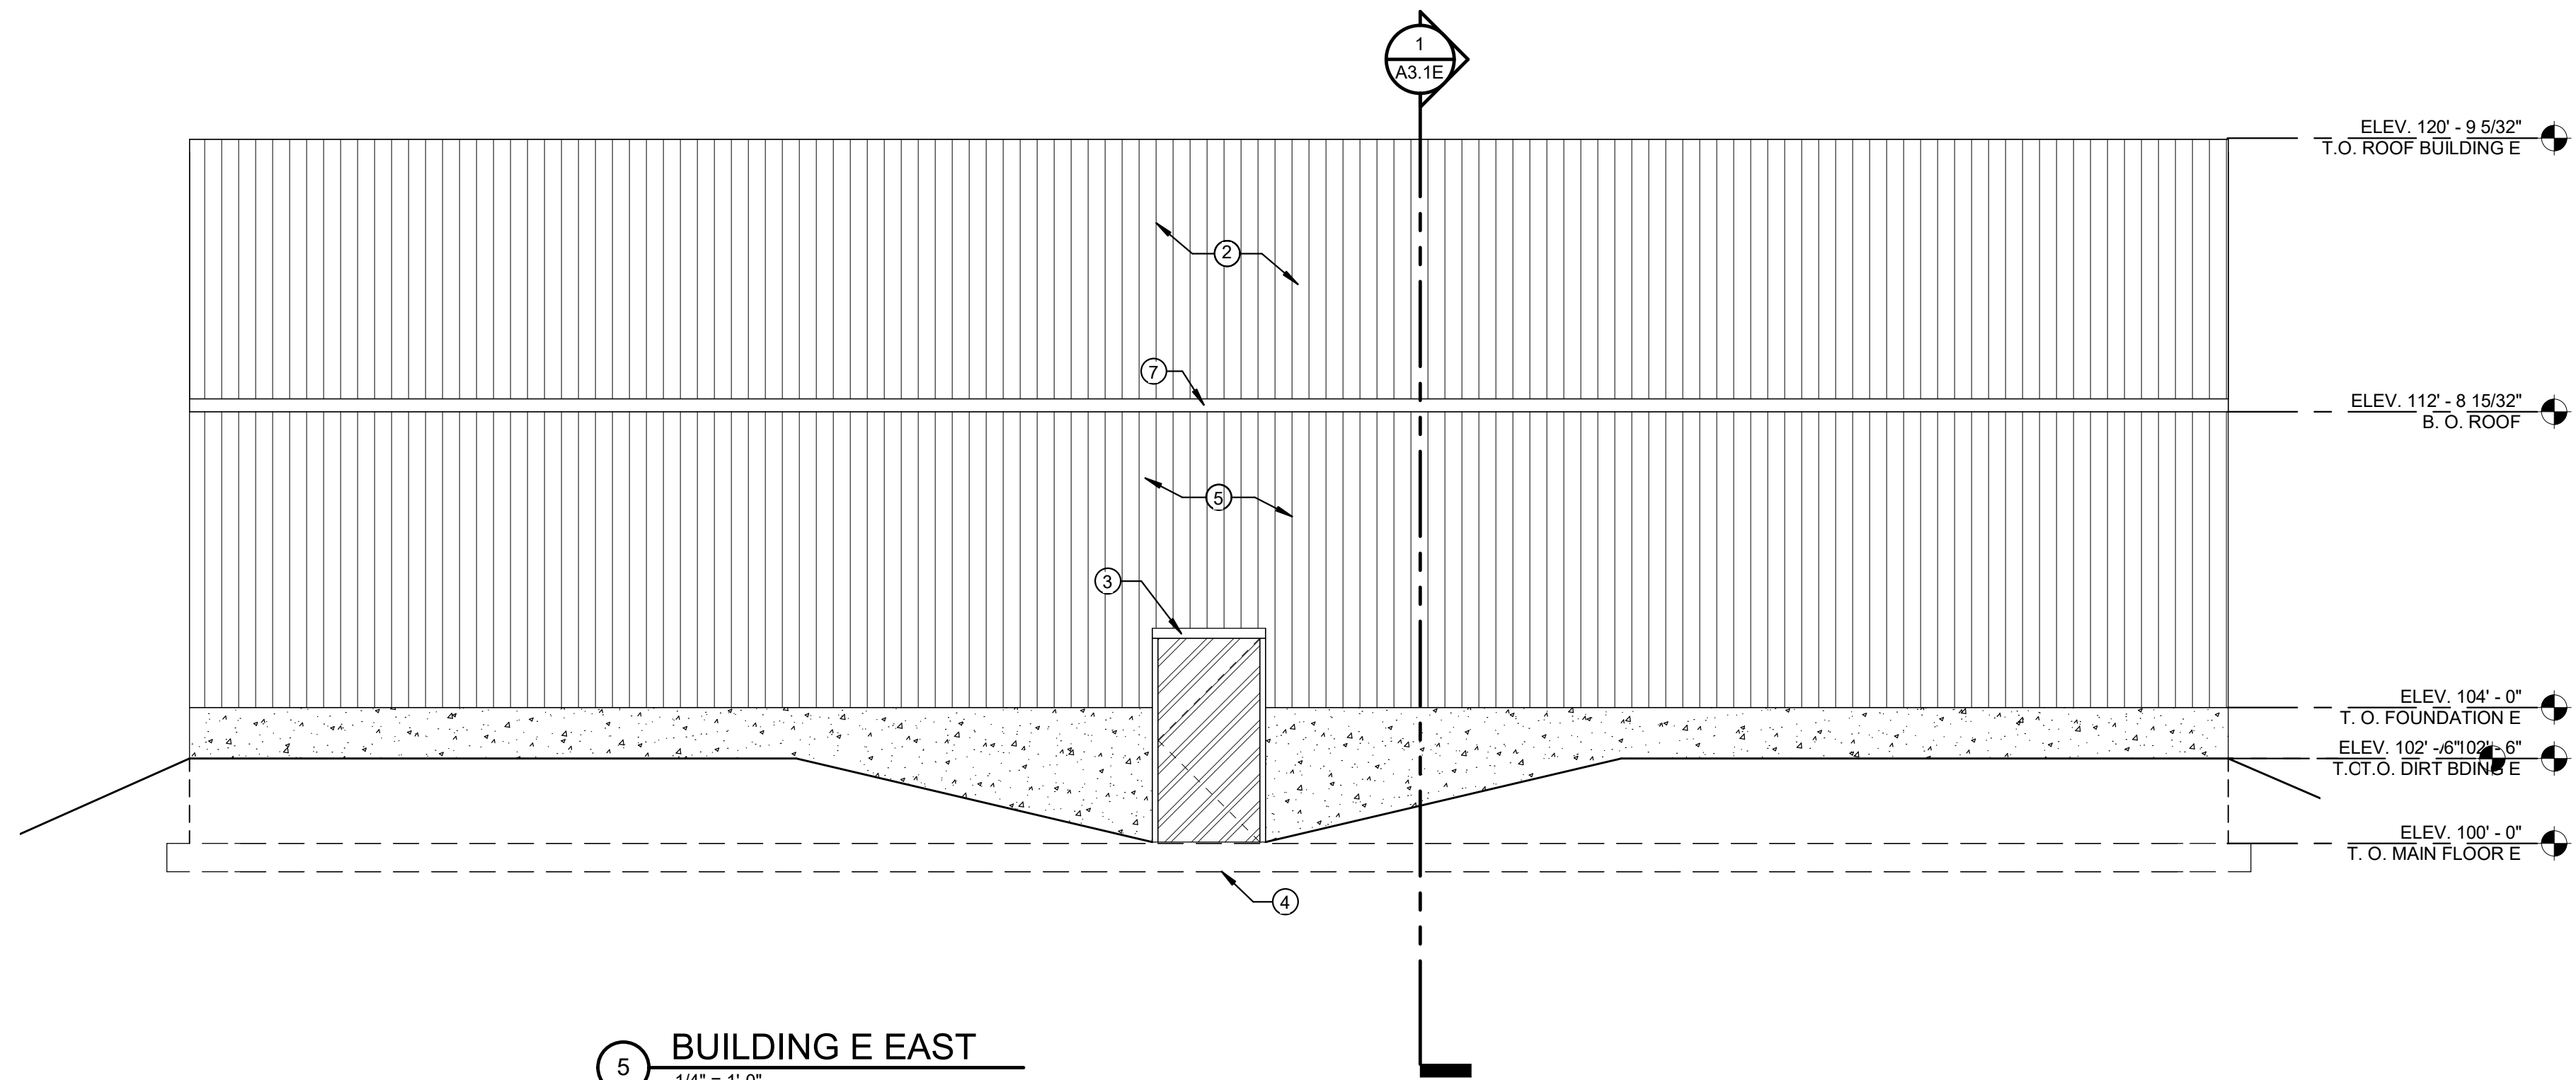

5 BUILDING E EAST
1/4" = 1'-0"

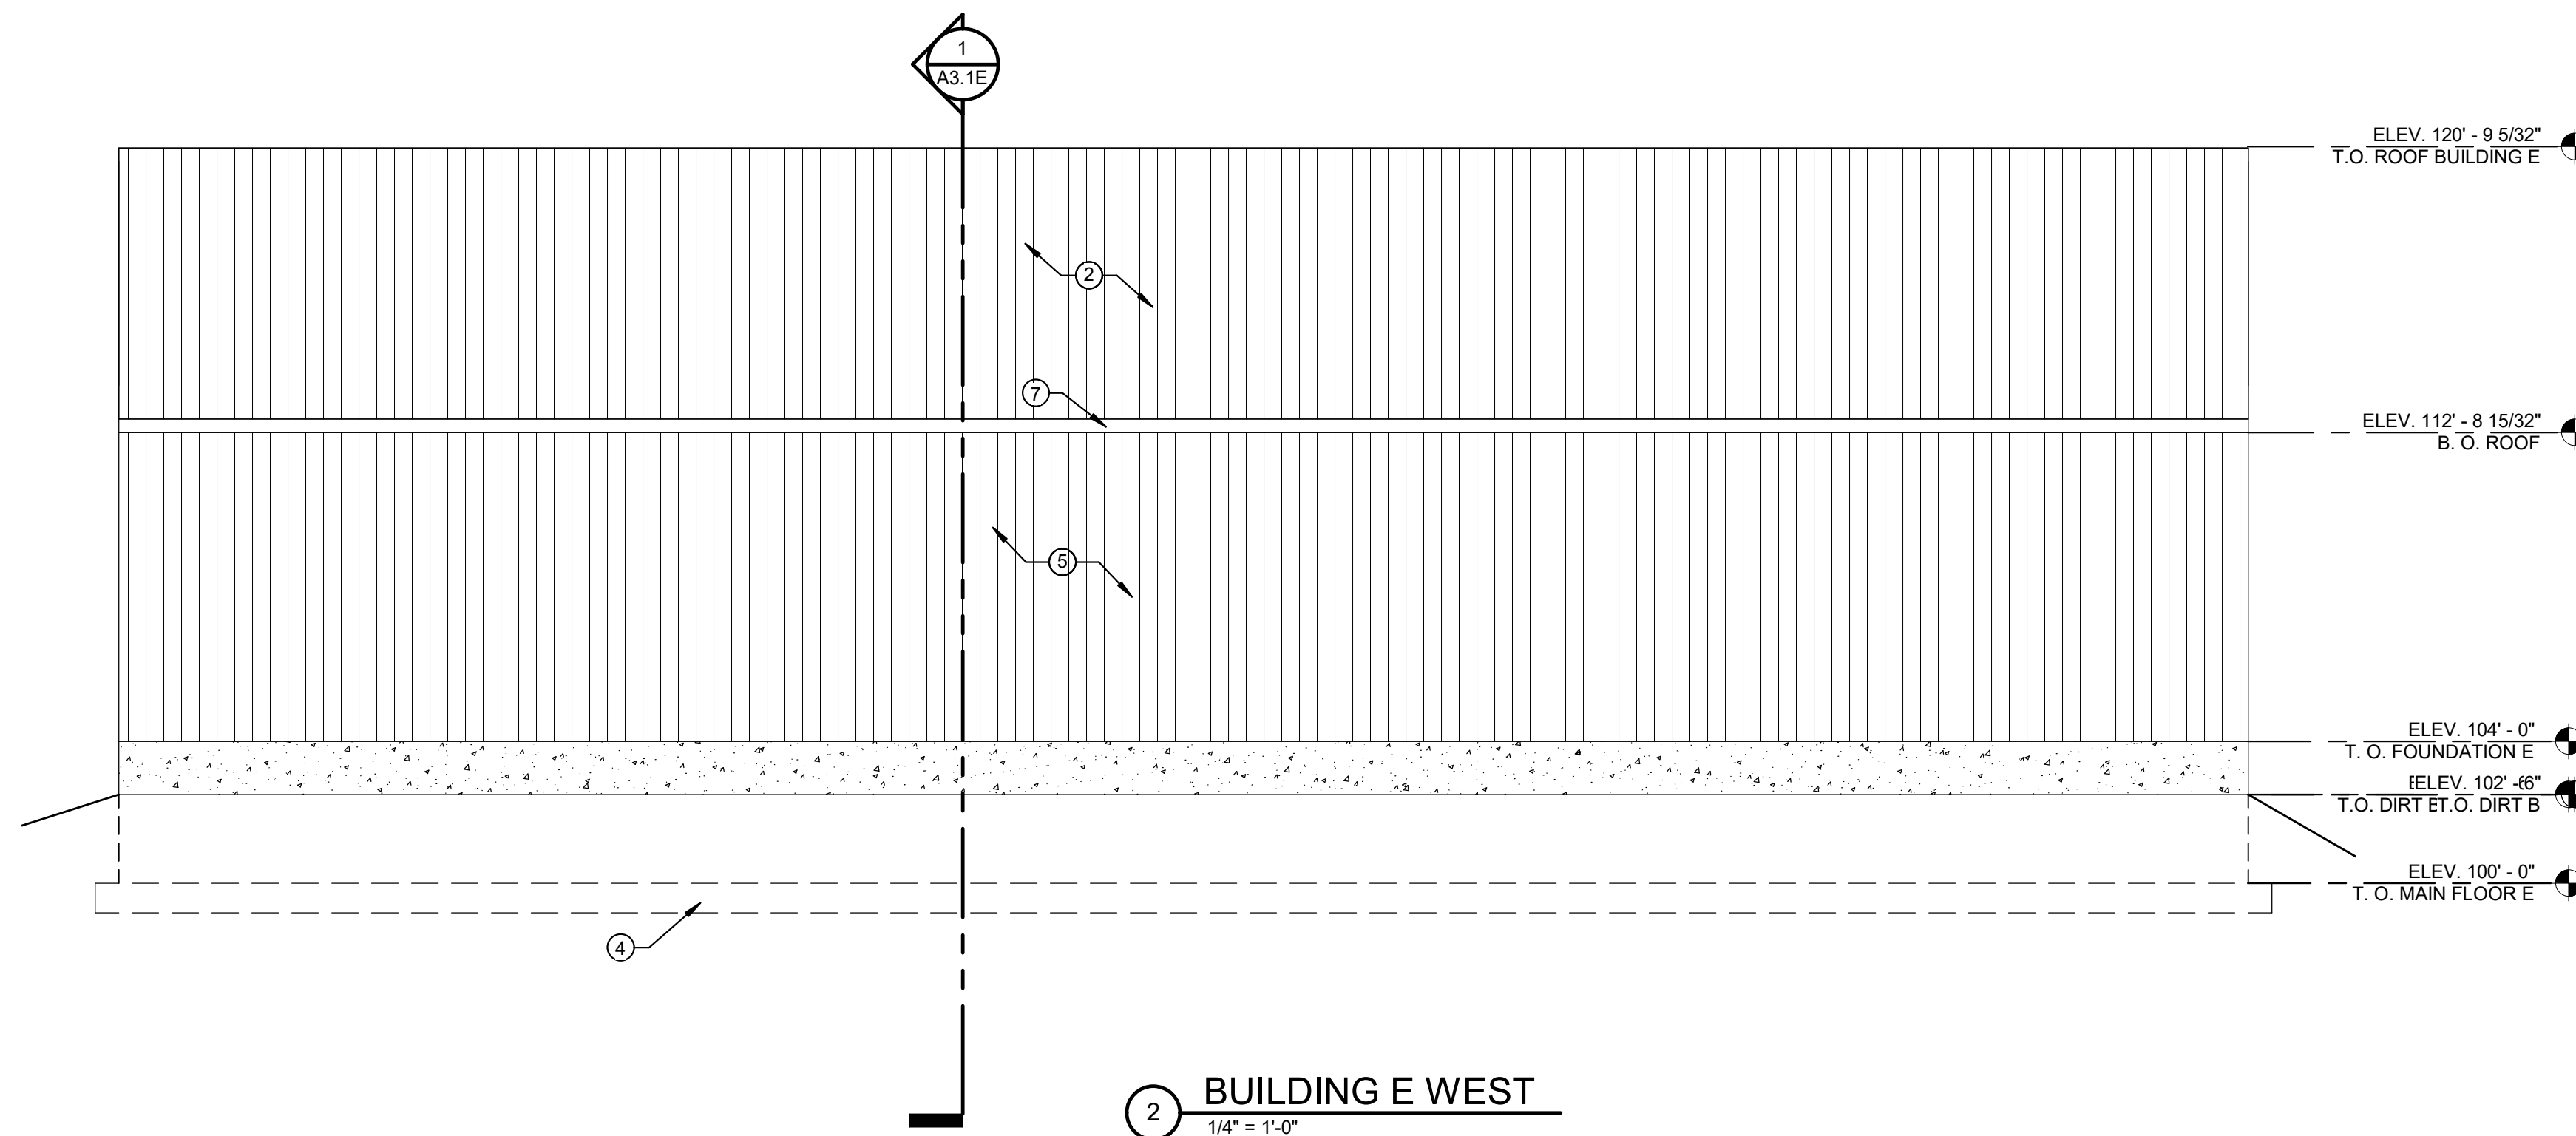

2 BUILDING E WEST
1/4" = 1'-0"

SHEET NOTES

- 1 - WOOD FRAME WALLS W/ 5/8" PLYWOOD - SEE STRUCTURAL SHEETS
- 2 - METAL ROOF PANELS
- 3 - HOLLOW METAL DOOR AND FRAME (PAINTED) - SEE DOOR SCHEDULE. COLOR AS SELECTED BY ARCHITECT.
- 4 - CONCRETE FOOTINGS AND FOUNDATION WALLS - SEE STRUCTURAL SHEETS FOR SIZE AND REINFORCING.
- 5 - METAL WALL PANELS
- 6 - 10' ROLL UP DOOR
- 7 - METAL SOFFIT, FASCIA, AND DOWN SPOUT



REVISIONS:

PROJECT TITLE
NEBO SCHOOL DISTRICT
NEBO ANIMAL LABS
1400 E HIGHLINE CANAL RD
SANATQUIN, UTAH


PROJECT TITLE
NEBO SCHOOL DISTRICT
NEBO ANIMAL LABS
1400 E HIGHLINE CANAL RD
SANATQUIN, UTAH

DRAWN BY: Author
CHECKED BY: Checker
DATE: FEB 2023
PROJECT #: 171022


A3.1E

170 NORTH MAIN STREET
SPRINGFIELD, UTAH 84660
WWW.KMAARCHITECTS.COM


KMA
ARCHITECTS

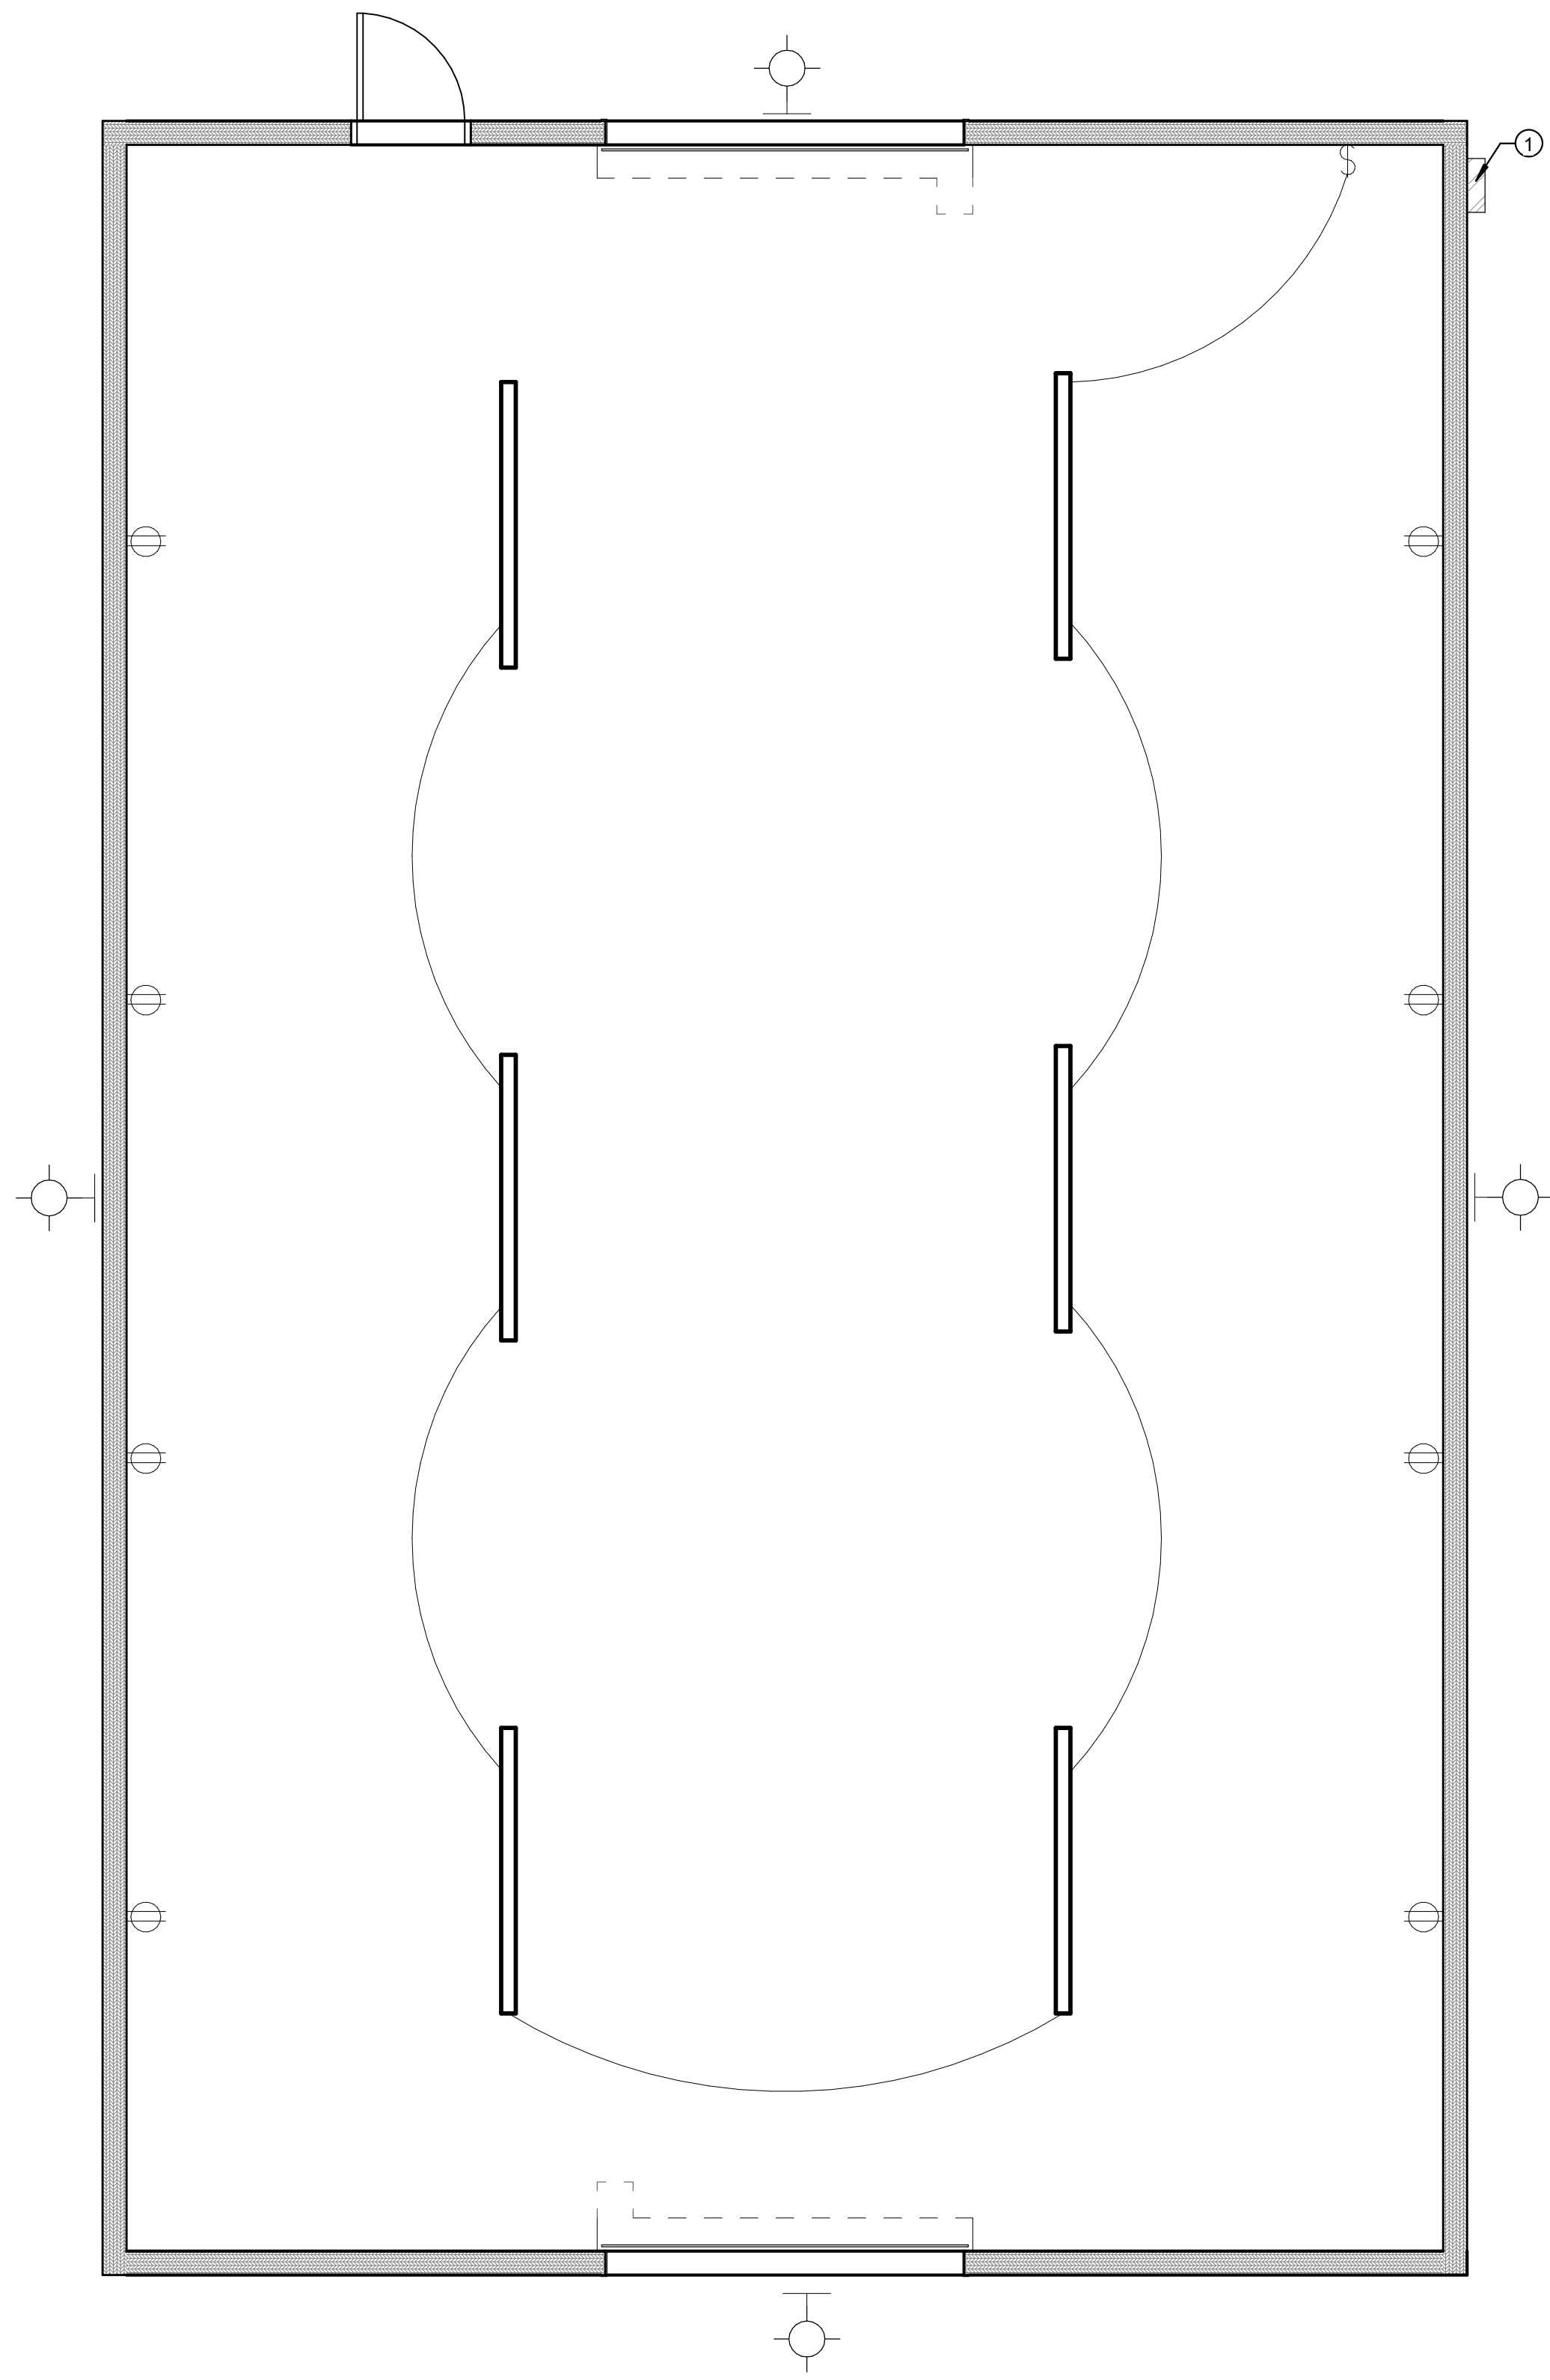

1 LIGHT PLAN BUILDING A
1/4" = 1'-0"

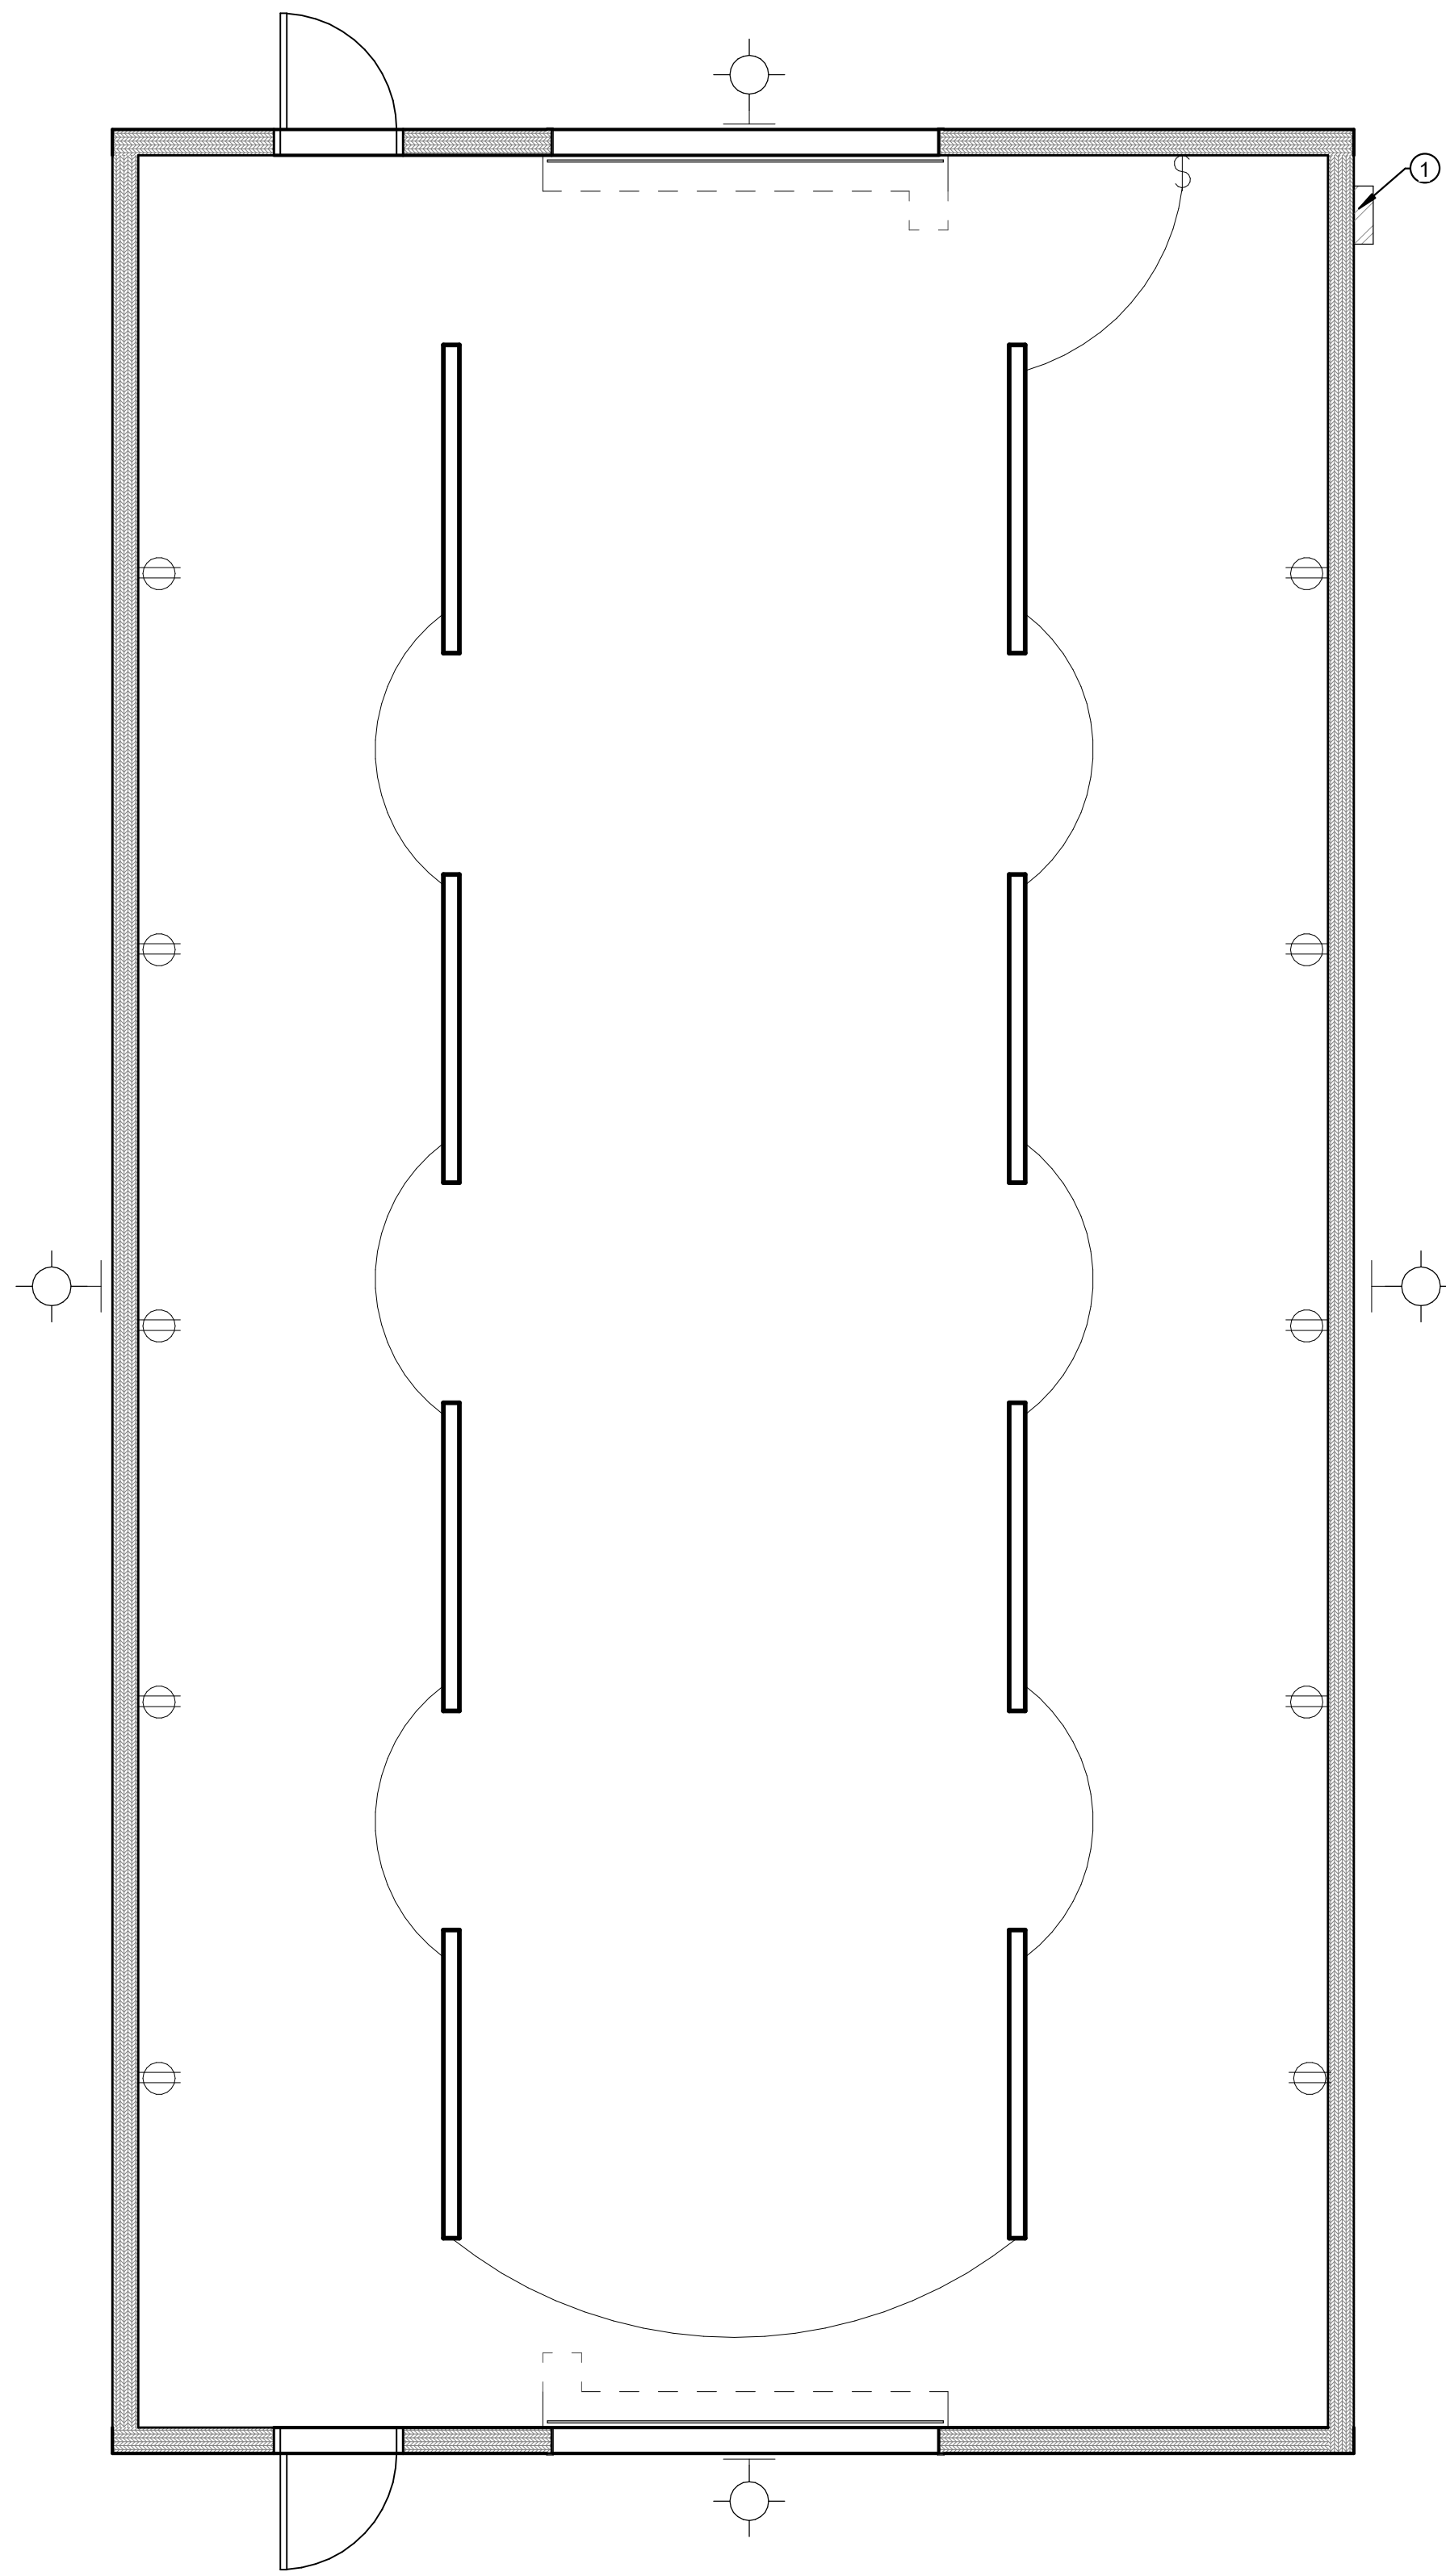

2 LIGHT PLAN BUILDING B
1/4" = 1'-0"

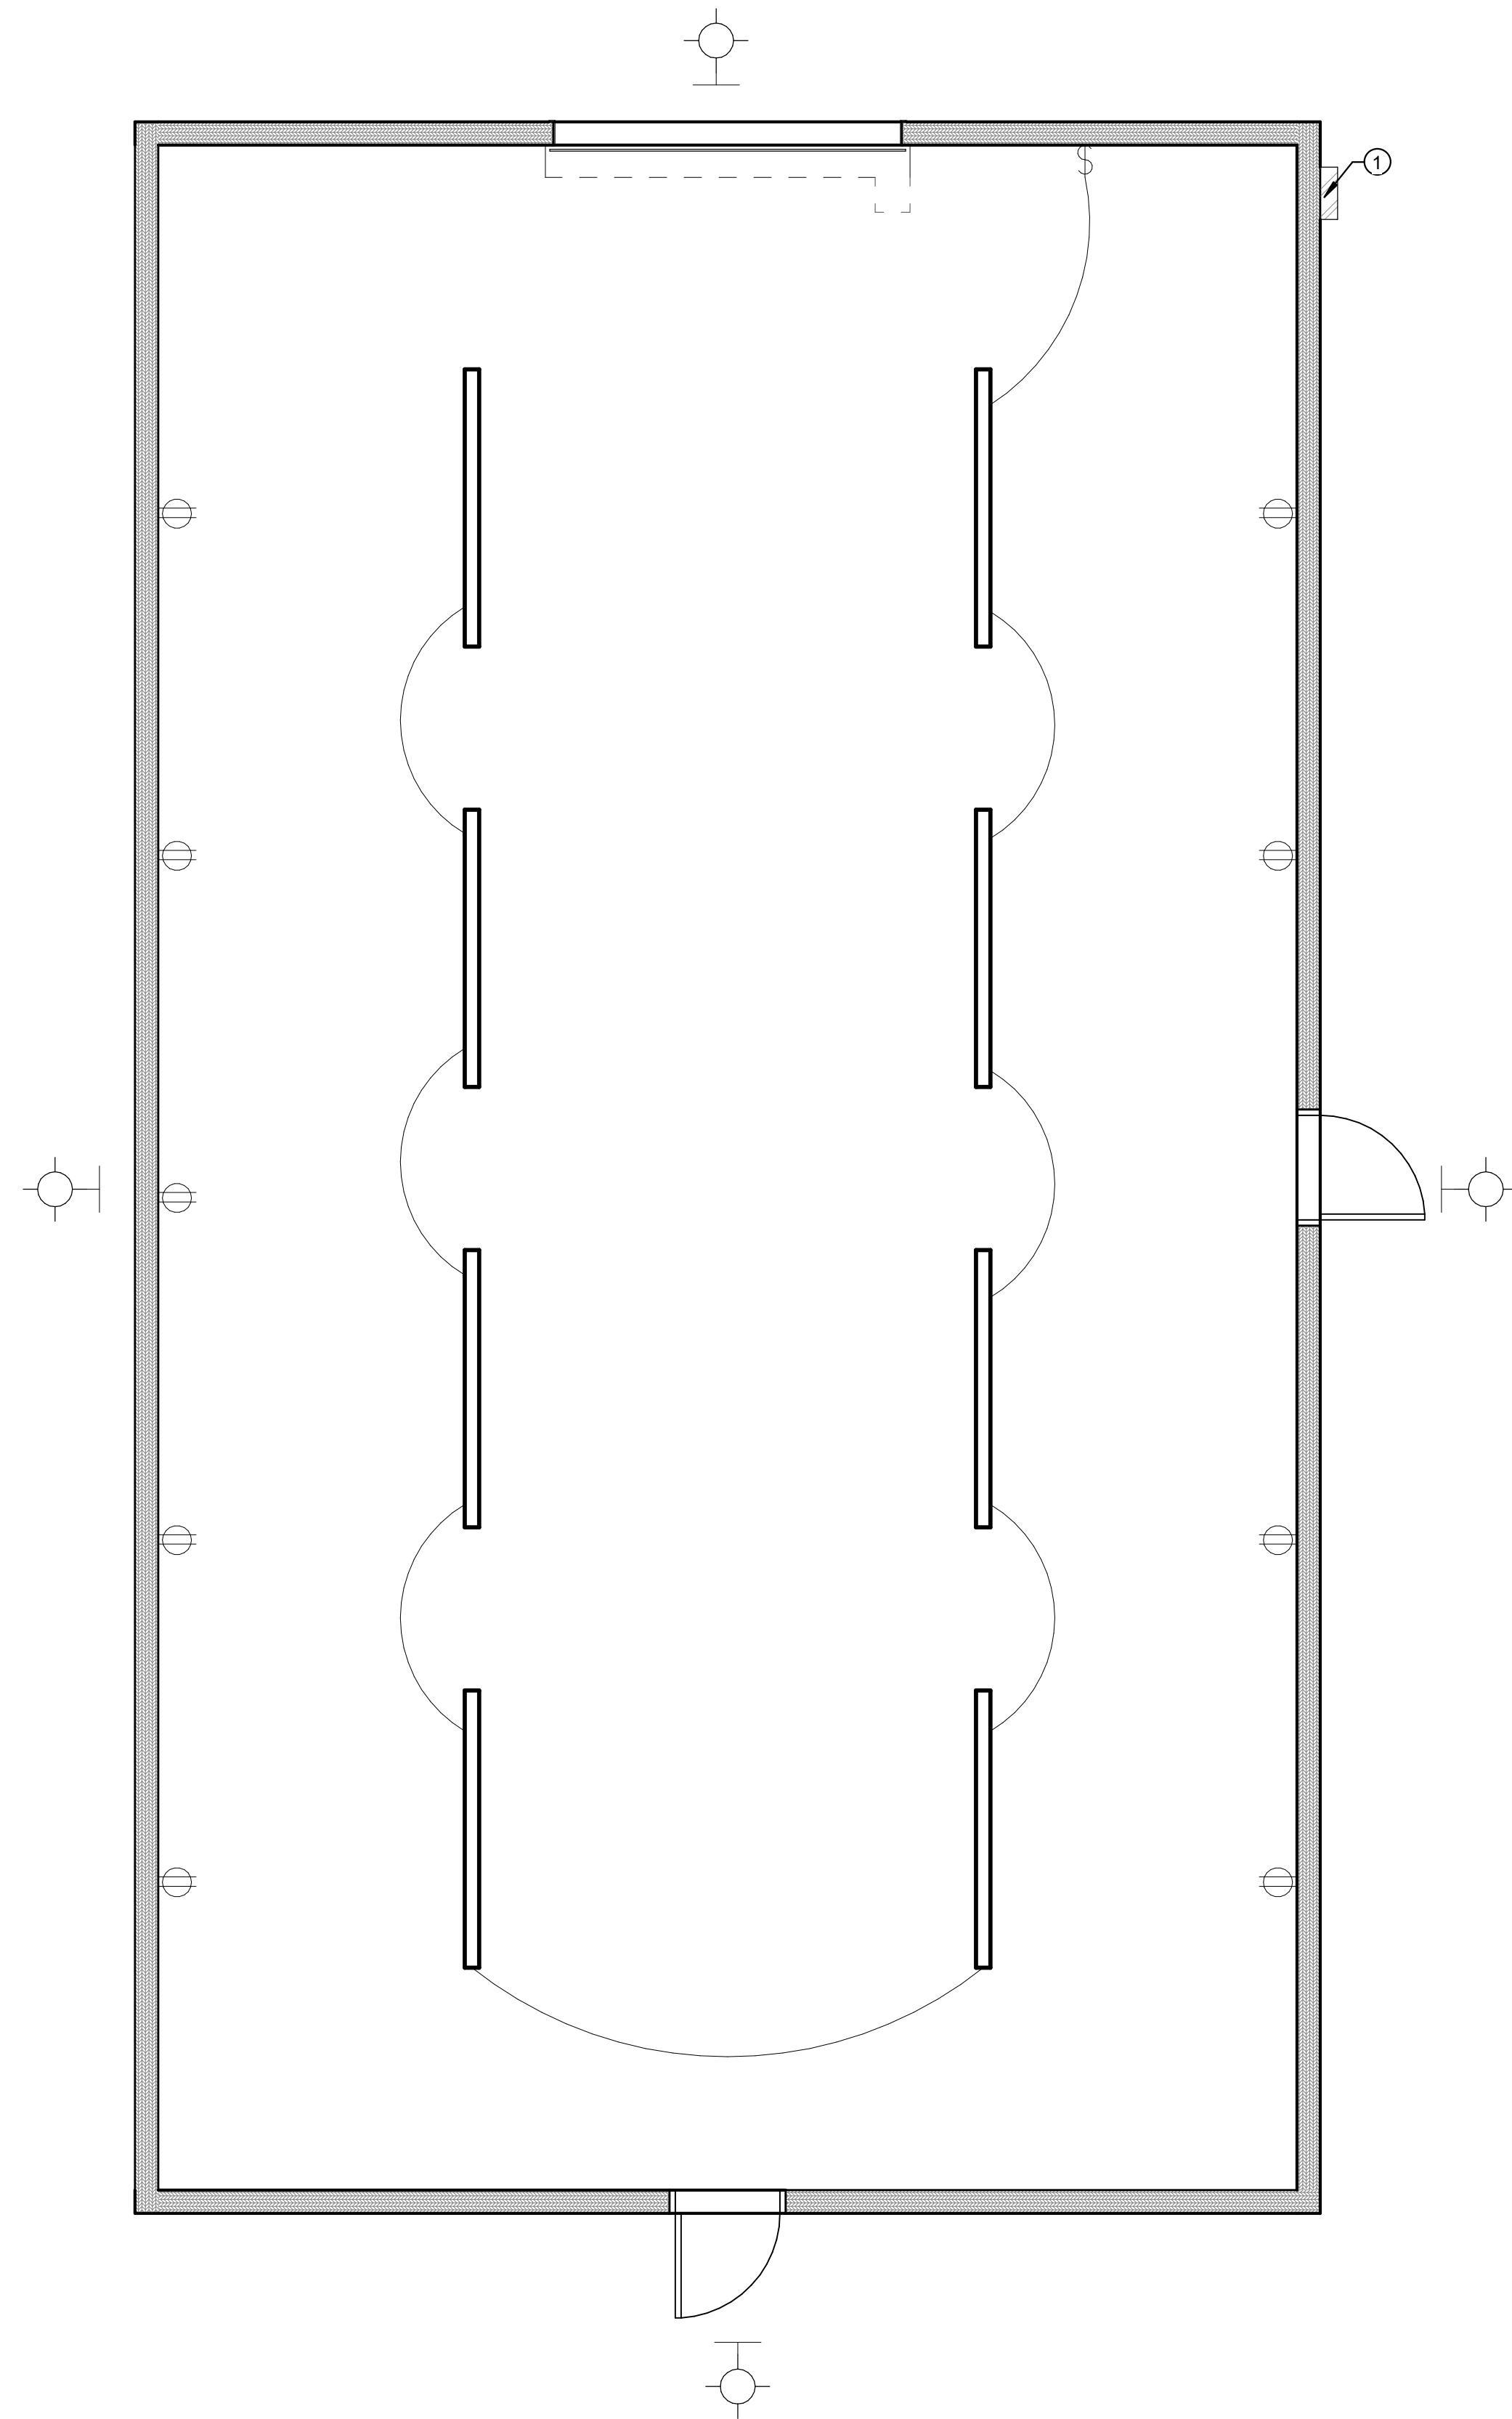

4 LIGHT PLAN BUILDING E
1/4" = 1'-0"

SHEET NOTES

- 1 - ELECTRICAL PANEL AND EQUIPMENT - SEE ELECTRICAL SHEETS.




REVISIONS:

PROJECT TITLE
NEBO SCHOOL DISTRICT
NEBO ANIMAL LABS
400 E HIGHLINE CANAL RD
SANATQUIN, UTAH


DRAWN BY: STAFF
CHECKED BY: W.C.
DATE: FEB 2023
PROJECT #: 171022

E1

170 NORTH MAIN STREET
SPANISH FORK, UT 84660
WWW.KMAARCHITECTS.COM

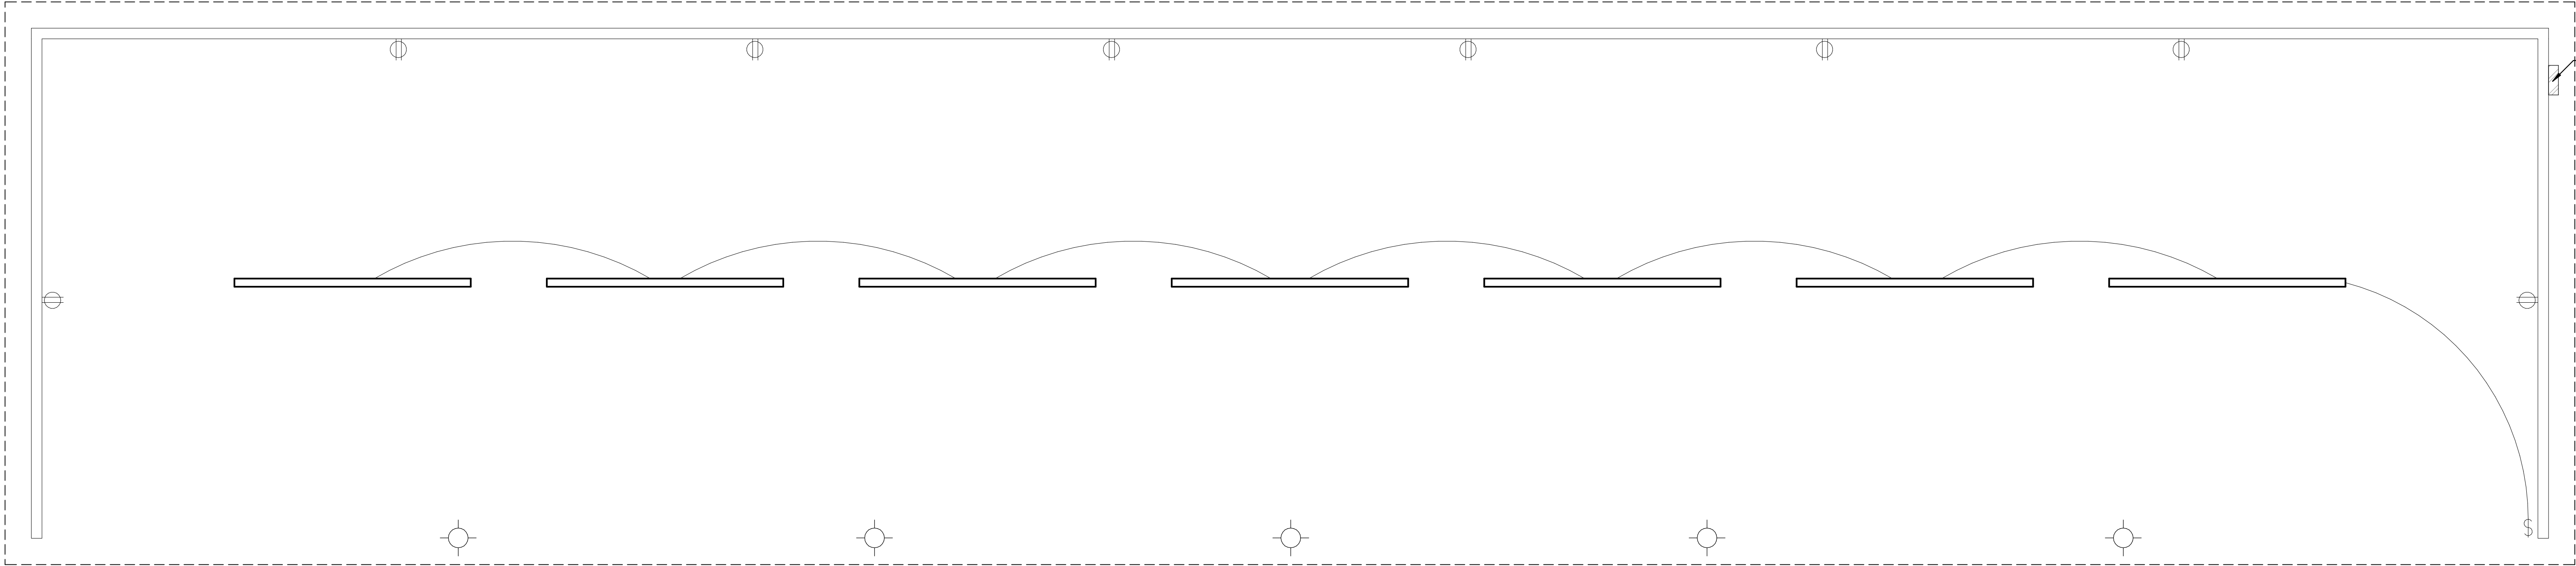


1 LIGHT PLAN BUILDING C
1/4" = 1'-0"

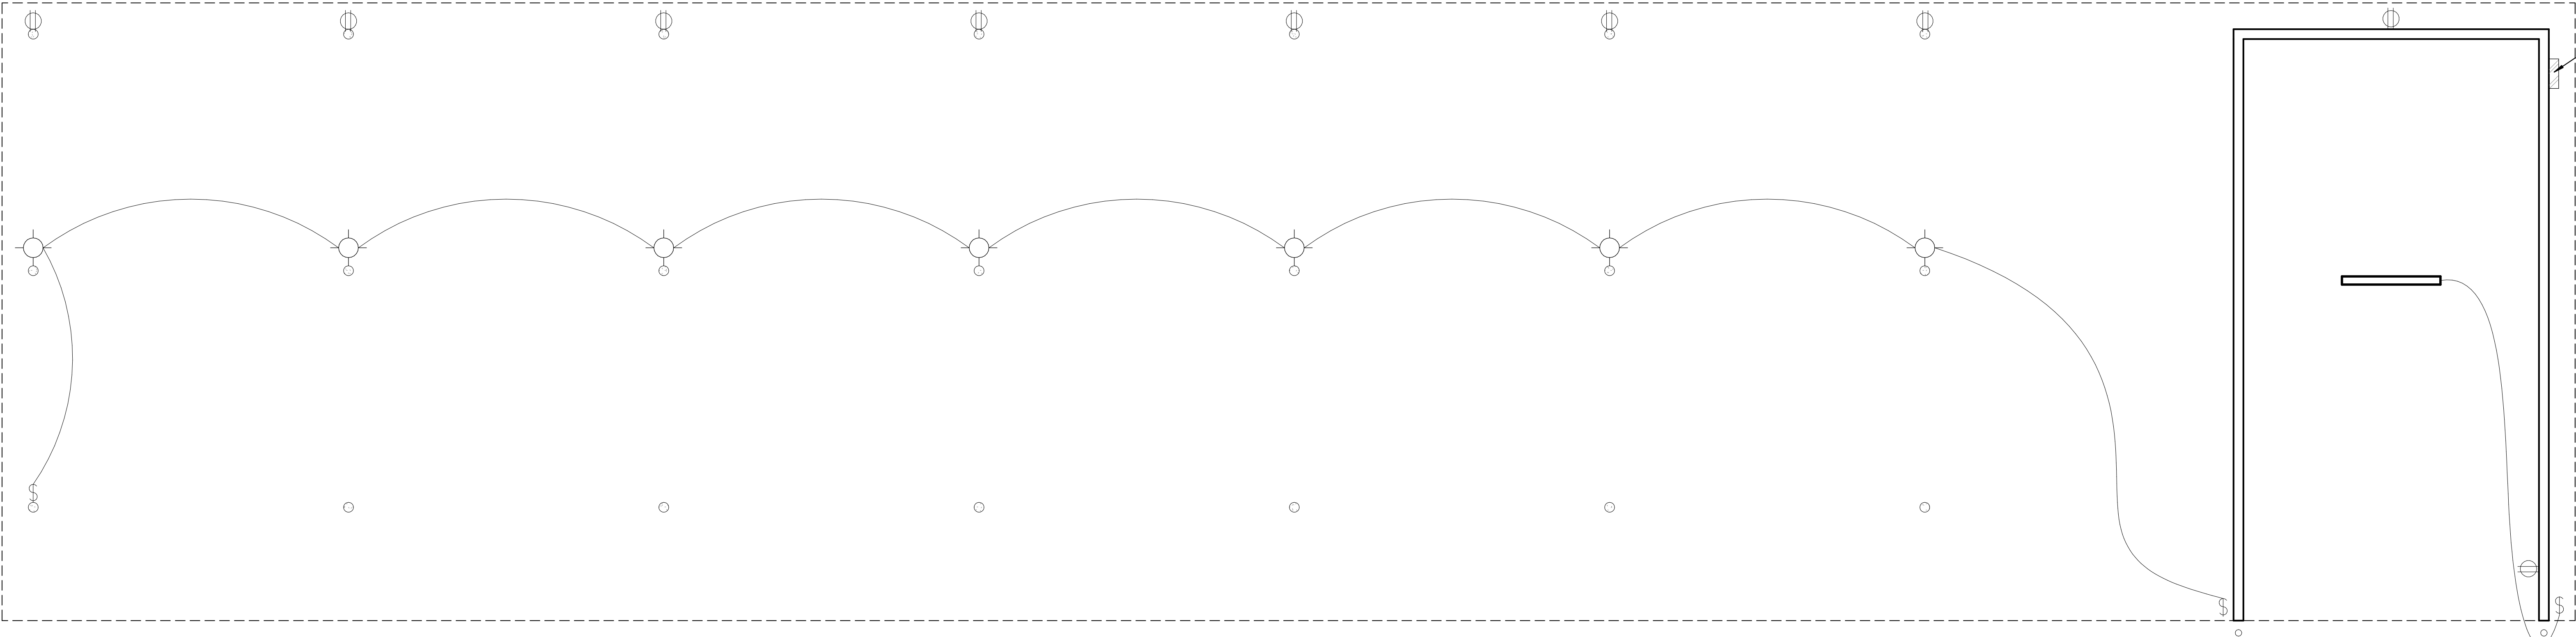

2 LIGHT PLAN BUILDING D
1/4" = 1'-0"

SHEET NOTES

- 1 - ELECTRICAL PANEL AND EQUIPMENT - SEE ELECTRICAL SHEETS.

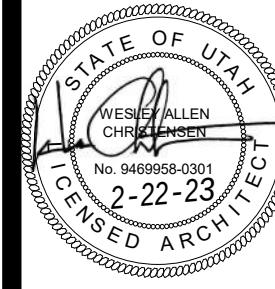

REVISIONS:

PROJECT TITLE
NEBO SCHOOL DISTRICT
NEBO ANIMAL LABS
1400 E HIGHLINE CANAL RD
SANATQUIN, UTAH

DRAWN BY: Author
CHECKED BY: Checker
DATE: FEB 2023
PROJECT #: 171022

E1.1



170 NORTH MAIN STREET
SPANISH FORK, UT 84660
WWW.KMAARCHITECTS.COM