



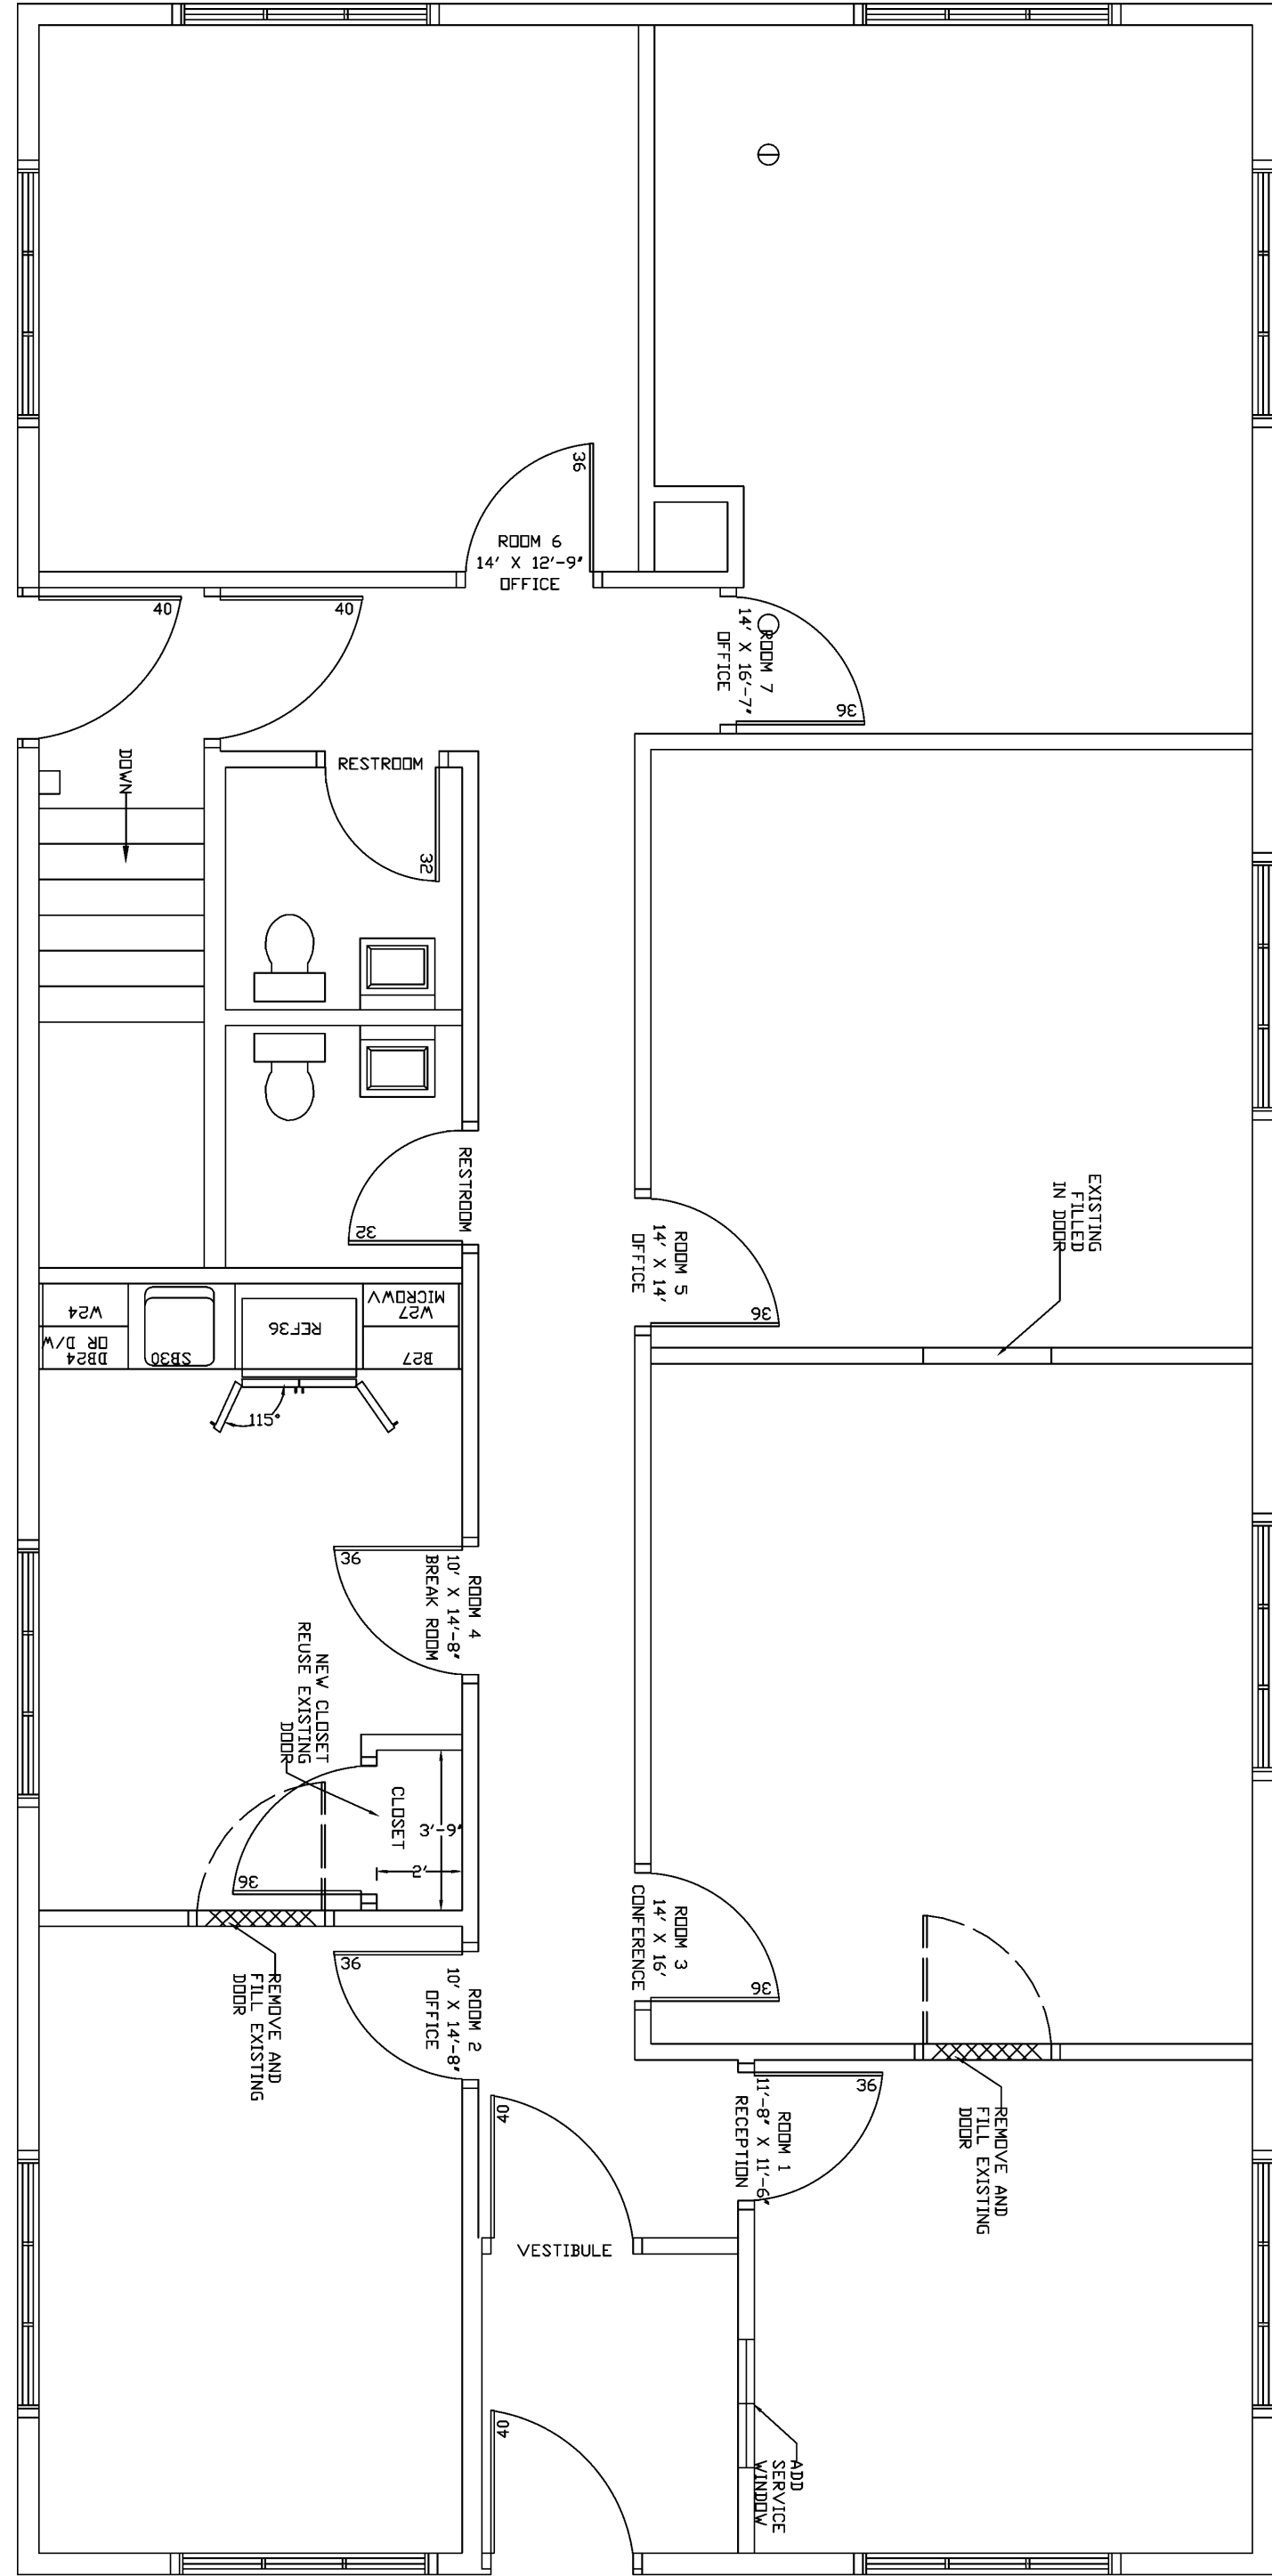

FIRST FLOOR PLAN

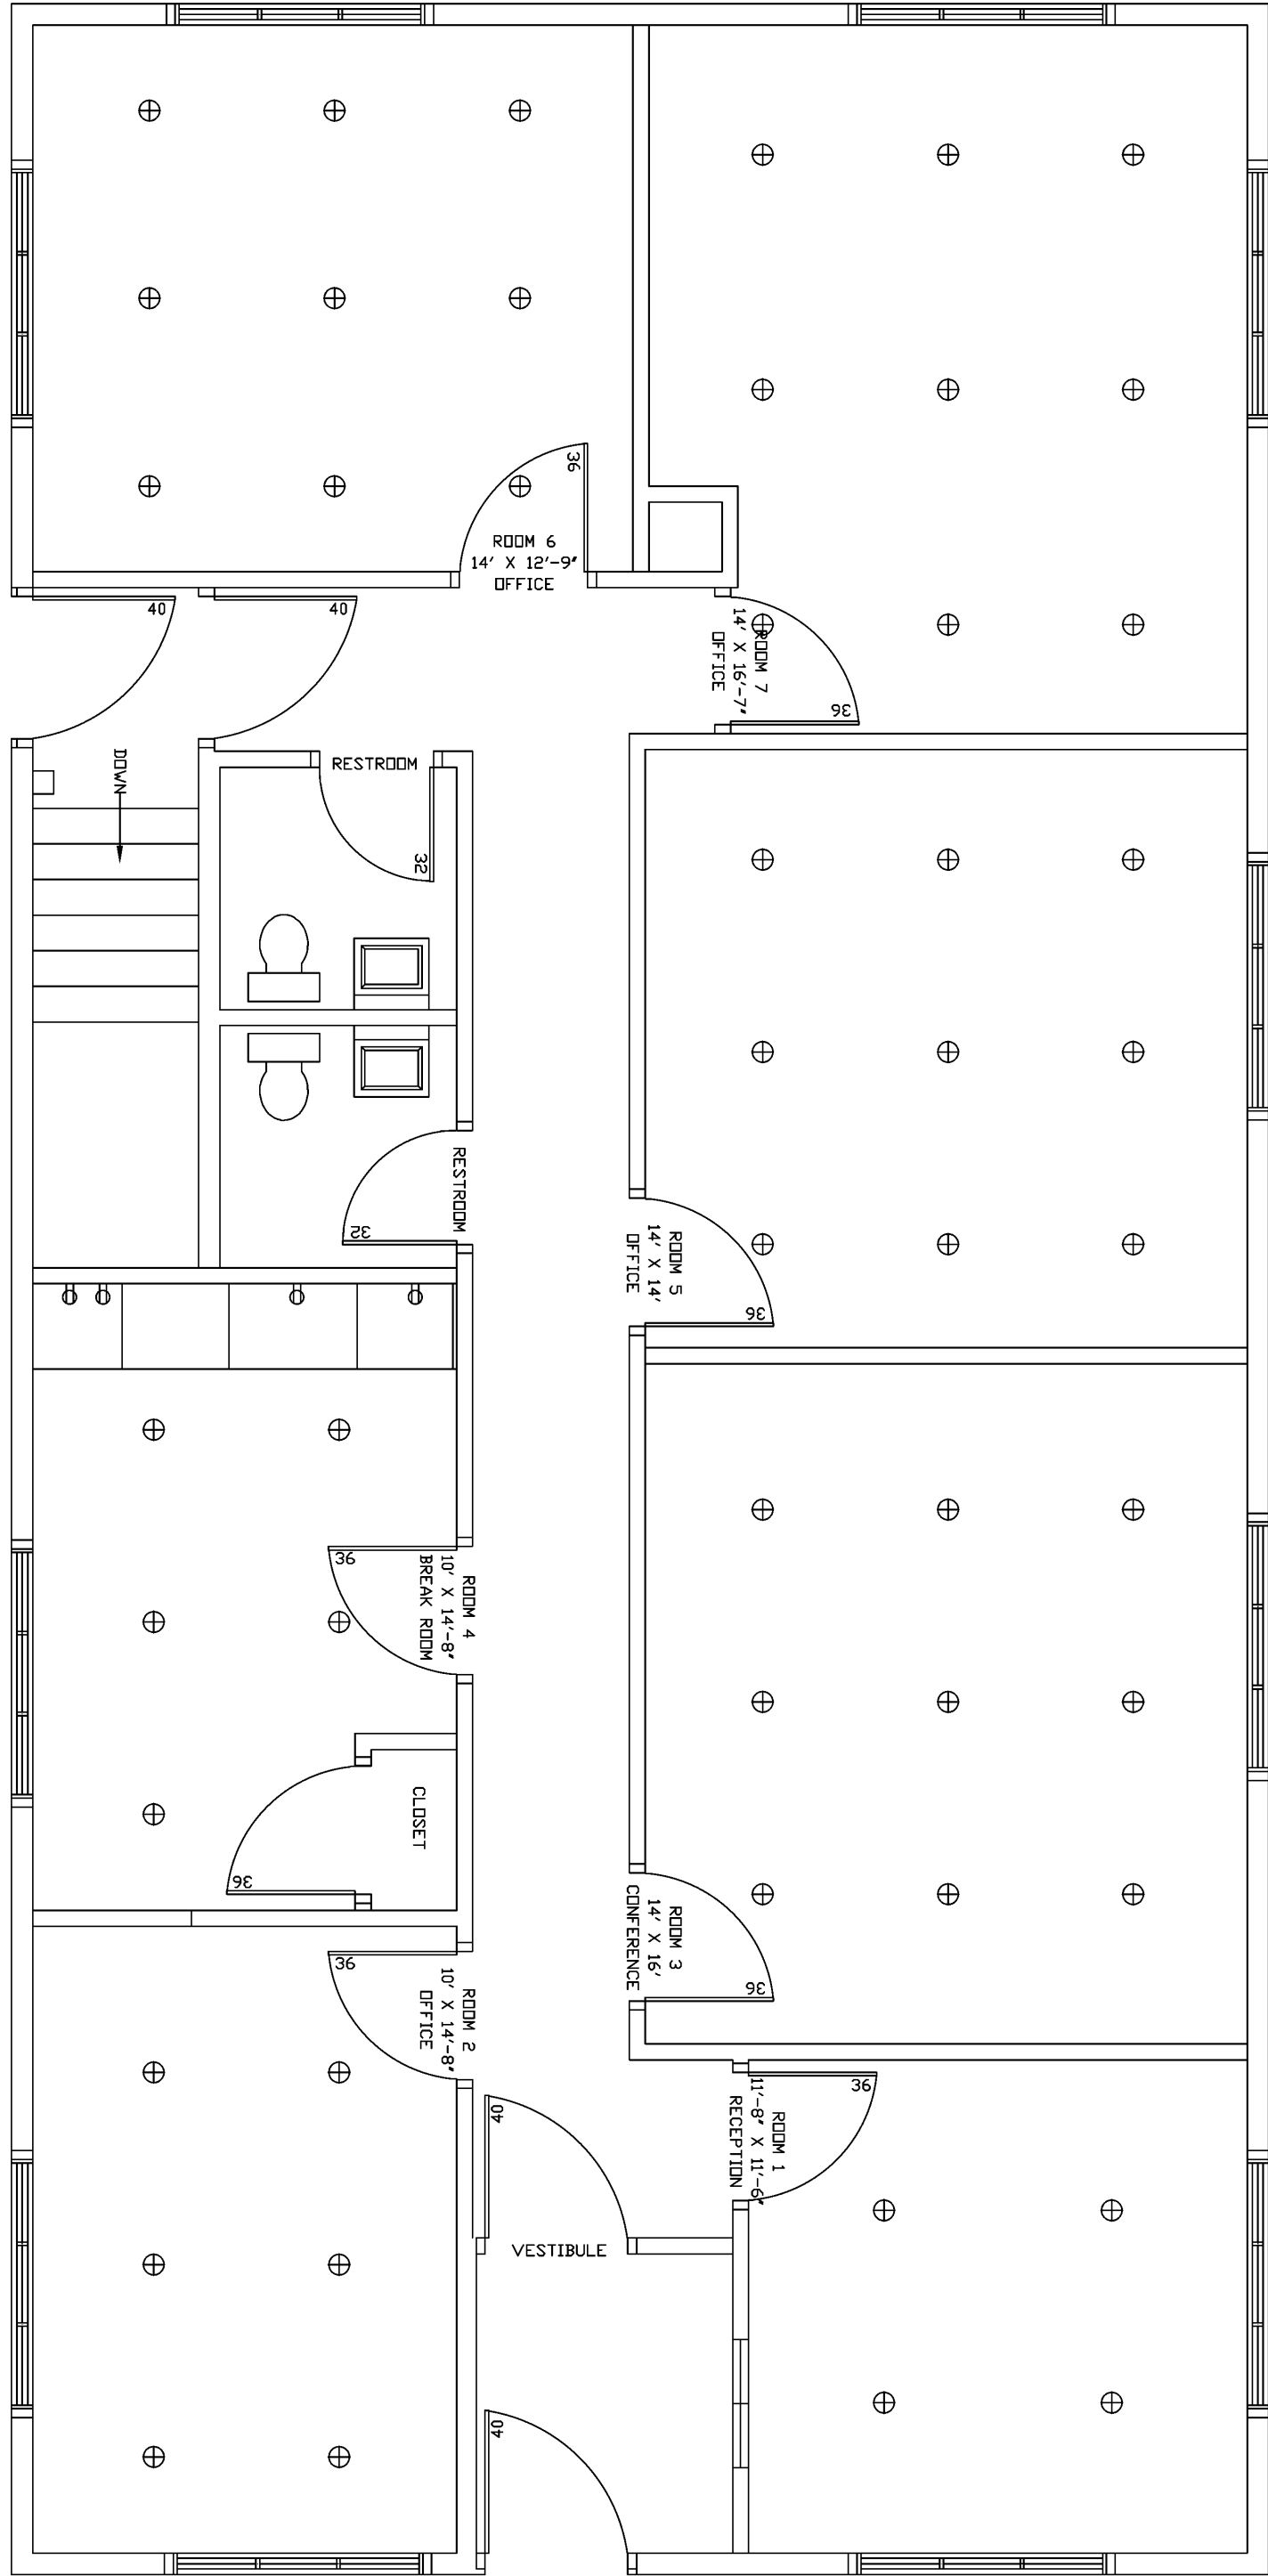

FIRST FLOOR ELECTRICAL PLAN



AP DESIGN
2722 NORTH 21ST STREET
SHEBOYGAN, WISCONSIN

OFFICE UPDATE

FIRST FLOOR
PLAN &
ELECTRICAL
PLAN

Date
JULY 1, 2025
Scale
1/4"=1'-0"
Sheet
1/1