

Video Surveillance

MCAM 32C-H5A-4MH-30 1

Infrastructure


SMC NETWAYSP4BTWPX 1

LUMINAIRE SCHEDULE										
TYPE	DESCRIPTION	TYPE	VOLTS	WATTS / FITTURE	MANUFACTURER	MANUFACTURER NUMBER		MOUNTING	MANUFACTURER	MANUFACTURER NUMBER
						BASIS OF DESIGN OR ENGINEER APPROVED EQUAL				BASIS OF DESIGN OR ENGINEER APPROVED EQUAL
S1	AREA LIGHT - DUAL MOUNTING (2 AT 180°)	LED	120-277 VAC	277	LITHONIA LIGHTING	55X1 LED P5 40K 70CRI T3M HVOLT SPA ULTRA2 P19W HS DOB80		POLE	LITHONIA LIGHTING	55S QS 16 4G 0H28AS DOB80
S2	AREA LIGHT - SINGLE MOUNTING	LED	120-277 VAC	277	LITHONIA LIGHTING	55X1 LED P5 40K 70CRI T3M HVOLT SPA ULTRA2 P19W HS DOB80		POLE	LITHONIA LIGHTING	55S QS 16 4G 0H19AS DOB80

LUMINAIRE SCHEDULE

KEY NOTES

- STUB-OUT, CAP UNDERGROUND AND MARK, FOR FUTURE AUTOMATIC GATE. COORDINATE FINAL LOCATION WITH OWNER.
- STUB-OUT, CAP UNDERGROUND AND MARK, FOR FUTURE PARKING KIOSK. COORDINATE FINAL LOCATION WITH OWNER.
- STUB-OUT, CAP UNDERGROUND AND MARK, FOR FUTURE RECEIPTABLE.
- ROUTE RECEPTACLE CONDUITS AS SHOWN, ALONG CENTER LINE OF PARKING SPACES.
- COORDINATE WITH AVISTA TO FURNISH AND INSTALL STANDARD ARM MOUNTED CORBA HEAD LUMINAIRE WITH TYPE IV LIGHT DISTRIBUTION PATTERN. COORDINATE WITH OWNER AND ENGINEER TO DETERMINE FINAL ORIENTATION, HEIGHT, AND WATTAGE SELECTOR SWITCH SETTING.

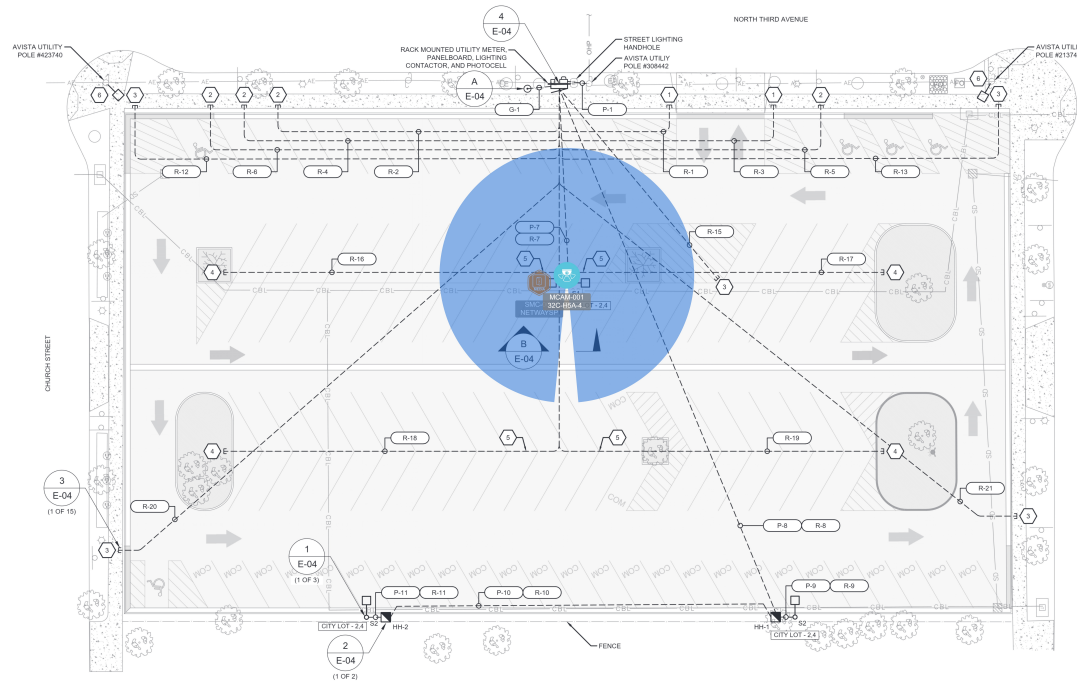

1 ELECTRICAL PLAN
1/16\" = 1'-0\"

REUSE OF DOCUMENTS

THIS DRAWING AND THE DESIGNS INCORPORATED HEREIN, AS AN INSTRUMENT OF PROFESSIONAL SERVICE, IS THE PROPERTY OF CENTURY WEST ENGINEERING CORPORATION, AND IS NOT TO BE USED, IN WHOLE OR IN PART, FOR ANY OTHER PROJECT WITHOUT THE WRITTEN CONSENT OF CENTURY WEST ENGINEERING CORPORATION.

© CENTURY WEST ENGINEERING CORPORATION



VERIFY SCALES
BAR IS ONE INCH ON ORIGINAL DRAWING.
IF NOT ONE INCH ON THIS SHEET, ADJUST SCALES ACCORDINGLY.

NO.	DATE	BY	APPR	REVISIONS
0	3/26/25	JR	GW	ISSUED FOR BIDS



SANDPOINT OFFICE
102 S. BULLOCK AVE., SUITE 107
SANDPOINT, ID 83864
208.949.4380

DATE: MARCH 2025

PROJECT NO: 51004.006.01

DESIGNED BY: GW
DRAWN BY: JTR
CHECKED BY: SAG
SCALE: AS NOTED

CITY OF SANDPOINT
PARKING LOT IMPROVEMENTS 2025

ELECTRICAL
PLAN

DRAWING NO
E-03
SHEET NO.
3 OF 5

Ednetics

Rylin DUKES

City of Sandpoint

City of Sandpoint

City of Sandpoint - Parking Lot
(Option Two)

7/22/2025