


NOTES:
FOR ACCURATE RIGHT OF WAY DATA, CONTACT
RIGHT OF WAY ENGINEERING AT THE DISTRICT OFFICE.

- 12" HDPE PIPE
INLET
FLOW DIRECTION
DRAINAGE SYS
DRAINAGE ITEM

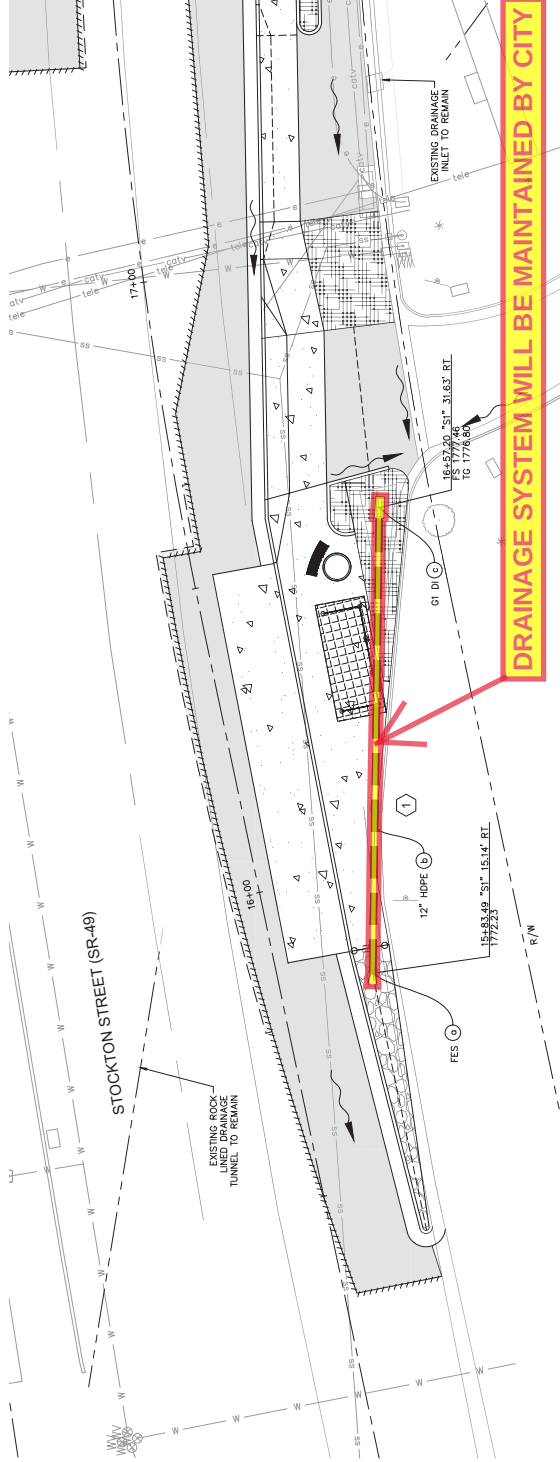


DRAINAGE SYSTEM WILL BE MAINTAINED BY CITY

1800	1741	1775.4	1776.9	1778.5	1800
1795					1795
1792					1792
1788					1788
1784					1784
1780					1780
1776					1776
1772					1772
1768					1768
1764					1764
1760					1760
1756					1756
1752					1752
1750					1750

- (a) FES PER CALTRANS Std PLAN D94A
- (b) 73' x 12" HDPE
- (c) DI (TYPE G1) PER CALTRANS Std PLAN D73B, H = 5.25
GATE TYPE 24-9 PER CALTRANS Std PLAN D73A

DRAINAGE SYSTEM No. 1
HORZ SCALE: 1"=10'
VERT SCALE: 1"=10'

 EXHIBIT A-4



Call before you dig.



APPROVED FOR DRAINAGE WORK ONLY

Kimley»Horn

4637 CHABOT DRIVE, STE 300 PLEASANTON, CA 94588
PHONE: 925-398-4840
WWW.KIMLEY-HORN.COM



FOR REDUCED PLANS
ORIGINAL SCALE IS IN INCHES

**STOCKTON-WASHINGTON CORRIDOR -
DOWNTOWN TRANSIT & ACCESSIBILITY PROJECT**

DRAINAGE PLANS AND PROFILE

Encroachment Permit 10-1K590
10-TU0-49 17.8/18.0

Drawing No.

Sheet 04 of 04
DR-01

Rev.	Description	Date
------	-------------	------