




51 Essex Street . San Antonio . TX 78210
 P.210.943.3777 E. info@creoarc.com
 www.creoarc.com

Design Team
 Consultant Essential Light Design Studio
 Address 3027 Clover Street
 Address Dallas, TX 75226
 Phone (972)415-8655
 Fax
 e-mail jill@essentiallight.com
 Consultant
 Address
 Address
 Phone
 Fax
 e-mail

Lighting Legend

- Wall Mounted Adjustable
- ⊙ Wall Mounted Ceiling Wash
- ⊙ Ceiling Mounted Adjustable
- ⊙ Ceiling Mounted Wallwash
- ⊙ Recessed Adjustable Accent
- Recessed Fixture
- ⊙ Recessed Wall Washer
- ⊙ Recessed Double Wall Washer
- ⊙ Recessed Corner Wall Washer
- ⊙ Wall Mounted Fixture
- ⊙ Stake Mounted Fixture
- ⊙ Surface Mounted Fixture
- ⊙ Decorative Wall Sconce
- ⊙ Decorative Pendant, Chandelier or Ceiling Mount
- ⊙ Decorative Table or Floor Lamp
- PAR Cove Lighting
- Linear Lighting (Horizontal)
- Linear Lighting (Vertical)
- Track Fixture
- Fluorescent Strip
- Recessed 1x4
- Recessed 2x2
- Recessed 2x4
- ▨ Recessed 1x4 with louver
- ▨ Wall Mounted Linear Strip w/Lens
- ▨ Suspended Linear
- ▨ Fiber Optic Illuminator - must be accessible
- ⊙ Stem Mounted Rectangular Accent
- ⊙ Ceiling Mounted Rectangular Accent
- ⊙ Recessed Rectangular Wall Washer
- ⊙ Step Light
- ⊙ Well Light
- ⊙ Stake Mounted Adjustable
- ⊙ Stake Mounted Horiz/Linear/Adjustable
- ⊙ Fan with Light Kit
- ⊙ Pole Mounted Single Head
- ⊙ Pole Mounted Double Head - Back to Back
- ⊙ Bollard
- ⊙ Exit Sign
- ⊙ Remote Transformer (xxx=VA Rating)
- ⊙ Dimmed Floor Receptacle (NEMA 6-20R Note 2)
- ⊙ Dimmed Duplex Receptacle (NEMA 6-20R Note 2)
- ⊙ Wallbox Dimmer or Switch
- ⊙ Remote Keypad
- ⊙ Partition Control
- ⊙ Lighting Control Panel - Dimmer Rack

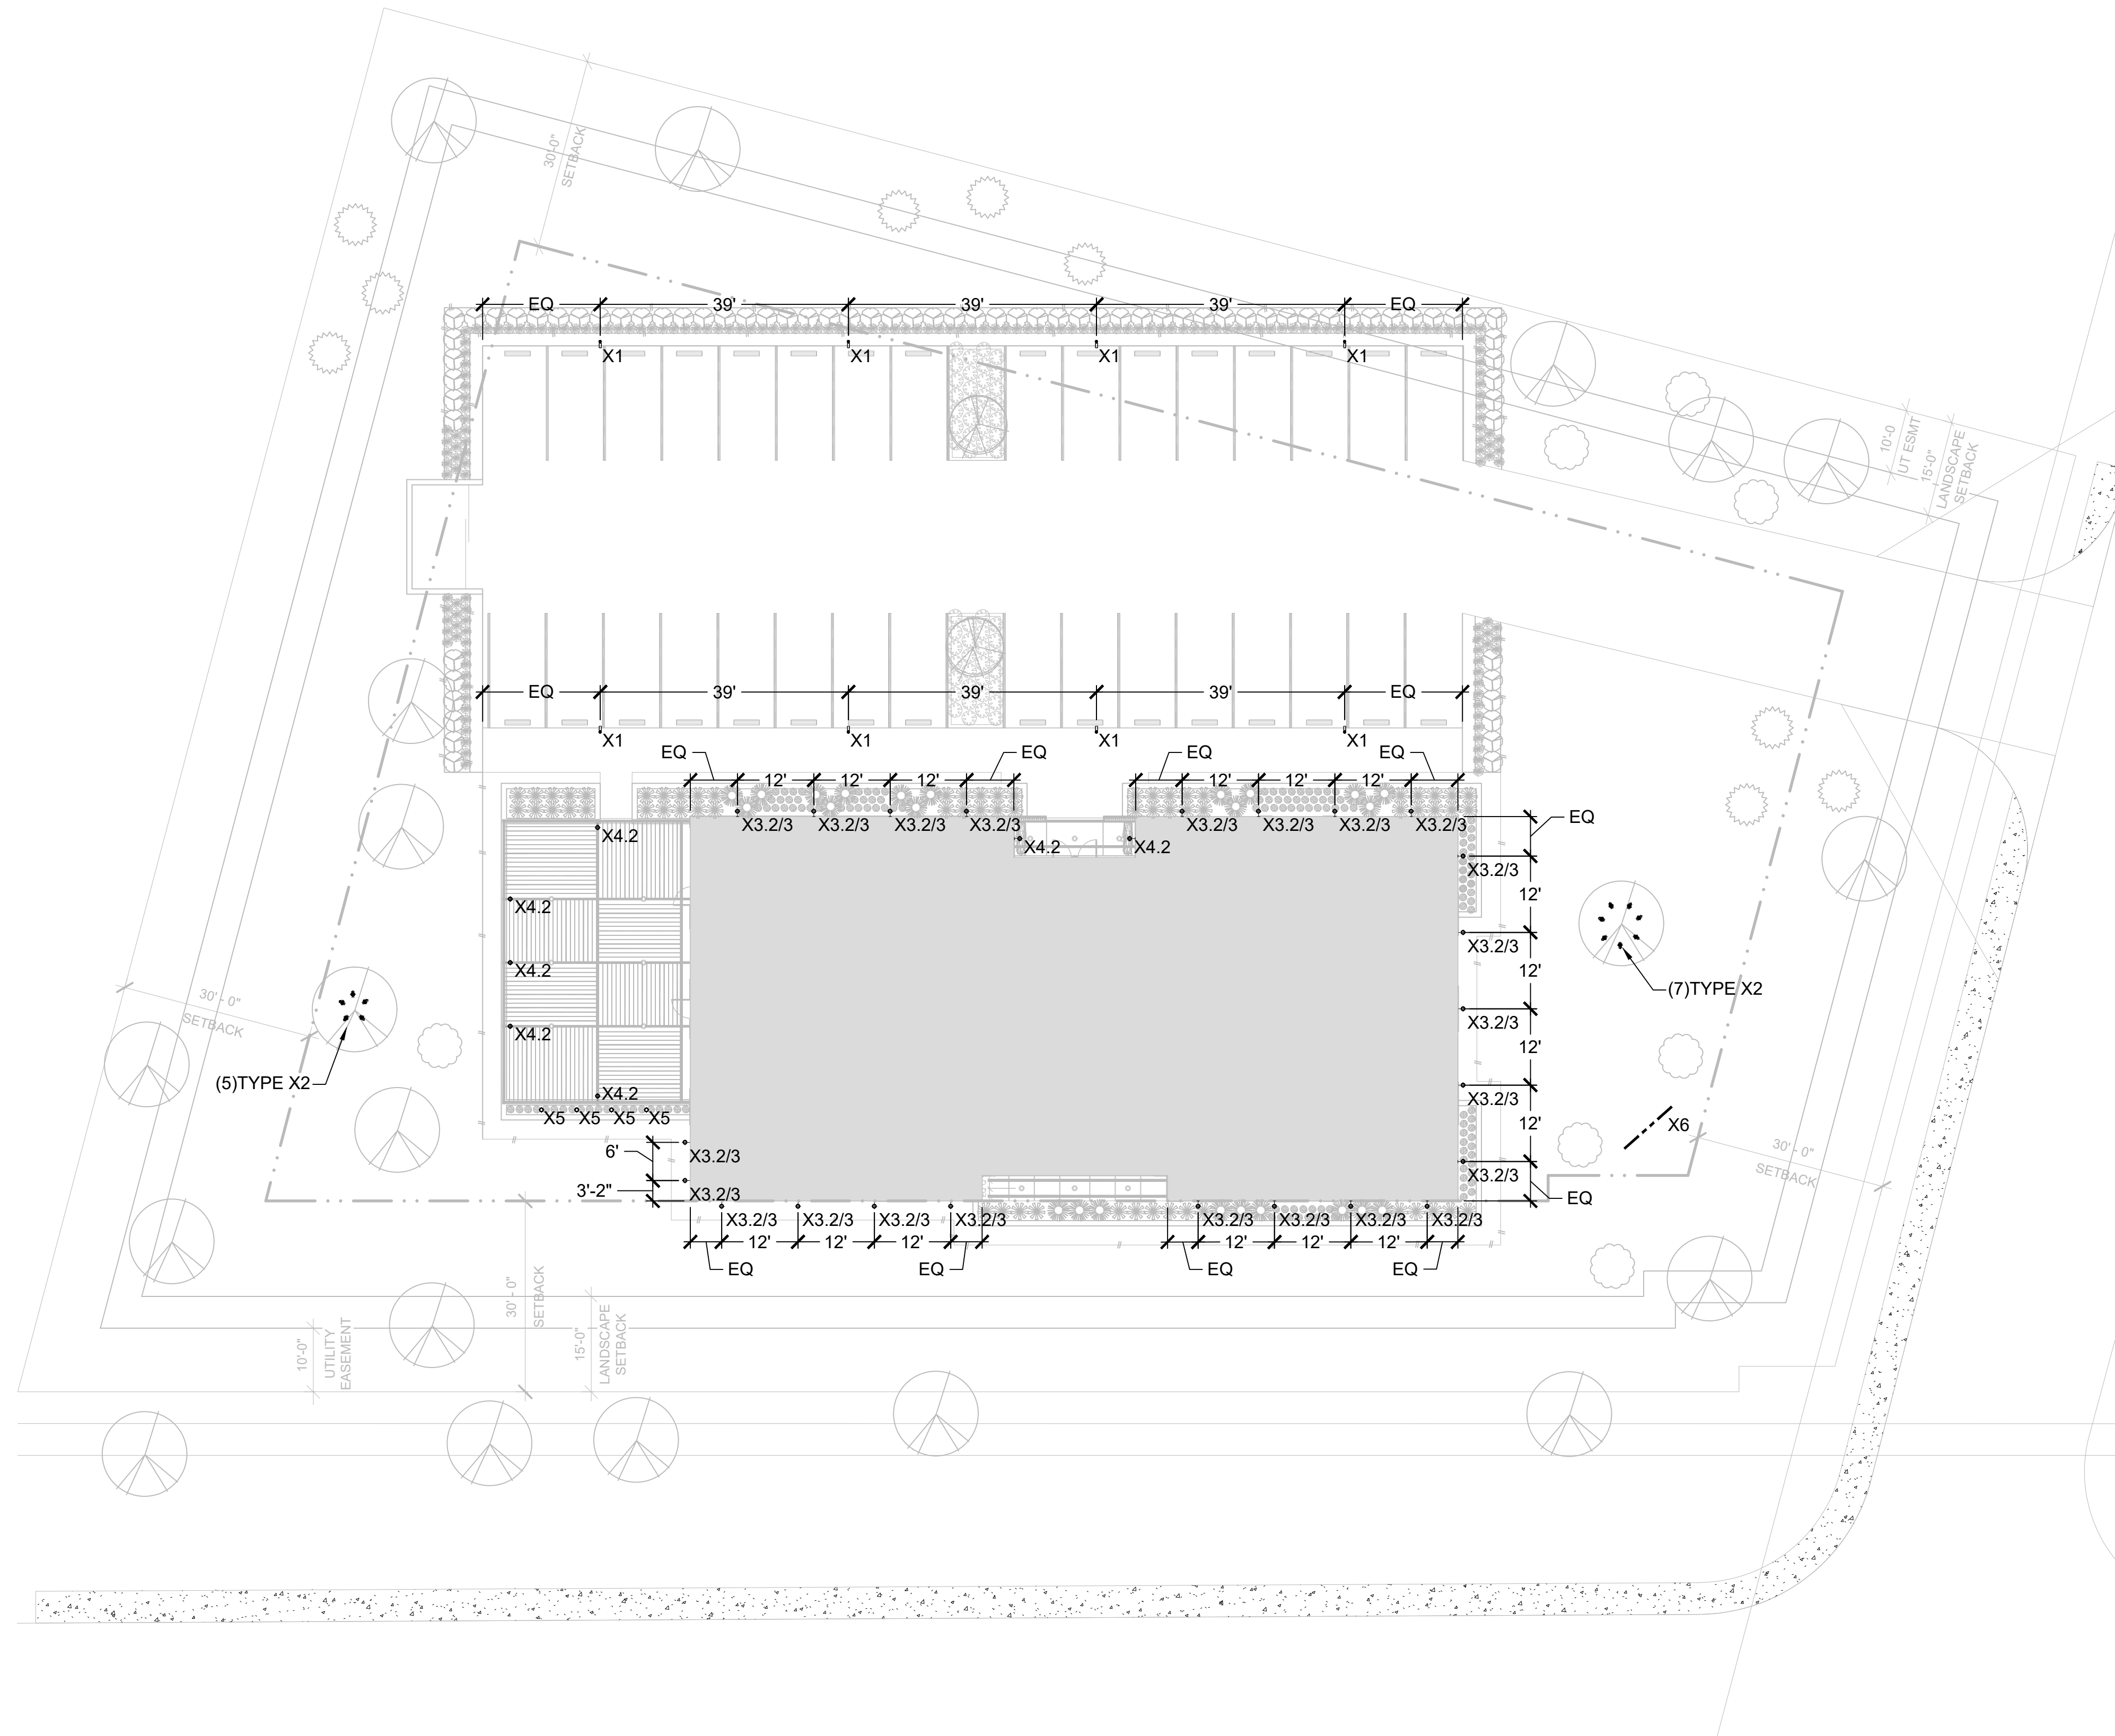

① SITE LIGHTING PLAN - BUILDING FACADE OPTION 2
 1/16" = 1'-0"

CLIENT
NAME: Justin Haschke
ADDRESS: FM 988 NW & Pecan Hill Dr.
 PROJECT
Stephenville Office



ARCHITECT STAMP

NOT FOR CONSTRUCTION
 FOR PD REGULATORY
 APPROVAL ONLY

REVISIONS

No.	Description	Date
1	PERMIT ISSUE	05/06/2022

SHEET TITLE
**SITE LIGHTING
 PLANS**
 DWG INFO
PROJECT: 2022-01
ISSUE DATE: 01/07/2022
DRAWN BY: DN
CHECKED BY: DN, JK
SHEET LT1.2