

HAYES FAMILY AUTO

SITE DEVELOPMENT

717 WEST MAIN STREET
WATERTOWN, WI 53094

DRAWING INDEX:

SP-1	SITE PLAN, DRAWING INDEX, SITE CALC'S.
SP-2	EROSION, CONTROL DETAILS
SP-3	LANDSCAPE PLAN & SCHEDULE
SP-4	SITE LIGHTING PLAN
A-1	EXISTING SITE PLAN
A-2	BLDG "A" MAIN FLOOR & ROOF PLANS
A-2	BLDG "A" ELEVATIONS
A-3	BLDG "A" ELEVATIONS
A-4	BLDG "B" MAIN FLOOR & ROOF PLANS
A-5	BLDG "B" ELEVATIONS
A-6	BLDG "B" ELEVATIONS

PROJECT DESCRIPTION:

DEVELOPE SITE WITH TWO NEW BUILDINGS AND EXPANDED PARKING.

LEGAL DESCRIPTION:


LOT 1, CSM 5807-33-098, DOC 1384903

EXISTING SITE INFORMATION:

SITE AREA:	30,285 S.F.	(0.69 ACRE)
BUILDING FOOTPRINT AREA:	5,774 S.F.	(9.1%)
PARKING AREA:	15,921 S.F.	(52.6%)
SIDEWALK AREA:	918 S.F.	(3.0%)
GREEN SPACE AREA:	7,672 S.F.	(25.3%)
IMPERVIOUS AREA:	22,613 S.F.	(74.7%)
BUILDING HEIGHT:	25'-8"	
ZONED:	GB - GENERAL BUSINESS	


GB - GENERAL BUSINESS

PRELIMINARY NOT
FOR CONSTRUCTION

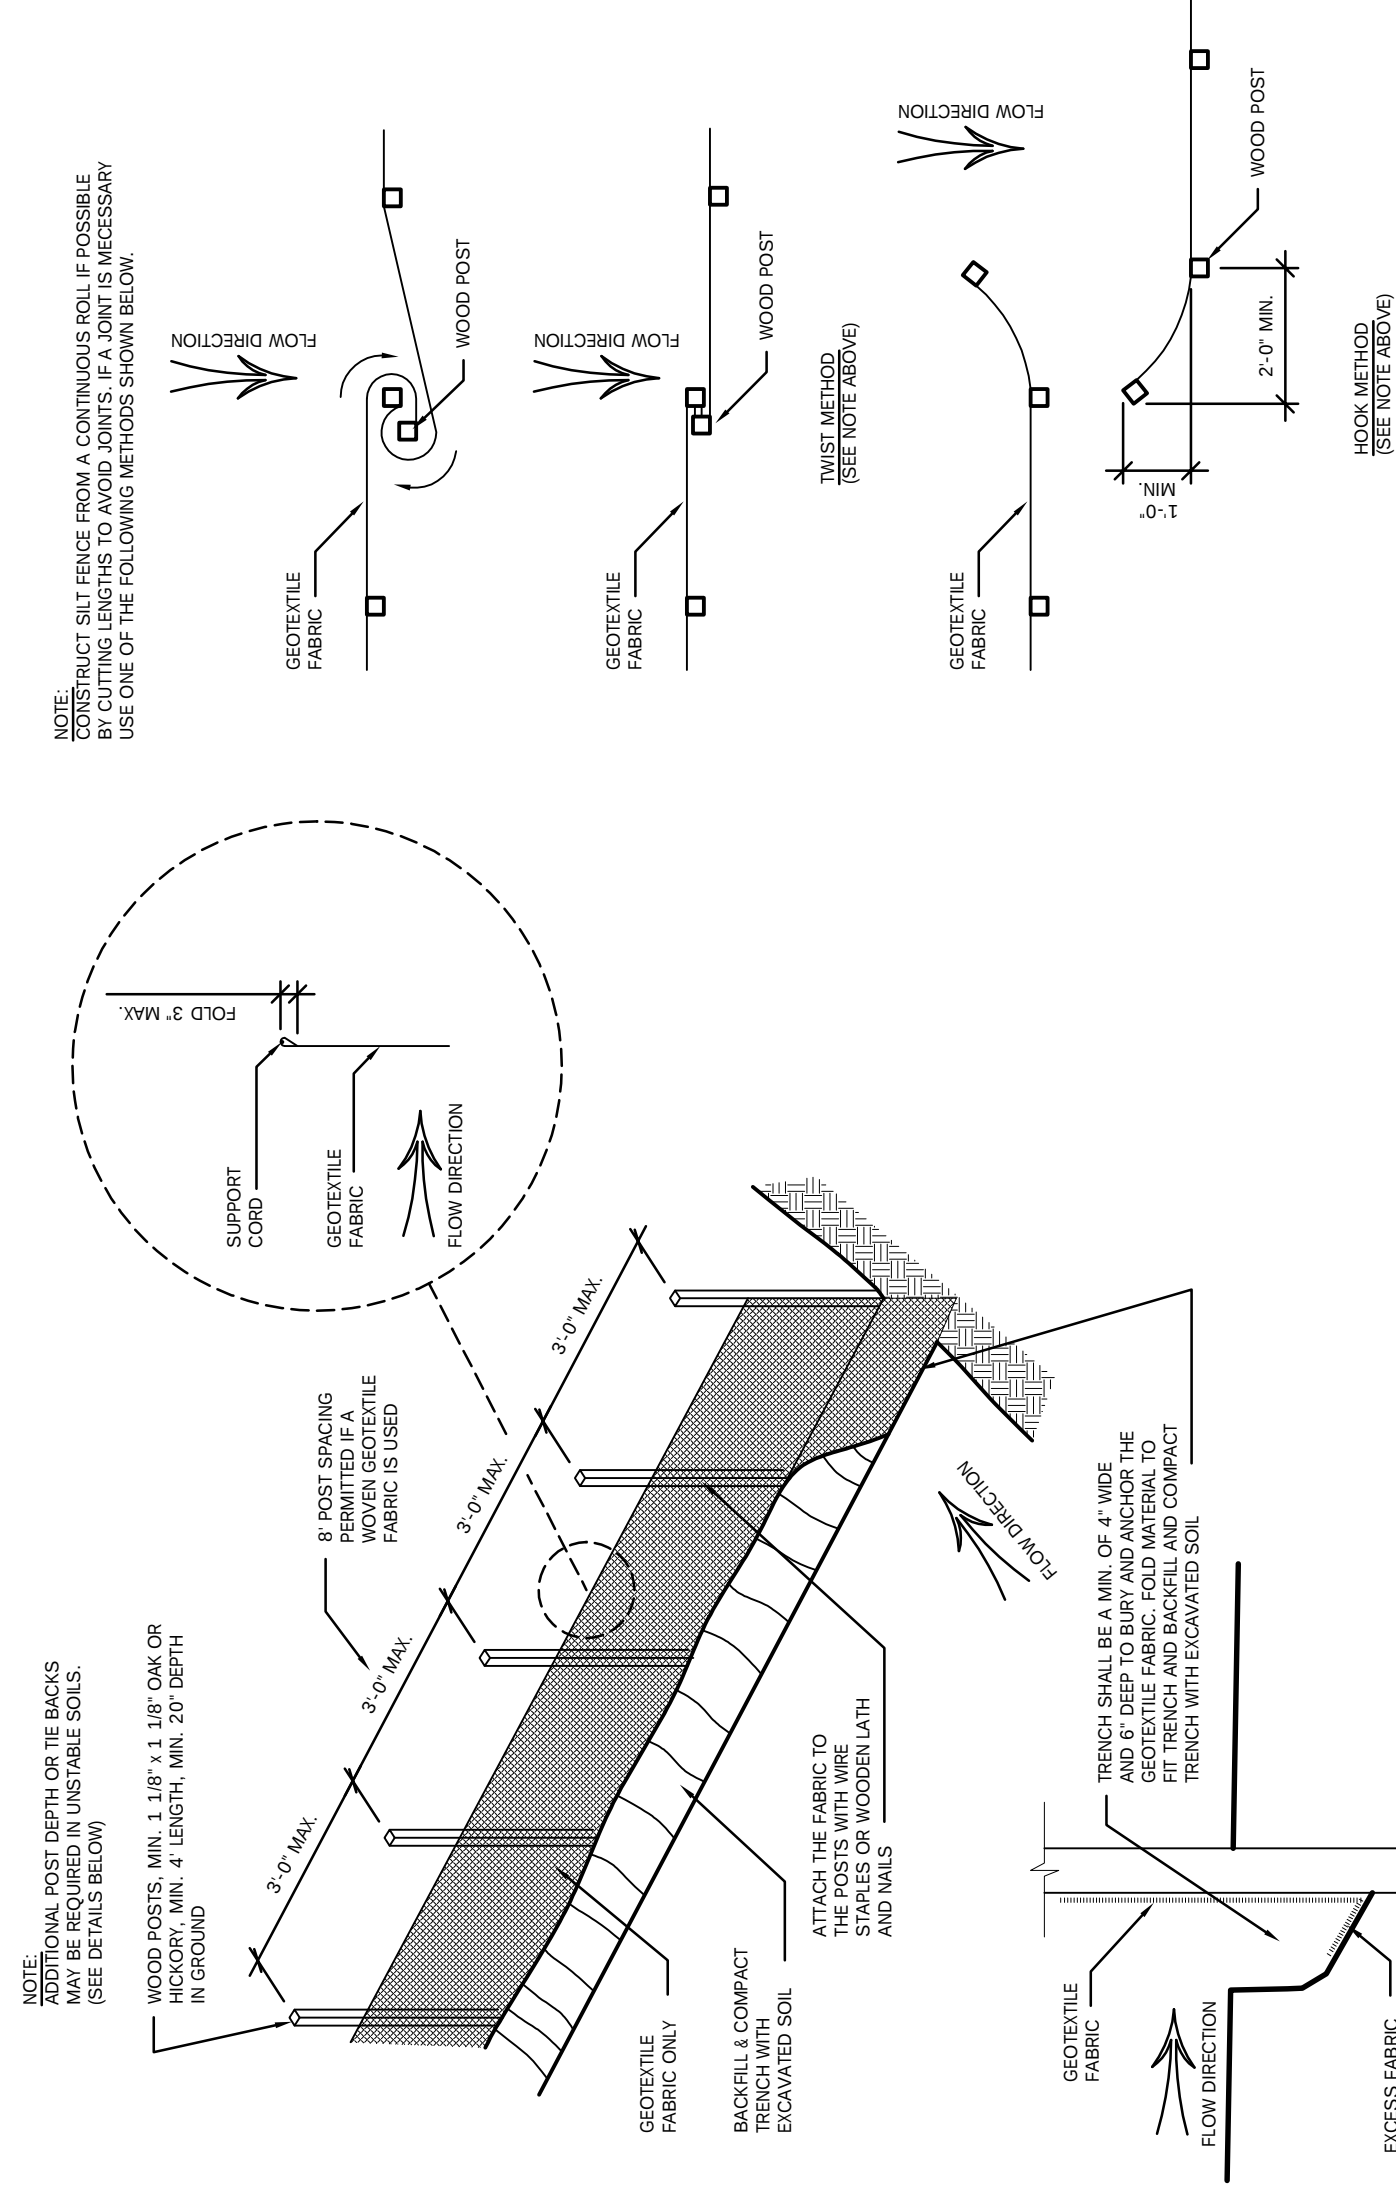

EROSION CONTROL DETAILS

2023/HAYES FAMILY AUTO/HFA-DRAWINGS.DWG
SCALE: N.T.S.
DATE: 10/4/2023

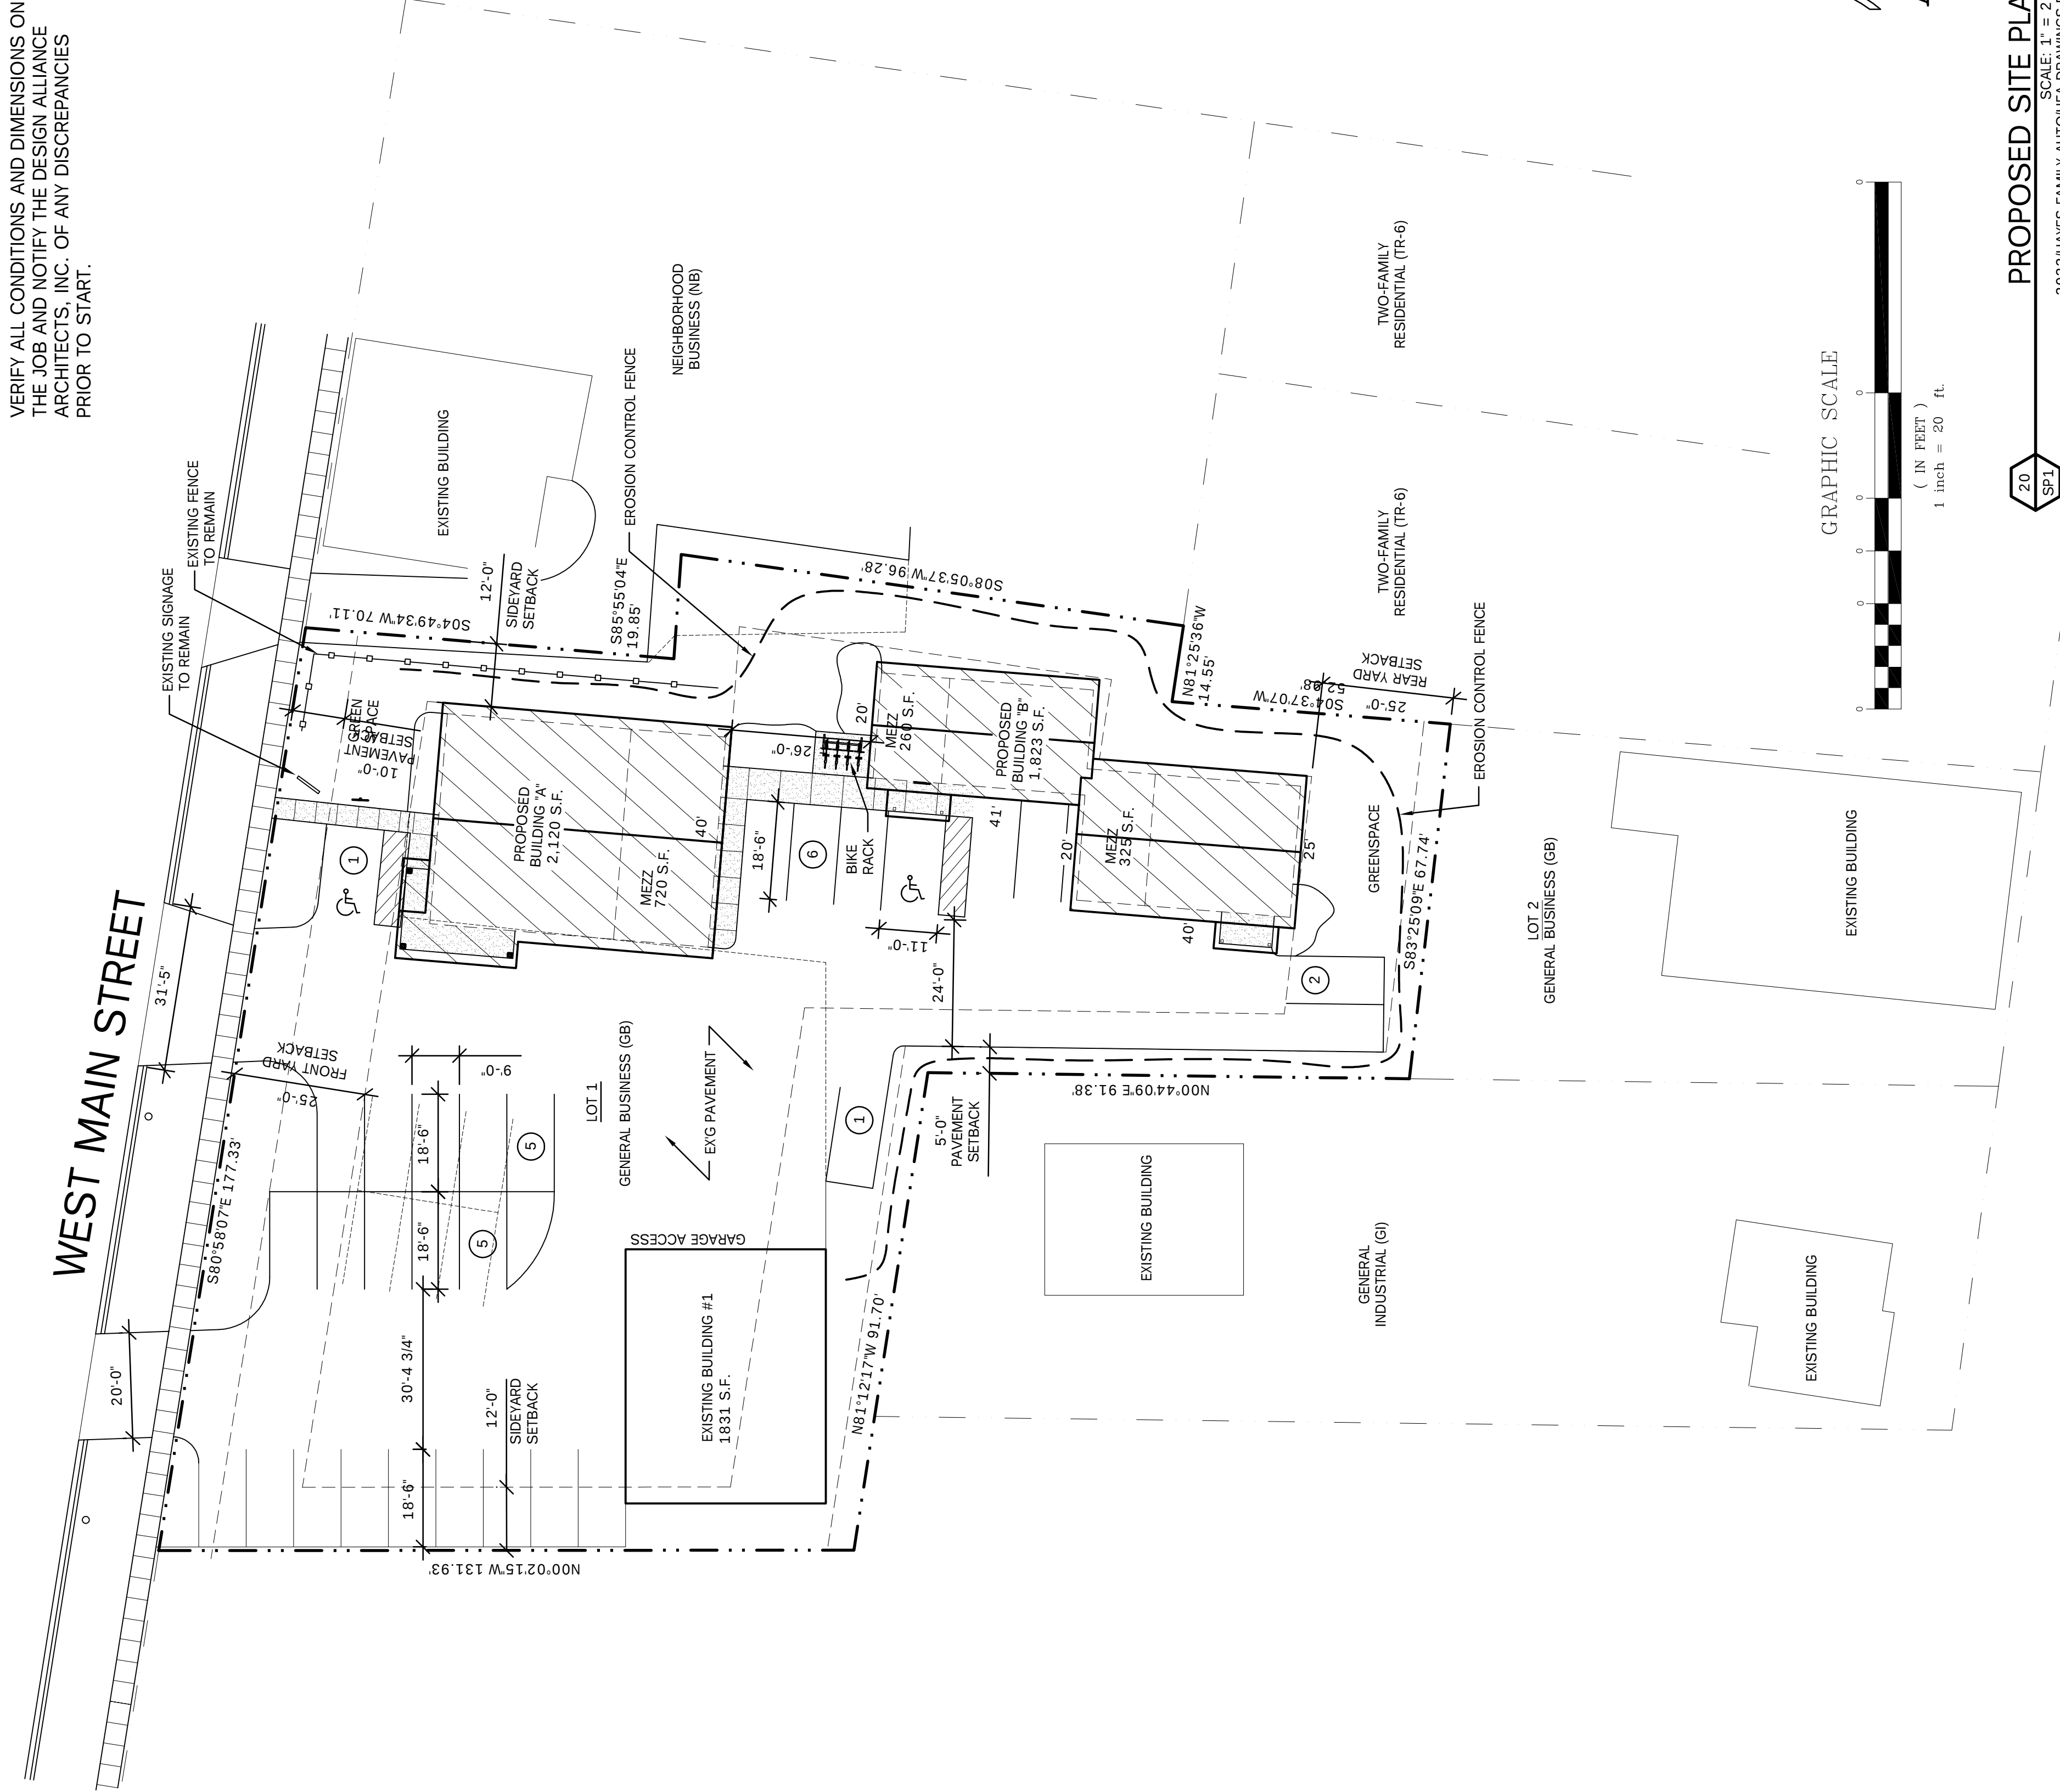

PROPOSED SITE PLAN

SCALE: 1" = 20'-0"
2023/HAYES FAMILY AUTO/HFA-DRAWINGS.DWG
DATE: 10/4/2023

HAYES FAMILY AUTO
SITE DEVELOPMENT
7717 W MAIN STREET
WATERTOWN, WI 53094

[illegible]

S-P-1

PLANTING SCHEDULE

TYPE	DESCRIPTION	PLANTING SIZE	MATURE SIZE	QUANTITY	POINTS	TOTAL POINTS
A	EXISTING LANDSCAPING					
B	EXISTING TREES TO BE REMOVED					
C	BLACK MAPLE	1 1/2" CAL	40" DIA	1	30	30
D	AMUR CHOKECHERRY	1 1/2" CAL	30" DIA	2	15	30
E	ARBOR VITAE PYRAMIDAL	4" H	6" DIA	15	12	180
F	"NORTH POLE" ARBORVITAE	15-18"H	4" DIA	24	5	120
G	VIBURNUM CARLESII	24"H	4" DIA	3	3	9
H	TAMARIX SAVIN JUNIPER	18"H	4" DIA	6	3	18
J	TAXUS TAUNTONI	12"H	4" DIA	13	3	39
K	KOREAN SPICE VIBURNUM	18"H	3" DIA	21	3	63
					TOTAL	489

LANDSCAPE REQUIREMENTS:

STREET TREES: 20 PTS PER 100' -- 177' / 100' = 1.8 x 20 = 36 POINTS
PROVIDED: 1 TALL DECIDUOUS TREE AT 30 PTS = 30 POINTS
1 MEDIUM DECIDUOUS TREE AT 15 PTS = 15 POINTS
TOTAL 45 POINTS

PAVEMENT: 40 PTS PER 10,000 S.F. -- 16,028 S.F. / 10,000 S.F. = 1.6 x 40 PTS = 64 PTS x 1.5 = 96 POINTS
PROVIDED: 1 MEDIUM DECIDUOUS SHRUB AT 3 PTS = 24 POINTS
15 MEDIUM DECIDUOUS SHRUBS AT 3 PTS = 45 POINTS
10 LOW EVERGREEN SHRUBS AT 3 PTS = 30 POINTS
TOTAL 114 POINTS

FOUNDATION: 20 PTS PER 100' -- 20 PTS = 20 PTS
BLDG "A": 66' x 100' = 11,920 PTS = 98 PTS x 1.5 = 57 POINTS
BLDG "B": 100' x 100' = 10,000 PTS = 80 PTS x 1.5 = 45 POINTS
PROVIDED: 1 MEDIUM DECIDUOUS SHRUB AT 3 PTS = 3 POINTS
1 MEDIUM DECIDUOUS SHRUBS AT 3 PTS = 9 POINTS
3 LOW EVERGREEN SHRUBS AT 3 PTS = 9 POINTS
TOTAL 57 POINTS

BLDG "B": 242' / 100' = 2.4 x 20 PTS = 48 PTS x 1.5 = 72 POINTS
PROVIDED: 1 MEDIUM DECIDUOUS SHRUB AT 3 PTS = 3 POINTS
15 MEDIUM DECIDUOUS SHRUBS AT 3 PTS = 45 POINTS
6 LOW EVERGREEN SHRUBS AT 3 PTS = 18 POINTS
TOTAL 78 POINTS

BUFFER YARD: TR-6 = 0.4 10W + 53 PTS PER 100' -- 687/100' = .68 x 53 PTS = 37 POINTS
NB: 1.0W PER 100' = 186/100' = 1.86 x 91 PTS = 170 POINTS
PROVIDED: 1 MEDIUM DECIDUOUS TREE AT 12 PTS = 12 POINTS
6 LOW EVERGREEN TREES AT 12 PTS = 72 POINTS
PROVIDED AT NB: 9 LOW EVERGREEN TREES AT 12 PTS = 108 POINTS
TOTAL 180 POINTS

GENERAL YARD: 5 PTS PER 1,000 S.F. OF TOTAL GROSS FLOOR AREA -- 5,248 S.F. / 1,000 S.F. = 5.2 x 5 = 26 PTS
PROVIDED: 1 MEDIUM DECIDUOUS TREE AT 15 PTS = 15 POINTS
EXISTING LANDSCAPING LABELED "A" SHOULD BE ADEQUATE TO FULFILL THE GENERAL YARD REQUIREMENTS

LANDSCAPE SCHEDULE & CALC'S

2023HAYES FAMILY AUTO/HFA-DRAWINGS.DWG
SCALE: N.T.S.
DATE: 10/4/2023

VERIFY ALL CONDITIONS AND DIMENSIONS ON THE JOB AND NOTIFY THE DESIGN ALLIANCE ARCHITECTS, INC. OF ANY DISCREPANCIES PRIOR TO START.


PRELIMINARY NOT FOR CONSTRUCTION



Statistics							
Description	Symbol	Avg	Max	Min	Max/Min	Avg/Min	
Calc Zone #1	+	3.5 fc	22.4 fc	0.2 fc	112.0:1	17.5:1	

Schedule						
Symbol	Label	QTY	Manufacturer	Catalog	Description	Number Lamps
	A	3	Lithonia Lighting		Existing Light Fixture on Utility Pole	1
	B	1	Lithonia Lighting		Existing Light on Building	1
	C	7	Lithonia Lighting	OLLWD LED P1 40K MVOLT	OUTDOOR LED WALL CYLINDER DOWN LIGHT & 4000K NICHIA 219C	1
	D	4	Lithonia Lighting	EML25 63LED 525MA 4K GCF R2 480	ASL EML25. LARGE BELL SHAPE CAST ALUMINUM HSG. WITH LED MODULE, TYPE 2, 4000K, 480VOLT DRIVERS.	1
	E	2	C-Lite	C-WM-A-WDG-S4L-5K (27W)	CONFIGURED FROM C-Lite LED Gooseneck without Shade, Selectable Wattage (27W), 5000K	1



 



18
A1

BUILDING "A" ROOF PLAN

SCALE: 1/4" = 1'-0"

2023HAYES FAMILY AUTOHFA-DRAWINGS DWG

 DATE: 10/4/2023

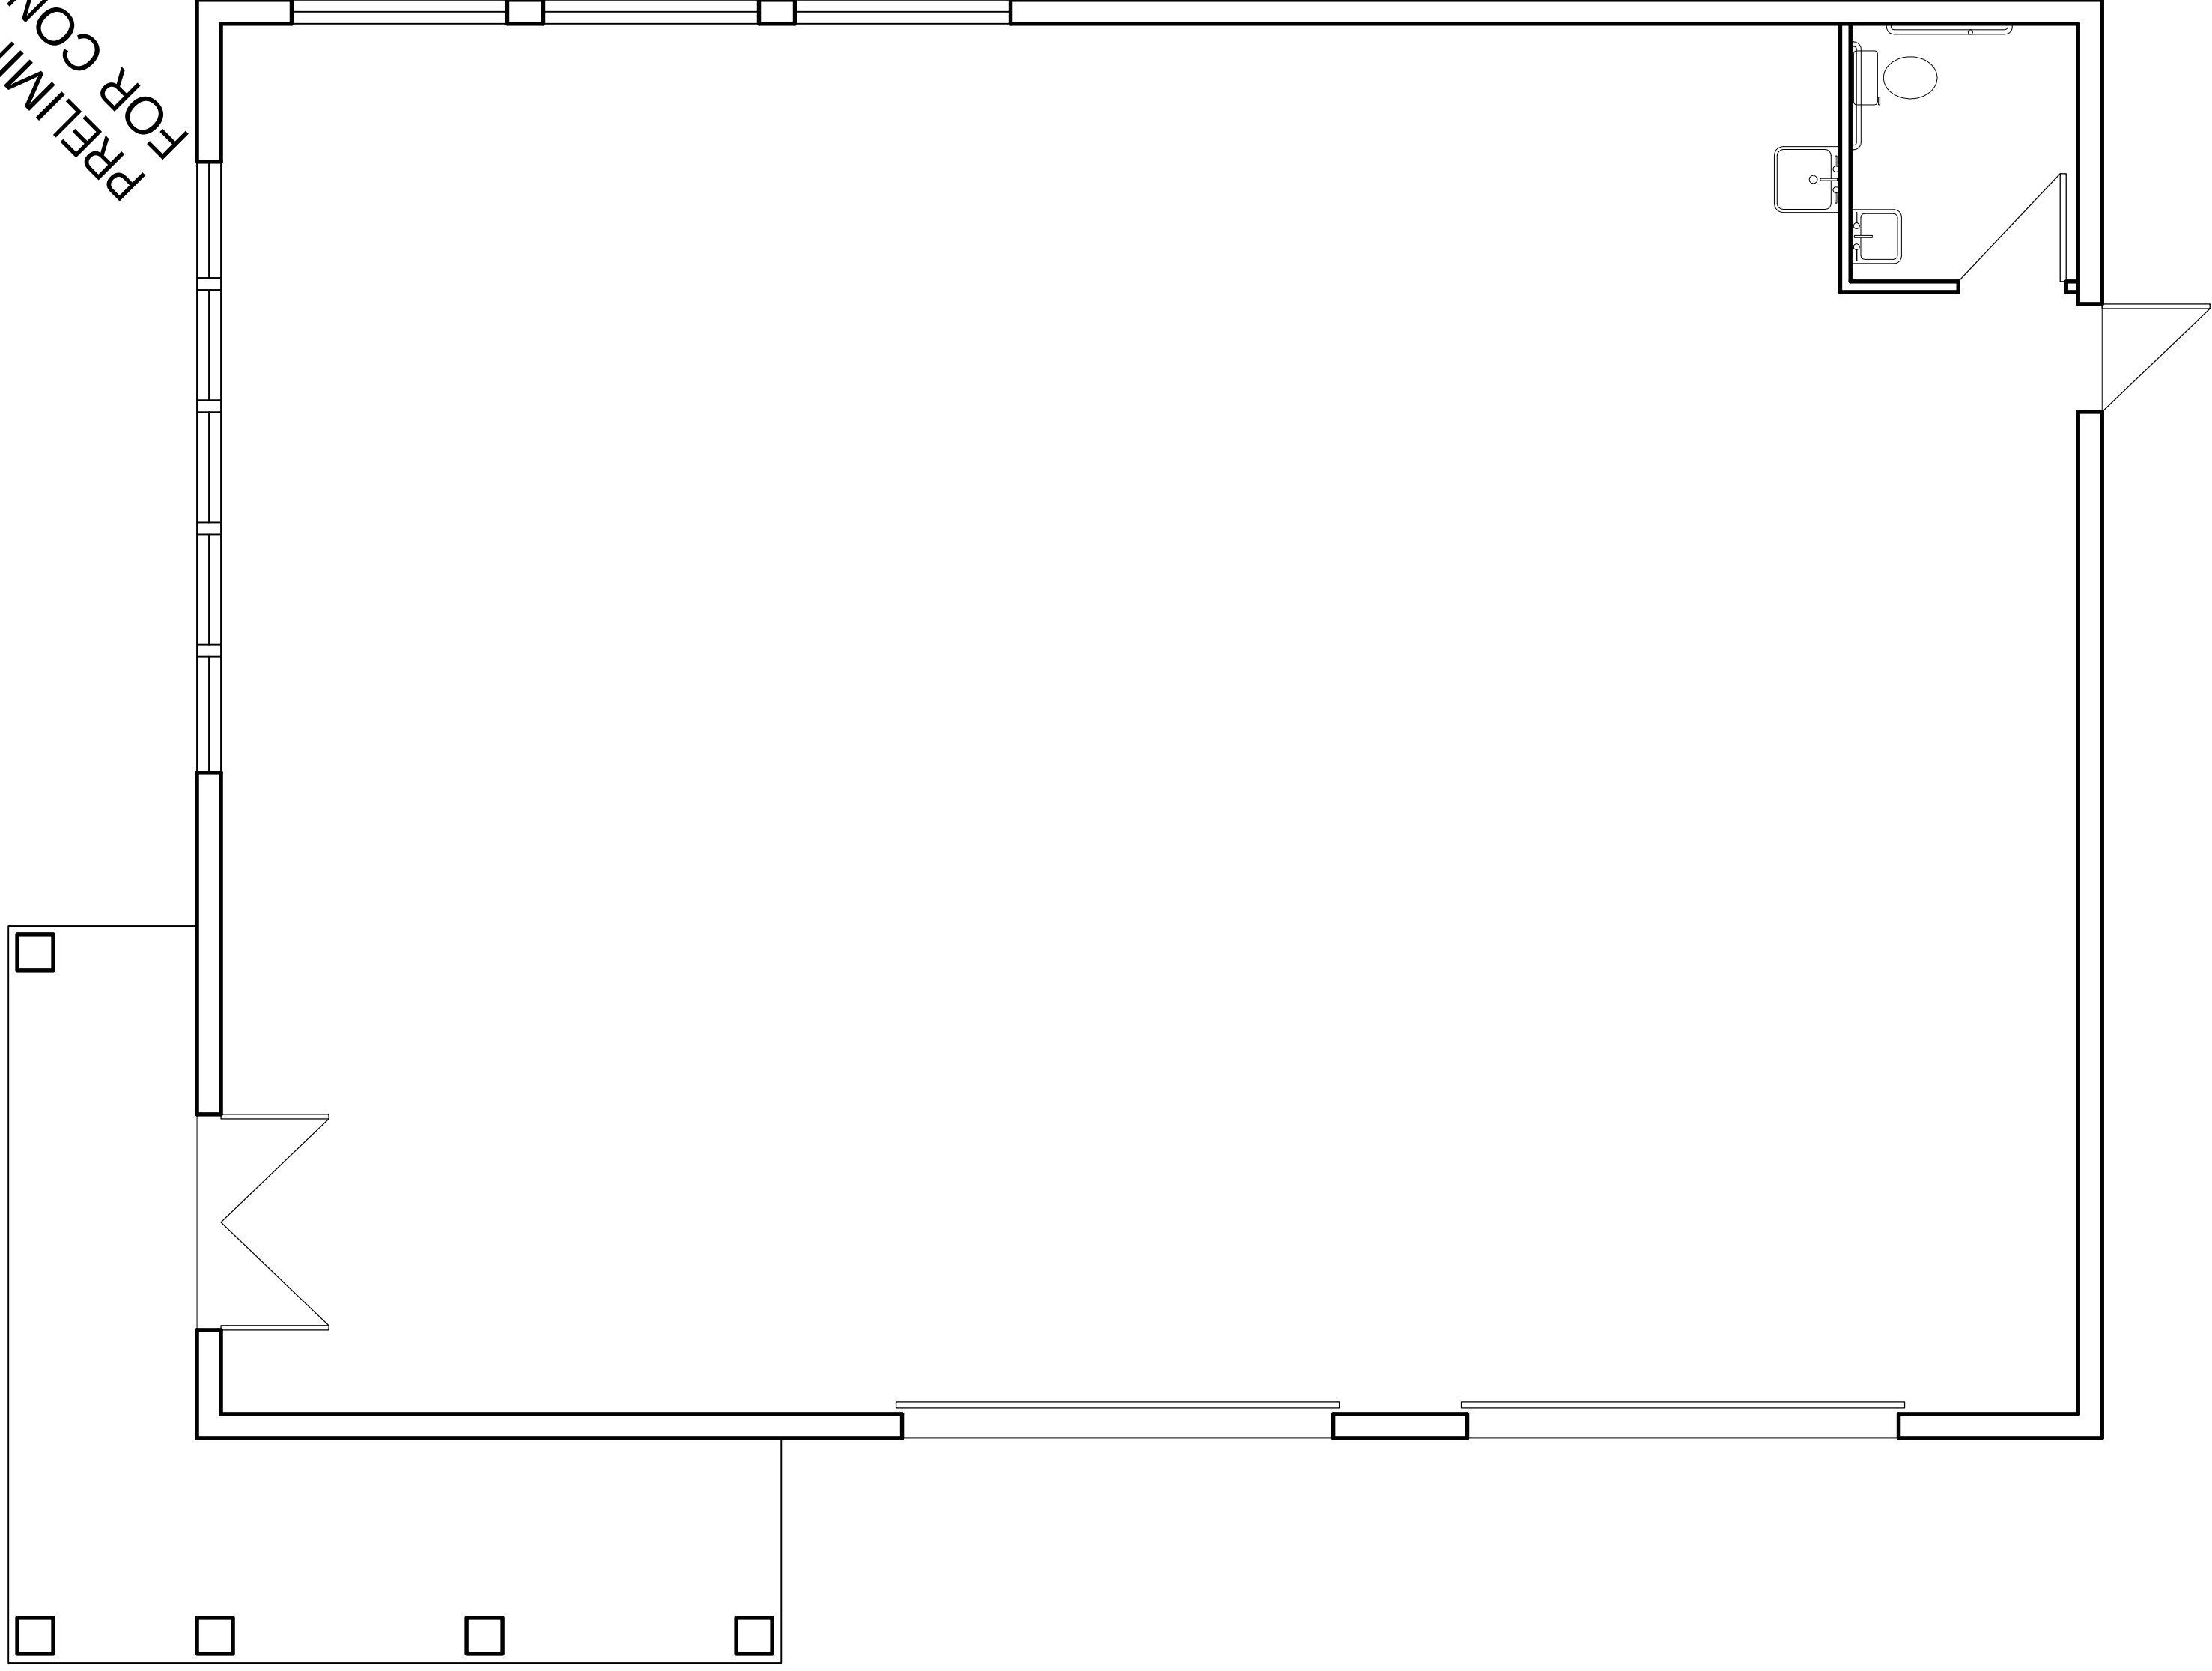


BUILDING "A" MAIN FLOOR PLAN

SCALE: 1/4" = 1'-0"

2023 HAYES FAMILY AUTO/HFA-DRAWINGS, DWG

 DATE: 10/4/2023




VERIFY ALL CONDITIONS AND DIMENSIONS ON THE JOB AND NOTIFY THE DESIGN ALLIANCE ARCHITECTS, INC. OF ANY DISCREPANCIES PRIOR TO START.

PRELIMINARY NOT
FOR CONSTRUCTION

1003 Madison Avenue Fort Atkinson, WI (920) 563-3404		HAYES FAMILY AUTO SITE DEVELOPMENT 717 W MAIN STREET WATERTOWN, WI 53094	
		DRAWING NAMES BUILDING "A" PLANS	
REVISIONS		PROJECT DATA DATE: 2/5/2024 DRAWN BY: CL CHECKED BY: P.W. SHEET NO.	
		A-1	


VERIFY ALL CONDITIONS AND DIMENSIONS ON
THE JOB AND NOTIFY THE DESIGN ALLIANCE
ARCHITECTS, INC. OF ANY DISCREPANCIES
PRIOR TO START.

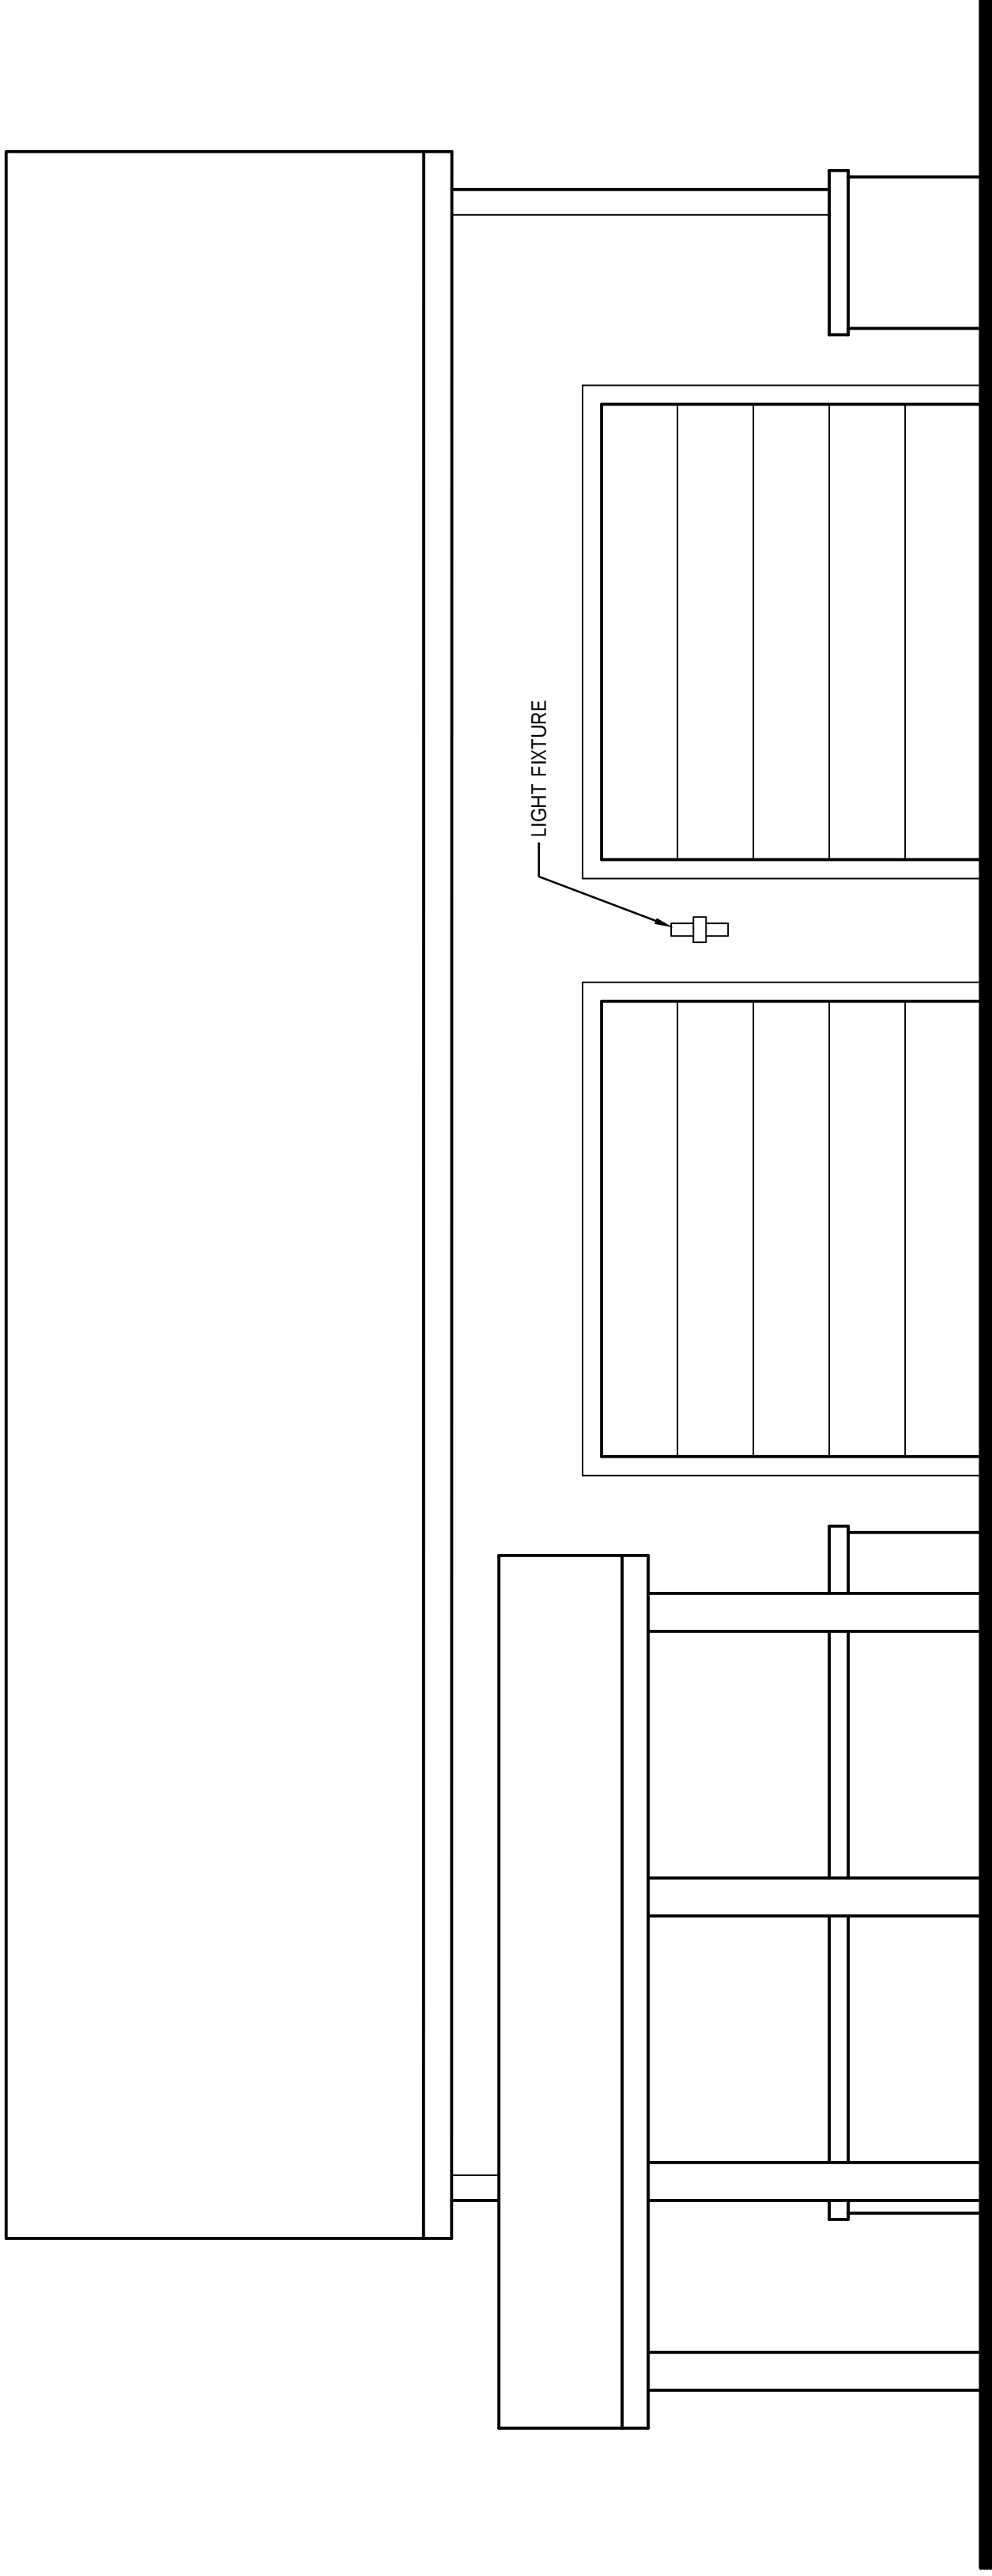

WEST ELEVATION

20 A2 BUILDING "A" WEST ELEVATION
SCALE: 1/4" = 1'-0"
2023HAYES FAMILY AUTO/HFA-DRAWINGS.DWG
DATE: 10/4/2023

PRELIMINARY NOT
FOR CONSTRUCTION

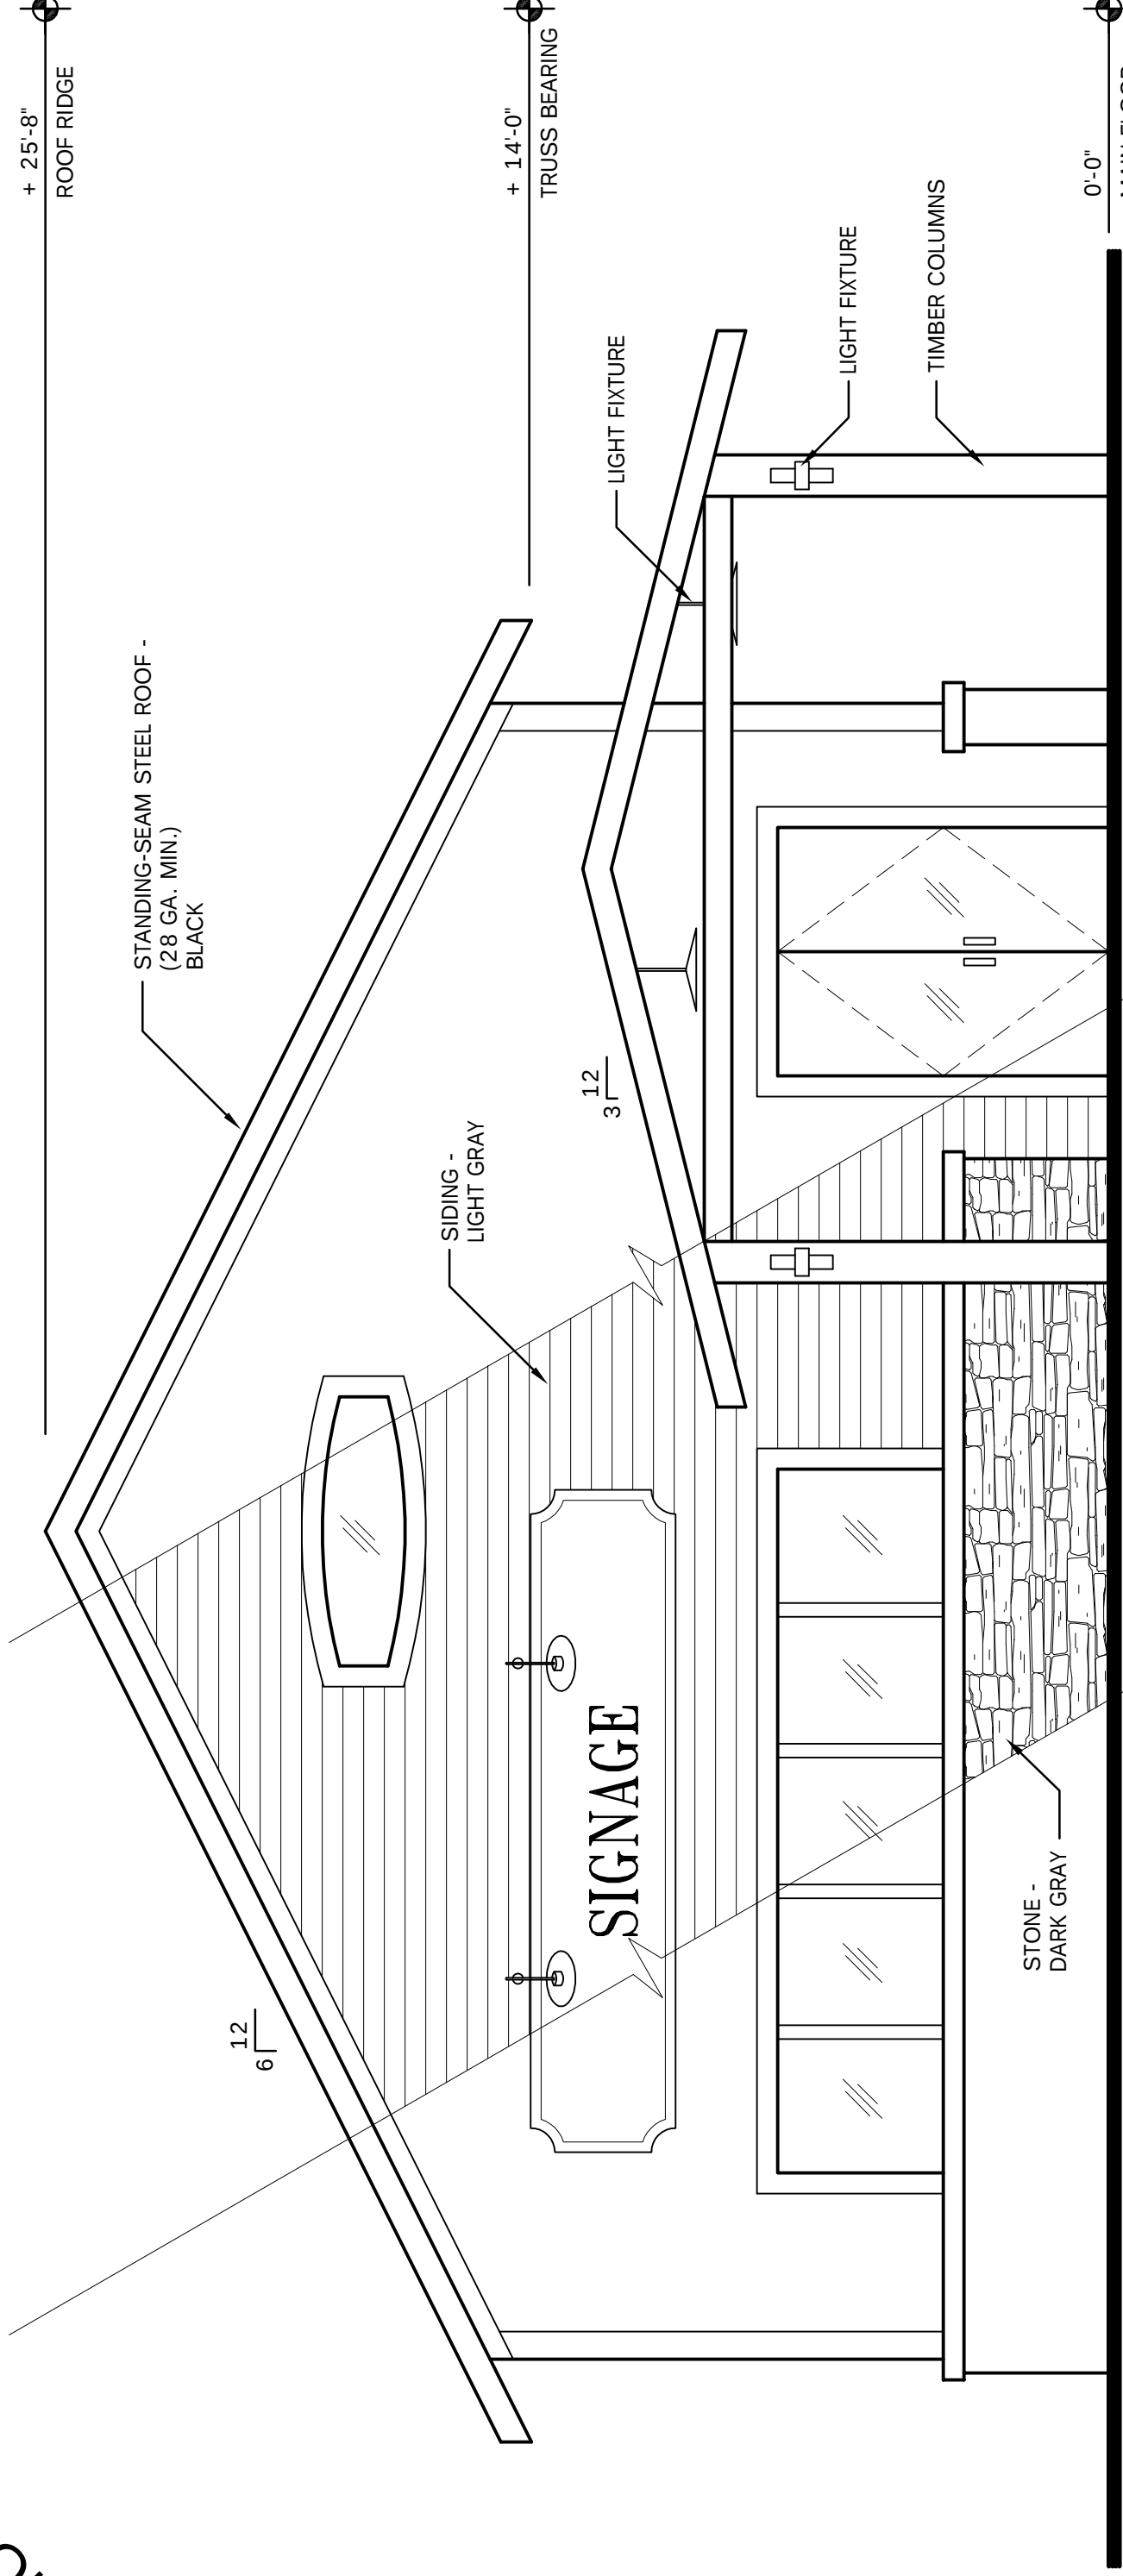

NORTH ELEVATION

20 A2 BUILDING "A" NORTH ELEVATION
SCALE: 1/4" = 1'-0"
2023HAYES FAMILY AUTO/HFA-DRAWINGS.DWG
DATE: 10/4/2023

HAYES FAMILY AUTO
SITE DEVELOPMENT
717 W MAIN STREET
WATERTOWN, WI 53094

DRAWING NAMES

BUILDING "A" ELEVATIONS

REVISIONS

PROJECT DATA

DATE: 2/5/2024

DRAWN BY: CL

CHECKED BY: P.W.

SHEET NO.


A-2

theDesign
Alliance
Architects, Inc.

1003 Madison Avenue
Fort Atkinson, WI

(920) 563-3404


VERIFY ALL CONDITIONS AND DIMENSIONS ON THE JOB AND NOTIFY THE DESIGN ALLIANCE ARCHITECTS, INC. OF ANY DISCREPANCIES PRIOR TO START.

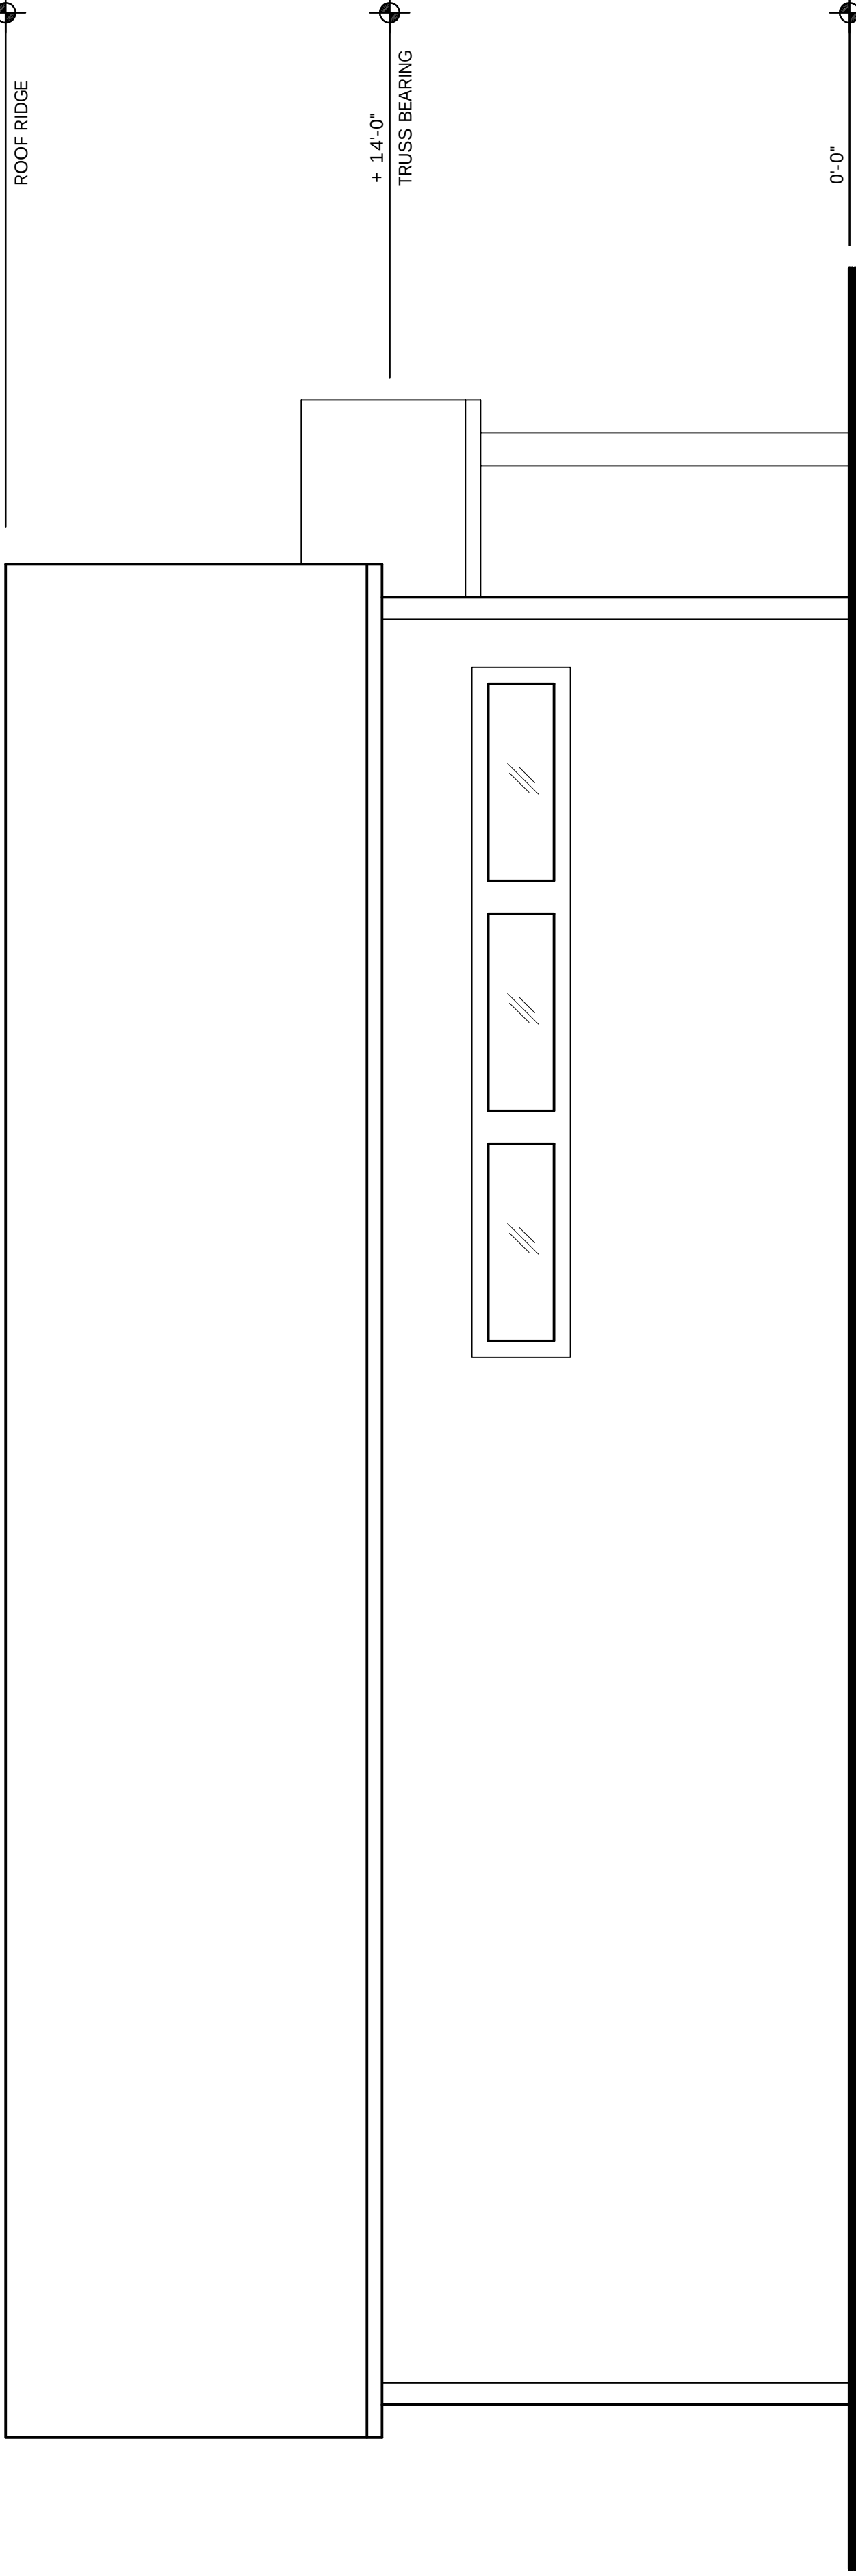

EAST ELEVATION

20 A3 BUILDING "A" EAST ELEVATION
SCALE: 1/4" = 1'-0"
2023HAYES FAMILY AUTOHFA-DRAWINGS.DWG DATE: 10/4/2023

PRELIMINARY NOT
FOR CONSTRUCTION

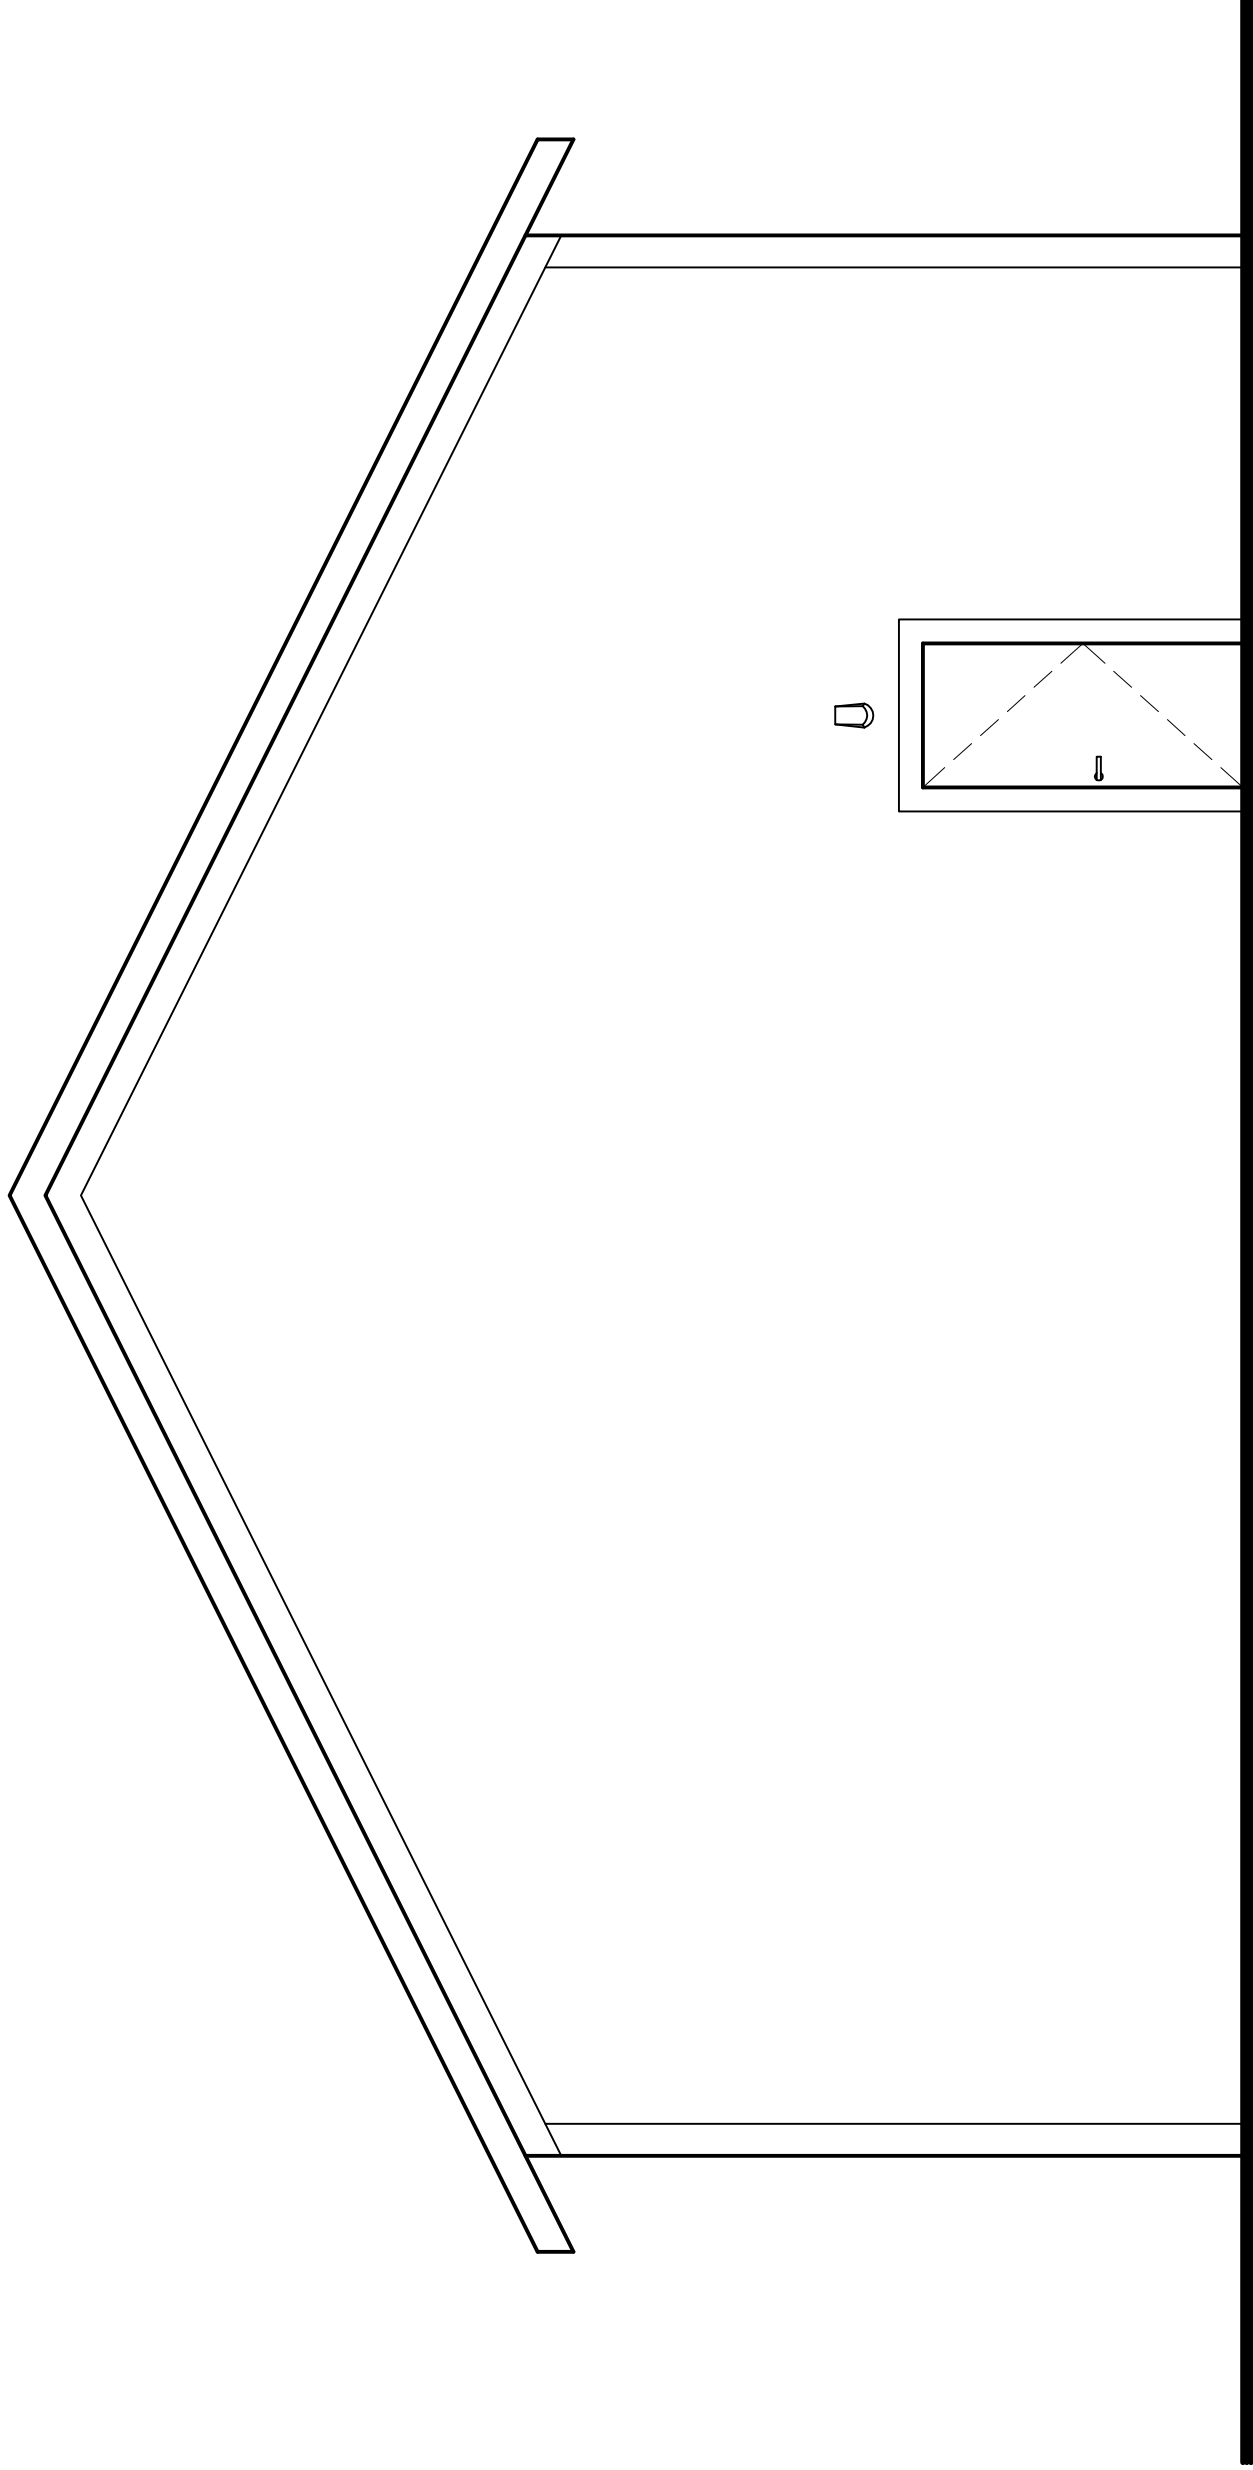

SOUTH ELEVATION

20 A3 BUILDING "A" SOUTH ELEVATION
SCALE: 1/4" = 1'-0"
2023HAYES FAMILY AUTOHFA-DRAWINGS.DWG DATE: 10/4/2023

HAYES FAMILY AUTO
SITE DEVELOPMENT
717 W MAIN STREET
WATERTOWN, WI 53094

DRAWING NAMES

BUILDING "A" ELEVATIONS

REVISIONS

PROJECT DATA

DATE: 2/5/2024


DRAWN BY: CJ

CHECKED BY: P.W.



SHEET NO.

A-3


the Design Alliance Architects, Inc.
1003 Madison Avenue
Fort Atkinson, WI
(920) 563-3404

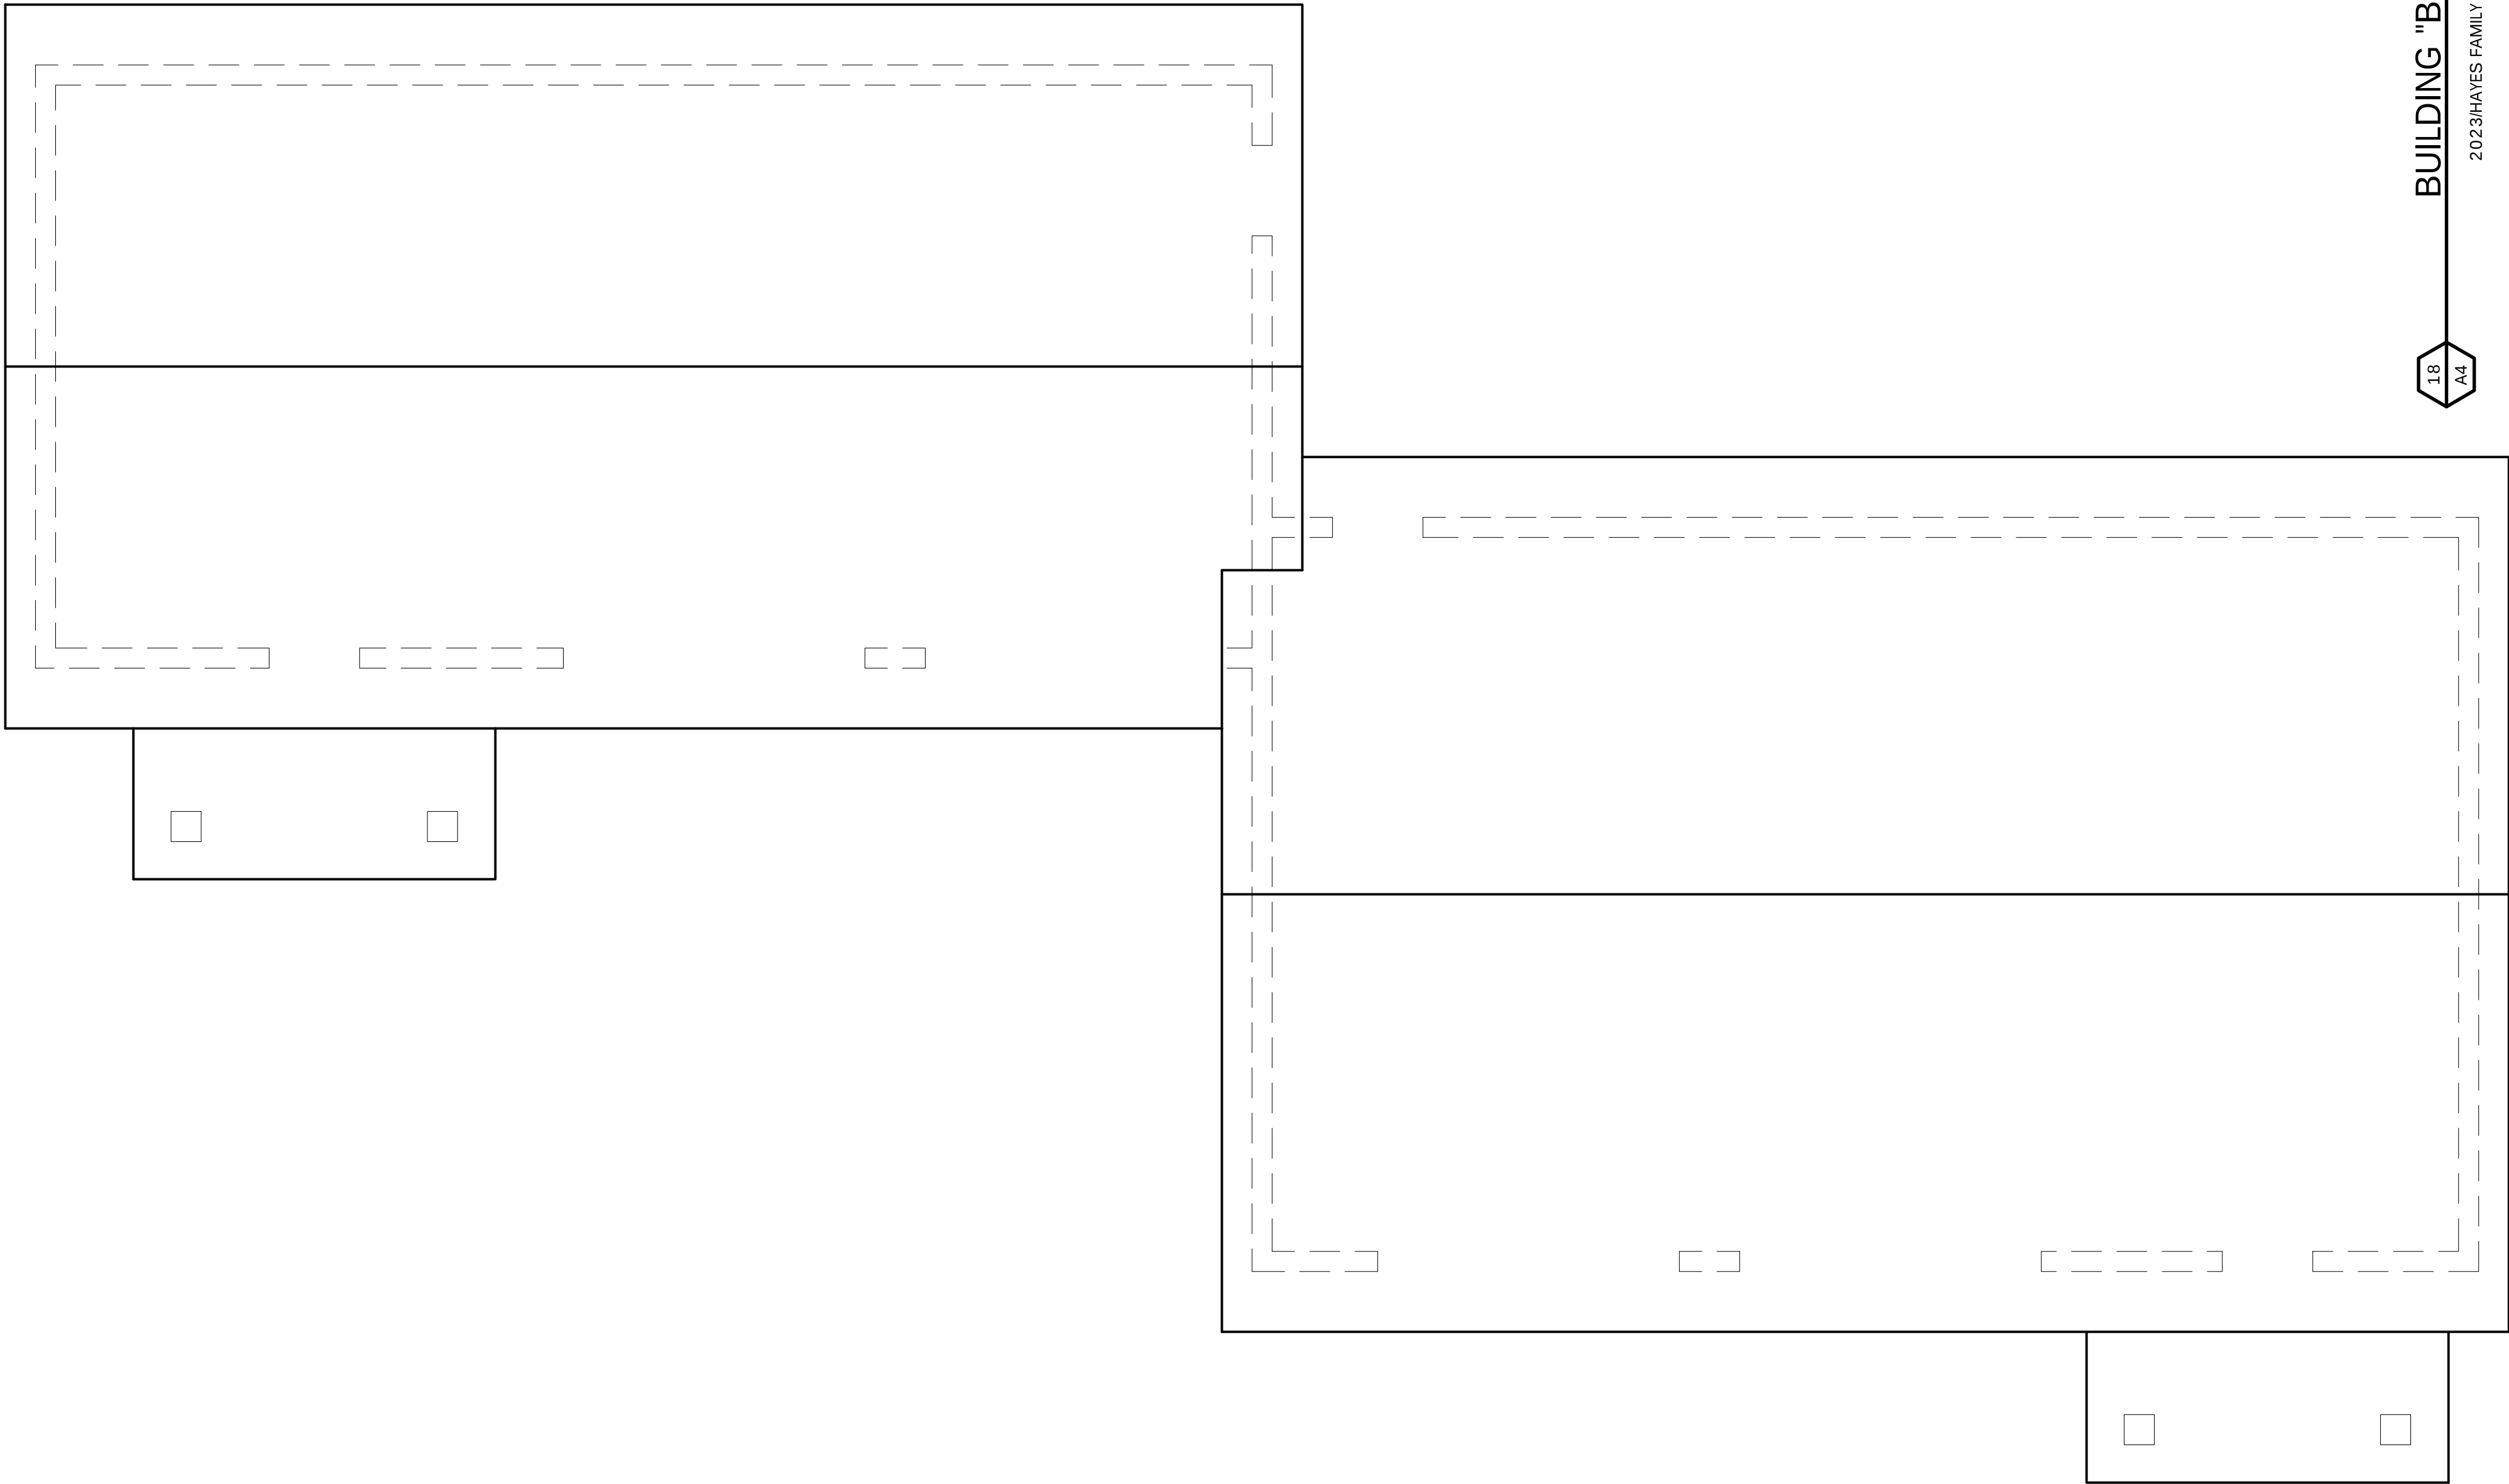

 BUILDING "B" ROOF PLAN
SCALE: 1/4" = 1'-0"
2023HAYES FAMILY AUTOHFA-DRAWINGS.DWG
DATE: 10/4/2023

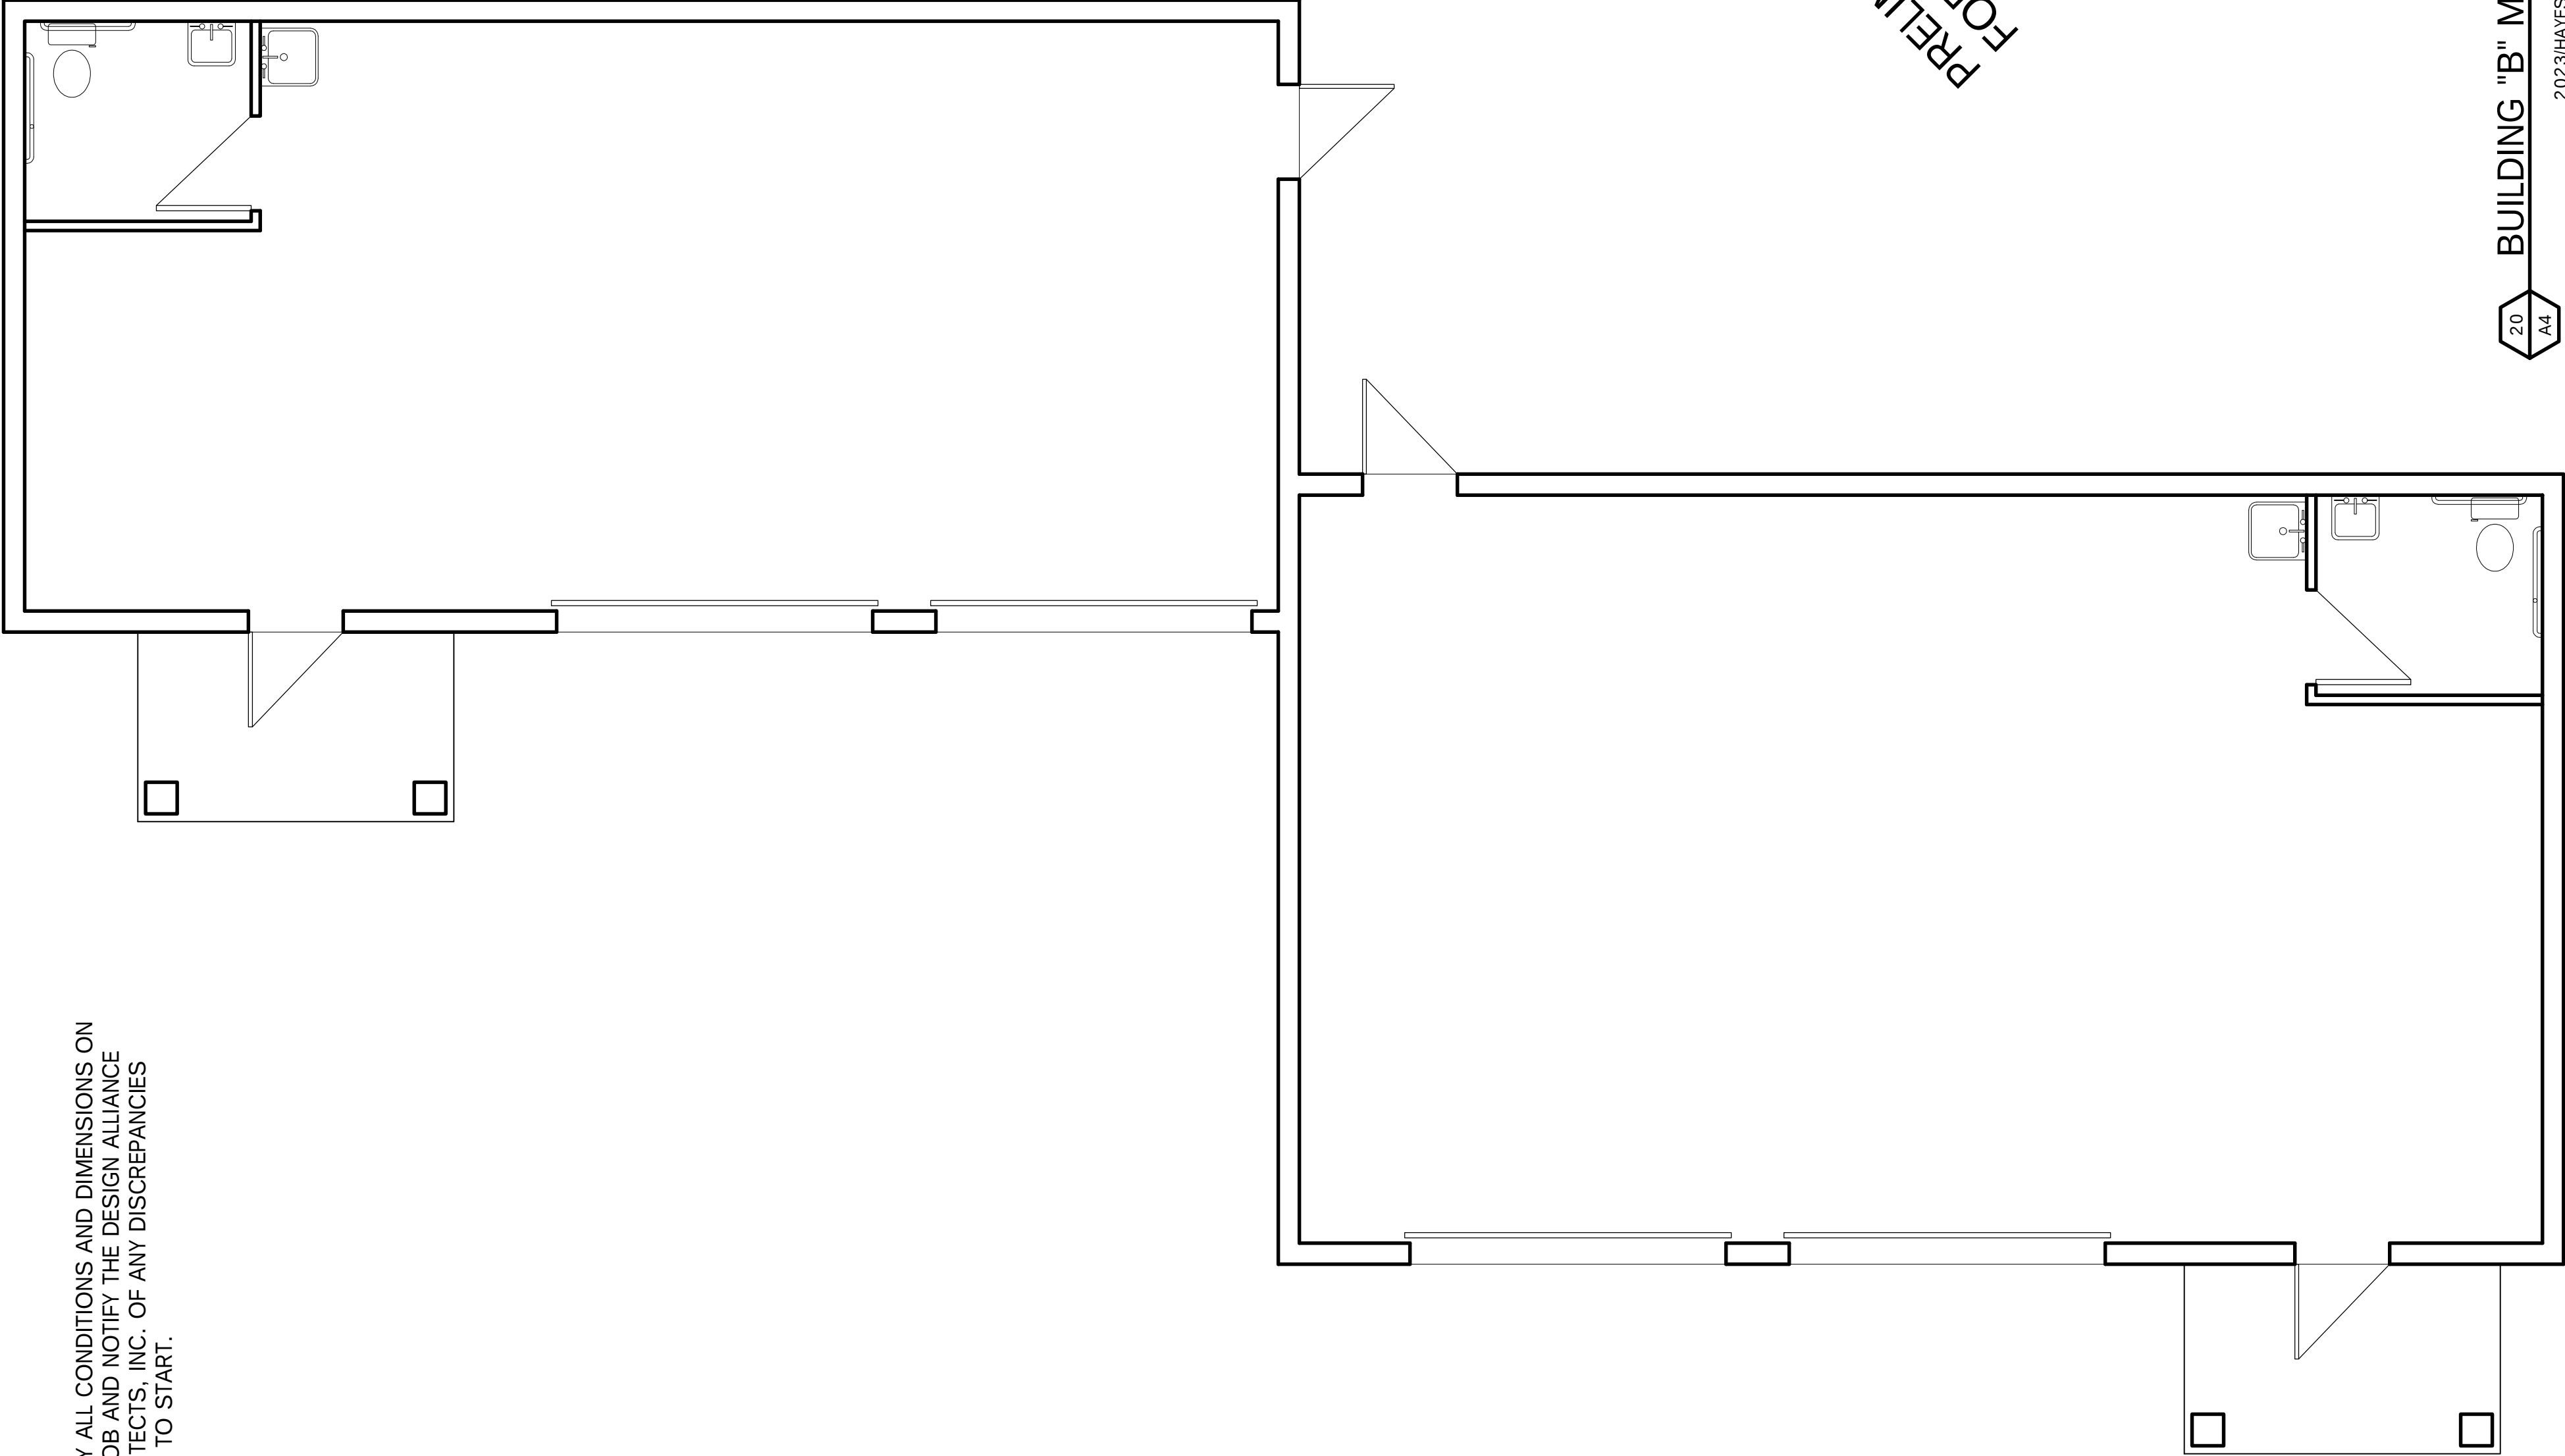

 BUILDING "B" MAIN FLOOR PLAN
SCALE: 1/4" = 1'-0"
2023HAYES FAMILY AUTOHFA-DRAWINGS.DWG
DATE: 10/4/2023



PRELIMINARY NOT
FOR CONSTRUCTION

HAYES FAMILY AUTO
SITE DEVELOPMENT
717 W MAIN STREET
WATERTOWN, WI 53094

DRAWING NAMES

BUILDING "B" PLANS

REVISIONS

PROJECT DATA

DATE: 2/5/2024

DRAWN BY: CL

CHECKED BY: P.W.

SHEET NO.

A-4

 
theDesign
Alliance
Architects, Inc.

1003 Madison Avenue
Fort Atkinson, WI

(920) 563-3404

VERIFY ALL CONDITIONS AND DIMENSIONS ON
THE JOB AND NOTIFY THE DESIGN ALLIANCE
ARCHITECTS, INC. OF ANY DISCREPANCIES
PRIOR TO START.

VERIFY ALL CONDITIONS AND DIMENSIONS ON
THE JOB AND NOTIFY THE DESIGN ALLIANCE
ARCHITECTS, INC. OF ANY DISCREPANCIES
PRIOR TO START.



EAST ELEVATION

20
A5

BUILDING "B" EAST ELEVATION

SCALE: 1/4" = 1'-0"

2023HAYES FAMILY AUTOHFA-DRAWINGS.DWG DATE: 10/4/2023

HAYES FAMILY AUTO
SITE DEVELOPMENT
717 W MAIN STREET
WATERTOWN, WI 53094

DRAWING NAMES

BUILDING "B" ELEVATIONS

REVISIONS

PROJECT DATA

DATE: 2/5/2024

DRAWN BY: CJ

CHECKED BY: P.W.

SHEET NO.

A-5

PRELIMINARY NOT
FOR CONSTRUCTION

+ 22'-0"
ROOF RIDGE

+ 14'-0"
TRUSS BEARING

0'-0"
MAIN FLOOR

LIGHT FIXTURE
UNDER ROOF

WEST ELEVATION

20
A5

BUILDING "B" WEST ELEVATION

SCALE: 1/4" = 1'-0"

2023HAYES FAMILY AUTOHFA-DRAWINGS.DWG DATE: 10/4/2023


the
Design
Alliance
Architects, Inc.

1003 Madison Avenue
Fort Atkinson, WI

(920) 563-3404

VERIFY ALL CONDITIONS AND DIMENSIONS ON
THE JOB AND NOTIFY THE DESIGN ALLIANCE
ARCHITECTS, INC. OF ANY DISCREPANCIES
PRIOR TO START.

PRELIMINARY NOT
FOR CONSTRUCTION

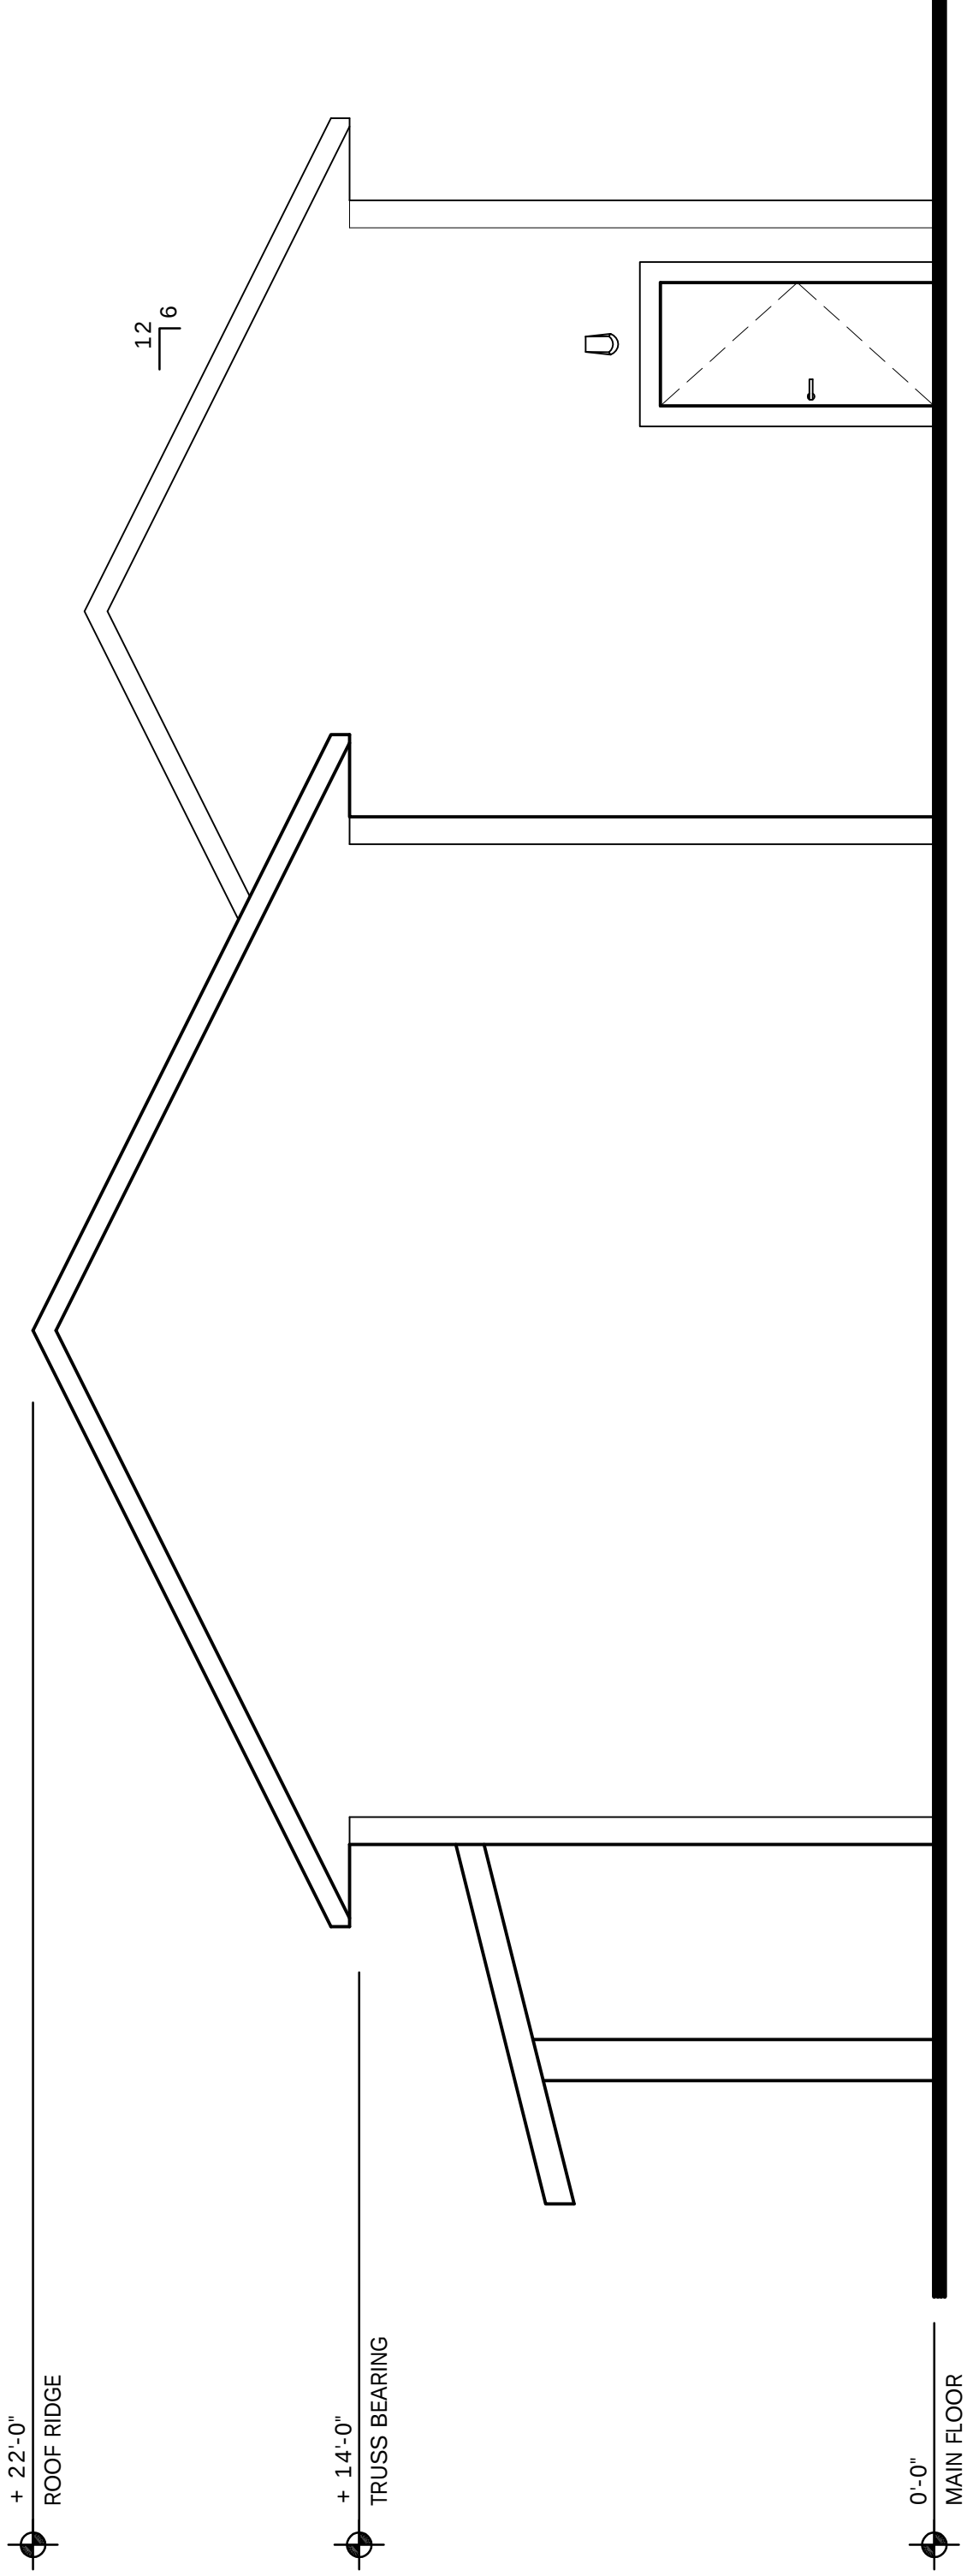


SOUTH ELEVATION

20
A6

BUILDING "B" SOUTH ELEVATION

SCALE: 1/4" = 1'-0"

2023HAYES FAMILY AUTOHFA-DRAWINGS.DWG DATE: 10/4/2023

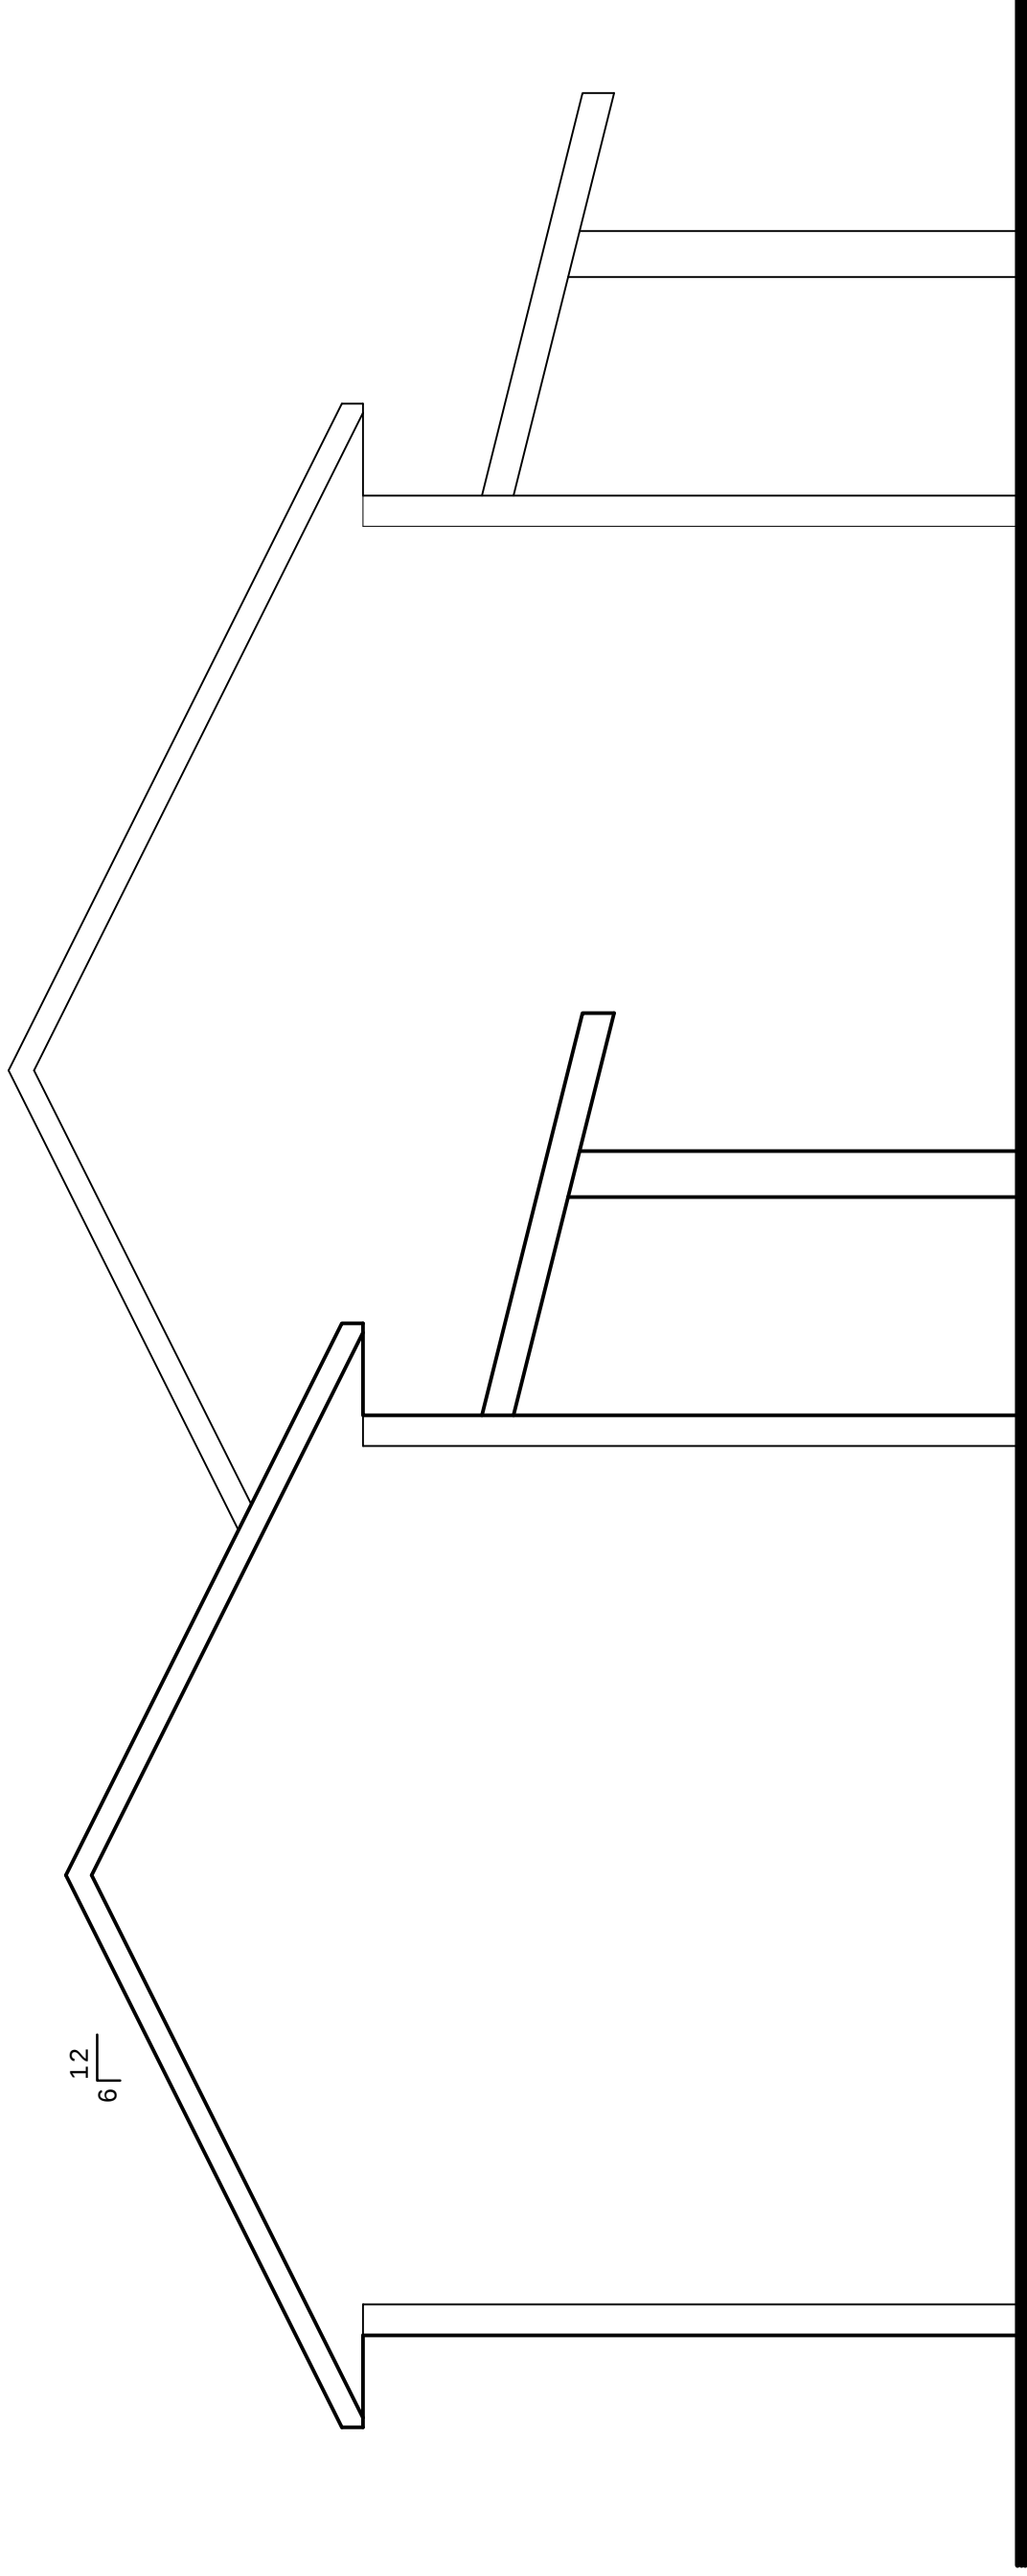

NORTH ELEVATION

20
A6

BUILDING "B" NORTH ELEVATION

SCALE: 1/4" = 1'-0"

2023HAYES FAMILY AUTOHFA-DRAWINGS.DWG DATE: 10/4/2023

HAYES FAMILY AUTO
SITE DEVELOPMENT
717 W MAIN STREET
WATERTOWN, WI 53094

DRAWING NAMES

BUILDING "B" ELEVATIONS

REVISIONS

PROJECT DATA

DATE: 2/5/2024

DRAWN BY: CL

CHECKED BY: P.W.

SHEET NO.

A-6

the
Design
Alliance
Architects, Inc.

1003 Madison Avenue
Fort Atkinson, WI

(920) 563-3404