



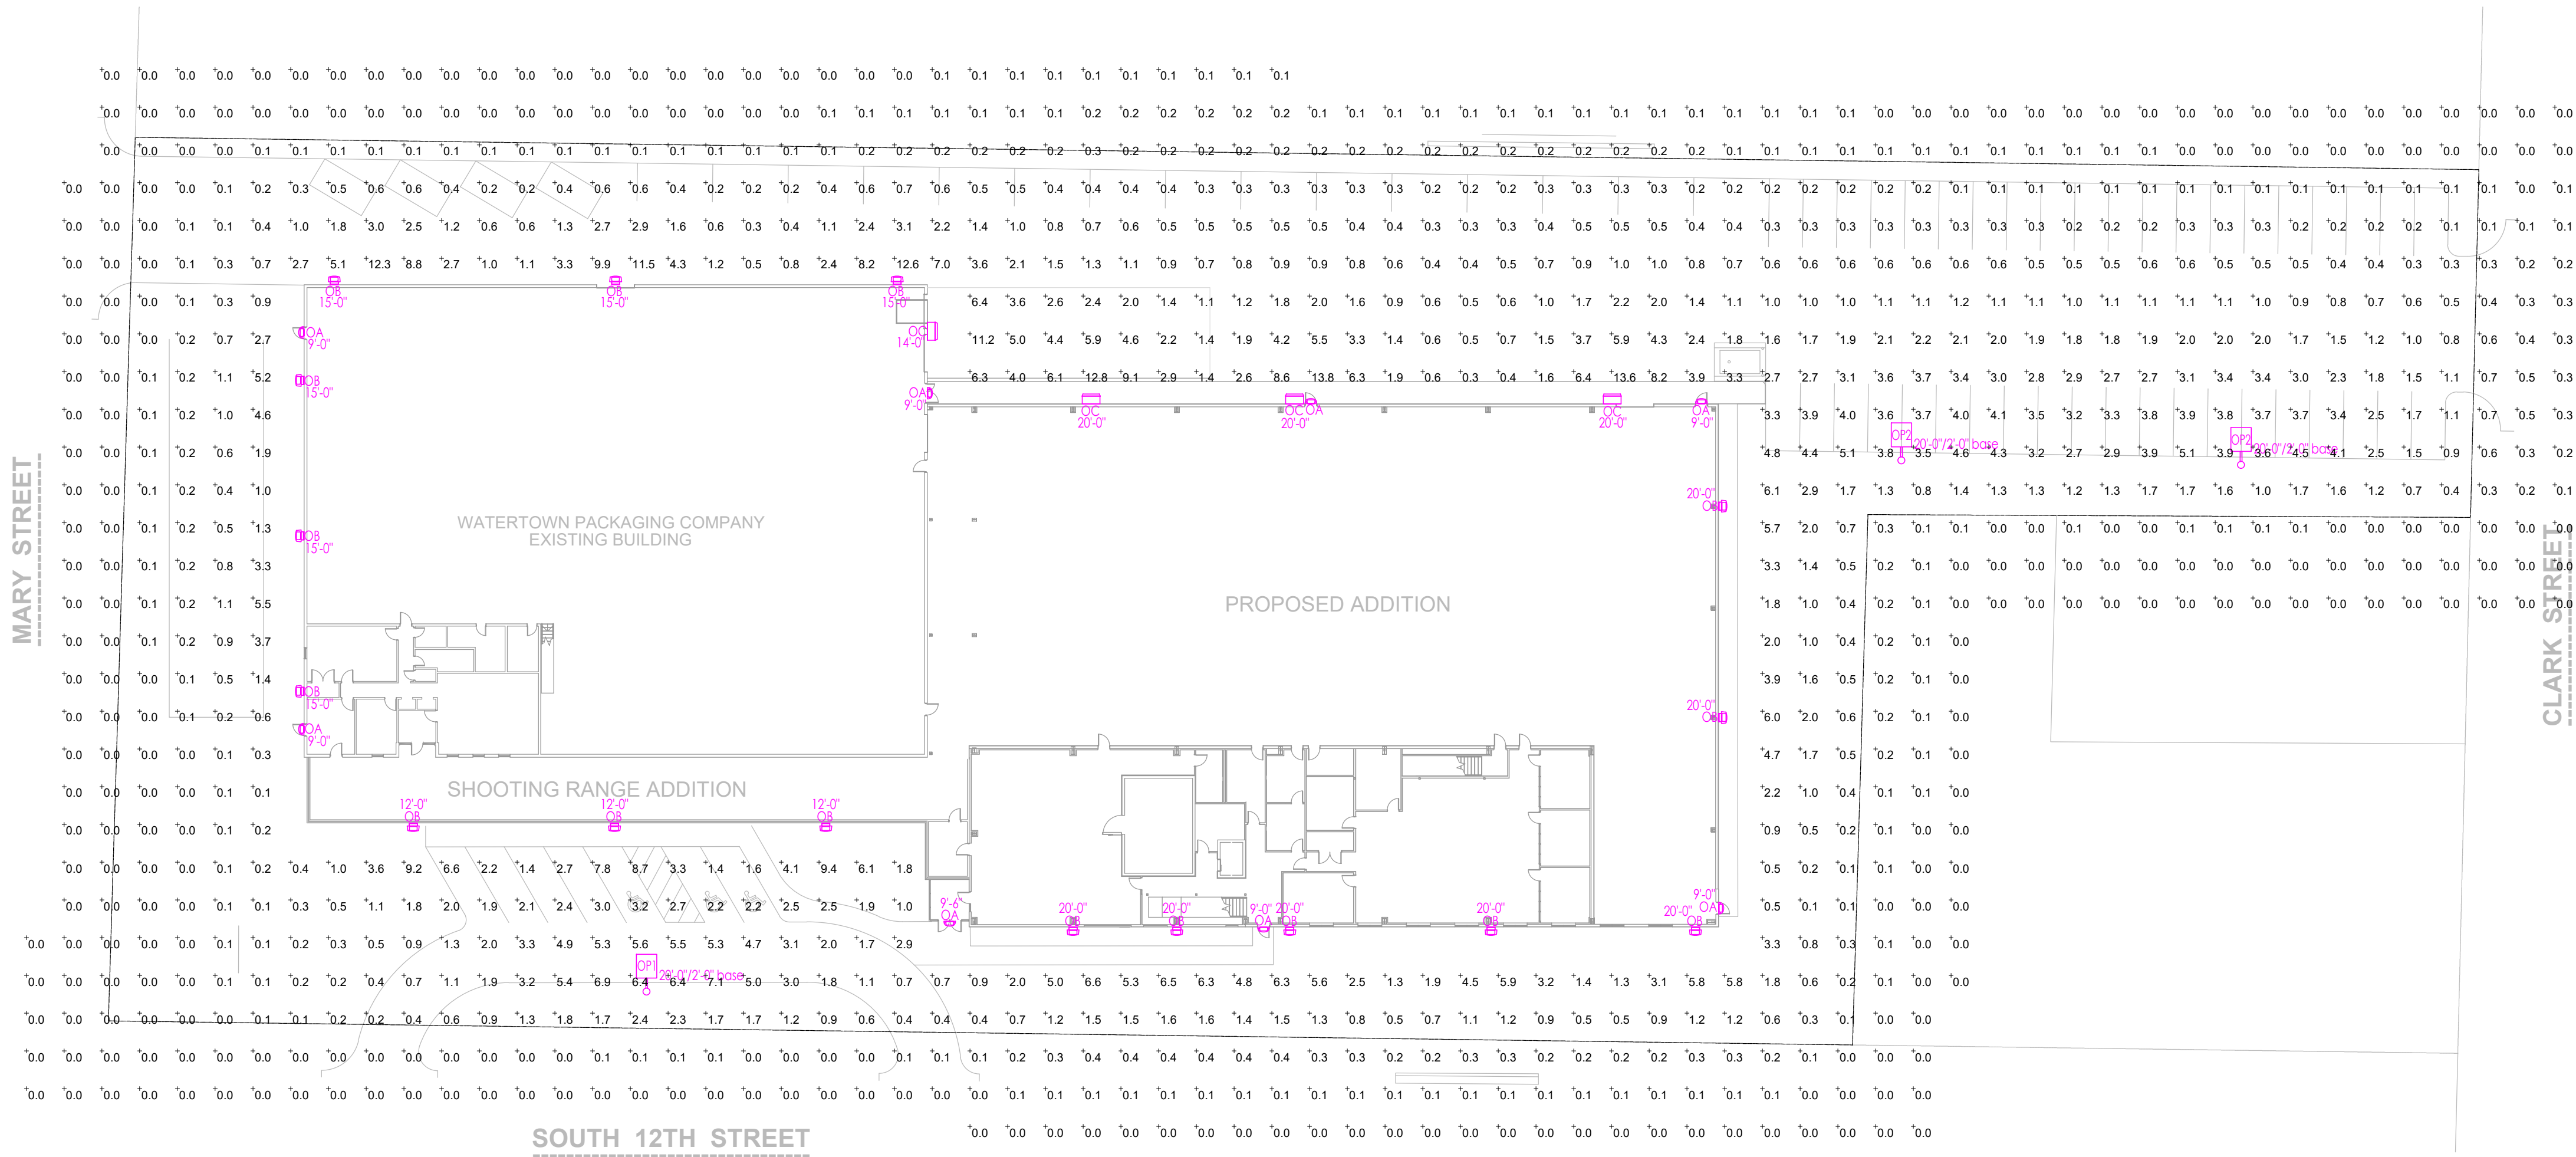

SITE PLAN - PHOTOMETRIC
SCALE: 1" = 30'-0"

EXTERIOR LIGHTING FIXTURE SCHEDULE											
QTY	TYPE	LAMP DATA	DESCRIPTION	LIGHTING FIXTURE		MOUNTING		DIMMING	DRIVER LOCATION	VOLT	SEE NOTE
		TYPE		MAKE CATALOG NO.							
8 15 4 2	OA	32W LED 1600L 40K	LED SECURITY WALLPACK LIGHT WITH BLACK FINISH & EM DRIVER/HEATER/PHOTOCCELL	MULE LIGHTING	MERU-LED ACEM BK IH	WALL	N/A	-	-	120	
	OB	75W LED 10000L 40K	SLIM LED ADJUSTABLE WALL PACK WITH BLACK FINISH	ILP LIGHTING	SWP-10L-U-CCTS(40K)-BLK + EK4036S	WALL	N/A	0-10V	FIXTURE	120	
	OC	119W LED 16000L 40K	OPEN FACE LED WALL PACK WITH BLACK FINISH	ILP LIGHTING	OWL-10L/13L/16L-U-CCTS(40K)-BLK + EK4036S	WALL	N/A	0-10V	FIXTURE	120	
	OD	24W LED LED 1000L 40K	DECORATIVE OUTDOOR LED LIGHT WITH METAL ACCENTS IN TEXTURED GRAY FINISH	AFX LIGHTING	SEW5182300L30MVTG-PC	WALL	N/A	0-10V	FIXTURE	120	
1	OP1	131W LED 17172L 40K	SINGLE LED POLE HEAD WITH TYPE 2 DIST./HSS ON 20'-0" POLE/2'-0" BASE WITH BLACK FINISH	COOPER	PRV-P-C40-D-UNV-T2-SA-BK-HSS (HEAD) + SSS4A20SYM1 / A B1 / TMP1 (POLE)	2'-0" CONC BASE		0-10V	FIXTURE	120	
2	OP2	131W LED 17144L 40K	SINGLE LED POLE HEAD WITH TYPE 5 DIST. ON 15'-0" POLE/2'-0" BASE WITH BLACK FINISH	COOPER	PRV-P-C40-D-UNV-T3-SA-BK-HSS (HEAD) + SSS4A20SYM1 / A B1 / TMP1 (POLE)	2'-0" CONC BASE		0-10V	FIXTURE	120	

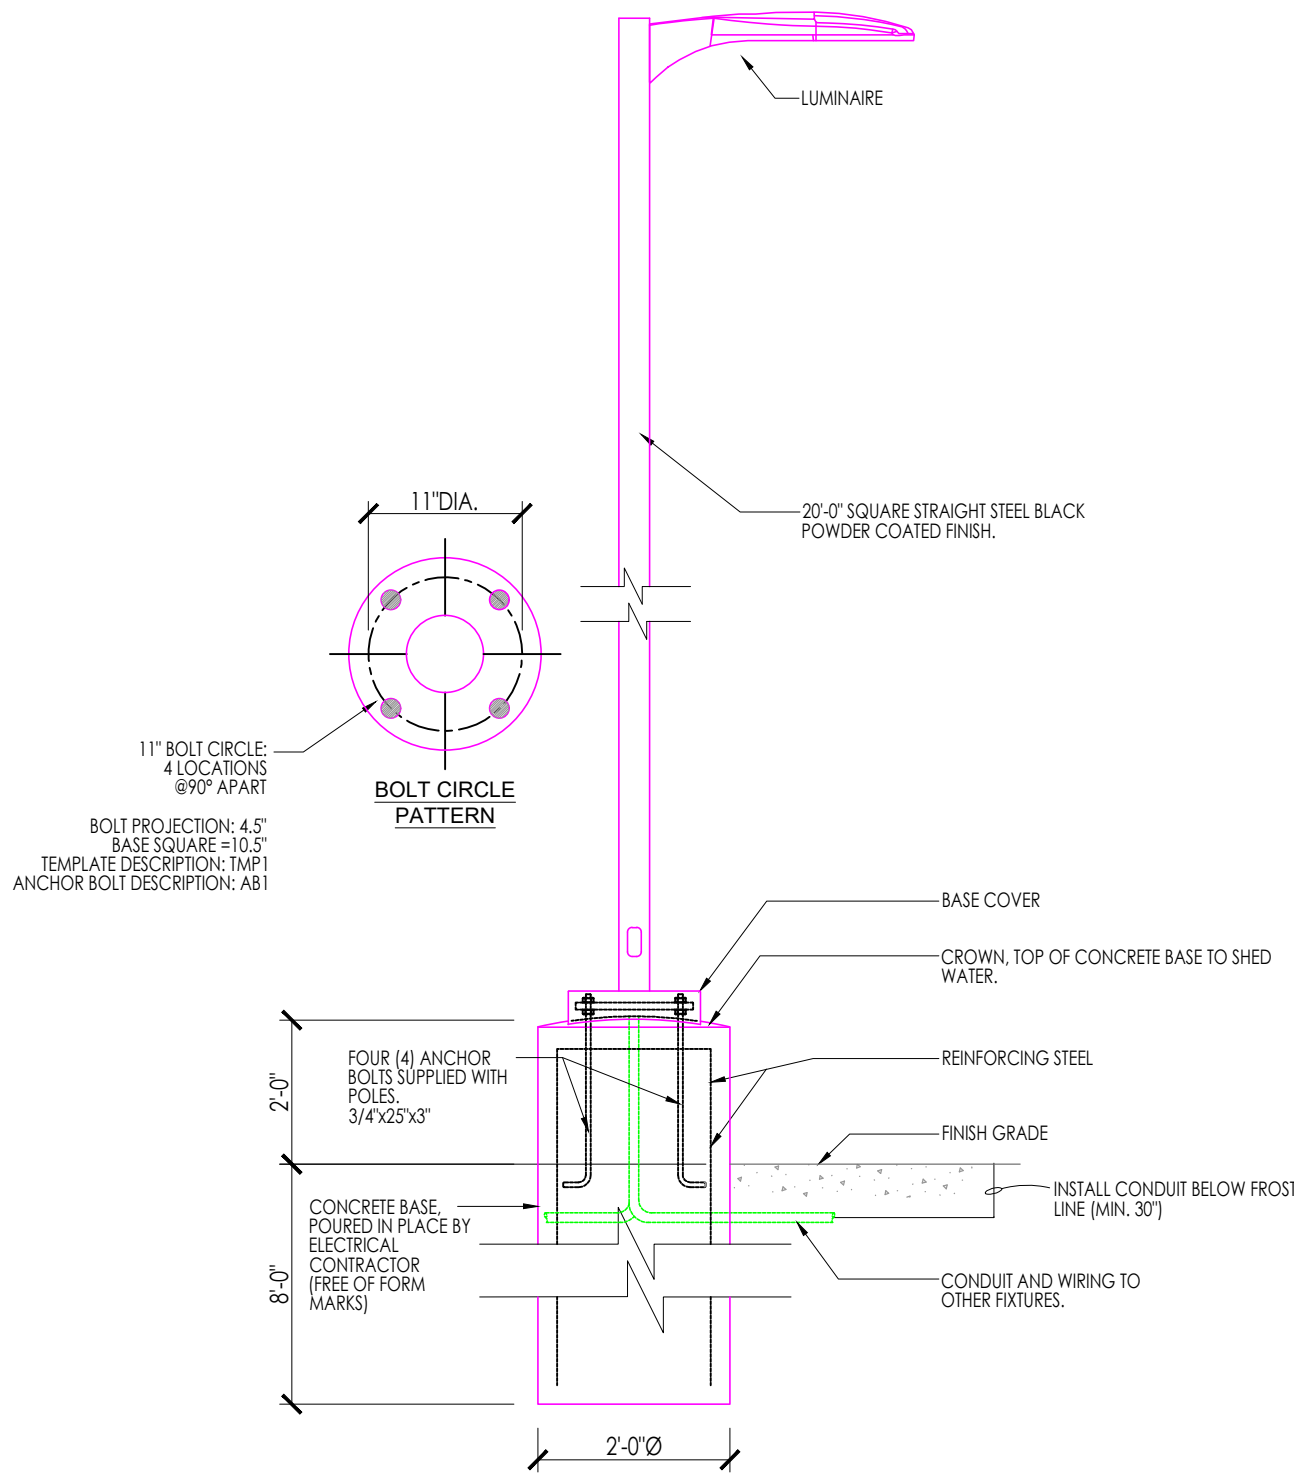

LIGHTING STANDARD
ELEVATION (TYPE OP1/OP2)

1 NO SCALE

Statistics					
Description	Avg	Max	Min	Max/Min	Avg/Min
Calc Zone	1.1 fc	13.8 fc	0.0 fc	N/A	N/A



FIRM ADDRESS AND CONTACT:
1265 E WISCONSIN AVENUE - SUITE A
PEWaukee, WI 53072
CONTACT: NATHAN STOPPENBACH
TEL: 262.366.6045
EMAIL: NATHAN@EDGEELECTRICWI.COM



Griffin Armament
Addition

801 S. 12TH STREET
WATERTOWN, WISCONSIN 53094

Revisions	
Description	Date

SHEET TITLE:
Site Plan - Photometric

DRAWN BY:
RC

DATE:
01/06/2023

SHEET:
E0P