




EPPSTEIN UHEN
ARCHITECTS

333 East Chicago Street
Milwaukee, WI 53202
414 271-5350 • FAX 414 271-7794
www.eppsteinuhen.com

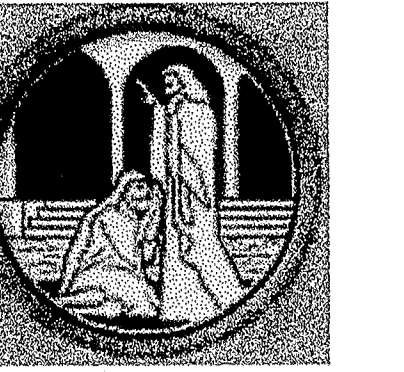

Bethesda

Project

Bethesda Lutheran
Homes and Services
Phase II
Office Building

C01061
CZARNECKI
ENGINEERING
INCORPORATED
1099 QUAIL COURT, SUITE 100 - PEWAUKEE, WI 53072
VOICE: (262) 691-1010 FAX: (262) 691-7334
WEB PAGE: www.cceeng.com

Sheet Title

Electrical Site Plan

Revisions

Item	Date	By
------	------	----

Project Architect SR



Drawn By CZE

Project No. 1-00339-01

Date 10/12/01

Sheet No.

E0.1

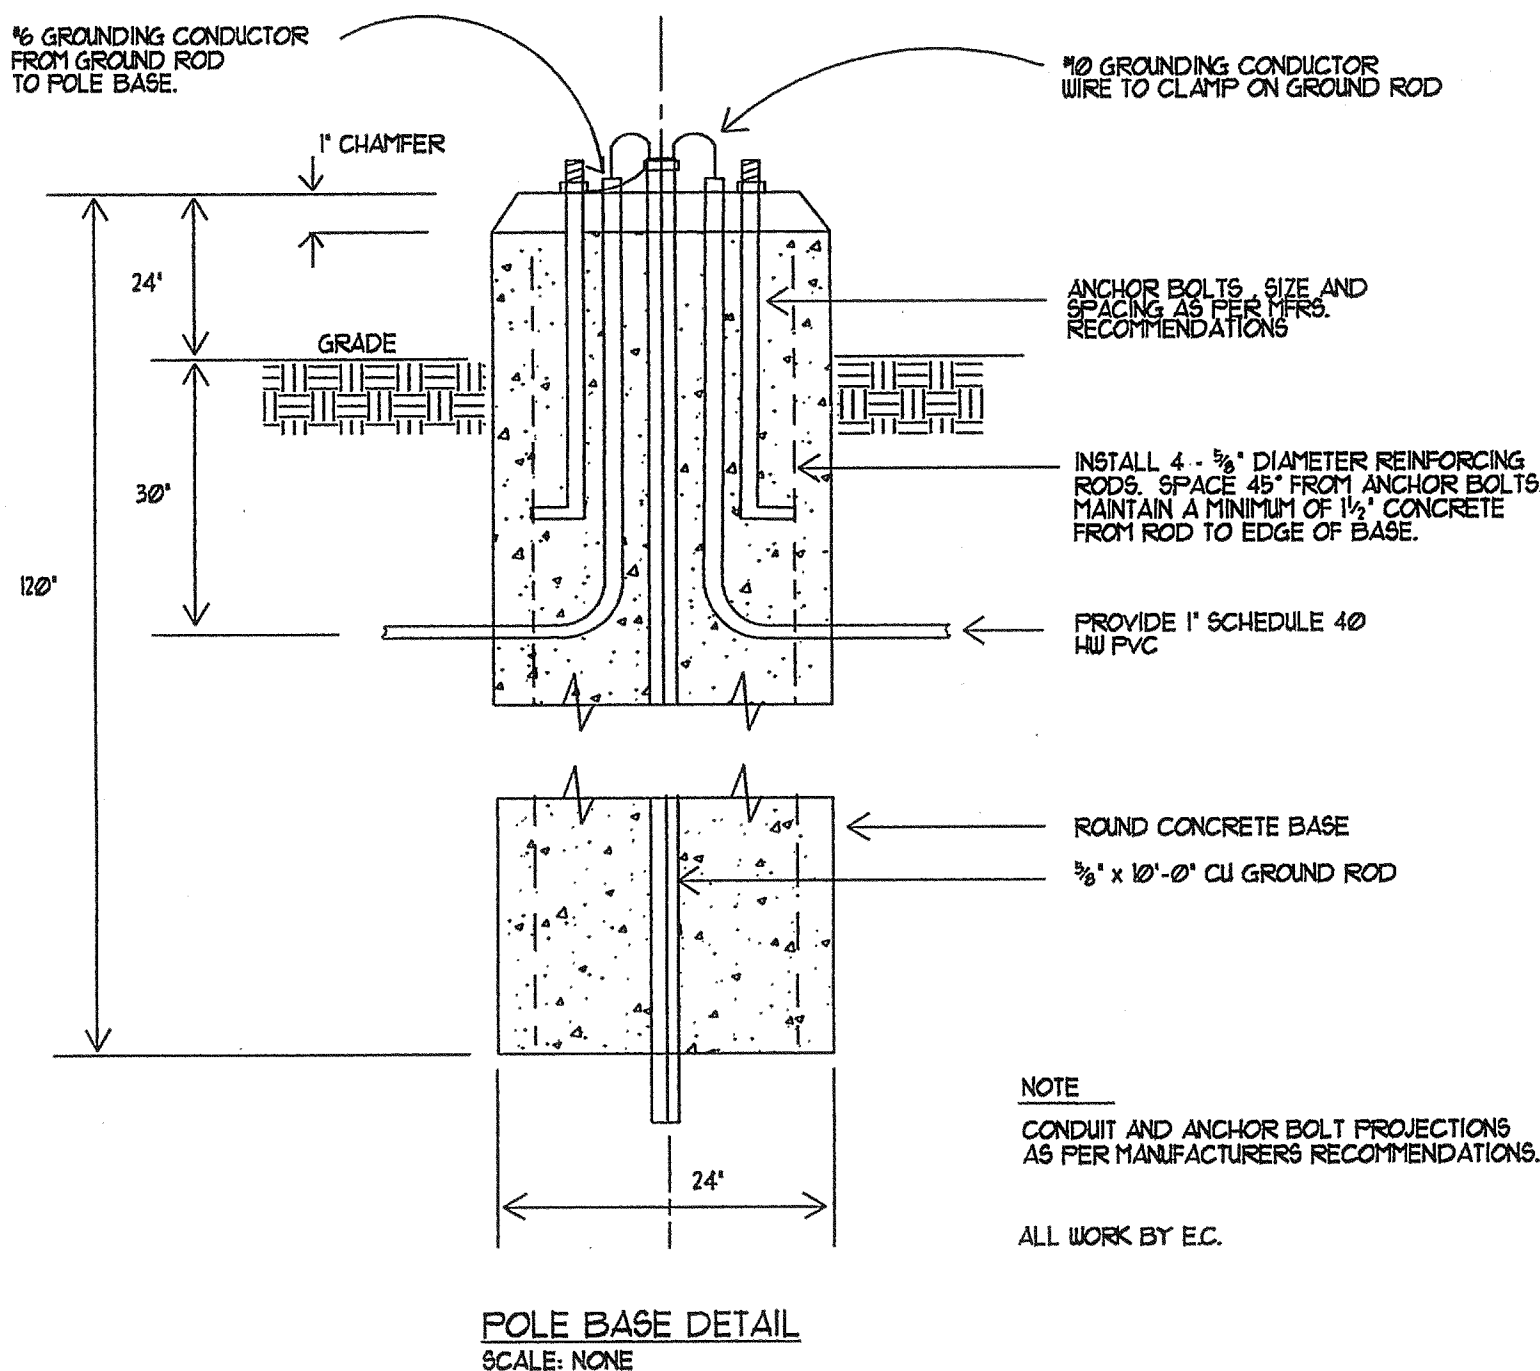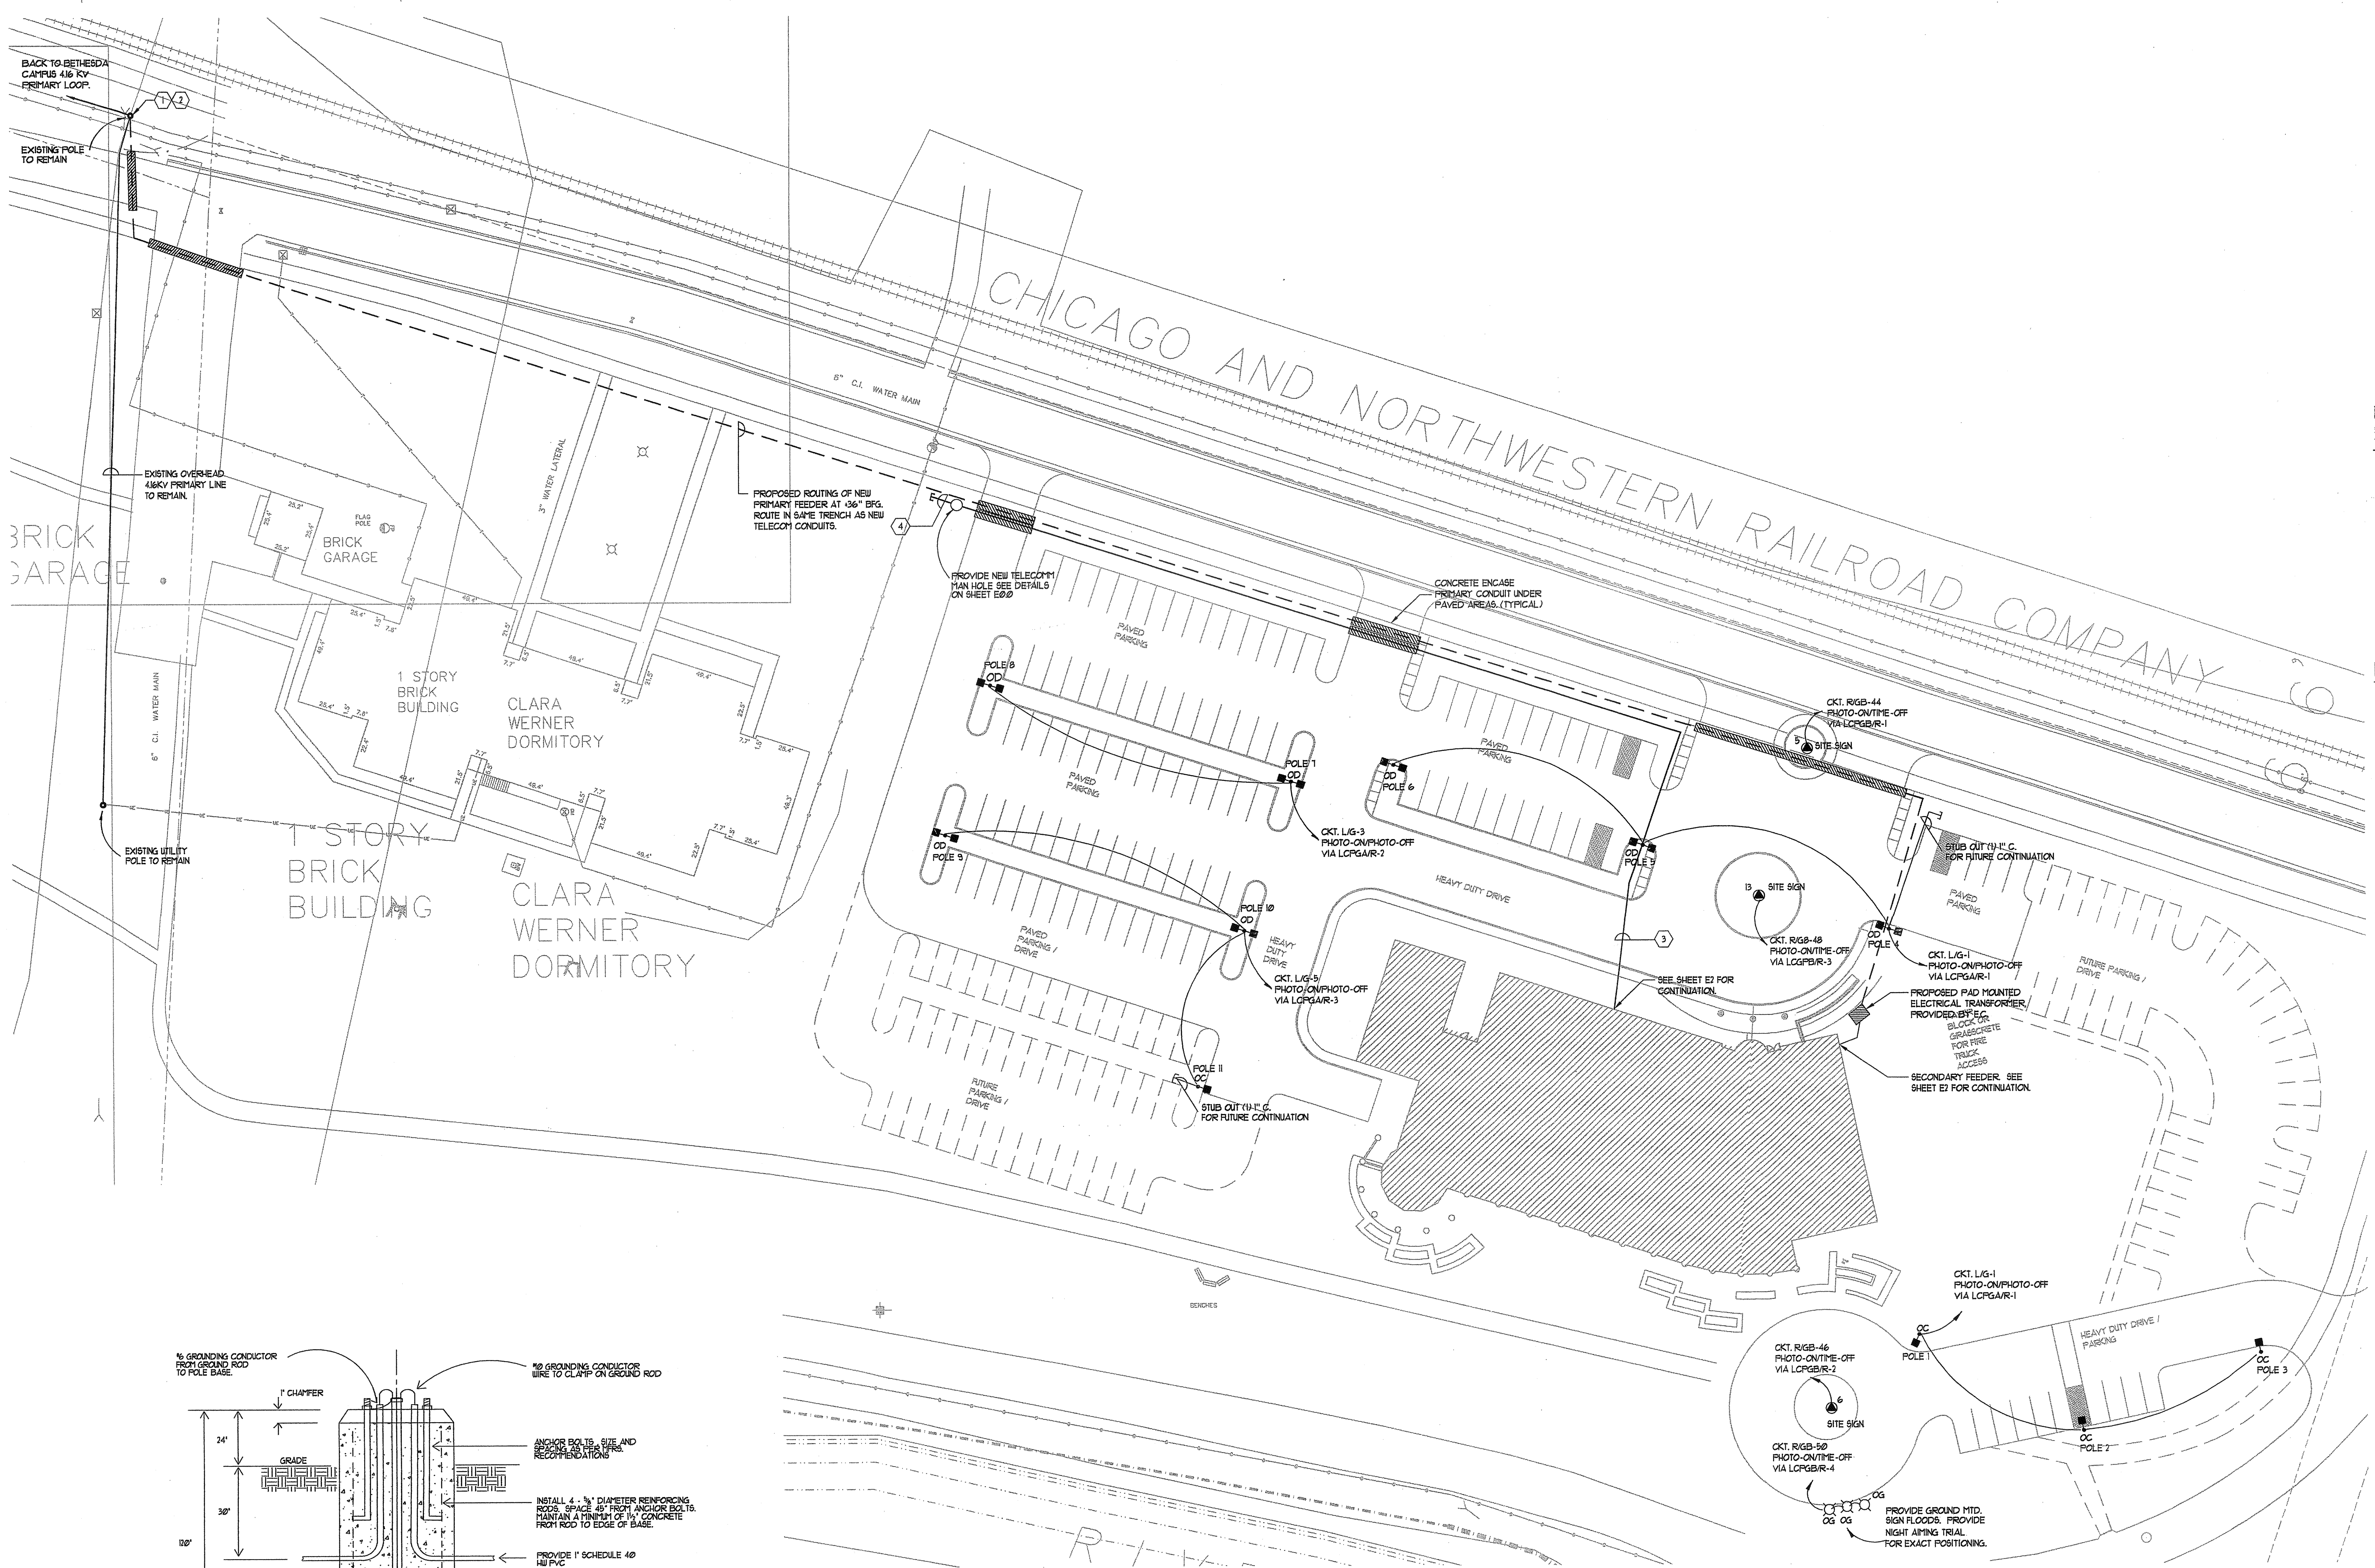

- GENERAL NOTES:
- CONTRACTOR SHALL VISIT THE JOB SITE AND FAMILIARIZE HIMSELF WITH EXISTING CONDITION PRIOR TO SUBMITTING BID.
 - ELECTRICAL CONTRACTOR SHALL REVIEW ALL OTHER TRADES DOCUMENTS & COORDINATE LOCATION OF MOTOR, LIGHTS & DEVICES. PROVIDE ADDITIONAL EQUIPMENT EVEN IF NOT SHOWN ON THE ELECTRICAL DRAWINGS.
 - FAILURE TO PROVIDE FOR AND INCLUDE COST FOR THESE CONTINGENCIES IN THE ORIGINAL BID WILL NOT BE ACCEPTED AS AN EXCUSE FOR EXTRA PAYMENT.
 - ALL EXTERIOR LIGHTING BRANCH Ckt. WIRING SHALL BE MIN 1/2\"/>
 - COORDINATE ALL REQUIRED DOWNTIME AND SERVICE OUTAGES WITH CONSTRUCTION MANAGER AND BLHS. ALL OUTAGES TO BE DONE AT A TIME TO BE DETERMINED BY BLHS.

ELECTRICAL SITE PLAN
SCALE: 1\"/>

KEYED NOTES:

- PROVIDE SPLICE OF EXISTING 4/0 KV OVERHEAD PRIMARY CONDUCTORS ON TOP OF POLE. USE 3/4\"/>
- ROUTE NEW PRIMARY FEEDER DOWN EXISTING POLE (OWNED BY BLHS) FOR NEW UNDERGROUND PRIMARY FEEDER TO OFFICE BUILDING. SEE RISER DIAGRAM ON SHEET E1 FOR MORE INFORMATION.
- PROVIDE (3) 4\"/>
- STUB OUT (3) 4\"/>