



VARIABLE WIDTH R/W
ASPHALT PAVED PUBLIC ROADWAY
PCN: 77-40-43-01-22-001-0000

$R=500.00'$
 $\Delta=006^{\circ}00'43''$
 $L=52.46'$
 $B=N88^{\circ}42'31''E$
 $CHD=52.44'$

S88°17'08"E
52.00'

S88°17'08"E
52.00'

N 881050



ONSITE PROPERTY LINE / R.O.W. LINE	
LEASE PROPERTY LINE	
EX. EASEMENT	
EX. ROADWAY C/L	
EX. OVERHEAD ELECTRIC	
EX. STORM SEWER	
EX. SANITARY LINE	
EX. WATER LINE	
EX. RECLAIM WATER LINE	
EX. FENCE	
EX. SPOT ELEVATION	
EX. TREE	
TO BE REMOVED/ TO BE RELOCATED	
EX. TREE TO BE REMOVED	

REV	DATE	COMMENT	DRAWN BY CHECKED BY
1	7/14/2025	1ST ROUND OF COMMENTS	AH KD
2	8/11/2025	2ND ROUND OF COMMENTS	AH KD
3	08/14/2025	QAQC COMMENTS	AH KD
4	10/23/2025	3RD ROUND OF COMMENTS	KD KD



THIS DRAWING IS INTENDED FOR MUNICIPAL AND/OR AGENCY
REVIEW AND APPROVAL. IT IS NOT INTENDED AS A CONSTRUCTION
DOCUMENT UNLESS INDICATED OTHERWISE.

PROJECT:

16775 PERSIMMON BLVD
WESTLAKE, FL 33470
CITY OF WESTLAKE
S 01, T 43S, R 40E

**600 N. WESTSHORE BLVD. SUITE 950
TAMPA, FLORIDA 33609
Phone: (813) 812-4100
Fax: (813) 812-4101**

FLORIDA BUSINESS CERT. OF AUTH. No. 30780

This item has been digitally signed and sealed by Kayla M. Dedrick PE on the date adjacent to the seal. Signature must be verified on any electronic copies.

SHEET NUMBER:


C-201

REVISION 4 - 10/23/2025

1. BOHLER ENGINEERING LLC IS NOT RESPONSIBLE FOR JOB SITE SAFETY OR SUPERVISION. CONTRACTOR IS TO PROCEED WITH THE DEMOLITION IN A SYSTEMATIC AND SAFE MANNER, FOLLOWING ALL THE OSHA REQUIREMENTS, TO ENSURE PUBLIC AND CONTRACTOR SAFETY.
2. ALL DEMOLITION ACTIVITIES ARE TO BE PERFORMED IN ACCORDANCE WITH THESE PLANS AND SPECIFICATIONS AS WELL AS ALL FEDERAL, STATE, AND LOCAL REGULATIONS. ANY DISCREPANCIES OR DEVIATIONS SHALL BE IDENTIFIED BY THE CONTRACTOR TO BOHLER F.L.L.C IN WRITING FOR RESOLUTION PRIOR TO INITIATION OF SITE ACTIVITY.
3. PRIOR TO STARTING ANY DEMOLITION ACTIVITY THE CONTRACTOR IS RESPONSIBLE FOR TO:
 - A. THE CONTRACTOR SHALL OBTAIN ONE CALL LOCATION CERTIFICATION PRIOR TO ANY EXCAVATION OR DEMOLITION. THE NUMBER IS 1-800-432-4770.
 - B. ENSURING COPIES OF ALL PERMITS AND APPROVALS MUST BE MAINTAINED ON SITE AND AVAILABLE FOR REVIEW.
 - C. OBTAINING THE NECESSARY NEIGHBORHOOD NOTIFICATION AND COMPLIANCE PRIOR TO SITE DISTURBANCE.
 - D. LOCATE/CAP ALL UTILITIES AND SERVICES, INCLUDING BUT NOT LIMITED TO GAS, WATER, ELECTRIC, SANITARY AND STORM SEWER, TELEPHONE, CABLE, FIBER OPTIC CABLE, ETC. WITHIN THE LIMITS OF DISTURBANCE.
 - E. PROTECTING AND MAINTAINING IN OPERATION, ALL ACTIVE SYSTEMS THAT ARE NOT BEING REMOVED DURING ALL DEMOLITION ACTIVITIES.
 - F. FAMILIARIZING THEMSELVES WITH THE APPLICABLE UTILITY SERVICE PROVIDER AND BEING RESPONSIBLE FOR ALL COORDINATION REGARDING UTILITY DEMOLITION REQUIRED FOR THE PROJECT. THE CONTRACTOR SHALL PROVIDE THE NECESSARY WRITTEN NOTICE TO THE UTILITY COMPANIES. ANY ACTIVITIES THAT HAVE BEEN TERMINATED AND ABANDONED IN ACCORDANCE WITH JURISDICTION AND UTILITY COMPANY REQUIREMENTS.
 - G. COORDINATION WITH UTILITY COMPANIES REGARDING WORKING "OFF-PEAK" HOURS OR ON WEEKENDS AS MAY BE REQUIRED TO MINIMIZE PUBLIC INTERFERENCE.
 - H. A COMPLETE INSPECTION OF CONTAMINANTS BY A LICENSED ENVIRONMENTAL TESTING AGENCY, OF ALL BUILDINGS AND/OR STRUCTURES TO BE REMOVED. SAME SHALL BE PERFORMED IN ACCORDANCE WITH ALL APPLICABLE LOCAL, STATE, AND FEDERAL ENVIRONMENTAL REGULATIONS. ANYVAIL CONTAMINANTS SHALL BE REMOVED AND DISPOSED OF IN ACCORDANCE WITH ALL APPLICABLE FEDERAL, STATE, AND LOCAL REGULATIONS. THE CONTRACTOR SHALL BE RESPONSIBLE FOR THE COST OF ALL TESTING AND REMEDIATION. THE CONTRACTOR SHALL BE RESPONSIBLE FOR THE COST OF ALL TESTING AND REMEDIATION. THE CONTRACTOR SHALL BE RESPONSIBLE FOR THE COST OF ALL TESTING AND REMEDIATION. HEREIN IS THE SOLE RESPONSIBILITY OF THE OWNER'S ENVIRONMENTAL CONSULTANT.
4. THE CONTRACTOR SHALL BE RESPONSIBLE FOR THE PROTECTION OF ALL EXISTING ADJACENT MOVEMENT, SETTLEMENT, OR COLLAPSE OF EXISTING STRUCTURES, AND ANY OTHER IMPROVEMENTS THAT ARE REMAINING ON OR OFF SITE. THE DEMOLITION CONTRACTOR IS RESPONSIBLE FOR ALL REPAIRS OF DAMAGE TO ALL ITEMS THAT ARE TO REMAIN AS A RESULT OF HIS ACTIVITIES. THE CONTRACTOR SHALL REPAIRS SHALL USE NEW MATERIAL. THE REPAIRS SHALL RESTORE THE ITEM TO THE ORIGINAL CONDITION.
5. IN THE ABSENCE OF SPECIFICATIONS, THE CONTRACTOR SHALL PERFORM EARTH MOVEMENT ACTIVITIES, DEMOLITION AND REMOVAL OF ALL FOUNDATION WALLS, FOOTINGS, AND OTHER MATERIALS WITHIN THE LIMITS OF DISTURBANCE IN ACCORDANCE WITH ALL APPLICABLE FEDERAL, STATE, AND LOCAL REGULATIONS.
6. EXPLOSIVES SHALL NOT BE USED WITHOUT PRIOR WRITTEN CONSENT OF BOTH THE OWNER AND APPLICABLE GOVERNMENTAL AUTHORITIES. ALL INSPECTED PERMITS AND EXPLOSIVE CONTROL MEASURES THAT ARE REQUIRED BY FEDERAL, STATE, AND LOCAL REGULATIONS SHALL BE IN PLACE PRIOR TO STARTING ANY EXPLOSIVE PROGRAM. THE CONTRACTOR IS ALSO RESPONSIBLE FOR THE REQUIRED INSPECTION AND SEISMIC VIBRATION TESTING THAT IS REQUIRED TO MONITOR THE EFFECTS ON ALL LOCAL STRUCTURES.
7. CONTRACTOR SHALL PROVIDE TRAFFIC CONTROL AND GENERALLY ACCEPTED SAFE PRACTICES IN CONFORMANCE WITH THE MANUAL ON UNIFORM CONTROL DEVICES, SIGNALS, AND MARKINGS, STATE AND LOCAL REGULATIONS WHEN DEMOLITION RELATED ACTIVITIES IMPACT ROADWAYS OR ROADWAY RIGHT-OF-WAY.
8. CONDUCT DEMOLITION ACTIVITIES IN SUCH A MANNER TO ENSURE MINIMUM INTERFERENCE WITH ROADS, STREETS, SIDEWALKS, AND WALKWAYS OF ADJACENT FACILITIES. STREET CLOSURE PERMITS MUST BE RECEIVED FROM THE APPROPRIATE GOVERNMENTAL AUTHORITY.
9. DEMOLITION ACTIVITIES AND EQUIPMENT SHALL NOT USE AREAS OUTSIDE THE DEFINED PROPERTY LINE WITHOUT WRITTEN PERMISSION OF THE OWNER, AND/OR APPROPRIATE GOVERNMENT AGENCY.
10. THE CONTRACTOR SHALL CONTROL AND MONITOR THE DEMOLITION ACTIVITIES AND SCATTERING IN THE AIR IN ACCORDANCE WITH FEDERAL, STATE, AND LOCAL REGULATIONS. AFTER THE DEMOLITION IS COMPLETE, ADJACENT STRUCTURES AND IMPROVEMENTS SHALL BE CLEANED OF ALL DUST AND DEBRIS CAUSED BY THE DEMOLITION OPERATIONS. THE CONTRACTOR IS RESPONSIBLE FOR THE PROTECTION OF ALL EXISTING ADJACENT IMPROVEMENTS AND UTILITIES.
11. CONTRACTOR IS RESPONSIBLE TO SECURE THE PROPERTY AS NECESSARY TO PERFORM THE DEMOLITION IN SUCH A MANNER AS TO PREVENT THE DEMOLITION OF UNAUTHORIZED PERSONS AT ANY TIME.
12. THIS DEMOLITION PLAN IS INTENDED TO IDENTIFY THOSE EXISTING ITEMS/CONTAMINANTS WHICH ARE TO BE REMOVED. IT IS NOT INTENDED TO PREVENT OR PROHIBIT THE USE OF ANY METHODS AND MEANS ARE TO BE IN ACCORDANCE WITH FEDERAL, STATE, AND LOCAL REGULATIONS. THE CONTRACTOR SHALL BE RESPONSIBLE FOR ALL OSHA AND OTHER SAFETY PRECAUTIONS NECESSARY TO PROVIDE A SAFE WORK SITE.
13. DEBRIS SHALL NOT BE REUSED OR RECYCLED. ALL DEMOLITION WASTES AND DEBRIS (SOLID WASTE) SHALL BE DISPOSED OF IN ACCORDANCE WITH ALL FEDERAL, STATE, AND LOCAL REGULATIONS AND APPLICABLE CODES.
14. CONTRACTOR IS RESPONSIBLE FOR FIELD VERIFYING ALL EXISTING SITE IMPROVEMENTS AND UTILITIES. ALL DISCREPANCIES SHALL BE IDENTIFIED TO THE ENGINEER IN WRITING.
15. ALL EXISTING UTILITIES BEING REMOVED SHALL BE DONE SO BY THE CONTRACTOR IN ACCORDANCE WITH STATE AND LOCAL REGULATIONS.
16. THERE ARE NO KNOWN WATER COURSES, WATER BODIES, FLOODPLAINS, XERIC UPLANDS, WETLANDS, CUTHROTH GRASS RESTORATION, OR OTHER SENSITIVE AREAS. THERE ARE NO KNOWN OR SUSPECTED CONTAMINATED AREAS, INCLUDING BUT NOT LIMITED TO RECHARGE AREAS, SOIL TYPES, AND VEGETATIVE COVER LOCATED WITHIN PROJECT LIMITS.

ELEVATIONS ARE BASED ON NAVD88 DATUM DETERMINED BY GPS OBSERVATIONS AND TIED IN TO THE NGS NO. D18238 WITH A PUBLISHED ELEVATION OF 21.01 FEET.

THE PROPERTY IS LOCATED IN OTHER AREAS ZONE X (AREAS DETERMINED TO BE OUTSIDE THE 0.2% ANNUAL CHANCE FLOODPLAIN) AND SPECIAL FLOOD HAZARD AREAS SUBJECT TO INUNDATION BY THE 1% ANNUAL CHANCE FLOOD ZONE AE (BASE FLOOD ELEVATIONS DETERMINED) PER MAP ENTITLED "FIRM FLOOD INSURANCE RATE MAP, PALM BEACH COUNTY, FLORIDA AND INCORPORATED AREAS, PANEL 345 OF 1200", MAP NUMBER 12099C0345F, WITH A MAP EFFECTIVE DATE OF OCTOBER 5, 2017.

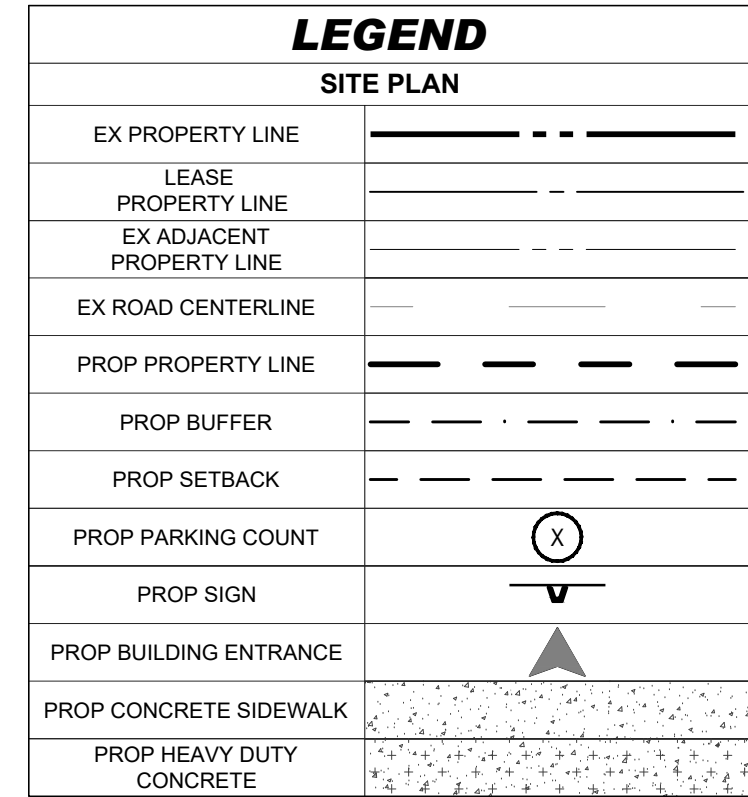[illegible]

THIS DRAWING IS INTENDED FOR MUNICIPAL AND/OR AGENCY
REVIEW AND APPROVAL. IT IS NOT INTENDED AS A CONSTRUCTION
DOCUMENT UNLESS INDICATED OTHERWISE.

PROJECT No.:	FLA230191.00-0A
DRAWN BY:	~AH/MV~
CHECKED BY:	~KD/KM ~
DATE:	10/23/2025
CAD I.D.:	P-CIVL-SITE

PROJECT:

SITE CONSTRUCTION PLANS



16775 PERSIMMON BLVD
WESTLAKE, FL 33470
CITY OF WESTLAKE
S 01, T 43S, R 40E

**600 N. WESTSHORE BLVD. SUITE 950
TAMPA, FLORIDA 33609
Phone: (813) 812-4100
Fax: (813) 812-4101**

FLORIDA BUSINESS CERT. OF AUTH. No. 30780

This item has been digitally signed and sealed by Kayla M. Dedrick PE on the date adjacent to the seal. Signature must be verified on any electronic copies.

SHEET TITLE:

FIRE TRUCK TURN PLAN


SHEET NUMBER:


C-302

100% 90% 80% 70% 60% 50% 40% 30% 20% 10% 0%

REVISION 4 - 10/23/2025

**THIS PLAN TO BE UTILIZED
FOR SITE LAYOUT PURPOSES
ONLY**

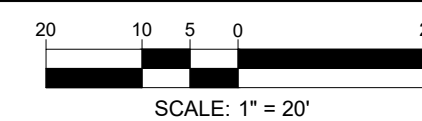

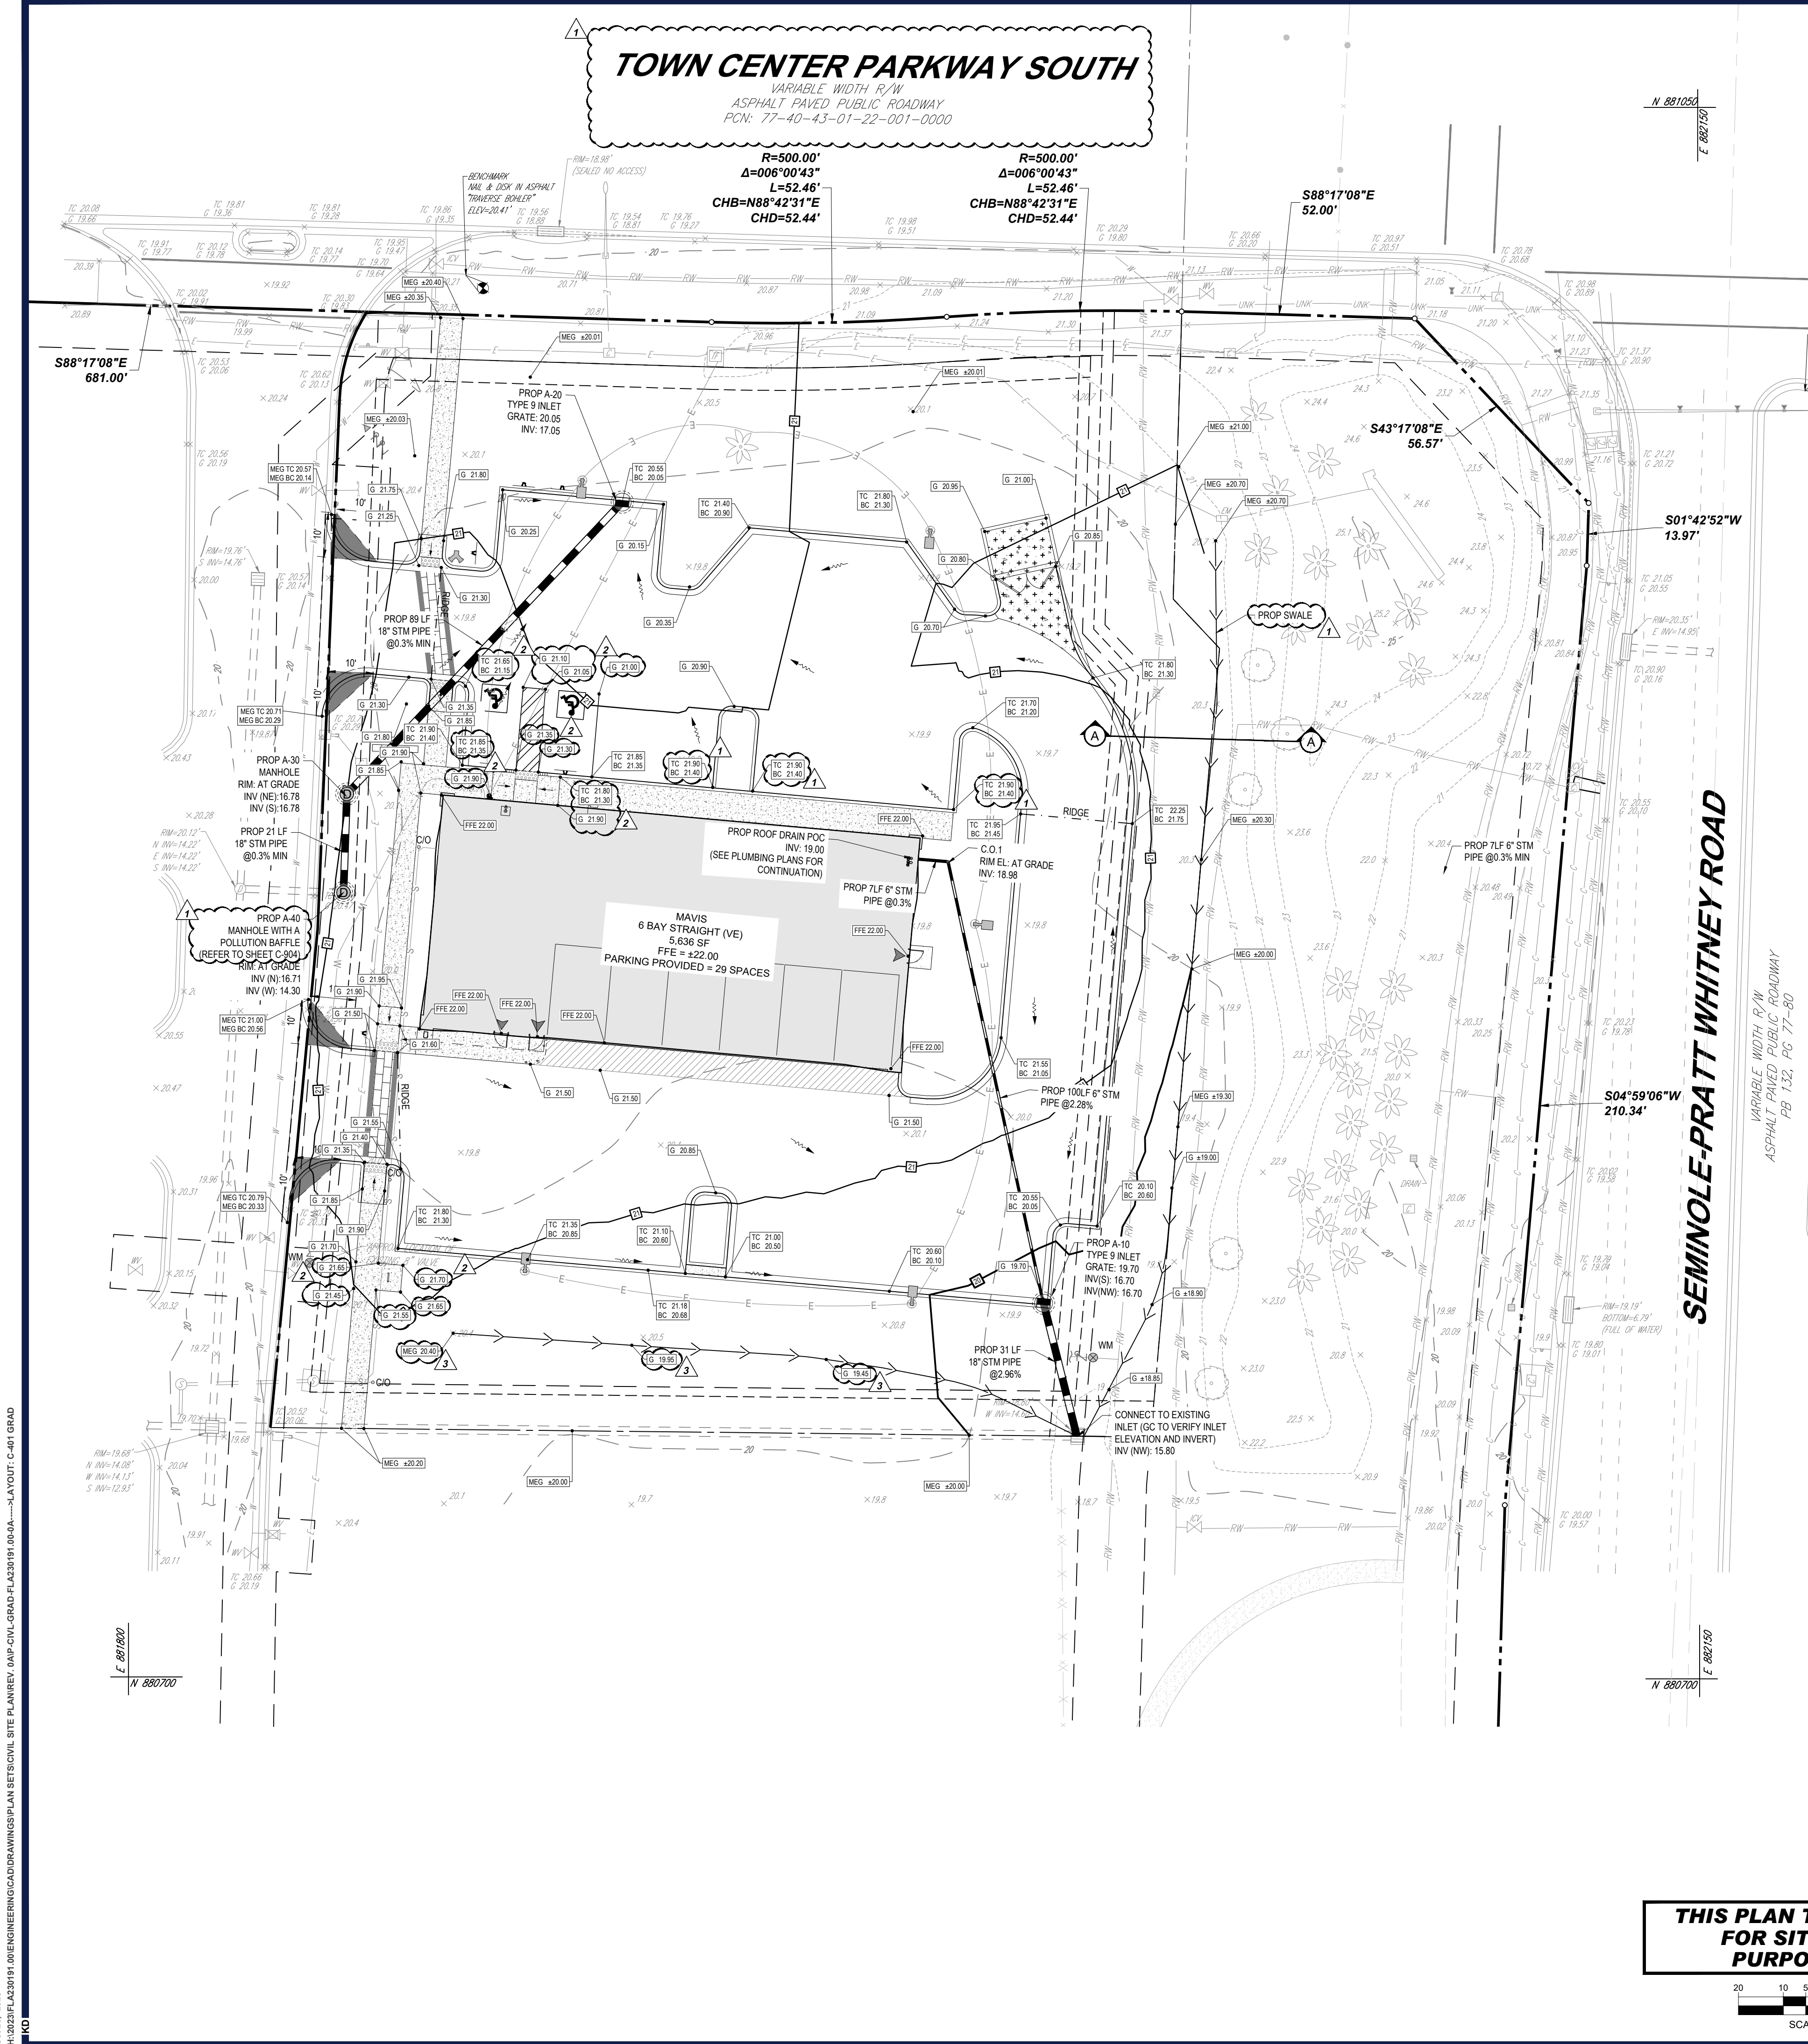

GENERAL NOTES

1. CONTRACTOR WILL BE RESPONSIBLE FOR VERIFYING THE LOCATION AND DEPTH OF ALL EXISTING UTILITIES PRIOR TO CONSTRUCTION.
2. CONTRACTOR SHALL SUBMIT SHOP DRAWINGS TO THE ENGINEER FOR REVIEW AND APPROVAL PRIOR TO CASTING STRUCTURES.
3. COORDINATE ALL UTILITY LEADS AND BUILDING CONNECTIONS WITH THE ARCHITECTURAL PLANS.
4. STANDARD INDEXES REFER TO THE LATEST EDITION OF F.D.O.T. "ROADWAY AND TRAFFIC DESIGN STANDARDS."
5. ALL DISTURBED AREAS WITHIN RIGHT-OF-WAY WILL NEED TO BE SODED.

PAVING AND GRADING NOTES

- A. GENERAL:
1. ALL ELEVATIONS SHOWN ARE IN REFERENCE TO THE SURVEYOR'S BENCHMARKS AND MUST BE VERIFIED BY THE GENERAL CONTRACTOR PRIOR TO GROUNDWORK.
 2. ALL GRADES SHOWN REFERENCE PROPOSED ELEVATIONS AT EDGE OF PAVEMENT, UNLESS OTHERWISE NOTED. "TC" = TOP OF CURB ELEVATION; "SF" = FINISHED GRADE; "MEG" = PROPOSED GRADE TO MATCH EXISTING GRADE; "TW" = TOP OF RETAINING WALL ELEVATION; "BW" = BOTTOM OF RETAINING WALL ELEVATION.
 3. THE ALTAJACSM LAND TITLE SURVEY SHALL BE CONSIDERED A PART OF THESE PLANS.
 4. THE GEOTECHNICAL REPORT AND RECOMMENDATIONS SET FORTH THEREIN ARE A PART OF THE REQUIRED CONSTRUCTION DOCUMENTS AND IN CASE OF CONFLICT SHALL TAKE PRECEDENCE UNLESS SPECIFICALLY NOTED OTHERWISE ON THE PLANS. THE CONTRACTOR SHALL NOTIFY THE ENGINEER IN WRITING OF ANY SUCH DISCREPANCY BETWEEN GEOTECHNICAL REPORT AND PLANS, ETC.
 5. ALL UNDERGROUND UTILITIES SHALL BE COMPLETED PRIOR TO CONSTRUCTION OF LIMEROCK BASE.
 6. ALL EXISTING PAVEMENT, CUT OR DAMAGED BY CONSTRUCTION, SHALL BE PROPERLY RESTORED AT THE CONTRACTOR'S EXPENSE.
 7. WHERE ANY PROPOSED PAVEMENT IS TO BE CONNECTED TO EXISTING PAVEMENT, THE EXISTING EDGE OF PAVEMENT SHALL BE SAWCUT TO ENSURE A PROPER JOINT.
 8. PRIOR TO CONSTRUCTION OR INSTALLATION, SHOP DRAWINGS SHALL BE SUBMITTED TO AND APPROVED BY THE ENGINEER OF RECORD. IT IS THE RESPONSIBILITY OF THE CONTRACTOR TO OBTAIN ALL OTHER AGENCY APPROVALS IF REQUIRED.
- B. MATERIALS:
1. BASE COURSE SHALL BE ABC-3 PER F.D.O.T. SPECIFICATIONS OR EQUIVALENT LIMEROCK THICKNESS W/ MINIMUM LBR-100 (MAX. 6" LIFTS).
 2. ASPHALT SURFACES SHALL BE TYPE S-III ASPHALTIC CONCRETE, UNLESS OTHERWISE SPECIFIED ON THE PLANS. SHALL BE A MINIMUM OF 1-1/2" THICK, AND SHALL BE CONSTRUCTED IN TWO 3/4" LIFTS, WITH TACKCOAT BETWEEN LIFTS.
 3. REINFORCED CONCRETE SLABS SHALL BE CONSTRUCTED OF CLASS I CONCRETE WITH A MINIMUM STRENGTH OF 3,000 PSI AND SHALL BE REINFORCED WITH A 6" x 6" NO. 6 GAUGE WIRE MESH.
- C. INSTALLATION:
1. SUBGRADE FOR ROADWAY SHALL BE COMPACTED TO A MINIMUM OF 98% OF THE MAXIMUM DENSITY (ASHTO T-180), SHALL BE A MINIMUM 12", AND SHALL HAVE A MINIMUM LBR 40.
 2. BASE COURSE MATERIAL FOR PAVED AREAS SHALL BE A MINIMUM THICKNESS OF 6" PLACED IN ONE LIFT. ADDITIONALLY, BASE COURSE MATERIAL SHALL HAVE A MINIMUM MARSHALL STABILITY OF 1000, UNLESS OTHERWISE INDICATED (OR LBR-100).
 3. BASE COURSE SHALL BE COMPACTED TO 98% OF THE MAXIMUM DENSITY AS PER ASHTO T-180.
 4. INSTALLATION OF THE WEARING SURFACE SHALL CONFORM TO THE REQUIREMENTS OF THE D.O.T. STANDARD SPECIFICATIONS FOR TYPE S-III ASPHALTIC CONCRETE OR THE LATEST REVISION.
- D. TESTING:
1. THE FINISHED SURFACE OF THE BASE COURSE AND THAT OF THE WEARING SURFACE SHALL NOT VARY MORE THAN 1/4" FROM THE TEMPLATE. ANY IRREGULARITIES EXCEEDING THIS LIMIT SHALL BE CORRECTED.
 2. DENSITY TESTS SHALL BE TAKEN BY AN INDEPENDENT TESTING LABORATORY CERTIFIED BY THE STATE OF FLORIDA, WHERE DIRECTED BY THE ENGINEER.
 3. ALL TESTING COSTS (PAVING) SHALL BE PAID FOR BY THE CONTRACTOR.
 4. DENSITY TESTS ON THE STABILIZED SUBGRADE SHALL BE SUPPLIED TO AND APPROVED BY THE ENGINEER OF RECORD AND GEOTECHNICAL ENGINEER BEFORE ANY BASE IS CONSTRUCTED.
 5. DENSITY TESTS AND "AS-BUILTS" ON THE FINISHED BASE SHALL BE SUPPLIED TO AND APPROVED BY THE GEOTECHNICAL ENGINEER BEFORE ANY ASPHALT PAVEMENT IS CONSTRUCTED.

DATUM NOTE

ELEVATIONS ARE BASED ON NAVD83 DATUM DETERMINED BY GPS OBSERVATIONS AND TIED IN TO THE NGS NO. D18238 WITH A PUBLISHED ELEVATION OF 21.01 FEET.

FEMA NOTE

THE PROPERTY IS LOCATED IN OTHER AREAS ZONE X (AREAS DETERMINED TO BE OUTSIDE THE 0.2% ANNUAL CHANCE FLOODPLAIN) AND SPECIAL FLOOD HAZARD AREAS SUBJECT TO INUNDATION BY THE 1% ANNUAL CHANCE FLOOD ZONE AE (BASE FLOOD ELEVATIONS DETERMINED) PER MAP ENTITLED "FIRM FLOOD INSURANCE RATE MAP, PALM BEACH COUNTY, FLORIDA AND INCORPORATED AREAS, PANEL 345 OF 1200", MAP NUMBER 12096C345F, WITH A MAP EFFECTIVE DATE OF OCTOBER 5, 2017.

DEWATERING NOTE

CONTRACTOR SHALL SUBMIT DEWATERING PLAN TO THE DISTRICT 14 DAYS PRIOR TO COMMENCEMENT, SUBJECT PLANS SHALL BE REVISED AS NECESSARY.

LEGEND	
GRADING PLAN	
PROPERTY LINE	---
LEASE PROPERTY LINE	---
PROP SPOT ELEVATION	12.35
EX STORM SEWER	==
PROP STORM SEWER	==
PROP GRATE INLET	⊗
PROP STORM CLEANOUT	⊙
PROP STORM MANHOLE	⊗
RIDGE LINE	---
SWALE LINE	---
EX BENCHMARK	⊗
PROP CONCRETE SIDEWALK	---
PROP STANDARD DUTY CONCRETE	---
PROP HEAVY DUTY CONCRETE	---
PROP STANDARD DUTY ASPHALT	---
PROP HEAVY DUTY ASPHALT	---

REVISIONS

REV	DATE	COMMENT	DRAWN BY
1	7/14/2025	1ST ROUND OF COMMENTS	AH
2	8/11/2025	2ND ROUND OF COMMENTS	KD
3	08/14/2025	QA/QC COMMENTS	AH
4	10/23/2025	3RD ROUND OF COMMENTS	KD



ISSUED FOR MUNICIPAL & AGENCY REVIEW & APPROVAL

THIS DRAWING IS INTENDED FOR MUNICIPAL AND/OR AGENCY REVIEW AND APPROVAL. IT IS NOT INTENDED AS A CONSTRUCTION DOCUMENT UNLESS INDICATED OTHERWISE.

PROJECT NO.: FLA230191 00-04
DRAWN BY: -AHM-
CHECKED BY: -KDKM-
DATE: 10/23/2025
CAD ID: P-CIVIL-GRAD

PROJECT:

SITE CONSTRUCTION PLANS FOR




16775 PERSIMMON BLVD
WESTLAKE, FL 33470
CITY OF WESTLAKE
S 01, T 43S, R 40E

BOHLER

600 N. WESTSHORE BLVD. SUITE 950
TAMPA, FLORIDA 33609
Phone: (813) 812-4100
Fax: (813) 812-4101

FLORIDA BUSINESS CERT. OF AUTH. NO. 30780

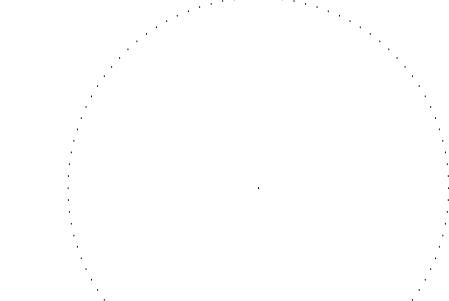


SHEET TITLE:

GRADING PLAN


SHEET NUMBER:

C-401

REVISION 4 - 10/23/2025

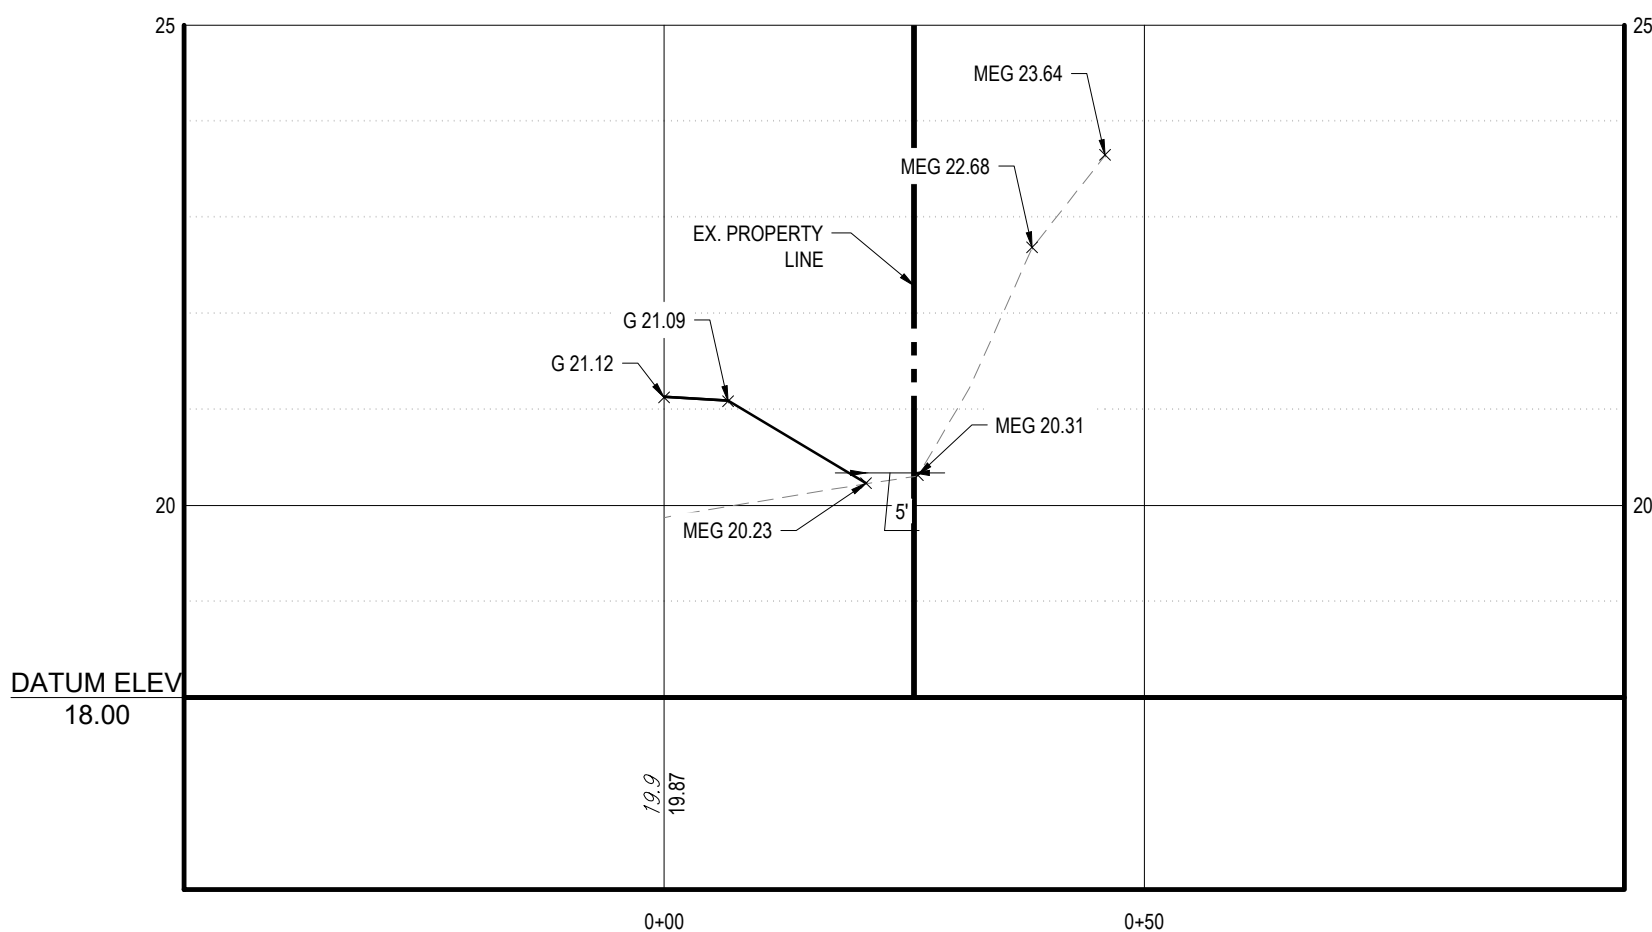


 THIS PLAN TO BE UTILIZED FOR SITE GRADING PURPOSES ONLY



Section A-A

SCALE: 1"=20' HORIZONTAL
1"=2' VERTICAL

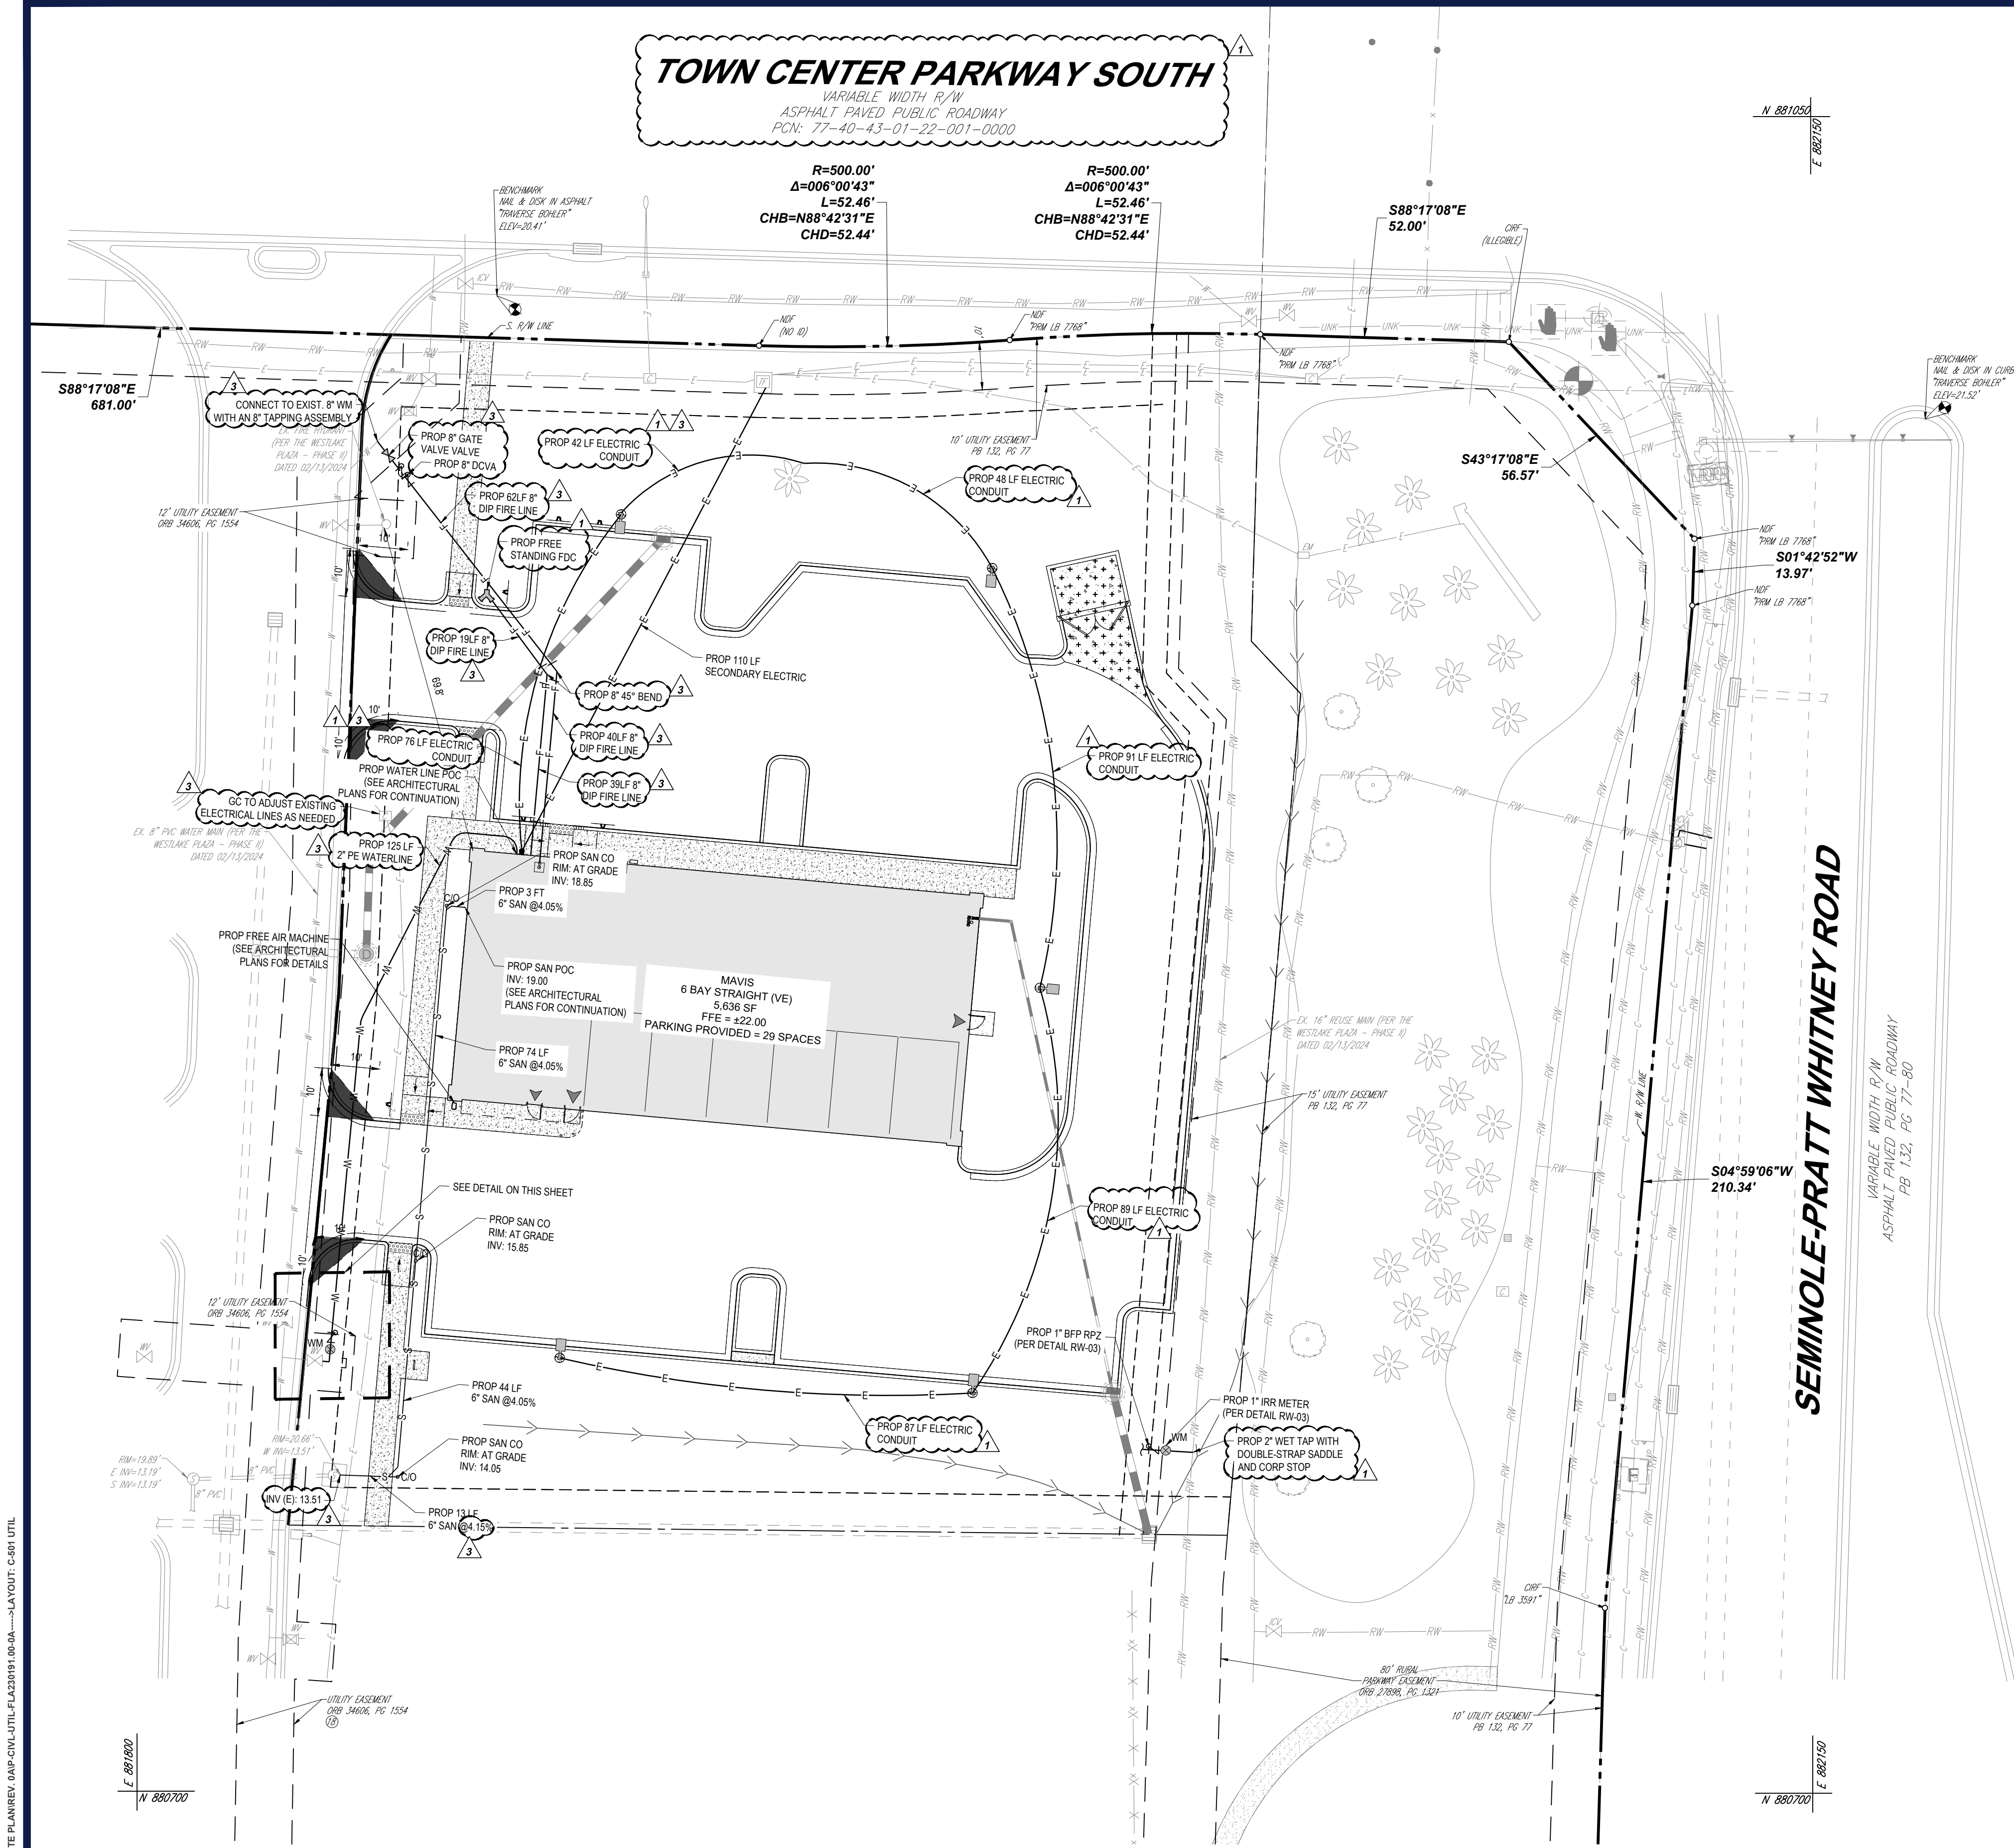

DATUM NOTE

ELEVATIONS ARE BASED ON NAVD83 DATUM DETERMINED BY GPS OBSERVATIONS AND TIED IN TO THE NGS NO. D18238 WITH A PUBLISHED ELEVATION OF 21.01 FEET.

FEMA NOTE

THE PROPERTY IS LOCATED IN OTHER AREAS ZONE X (AREAS DETERMINED TO BE OUTSIDE THE 0.2% ANNUAL CHANCE FLOODPLAIN) AND SPECIAL FLOOD HAZARD AREAS SUBJECT TO INUNDATION BY THE 1% ANNUAL CHANCE FLOOD ZONE AE (BASE FLOOD ELEVATIONS DETERMINED) PER MAP ENTITLED "FIRM FLOOD INSURANCE RATE MAP, PALM BEACH COUNTY, FLORIDA AND INCORPORATED AREAS, PANEL 345 OF 1200", MAP NUMBER 12099C0345F, WITH A MAP EFFECTIVE DATE OF OCTOBER 5, 2017.

GENERAL NOTE

ALL ONSITE WATER AND SEWER DISTRIBUTION/COLLECTION LINES/MAINS TO BE PRIVATELY OWNED & MAINTAINED UNLESS OR UNTIL A UTILITY EASEMENT IS DESCRIBED & APPROVED BY ALL INVOLVED PARTIES.

SANITARY SEWER NOTES


- GENERAL:
 - DISTANCE AND LENGTHS SHOWN ON PLANS AND PROFILE DRAWINGS ARE REFERENCED TO THE CENTER OF STRUCTURES.
 - PRIOR TO COMMENCING CONSTRUCTION, CONTRACTOR TO TELEVIEW EXISTING SANITARY SEWER LINE FROM POINT OF CONNECTION THROUGH THE NEXT SEQUENTIAL DOWNSTREAM RUN OF PIPE. ADDITIONALLY, PRIOR TO COMPLETION OF CONSTRUCTION, CONTRACTOR SHALL TELEVIEW THE NEWLY INSTALLED SANITARY SEWER MAIN TO ENSURE NO DIPS OR DEBRIS WITHIN LINE.
 - EXISTING SERVICES WITHIN MANHOLES SHALL BE RELOCATED TO NEW SEWER.
 - BYPASS PUMPING MAY BE REQUIRED AND SANITARY SERVICE MAINTAINED WHILE EXISTING SEWER IS BEING REPLACED.
 - CONTRACTOR WILL BE REQUIRED TO COORDINATE WITH CITY WITH MAKING CONNECTION TO PUMP STATION / MANHOLE.
 - CONTRACTOR MUST COORDINATE WITH CITY AND SHOPPING CENTER AND PROVIDE AT LEAST 48-HOURS NOTICE PRIOR TO REPLACING SERVICES.
- MATERIALS:
 - ALL PVC SEWER PIPE AND FITTINGS SHALL BE NON-PRESSURE POLYVINYL CHLORIDE (PVC) PIPE CONFORMING TO ASTM D 3034, SDR 26, WITH PUSH-ON RUBBER GASKET JOINTS.
 - ALL FITTINGS AND ACCESSORIES SHALL BE AS MANUFACTURED OR SUPPLIED BY THE PIPE MANUFACTURER OR APPROVED EQUAL.
 - ALL SANITARY CLEANOUTS WITHIN PAVEMENT SHALL HAVE A LID THAT IS H2O LOADING.
- INSTALLATION:
 - PIPE AND FITTINGS:
 - SEWER PIPE SHALL BE INSTALLED IN ACCORDANCE WITH ASTM D3231, AND THE UN-BELL PLASTICS PIPE ASSOCIATION'S RECOMMENDED PRACTICE FOR THE INSTALLATION OF PVC SEWER PIPE.
 - BEDDING AND INITIAL BACKFILL (12" OVER SEWER MAINS AND SERVICES SHALL BE SAND WITH NO ROCK LARGER THAN 1" IN DIAMETER. PEA ROCK OR 3/4" WASHED ROCK WILL BE USED IN WATER OR WHERE UNSUITABLE BEDDING EXISTS. ALL OTHER FILL SHALL NOT HAVE ROCK LARGER THAN 6" IN DIAMETER.
 - CLEANOUTS:
 - CLEANOUTS SHALL BE SET PLUMB TO LINE AND GRADE ON FIRM CLEAN SUBGRADE PROVIDING UNIFORM BEARING UNDER THE BASE.
 - ALL OPENINGS AND JOINTS SHALL BE SEALED WATER-TIGHT.
 - SERVICE:
 - MINIMUM SLOPE OF ALL SERVICE LINES SHALL BE 1.00%.
 - EACH SERVICE CONNECTION SHALL BE PLUGGED WATER-TIGHT WITH AN APPROVED PLUG.
 - CONNECTION OF SERVICES TO BUILDING'S PLUMBING SHALL BE COORDINATED WITH THE ARCHITECTURAL DRAWINGS.
- TESTING:
 - AFTER CONSTRUCTION OF THE SEWER SYSTEM, THE ENGINEER MAY REQUIRE A VISUAL INFILTRATION AND/OR EXFILTRATION TEST TO BE PERFORMED ON THE ENTIRE SYSTEM OR ANY PART THEREOF.
 - AN AIR TEST MAY BE SUBSTITUTED FOR THE WATER EXFILTRATION TEST, UPON APPROVAL OF THE ENGINEER.
 - SEWER PIPE LEAKAGE ALLOWABLE SHALL NOT EXCEED 150 GALLONS PER DAY PER INCH DIAMETER PER MILE IN A TWO HOUR TEST PERIOD FOR ANY SECTION TESTED. NO VISIBLE LEAKAGE SHALL BE ALLOWED.
 - CONTRACTOR IS RESPONSIBLE FOR CORRECTING ANY DEFICIENCIES PRIOR TO THE CERTIFICATION TO ANY AGENCY.
 - GENERAL CONTRACTOR SHALL EMPLOY AN INDEPENDENT INSPECTOR FOR 100% CONTINUOUS INSPECTION OF THE BEDDING AND BACKFILL OPERATION. COMPACTION TEST SHALL BE TAKEN AT THE BOTTOM OF TRENCH AND AT EACH LIFT OF BACKFILL.
 - GENERAL CONTRACTOR SHALL EMPLOY A LICENSED SURVEYOR AS-BUILT TOP OF PIPE ELEVATIONS TAKEN WHEN BEDDING OPERATIONS IS 75% COMPLETE. THESE ELEVATIONS SHALL BE TAKEN AT POINTS OF CONNECTION, CHANGES IN DIRECTION AND AT MINIMUM 20' INTERVALS ALONG THE LENGTH OF THE PIPE. THESE ELEVATIONS SHALL BE RECORDED AS AS-BUILT DIMENSIONS ON SITE PLAN REVIEW BY PROJECT ENGINEER.
 - ALL SANITARY LINES ARE TO BE FLUSHED PRIOR TO CONTRACTOR TURNOVER OF THE FACILITY.

WATER DISTRIBUTION NOTES

- CONTRACTOR SHALL FOLLOW GUIDELINES AND PROCEDURES OUTLINED BY UTILITY PROVIDER, AND HAVE UTILITY PROVIDER'S MANUAL ON-SITE AT ALL TIMES. THIS POLICY MANUAL SHALL BE CONSIDERED PART OF THE CONSTRUCTION DOCUMENTS AS IT PERTAINS TO APPROVED MATERIALS, INSTALLATION METHODS, INSPECTION NOTIFICATION, AND AS-BUILT/PROJECT CLOSEOUT REQUIREMENTS.
- ALL HIGH DENSITY POLYETHYLENE PIPE AND FITTINGS SHALL MEET THE REQUIREMENTS OF AASHTO M-294 LATEST REVISIONS. ALL PIPING TO BE NON-PERFORATED TUBING.
- CONTRACTOR TO COORDINATE WITH COUNTY AND ADJACENT PROPERTY OWNERS AND BUSINESSES FOR ANY ANTICIPATED WATER INTERRUPTIONS FOR CONNECTION TO EXISTING WATER LINE.
- CONTRACTOR TO DEFLECT OR BEND WATER LINES AS NECESSARY TO MAINTAIN 12" VERTICAL SEPARATION FROM STORM SEWER PER FLORIDA DEPARTMENT OF ENVIRONMENTAL PROTECTION.

SANITARY SEWER GRAVITY NOTES

- IF REQUIRED, THE CONTRACTOR SHALL RECONSTRUCT THE BENCH IN THE EXISTING MANHOLE TO ACCOMMODATE THE NEW FLOW DIRECTION.
- WASTEWATER FLOW IN THE EXISTING SEWER MUST BE MAINTAINED DURING THE INSTALLATION OF THE LATERAL. IF A BY-PASS IS REQUIRED, THE CONTRACTOR MUST SUBMIT DETAILS OF THE SYSTEM FOR REVIEW AND APPROVAL TO THE CITY OF WESTLAKE PUBLIC WORKS DEPARTMENT PRIOR TO STARTING CONSTRUCTION.

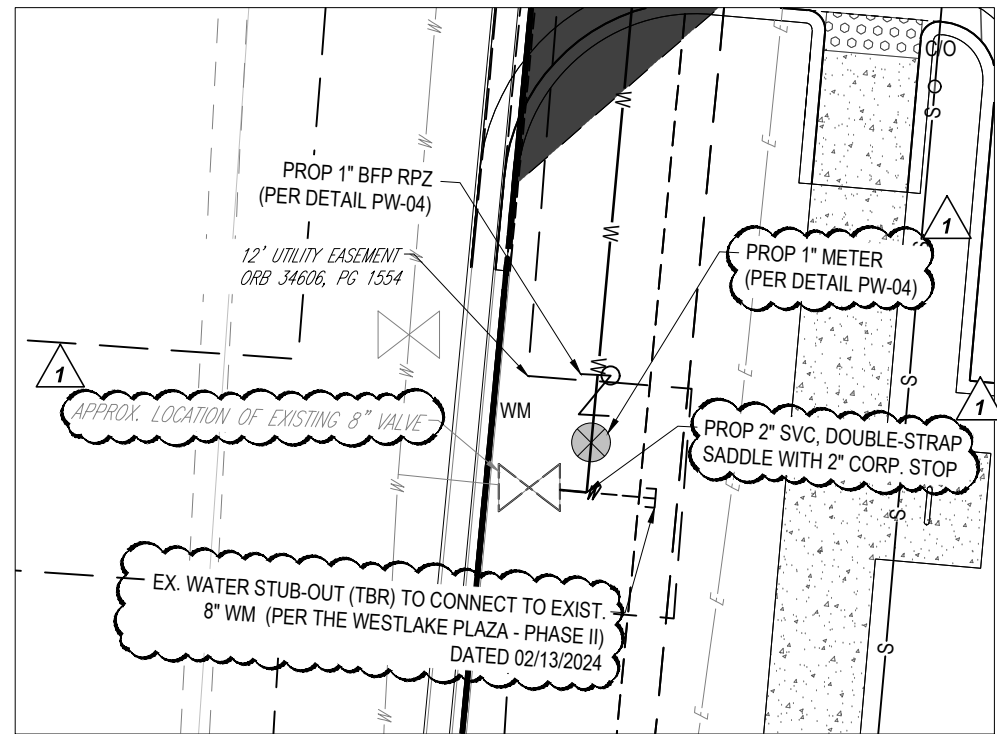

WATER CONNECTION DETAILS
SCALE: 1" = 10'

THIS PLAN TO BE UTILIZED
FOR UTILITIES PURPOSES
ONLY

SCALE: 1" = 20'

LEGEND

UTILITY PLAN

LEASE PROPERTY LINE	---
EX. UNDERGROUND WATER LINE	—W—W—
EX. UNDERGROUND ELECTRIC LINE	—E—E—
EX. STORM SEWER	—S—S—
EX. SANITARY SEWER MAIN	—S—S—
EX. FORCE MAIN	—FM—FM—
EX. OVERHEAD LINE	—OH—OH—
EX. SANITARY MANHOLE	(S)
PROP. UNDERGROUND WATER LINE	—W—W—
PROP. UNDERGROUND ELECTRIC LINE	—E—E—
PROP. STORM SEWER	—S—S—
PROP. SANITARY SEWER MAIN	—S—S—
PROP. TELECOM	—T—T—
PROP. OVERHEAD LINE	—OH—OH—
PROP. SANITARY CLEANOUT	(C)
PROP. BACKFLOW PREVENTER	(B)
PROP. WATER METER	(M)
PROP. WATER VALVE	(V)
PROP. GREASE TRAP	(G)

BOHLER
SITE CIVIL AND CONSULTING ENGINEERING
PROGRAM MANAGEMENT
LANDSCAPE ARCHITECTURE
SUSTAINABLE DESIGN
PERMITTING SERVICES
TRANSPORTATION SERVICES

REVISIONS

REV	DATE	COMMENT	DRAWN BY
1	7/14/2025	1ST ROUND OF COMMENTS	AH
2	8/11/2025	2ND ROUND OF COMMENTS	KD
3	08/14/2025	QA/QC COMMENTS	AH
4	10/23/2025	3RD ROUND OF COMMENTS	KD



ISSUED FOR MUNICIPAL & AGENCY REVIEW & APPROVAL

THIS DRAWING IS INTENDED FOR MUNICIPAL AND/OR AGENCY REVIEW AND APPROVAL. IT IS NOT INTENDED AS A CONSTRUCTION DOCUMENT UNLESS INDICATED OTHERWISE.

PROJECT No.: FLA230191.00-0A
DRAWN BY: -AHMV-
CHECKED BY: -KDKM-
DATE: 10/23/2025
CAD ID: P-CIVL-UTL

PROJECT:

SITE CONSTRUCTION PLANS

FOR



MAVIS TIRES & BRAKES - CITY OF WESTLAKE

16775 PERSIMMON BLVD
WESTLAKE, FL 33470
CITY OF WESTLAKE
S 01, T 43S, R 40E

BOHLER

600 N. WESTSHORE BLVD. SUITE 950
TAMPA, FLORIDA 33609
Phone: (813) 812-4100
Fax: (813) 812-4101

FLORIDA BUSINESS CERT. OF AUTH. No. 30780

This item has been digitally signed and sealed by Kayla M. Dedrick PE on the date adjacent to the seal. Signature must be verified on any electronic copies.

SHEET TITLE:


UTILITY PLAN

SHEET NUMBER:


C-501

REVISION 4 - 10/23/2025

VARIABLE WIDTH R/W
ASPHALT PAVED PUBLIC ROADWAY
PCN: 77-40-43-01-22-001-0000

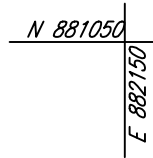

 SOIL EROSION AND SEDIMENT CONTROL PLAN PHASE I

ONSITE PROPERTY LINE / R.O.W. LINE	
LEASE PROPERTY LINE	
NEIGHBORING PROPERTY LINE	
EX. EASEMENT	
EX. ROADWAY C/L	
EX. OVERHEAD ELECTRIC	
EX. STORM SEWER	
EX. SANITARY LINE	
EX. FENCE	
EX. SPOT ELEVATION	
EX. TREE	
EX. CONCRETE	
TO BE REMOVED/ TO BE RELOCATED	
SOIL TRACKING PREVENTION MAT	
PROP. SILT FENCE	
PROP. INLET PROTECTION	
EX. TREE TO BE REMOVED	

- IP INLET PROTECTION
- SF SILT FENCE
- SCE CONSTRUCTION ENTRANCE

BOHLER ENGINEERING FL, LLC IS NOT RESPONSIBLE FOR JOB SITE SAFETY OR SUPERVISION. CONTRACTOR IS TO PROCEED WITH THE DEMOLITION IN A SYSTEMATIC AND SAFE MANNER, FOLLOWING ALL THE OSHA REQUIREMENTS, TO ENSURE PUBLIC AND CONTRACTOR SAFETY.

1. DEMOLITION ACTIVITIES SHALL BE CONDUCTED IN ACCORDANCE WITH THESE PLANS AND SPECIFICATIONS AS WELL AS ALL FEDERAL, STATE, AND LOCAL REGULATIONS. ANY DISCREPANCIES OR DEVIATIONS SHALL BE IDENTIFIED BY THE CONTRACTOR TO BOHLER ENGINEERING FL, LLC IN WRITING FOR RESOLUTION PRIOR TO INITIATION OF SITE ACTIVITY.

2. PRIOR TO STARTING ANY DEMOLITION CONTRACTOR IS RESPONSIBLE FOR:

- A. THE CONTRACTOR SHALL OBTAIN A SUNSHINE STATE ONE CALL LOCATION CERTIFICATION PRIOR TO ANY EXCAVATION OR DEMOLITION. THE NUMBER IS 1-800-433-4770.
- B. THE CONTRACTOR SHALL MAINTAIN ALL UTILITIES MAINTAINED ON SITE AND AVAILABLE FOR REVIEW.
- C. INSTALLING THE REQUIRED SOIL EROSION AND SEDIMENT CONTROL MEASURES PRIOR TO SITE DISTURBANCE.
- D. LOCATECAP ALL UTILITIES AND SERVICES, INCLUDING BUT NOT LIMITED TO GAS, WATER, ELECTRIC, SANITARY AND STORM SEWER, TELEPHONE, CABLE, FIBER OPTIC CABLE, ETC. WITHIN THE LIMITS OF DISTURBANCE.
- E. FENCING AND TRAFFIC CONTROL, ALL ACTIVE SYSTEMS THAT ARE NOT BEING REMOVED DURING ALL DEMOLITION ACTIVITIES.

3. FAMILIARIZING THEMSELVES WITH THE APPLICABLE UTILITY SERVICE PROVIDER AND BEING RESPONSIBLE FOR COORDINATION AND COMMUNICATION WITH ALL UTILITIES AND SERVICE PROVIDERS. CONTRACTOR SHALL PROVIDE THE OWNER WRITTEN NOTIFICATION THAT THE EXISTING UTILITIES AND SERVICES HAVE BEEN TERMINATED AND ABANDONED IN ACCORDANCE WITH JURISDICTION AND UTILITY COMPANY REQUIREMENTS.

4. COORDINATION WITH THE LOCAL COMMUNITY TO AVOID OFF-PEAK HOURS OR ON WEEKENDS AS MAY BE REQUIRED TO MINIMIZE THE IMPACT ON THE AFFECTED PARTIES.

5. A COMPLETE INSPECTION OF CONTAMINANTS BY A LICENSED ENVIRONMENTAL TESTING AGENCY, OF ALL BUILDINGS AND/OR STRUCTURES TO BE REMOVED. SAME SHALL BE PERFORMED IN ACCORDANCE WITH ALL APPLICABLE LOCAL, STATE, AND FEDERAL REGULATIONS. THE CONTRACTOR SHALL BE RESPONSIBLE FOR THE REMOVAL AND DISPOSAL OF BY A FEDERALLY LICENSED CONTRACTOR IN ACCORDANCE WITH FEDERAL, STATE, AND LOCAL REGULATIONS. ALL ENVIRONMENTAL WORK INCLUDING HAZARDOUS MATERIAL, SOILS, ASBESTOS, OR OTHERS REFERENCED OR IMPLIED HEREIN IS THE SOLE RESPONSIBILITY OF THE OWNER'S ENVIRONMENTAL CONSULTANT.

6. THE CONTRACTOR SHALL PROVIDE ALL THE "MEANS AND METHODS" NECESSARY TO PREVENT MOVEMENT, SETTLEMENT, OR COLLAPSE OF EXISTING STRUCTURES, AND ANY OTHER IMPROVEMENTS THAT ARE REMAINING ON OR ADJACENT TO THE SITE. THE USE OF ANY SUCH MEANS AND METHODS SHALL BE APPROVED BY THE OWNER. ITEMS TO BE REMAIN ARE TO REMAIN AS A RESULT OF HIS ACTIVITIES. ALL REPAIRS SHALL USE NEW MATERIAL. THE REPAIRS SHALL RESTORE THE ITEM TO THE PRE-DEMOLITION CONDITION.

7. THE CONTRACTOR SHALL BE RESPONSIBLE FOR THE DEMOLITION SHALL PERFORM EARTH MOVEMENT ACTIVITIES, DEMOLITION AND REMOVAL OF ALL FOUNDATION WALLS, FOOTINGS, AND OTHER MATERIALS WITHIN THE LIMITS OF DISTURBANCE IN ACCORDANCE WITH DIRECTION BY OWNER'S STRUCTURAL OR GEOTECHNICAL ENGINEER.

8. THE CONTRACTOR SHALL BE RESPONSIBLE FOR THE DEMOLITION OF ALL EXISTING UTILITIES AND APPLICABLE GOVERNMENTAL AUTHORITIES. ALL THE REQUIRED PERMITTAL AND EXPLOSIVE CONTROL MEASURES THAT ARE REQUIRED BY THE FEDERAL, STATE, AND LOCAL REGULATIONS SHALL BE IN PLACE PRIOR TO STARTING AN EXPLOSIVE PROGRAM. THE CONTRACTOR IS ALSO RESPONSIBLE FOR ALL INSPECTION AND SEISMIC VIBRATION MONITORING THAT IS REQUIRED BY THE FEDERAL, STATE, AND LOCAL REGULATIONS.

9. THE CONTRACTOR SHALL PROVIDE TRAFFIC CONTROL AND GENERALLY ACCEPTED SAFE PRACTICES IN CONFORMANCE WITH THE "MANUAL ON UNIFORM TRAFFIC CONTROL," AS WELL AS FEDERAL, STATE, AND LOCAL REGULATIONS AND ANY OTHER APPLICABLE GOVERNMENTAL AGENCIES.

10. CONDUCT DEMOLITION ACTIVITIES IN SUCH A MANNER TO ENSURE MINIMUM INTERFERENCE WITH ROADS, STREETS, SIDEWALKS, WALKWAYS, AND OTHER ADJACENT FACILITIES. STREET CLOSURE PERMITS MUST BE RECEIVED FROM THE APPROPRIATE GOVERNMENTAL AUTHORITY.

11. THE CONTRACTOR SHALL NOT USE AREAS OUTSIDE THE DEFINED PROPERTY LINE WITHOUT WRITTEN PERMISSION OF THE OWNER, AND NOT APPROVE GOVERNMENT AGENCY.

12. USE DUST CONTROL MEASURES TO LIMIT AIRBORNE DUST AND DIRT RISING AND SCATTERING IN THE AIR IN ACCORDANCE WITH THE FEDERAL, STATE, AND LOCAL REGULATIONS. ALL EXISTING UTILITIES AND ADJACENT STRUCTURES AND IMPROVEMENTS SHALL BE CLEANED OF ALL DUST AND DEBRIS CAUSED BY THE DEMOLITION OPERATIONS. THE CONTRACTOR IS RESPONSIBLE FOR RETURNING ALL ADJACENT AREAS TO THEIR PRE-DEMOLITION CONDITION.

13. THE CONTRACTOR IS RESPONSIBLE TO SAFEGUARD SITE AS NECESSARY TO PERFORM THE DEMOLITION IN SUCH A MANNER AS TO PREVENT THE ENTRY OF UNAUTHORIZED PERSONS AT ANY TIME.

14. THIS DEMOLITION PLAN IS INTENDED TO IDENTIFY THOSE EXISTING ITEMS/CONDITIONS AND MEANS ARE TO BE REMOVED. IT IS NOT INTENDED TO IDENTIFY EXISTING UTILITIES OR CONDITIONS AND MEANS ARE TO BE REMOVED. THE CONTRACTOR SHALL BE RESPONSIBLE FOR ALL DISCREPANCIES WITH ALL FEDERAL, STATE, AND LOCAL REGULATIONS. THE CONTRACTOR SHALL BE RESPONSIBLE FOR ALL OSHA AND OTHER SAFETY PRECAUTIONS NECESSARY TO PROVIDE A SAFE WORK SITE.

15. DEBRIS SHALL NOT BE REUSED OR RECYCLED. ALL EXISTING MATERIALS (SOLID WASTE) SHALL BE DISPOSED OF IN ACCORDANCE WITH ALL FEDERAL, STATE, AND LOCAL REGULATIONS AND APPLICABLE CODES.

16. THE CONTRACTOR IS RESPONSIBLE FOR FIELD VERIFYING ALL EXISTING SITE IMPROVEMENTS AND UTILITIES. ALL DISCREPANCIES SHALL BE IDENTIFIED TO THE ENGINEER IN WRITING.

17. ALL EXISTING UTILITIES REMOVED SHALL BE DONE SO BY THE CONTRACTOR IN ACCORDANCE WITH STATE AND LOCAL REGULATIONS.

18. THERE ARE NO KNOWN WATER COURSES, WATER BODIES, FLOODPLAINS, XERIC UPLANDS, WETLANDS, CUTOATH OR OTHER SENSITIVE, HISTORIC, OR CULTURAL RESOURCES OR CONDITIONS OF INFLUENCE FOR POTABLE WELLS, AQUIFER RECHARGE AREAS, SOIL TYPES, AND VEGETATIVE COVER LOCATED WITHIN PROJECT LIMITS.

ELEVATIONS ARE BASED ON NAVD88 DATUM DETERMINED BY GPS OBSERVATIONS AND TIED IN TO THE NGS NO. DI8238 WITH A PUBLISHED ELEVATION OF 21.01 FEET.

THE PROPERTY IS LOCATED IN OTHER AREAS ZONE X (AREAS DETERMINED TO BE OUTSIDE THE 0.2% ANNUAL CHANCE FLOODPLAIN) AND SPECIAL FLOOD HAZARD AREAS SUBJECT TO INUNDATION BY THE 1% ANNUAL CHANCE FLOOD ZONE AE (BASE FLOOD ELEVATIONS DETERMINED) PER MAP ENTITLED "FIRM FLOOD INSURANCE RATE MAP, PALM BEACH COUNTY, FLORIDA AND INCORPORATED AREAS, PANEL 345 OF 1200", MAP NUMBER 12099C0345F, WITH A MAP EFFECTIVE DATE OF OCTOBER 5, 2017.

SCALE: 1" = 20'

REV	DATE	COMMENT
1	7/14/2025	1ST ROUND OF COMMENTS
2	8/11/2025	2ND ROUND OF COMMENTS
3	08/14/2025	QAQC COMMENTS
4	10/23/2025	3RD ROUND OF COMMENTS



THIS DRAWING IS INTENDED FOR MUNICIPAL AND/OR AGENCY
REVIEW AND APPROVAL. IT IS NOT INTENDED AS A CONSTRUCTION
DOCUMENT UNLESS INDICATED OTHERWISE.

PROJECT No.: FLA230191.00-0A
DRAWN BY: ~AH/MV~
CHECKED BY: ~KD/KM~
DATE: 10/23/2025
CAD I.D.: P-CIVL-EROS

PROJECT:

MAVIS
TIRES & BRAKES
at DISCOUNT PRICES

MAVIS TIRES & BRAKES - CITY OF WESTLAKE

16775 PERSIMMON BLVD
WESTLAKE, FL 33470
CITY OF WESTLAKE
S 01, T 43S, R 40E

BOHLERTM

**600 N. WESTSHORE BLVD. SUITE 950
TAMPA, FLORIDA 33609
Phone: (813) 812-4100
Fax: (813) 812-4101**

FLORIDA BUSINESS CERT. OF AUTH. No. 30780

This item has been digitally signed and sealed by Kayla M Dedrick PE on the date adjacent to the seal. Signature must be verified on any electronic copies.


SHEET TITLE:
***EROSION AND
SEDIMENT
CONTROL PLAN
PHASE 1***

SHEET NUMBER:

C-801

REVISION 4 - 10/23/2025

VARIABLE WIDTH R/W
ASPHALT PAVED PUBLIC ROADWAY
PCN: 77-40-43-01-22-001-0000

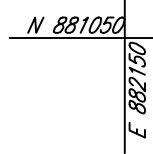

SOIL EROSION AND SEDIMENT CONTROL PLAN PHASE II

ONSITE PROPERTY LINE / R.O.W. LINE	
LEASE PROPERTY LINE	
NEIGHBORING PROPERTY LINE	
EX. OVERHEAD ELECTRIC	
EX. SPOT ELEVATION	
PROP. STORM SEWER	
RIDGE LINE	
PROP. SILT FENCE	
PROP. INLET PROTECTION	
SOIL TRACKING PREVENTION MAT	

(IP) INLET PROTECTION
 (SF) SILT FENCE
 (SCE) CONSTRUCTION ENTRANCE

1. EROSION AND SEDIMENT CONTROL BMP'S IN ADDITION TO THOSE PRESENTED ON THESE PLANS SHALL BE IMPLEMENTED AS NECESSARY TO PREVENT TURBID DISCHARGES FROM FLOWING INTO ADJACENT PROPERTIES OR INTO SURFACE WATERS. BMP'S SHALL BE DESIGNED, INSTALLED, AND MAINTAINED BY THE SITE OPERATOR TO ENSURE THAT OFF SITE SURFACE WATER QUALITY REMAINS CONSISTENT WITH FEDERAL, STATE, AND LOCAL REGULATIONS. (THE OPERATOR IS THE ENTITY THAT OWNS OR OPERATES THE PROJECT AND HAS AUTHORITY TO CONTROL THOSE ACTIVITIES AT THE PROJECT NECESSARY TO ENSURE COMPLIANCE.)
2. OFF SITE SURFACE WATER DISCHARGES, DISCHARGES TO ONSITE WETLANDS, OR SURFACE WATERS WITH TURBIDITY IN EXCESS OF 25 NEPHELOMETRIC TURBIDITY UNITS (NTU) ABOVE BACKGROUND OR OTHERS OR OTHER UNWANTED SUCH INCIDENTS SHALL BE REPORTED TO WATER RESOURCES WITHIN 24 HOURS OF THE OCCURRENCE. THE REPORT SHALL INCLUDE THE CAUSE OF THE DISCHARGE AND CORRECTIVE ACTIONS TAKEN.
3. THE OPERATOR SHALL HAVE UNCONFINED PROPERTIES ARE NOT IMPACTED BY WIND EROSION, OR EMISSIONS OF UNCONFINED PARTICULATE MATTER IN ACCORDANCE WITH RULE 62-296.320(4)(C)1, F.A.C., BY TAKING APPROPRIATE MEASURES TO STABILIZE AFFECTED AREAS.
4. FUEL AND OTHER PETROLEUM PRODUCT SPILLS THAT ENTER STORMWATER DRAINS OR WATERBODIES, OR FUEL OR OTHER PETROLEUM ADJACENT IS DISCOVERED, 100 GALLONS SHALL BE CONTAINED, CLEANED UP, AND IMMEDIATELY REPORTED TO WATER RESOURCES. SMALLER GROUNDWATER SPILLS SHALL BE CLEANED UP AS SOON AS PRACTICAL.
5. THE OPERATOR SHALL MAINTAIN ACCESS TO ALL AREAS DURING DEVELOPMENT OF THE SITE, ALL ACTIVITY IN THE VICINITY OF THE CONTAMINATION SHALL IMMEDIATELY CEASE AND WATER RESOURCES SHALL BE CONTACTED.
6. PRIOR TO DEMOLITION OF EXISTING ON SITE STRUCTURES AN ASBESTOS SURVEY AND/OR ASBESTOS NOTIFICATION MAY BE REQUIRED.
7. NATIONAL POLLUTANT DISCHARGE ELIMINATION SYSTEM:
 - A. NPDES CONSTRUCTION GENERIC PERMIT COVERAGE SHALL BE OBTAINED AT LEAST 48 HOURS IN ADVANCE OF CONSTRUCTION COMMENCEMENT IN ACCORDANCE WITH RULE 62-621.300(4)(A).
 - B. A COPY OF THE CERTIFIED NPDES NOI, OR A COPY OF THE FDEP COVERAGE CONFIRMATION LETTER SHALL BE POSTED AT THE SITE IN ACCORDANCE WITH RULE 62-621.300(4)(A) PART 1, F.A.C.
 - C. A COPY OF THE CERTIFIED NPDES NOI, OR A COPY OF THE FDEP COVERAGE CONFIRMATION LETTER SHALL BE PROVIDED TO WATER RESOURCES IN ACCORDANCE WITH RULE 62-621.300(4)(A) PART III D, F.A.C.
 - D. THE SWPPP SHALL BE CERTIFIED IN ACCORDANCE WITH RULE 62-621.300(4)(A) PART V D.6, F.A.C.
 - E. A COPY OF THE SWPPP, AND COPIES OF THE INSPECTION AND MAINTENANCE RECORDS SHALL BE MAINTAINED AT THE PROJECT SITE, AND SHALL BE READILY AVAILABLE TO COUNTY OR STATE INSPECTORS.
8. THE DISCHARGE OF GROUNDWATER PRODUCED THROUGH DEWATERING, TO SURFACE WATERS, OR ANY PORTION OF THE MSA WILL REQUIRE SEPARATE PERMITTING FROM THE FLORIDA DEPARTMENT OF ENVIRONMENTAL PROTECTION (DEP). PERMITS SHALL BE OBTAINED PRIOR TO THE COMMENCEMENT OF DEWATERING.

1. N.P.D.S. PERMIT COMPLIANCE REQUIRES INSPECTIONS EVERY 7 CALENDAR DAYS BY A NPDES QUALIFIED INSPECTOR AND PERIODIC INSPECTIONS WITHIN 24 HOURS OF ANY RAINFALL EVENT OF 0.5" OR GREATER. THE INSPECTIONS REQUIRED BY THE PERMIT SHALL BE PERFORMED IMMEDIATELY FOLLOWING THE RAINFALL EVENT. EROSION CONTROL, DEBRIS, AS WELL AS FURTHER MAINTENANCE AS OUTLINED BELOW, IT SHALL BE THE CONTRACTORS RESPONSIBILITY TO ENSURE N.P.D.S. COMPLIANCE.
2. INSPECTIONS BY CONTRACTOR MUST OCCUR AT LEAST ONE WEEK OR WITHIN 24 HOURS OF THE FOLLOWING RAINFALL EVENT.
3. THROUGHOUT THE CONSTRUCTION PERIOD, ALL MUDSILT TRACKED ONTO EXISTING ROADS FROM THE SITE DUE TO CONSTRUCTION SHALL BE IMMEDIATELY REMOVED BY THE CONTRACTOR.
4. CATCH BASIN INLET AND CONCRETE FUME FILTERS SHALL BE MAINTAINED CLEAN AT ALL TIMES. WHEN THE FILTERS ARE CLOGGED, THEY SHALL BE REPLACED OR REPERFORMED EVERY 7 CALENDAR DAYS. IF A FILTER HAS HOLES OR IS INUNDATED WITH SEDIMENT, THE FILTER WILL REQUIRE REPLACEMENT BY CONTRACTOR.
5. THROUGHOUT THE CONSTRUCTION PERIOD, TRACKING MAT MUST BE MAINTAINED BY CONTRACTOR. REPLENISH CRUSHED AGGREGATE IF PRESENT LAYER IS FILLED WITH SEDIMENT, POOLING WATER, OR HAS RUTS. A NEW LAYER MAY BE ADDED IF OLD LAYERS BECOME COMPACTED.
6. SILT FENCE IS TO BE INSPECTED DAILY BY CONTRACTOR AND EVERY 7 CALENDAR DAYS BY N.P.D.S. QUALIFIED INSPECTOR. REPAIRS OR REPLACEMENT IF NECESSARY, IT SHALL BE PERFORMED IMMEDIATELY. THE SILT FENCE SHOULD BE TRENCHED IN, BACK-FILLED, AND STAPLED OR STAKED ACCORDING TO THE MANUFACTURER'S SPECIFICATIONS. MAINTENANCE INCLUDES THE REMOVING OF SEDIMENT FROM THE FENCE. THE FENCE SHALL BE MAINTAINED THROUGHOUT THE CONSTRUCTION PERIOD. THE CONTRACTOR MAY HAVE TO REMOVE, REPLACE, RETRENCH, OR RE-BACKFILL THE FENCE IF IT FAILS. IT WOULD ALSO BE NECESSARY TO REINSTALL IF ANY PORTION OF THE FENCING WAS DAMAGED BY CONSTRUCTION MACHINERY.
7. SEEDING OR RESEEDING MAY BE REQUIRED IMMEDIATELY TO AREAS WHICH HAVE BEEN DAMAGED BY RUNOFF.
8. THE CONTRACTOR SHALL CONTINUOUSLY ENSURE THAT THE PERIMETER OF THE SITE, INCLUDING CONSTRUCTION ENCLOSURES, IS SECURED FROM ALLOWING DEBRIS TO LEAVE THE SITE DUE TO CONSTRUCTION ACTIVITIES. DEBRIS SHALL BE REMOVED WEEKLY AND LOGS BE UPDATED AND KEPT ON-SITE IN ACCORDANCE WITH THE N.P.D.S. PERMIT. BY BIDDING DOCUMENTS CONTRACTOR ACKNOWLEDGES HE/SHE IS AWARE OF N.P.D.S. GUIDELINES AND POLICIES AS WELL AS BEST MANAGEMENT PRACTICES AND ACCEPTS SOLE RESPONSIBILITY FOR FINES IMPOSED BY GOVERNMENTAL AGENCIES DUE TO VIOLATIONS.

UPON IMPLEMENTATION AND INSTALLATION OF THE FOLLOWING AREAS: TRAILER PARKING, LAYDOWN, PORTABLE RESTROOMS, WHEELED WASTE DISPOSAL (DUMPSITE/S), WHEEL WASH, CONCRETE WASHOUT, AND OTHER AREAS, THE CONTRACTOR SHALL IMMEDIATELY DENOTE THEM ON THE SITE MAPS AND NOTE ANY CHANGES IN THEIR LOCATIONS ON THE SITE MAP.


PHASE 1

1. CONSTRUCT STABILIZED CONSTRUCTION ENTRANCE AND INSTALL SILT FENCE.
2. INSTALL INLET PROTECTION AT EXISTING INLETS(S).
3. PREPARE CLEARING AND GRUBBING OF THE SITE, IF APPLICABLE.
4. INSTALL STORMWATER CONVEYANCE STRUCTURES AND CULVERTS, ENSURE THAT NEW INLETS ARE PROTECTED PRIOR TO MAKING THE OUTFALL CONNECTION.

PHASE 2

1. PERFORM MASS GRADING, ROUGH GRADE TO ESTABLISH PROPOSED DRAINAGE PATTERNS.
2. START CONSTRUCTION OF THE PROPOSED BUILDING PAD AND STRUCTURES.
3. REPAIR AND RESTORE ALL EXISTING DISTURBED AREAS THAT WILL BE INACTIVE FOR 7 DAYS OR MORE AS REQUIRED BY THE GENERIC PERMIT.

 **THIS PLAN TO BE UTILIZED FOR
SOIL EROSION AND SEDIMENT
CONTROL PURPOSES ONLY**



REV	DATE	COMMENT	DRAWN BY CHECKED BY
1	7/14/2025	1ST ROUND OF COMMENTS	AH KD
2	8/11/2025	2ND ROUND OF COMMENTS	AH KD
3	08/14/2025	QAQC COMMENTS	AH KD
4	10/23/2025	3RD ROUND OF COMMENTS	KD KD



THIS DRAWING IS INTENDED FOR MUNICIPAL AND/OR AGENCY REVIEW AND APPROVAL. IT IS NOT INTENDED AS A CONSTRUCTION DOCUMENT UNLESS INDICATED OTHERWISE.

PROJECT No.:	FLA230191.00-0A
DRAWN BY:	~AH/MV~
CHECKED BY:	~KD/KM ~
DATE:	10/23/2025
CAD I.D.:	P-CIVL-EROS

PROJECT:

MAVIS TIRES & BRAKES - CITY OF WESTLAKE

16775 PERSIMMON BLVD
WESTLAKE, FL 33470
CITY OF WESTLAKE
S 01, T 43S, R 40E

BOHLER//TM

**600 N. WESTSHORE BLVD. SUITE 950
TAMPA, FLORIDA 33609
Phone: (813) 812-4100
Fax: (813) 812-4101**

FLORIDA BUSINESS CERT. OF AUTH. No. 3078


This item has been digitally signed and sealed by Kayla Dedrick PE on the date adjacent to the seal. Signature must be verified on any electronic copies.

**EROSION AND
SEDIMENT
CONTROL
PLAN PHASE 2**

SHEET NUMBER

C-802

REVISION 4 - 10/23/2025

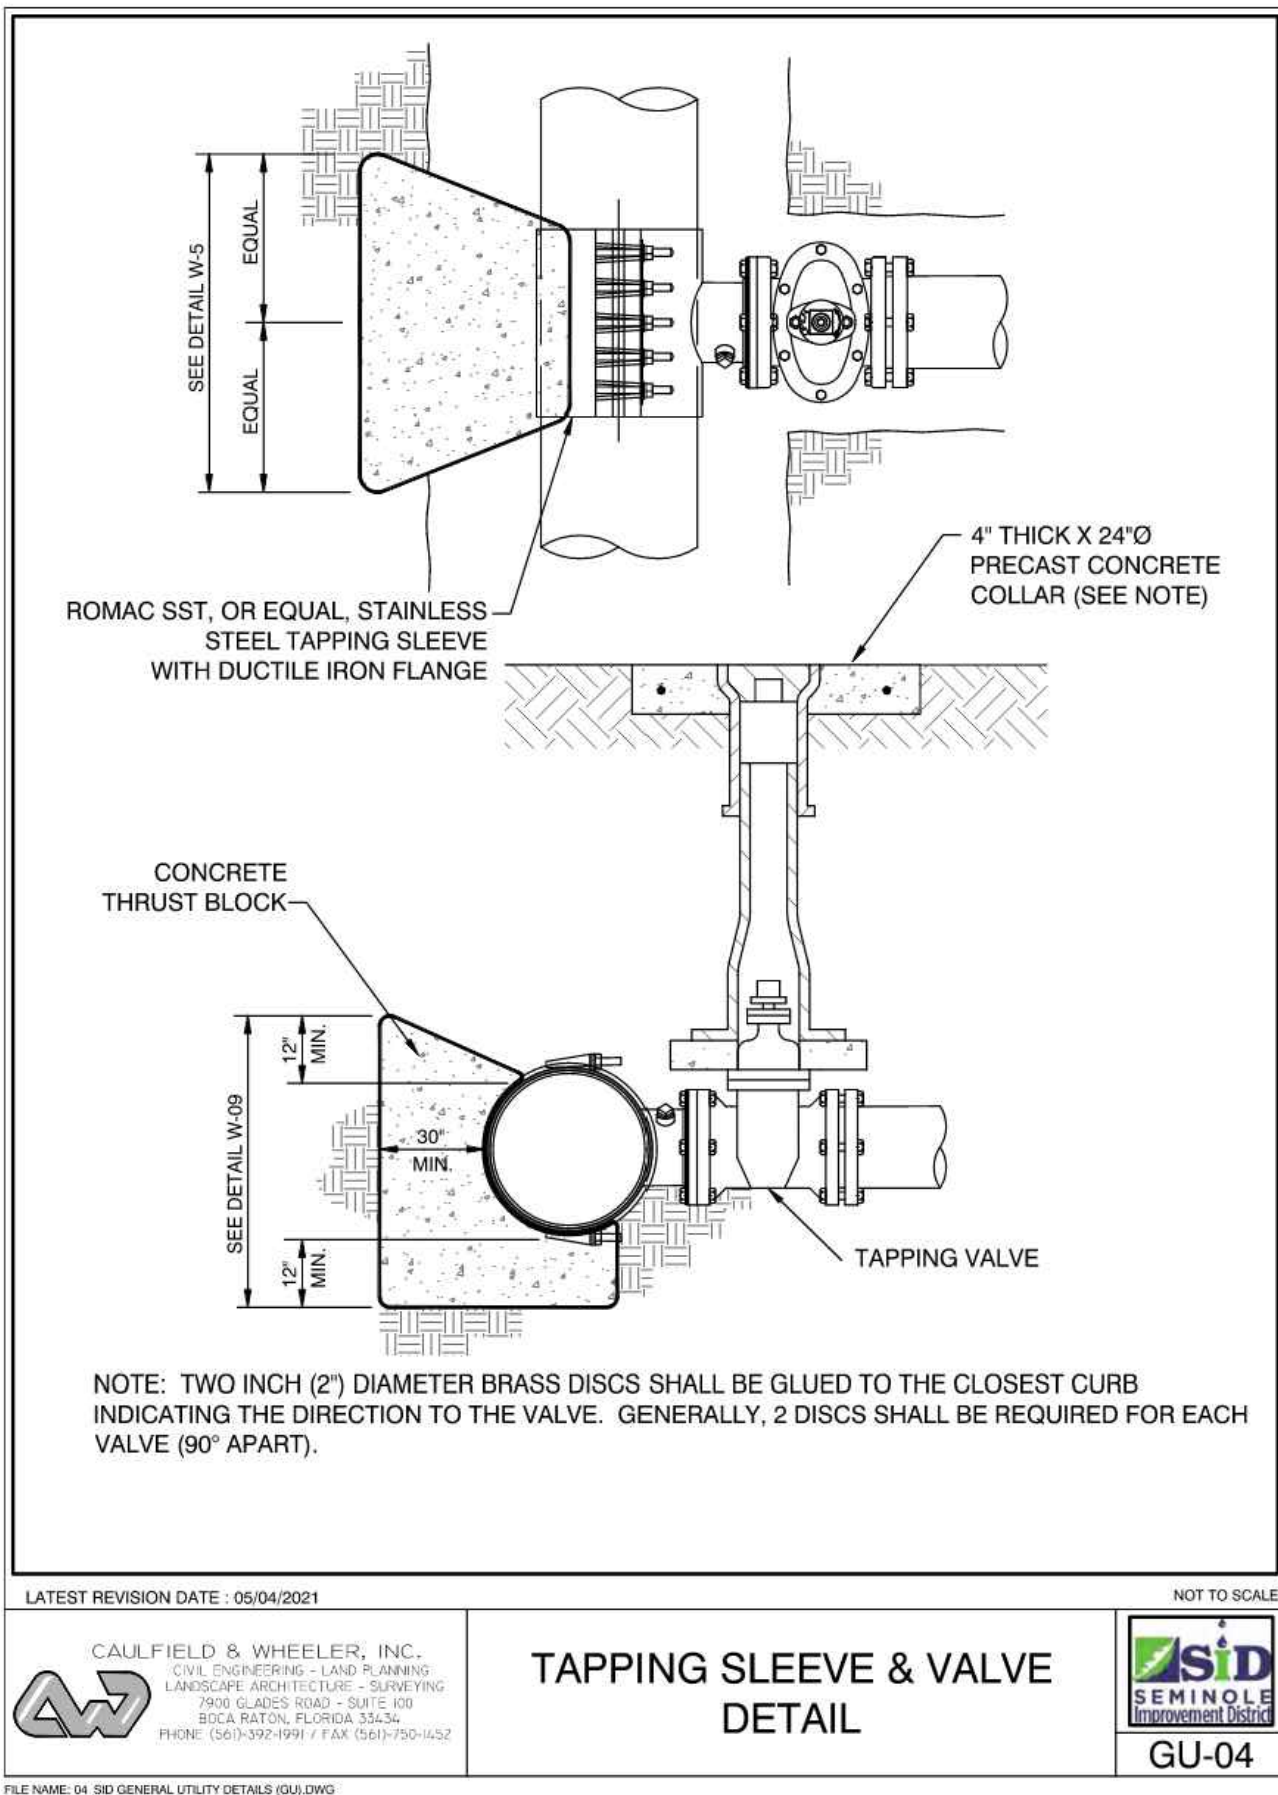


LATEST REVISION DATE: 05/04/2021

CAULFIELD & WHEELER, INC.
CIVIL ENGINEERING - LAND PLANNING
LANDSCAPE ARCHITECTURE - SURVEYING
7900 GUEST ROAD - SUITE 100
BOCA RATON, FLORIDA 33433
PHONE: (561) 392-1991 / FAX: (561) 750-1432

TAPPING SLEEVE & VALVE
DETAIL

GU-04

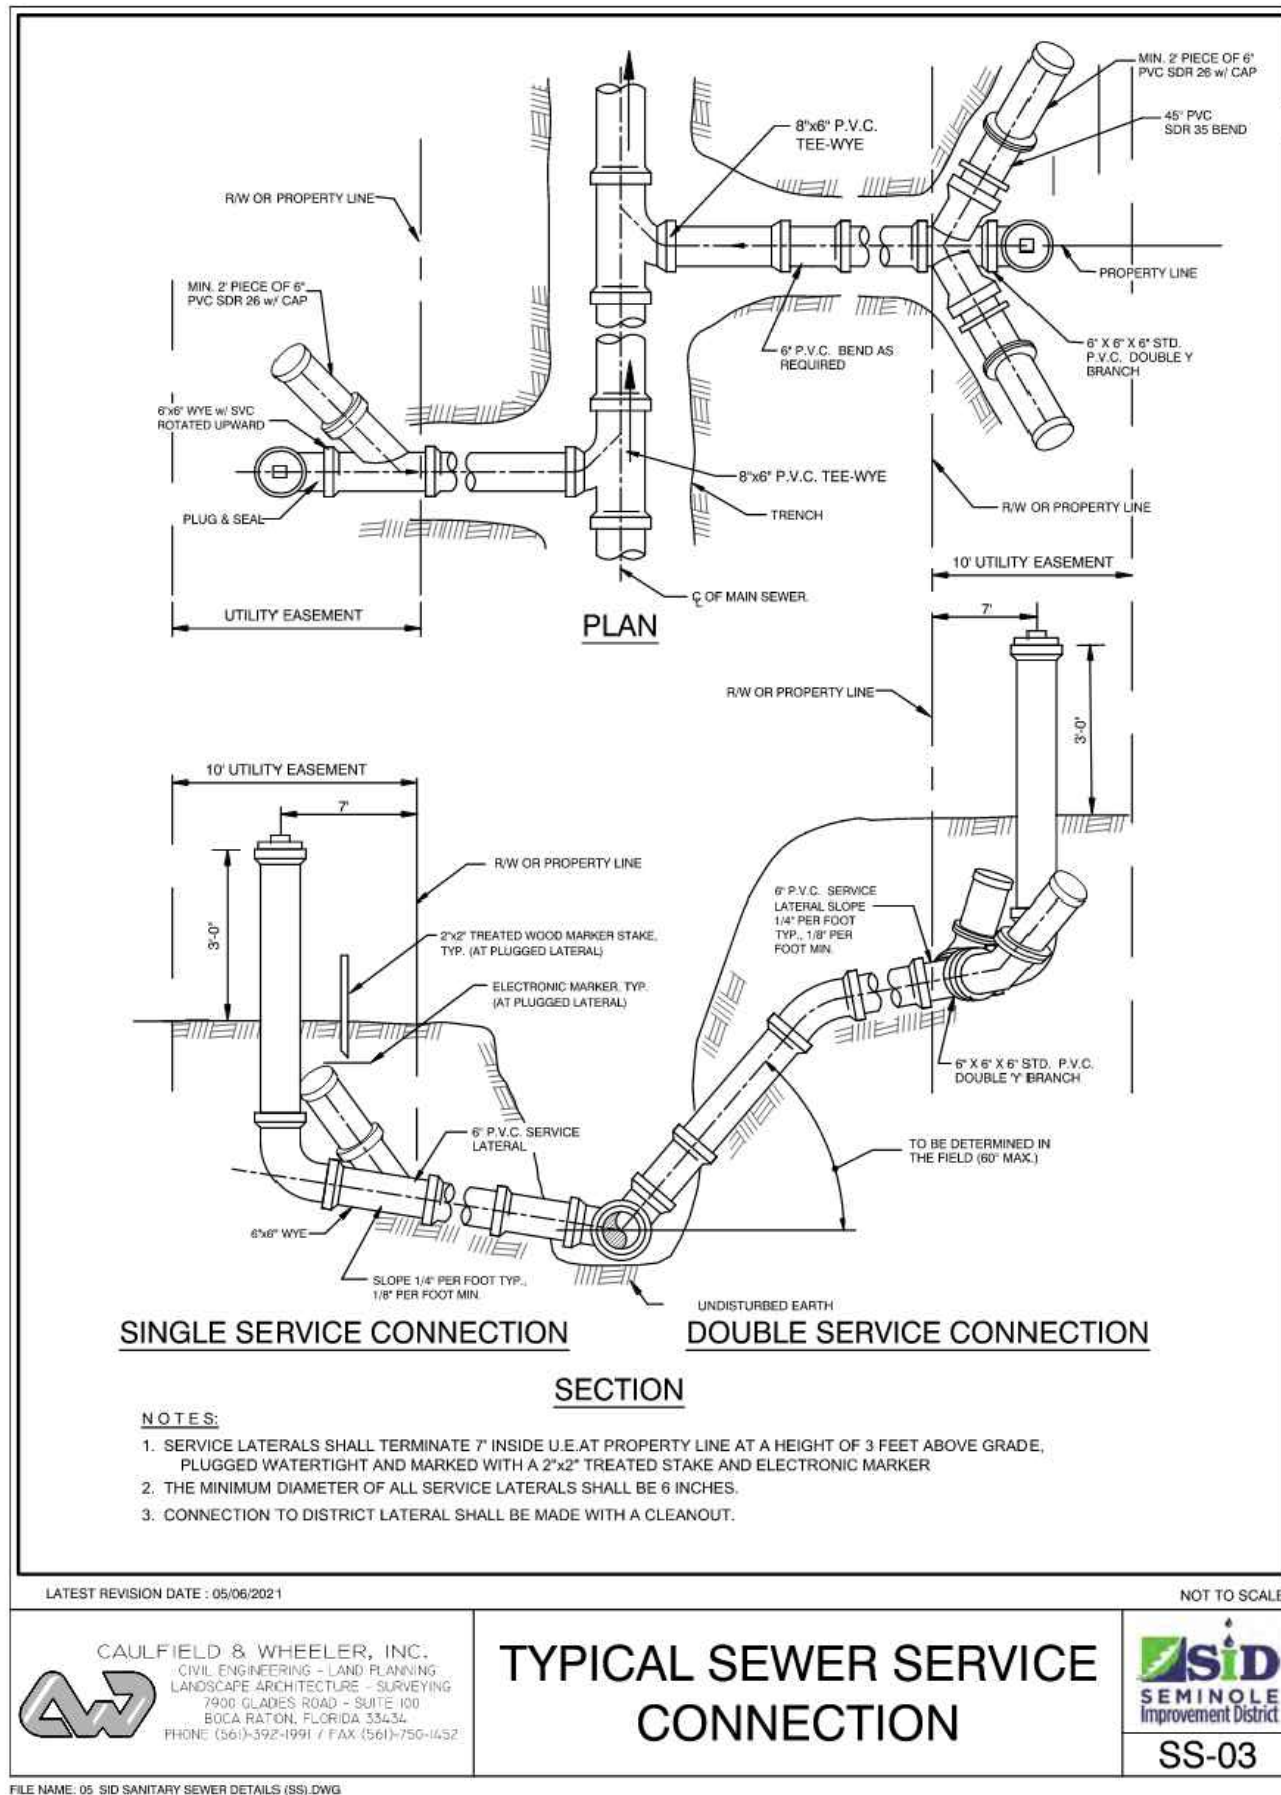


LATEST REVISION DATE: 05/06/2021

CAULFIELD & WHEELER, INC.
CIVIL ENGINEERING - LAND PLANNING
LANDSCAPE ARCHITECTURE - SURVEYING
7900 GUEST ROAD - SUITE 100
BOCA RATON, FLORIDA 33433
PHONE: (561) 392-1991 / FAX: (561) 750-1432

TYPICAL SEWER SERVICE
CONNECTION

SS-03

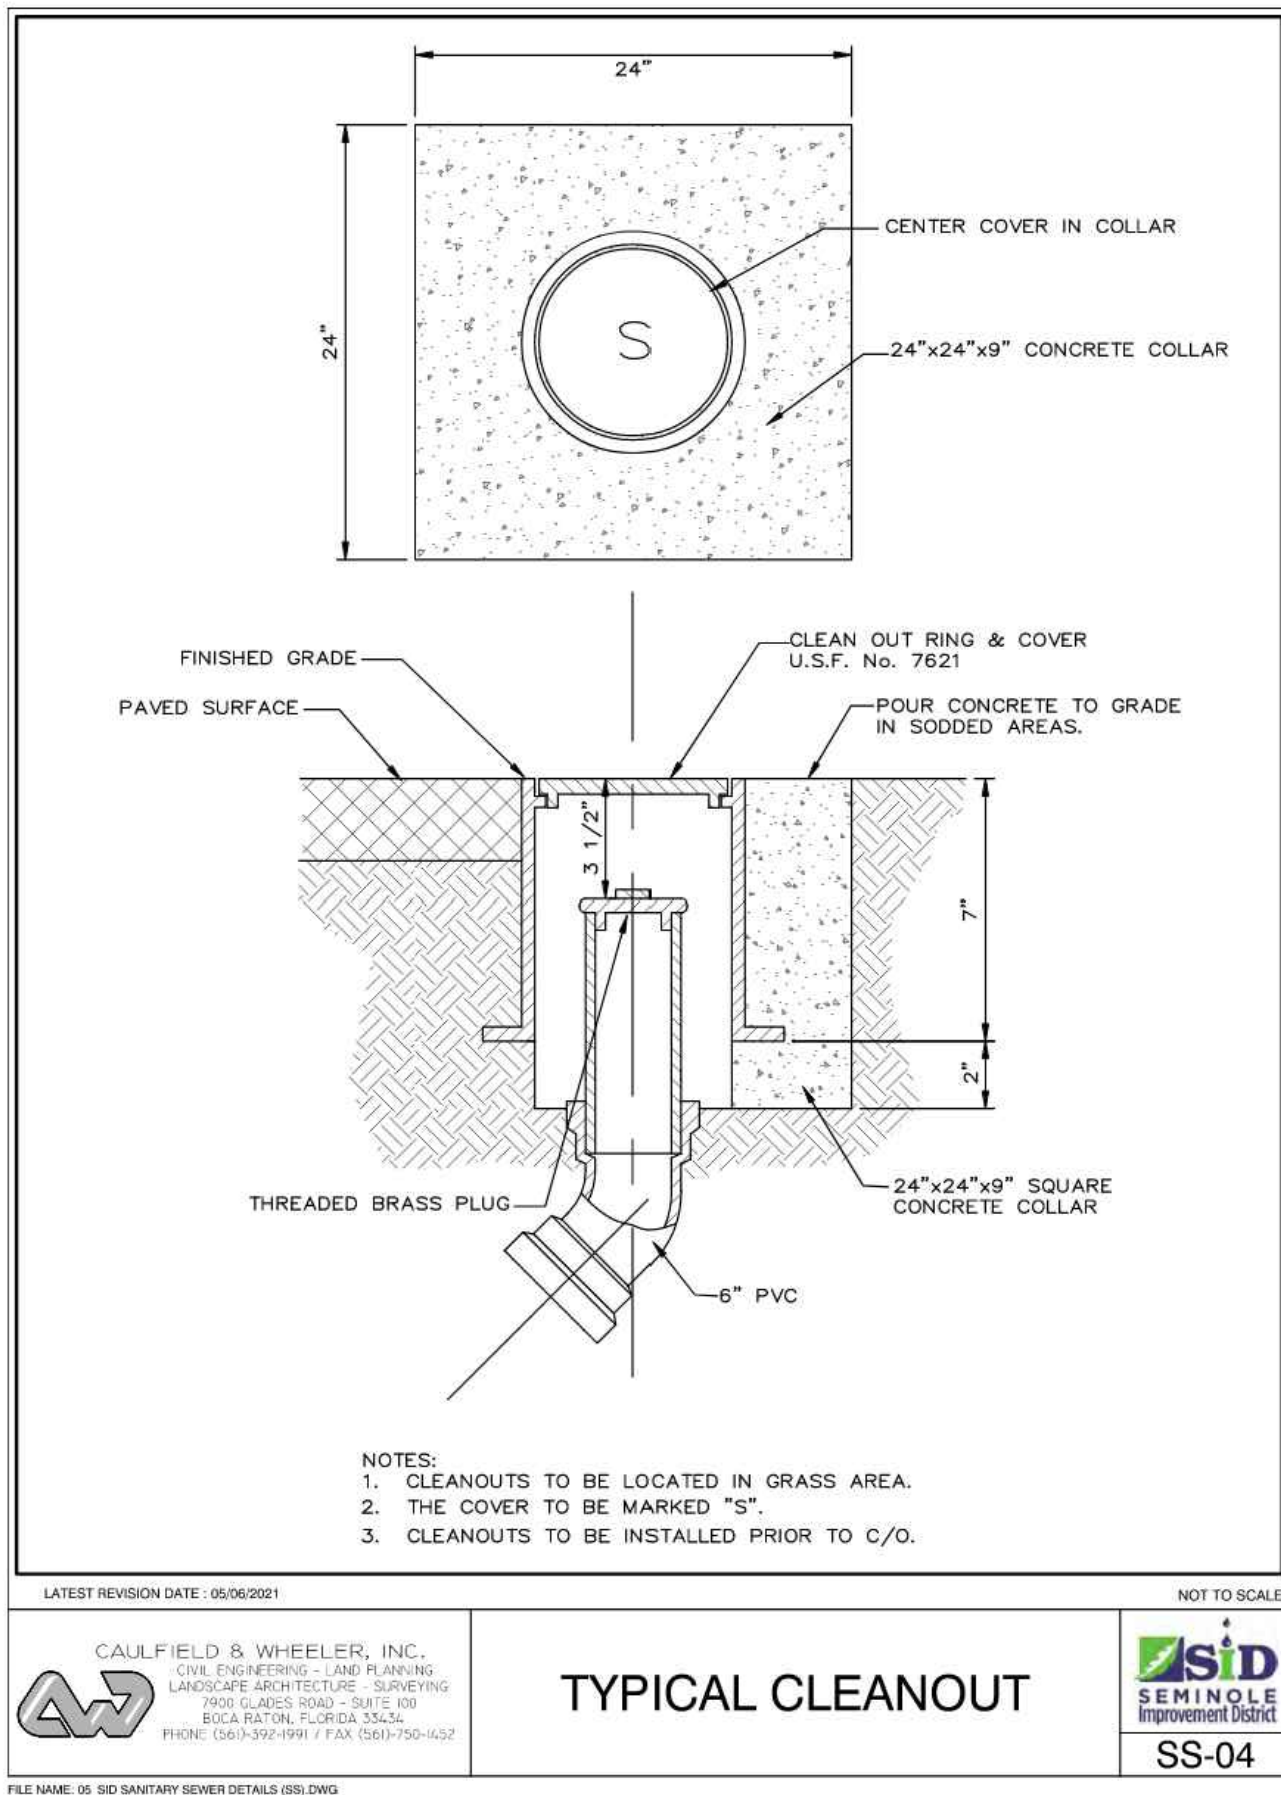


LATEST REVISION DATE: 05/06/2021

CAULFIELD & WHEELER, INC.
CIVIL ENGINEERING - LAND PLANNING
LANDSCAPE ARCHITECTURE - SURVEYING
7900 GUEST ROAD - SUITE 100
BOCA RATON, FLORIDA 33433
PHONE: (561) 392-1991 / FAX: (561) 750-1432

TYPICAL CLEANOUT

SS-04

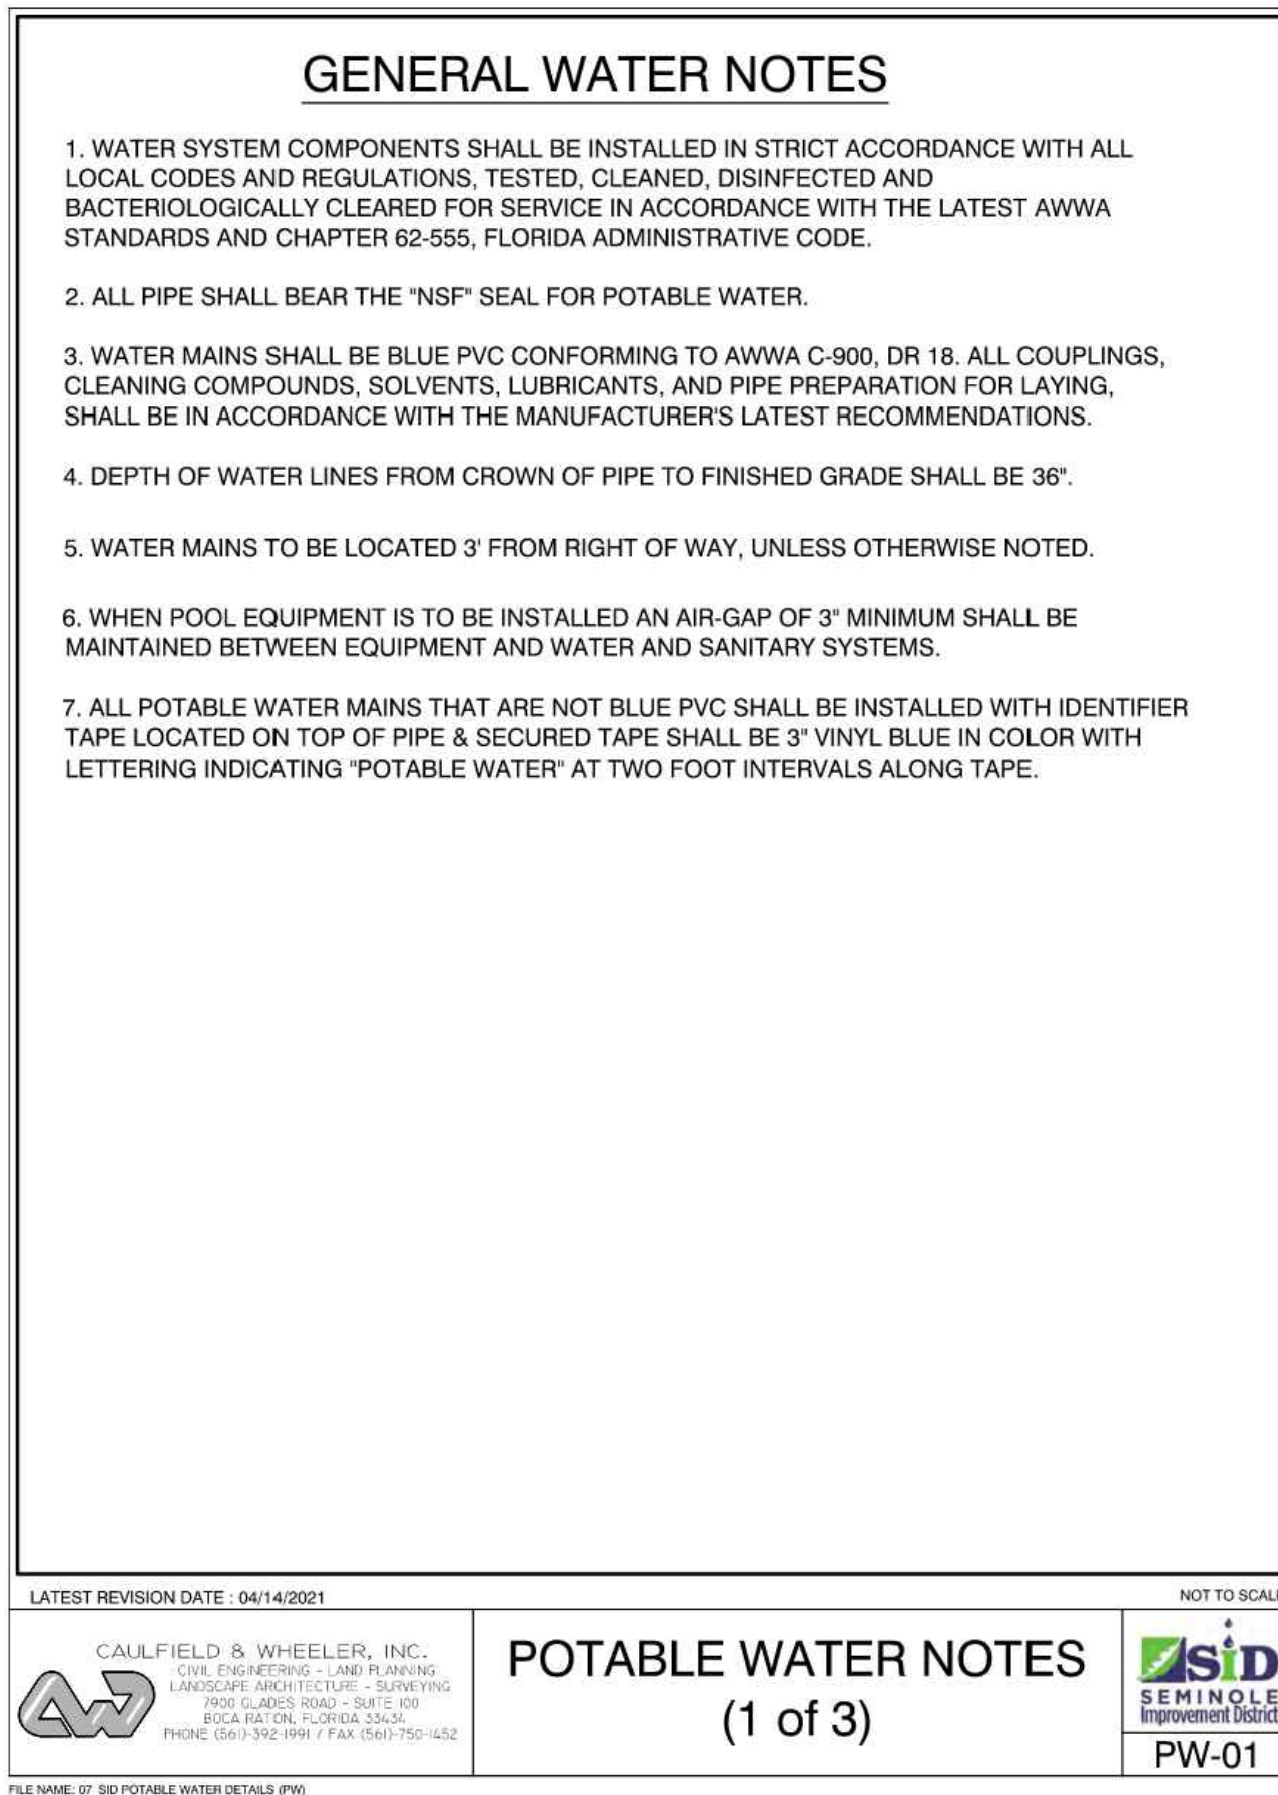


LATEST REVISION DATE: 04/14/2021

CAULFIELD & WHEELER, INC.
CIVIL ENGINEERING - LAND PLANNING
LANDSCAPE ARCHITECTURE - SURVEYING
7900 GUEST ROAD - SUITE 100
BOCA RATON, FLORIDA 33433
PHONE: (561) 392-1991 / FAX: (561) 750-1432

POTABLE WATER NOTES
(1 of 3)

PW-01

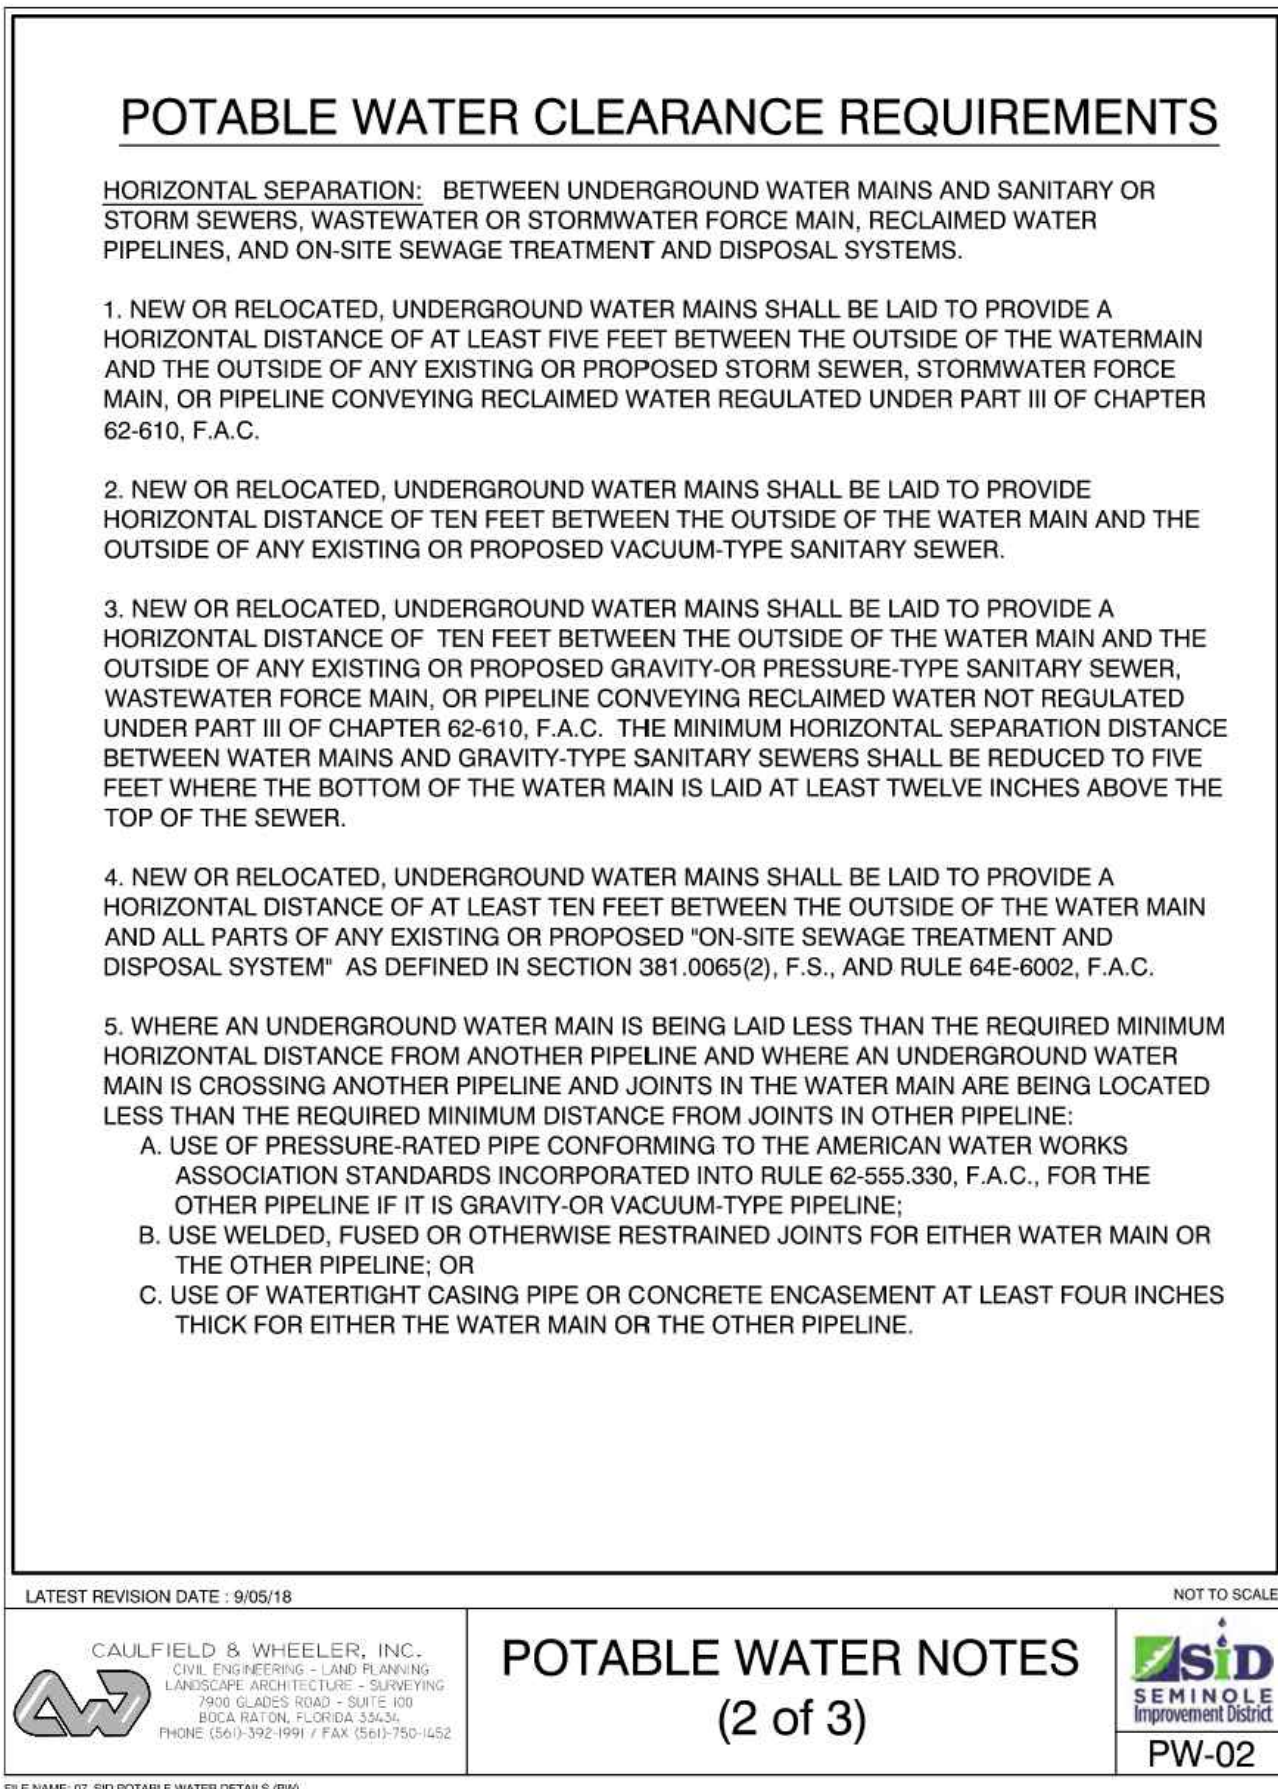


LATEST REVISION DATE: 9/05/18

CAULFIELD & WHEELER, INC.
CIVIL ENGINEERING - LAND PLANNING
LANDSCAPE ARCHITECTURE - SURVEYING
7900 GUEST ROAD - SUITE 100
BOCA RATON, FLORIDA 33433
PHONE: (561) 392-1991 / FAX: (561) 750-1432

POTABLE WATER NOTES
(2 of 3)

PW-02

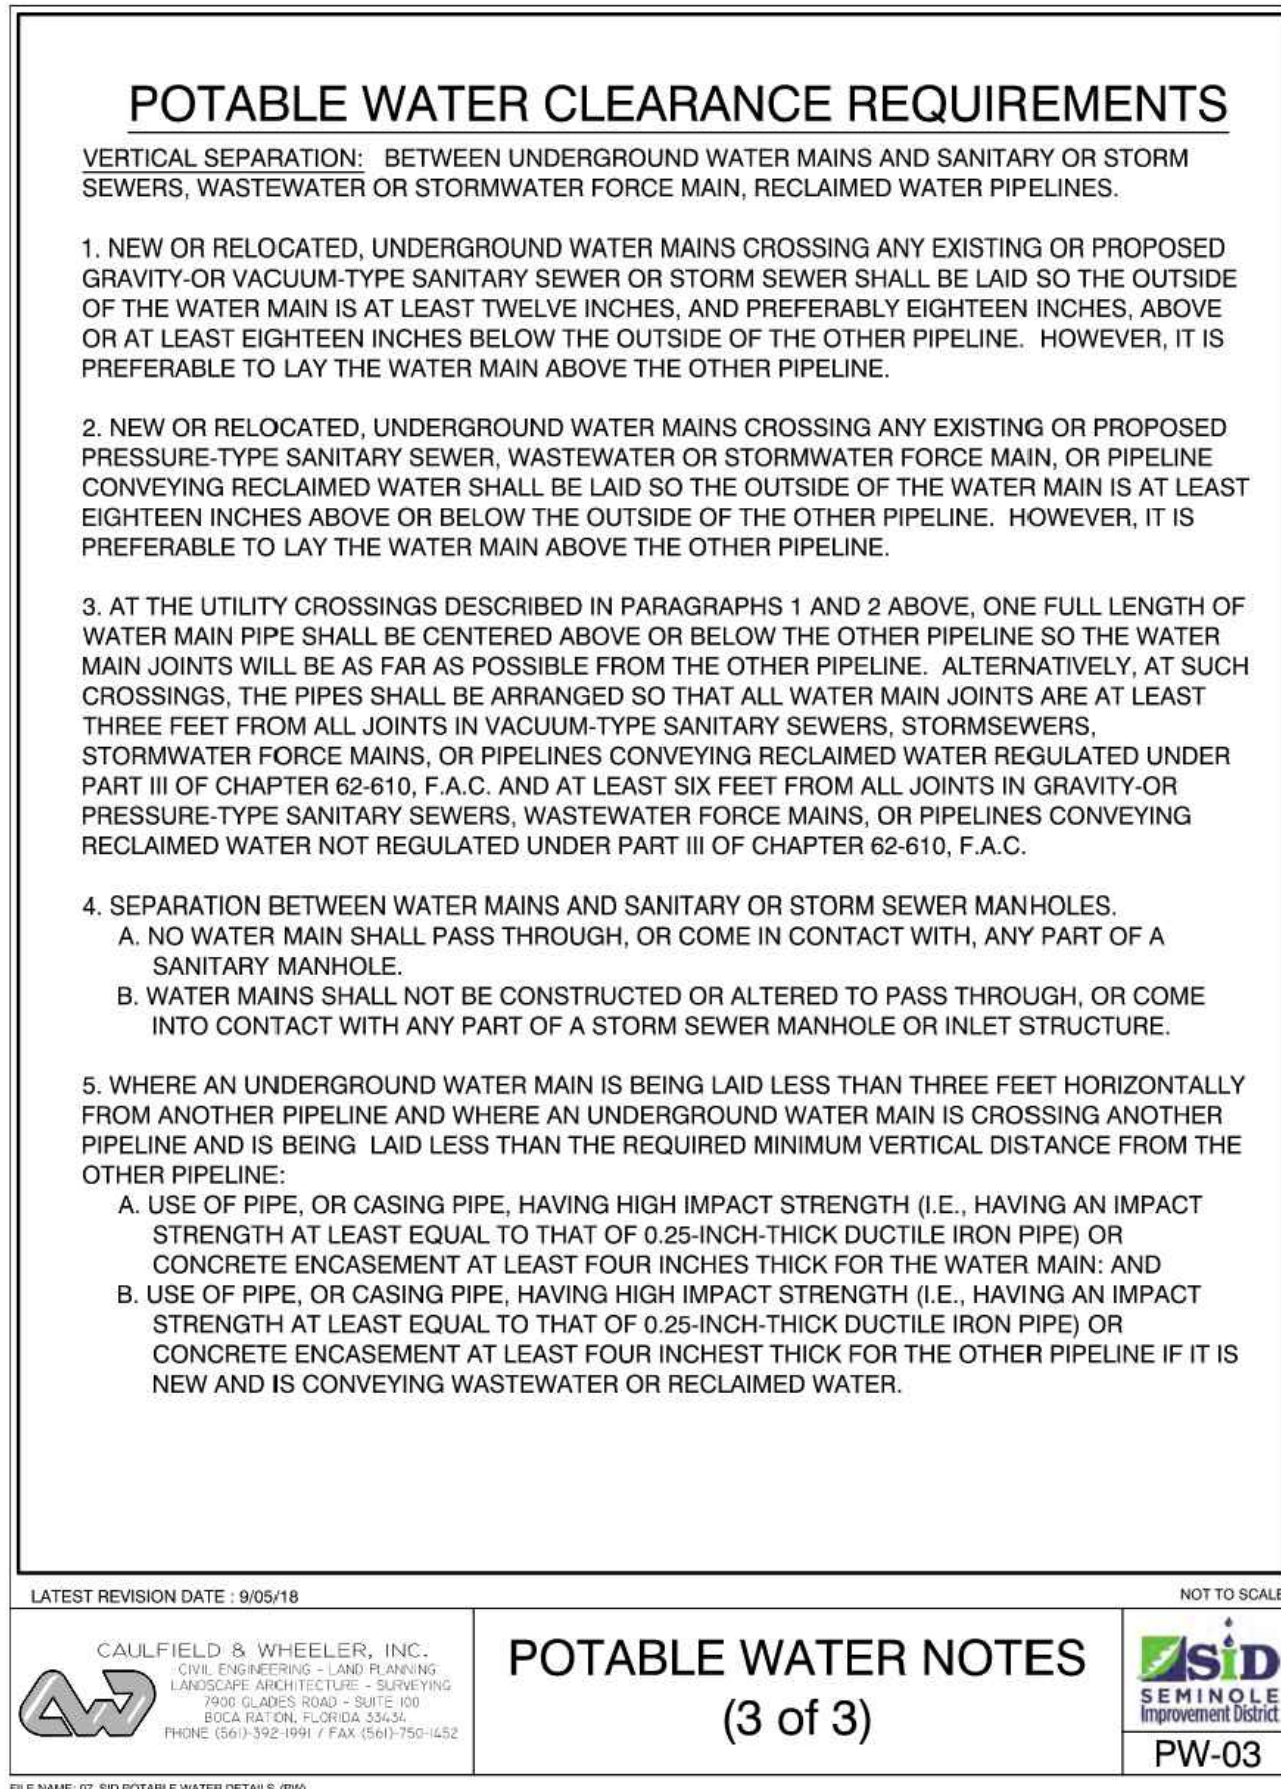


LATEST REVISION DATE: 9/05/18

CAULFIELD & WHEELER, INC.
CIVIL ENGINEERING - LAND PLANNING
LANDSCAPE ARCHITECTURE - SURVEYING
7900 GUEST ROAD - SUITE 100
BOCA RATON, FLORIDA 33433
PHONE: (561) 392-1991 / FAX: (561) 750-1432

POTABLE WATER NOTES
(3 of 3)

PW-03

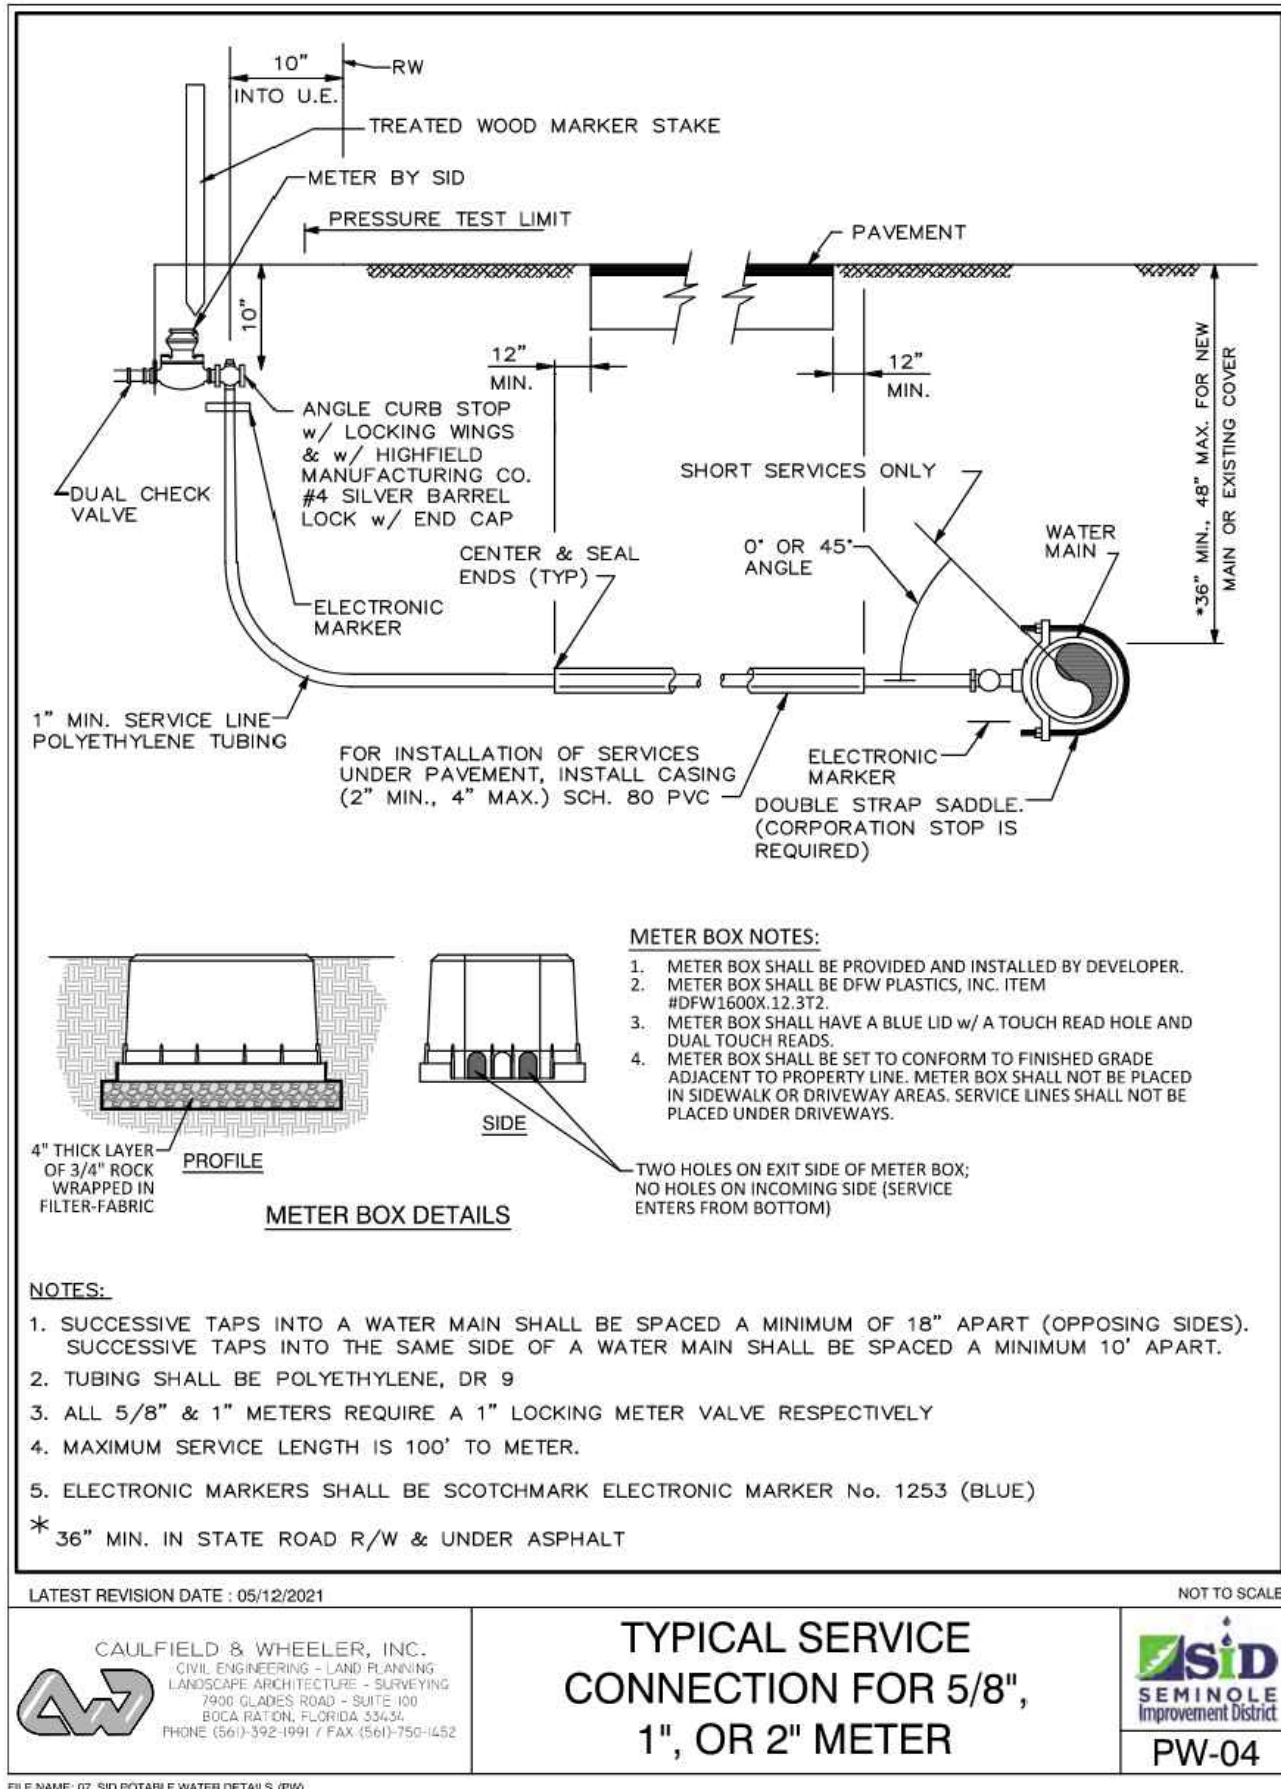


LATEST REVISION DATE: 05/12/2021

CAULFIELD & WHEELER, INC.
CIVIL ENGINEERING - LAND PLANNING
LANDSCAPE ARCHITECTURE - SURVEYING
7900 GUEST ROAD - SUITE 100
BOCA RATON, FLORIDA 33433
PHONE: (561) 392-1991 / FAX: (561) 750-1432

TYPICAL SERVICE
CONNECTION FOR 5/8",
1", OR 2" METER

PW-04

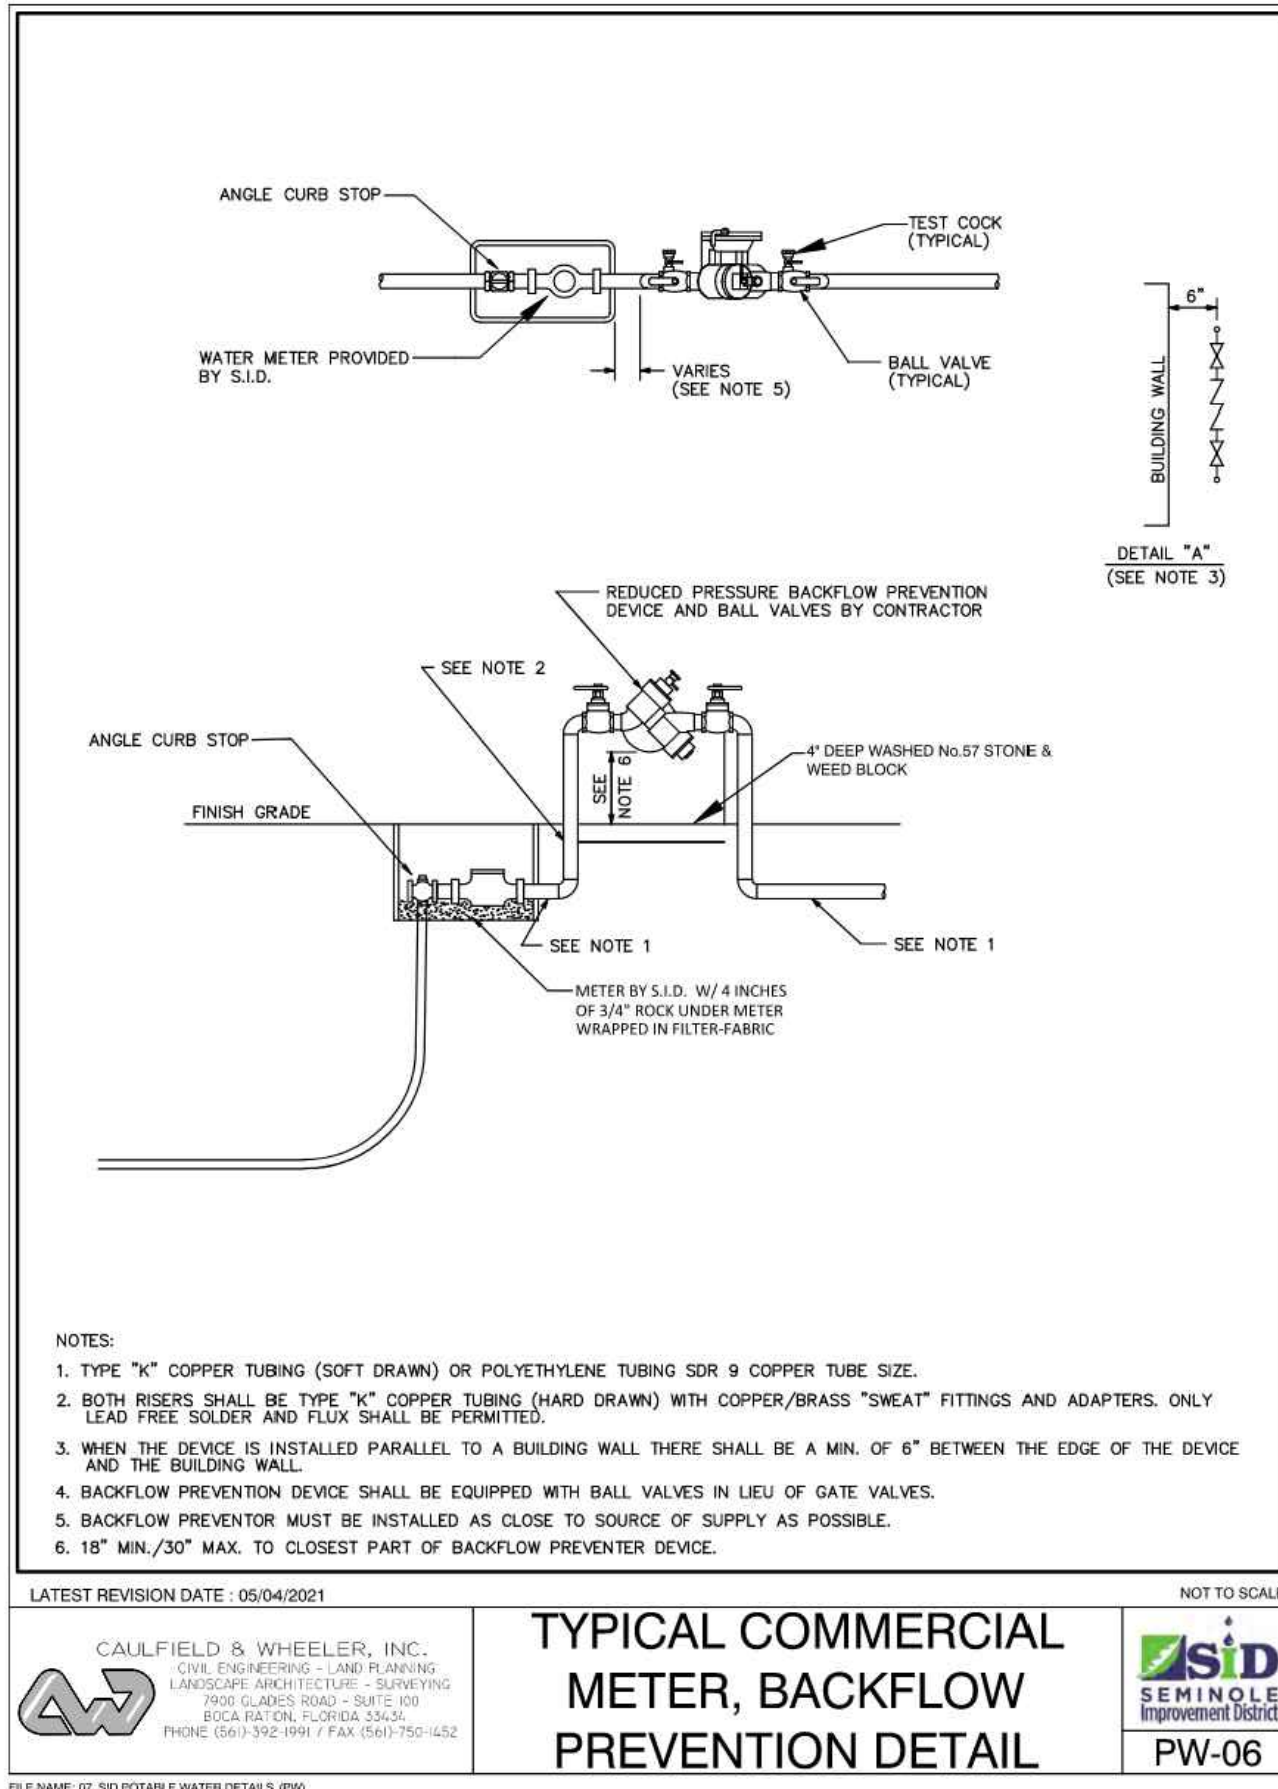

LATEST REVISION DATE: 05/04/2021

CAULFIELD & WHEELER, INC.
CIVIL ENGINEERING - LAND PLANNING
LANDSCAPE ARCHITECTURE - SURVEYING
7900 GUEST ROAD - SUITE 100
BOCA RATON, FLORIDA 33433
PHONE: (561) 392-1991 / FAX: (561) 750-1432

TYPICAL COMMERCIAL
METER, BACKFLOW
PREVENTION DETAIL

PW-06

BOHLER

SITE CIVIL AND CONSULTING ENGINEERING
PROGRAM MANAGEMENT
LANDSCAPE ARCHITECTURE
SUSTAINABLE DESIGN
PERMITTING SERVICES
TRANSPORTATION SERVICES

REVISIONS				
REV	DATE	COMMENT	DESIGNED BY	CHECKED BY
1	7/14/2025	1ST ROUND OF COMMENTS	AH	KD
2	8/11/2025	2ND ROUND OF COMMENTS	AH	KD
3	08/14/2025	QA/QC COMMENTS	AH	KD
4	10/23/2025	3RD ROUND OF COMMENTS	KD	KD

811 KNOW WHAT'S BELOW
ALWAYS CALL 811
BEFORE YOU DIG

www.call811shrine.com

ISSUED FOR MUNICIPAL & AGENCY REVIEW & APPROVAL

THIS DRAWING IS INTENDED FOR MUNICIPAL AND/OR AGENCY REVIEW AND APPROVAL. IT IS NOT INTENDED AS A CONSTRUCTION DOCUMENT UNLESS INDICATED OTHERWISE.

PROJECT No.: FLA230191.00-0A
DRAWN BY: -AH/MV-
CHECKED BY: -KD/KM-
DATE: 10/23/2025
CAD LID: P-CIVL-00DS

PROJECT:

SITE CONSTRUCTION PLANS

FOR

MAVIS TIRES & BRAKES
DISCOUNT PRICES

MAVIS TIRES & BRAKES - CITY OF WESTLAKE

16775 PERSIMMON BLVD
WESTLAKE, FL 33470
CITY OF WESTLAKE
S 01, T 43S, R 40E

BOHLER

600 N. WESTSHORE BLVD. SUITE 950
TAMPA, FLORIDA 33609
Phone: (813) 812-4100
Fax: (813) 812-4101


FLORIDA BUSINESS CERT. OF AUTH. NO. 30780

This item has been digitally signed and sealed by Kayla M. Dedrick PE on the date adjacent to the seal. Signature must be verified on any electronic copies.

SHEET TITLE:
SEMINOLE IMPROVEMENT DISTRICT DETAILS

SHEET NUMBER:
C-903

REVISION 4 - 10/23/2025

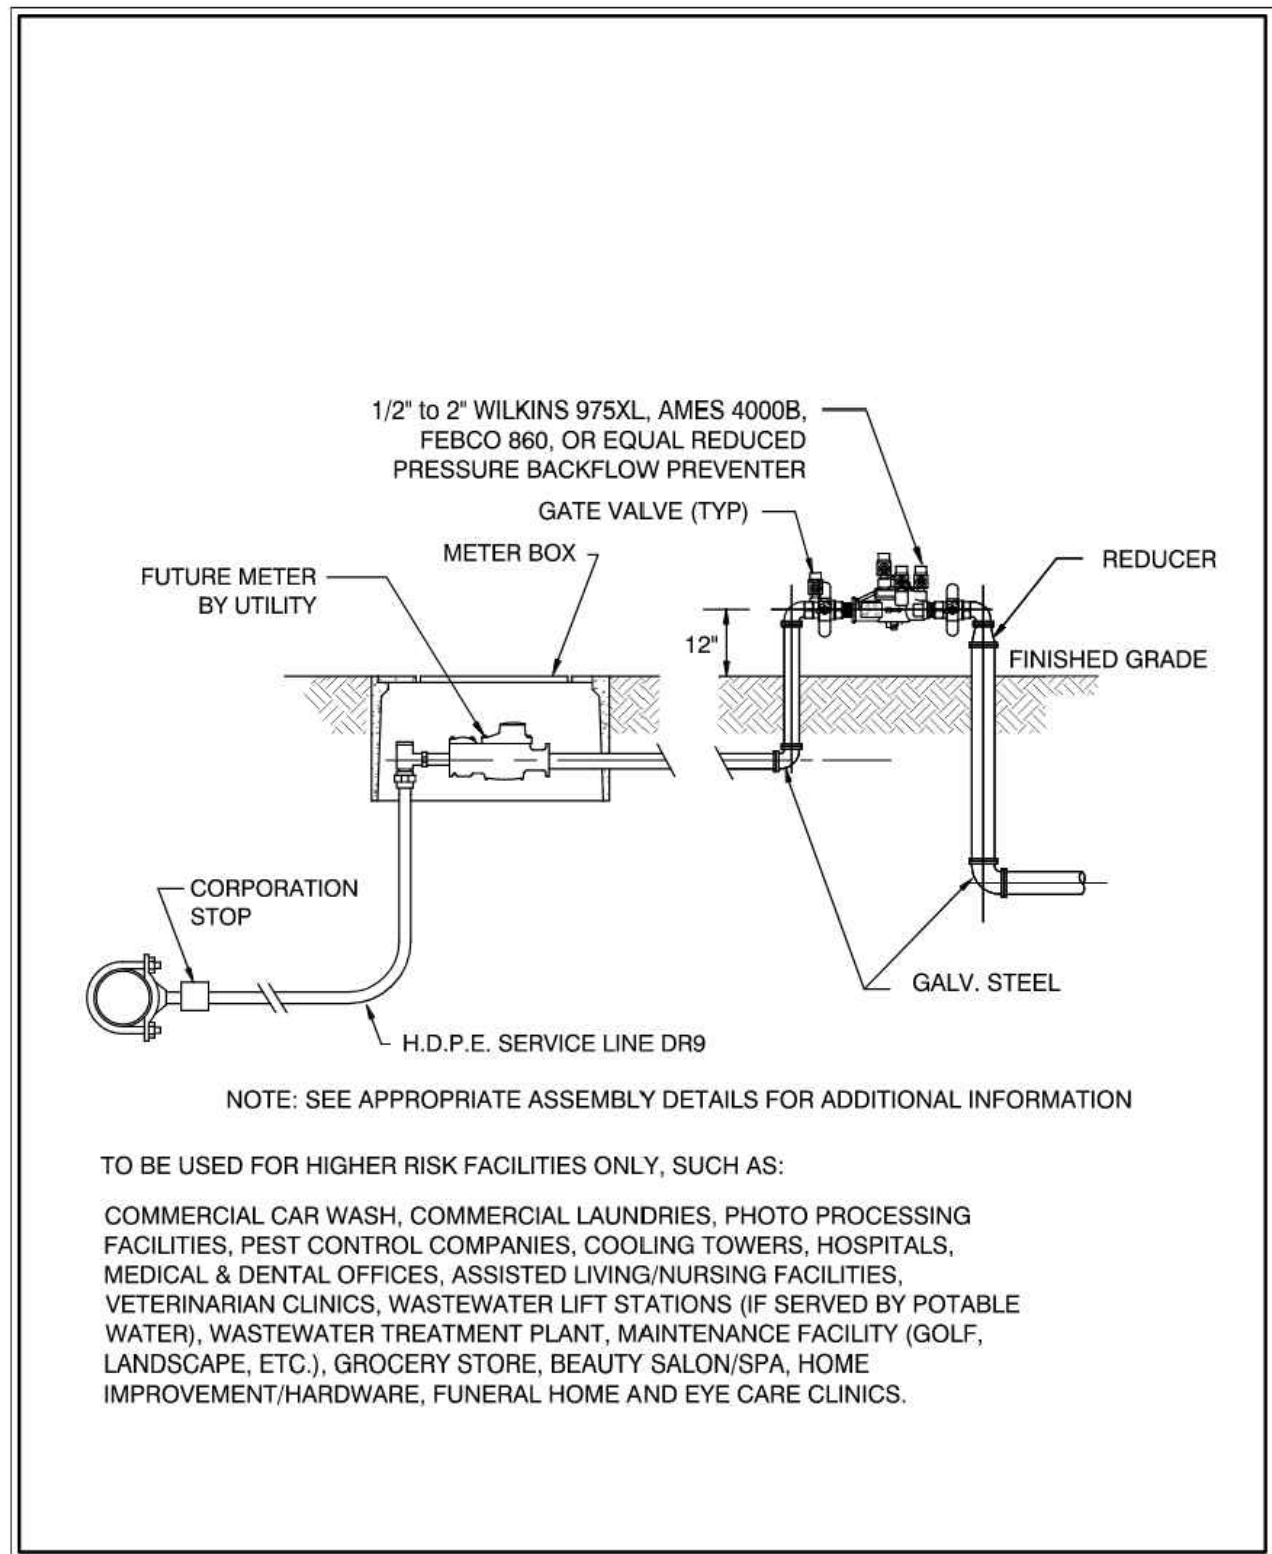

LATEST REVISION DATE: 09/05/18


CAULFIELD & WHEELER, INC.
CIVIL ENGINEERING - LAND PLANNING
LANDSCAPE ARCHITECTURE - SURVEYING
7800 GLADES ROAD - SUITE 100
P.O. BOX 1000, FORT LAUDERDALE, FL 33304
PHONE: (561) 392-1991 / FAX: (561) 750-1432

BACKFLOW PREVENTER ASSEMBLY DETAIL

FILE NAME: 01_360 POTABLE WATER DETAILS (PWS)

NOT TO SCALE

SEMIOLE IMPROVEMENT DISTRICT
PW-07

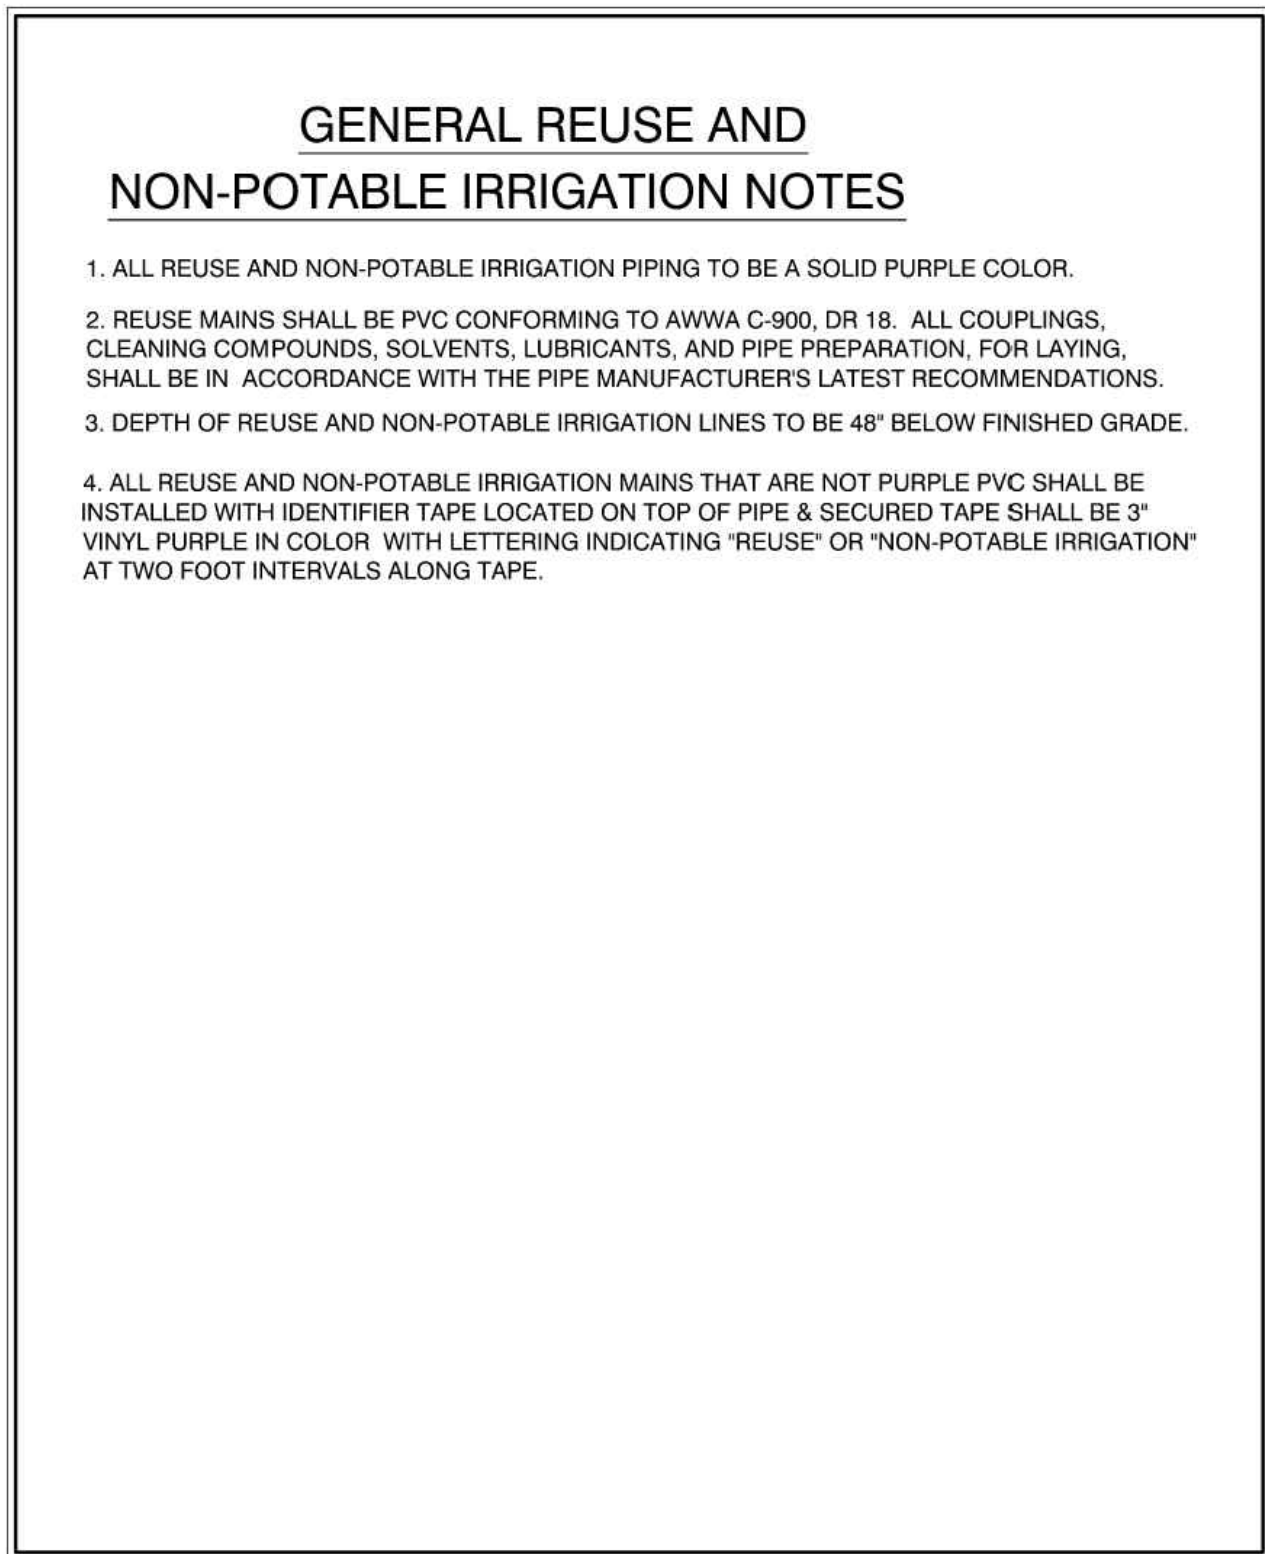

LATEST REVISION DATE: 09/05/18


CAULFIELD & WHEELER, INC.
CIVIL ENGINEERING - LAND PLANNING
LANDSCAPE ARCHITECTURE - SURVEYING
7800 GLADES ROAD - SUITE 100
P.O. BOX 1000, FORT LAUDERDALE, FL 33304
PHONE: (561) 392-1991 / FAX: (561) 750-1432

RECLAIMED WATER NOTES

FILE NAME: 01_360 RECLAIMED WATER DETAILS (RWS)

NOT TO SCALE

SEMIOLE IMPROVEMENT DISTRICT
RW-01

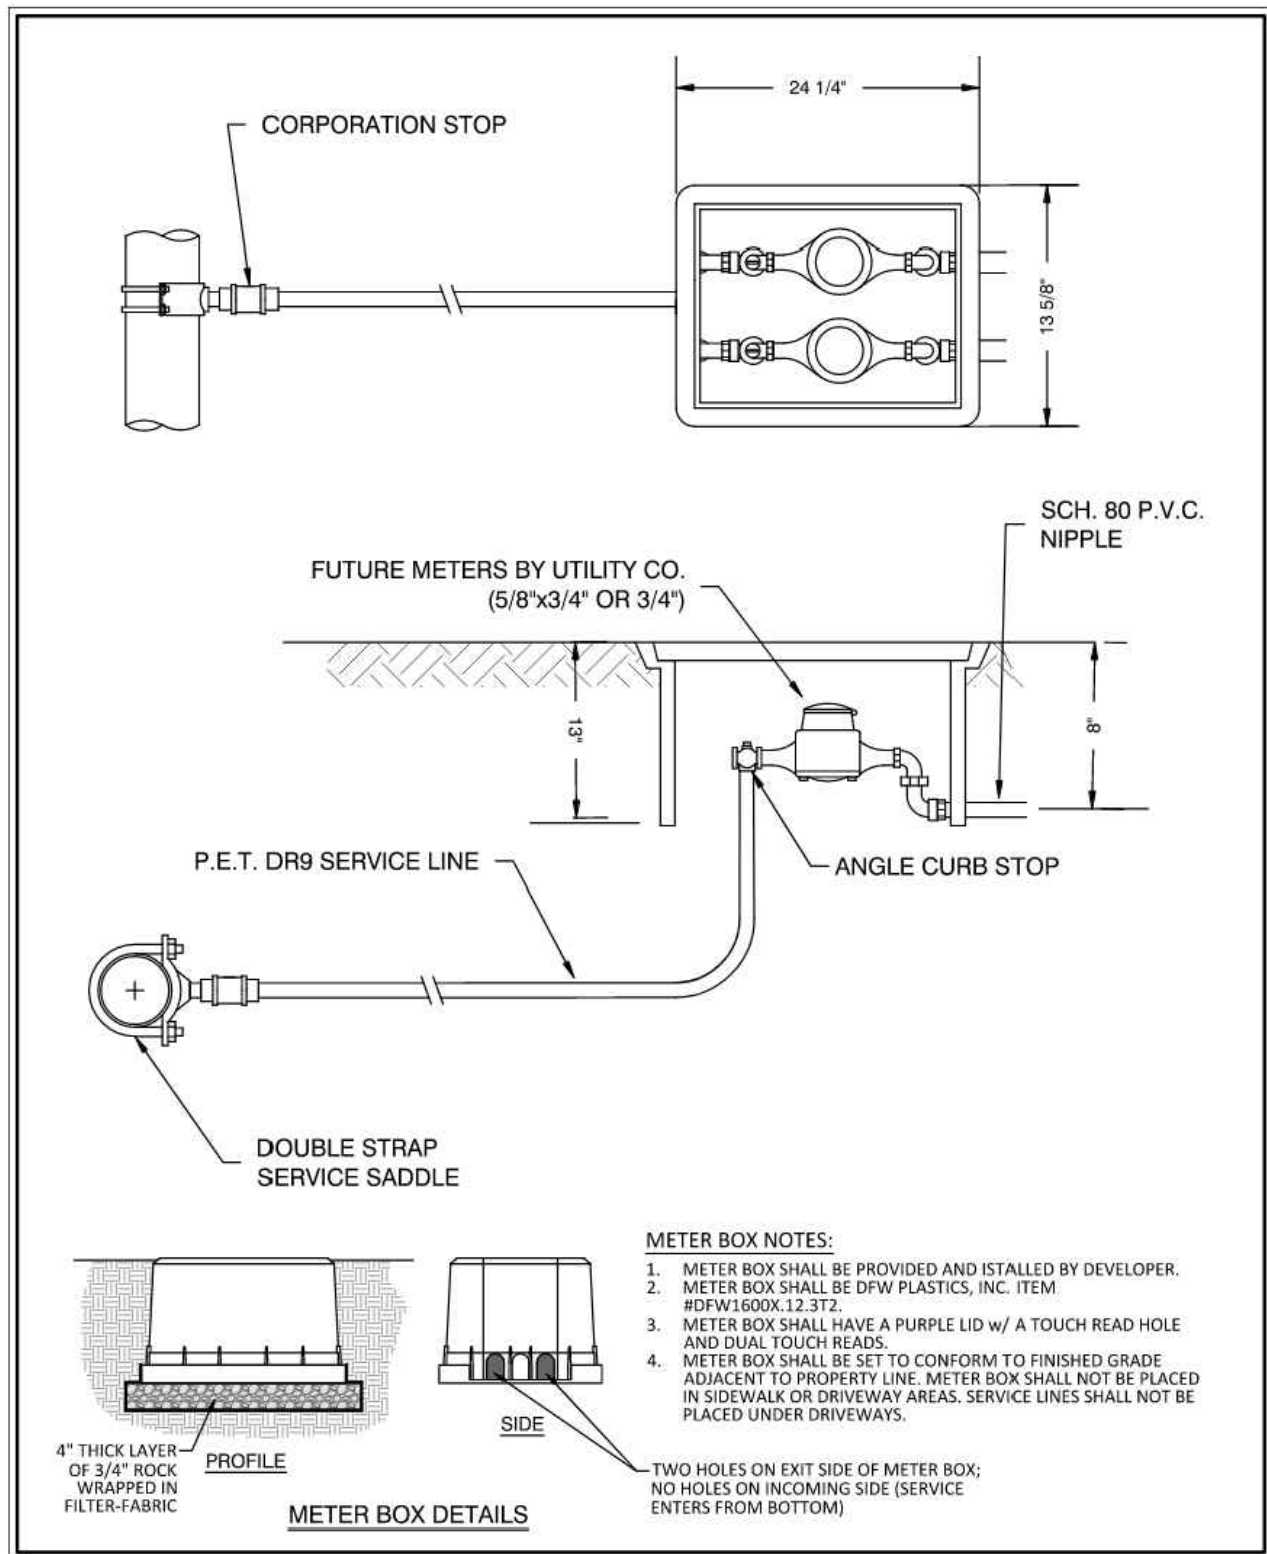

LATEST REVISION DATE: 05/04/2021


CAULFIELD & WHEELER, INC.
CIVIL ENGINEERING - LAND PLANNING
LANDSCAPE ARCHITECTURE - SURVEYING
7800 GLADES ROAD - SUITE 100
P.O. BOX 1000, FORT LAUDERDALE, FL 33304
PHONE: (561) 392-1991 / FAX: (561) 750-1432

RECLAIMED WATER METER ASSEMBLY DETAIL

FILE NAME: 01_360 RECLAIMED WATER DETAILS (RWS)

NOT TO SCALE

SEMIOLE IMPROVEMENT DISTRICT
RW-02

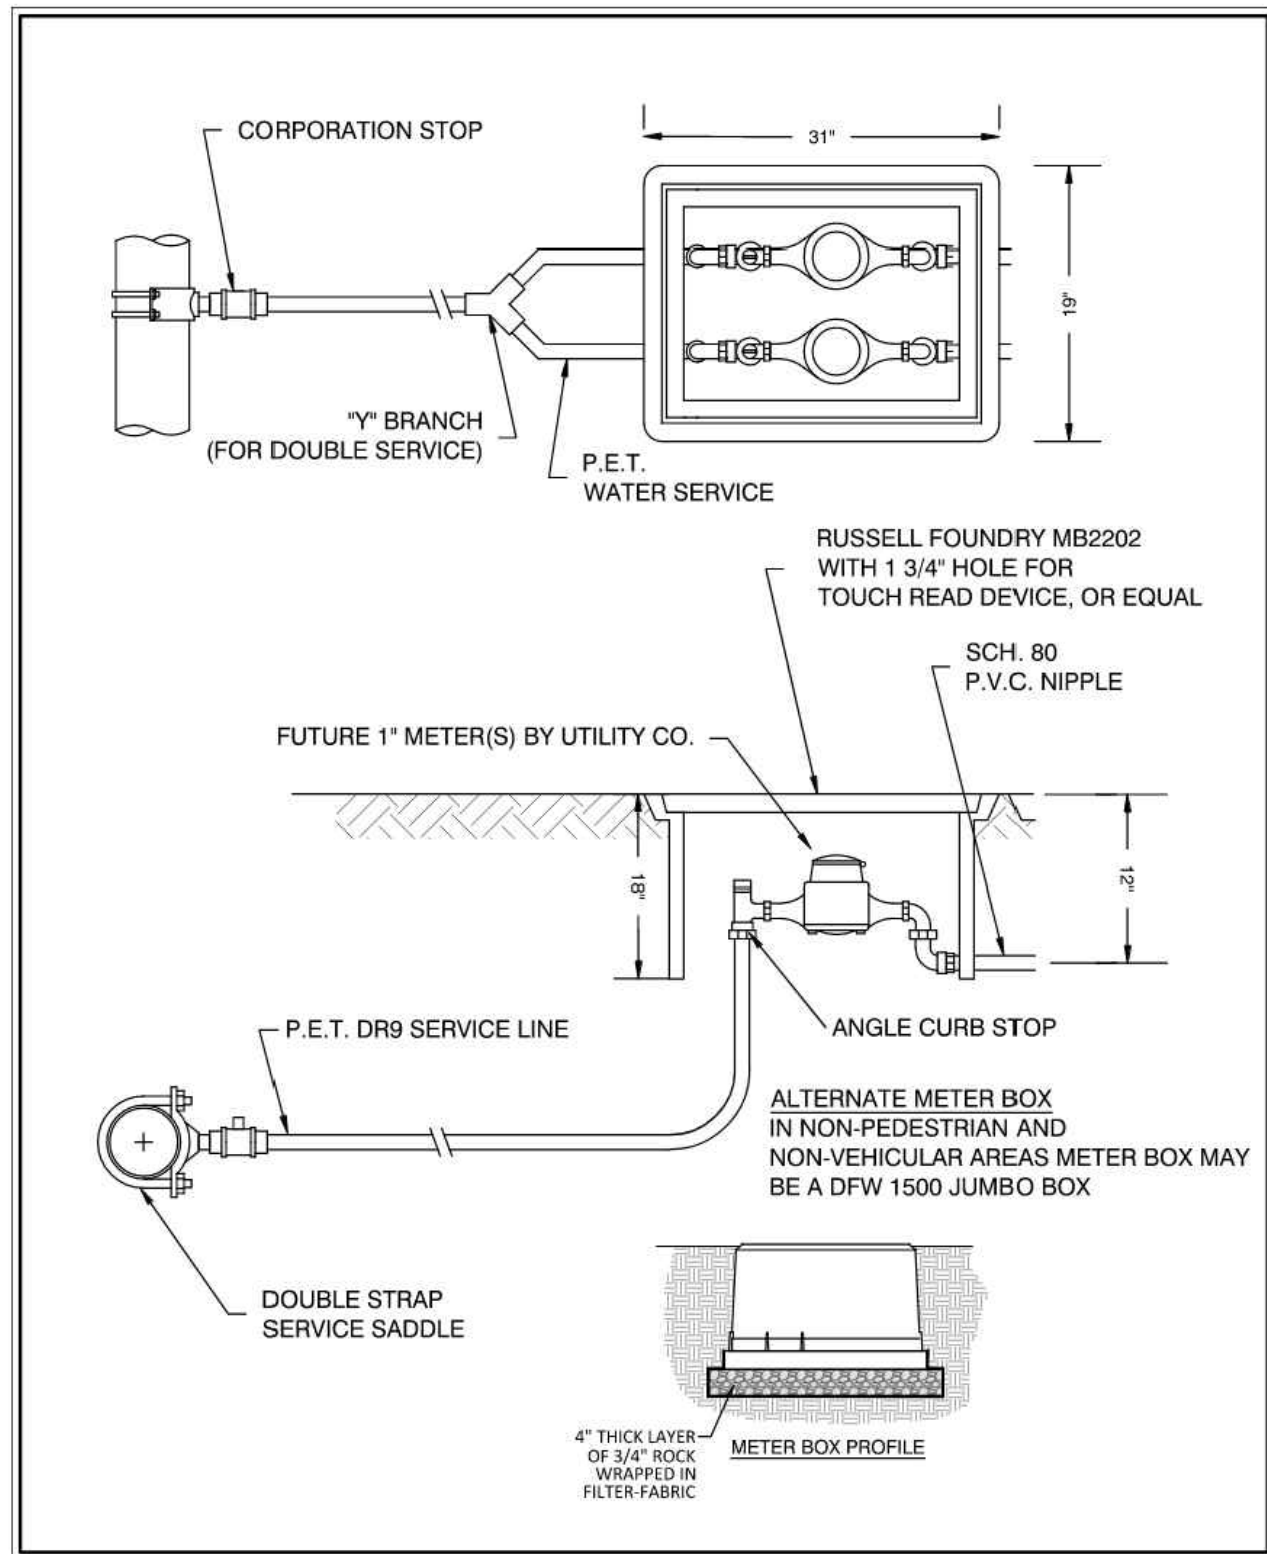

LATEST REVISION DATE: 05/04/2021



CAULFIELD & WHEELER, INC.
CIVIL ENGINEERING - LAND PLANNING
LANDSCAPE ARCHITECTURE - SURVEYING
7800 GLADES ROAD - SUITE 100
P.O. BOX 1000, FORT LAUDERDALE, FL 33304
PHONE: (561) 392-1991 / FAX: (561) 750-1432

1 IN. RECLAIMED WATER METER ASSEMBLY DETAIL

FILE NAME: 01_360 RECLAIMED WATER DETAILS (RWS)

NOT TO SCALE

SEMIOLE IMPROVEMENT DISTRICT
RW-03

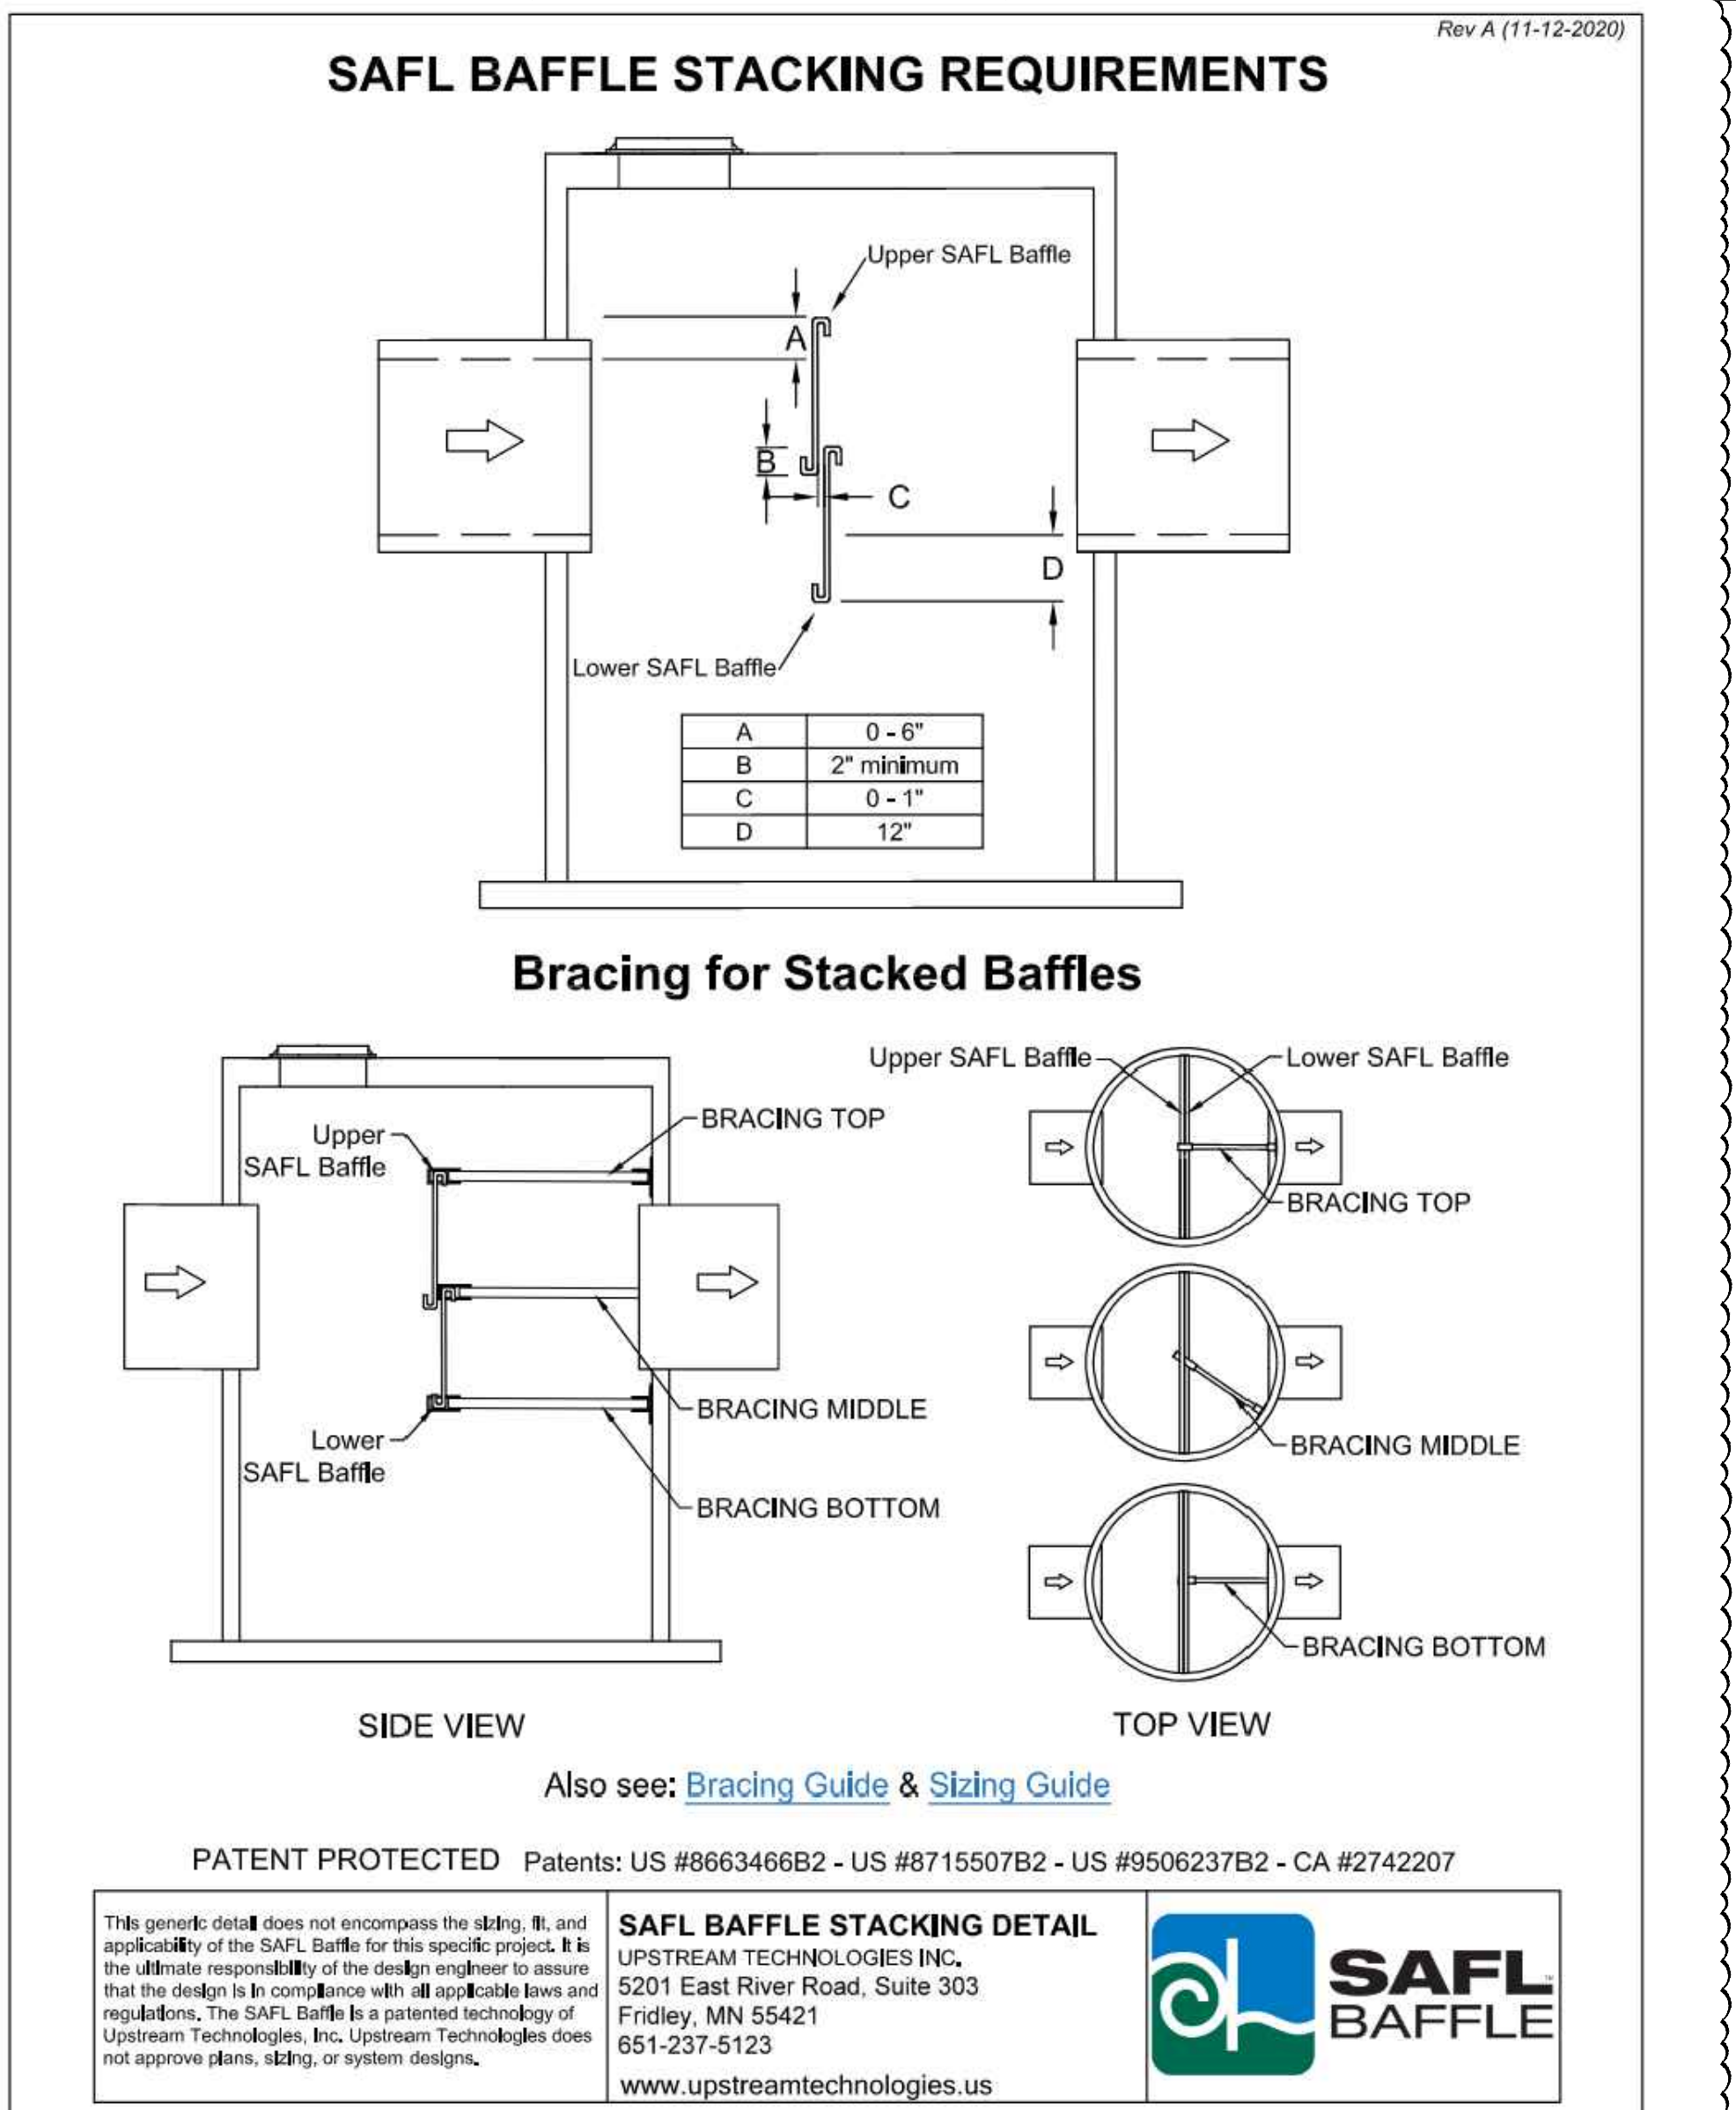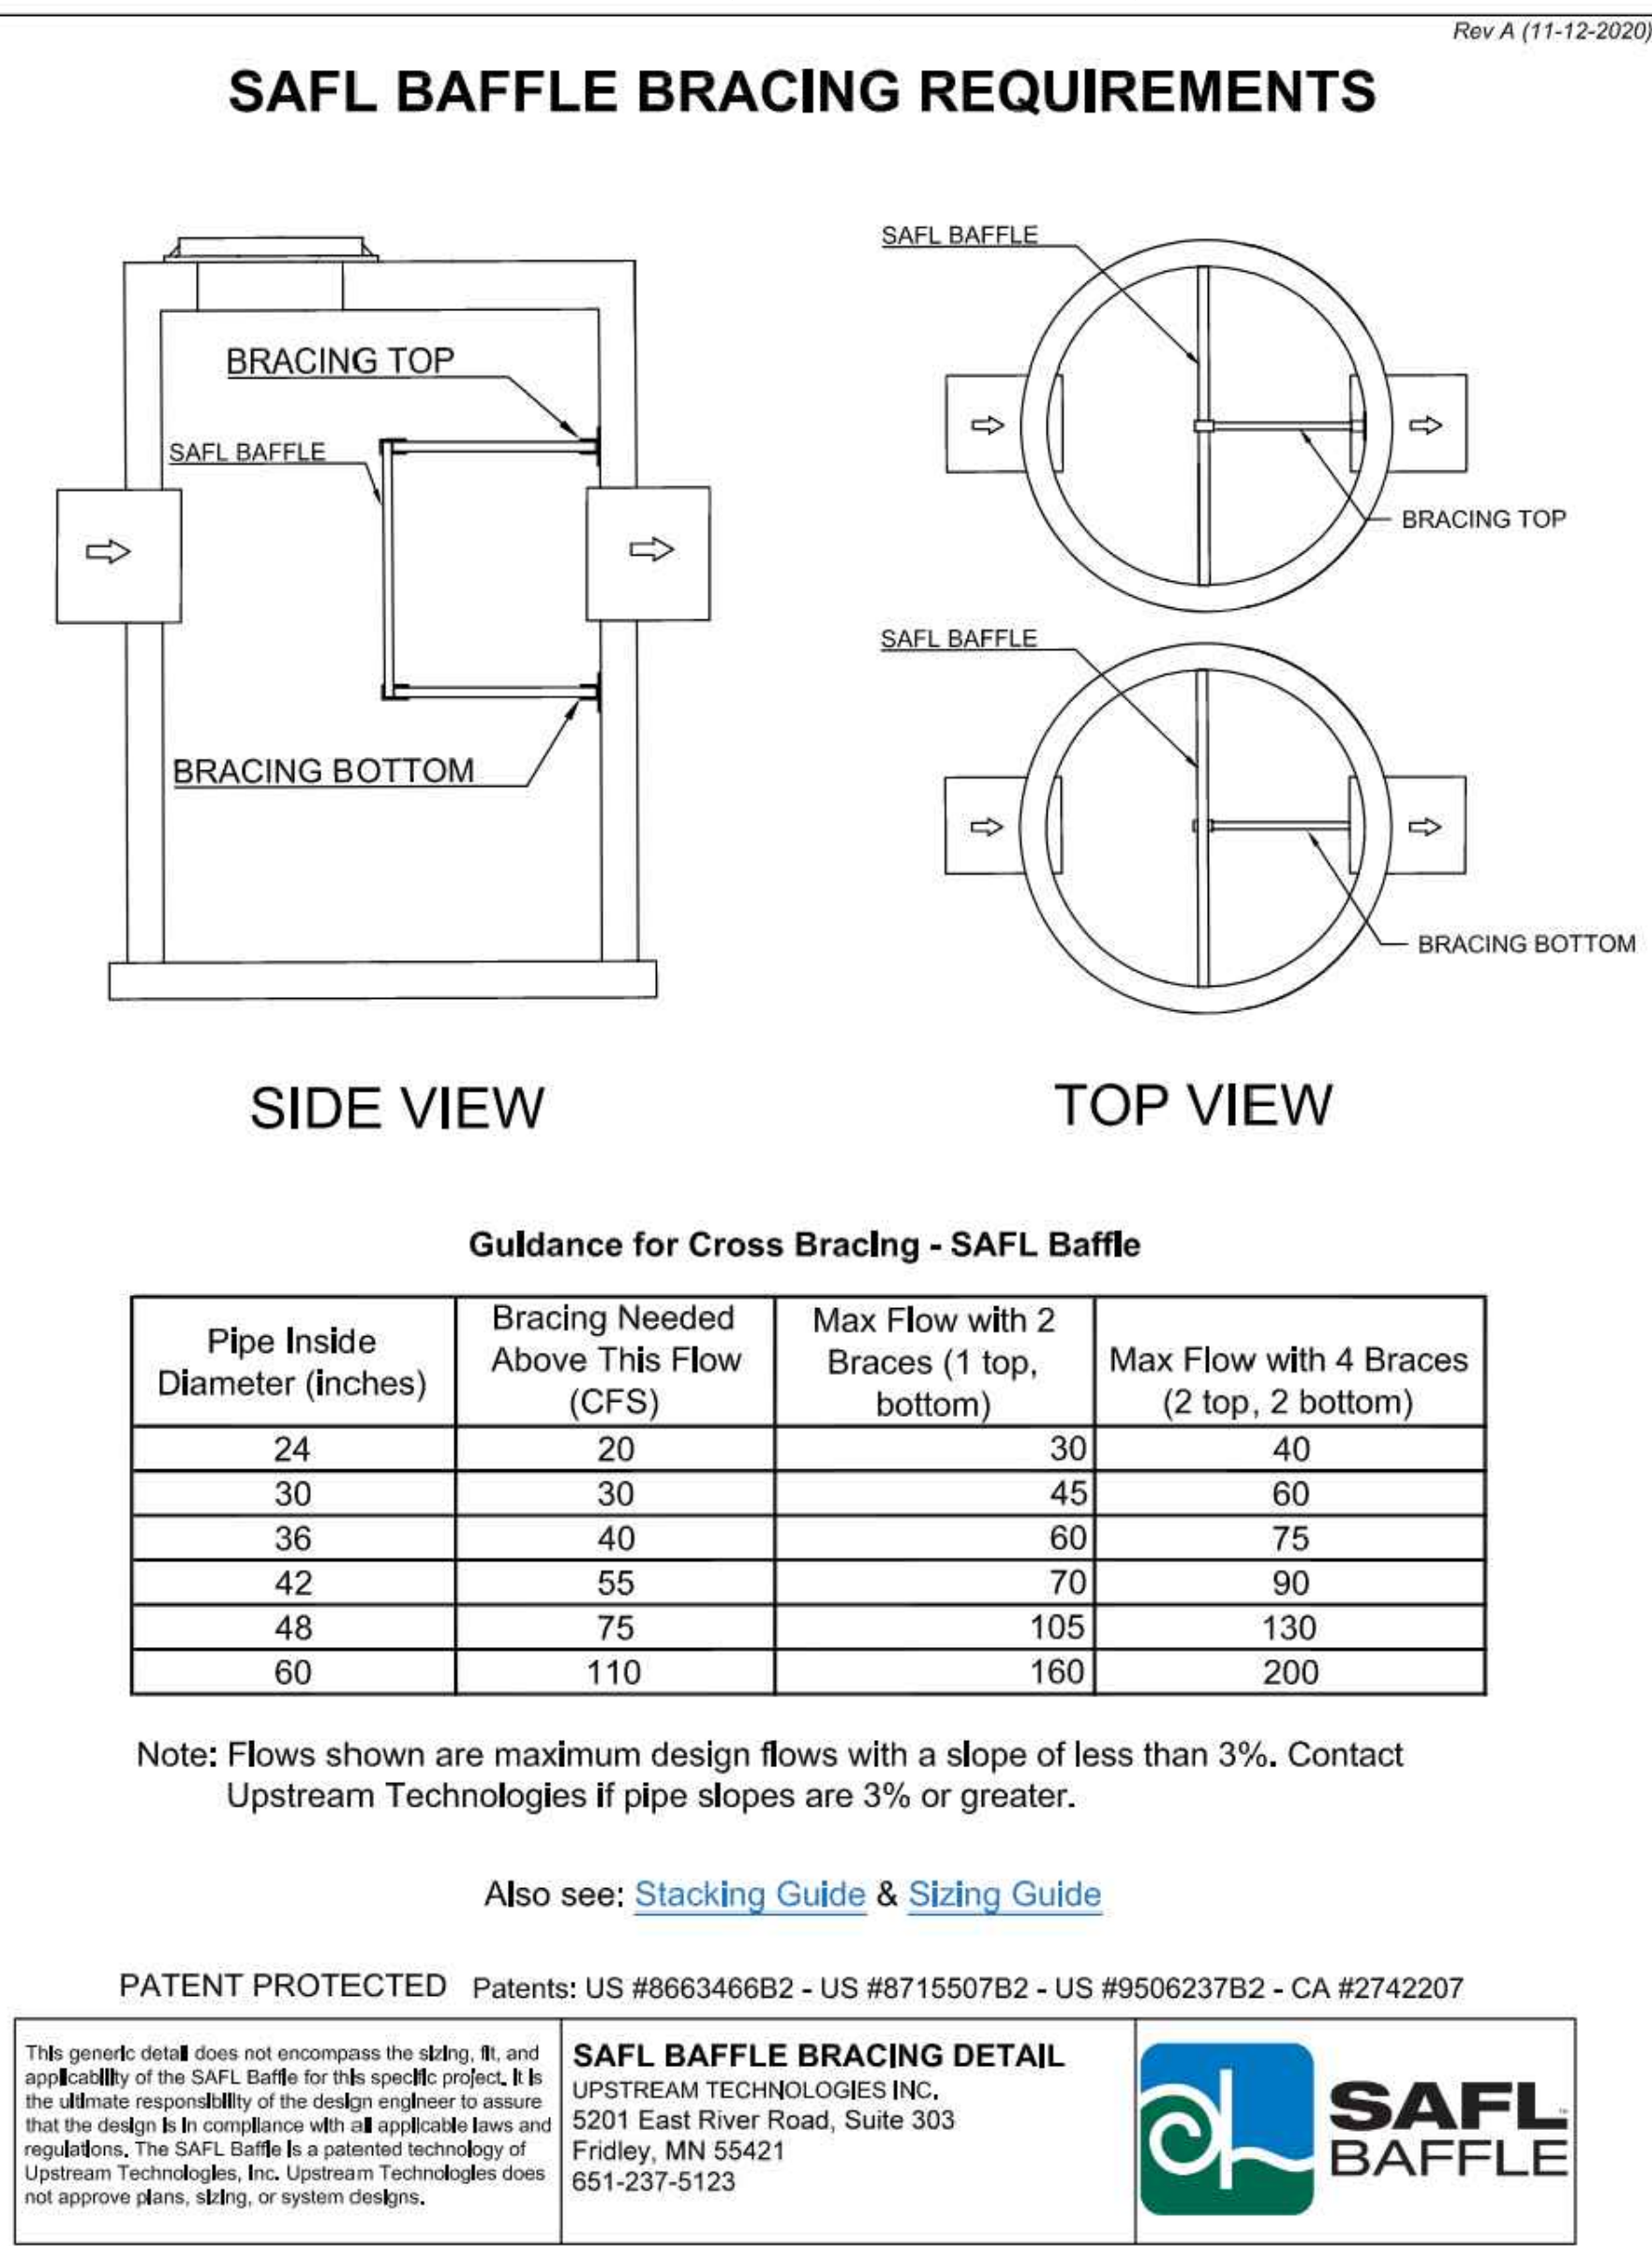

BOHLER
SITE CIVIL AND CONSULTING ENGINEERING
PROGRAM MANAGEMENT
LANDSCAPE ARCHITECTURE
SUSTAINABLE DESIGN
PERMITTING SERVICES
TRANSPORTATION SERVICES

REVISIONS				
REV	DATE	COMMENT	DRAWN BY	
1	7/14/2025	1ST ROUND OF COMMENTS	AH	KD
2	8/11/2025	2ND ROUND OF COMMENTS	AH	KD
3	08/14/2025	QA/QC COMMENTS	AH	KD
4	10/23/2025	3RD ROUND OF COMMENTS	KD	KD

811 KNOW WHAT'S BELOW
ALWAYS CALL 811 BEFORE YOU DIG
It's Not. It's Free. It's the Law.
www.call811shrine.com

ISSUED FOR MUNICIPAL & AGENCY REVIEW & APPROVAL

THIS DRAWING IS INTENDED FOR MUNICIPAL AND/OR AGENCY REVIEW AND APPROVAL. IT IS NOT INTENDED AS A CONSTRUCTION DOCUMENT UNLESS INDICATED OTHERWISE.

PROJECT No.: FLA230191.00-0A
DRAWN BY: ~AHMV~
CHECKED BY: ~KDKM~
DATE: 10/23/2025
CAD ID: P-CIVL-00DS

PROJECT:

SITE CONSTRUCTION PLANS
FOR
MAVIS TIRES & BRAKES - CITY OF WESTLAKE
16775 PERSIMMON BLVD
WESTLAKE, FL 33470
CITY OF WESTLAKE
S 01, T 43S, R 40E

BOHLER
600 N. WESTSHORE BLVD. SUITE 950
TAMPA, FLORIDA 33609
Phone: (813) 812-4100
Fax: (813) 812-4101
FLORIDA BUSINESS CERT. OF AUTH. No. 30780

This item has been digitally signed and sealed by Kayla M. Detrick PE on the date adjacent to the seal. Signature must be verified on any electronic copies.

SHEET TITLE:
SEMIOLE IMPROVEMENT DISTRICT DETAILS
SHEET NUMBER:
C-904
REVISION 4 - 10/23/2025

01-23, 2025
H:\2025\FLA230191\00ENGINEERING\CAD\DRAWINGS\PLAN SETS\CIVIL SITE PLAN\REV. 0-AP-CIVIL-LIGHT-FLA230191-00-0A-1-201 LIGHT

10

10

TOWN CENTER PARKWAY SOUTH

VARIABLE WIDTH R/W
ASPHALT PAVED PUBLIC ROADWAY
PCN: 77-40-43-01-22-001-0000

R=500.00'
Δ=006°00'43"
L=52.46'
CHB=N88°42'31"E
CHD=52.44'

R=500.00'
Δ=006°00'43"
L=52.46'
CHB=N88°42'31"E
CHD=52.44'

S88°17'08"E
52.00'

CRF
(ALLEGIBLE)

S43°17'08"E
56.57'

N 881020
E 880750

N 880700
E 880750

SEMINOLE-PRATT WHITNEY ROAD

VARIABLE WIDTH R/W
ASPHALT PAVED PUBLIC ROADWAY
PB 132, PG 77-80

S04°59'06"W
210.34'

CRF
13.2591'

8' PUBLIC
PARKWAY EASEMENT
PB 132, PG 77

10' UTILITY EASEMENT
PB 132, PG 77

BENCHMARK
NAIL & DISK IN ASPHALT
TRANSVERSE BOHLER
ELEV=20.41'

BENCHMARK
NAIL & DISK IN CURB
TRANSVERSE BOHLER
ELEV=21.52'



BOHLER

SITE CIVIL AND CONSULTING ENGINEERING
PROGRAM MANAGEMENT
LANDSCAPE ARCHITECTURE
SUSTAINABLE DESIGN
PERMITTING SERVICES
TRANSPORTATION SERVICES

REVISIONS

REV	DATE	COMMENT	CHECKED BY
1	7/14/2025	1ST ROUND OF COMMENTS	AH
2	8/11/2025	2ND ROUND OF COMMENTS	KD
3	08/14/2025	QA/QC COMMENTS	AH
4	10/23/2025	3RD ROUND OF COMMENTS	KD



ISSUED FOR MUNICIPAL & AGENCY REVIEW & APPROVAL

THIS DRAWING IS INTENDED FOR MUNICIPAL AND/OR AGENCY REVIEW AND APPROVAL. IT IS NOT INTENDED AS A CONSTRUCTION DOCUMENT UNLESS INDICATED OTHERWISE.

PROJECT No.: FLA230191-00-0A
DRAWN BY: -AHMV-
CHECKED BY: -KD/KM-
DATE: 10/23/2025
CAD ID: P-CIVIL-LGHT

PROJECT:

SITE CONSTRUCTION PLANS

FOR




MAVIS TIRES & BRAKES - CITY OF WESTLAKE
16775 PERSIMMON BLVD
WESTLAKE, FL 33470
CITY OF WESTLAKE
S 01, T 43S, R 40E

BOHLER

600 N. WESTSHORE BLVD. SUITE 950
TAMPA, FLORIDA 33609
Phone: (813) 812-4100
Fax: (813) 812-4101

FLORIDA BUSINESS CERT. OF AUTH. No. 30780

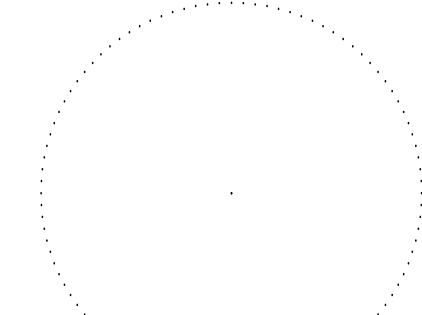

This item has been digitally signed and sealed by Kayla M. Dedrick PE on the date adjacent to the seal. Signature must be verified on any electronic copies.

SHEET TITLE:

LIGHTING PLAN

SHEET NUMBER:

L-201

REVISION 4 - 10/23/2025

THIS PLAN TO BE UTILIZED
FOR LIGHTING PURPOSES
ONLY