

VERIFY ALL CONDITIONS AND DIMENSIONS ON THE JOB AND NOTIFY THE DESIGN ALLIANCE ARCHITECTS, INC. OF ANY DISCREPANCIES PRIOR TO START.

ALL DRAWINGS ARE  
1/2 SCALE SHOWN

PRELIMINARY NOT  
FOR CONSTRUCTION

# WALWORTH CO. HOUSING AUTHORITY MIXED-USE BUILDING

209 South Taft Street, Whitewater, WI 53190

DRAWING INDEX:

- SP-1 DRAWING INDEX, SITE PLAN, SITE AERIAL PHOTO
- SP-2 LANDSCAPING PLAN, DUMPSTER DETAILS
- SP-3 SITE LIGHTING PLAN
- A-1 MAIN FLOOR PLAN (REMODEL)
- A-2 SECOND FLOOR PLAN (REMODEL)
- A-3 ROOF PLAN (REMODEL)
- A-4 ELEVATIONS (REMODEL)
- A-5 ELEVATIONS (REMODEL)
- A-6 EXTERIOR PHOTOS

DRAWING INDEX: (CONTINUED)

- AB-1 MAIN FLOOR PLAN (AS-BUILT)
- AB-2 SECOND FLOOR PLAN (AS-BUILT)
- AB-3 ROOF PLAN (AS-BUILT)
- AB-4 ELEVATIONS (AS-BUILT)
- AB-5 ELEVATIONS (AS-BUILT)
- D-1 MAIN FLOOR PLAN (DEMO)
- D-2 SECOND FLOOR PLAN (DEMO)

PROJECT DESCRIPTION:

REMODEL EXISTING BUILDING FOR MIXED-USE .  
5) APARTMENTS AND COMMERCIAL SPACE.

IEBC LEVEL II ALTERATION.

BUILDING INFORMATION:

|                             |                   |
|-----------------------------|-------------------|
| CONSTRUCTION TYPE:          | TYPE VB           |
| BUILDING FOOTPRINT:         | ± 2,724 S.F.      |
| ALTERED AREA:               | 5,448 S.F.        |
| NO. OF FLOORS:              | 2                 |
| OCCUPANCY GROUP:            | B / R-2           |
| SPRINKLERED:                | NO                |
| SOIL BEARING:               | 2,000 psf ASSUMED |
| BUILDING CODE:              | IBC 2025          |
| RISK CATAGORY: TABLE 1604.5 | II                |

SITE INFORMATION:


|                   |               |             |
|-------------------|---------------|-------------|
| SITE AREA:        | ± 15,320 S.F. | (0.35 ACRE) |
| FOOTPRINT AREA:   | 2,724 S.F.    | (17.8%)     |
| PARKING AREA:     | 4,254 S.F.    | (27.8%)     |
| SIDEWALK AREA:    | 624 S.F.      | (4.1%)      |
| GREEN SPACE AREA: | 7,707 S.F.    | (50.3%)     |



SITE AERIAL PHOTO - (FROM WALWORTH COUNTY G.I.S. WEBSITE)



SCALE: 1" = 20'-0"  
2025/DRAWINGS.DWG  
DATE:

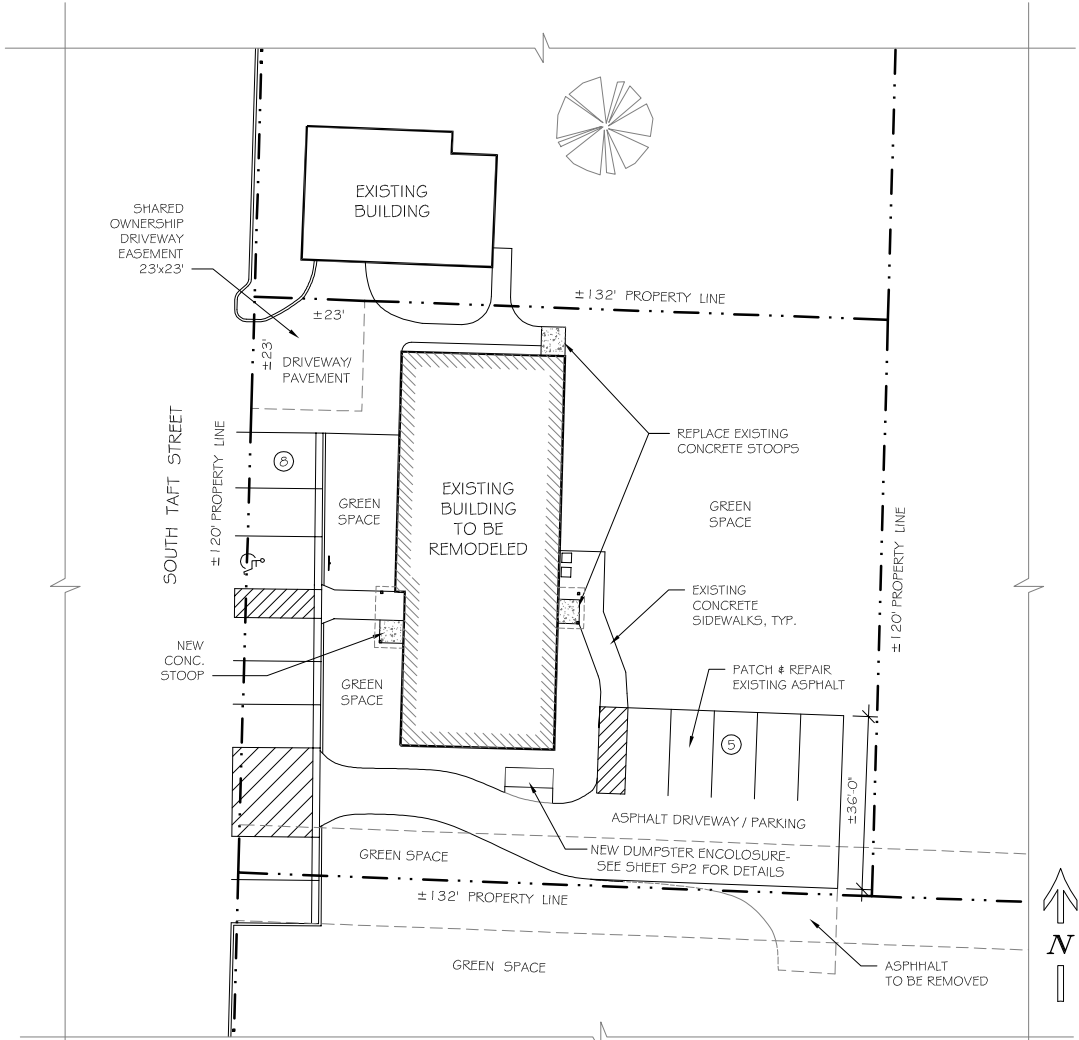

SITE PLAN  
SCALE: 1" = 20'-0"  
2025/DRAWINGS.DWG  
DATE:

WALWORTH CO. HOUSING AUTHORITY  
MIXED-USE BUILDING  
209 South Taft Street  
Whitewater, WI 53190

DRAWING NAMES

- DRAWING INDEX
- SITE PLAN
- SITE AERIAL PHOTO

REVISIONS

PROJECT DATA

DATE: 11/10/2025  
DRAWN BY: J.K.  
CHECKED BY: P.W.

SHEET NO.

SP-1

Design  
Alliance

Architects, Inc.


1003 Madison Avenue  
Fort Atkinson, WI

(920) 563-3404

VERIFY ALL CONDITIONS AND DIMENSIONS ON THE JOB AND NOTIFY THE DESIGN ALLIANCE ARCHITECTS, INC. OF ANY DISCREPANCIES PRIOR TO START.


ALL DRAWINGS ARE  
1/2 SCALE SHOWN

PRELIMINARY NOT  
FOR CONSTRUCTION

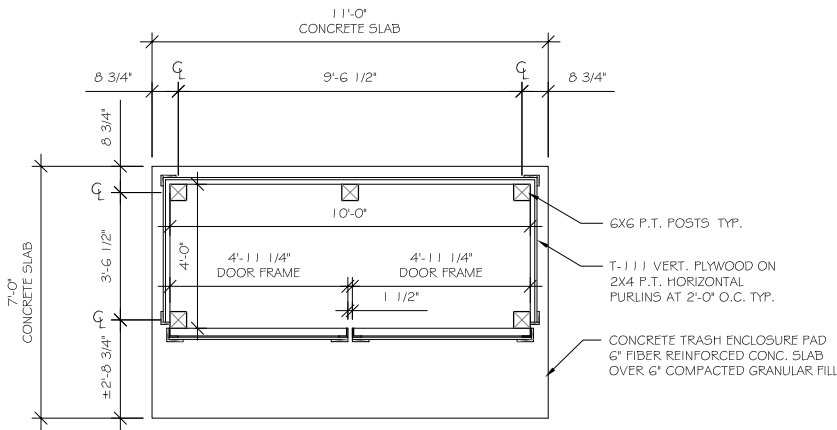


DUMPSTER ENLOCUSRE -  
FLOOR PLAN

SCALE: 3/8" = 1'-0"  
2025/DRAWINGS.DWG  
DATE:

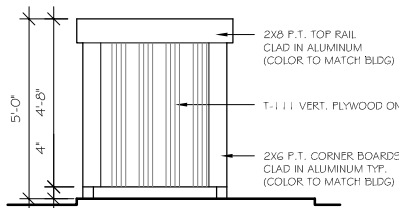


DUMPSTER ENLOCUSRE -  
WEST ELEVATION

SCALE: 3/8" = 1'-0"  
2025/DRAWINGS.DWG  
DATE:

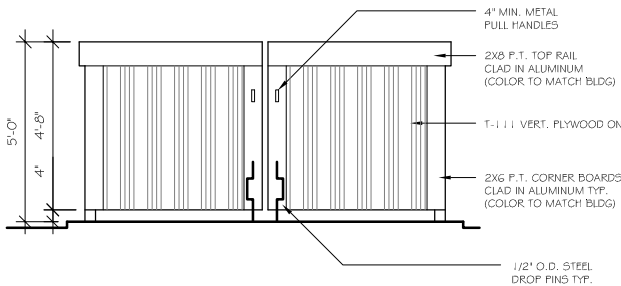

DUMPSTER ENLOCUSRE -  
SOUTH ELEVATION

SCALE: 3/8" = 1'-0"  
2025/DRAWINGS.DWG  
DATE:

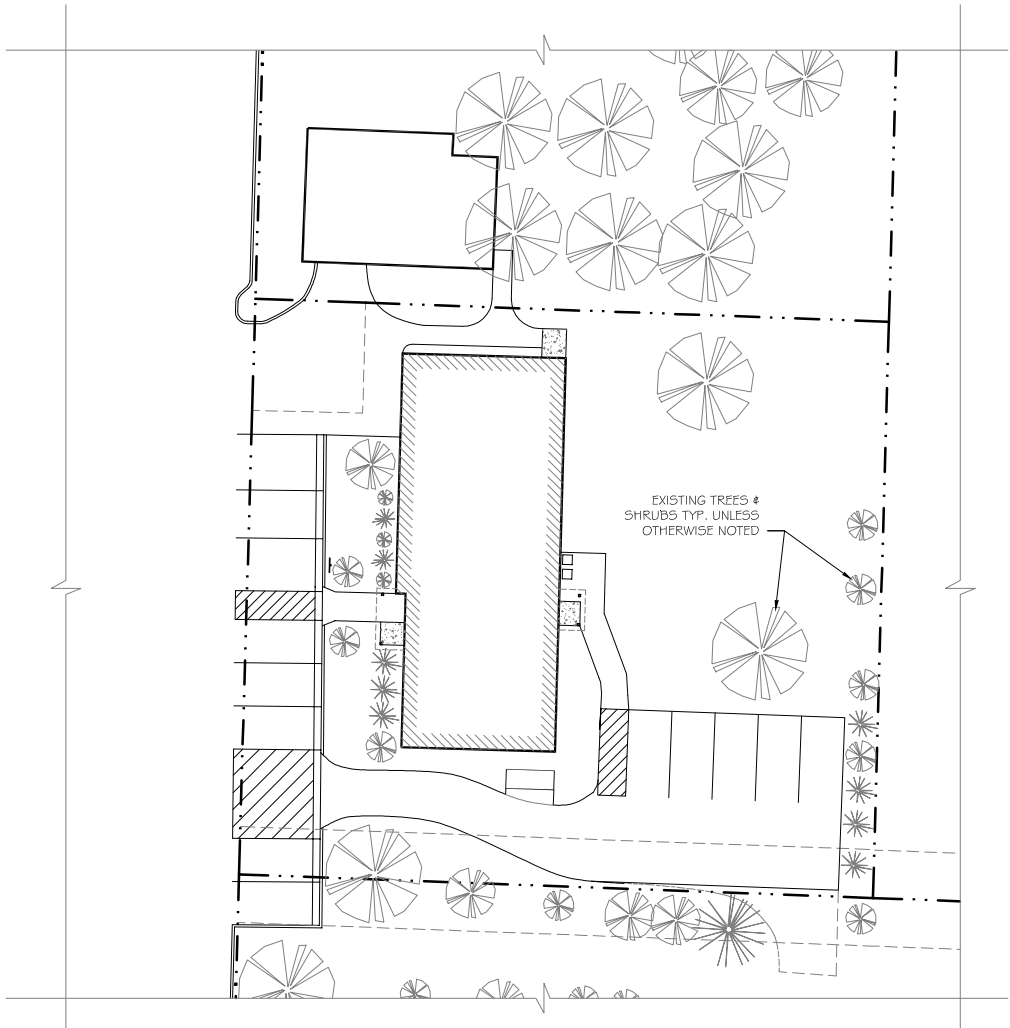

LANDSCAPING PLAN

SCALE: 1" = 20'-0"  
2025/DRAWINGS.DWG  
DATE:

WALWORTH CO. HOUSING AUTHORITY  
MIXED-USE BUILDING  
209 South Taft Street  
Whitewater, WI 53190

DRAWING NAMES

LANDSCAPING PLAN  
DUMPSTER DETAILS

REVISIONS

PROJECT DATA

DATE: 11/10/2025  
DRAWN BY: J.K.  
CHECKED BY: P.W.

SHEET NO.

SP-2

Design  
Alliance  
Architects, Inc.

1003 Madison Avenue  
Fort Atkinson, WI

(920) 563-3404

| Schedule                                                                                                                                                               |          |     |                                    |                                                                                                                                            |      |              |                 |      |         |
|------------------------------------------------------------------------------------------------------------------------------------------------------------------------|----------|-----|------------------------------------|--------------------------------------------------------------------------------------------------------------------------------------------|------|--------------|-----------------|------|---------|
| Symbol                                                                                                                                                                 | Label    | QTY | Catalog Number                     | Description                                                                                                                                | Lamp | Number Lamps | Lumens per Lamp | LLF  | Wattage |
|                                                                                       | <b>A</b> | 5   | DSXW1 P1 27K 80CRI BLC3            | 2000 2700K 80CRI Back Lit Type 3                                                                                                           |      | 1            | 1284            | 0.97 | 12.37   |
| <br> | <b>B</b> | 1   | DSX1 LED P1 27K 80CRI AFR HS EGS-F | D-Series Size 1 Area Luminaire P1 Performance Package 2700K CCT 80 CRI Automotive Front Row Houseside Shield Forward External Glare Shield |      | 1            | 4873            | 0.97 | 50.9    |

| Schedule                                                                                                                                                               |          |     |                                    |                                                                                                                                            |      |              |                 |      |         |
|------------------------------------------------------------------------------------------------------------------------------------------------------------------------|----------|-----|------------------------------------|--------------------------------------------------------------------------------------------------------------------------------------------|------|--------------|-----------------|------|---------|
| Symbol                                                                                                                                                                 | Label    | QTY | Catalog Number                     | Description                                                                                                                                | Lamp | Number Lamps | Lumens per Lamp | LLF  | Wattage |
|                                                                                       | <b>A</b> | 5   | DSXW1 P1 27K 80CRI BLC3            | 2000 2700K 80CRI Back Lit Type 3                                                                                                           |      | 1            | 1284            | 0.97 | 12.37   |
| <br> | <b>B</b> | 1   | DSX1 LED P1 27K 80CRI AFR HS EGS-F | D-Series Size 1 Area Luminaire P1 Performance Package 2700K CCT 80 CRI Automotive Front Row Houseside Shield Forward External Glare Shield |      | 1            | 4873            | 0.97 | 50.9    |

| Statistics   |        |        |        |        |         |         |
|--------------|--------|--------|--------|--------|---------|---------|
| Description  | Symbol | Avg    | Max    | Min    | Max/Min | Avg/Min |
| Calc Zone #2 | +      | 1.0 fc | 5.3 fc | 0.1 fc | 53.0:1  | 10.0:1  |

| Statistics   |        |        |        |        |         |         |
|--------------|--------|--------|--------|--------|---------|---------|
| Description  | Symbol | Avg    | Max    | Min    | Max/Min | Avg/Min |
| Calc Zone #2 | +      | 1.0 fc | 5.3 fc | 0.1 fc | 53.0:1  | 10.0:1  |



**WALWORTH CO. HOUSING AUTHORITY  
MIXED-USE BUILDING  
209 South Taft Street  
Whitewater, WI 53190**


## Summary

# SP-3

ALL DRAWINGS ARE  
1/2 SCALE SHOWN

PRELIMINARY NOT  
FOR CONSTRUCTION

|                                                                                    |                                                                                                                    |                                                                                     |                                                                                    |                                                                                     |                                                                                                           |                                                                                     |                                                                                                                                      |
|------------------------------------------------------------------------------------|--------------------------------------------------------------------------------------------------------------------|-------------------------------------------------------------------------------------|------------------------------------------------------------------------------------|-------------------------------------------------------------------------------------|-----------------------------------------------------------------------------------------------------------|-------------------------------------------------------------------------------------|--------------------------------------------------------------------------------------------------------------------------------------|
|  | <p>NEW DOOR WITH ADA COMPLIANT LEVER HANDLE</p>                                                                    |  | <p>NEW WALL: WOOD STUDS AT 16" O.C. WITH 1/2" DRYWALL EACH SIDE, TYP.</p>          |  | <p>EXISTING ILLUMINATED EXIT SIGN WITH EMERGENCY LIGHTS AND 90 MINUTE MIN. BATTERY BACK-UP, TYP.</p>      |  | <p>SMOKE ALARM -- HARD-WIRED WITH BATTERY BACK-UP, TYP. -- ALARMS TO BE INTERCONNECTED (HARD-WIRED OR WIRELESS) WITHIN EACH UNIT</p> |
|  | <p>EXISTING DOOR TO REMAIN -- REPLACE DOOR KNOB WITH ADA COMPLIANT LEVER HANDLE</p>                                |  | <p>EXISTING WALL</p>                                                               |  | <p>NEW APPROVED ILLUMINATED EXIT SIGN WITH EMERGENCY LIGHTS AND 90 MINUTE MIN. BATTERY BACK-UP, TYP.</p>  |  | <p>CARBON MONOXIDE DETECTOR -- HARD-WIRED WITH BATTERY BACK-UP, TYP.</p>                                                             |
|  | <p>APPROVED EMERGENCY LIGHTING WITH 90 MINUTE MIN. BATTERY BACK-UP, TYP. -- SEE EGRESS LIGHTING PLAN SHEET E-1</p> |  | <p>PROVIDE FIRE EXTINGUISHERS - CONFIRM REQUIREMENTS WITH LOCAL FIRE INSPECTOR</p> |  | <p>20"x 30" ATTIC SCUTTLE, TYP. -- 30" MIN. HEADROOM - SEE DETAIL 1/8/3 (CONFIRM LOCATION WITH OWNER)</p> |                                                                                     |                                                                                                                                      |

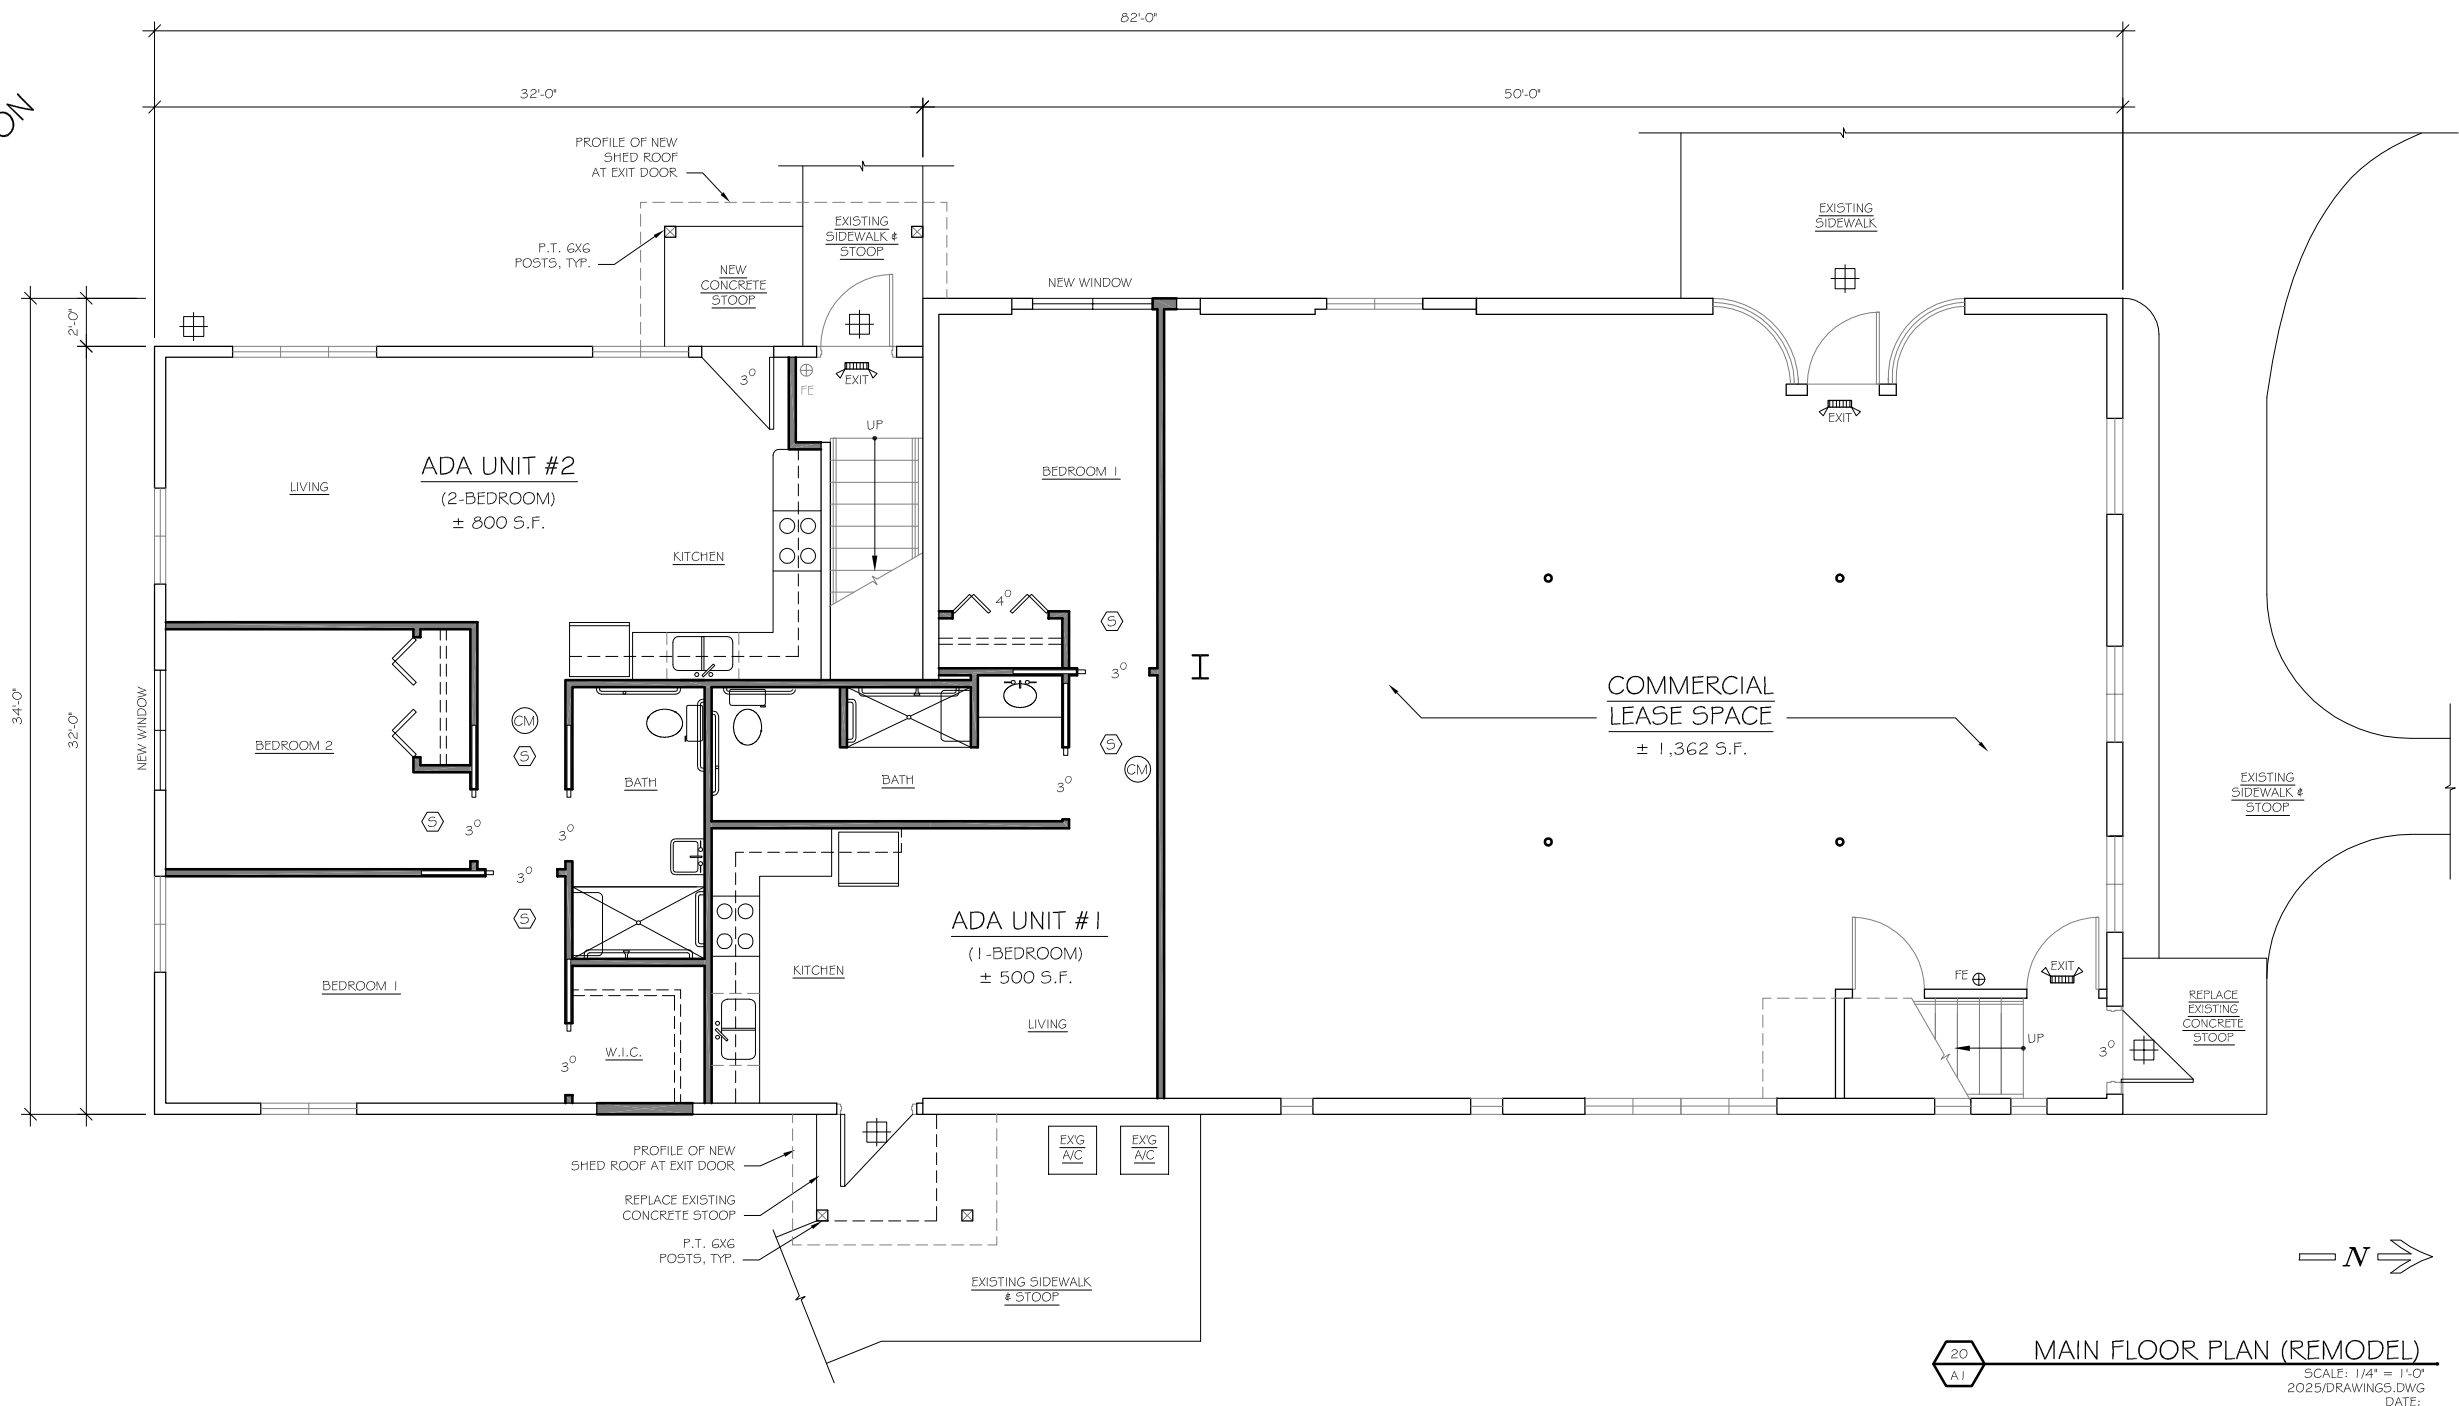

WALWORTH CO. HOUSING AUTHORITY  
MIXED-USE BUILDING  
209 South Taft Street  
Whitewater, WI 53190

## DRAWING NAMES

MAIN FLOOR PLAN (REMODEL)

## REVISIONS

## PROJECT DATA

DATE: 11/10/2025

DRAWN BY: J.K.

SHEET NO.

A-1

eDesign  
Alliance — Architects, Inc.

1003 Madison Avenue  
Fort Atkinson, WI


(920) 563-3404



VERIFY ALL CONDITIONS AND DIMENSIONS ON THE JOB AND NOTIFY THE DESIGN ALLIANCE ARCHITECTS, INC. OF ANY DISCREPANCIES PRIOR TO START.

ALL DRAWINGS ARE  
1/2 SCALE SHOWN

PRELIMINARY NOT  
FOR CONSTRUCTION

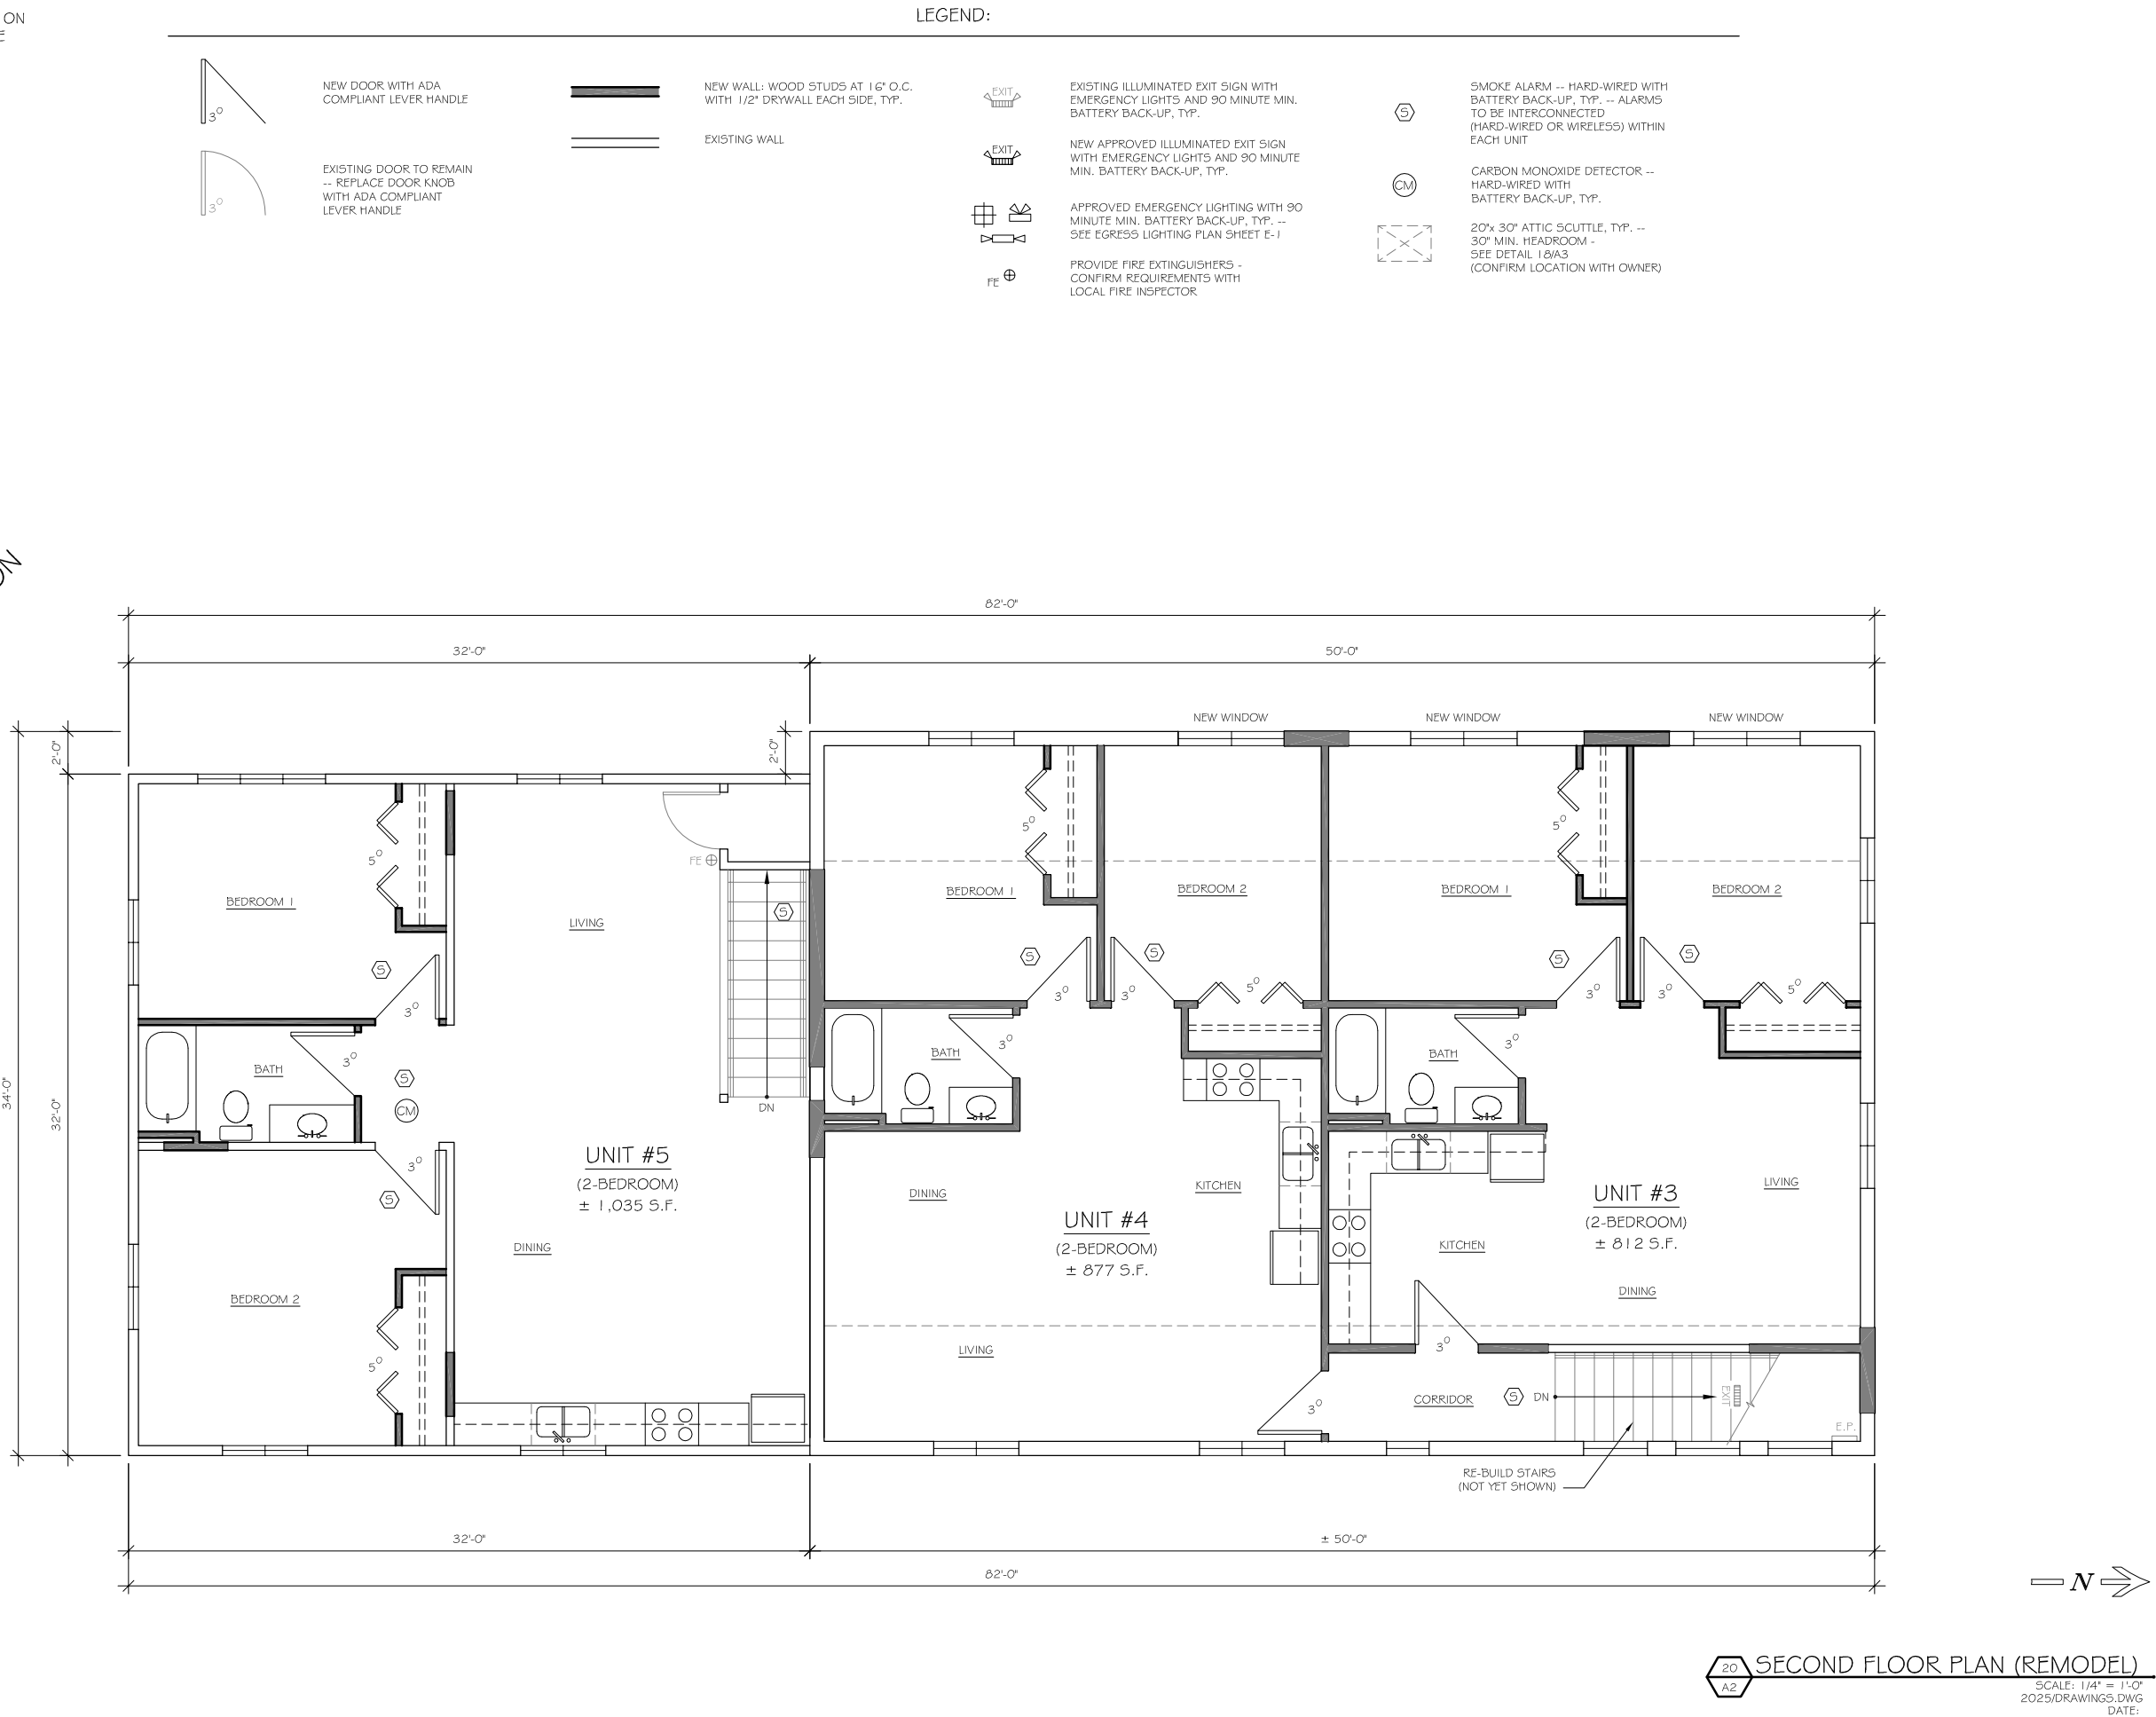

WALWORTH CO. HOUSING AUTHORITY  
MIXED-USE BUILDING  
209 South Taft Street  
Whitewater, WI 53190

DRAWING NAMES  
SECOND FLOOR PLAN  
(REMODEL)

REVISIONS

PROJECT DATA  
DATE: 11/10/2025  
DRAWN BY: J.K.  
CHECKED BY: P.W.

SHEET NO.


A-2

Design Alliance Architects, Inc.  
1003 Madison Avenue  
Fort Atkinson, WI  
(920) 563-3404

VERIFY ALL CONDITIONS AND DIMENSIONS ON THE JOB AND NOTIFY THE DESIGN ALLIANCE ARCHITECTS, INC. OF ANY DISCREPANCIES PRIOR TO START.

ALL DRAWINGS ARE  
1/2 SCALE SHOWN

PRELIMINARY NOT  
FOR CONSTRUCTION

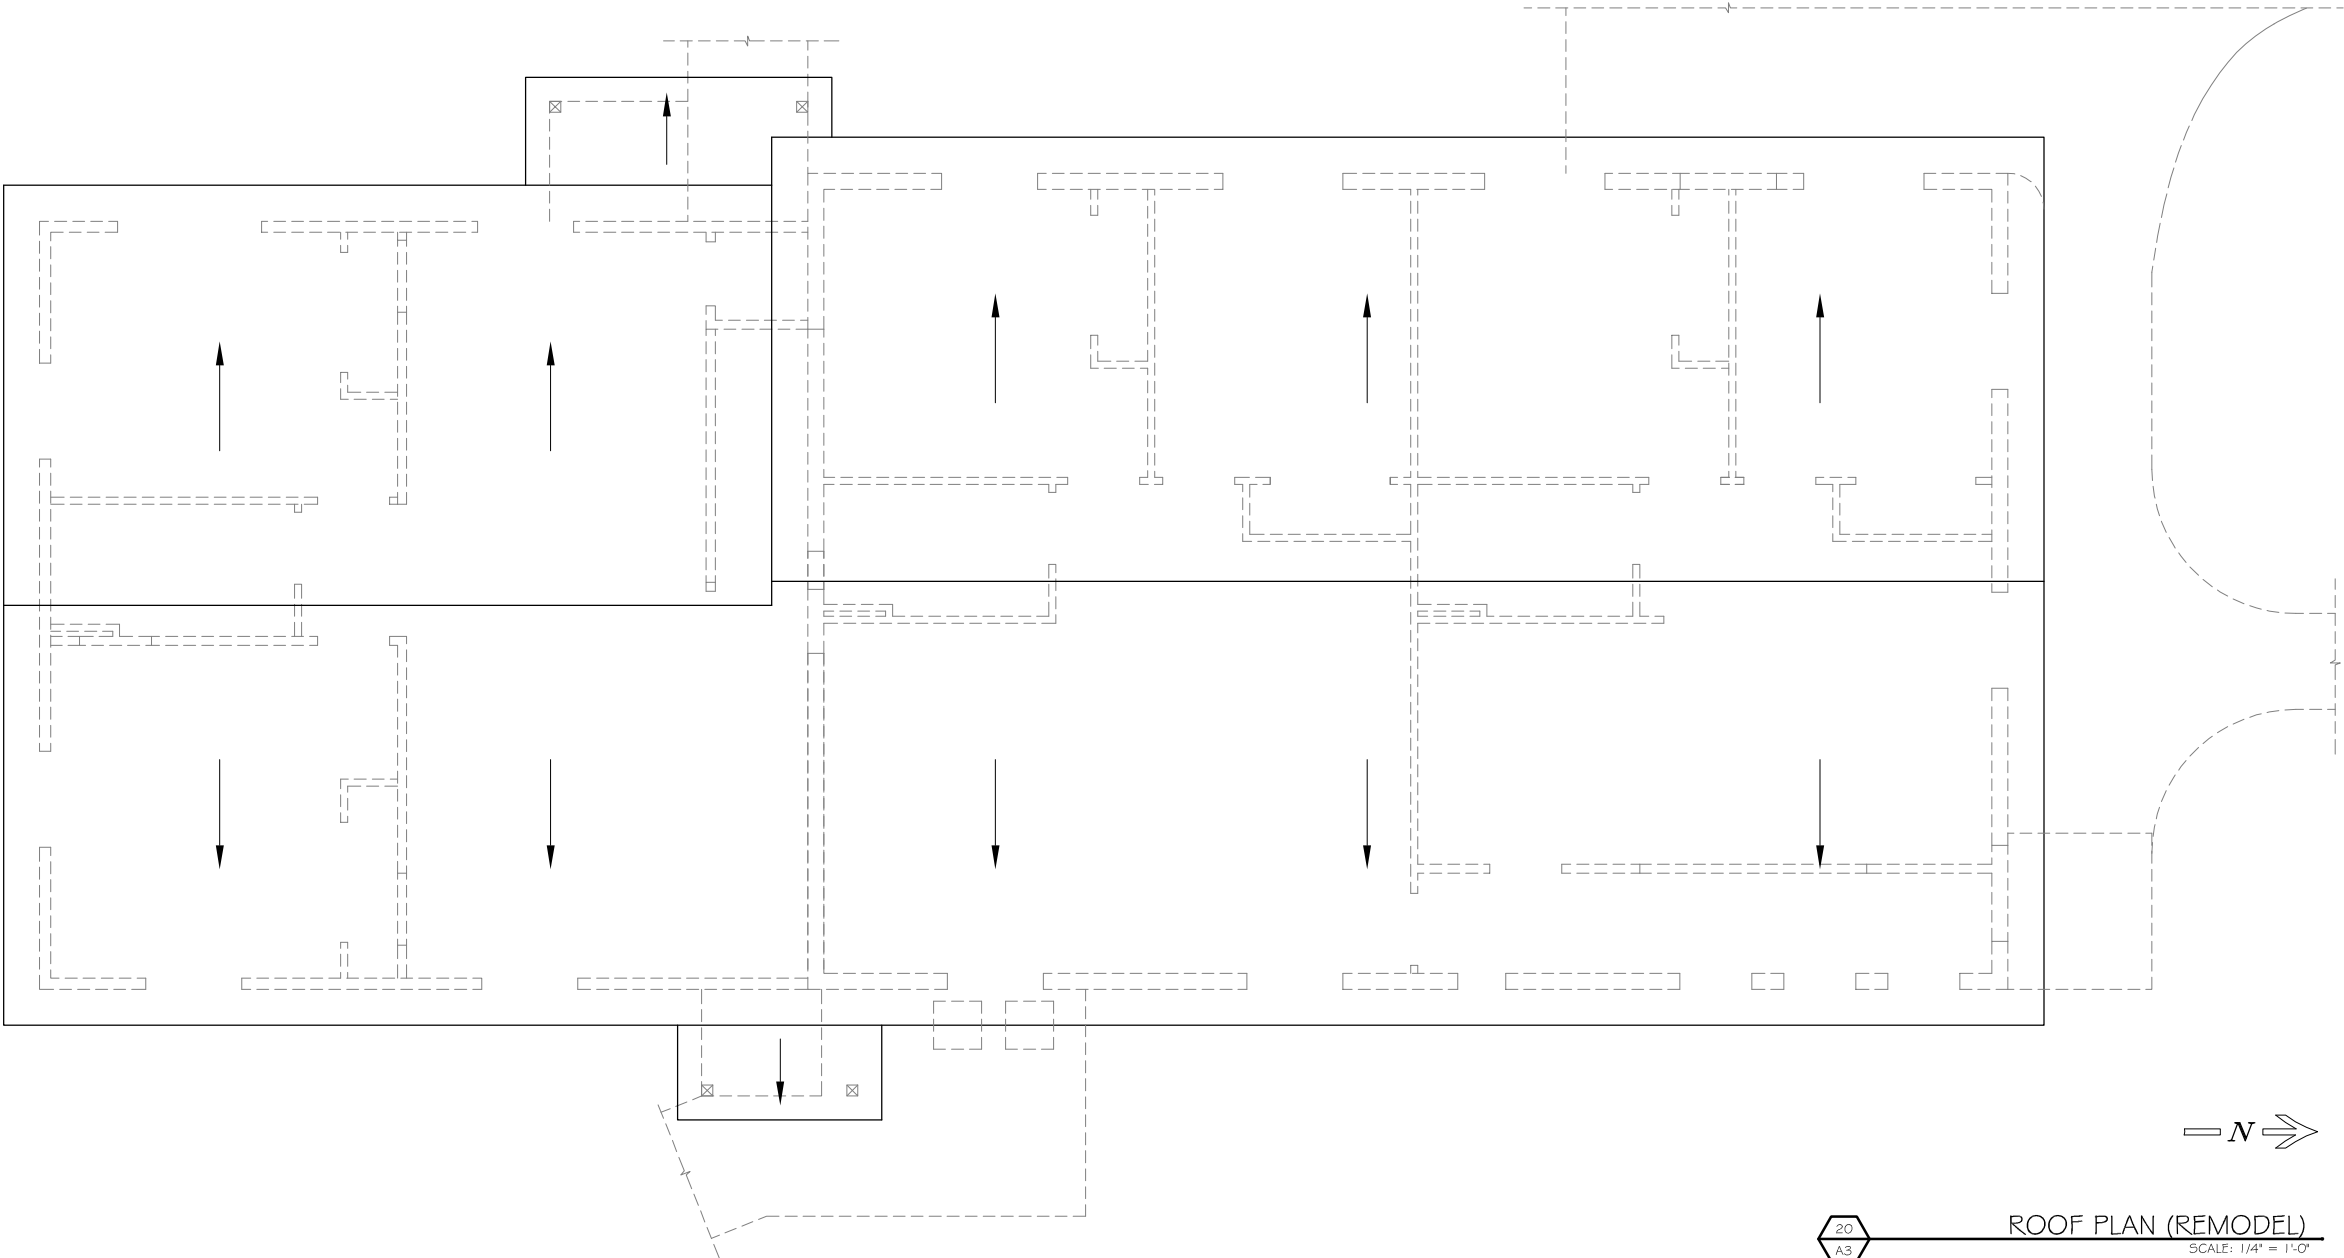

20  
A3

ROOF PLAN (REMODEL)

SCALE: 1/4" = 1'-0"  
2025/DRAWINGS.DWG  
DATE:

WALWORTH CO. HOUSING AUTHORITY  
MIXED-USE BUILDING  
209 South Taft Street  
Whitewater, WI 53190

DRAWING NAMES

ROOF PLAN  
(REMODEL)

REVISIONS

PROJECT DATA

DATE: 11/10/2025  
DRAWN BY: J.K.  
CHECKED BY: P.W.

SHEET NO.


Design  
Alliance  
Architects, Inc.  
1003 Madison Avenue  
Fort Atkinson, WI  
(920) 563-3404

A-3

VERIFY ALL CONDITIONS AND DIMENSIONS ON THE JOB AND NOTIFY THE DESIGN ALLIANCE ARCHITECTS, INC. OF ANY DISCREPANCIES PRIOR TO START.



10  
A4 WEST ELEVATION (REMODEL)  
SCALE: 1/4" = 1'-0"  
2025/DRAWINGS.DWG  
DATE:

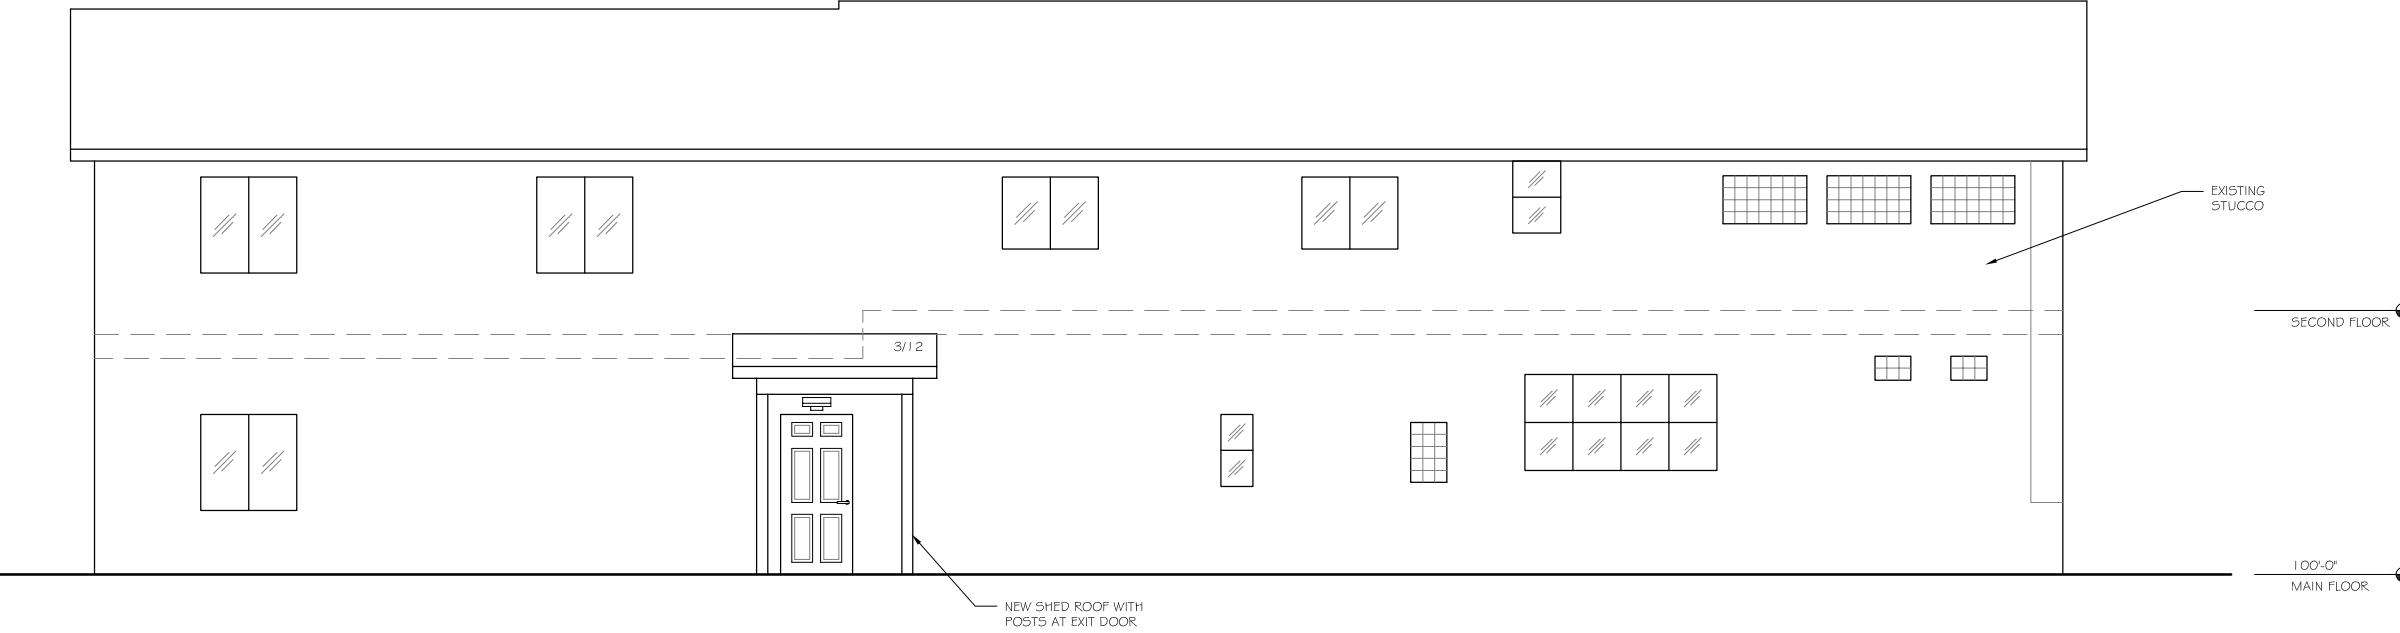

20  
A4 EAST ELEVATION (REMODEL)  
SCALE: 1/4" = 1'-0"  
2025/DRAWINGS.DWG  
DATE:

ALL DRAWINGS ARE  
1/2 SCALE SHOWN

PRELIMINARY NOT  
FOR CONSTRUCTION

WALWORTH CO. HOUSING AUTHORITY  
MIXED-USE BUILDING  
209 South Taft Street  
Whitewater, WI 53190

DRAWING NAMES

ELEVATIONS  
(REMODEL)

REVISIONS

PROJECT DATA

DATE: 11/10/2025  
DRAWN BY: J.K.  
CHECKED BY: P.W.

SHEET NO.


A-4

Design Alliance Architects, Inc.  
1003 Madison Avenue  
Fort Atkinson, WI  
(920) 563-3404


VERIFY ALL CONDITIONS AND DIMENSIONS ON THE JOB AND NOTIFY THE DESIGN ALLIANCE ARCHITECTS, INC. OF ANY DISCREPANCIES PRIOR TO START.

ALL DRAWINGS ARE  
1/2 SCALE SHOWN

PRELIMINARY NOT  
FOR CONSTRUCTION

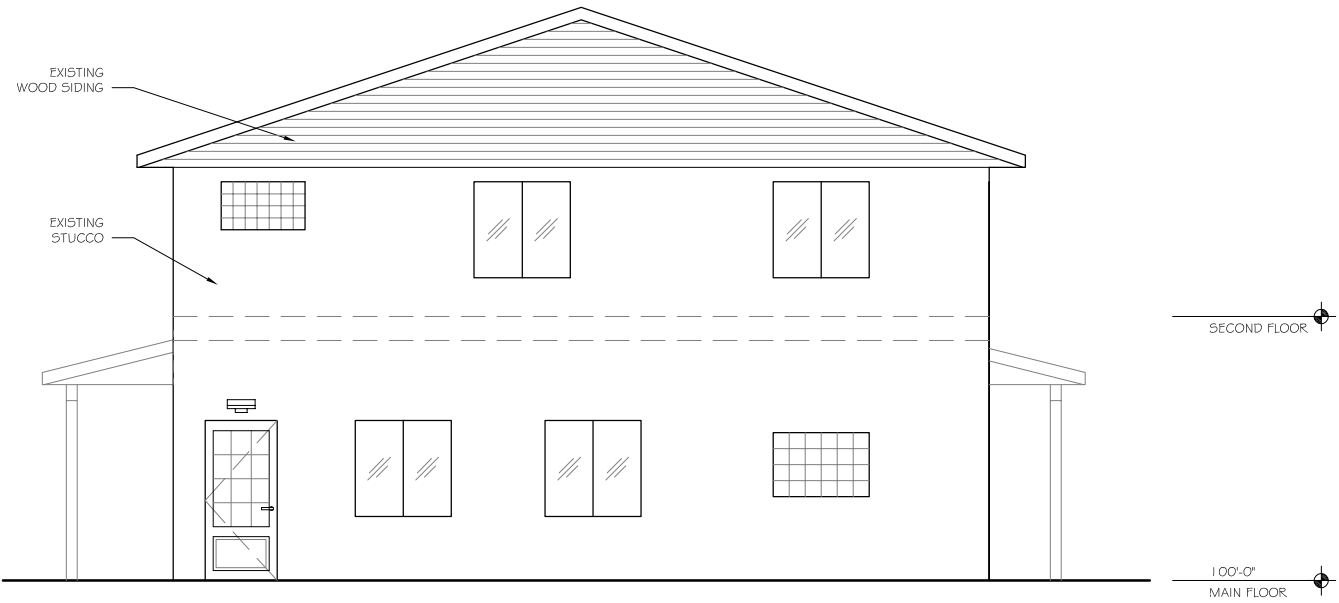

10 NORTH ELEVATION (REMODEL)  
A5  
SCALE: 1/4" = 1'-0"  
2025/DRAWINGS.DWG  
DATE:

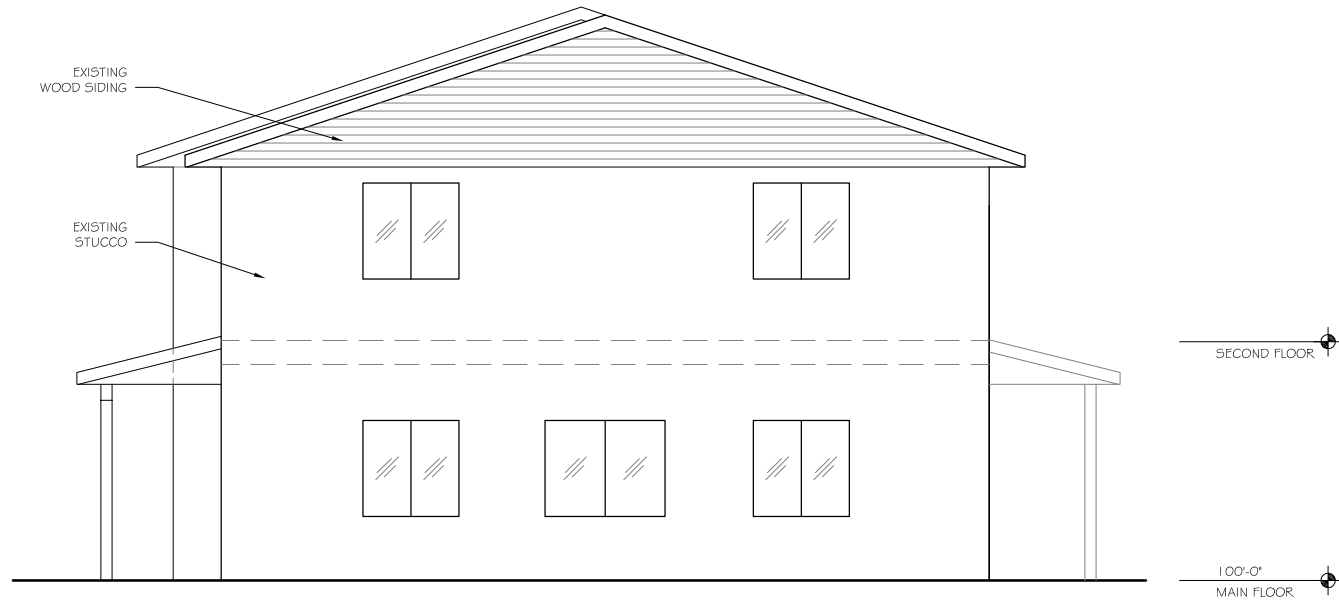

20 SOUTH ELEVATION (REMODEL)  
A5  
SCALE: 1/4" = 1'-0"  
2025/DRAWINGS.DWG  
DATE:

WALWORTH CO. HOUSING AUTHORITY  
MIXED-USE BUILDING  
209 South Taft Street  
Whitewater, WI 53190

DRAWING NAMES

|                         |
|-------------------------|
| ELEVATIONS<br>(REMODEL) |
|                         |
|                         |
|                         |
|                         |
|                         |
|                         |
|                         |

REVISIONS

|  |  |
|--|--|
|  |  |
|  |  |
|  |  |
|  |  |

PROJECT DATA

|                  |
|------------------|
| DATE: 11/10/2025 |
| DRAWN BY: J.K.   |
| CHECKED BY: P.W. |

SHEET NO.

A-5

Design Alliance Architects, Inc.

1003 Madison Avenue  
Fort Atkinson, WI

(920) 563-3404





ALL DRAWINGS ARE  
1/2 SCALE SHOWN

PRELIMINARY NOT  
FOR CONSTRUCTION



EXTERIOR PHOTO -  
WEST FACADE

---

SCALE: N.T.S.  
2025/DRAWINGS.DWG  
DATE:



EXTERIOR PHOTO -  
SOUTHWEST FACADE / DRIVEWAY

SCALE: N.T.S.  
2025/DRAWINGS.DWG  
DATE:



EXTERIOR PHOTO -  
EAST FACADE

---

SCALE: N.T.S.  
2025/DRAWINGS.DWG  
DATE:



EXTERIOR PHOTO -  
NORTHEAST FACADE / YARD

---

SCALE: N.T.S.  
2025/DRAWINGS.DWG  
DATE:

WALWORTH CO. HOUSING AUTHORITY  
MIXED-USE BUILDING  
209 South Taft Street  
Whitewater, WI 53190

3D Design  
Alliance Architects, Inc.

1003 Madison Avenue  
Fort Atkinson, WI

(920) 563-3404



|                  |  |
|------------------|--|
| DRAWING NAMES    |  |
| EXTERIOR PHOTOS  |  |
|                  |  |
|                  |  |
|                  |  |
|                  |  |
|                  |  |
|                  |  |
|                  |  |
| REVISIONS        |  |
|                  |  |
|                  |  |
|                  |  |
|                  |  |
| PROJECT DATA     |  |
| DATE: 11/10/2025 |  |
| DRAWN BY: J.K.   |  |
| CHECKED BY: P.W. |  |
| SHEET NO.        |  |
| A-6              |  |



VERIFY ALL CONDITIONS AND DIMENSIONS ON THE JOB AND NOTIFY THE DESIGN ALLIANCE ARCHITECTS, INC. OF ANY DISCREPANCIES PRIOR TO START.

ALL DRAWINGS ARE  
1/2 SCALE SHOWN

 PRELIMINARY NOT  
FOR CONSTRUCTION

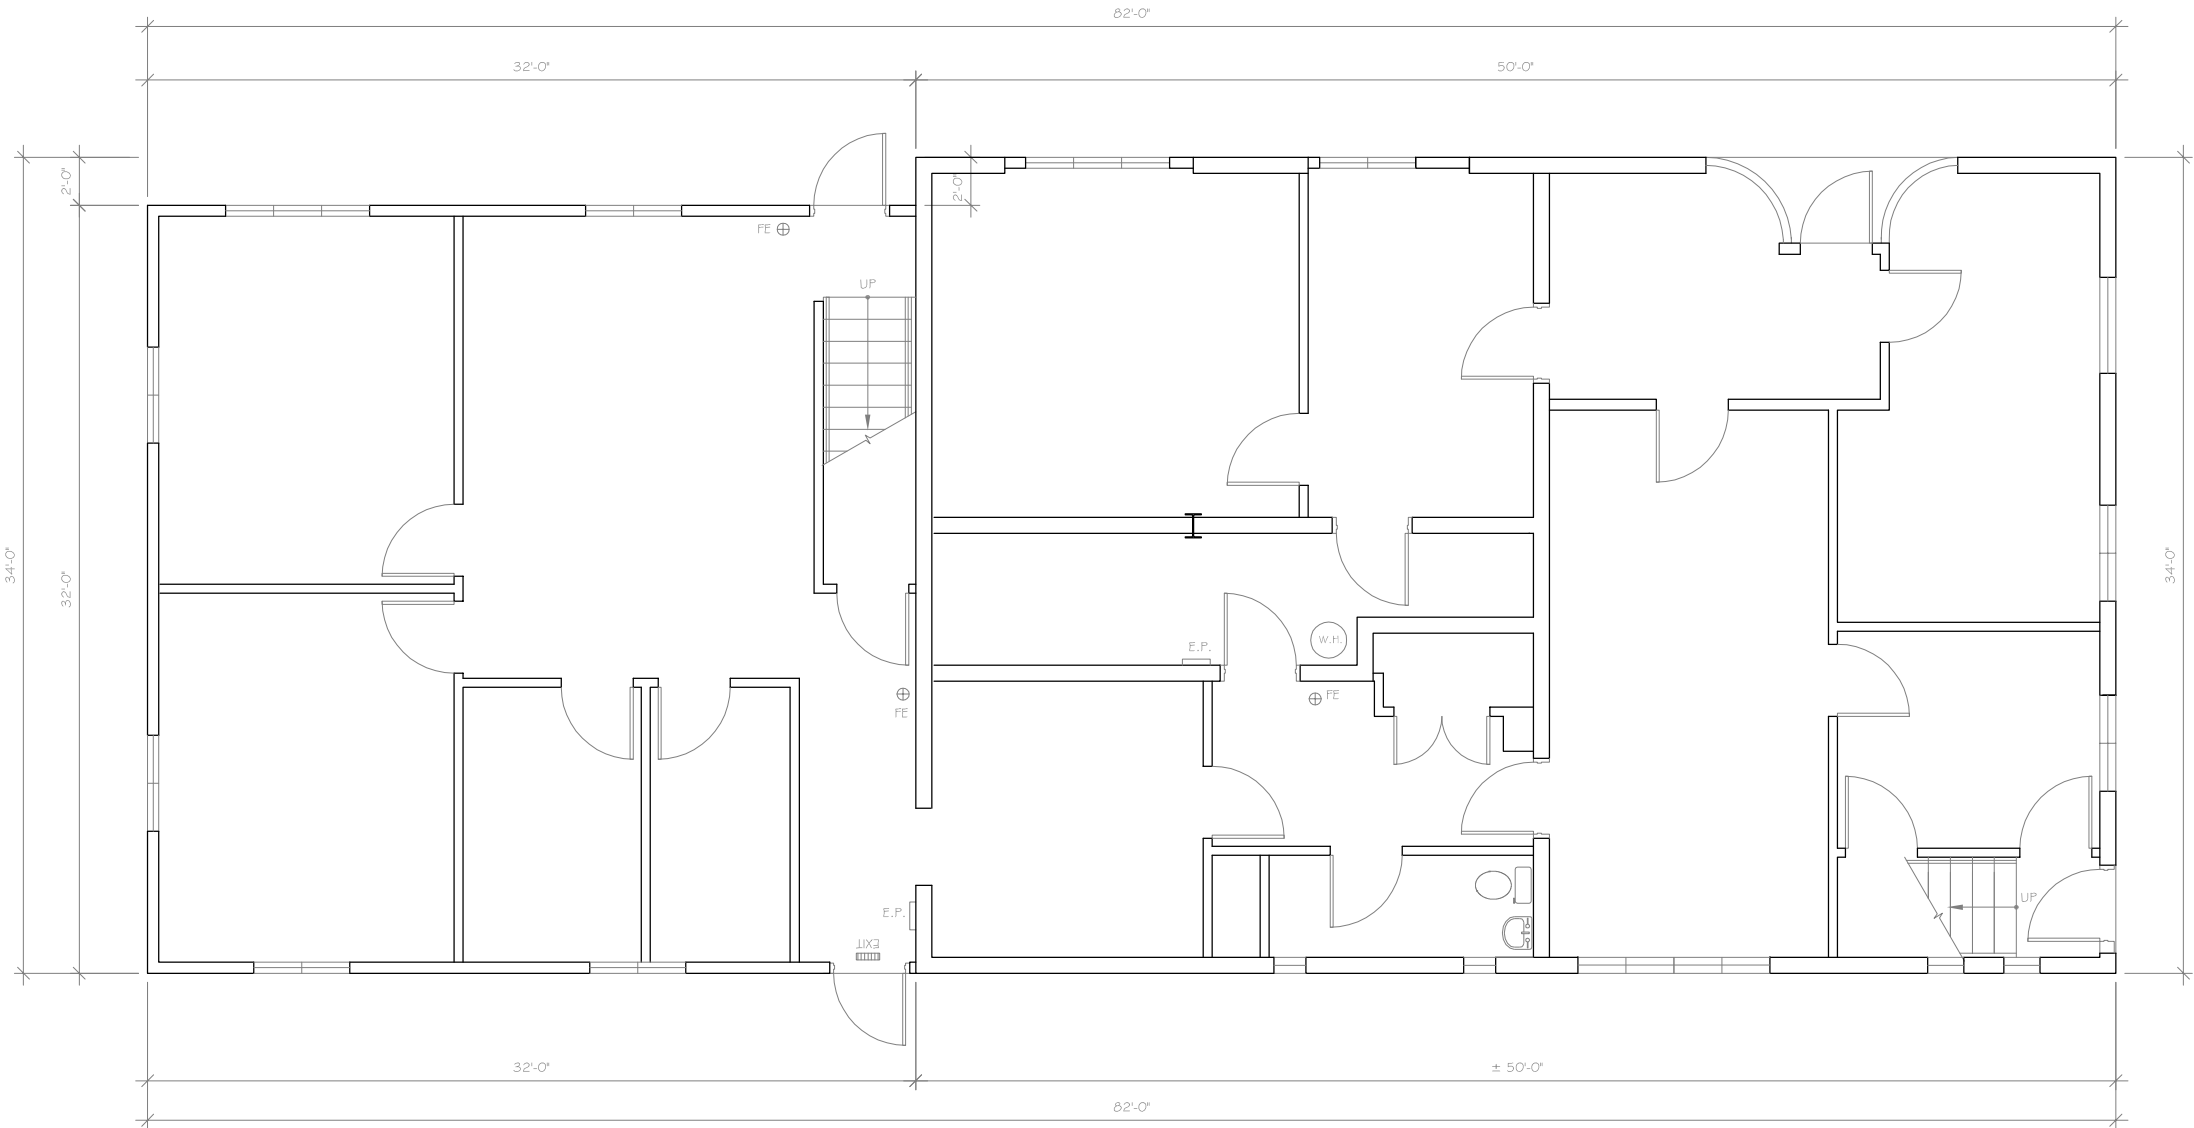

20  
AB-1

MAIN FLOOR PLAN (AS-BUILT)

SCALE: 1/4" = 1'-0"  
2025/DRAWINGS.DWG  
DATE:

WALWORTH CO. HOUSING AUTHORITY  
MIXED-USE BUILDING  
209 South Taft Street  
Whitewater, WI 53190

DRAWING NAMES

MAIN FLOOR PLAN (AS-BUILT)

REVISIONS

PROJECT DATA

DATE: 11/10/2025

DRAWN BY: J.K.

CHECKED BY: P.W.

SHEET NO.

AB-1

Design  
Alliance  
Architects, Inc.


1003 Madison Avenue  
Fort Atkinson, WI

(920) 563-3404

VERIFY ALL CONDITIONS AND DIMENSIONS ON THE JOB AND NOTIFY THE DESIGN ALLIANCE ARCHITECTS, INC. OF ANY DISCREPANCIES PRIOR TO START.

ALL DRAWINGS ARE  
1/2 SCALE SHOWN

PRELIMINARY NOT  
FOR CONSTRUCTION

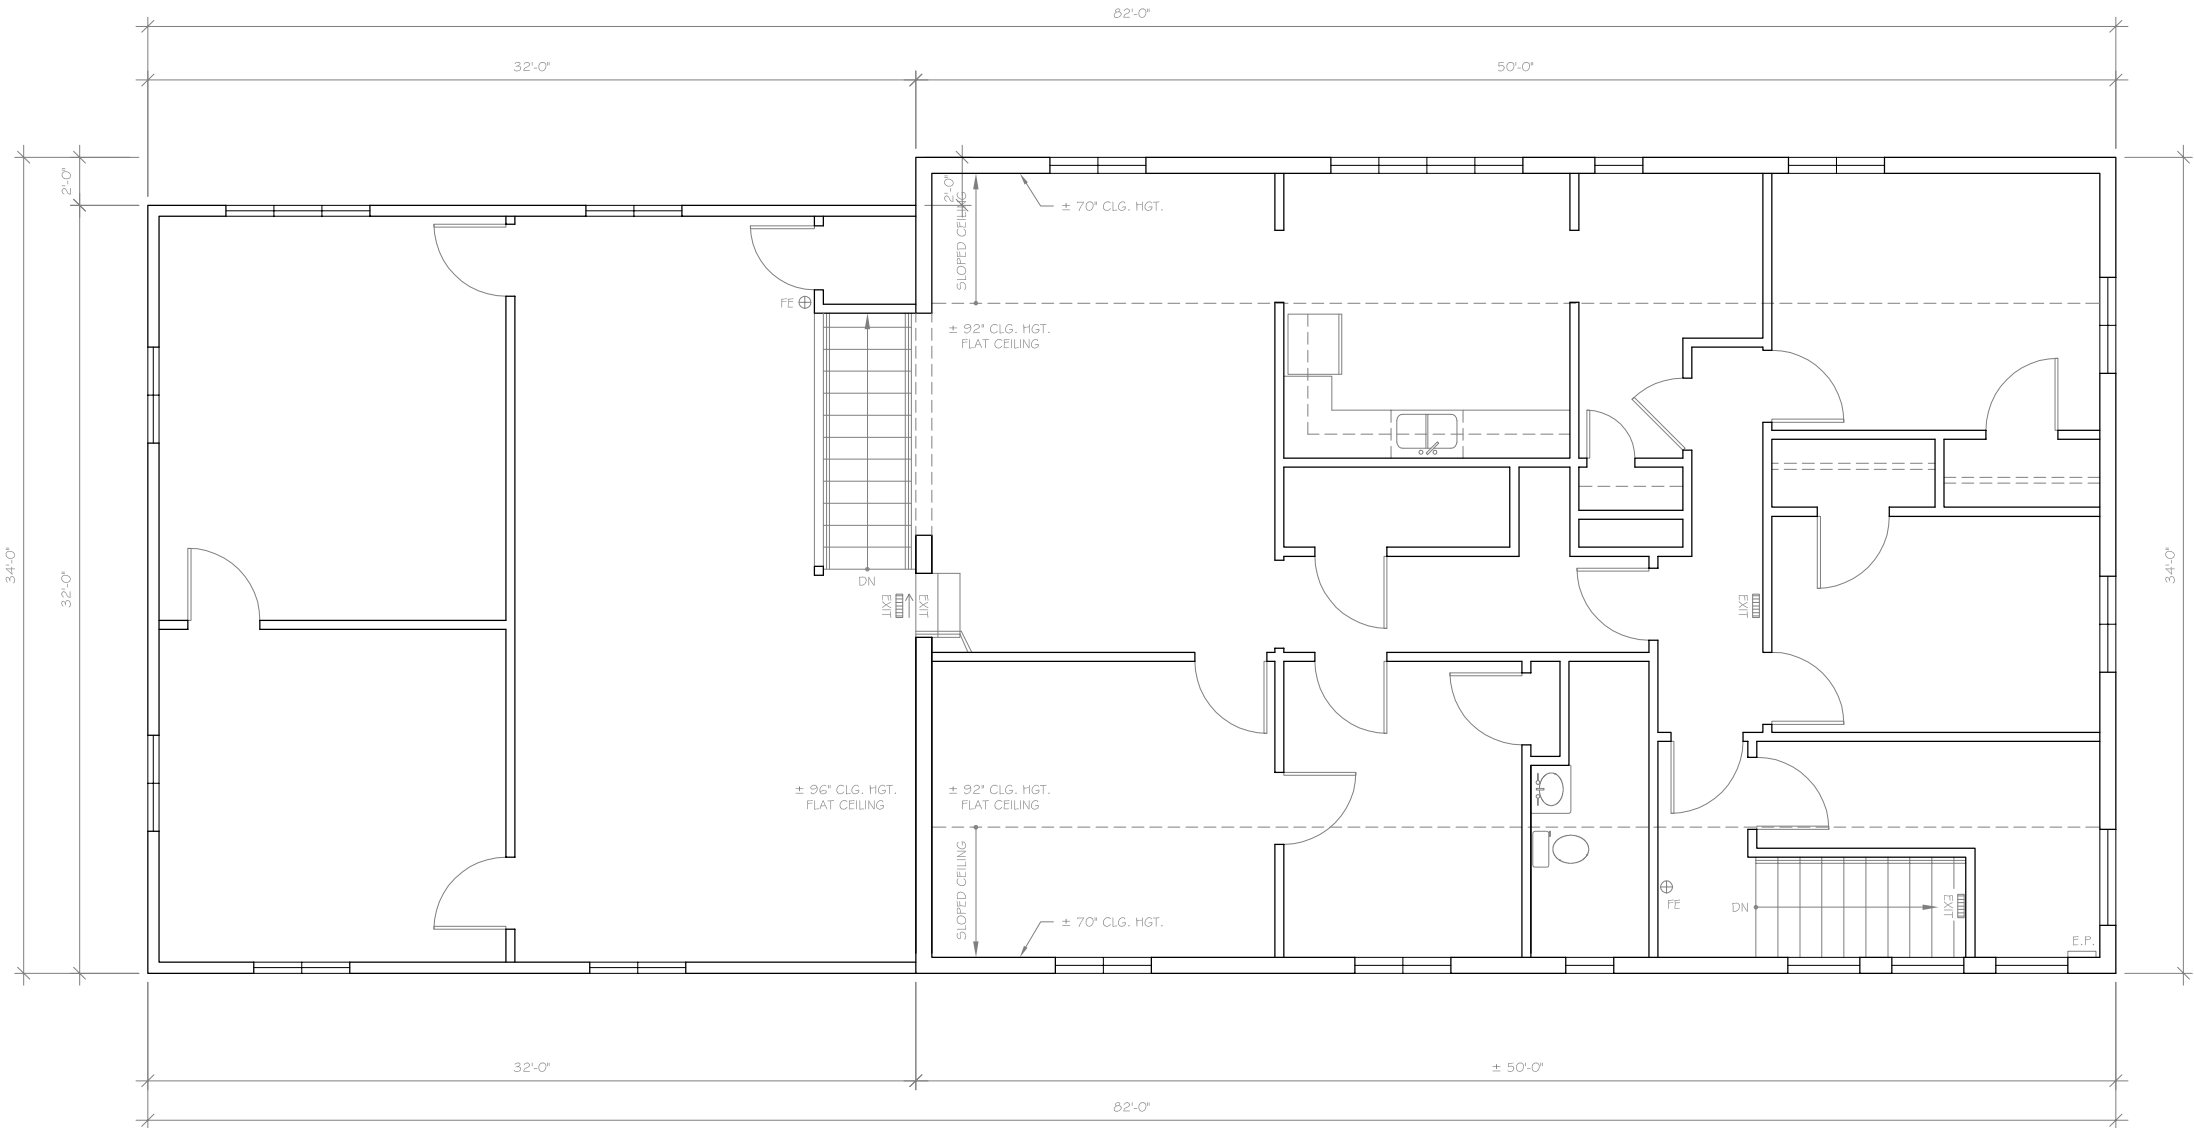

20 SECOND FLOOR PLAN (AS-BUILT)  
AB2  
SCALE: 1/4" = 1'-0"  
2025/DRAWINGS.DWG  
DATE:

WALWORTH CO. HOUSING AUTHORITY  
MIXED-USE BUILDING  
209 South Taft Street  
Whitewater, WI 53190

DRAWING NAMES  
SECOND FLOOR PLAN  
(AS-BUILT)

REVISIONS

PROJECT DATA  
DATE: 11/10/2025  
DRAWN BY: J.K.  
CHECKED BY: P.W.

 

SHEET NO.

AB-2

VERIFY ALL CONDITIONS AND DIMENSIONS ON THE JOB AND NOTIFY THE DESIGN ALLIANCE ARCHITECTS, INC. OF ANY DISCREPANCIES PRIOR TO START.

ALL DRAWINGS ARE  
1/2 SCALE SHOWN

PRELIMINARY NOT  
FOR CONSTRUCTION

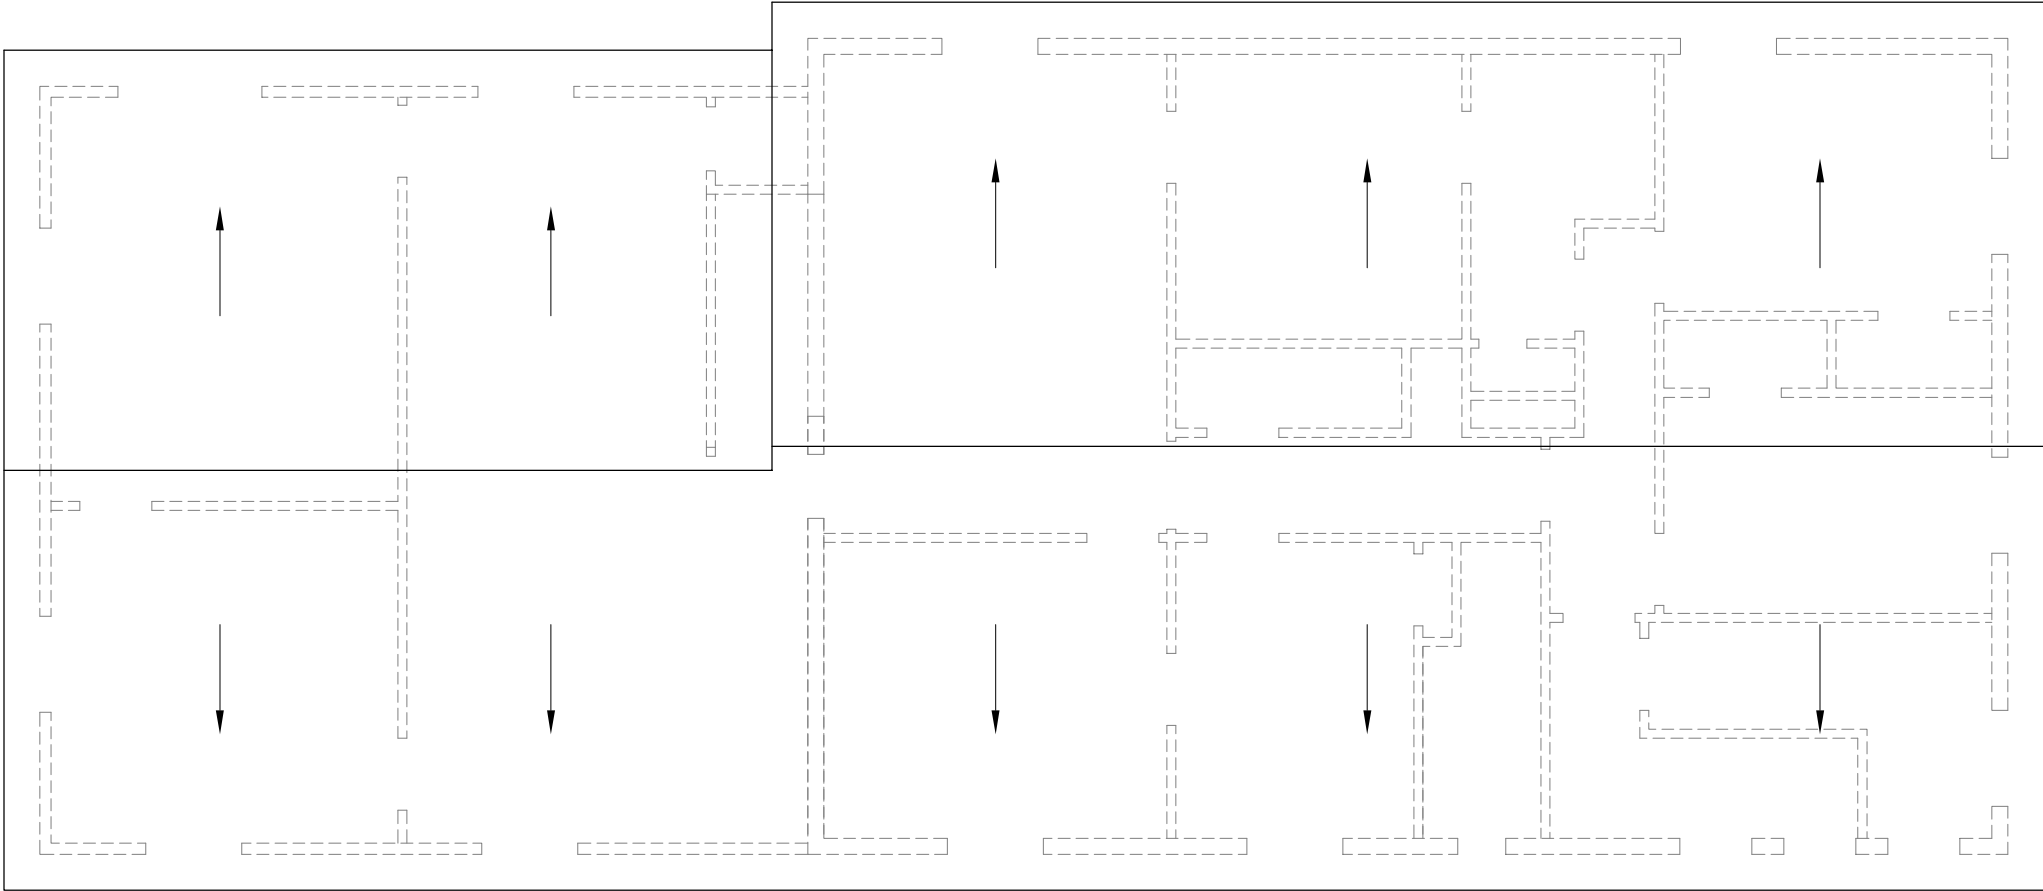

20  
AB3

ROOF PLAN (AS-BUILT)

SCALE: 1/4" = 1'-0"  
2025/DRAWINGS.DWG  
DATE:

DRAWING NAMES

ROOF PLAN  
(AS-BUILT)

REVISIONS

PROJECT DATA

DATE: 11/10/2025  
DRAWN BY: J.K.  
CHECKED BY: P.W.

SHEET NO.

AB-3


WALWORTH CO. HOUSING AUTHORITY  
MIXED-USE BUILDING  
209 South Taft Street  
Whitewater, WI 53190

Design  
Alliance  
Architects, Inc.  
1003 Madison Avenue  
Fort Atkinson, WI  
(920) 563-3404


VERIFY ALL CONDITIONS AND DIMENSIONS ON THE JOB AND NOTIFY THE DESIGN ALLIANCE ARCHITECTS, INC. OF ANY DISCREPANCIES PRIOR TO START.

ALL DRAWINGS ARE  
1/2 SCALE SHOWN

PRELIMINARY NOT  
FOR CONSTRUCTION

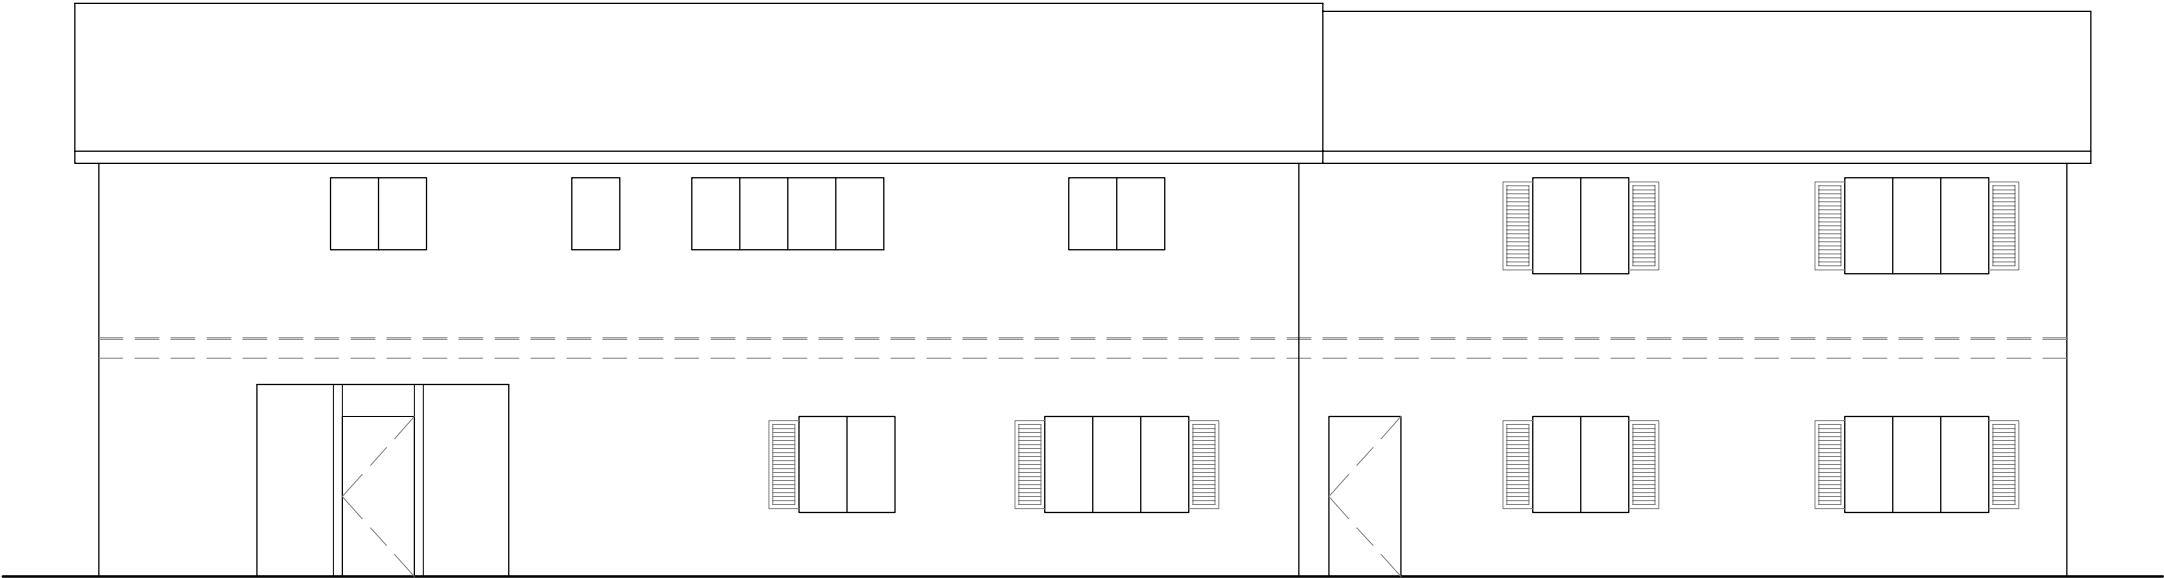

10 WEST ELEVATION (AS-BUILT)  
AB4  
SCALE: 1/4" = 1'-0"  
2025/DRAWINGS.DWG  
DATE:

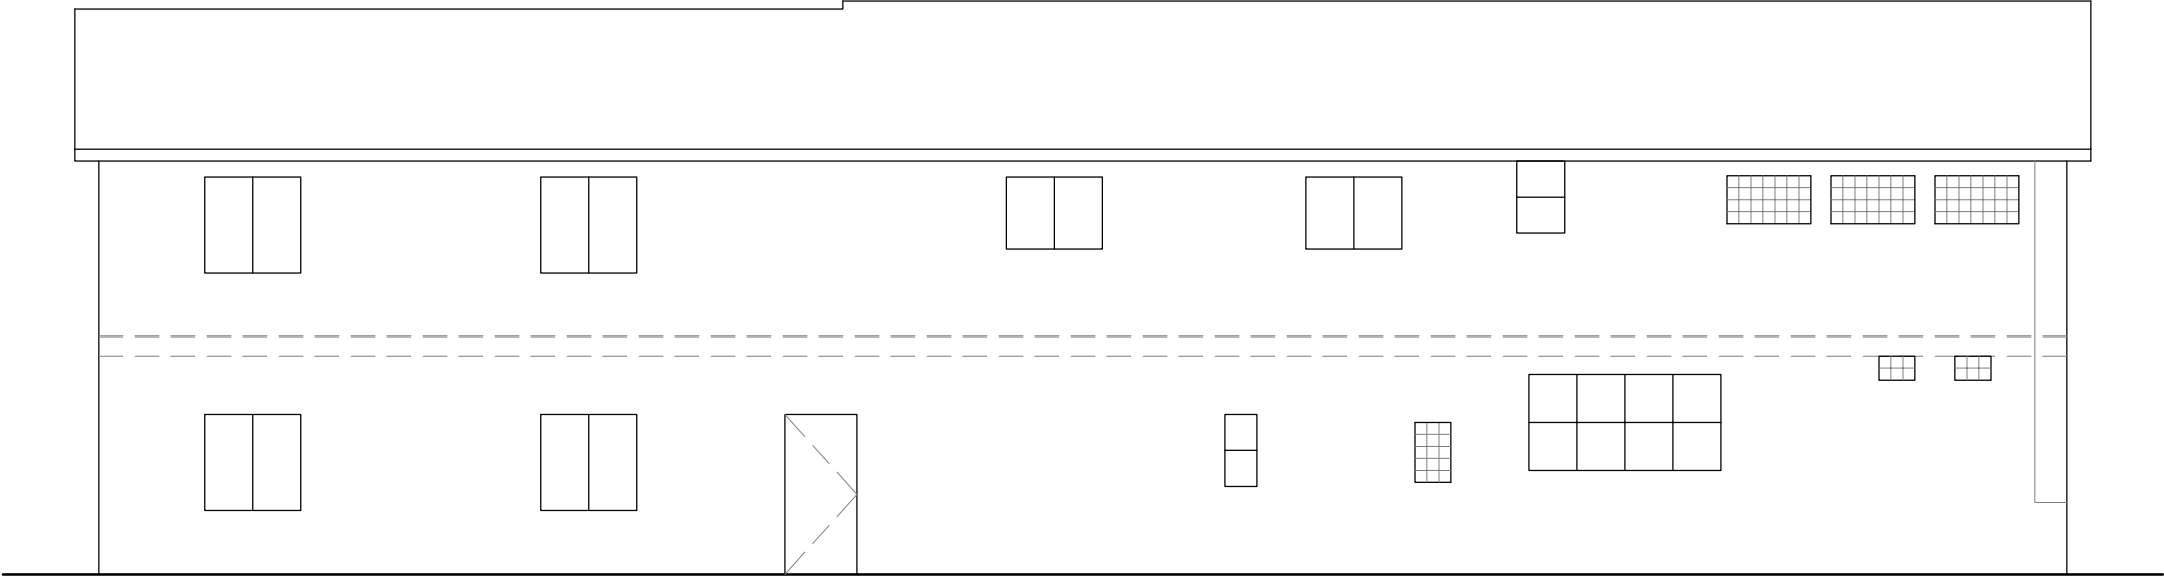

SECOND FLOOR

100'-0" MAIN FLOOR

20 EAST ELEVATION (AS-BUILT)  
AB4  
SCALE: 1/4" = 1'-0"  
2025/DRAWINGS.DWG  
DATE:

WALWORTH CO. HOUSING AUTHORITY  
MIXED-USE BUILDING  
209 South Taft Street  
Whitewater, WI 53190

DRAWING NAMES

| ELEVATIONS<br>(AS-BUILT) |
|--------------------------|
|                          |
|                          |
|                          |
|                          |
|                          |
|                          |
|                          |

REVISIONS

|  |  |
|--|--|
|  |  |
|  |  |
|  |  |
|  |  |

PROJECT DATA

|             |            |
|-------------|------------|
| DATE:       | 11/10/2025 |
| DRAWN BY:   | J.K.       |
| CHECKED BY: | P.W.       |

SHEET NO.

AB-4


VERIFY ALL CONDITIONS AND DIMENSIONS ON THE JOB AND NOTIFY THE DESIGN ALLIANCE ARCHITECTS, INC. OF ANY DISCREPANCIES PRIOR TO START.

ALL DRAWINGS ARE  
1/2 SCALE SHOWN

PRELIMINARY NOT  
FOR CONSTRUCTION



10 NORTH ELEVATION (AS-BUILT)  
AB5  
SCALE: 1/4" = 1'-0"  
2025/DRAWINGS.DWG  
DATE:

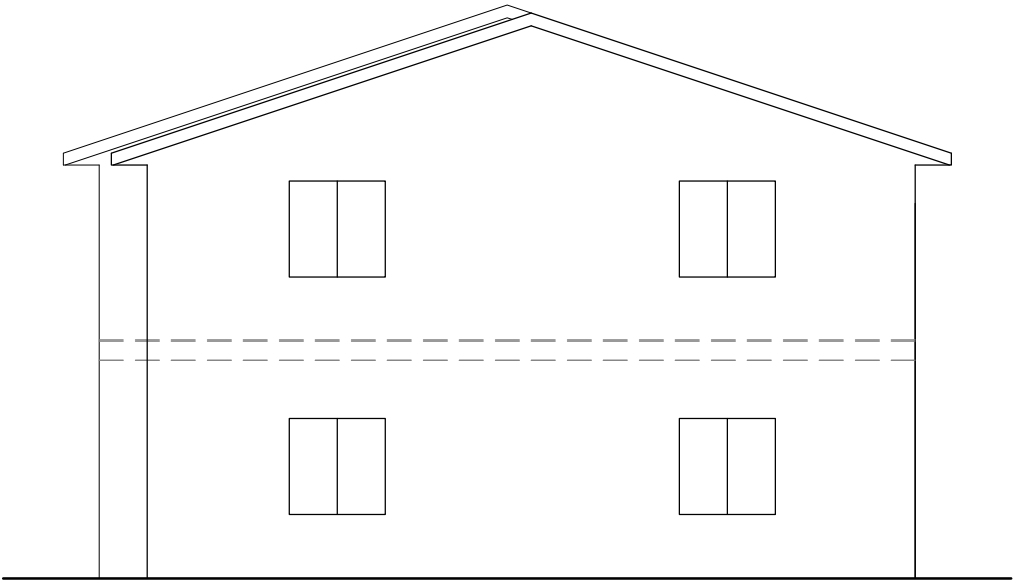

20 SOUTH ELEVATION (AS-BUILT)  
AB5  
SCALE: 1/4" = 1'-0"  
2025/DRAWINGS.DWG  
DATE:

WALWORTH CO. HOUSING AUTHORITY  
MIXED-USE BUILDING  
209 South Taft Street  
Whitewater, WI 53190

DRAWING NAMES

| ELEVATIONS<br>(AS-BUILT) |
|--------------------------|
|                          |
|                          |
|                          |
|                          |
|                          |
|                          |

REVISIONS

|  |  |
|--|--|
|  |  |
|  |  |
|  |  |
|  |  |

PROJECT DATA

|                  |
|------------------|
| DATE: 11/10/2025 |
| DRAWN BY: J.K.   |
| CHECKED BY: P.W. |

SHEET NO.

AB-5

Design Alliance Architects, Inc.


1003 Madison Avenue  
Fort Atkinson, WI

(920) 563-3404

VERIFY ALL CONDITIONS AND DIMENSIONS ON THE JOB AND NOTIFY THE DESIGN ALLIANCE ARCHITECTS, INC. OF ANY DISCREPANCIES PRIOR TO START.

ALL DRAWINGS ARE  
1/2 SCALE SHOWN

PRELIMINARY NOT  
FOR CONSTRUCTION

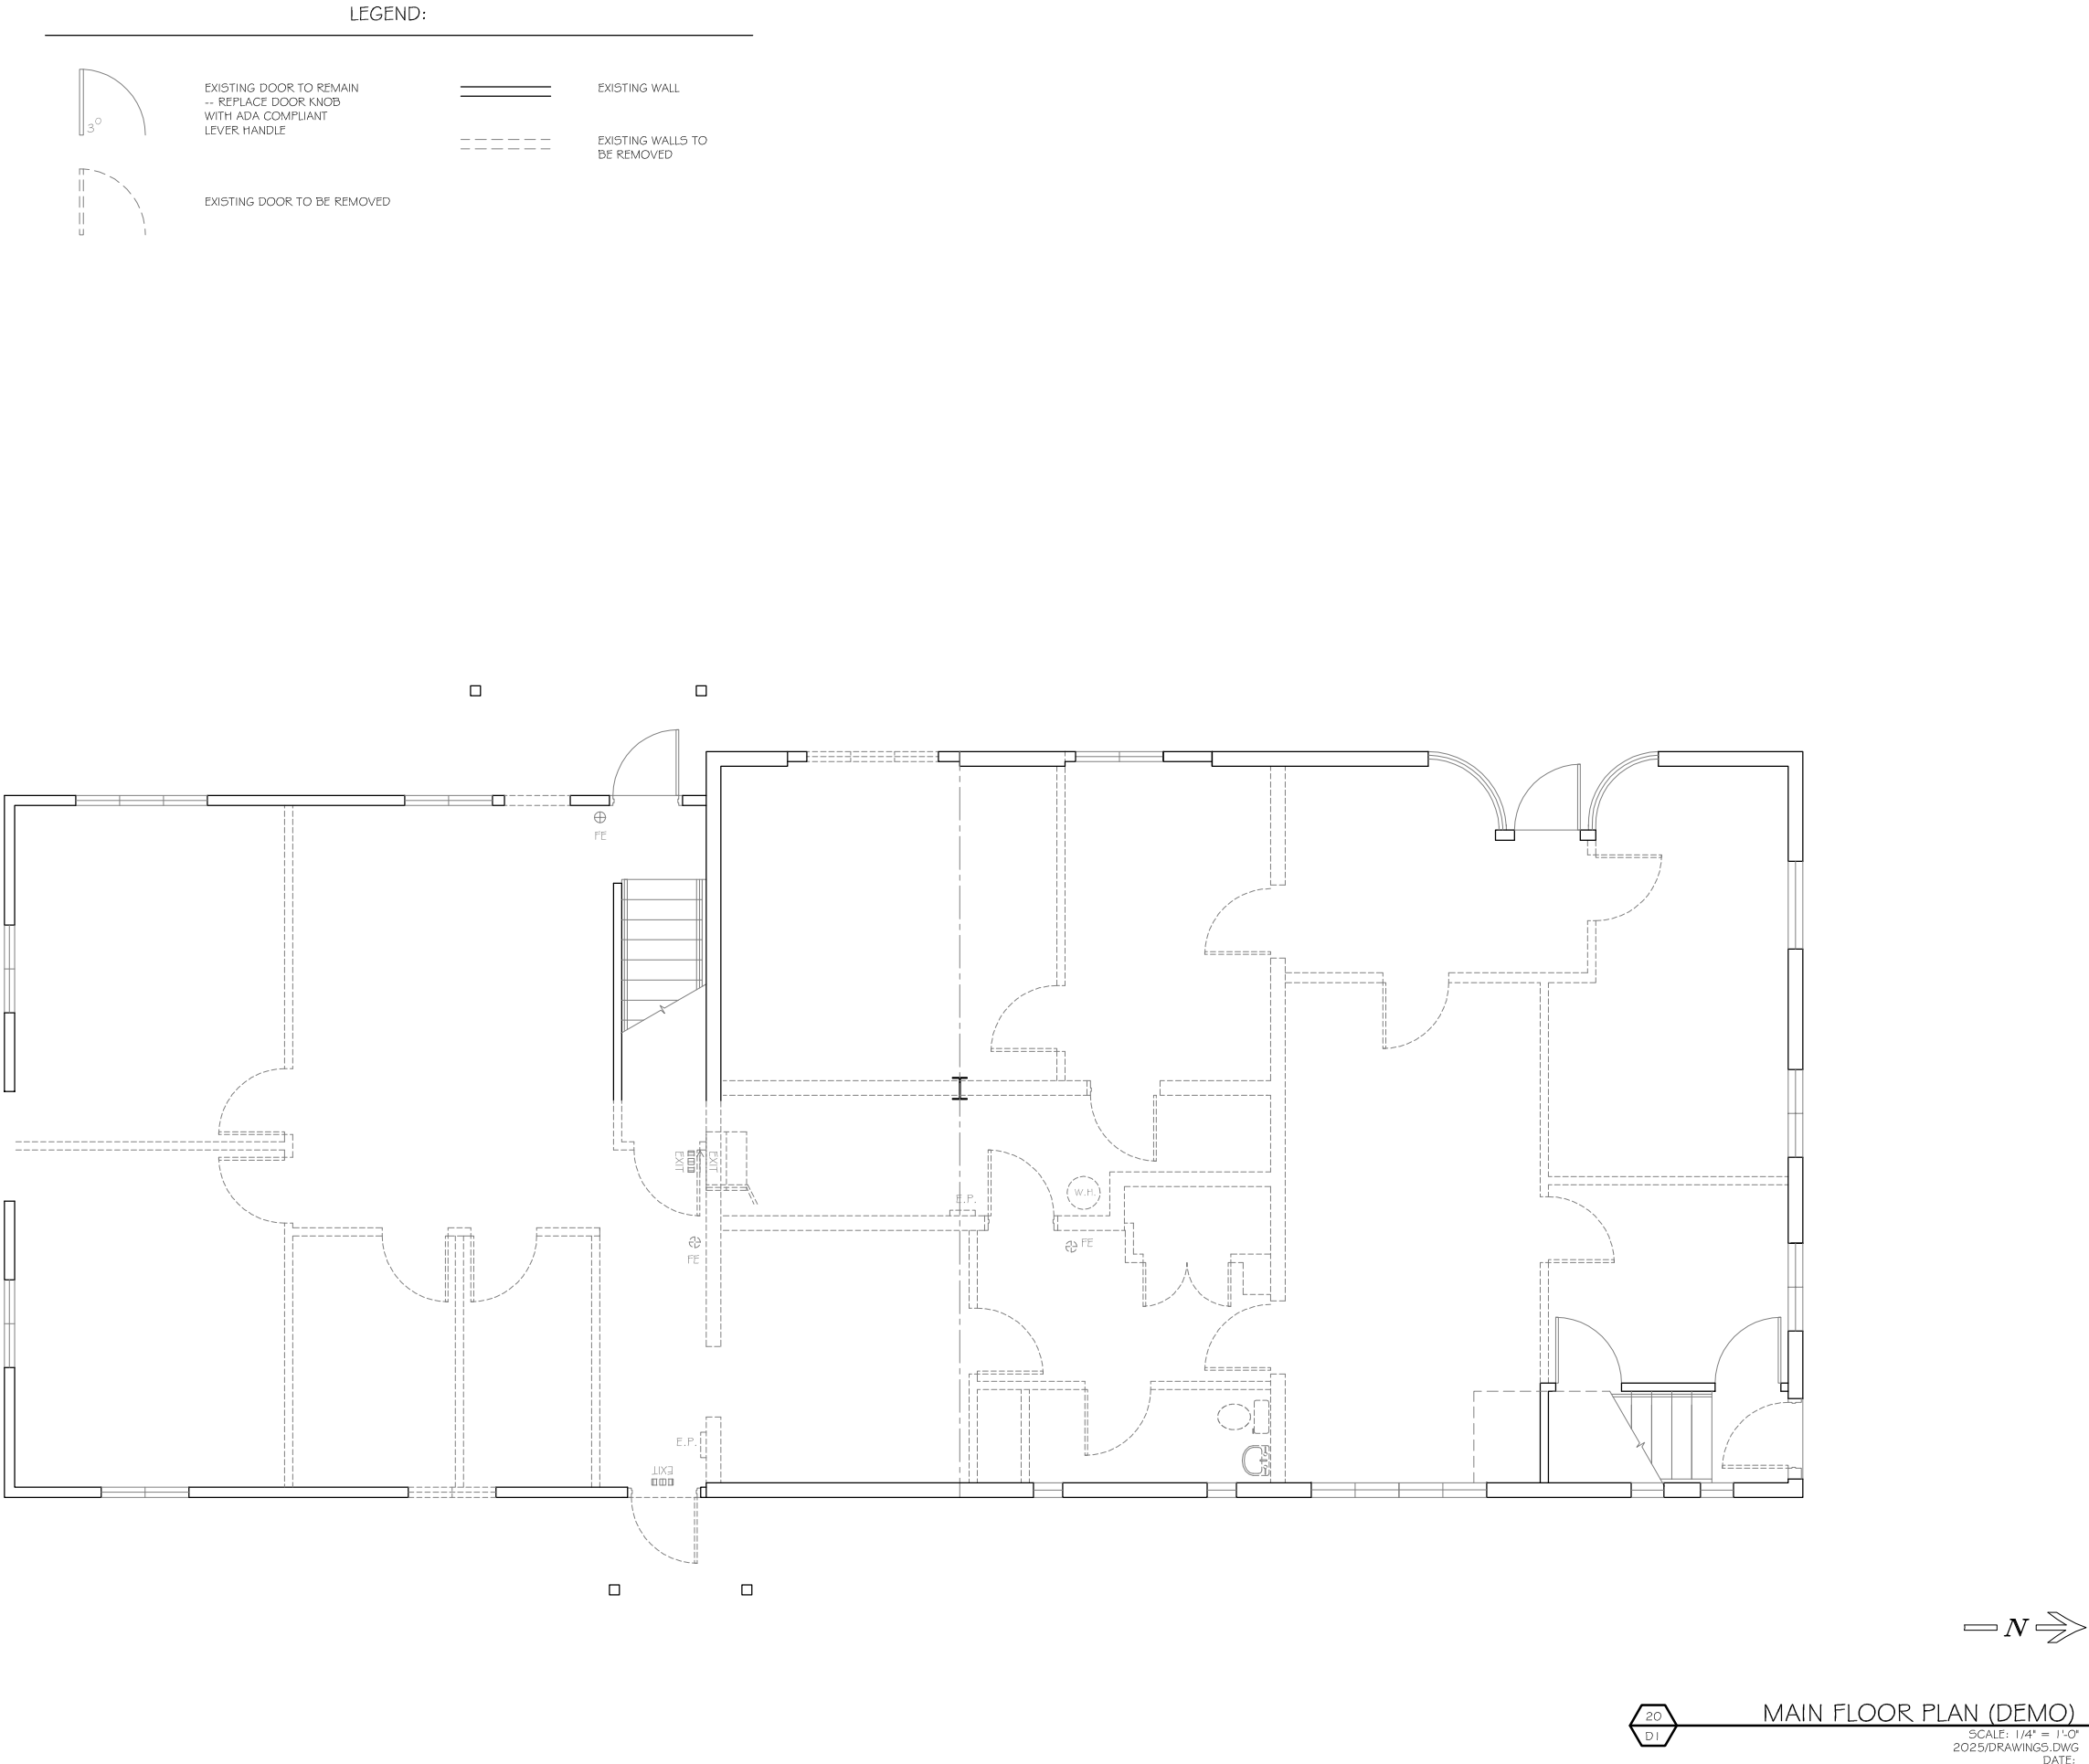

WALWORTH CO. HOUSING AUTHORITY  
MIXED-USE BUILDING  
209 South Taft Street  
Whitewater, WI 53190

DRAWING NAMES

MAIN FLOOR PLAN  
(DEMO)

REVISIONS

PROJECT DATA

DATE: 11/10/2025  
DRAWN BY: J.K.  
CHECKED BY: P.W.

SHEET NO.

D-1

Design  
Alliance  
Architects, Inc.

1003 Madison Avenue  
Fort Atkinson, WI

 

(920) 563-3404



VERIFY ALL CONDITIONS AND DIMENSIONS ON THE JOB AND NOTIFY THE DESIGN ALLIANCE ARCHITECTS, INC. OF ANY DISCREPANCIES PRIOR TO START.

ALL DRAWINGS ARE  
1/2 SCALE SHOWN

PRELIMINARY NOT  
FOR CONSTRUCTION

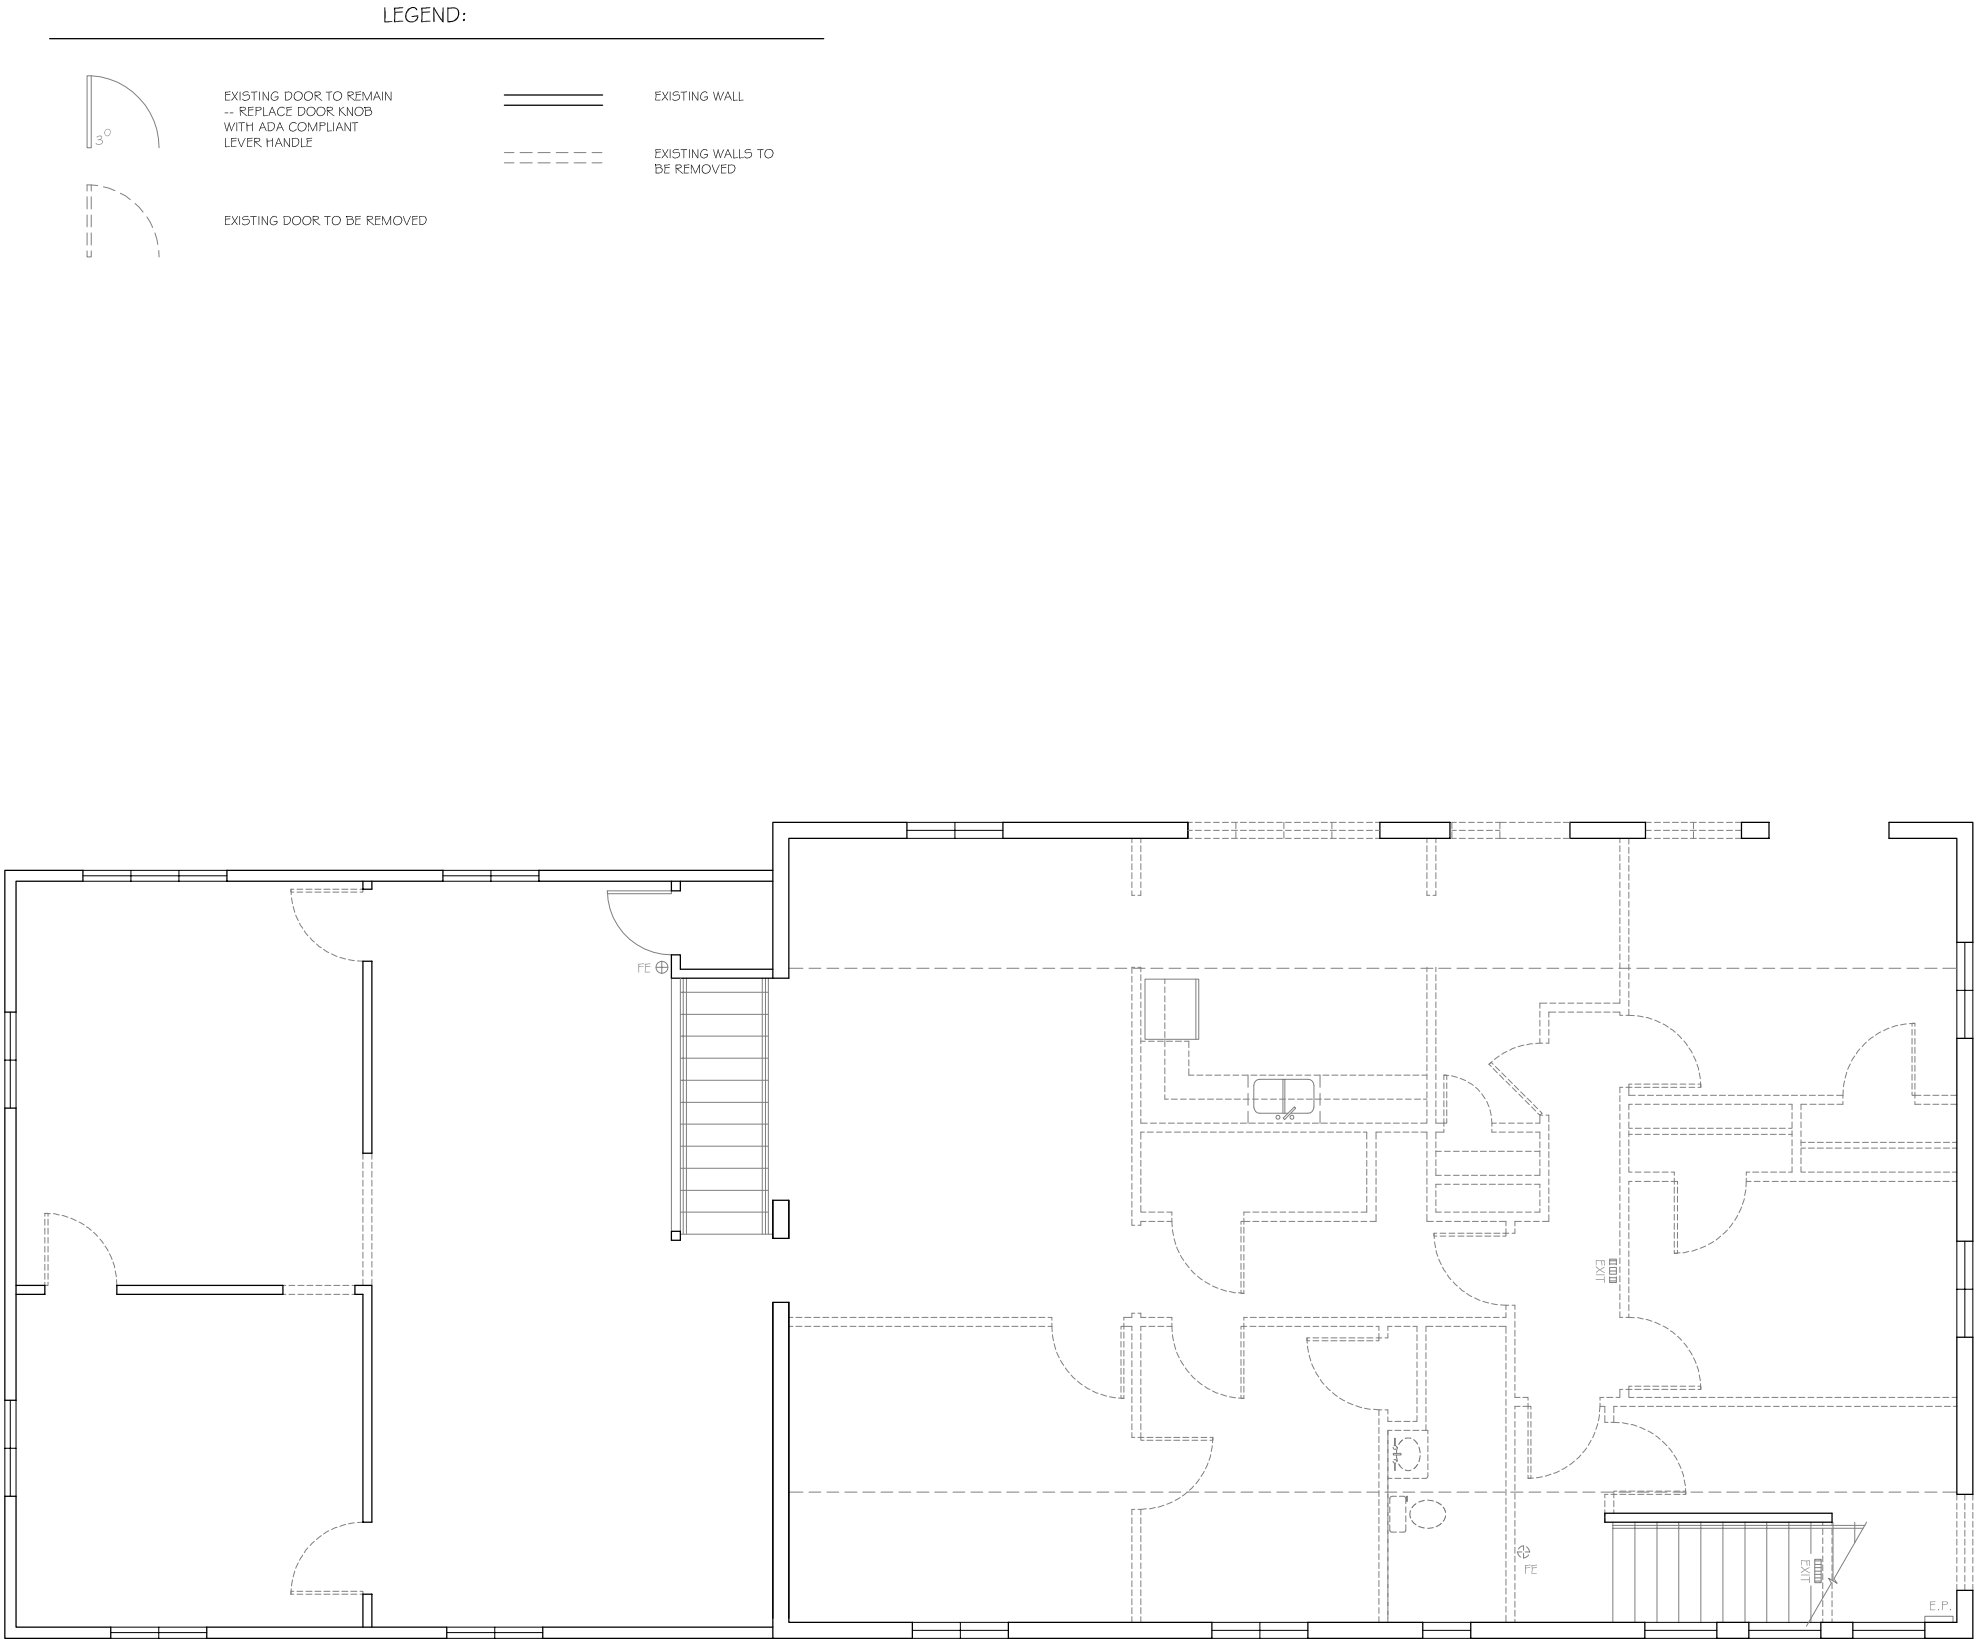

20  
D2

SECOND FLOOR PLAN (DEMO)

SCALE: 1/4" = 1'-0"  
2025/DRAWINGS.DWG  
DATE:

WALWORTH CO. HOUSING AUTHORITY  
MIXED-USE BUILDING  
209 South Taft Street  
Whitewater, WI 53190

DRAWING NAMES

SECOND FLOOR PLAN  
(DEMO)

REVISIONS

PROJECT DATA

DATE: 11/10/2025  
DRAWN BY: J.K.  
CHECKED BY: P.W.

SHEET NO.

D-2

Design  
Alliance  
Architects, Inc.

1003 Madison Avenue  
Fort Atkinson, WI

(920) 563-3404