

JOHN'S DISPOSAL

107 County Road U

Whitewater, WI 53190

DRAWING INDEX:

SP-1 SITE PLAN, DRAWING INDEX
SP-2 EXISTING SITE AERIAL PHOTO
SP-3 SITE LIGHTING PLAN
A101 MAIN FLOOR PLAN

PROJECT DESCRIPTION:

PROPOSED NEW RECYCLING BUILDING.


BUILDING INFORMATION:

CONSTRUCTION TYPE:	2B
BUILDING FOOTPRINT:	16,000 S.F.
NO. OF FLOORS:	1
OCCUPANCY GROUP:	B5-1
SPRINKLERED:	FULLY - NFPA 13
SOIL BEARING:	2,000 psf ASSUMED
BUILDING CODE:	IBC 2015
RISK CATAGORY:	TABLE 1604.5 II

VERIFY ALL CONDITIONS AND DIMENSIONS ON THE JOB AND NOTIFY THE DESIGN ALLIANCE ARCHITECTS, INC. OF ANY DISCREPANCIES PRIOR TO START.

ALL DRAWINGS ARE
1/2 SCALE SHOWN

PRELIMINARY NOT
FOR CONSTRUCTION

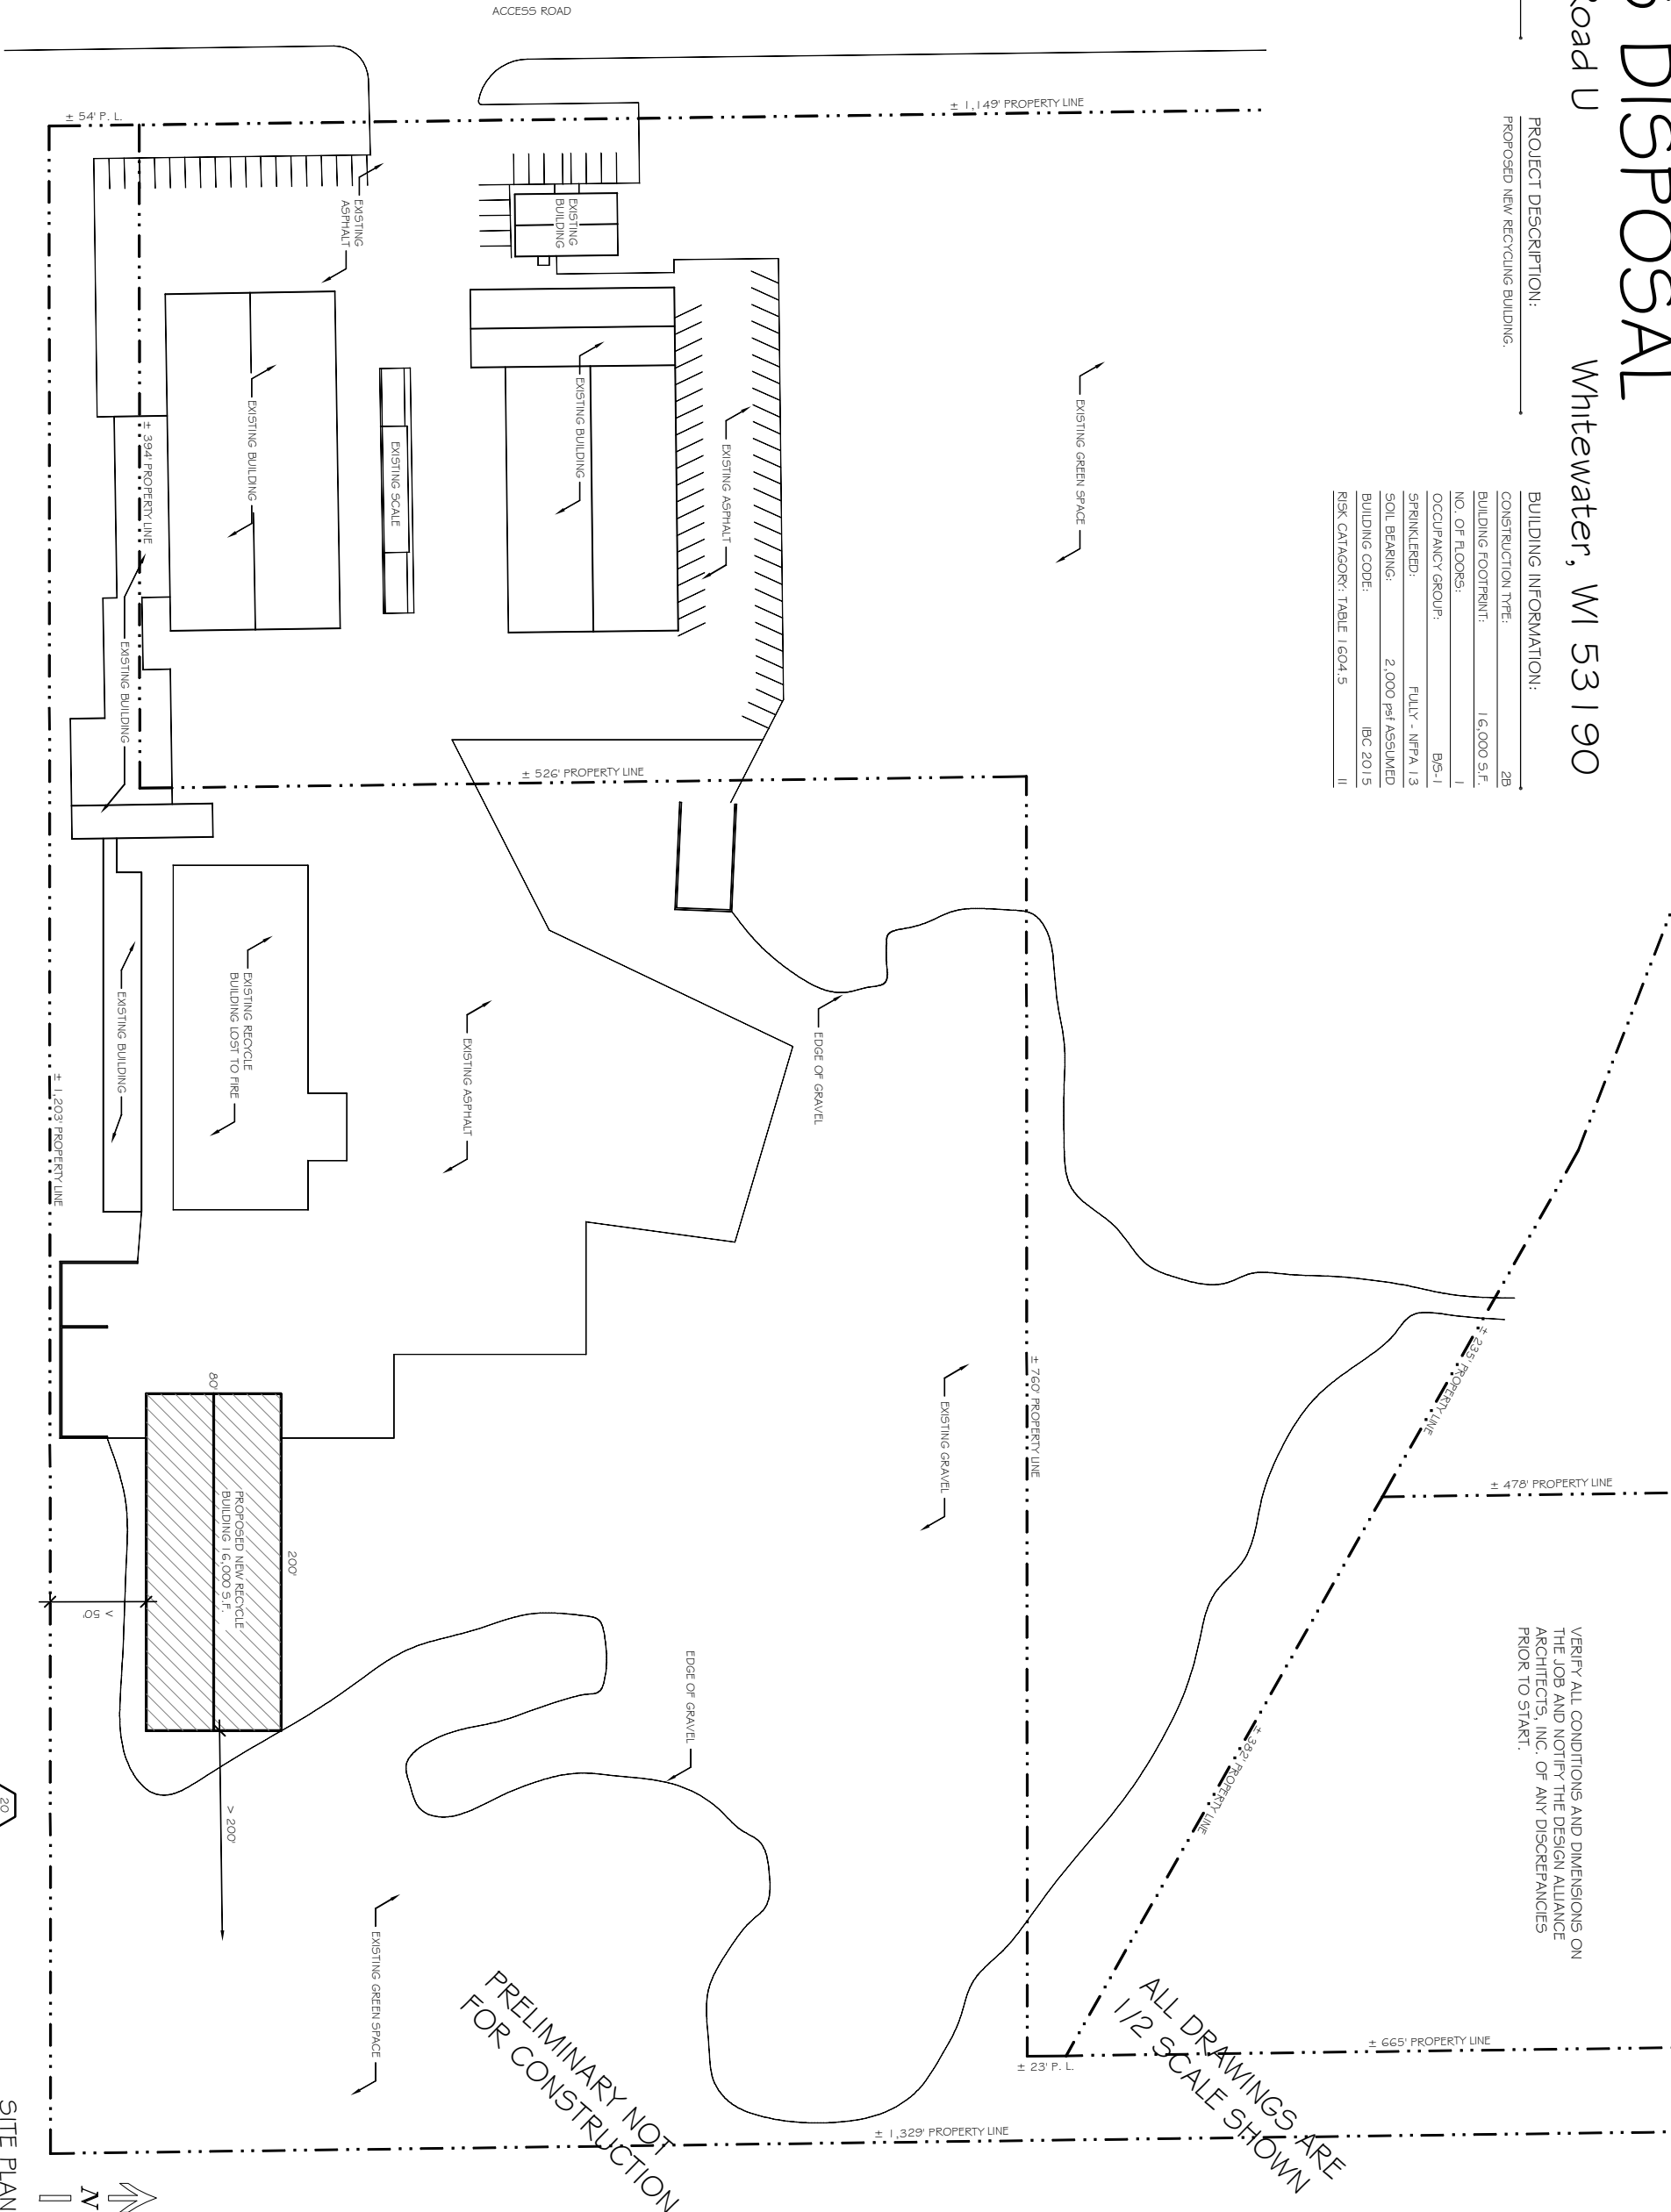

JOHN'S DISPOSAL
107 County Road U
Whitewater, WI 53190

the Design Alliance Architects, Inc.

1003 Madison Avenue
Fort Atkinson, WI

(920) 563-3404

DRAWING NAMES

SITE PLAN

DRAWING INDEX

REVISIONS

PROJECT DATA

DATE: 1/30/2025

DRAWN BY: CL

CHECKED BY: P.W.

SHEET NO.

SP-1

SITE PLAN

SCALE: 1" = 50'-0"
2025/JOHN'S DISPOSAL/DRAWINGS.DWG
DATE: JANUARY 24, 2025



VERIFY ALL CONDITIONS AND DIMENSIONS ON THE JOB AND NOTIFY THE DESIGN ALLIANCE ARCHITECTS, INC. OF ANY DISCREPANCIES PRIOR TO START.

ALL DRAWINGS ARE
1/2 SCALE SHOWN
PRELIMINARY NOT
FOR CONSTRUCTION

theDesign
Alliance
Architects, Inc.

1003 Madison Avenue
Fort Atkinson, WI (920) 563-3404

JOHN'S DISPOSAL
107 County Road U
Whitewater, WI 53190

DRAWING NAMES
SITE AERIAL PHOTO

REVISIONS

PROJECT DATA

DATE: 1/30/2025

DRAWN BY: CL

CHECKED BY: P.W.

SHEET NO.

SP-2

EXISTING SITE AERIAL PHOTO

20
SP2

SCALE: 1" = 50.0'

202510HN5 DISPOSAL.DWG
DATE: JANUARY 24, 2025

JEFFERSON COUNTY GIS



JOHN'S DISPOSAL
107 County Road U
Whitewater, WI 53190


Designer
CL
Date
01/27/2025
Scale
Not to Scale
Revision No.

Summary


SITE LIGHTING PLAN

Scale: N.T.S.

Date: 1/27/2025

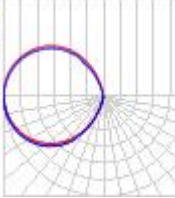Schedule											
Symbol	Label	Image	QTY	Manufacturer	Catalog	Description	Number Lamps	Lamp Output	LLF	Input Power	Polar Plot
	A		4	Lithonia Lighting	ESXF5 ALO SSW2 XVOLT YS DDB 50K 340W	Architectural Flood and Spot Luminaires	1	49655	0.87	334.14	

Statistics				
Description	Symbol	Avg	Max	Min
Calc Zone #2	+	2.5 fc	40.0 fc	0.2 fc
			200.0:1	12.5:1

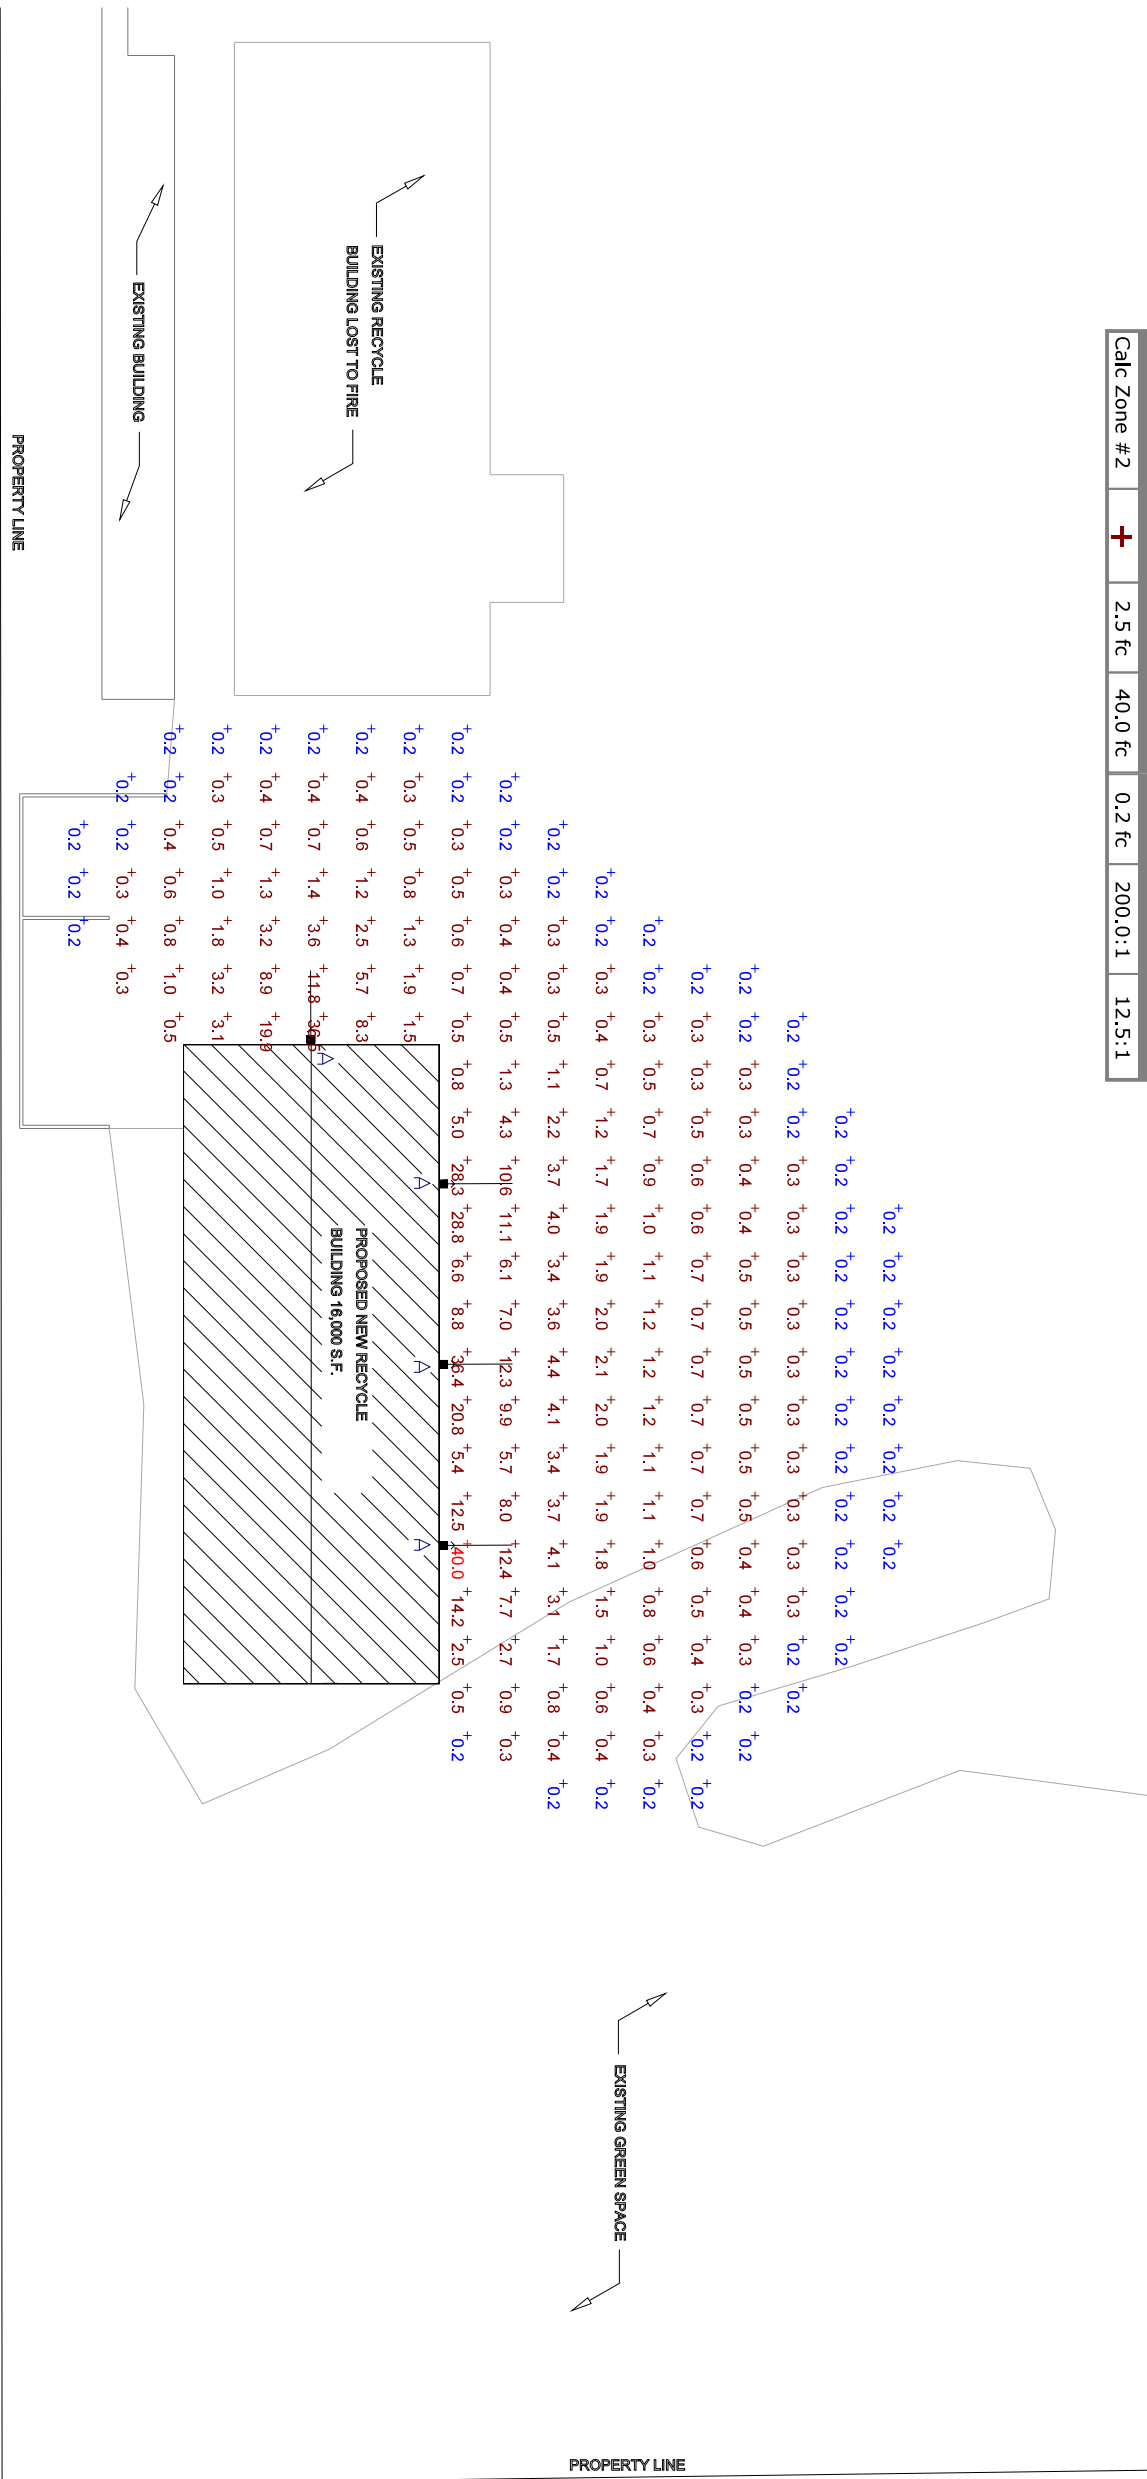

SP-3

WISCONSIN
 RYAN D. FENNEL
 A-132345
 HATFIELD, PA
 ARCHITECT

RYAN D. FENNELL, AIA
W/LC. NO. A-13234-5

107 COUNTY ROAD U
WHITEWATER, WI 53190

24-09-11

DRAWING NO.

A101