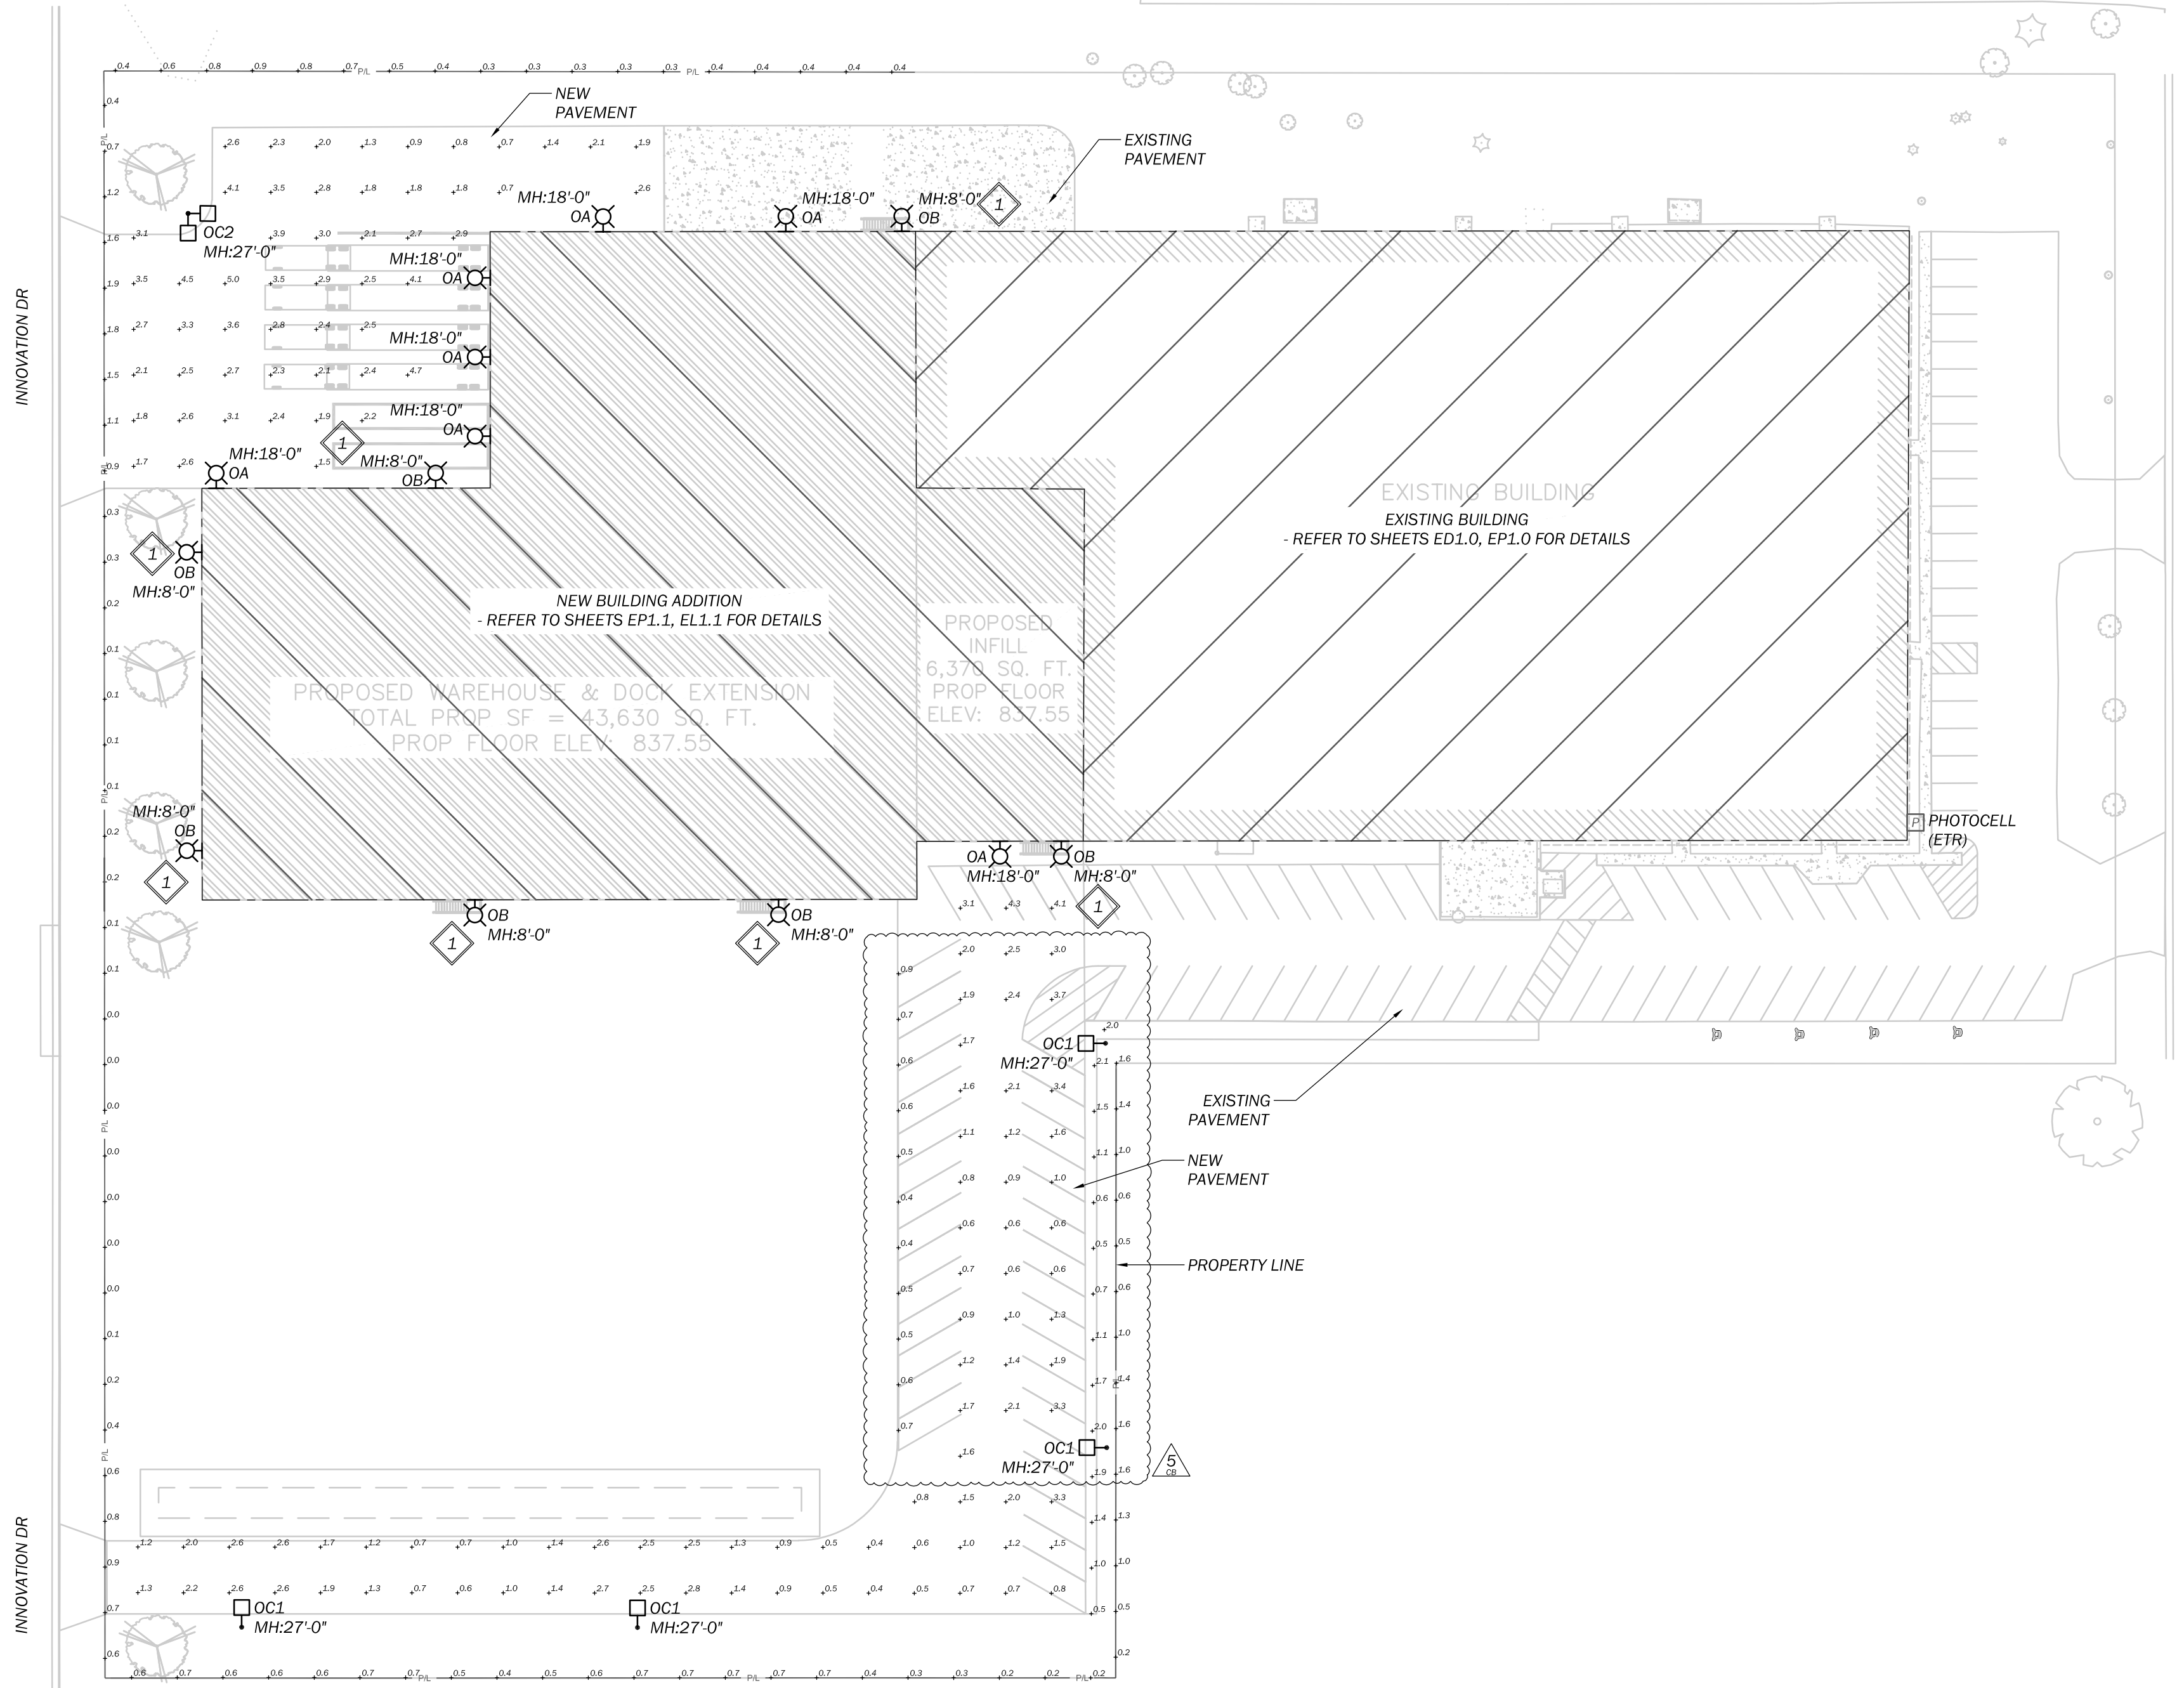


| ABBREVIATIONS |                      |      |                 |
|---------------|----------------------|------|-----------------|
| AFF           | ABOVE FINISHED FLOOR | JBOX | JUNCTION BOX    |
| AFG           | ABOVE FINISHED GRADE | LIG  | LIGHTING        |
| BLDG          | BUILDING             | MH   | MOUNTING HEIGHT |
| CB            | CIRCUIT BREAKER      | NTS  | NOT TO SCALE    |
| CKT           | CIRCUIT              | PNL  | PANELBOARD      |
| DWG           | DRAWING              | TYP  | TYPICAL         |
| ETR           | EXPOSED TO REMAIN    | UG   | UNDERGROUND     |
| GND           | GROUND               | WP   | WEATHERPROOF    |
| FDR           | FEEDER               | XFMR | TRANSFORMER     |

ADDRESS: 1215 UNIVERSAL BLVD  
WHITEWATER, WI 53190

PERMIT  
PLANS[illegible]

## SITE LIGHTING AND PHOTOMETRICS

SHEET NO.

*ES-1.0P*

| SITE LIGHTING FIXTURE SCHEDULE |                                                                               |            |--------------------------------|-------------------------------------------------------------------------------|------------|---------------|------|----------------|------------------|-----------|----------|-----------------|------------------------------------------------------------------------------------------------------------------------------------------|-------|-------------|--|--|-------------------|--|--|----------------|--|--|-------------------|--|--|
| ABBREVIATIONS:                 |                                                                               |            | D = DRIVER                     |                                                                               |            | DW = DRYWALL  |      |                | ET = ELECTRONIC  |           |          | MG = MAGNETIC   |                                                                                                                                          |       | R = RECESS  |  |  | S = SURFACE       |  |  | SP = SUSPENDED |  |  | V = VARIES        |  |  |
| DM = DIMMING                   |                                                                               |            | E = EXPOSED   |      |                | LG = LAY-IN GRID |           |          | OT = OTHER      |                                                                                                                                          |       | RM = REMOTE |  |  | SD = STEP DIMMING |  |  | ST = STANDARD  |  |  | WM = WALL MOUNTED |  |  |
| DWG ID                         | DESCRIPTION                                                                   | LAMPS/LEDS |               |      | BALLAST/DRIVER |                  |           | MOUNTING | FIXTURE VOLTAGE | MANUFACTURER PART NUMBER                                                                                                                 | NOTES |             |  |  |                   |  |  |                |  |  |                   |  |  |
|                                |                                                                               | TYPE       | LUMENS        | K    | WATTS          | TYPE             | NO.       |          |                 |                                                                                                                                          |       |             |  |  |                   |  |  |                |  |  |                   |  |  |
| 0A                             | OUTDOOR WALL PACK FIXTURE                                                     | LED        | 7500          | 4000 | 56             | D                | 1         | WM       | 120/277         | CURRENT LIGHTING EWAS-01-0-C3-AW-7-40-D-1-FM-DKBZ<br>OR APPROVED EQUIVALENT                                                              |       |             |  |  |                   |  |  |                |  |  |                   |  |  |
| 0B                             | OUTDOOR WALL PACK EMERGENCY EGRESS FIXTURE<br>WITH COLD WEATHER RATED BATTERY | LED        | 2500          | 4000 | 37             | D                | 1         | WM       | 120/277         | H.E. WILLIAMS WPHP-L30-7-40-TFT-DBZSDGLM-10WC<br>OR APPROVED EQUIVALENT                                                                  |       |             |  |  |                   |  |  |                |  |  |                   |  |  |
| OC1                            | OUTDOOR POLE-MOUNTED FIXTURE - SINGLE                                         | LED        | 15000         | 4000 | 123            | D                | 1         | POLE     | 120/277         | CURRENT LIGHTING EALS-04-0-F4-AF-7-40-E-D1-DKBZ<br>+ GENERAL STRUCTURES CPA-1-6018-25-AB-D1-DB-VD    OR APPROVED EQUIVALENT              |       |             |  |  |                   |  |  |                |  |  |                   |  |  |
| OC2                            | OUTDOOR POLE-MOUNTED FIXTURES - DUAL 90deg                                    | LED        | (2x)<br>15000 | 4000 | (2x)<br>123    | D                | (2x)<br>1 | POLE     | 120/277         | (2x) CURRENT LIGHTING EALS-04-0-F4-AF-7-40-E-D1-DKBZ<br>+ (1x) GENERAL STRUCTURES CPA-1-6018-25-AB-D2@90-DB-VD    OR APPROVED EQUIVALENT |       |             |  |  |                   |  |  |                |  |  |                   |  |  |
| SCHEDULE NOTES:                |                                                                               |            | 1                              |                                                                               |            