

Revisions	By	Date
MECHANICAL DESIGN	AIS DN	17 MAY 02
SIGN DEVELOPMENT	AIS DN	20 12 02
CONSTRUCTION DOCUMENTS	AIS DN	21 03 01
CHECK SET	AIS SD	21 04 09
PLAN	AIS ME	21 08 09
CONSTRUCTION DOCUMENTS	AIS ME	21 08 09

Client/Project	NORTH TEXAS MUNICIPAL WATER DISTRICT
	REGIONAL WATER SYSTEMS MAINTENANCE, PHASE II
	CITY OF WYLLIE, COLLIN COUNTY, TEXAS
Title	SITE PLAN 1


Permit-Seal
 FOR REVIEW ONLY
 Not for Construction or Permit Purpose

 PAUL M. HAMES
 Engineer
 P.E. No. 64791 Date 03-27-2021
 Project Number: 214000865

File Name:	C0865_710_dlm.dwg		
JG	JGW	JGW	21.07.30
Don	Chad	Don	YVAMDO

Drawing No.

Revision	Sheet
---	1 of 4

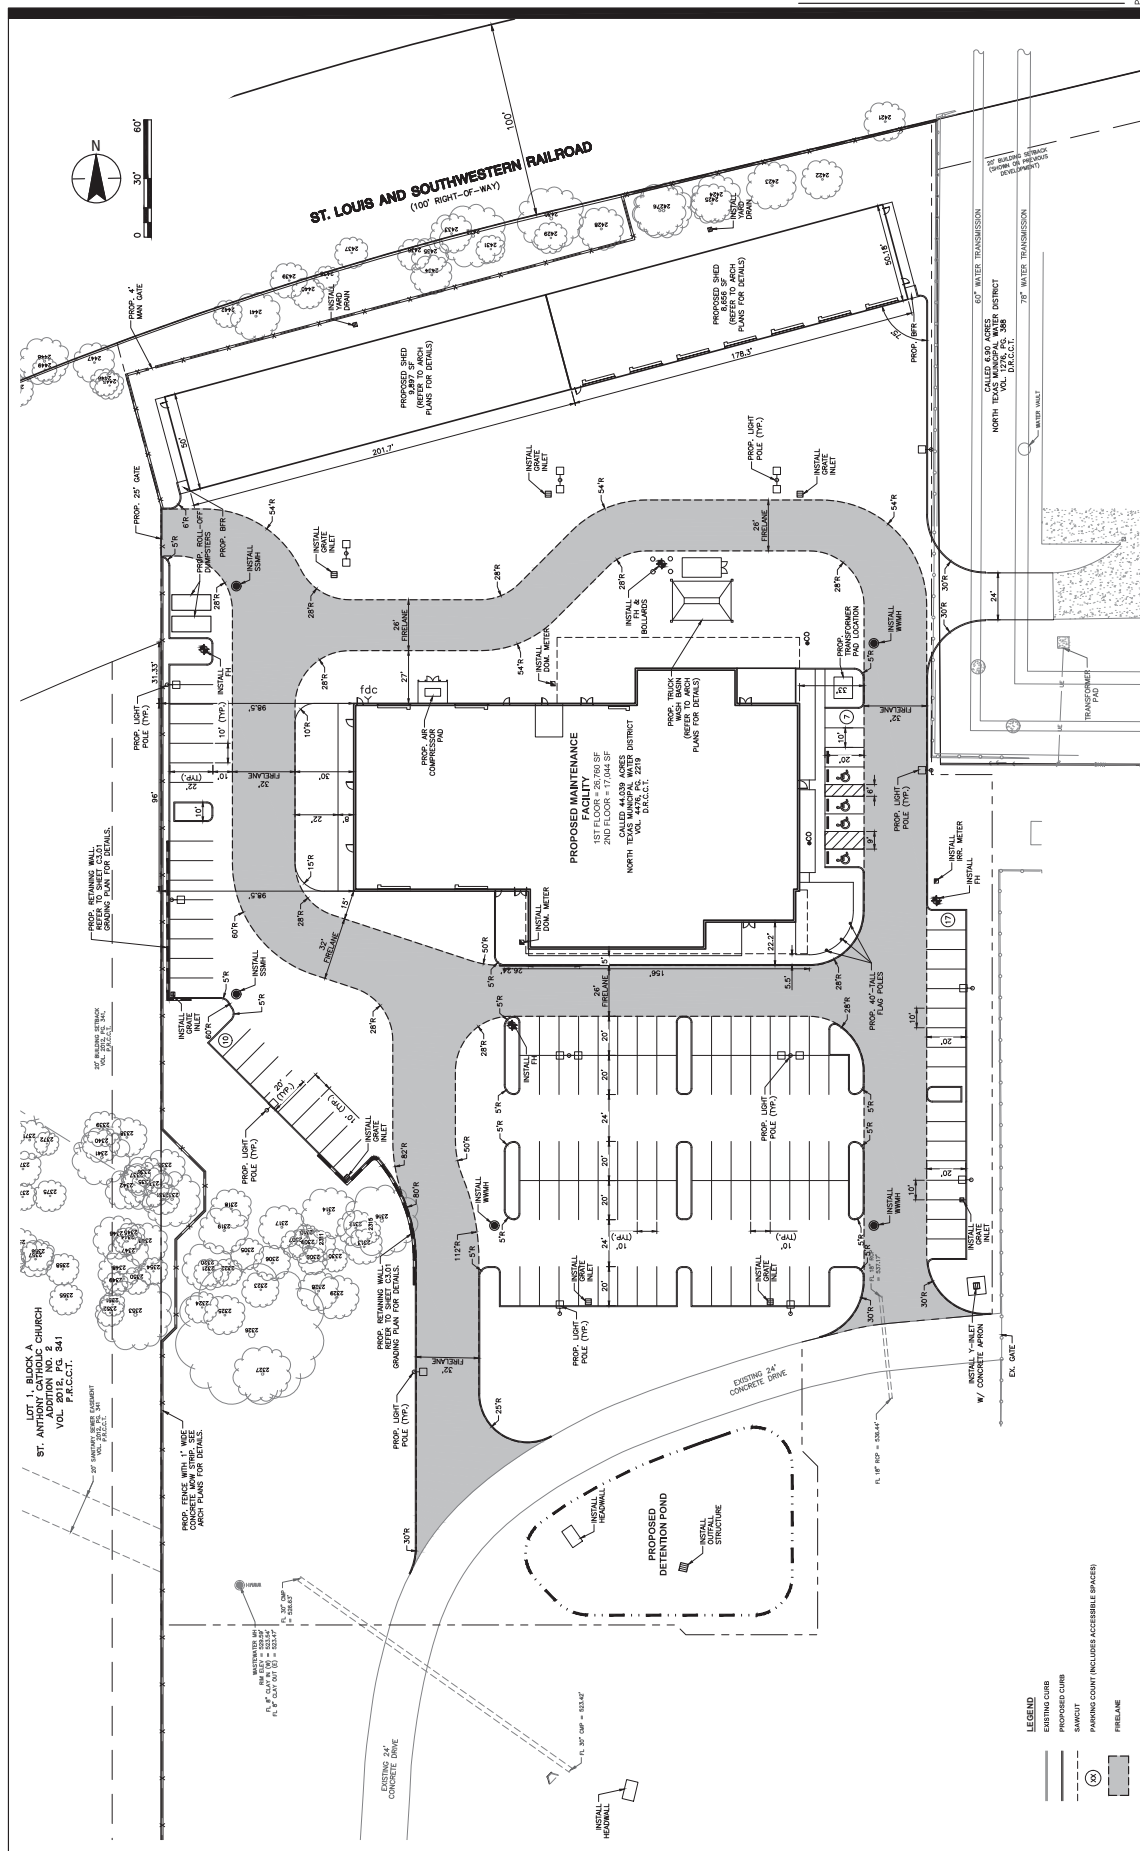

NOTES:

1. REFER TO DRAWING NO. CURB & GABT FOR GENERAL PROJECT NOTES & LEGEND.
2. PRIOR TO BEGINNING STAKING OF BUILDING LOCATION, THE EXISTING CURB & GABT SHALL MATCH NOTIFY STRUCTURAL AND CIVIL DISCREPANCY MATCH. NOTIFY DESIGNER OF ANY DISCREPANCY.
3. THE EXISTING CURB & GABT SHALL BE TO FACE OF CURB UNLESS OTHERWISE NOTED.
4. ALL CURB RADIUS SHALL BE 3' TO PLACE OF CURB UNLESS OTHERWISE NOTED.
5. PROVIDE ARCHITECTURAL PLANS FOR EXACT BUILDING DIMENSIONS.
6. REFER TO SITE LIGHTING PLANS FOR EXACT LIGHTING DIMENSIONS.
7. ALL SITE WORK FOR THIS PROJECT SHALL MEET OR EXCEED THE SPECIFICATIONS OF THE RELEVANT UTILITY AGENCIES.
8. PROVIDE SPECIFICATIONS FOR THE CONSTRUCTION OF EXISTING IMPROVEMENTS WHICH ARE BEING ALTERED OR REPLACED.

CAUTION !!

CONTRACTOR IS TO CONTACT TEXAS ONE-CALL SYSTEM (1-800-245-4345) OR OTHER UTILITY LOCATING SERVICES AT LEAST 48 HOURS PRIOR TO CONSTRUCTION ACTIVITIES. STATEC IS NOT RESPONSIBLE FOR ANY DAMAGE TO EXISTING UTILITIES IN THE PROJECT AREA NOR FOR DETERMINING THE EXACT LOCATIONS OF UTILITIES ON THESE DRAWINGS.

Revisions	By	Approved	Issued
REVISION 001	MS	21.08.13	
REVISION 002	MS	21.08.13	
REVISION 003	MS	21.08.13	
REVISION 089	MS	21.08.13	
REVISION 090	MS	21.08.13	</

Client/Project	NORTH TEXAS MUNICIPAL WATER DISTRICT
	REGIONAL WATER SYSTEMS MAINTENANCE, PHASE II
	CITY OF WYLLIE, COLLIN COUNTY, TEXAS
Title	SITE PLAN 2

Permit-Seal

FOR REVIEW ONLY
Not for Construction or Permit Purpose

Stantec
PAUL M. HAMES


P.E. No. 66791 Date 08-27-2021

Engineer

Project Number: 21400865	
File Name: 00865_sls_drawing	
JG	JGW
Dwn	Cdtd
21.07.30	Y1AMA.D0

Drawing No.

Revision	Sheet
---	2 of 4

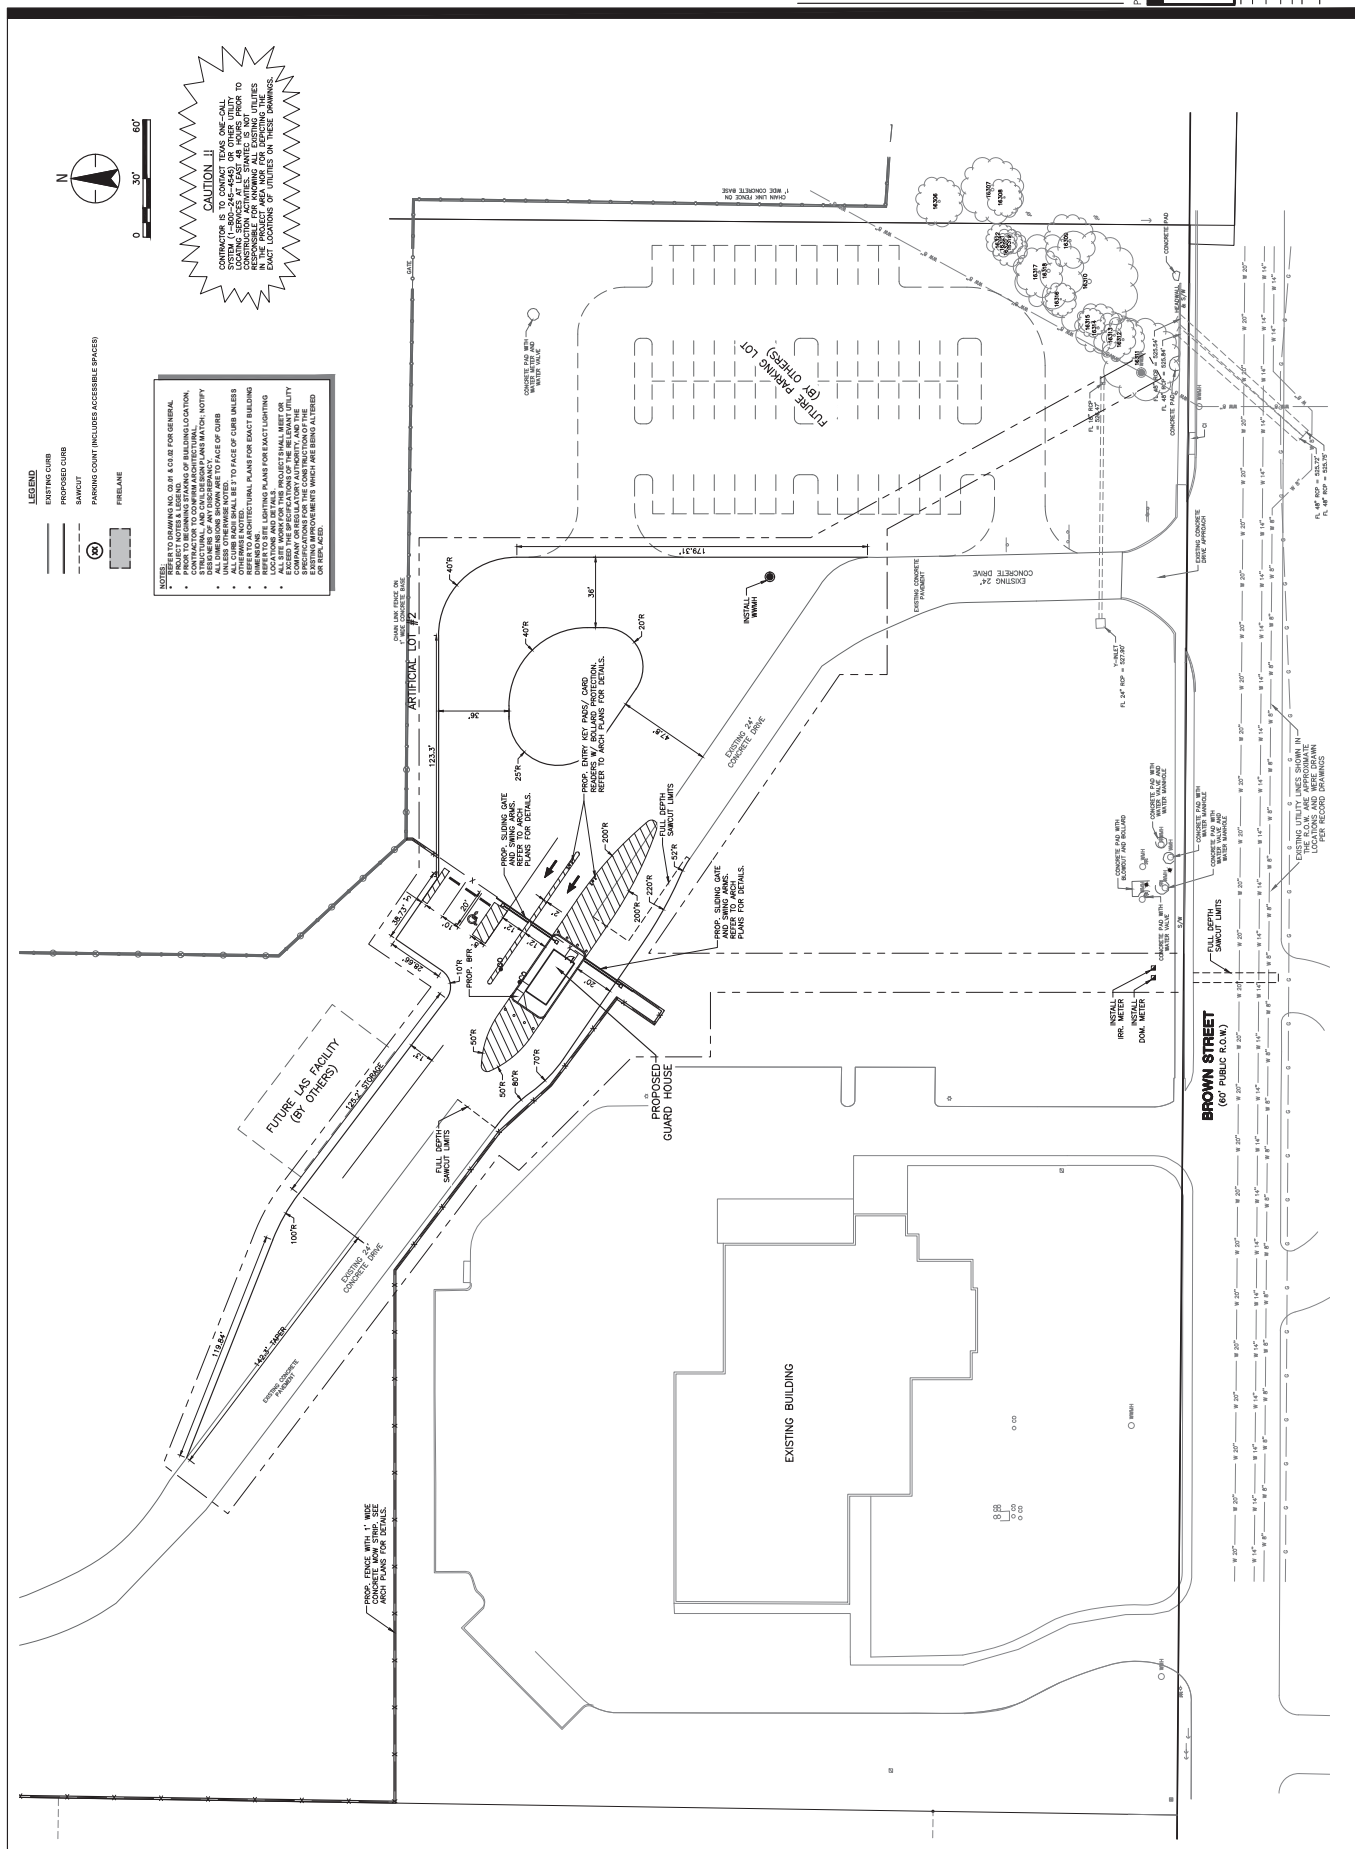

Revised	By	Date
CONSTRUCTION DOCUMENTS	AJS	21.08.13
95% PLAN	AJS	21.08.09
75% CHECK SET	AJS	21.04.09
50% CONSTRUCTION DOCUMENTS	AJS	21.03.01
DESIGN DEVELOPMENT	AJS	20.12.22
SCHMIDT DESIGN	NH	20.10.22

Client/Project
NORTH TEXAS MUNICIPAL WATER DISTRICT
CITY OF WYLLIE, COLLIN COUNTY, TEXAS
UTILITY & DRAINAGE PLAN 2

FOR REVIEW ONLY
Not for Construction or Permit Purposes

Stantec
Engineer
PAUL M. HAMES
P.E. No. 64791 Date 04.27.02


Project Number: 21400865

File Name: 00845_rfc_wmp.dwg					
JO	JGW	JGW	21.07.30		
Dwn	Chkd	Dgn	YAMA.DG		

Drawing No.

Revision	Sheet
----------	-------

4 of 4

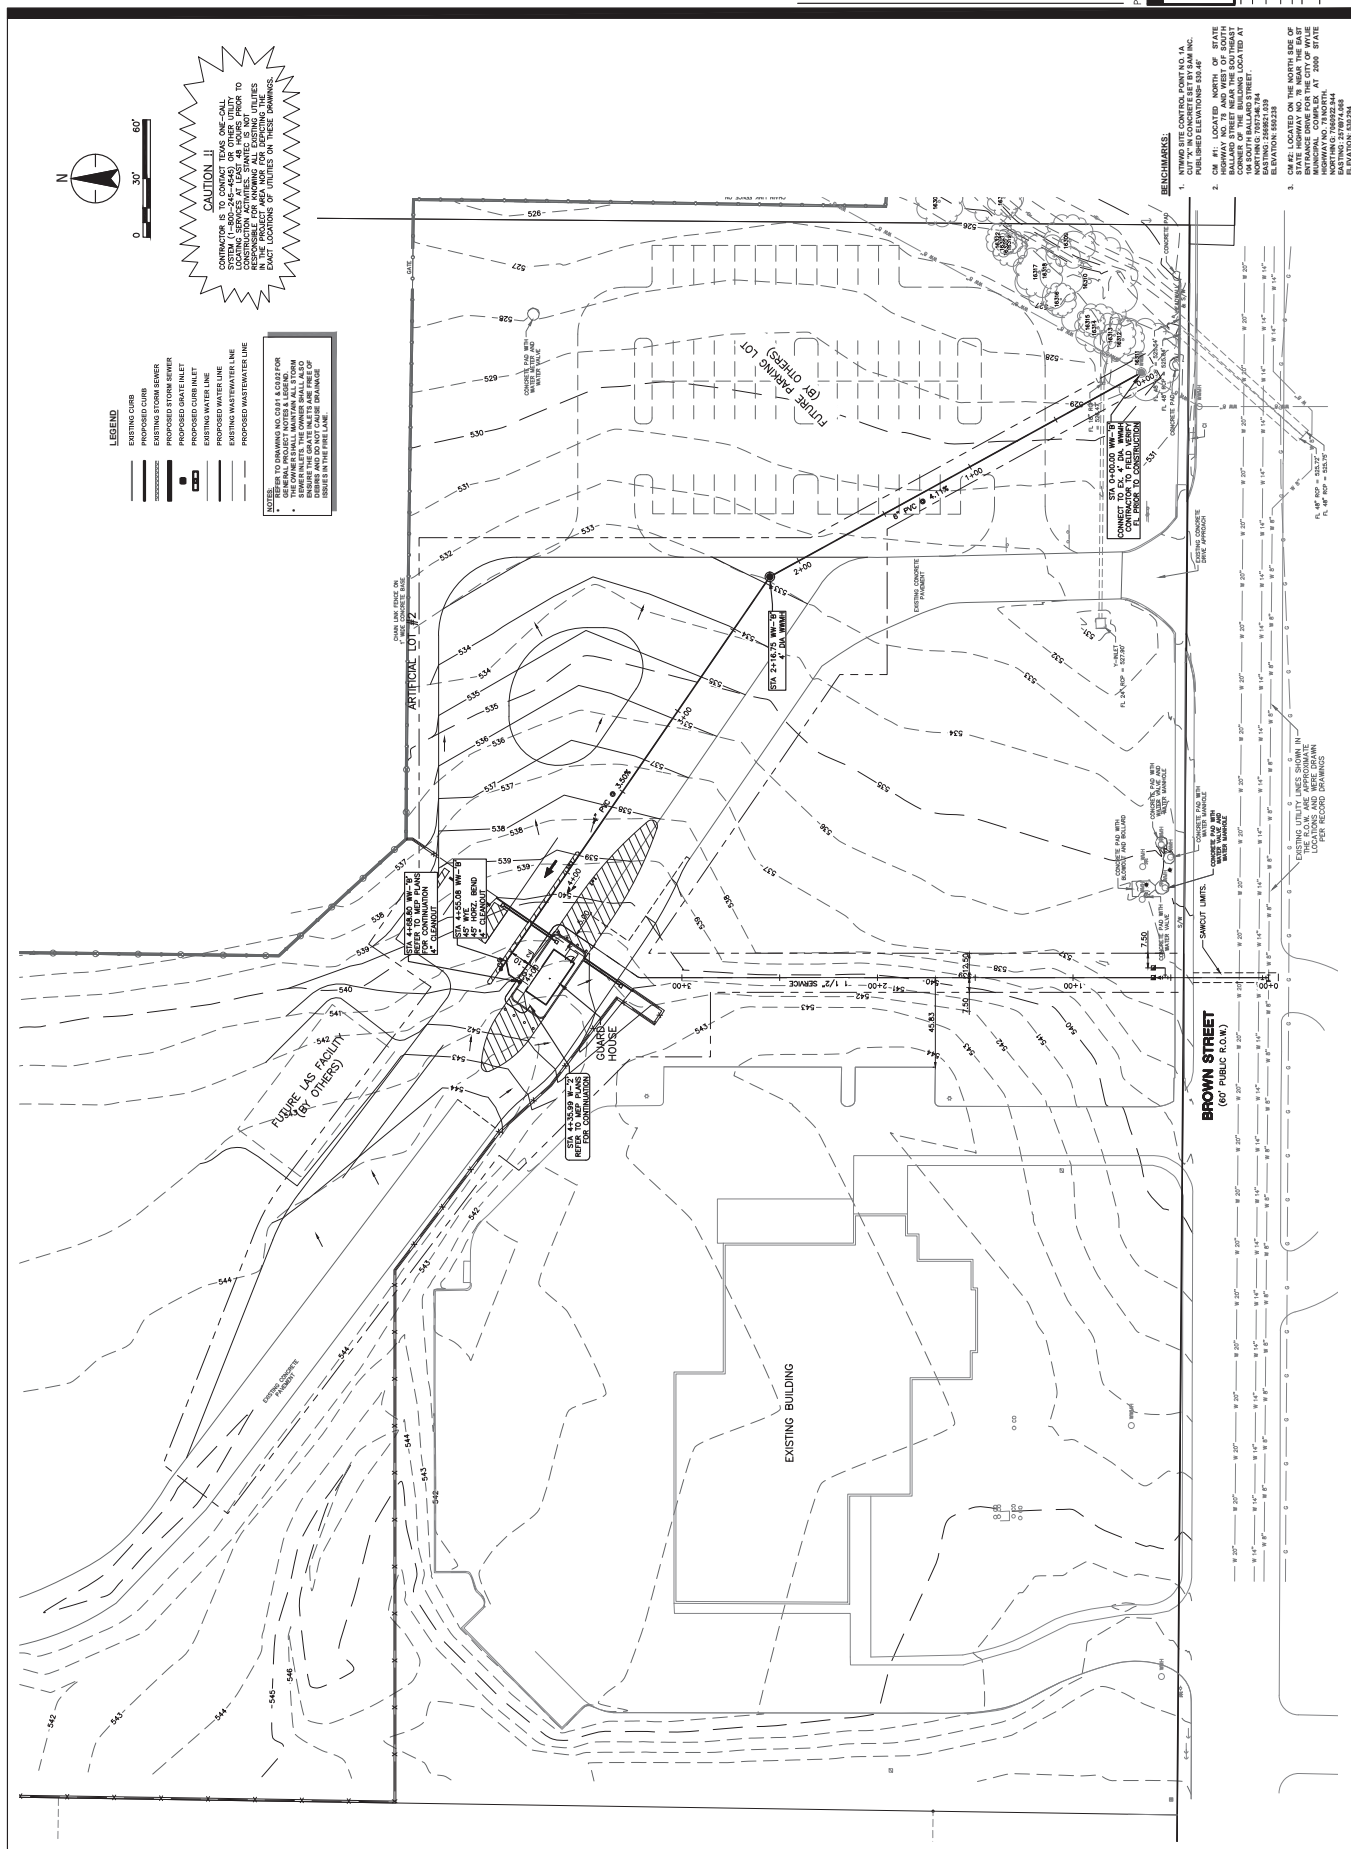



TREE LIST

[illegible]

[illegible]

City of Wylie, Collin County, Texas
Landscape Plan


NOT FOR REGULATORY
APPROVAL, PERMITTING,
OR CONSTRUCTION

Project Number: 21400865	
Ho Name:	
MY	CY
21.08.27	
Don	Cred
YYMMDD	Days

Revision Sheet 2 of 6 L1.02



80
40
120

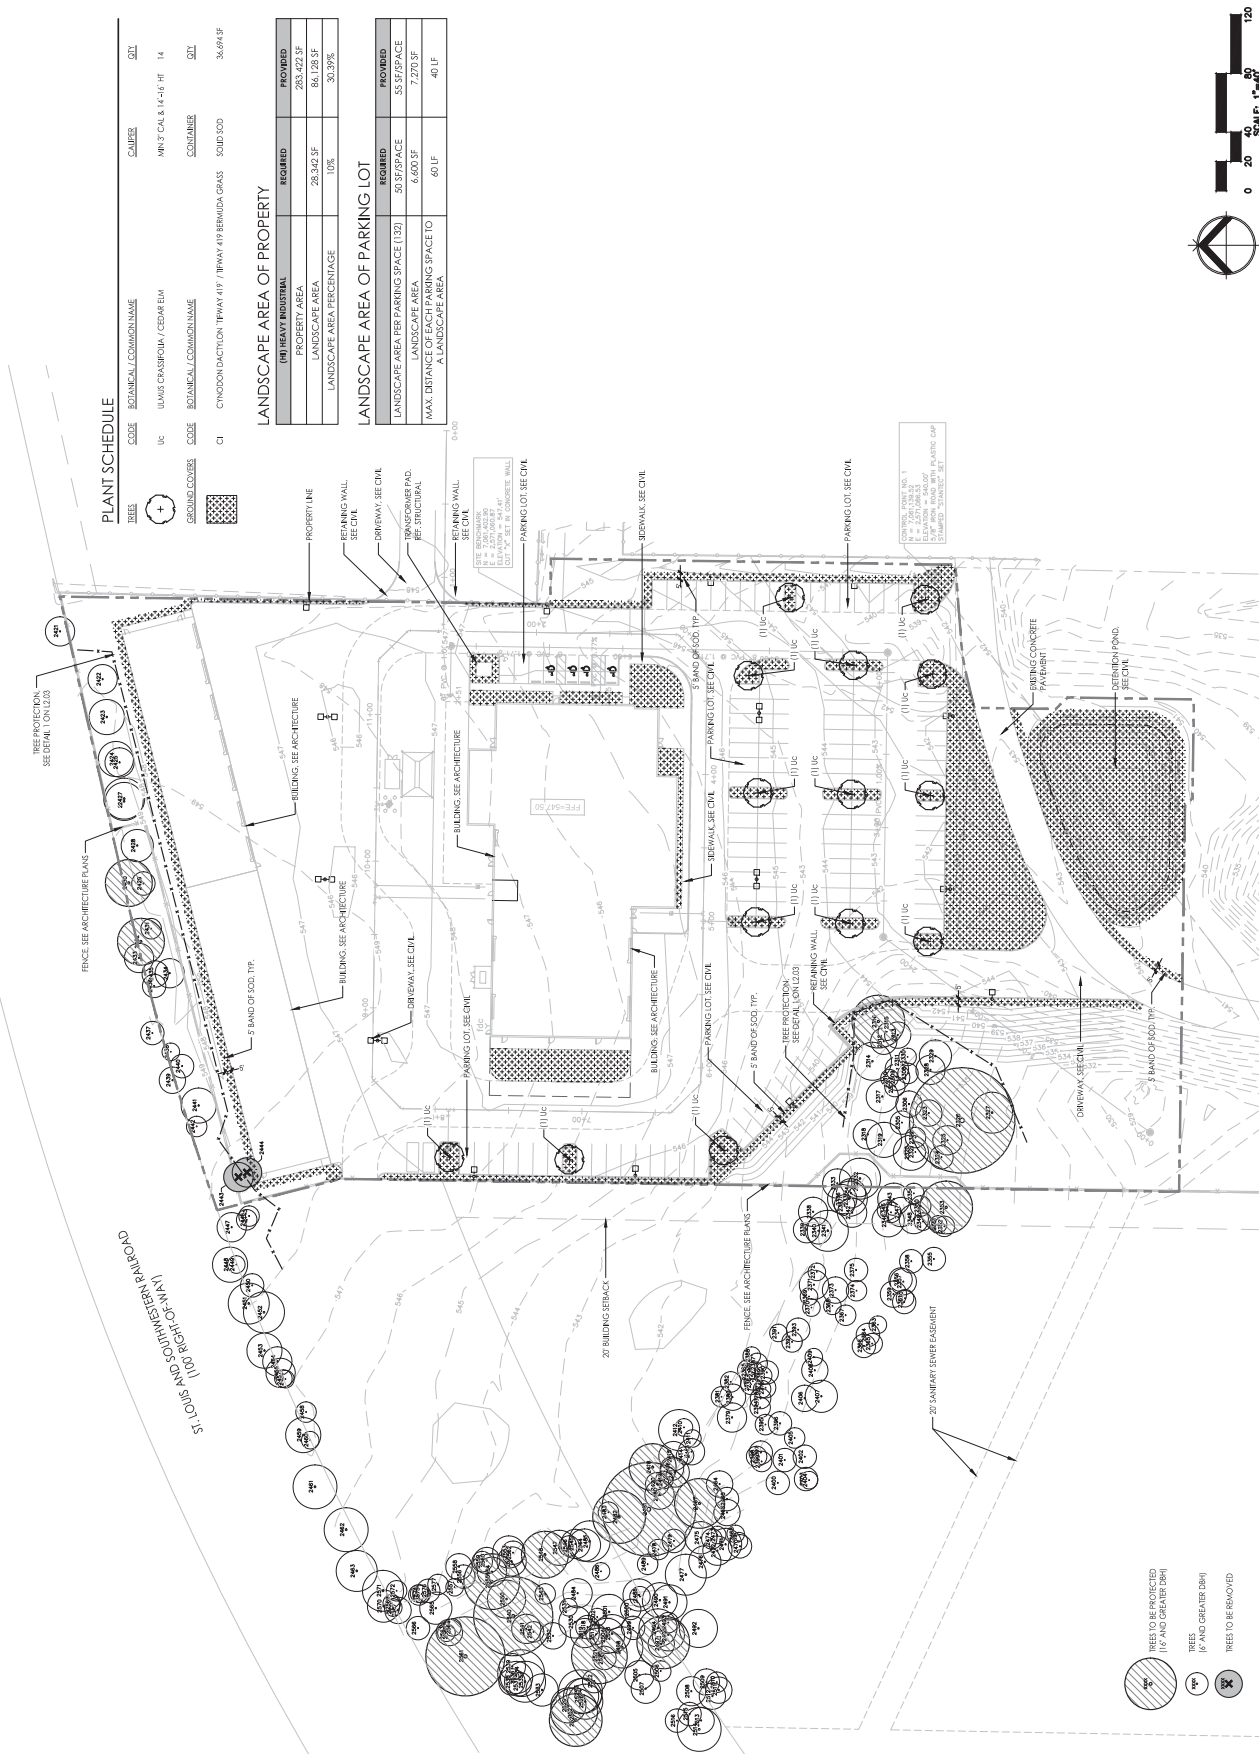

TREES TO BE PROTECTED
[16" AND GREATER DBH]

TREES
[6" AND GREATER DBH]

TREES TO BE REMOVED

[illegible]

City of Wylie, Collin County, Texas
Landscape Plan

Permit-Seal


NOT FOR REGULATORY
APPROVAL, PERMITTING,
OR CONSTRUCTION

Project Number: 21400865	
To: Name:	
MY	CY
Date: 21.08.27	Doc: YYMMDD
Drawing No. L103	

Revision Sheet
3 of 6



2

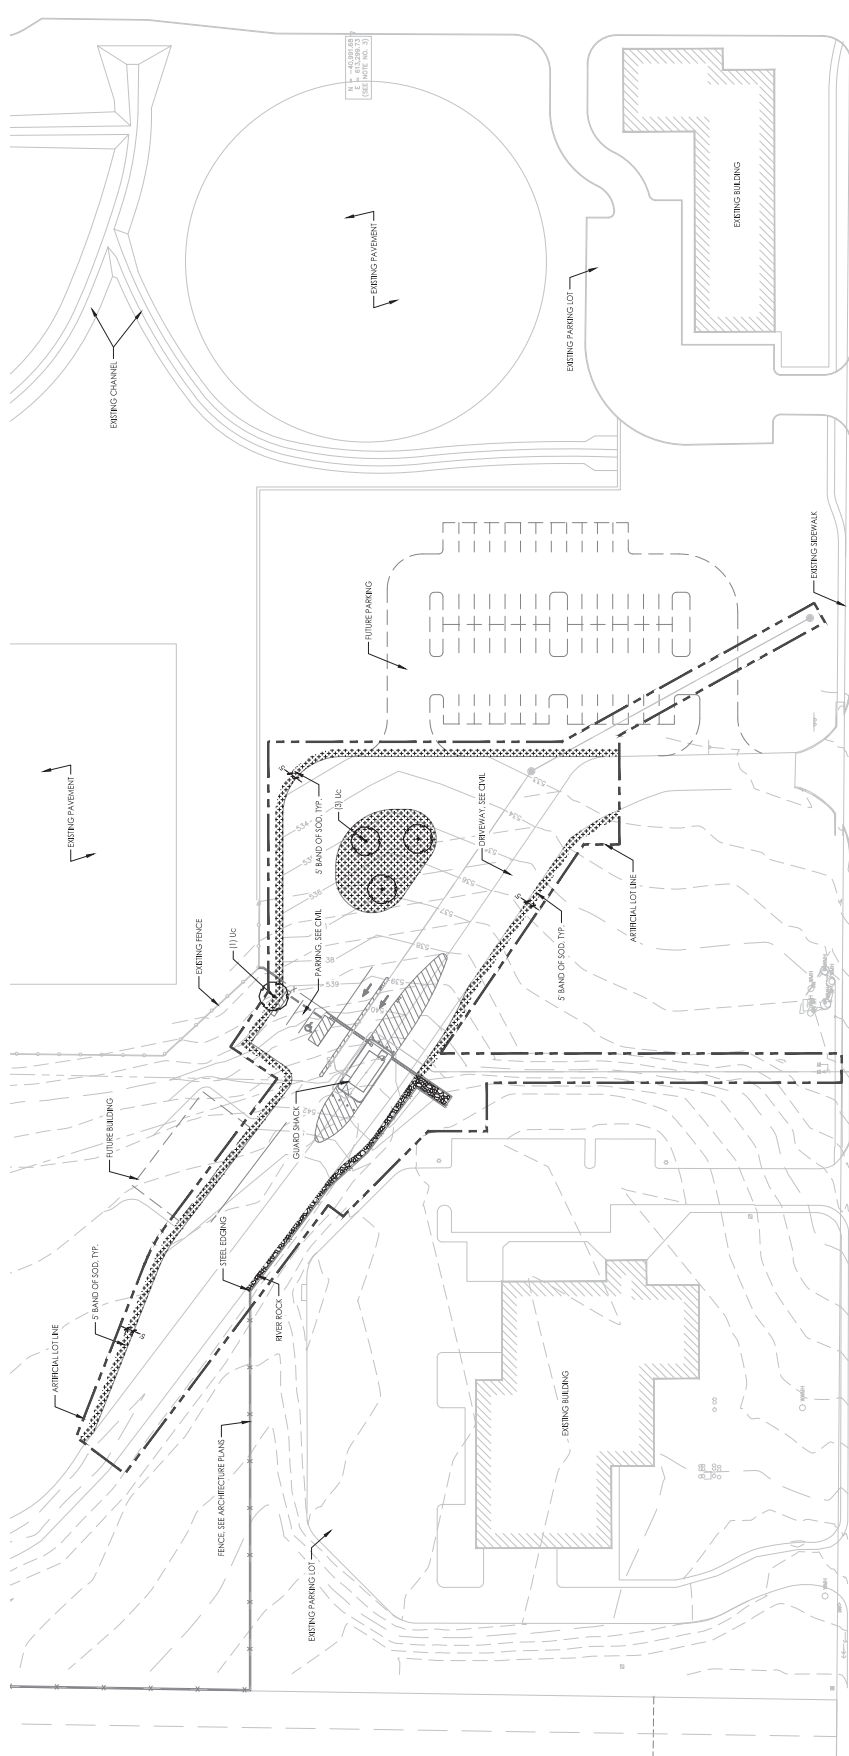

PLANT SCHEDULE

USES	CODE	QTY	BOTANICAL / COMMON NAME	COLPHE
	Uc	4	UNAKIS CHASIPOMIA / CEDAR BARK	HN 5' CAL 14-46 HT
BOUND COVERS	CODE	QTY	BOTANICAL / COMMON NAME	REMARKS
	cl	7,281 SF	CYNODON DACTYLON TWIKAY 4197 / TEWA 419 BERMECKA GRASS	SOLID SOID
	Dc	1,944 SF	RSB / PAPER ROCK	3' CLEAN RIVER ROCK

LANDSCAPE AREA OF PROPERTY

	REQUIRED	PROVIDED
(H3) HEAVY INDUSTRIAL PROPERTY AREA		66,528 SF
LANDSCAPE AREA	6,453 SF	9,926 SF
LANDSCAPE AREA PERCENTAGE	10%	14.97%

LANDSCAPE AREA OF PARKING LOT

	REQUIRED	PROVIDED
LANDSCAPE AREA PER PARKING SPACE (132)	50 SF/SPACE	158 SF/SPACE
LANDSCAPE AREA	150 SF	474 SF
MAX. DISTANCE OF EACH PARKING SPACE TO A LANDSCAPE AREA	60 LF	28 LF


[illegible]

TREE PROTECTION NOTES:

ALL PROTECTED TREES, PRESERVED UNDERSTORY, AND OTHER VEGETATION DESIRED FOR PROTECTION SHALL BE PROTECTED FROM INJURY DURING ANY LAND CLEARING AND BUILDING CONSTRUCTION IN THE FOLLOWING MANNER :

1. A TEMPORARY BARRIER SHALL BE CONSTRUCTED TO PREVENT ANY DISBURGANCE OF THE TOP SOIL LAYER.
2. WHEN PREPARING PROPOSED LANDSCAPE BEDS, DO NOT TILL WITHIN THE DRIP LINE OF EXISTING VEGETATION.
3. THE PROTECTED AREA SHALL BE MAINTAINED AT ITS ORIGINAL GRADE, WITH NO STORAGE OF TILL, COMPACTION OF SOIL OR TRINCHING OR CUTTING OF TREE ROOTS.
4. NO EXISTING VEGETATION SHALL BE CUT OR REMOVED FROM THE PROTECTED AREA.
5. THE CONTRACTOR SHALL NOT USE ANY OF THE FOLLOWING EQUIPMENT, MATERIALS, CONCRETE, OR ANY MATERIAL THAT CAN DAMAGE THE HEALTH OF VEGETATION WITHIN THE DRIP LINE OF PROTECTED VEGETATION.
6. NO ATTACHMENT OF WHEELS (INCLUDING W/ PROTECTIVE GUARD WHEELS), SPODS, OR OTHER EQUIPMENT SHALL BE USED WITHIN THE DRIP LINE OF PROTECTED VEGETATION.
7. ALL LOADING AND UNLOADING WITHIN THE PROTECTED AREA SHALL BE DONE

6" HT. CHAIN LINK FENCE
(ANCHOR TO GRADE)
LOCATE BARRICADE AT DRIP LINE OF TREE EXCEPT WHERE INDICATED ON
PLANS.
LOCATION TO BE FIELD VERIFIED BY LANDSCAPE ARCHITECT.

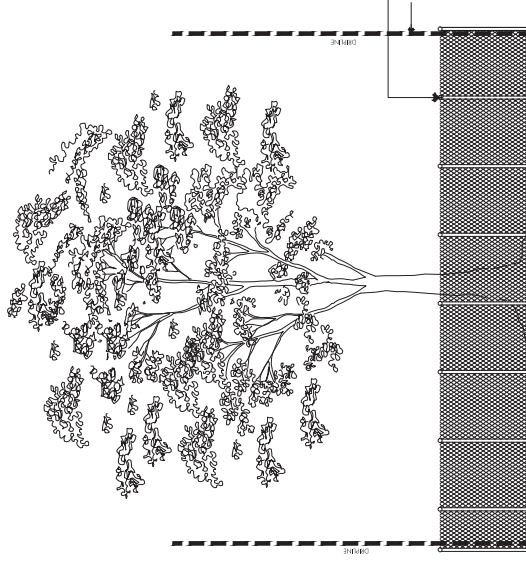

1 TREE PROTECTION

SECTION LINE

SCALE: 1/2" = 1'-0"


TREE STAKING

SECTION

SCALE: 1/2" = 1'-0"

TREE PLANTING NOTES:

1. ROOTBALL ANCHOR RINGS AND STAKES SHALL BE REMOVED AFTER ONE FULL GROWING SEASON.
2. TREE CALIPER MEASURED ABOVE TOP OF ROOTBALL SHALL BE 6" FOR TREES LESS THAN 4" IN CALIPER AND 12" FOR TREES 4" IN CALIPER AND GREATER.
3. ALL TREE PRUNING AT THE TIME OF INSTALLATION SHALL BE COORDINATED WITH THE OWNER.

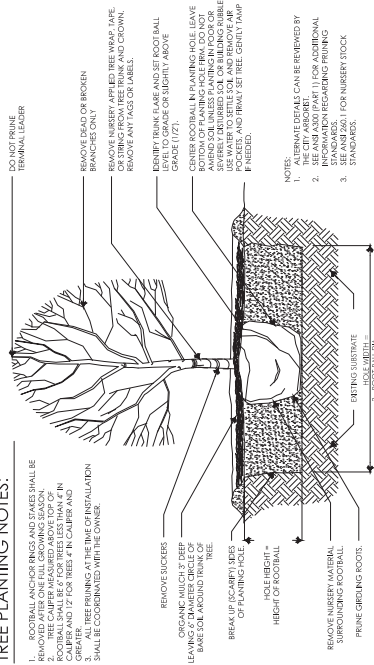

- NOTES:
1. ALTERNATE DETAILS CAN BE REVIEWED BY THE CITY ARBORETI.
 2. SEE ANSI A300 (PART 1) FOR ADDITIONAL INFORMATION REGARDING PRUNING STANDARDS.
 3. SEE ANSI Z60.1 FOR NURSERY STOCK STANDARDS.

5 TREE PLANTING

SECTION
TITLE

SCALE 1992-1993


SOD DETAIL

30	DETAIL
----	--------

SCALE: 10-112


☐ RIVER ROCK AND CONCRETE MOW STRIP AT FENCE

SCALE: 10-11.00

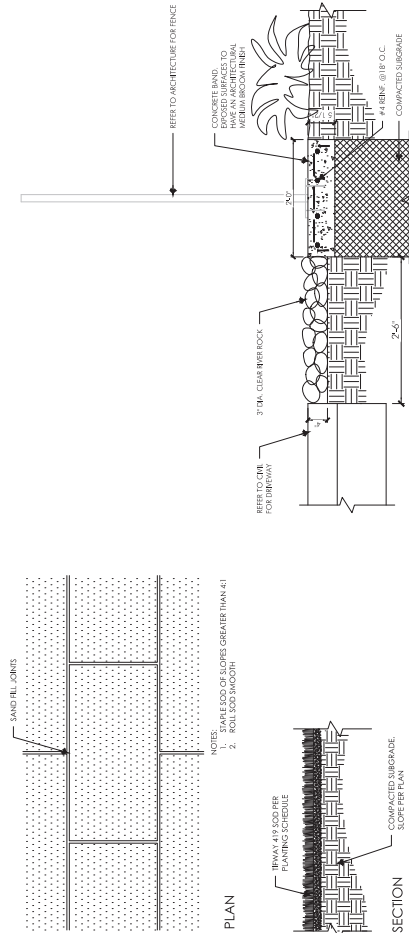


TREE STAKING NOTES:

1. TREE STAKE TO BE TREE STAKE SOLUTIONS ROOT ANCHOR TREE SUPPORT PRODUCT.
2. PLACE ROOTBALL ANCHOR RING AT BASE OF ROOTBALL.
3. TRUNK SHOULD BE IN THE CENTER OF THE RING.
4. INSTALL NAIL STAKE WITH HAMMER OR MALLET. FIRMLY INTO UNDISTURBED SOIL.
5. DRIVE NAIL STAKES FLUSH WITH U-BRACKET ADJACENT TO ROOTBALL (DO NOT DISTURB ROOTBALL).
6. BACKFILL HOLE WITH PLANTING SOIL WITH FINE COVER ROOTBALL ANCHOR RING, U-BRACKET, AND NAIL STAKES WITH 3 LAYER OF MULCH.
- 7.

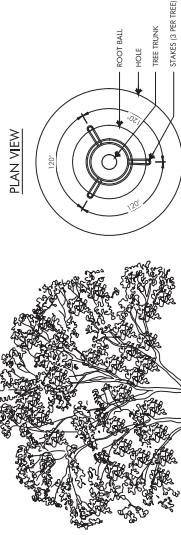


Revision	Bj	Asgd.	Vt MM CD
			95% CD 5mI
			75% CD 5mI
			50% CD 5mI
Issued	Bj	Asgd.	Vt MM CD
	MAY	CY	21.08.27
	MAY	CY	21.06.09
	MAY	CY	21.03.01
	APRIL	CY	VT MM CD

A1 EXTERIOR ELEVATION - MAIN BUILDING SOUTH

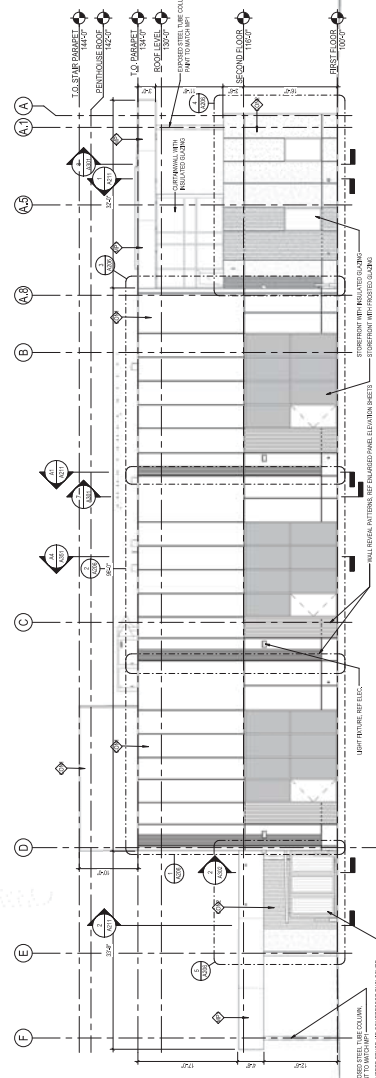[illegible]

EXTERIOR ELEVATION - MAIN BUILDING WEST

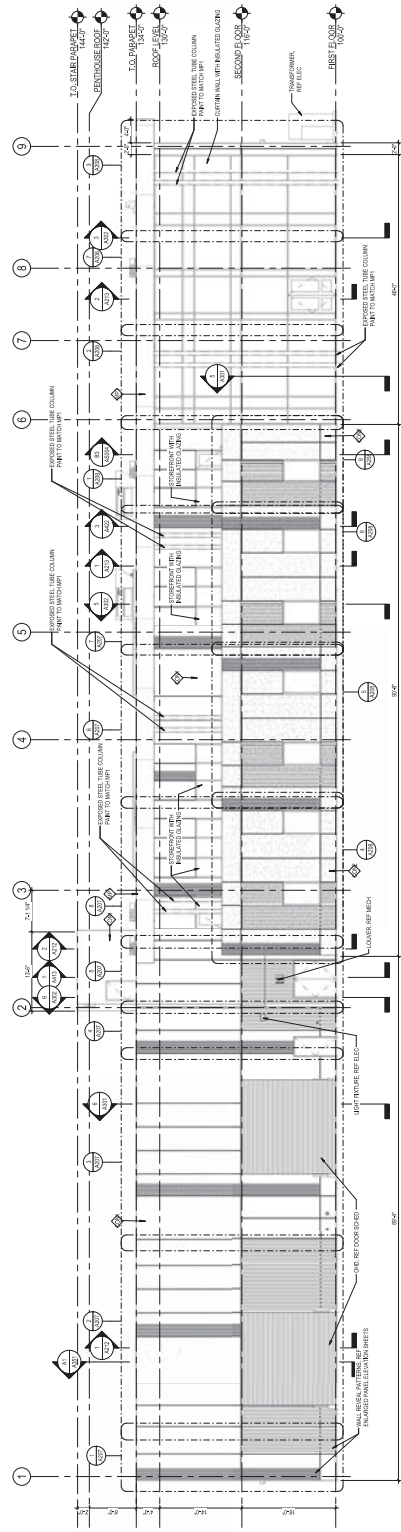

A1 EXTERIOR ELEVATION - MAIN BUILDING SOUTH

Notes

SITE PLAN
2021.08.09

Revision	By	Date	Description
1	MM	08/09/2021	Initial Design
2	MM	08/10/2021	Revised Design
3	MM	08/11/2021	Final Design
4	MM	08/12/2021	As-Built
5	MM	09/01/2021	Final As-Built
6	MM	09/02/2021	Final As-Built
7	MM	09/03/2021	Final As-Built
8	MM	09/04/2021	Final As-Built
9	MM	09/05/2021	Final As-Built
10	MM	09/06/2021	Final As-Built
11	MM	09/07/2021	Final As-Built
12	MM	09/08/2021	Final As-Built
13	MM	09/09/2021	Final As-Built
14	MM	09/10/2021	Final As-Built
15	MM	09/11/2021	Final As-Built
16	MM	09/12/2021	Final As-Built
17	MM	10/01/2021	Final As-Built
18	MM	10/02/2021	Final As-Built
19	MM	10/03/2021	Final As-Built
20	MM	10/04/2021	Final As-Built
21	MM	10/05/2021	Final As-Built
22	MM	10/06/2021	Final As-Built
23	MM	10/07/2021	Final As-Built
24	MM	10/08/2021	Final As-Built
25	MM	10/09/2021	Final As-Built
26	MM	10/10/2021	Final As-Built
27	MM	10/11/2021	Final As-Built
28	MM	10/12/2021	Final As-Built
29	MM	11/01/2021	Final As-Built
30	MM	11/02/2021	Final As-Built
31	MM	11/03/2021	Final As-Built
32	MM	11/04/2021	Final As-Built
33	MM	11/05/2021	Final As-Built
34	MM	11/06/2021	Final As-Built
35	MM	11/07/2021	Final As-Built
36	MM	11/08/2021	Final As-Built
37	MM	11/09/2021	Final As-Built
38	MM	11/10/2021	Final As-Built
39	MM	11/11/2021	Final As-Built
40	MM	11/12/2021	Final As-Built
41	MM	12/01/2021	Final As-Built
42	MM	12/02/2021	Final As-Built
43	MM	12/03/2021	Final As-Built
44	MM	12/04/2021	Final As-Built
45	MM	12/05/2021	Final As-Built
46	MM	12/06/2021	Final As-Built
47	MM	12/07/2021	Final As-Built
48	MM	12/08/2021	Final As-Built
49	MM	12/09/2021	Final As-Built
50	MM	12/10/2021	Final As-Built
51	MM	12/11/2021	Final As-Built
52	MM	12/12/2021	Final As-Built
53	MM	12/13/2021	Final As-Built
54	MM	12/14/2021	Final As-Built
55	MM	12/15/2021	Final As-Built
56	MM	12/16/2021	Final As-Built
57	MM	12/17/2021	Final As-Built
58	MM	12/18/2021	Final As-Built
59	MM	12/19/2021	Final As-Built
60	MM	12/20/2021	Final As-Built
61	MM	12/21/2021	Final As-Built
62	MM	12/22/2021	Final As-Built
63	MM	12/23/2021	Final As-Built
64	MM	12/24/2021	Final As-Built
65	MM	12/25/2021	Final As-Built
66	MM	12/26/2021	Final As-Built
67	MM	12/27/2021	Final As-Built
68	MM	12/28/2021	Final As-Built
69	MM	12/29/2021	Final As-Built
70	MM	12/30/2021	Final As-Built
71	MM	12/31/2021	Final As-Built
72	MM	01/01/2022	Final As-Built
73	MM	01/02/2022	Final As-Built
74	MM	01/03/2022	Final As-Built
75	MM	01/04/2022	Final As-Built
76	MM	01/05/2022	Final As-Built
77	MM	01/06/2022	Final As-Built
78	MM	01/07/2022	Final As-Built
79	MM	01/08/2022	Final As-Built
80	MM	01/09/2022	Final As-Built
81	MM	01/10/2022	Final As-Built
82	MM	01/11/2022	Final As-Built
83	MM	01/12/2022	Final As-Built
84	MM	02/01/2022	Final As-Built
85	MM	02/02/2022	Final As-Built
86	MM	02/03/2022	Final As-Built
87	MM	02/04/2022	Final As-Built
88	MM	02/05/2022	Final As-Built
89	MM	02/06/2022	Final As-Built
90	MM	02/07/2022	Final As-Built
91	MM	02/08/2022	Final As-Built
92	MM	02/09/2022	Final As-Built
93	MM	02/10/2022	Final As-Built
94	MM	02/11/2022	Final As-Built
95	MM	02/12/2022	Final As-Built
96	MM	03/01/2022	Final As-Built
97	MM	03/02/2022	Final As-Built
98	MM	03/03/2022	Final As-Built
99	MM	03/04/2022	Final As-Built
100	MM	03/05/2022	Final As-Built



Client/Project Logo

Client/Project
NTMWD

REGIONAL WSMFCR PHASE II


ADDRESS PRICKING

EXTERIOR ELEVATIONS


Project No.
21-0000000
Revision
01

Scale
1/8" = 1'-0"
1/4" = 1'-0"
1/2" = 1'-0"
3/4" = 1'-0"
1" = 1'-0"


A202

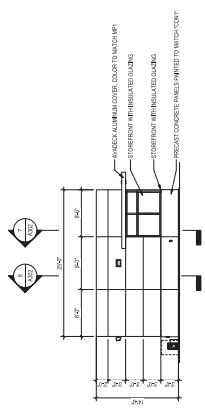


EXTERIOR ELEVATION - GUARDHOUSE SW
1/8" = 1'-0"

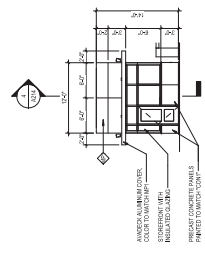


EXTERIOR ELEVATION - GUARDHOUSE SE
1/8" = 1'-0"

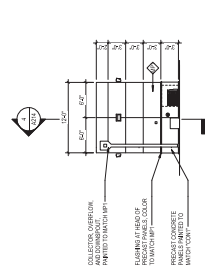


EXTERIOR ELEVATION - GUARDHOUSE NW
1/8" = 1'-0"

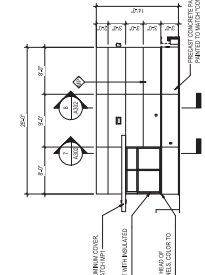

EXTERIOR ELEVATION - GUARDHOUSE NE
1/8" = 1'-0"

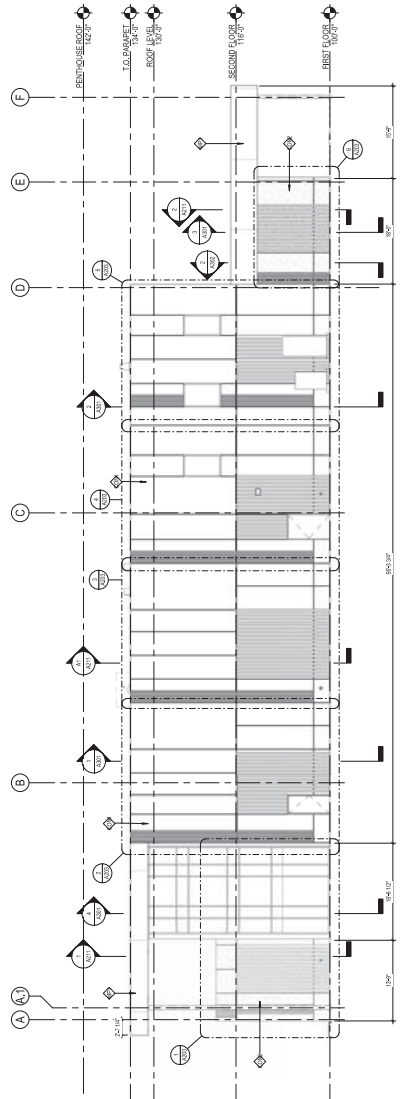

EXTERIOR ELEVATION - MAIN BUILDING EAST
1/8" = 1'-0"

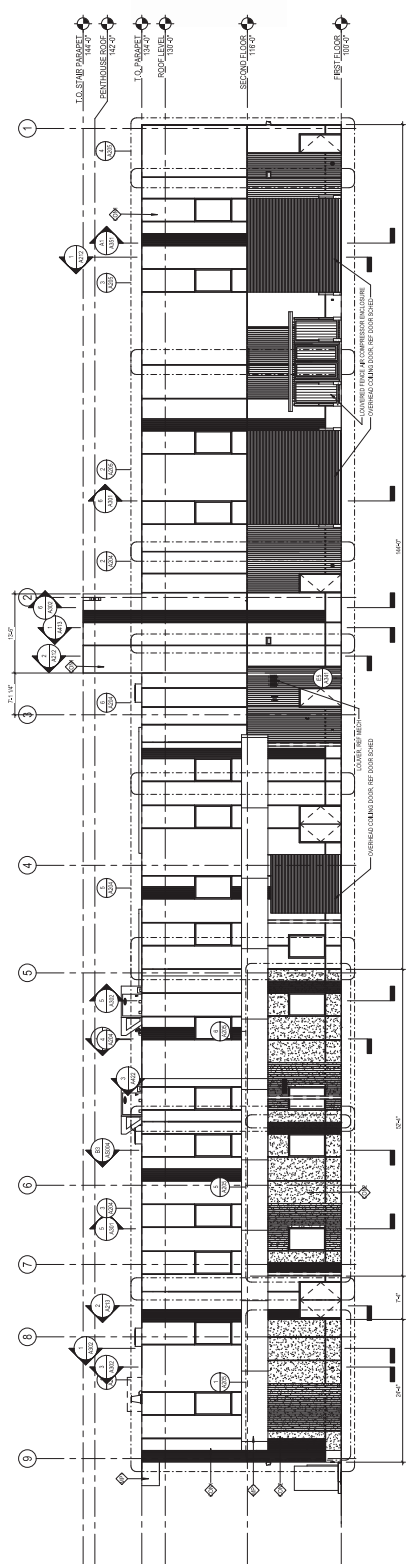

EXTERIOR ELEVATION - MAIN BUILDING NORTH
1/8" = 1'-0"